

RV STORAGE PROJECT TAMLIN ROAD

5080 TAMLIN ROAD


LOCATED IN SECTION 21, TOWNSHIP 13S, RANGE 65W OF THE 6TH P.M.,
COUNTY OF EL PASO, STATE OF COLORADO

LIGHTING PLAN


LIGHTING SCHEDULE								
SYMBOL	LABEL (1)	QTY	BRAND	WATTS	DISTRIBUTION TYPE V SHORT	LUMEN OUTPUT	MANUFACTURER	CATALOG NUMBER
	C1	1	Gleon	225	TYPE V SHORT	24,391	McGraw-Edison	GLEON-AF-03-LED-E1-T4W

NOTES

- VALUES SHOWN ARE HORIZONTAL ILLUMINANCE VALUES IN FOOT-CANDELES (FC) MEASURED AT GRADE.
- ANY PROPOSED LIGHT FIXTURES INSTALLED ON PRIVATE PROPERTY, ADJACENT TO THE PUBLIC ROW, SHALL BE ORIENTED IN SUCH A MANNER OR LIMITED IN LUMEN OUTPUT TO PREVENT GLARE PROBLEMS AND SHALL NOT EXCEED NATIONAL I.E.S. LIGHTING STANDARDS FOR DISABILITY GLARE.

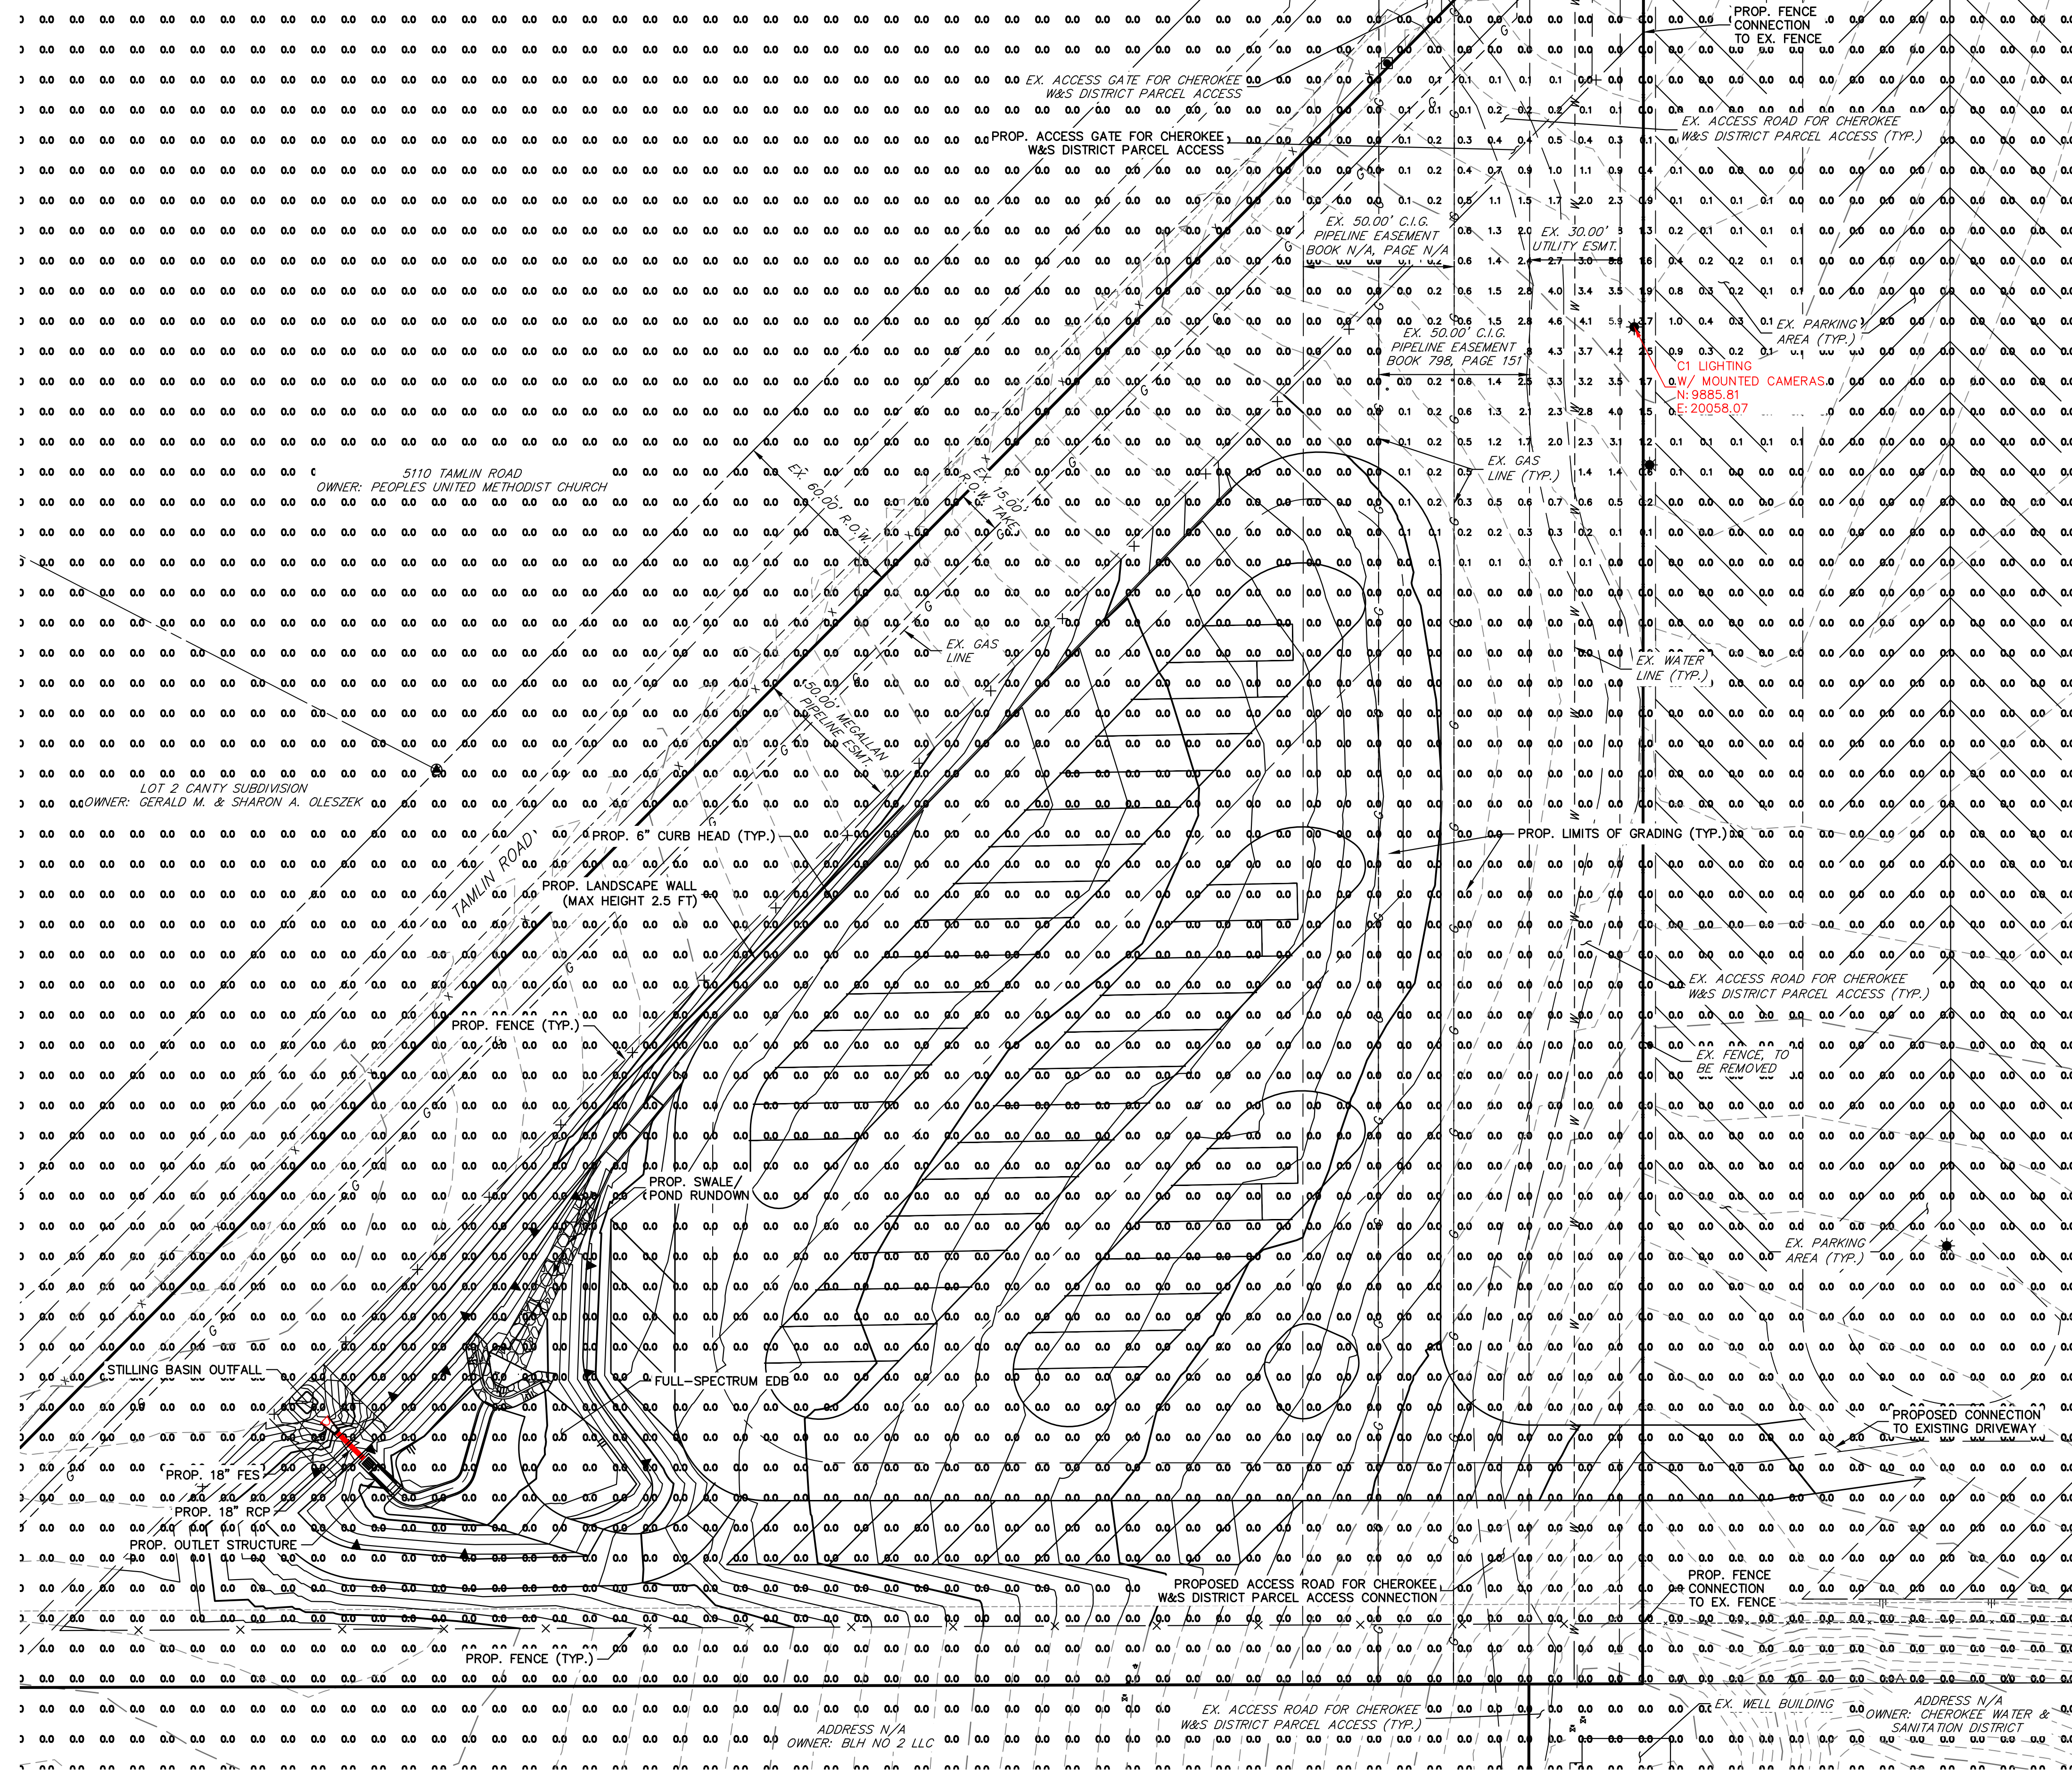

Add vicinity map

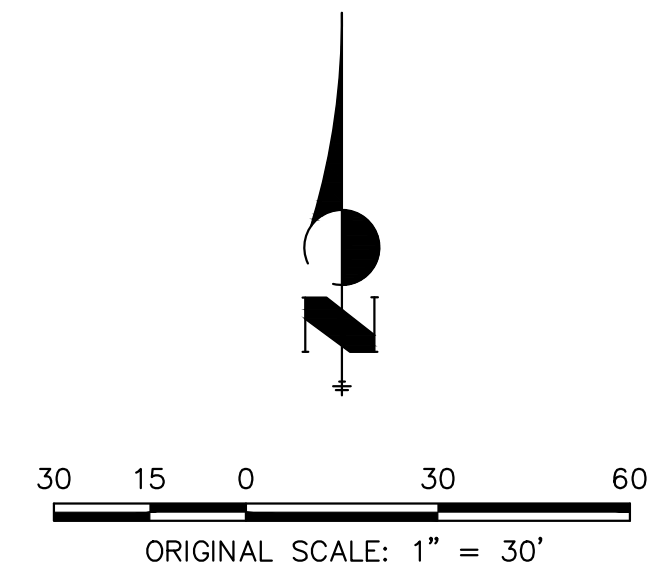

THE LOCATIONS OF EXISTING ABOVE GROUND AND UNDERGROUND UTILITIES ARE SHOWN IN AN APPROXIMATE WAY ONLY. THE CONTRACTOR SHALL DETERMINE THE EXACT LOCATION OF ALL EXISTING UTILITIES BEFORE COMMENCING WORK. THE CONTRACTOR SHALL BE FULLY RESPONSIBLE FOR ANY AND ALL DAMAGES WHICH MIGHT BE CAUSED BY HIS FAILURE TO EXACTLY LOCATE AND PRESERVE ANY AND ALL ABOVE GROUND AND UNDERGROUND UTILITIES.

Add property tax schedule number

Add current zoning: CS

Add lot/parcel size

UNTIL SUCH TIME AS THESE DRAWINGS ARE APPROVED BY THE APPROPRIATE REVIEWING AGENCIES, OR ENGINEERING APPROVES THEIR USE, THESE DRAWINGS ARE DESIGNATED BY WRITTEN AUTHORIZATION.

PREPARED FOR
TAMLIN STORAGE LLC
57 NEWPORT CIRCLE UNIT B
COLORADO SPRINGS, CO 80906
PARKER SAMELSON
(719) 659-7126

J.R. ENGINEERING
A Westman Company
Central 303-740-9888 • Colorado Springs 719-583-2583
Fort Collins 970-491-9888 • www.jrengineering.com

BY	DATE	No.	REVISION

H-SCALE 1"=30'
V-SCALE N/A
DATE 09/17/24
DESIGNED BY PAL
DRAWN BY PAL
CHECKED BY

RV STORAGE PROJECT
TAMLIN ROAD
LIGHTING PLAN

SHEET 1 OF 2
JOB NO. 25305.00



