


**NORTH ELEVATION**  
 11x17 SCALE: 3/32"=1'-0"  
 24x36 SCALE: 3/16"=1'-0"

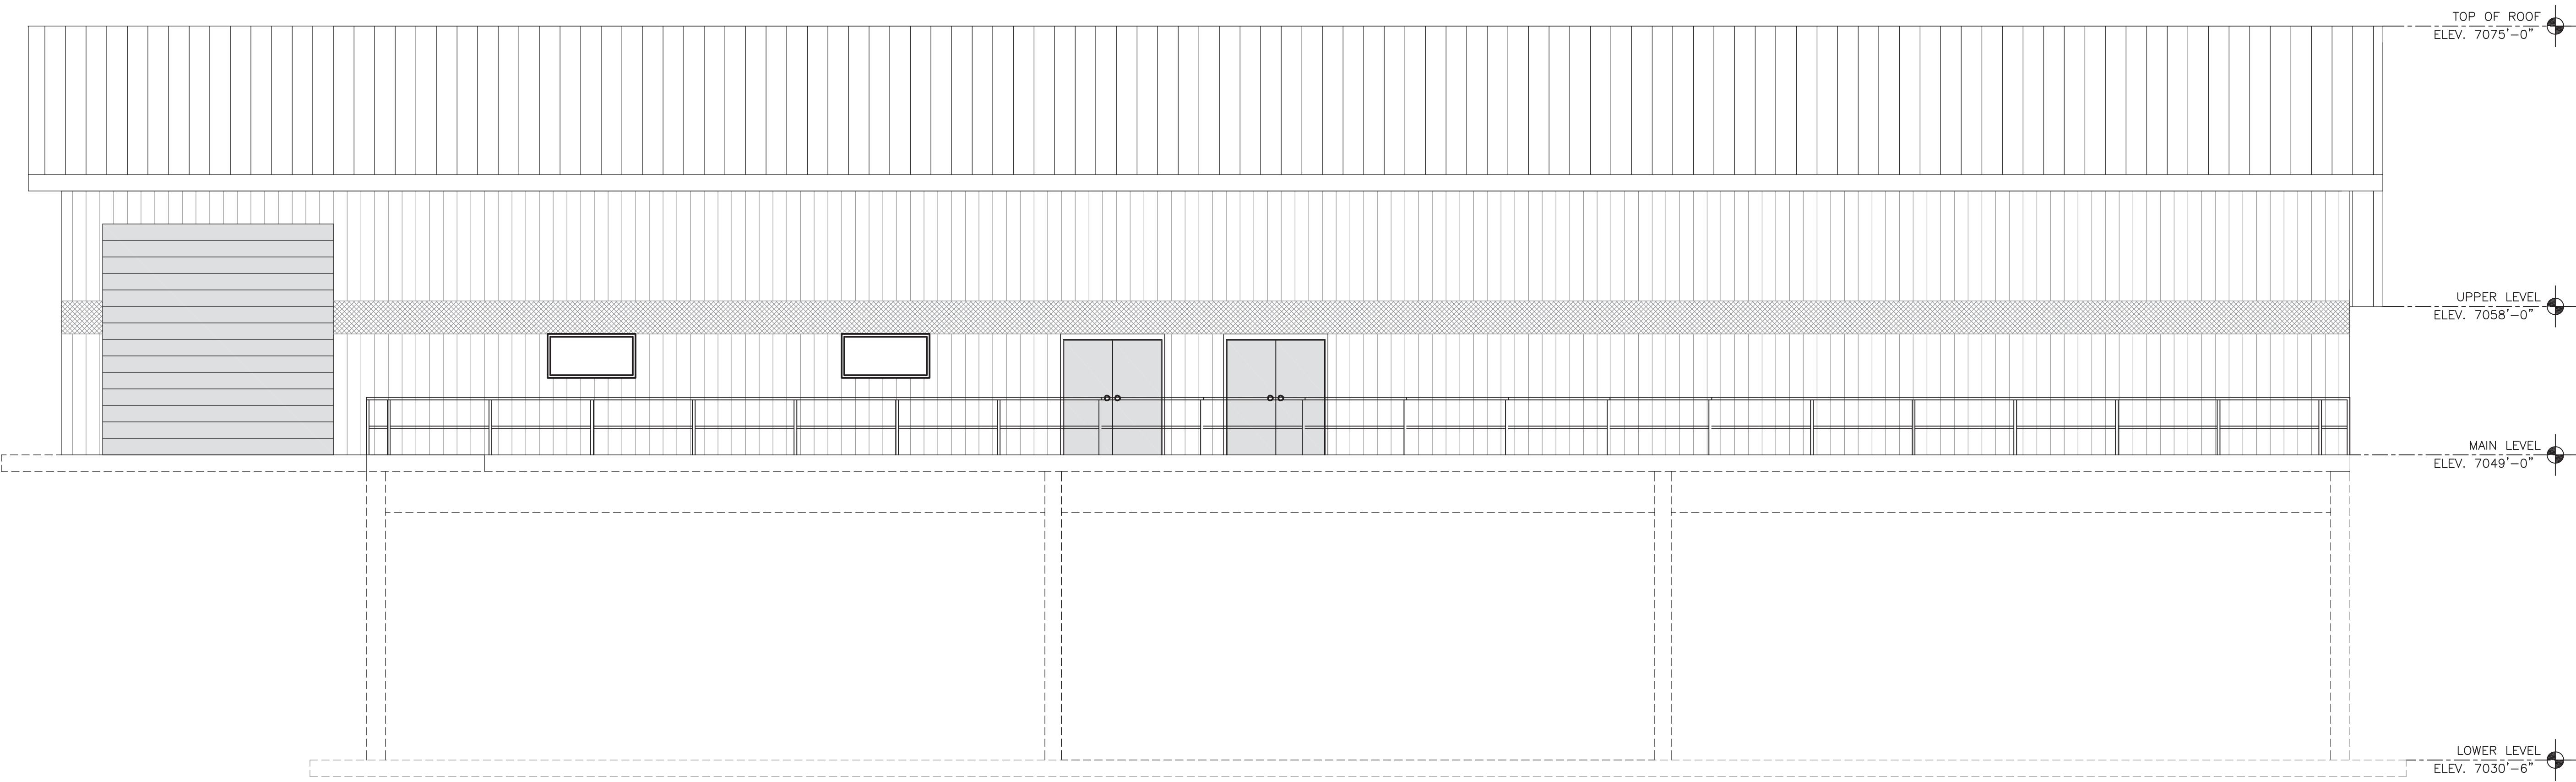


**SOUTH ELEVATION**  
 11x17 SCALE: 3/32"=1'-0"  
 24x36 SCALE: 3/16"=1'-0"


**JDS-HYDRO** CONSULTANTS, INC.  
 545 EAST PIKES PEAK AVENUE, SUITE 300  
 COLORADO SPRINGS, COLORADO 80903  
 PH: (719) 227-0072 - FAX: (719) 471-3401

**WOODMEN HILLS METROPOLITAN DISTRICT  
 REGIONAL WATER RECLAMATION FACILITY  
 NORTH/SOUTH BUILDING ELEVATIONS**  
 PCD FILE NO: PPR-17-027

Project No.:	112.88
Scale:	AS NOTED
Date:	05/22/17
Design:	RMM
Drawn:	RMM
Check:	JPM
Revised:	

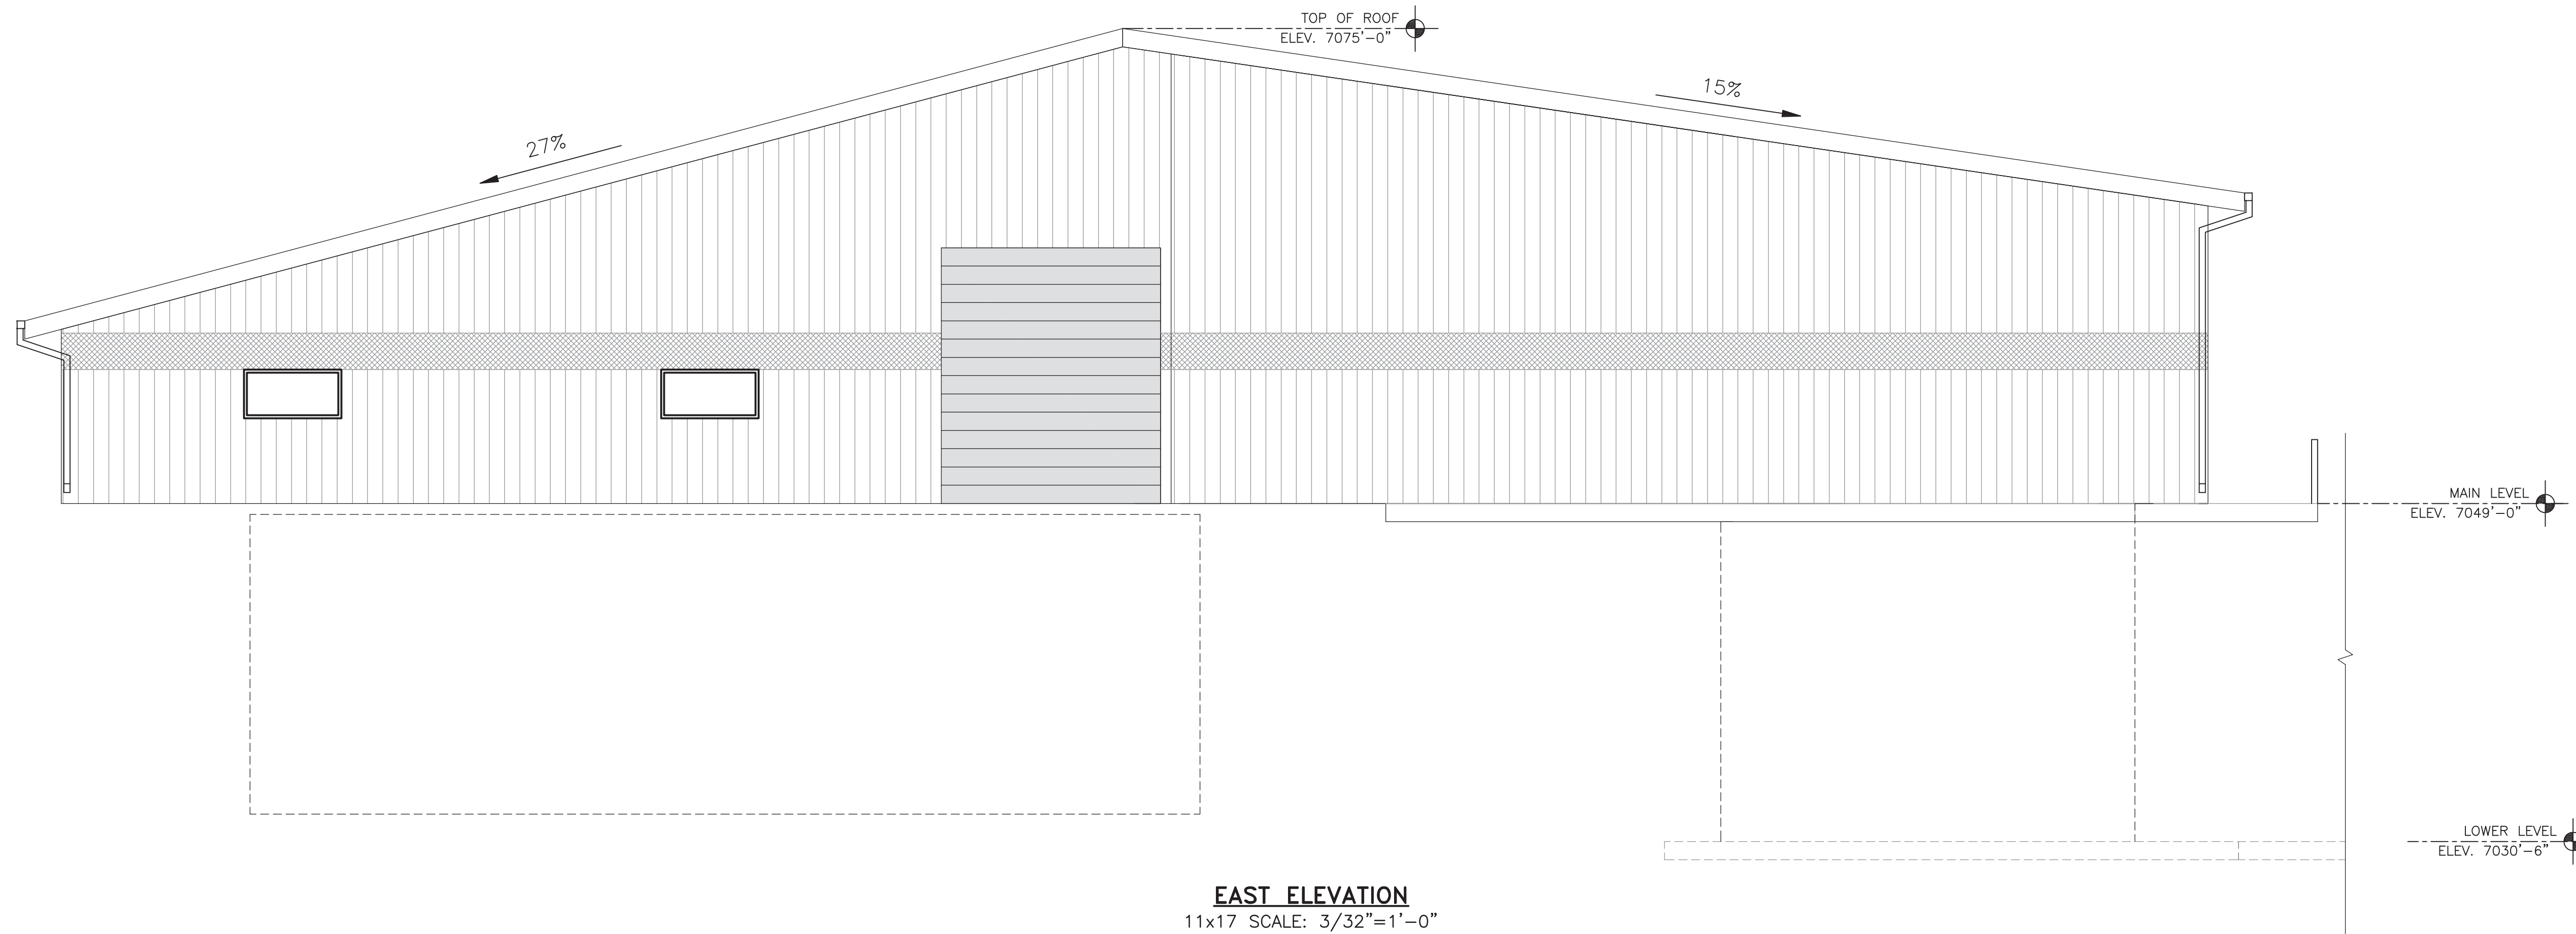

**EAST ELEVATION**  
 11x17 SCALE: 3/32"=1'-0"  
 24x36 SCALE: 3/16"=1'-0"

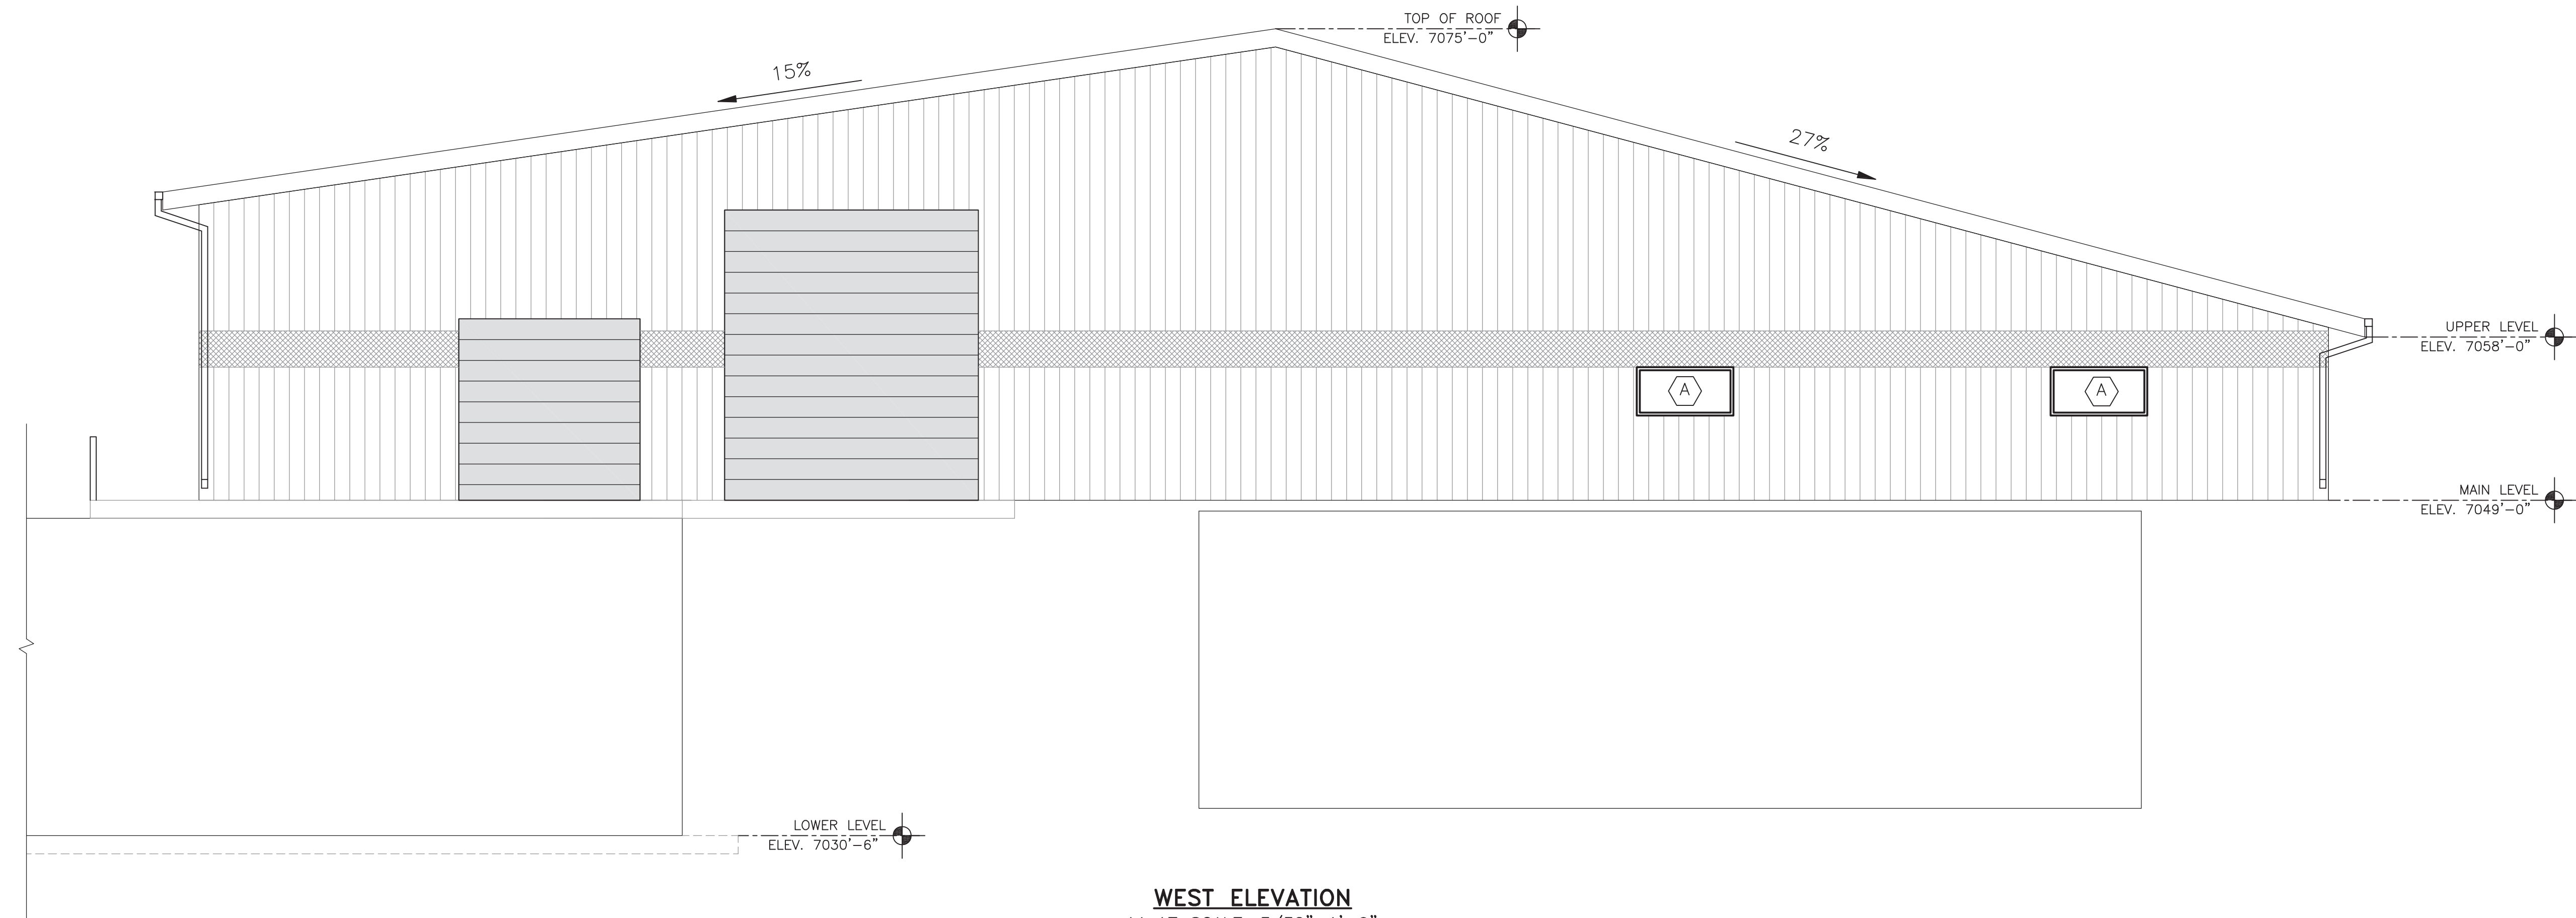

**WEST ELEVATION**  
 11x17 SCALE: 3/32"=1'-0"  
 24x36 SCALE: 3/16"=1'-0"

**JDS-HYDRO** CONSULTANTS, INC.  
 545 EAST PIKES PEAK AVENUE, SUITE 300  
 COLORADO SPRINGS, COLORADO 80903  
 PH: (719) 227-0072 - FAX: (719) 471-3401

WOODMEN HILLS METROPOLITAN DISTRICT  
 REGIONAL WATER RECLAMATION FACILITY  
 EAST/WEST BUILDING ELEVATIONS  
 PCD FILE NO: PPR-17-027

Project No.:	112.88
Scale:	AS NOTED
Date:	05/22/17
Design:	RMM
Drawn:	RMM
Check:	JPM
Revised:	