

Line #	Length	Direction
L1	103.39	N89° 43' 00.18"E
L2	103.33	N89° 43' 00.18"E
L3	100.00	N89° 43' 00.18"E
L4	115.53	N89° 43' 00.18"E
L5	165.16	N85° 49' 49.59"E
L6	175.53	S89° 43' 00.18"W
L8	92.33	N90° 00' 00.00"E
L10	211.72	N89° 43' 00.18"E
L11	120.15	N87° 04' 45.69"E
L12	57.41	N89° 43' 00.18"E
L14	41.24	N41° 12' 01.94"W
L15	52.66	S41° 12' 59.22"E
L16	4.25	S41° 12' 59.22"E
L17	30.97	N41° 16' 30.48"W
L18	18.96	S48° 43' 29.52"W
L19	262.89	S41° 16' 30.48"E
L21	262.89	S41° 16' 30.48"E
L22	73.63	N40° 55' 48.19"W
L24	41.58	N34° 27' 26.01"W
L25	46.15	S41° 16' 30.48"E


Curve #	Length	Radius	Delta
C1	16.46	10.00	94.29
C2	133.00	553.00	13.78
C3	33.43	59.18	32.36
C4	33.17	261.21	7.28
C5	10.00	75.00	7.64
C6	30.01	75.00	22.93
C7	14.40	46.50	17.74
C8	27.32	46.50	33.66
C9	11.45	46.50	14.11
C10	32.32	56.01	33.07
C11	10.93	46.50	13.46
C12	30.32	63.78	27.24

- NOTE TO CONTRACTOR:**
- ALL 4" AND 8" SOLID OR SKIP PAVEMENT MARKINGS ARE TO BE EPOXY.
 - SIGNS AND POLES SHALL BE PER CDOT STANDARDS S-614-8, S-1614-2, AND S-614-3, LATEST REVISION.
 - ALL SIGNAGE INSTALLATION IS TO BE IN COMPLIANCE WITH THE MANUAL ON UNIFORM TRAFFIC CONTROL DEVICES (MUTCD).
 - ROUNDBOUT LIGHT POLES TO BE INSTALLED ONCE PHOTOMETRIC PLANS ARE APPROVED. LIGHTING PLANS TO BE INDEPENDENTLY APPROVED BY EL PASO COUNTY.



STRIPING LEGEND		
STRIPE	PAVEMENT MARKINGS	MARKING DESCRIPTION
①	2-WAY LEFT TURN LANE MARKINGS (EPOXY)	OUTSIDE: SOLID YELLOW, 4" WIDE, INSIDE: BROKEN YELLOW, 4" WIDE, 10' SEGMENTS WITH 30" GAPS
②	2-WAY CENTERLINE LANE MARKINGS (EPOXY)	PARALLEL SOLID YELLOW, 4" WIDE, 4" APART
③	LANE LANES (EPOXY)	BROKEN WHITE, 4" WIDE, 10' SEGMENTS WITH 30" GAPS
④	BROKEN EDGE/BIKE LANE LINES (EPOXY)	BROKEN WHITE, 4" WIDE, 5' SEGMENTS WITH 15" GAPS
⑤	EDGE/BIKE LANE LINES (EPOXY)	SOLID WHITE, 6" WIDE
⑥	CHANNELIZING LINES (EPOXY)	SOLID WHITE, 8" WIDE
⑦	STOP LINES (THERMO PLASTIC)	SOLID WHITE, 24" WIDE
⑧	CHEVRON/DIAGONAL CROSSHATCH	SOLID WHITE, 8" WIDE
⑨	TRANSVERSE MARKINGS	SOLID WHITE, 2' WIDE BY 10' LONG
⑩	EXTENSION LINES	12" BROKEN WHITE LINE
⑪	MEDIAN LIP (EDGE) LINES	4" SOLID YELLOW LINE

NOTE: ALL STRIPING INSTALLATION SHALL BE PER COLORADO DEPARTMENT OF TRANSPORTATION (CDOT) "M&S STANDARDS" STANDARD PLAN NO. S-627-1.

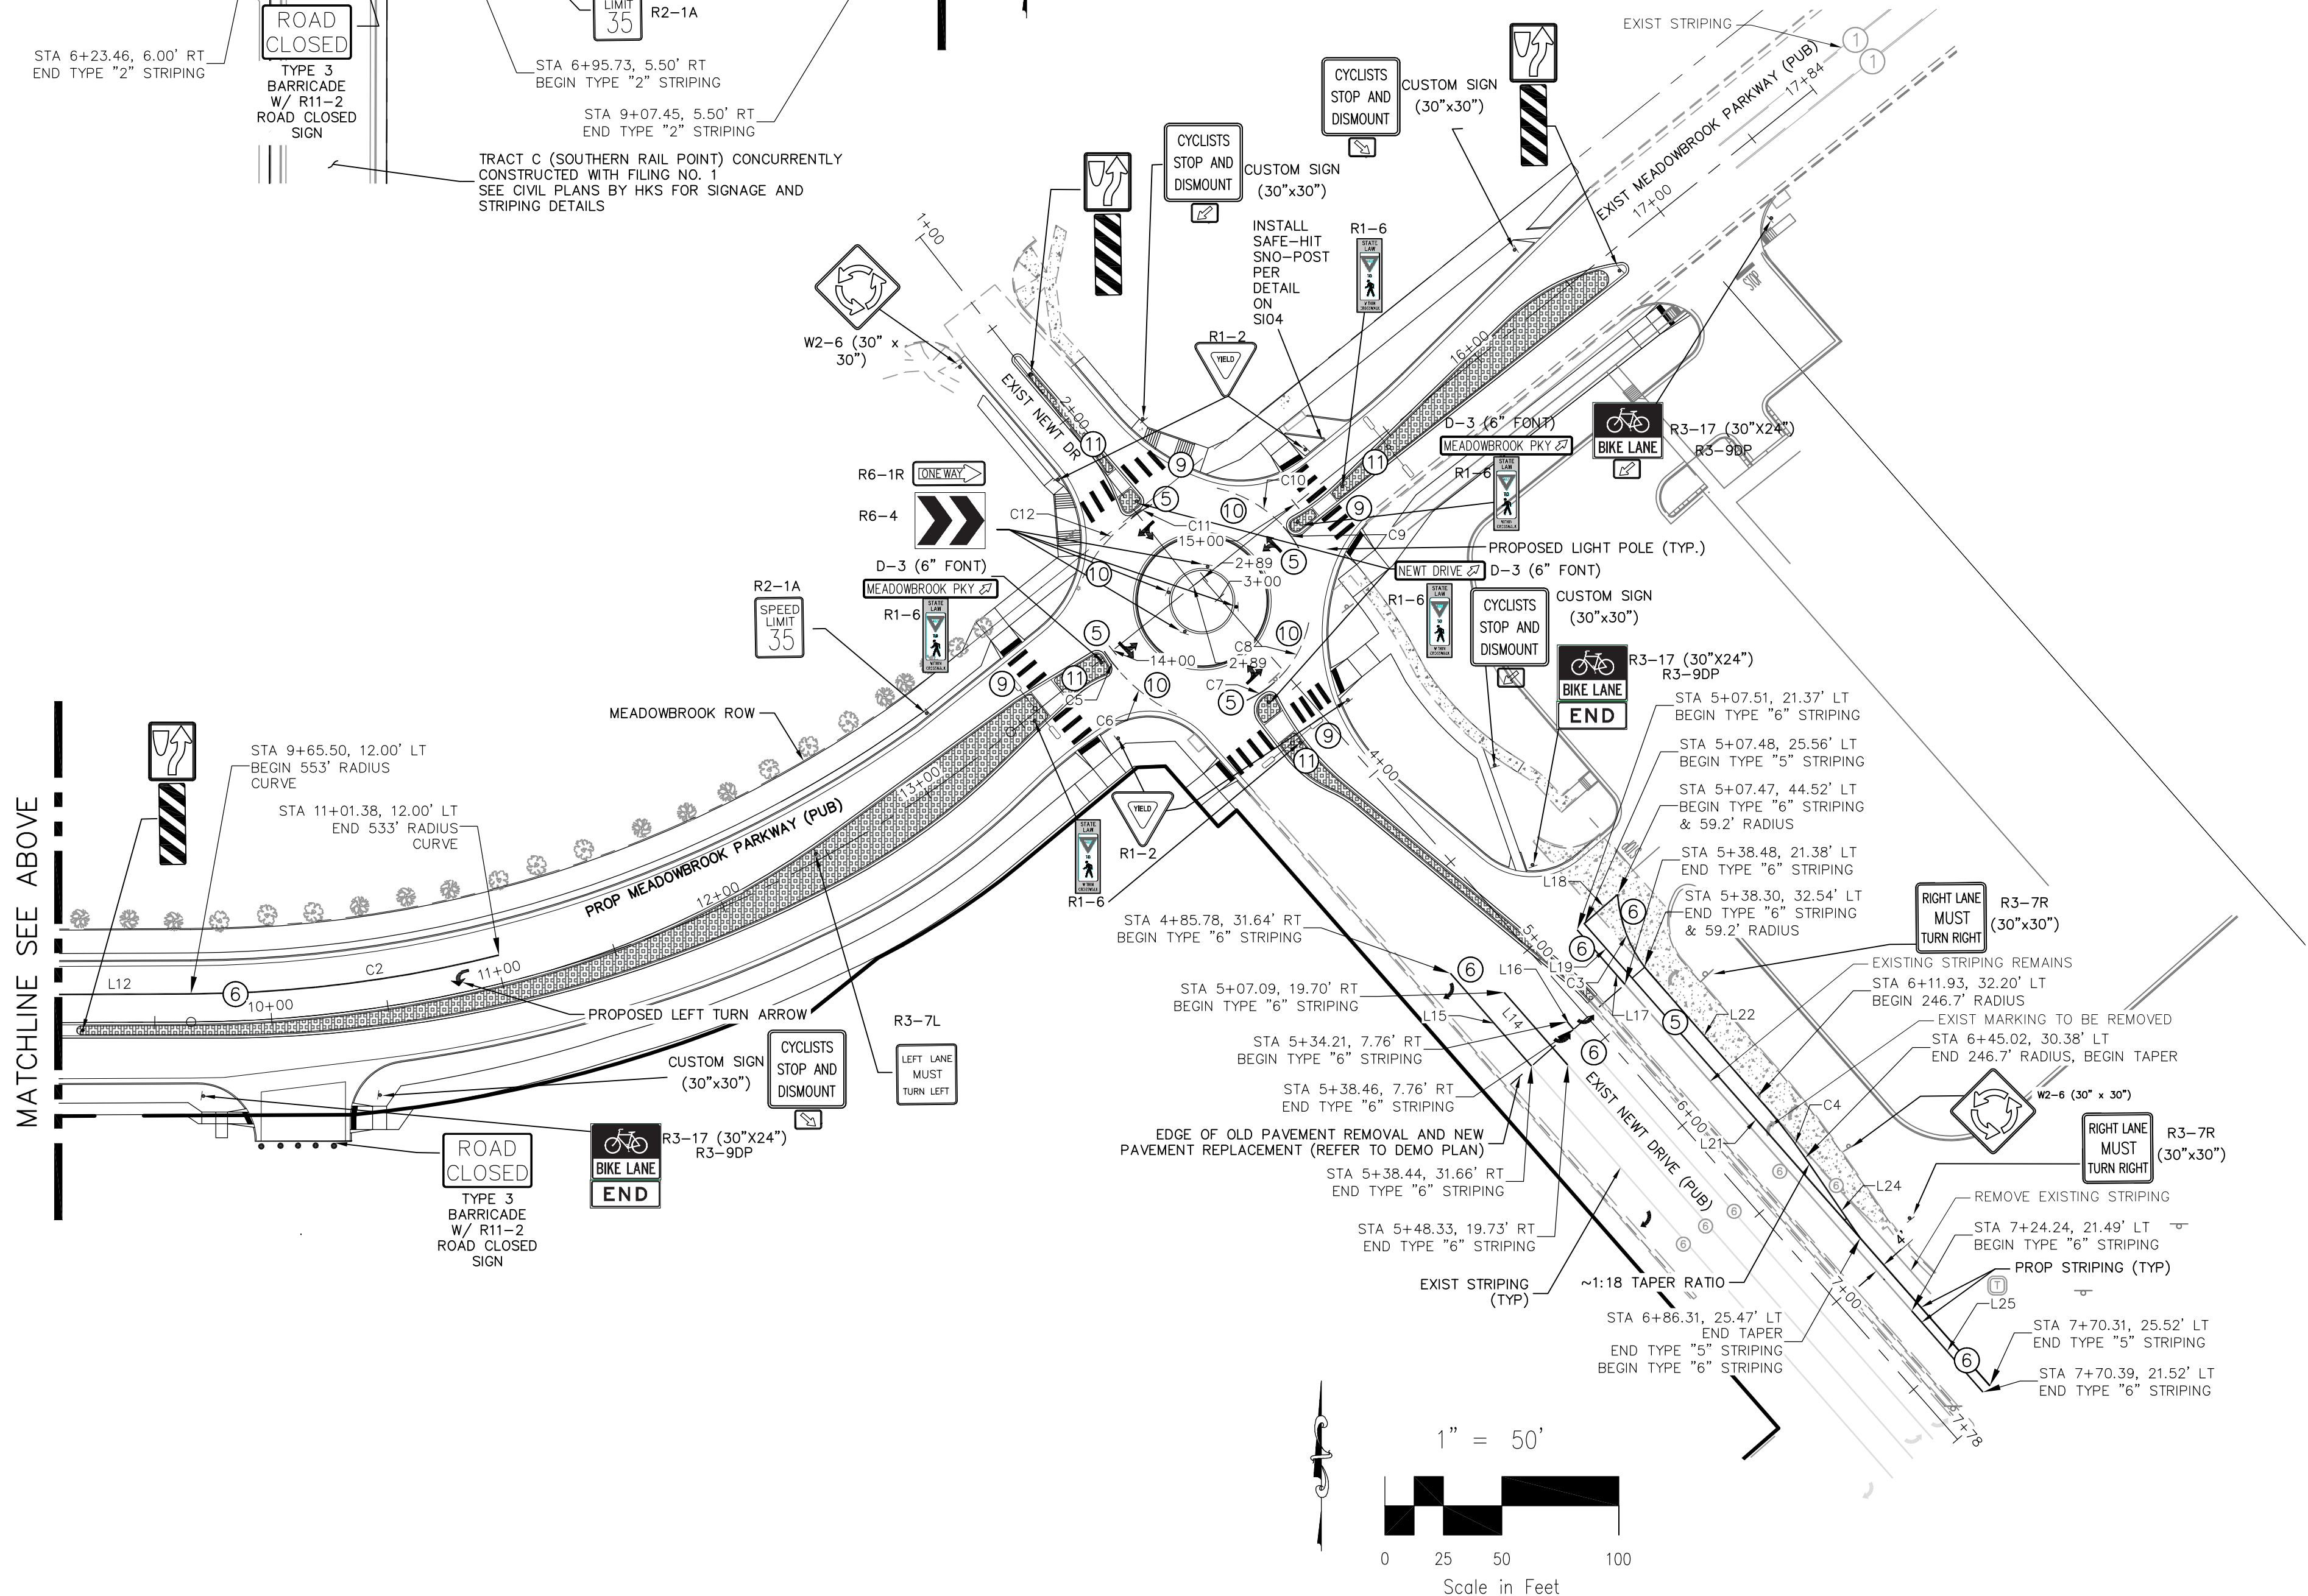

CROSSROADS MIXED USE FILING NO. 1

SIGNAGE AND STRIPING PLAN

DATE: 06/07/2022

SCALE: HORIZONTAL: 1"=50' VERTICAL: N/A

PROJECT NO. 18-003

DESIGNED BY: CWV

DRAWN BY: CWV

CHECKED BY: VAS

SHEET 12 OF 24

SI12

210 N. WABATCH AVE., STE 305
COLORADO SPRINGS, CO 80903
PHONE: 719.555.5485

FOR AND ON BEHALF OF CIVIL CONSULTANTS, INC.

VIRGIL A. SANCHEZ, COLORADO, P.E. NO. 37160

NO.	DATE	BY	DESCRIPTION

THE ENGINEER PREPARING THESE PLANS WILL NOT BE RESPONSIBLE, OR LIABLE FOR, UNAUTHORIZED CHANGES TO OR USES OF THESE PLANS. ALL CHANGES TO THE PLANS MUST BE IN WRITING AND MUST BE APPROVED BY THE PREPARED BY THESE PLANS.

CAUTION

Preliminary

06/07/2022 10:24:47 AM