


THE LOCATIONS OF EXISTING ABOVE GROUND AND UNDERGROUND UTILITIES ARE SHOWN IN AN APPROXIMATE WAY ONLY. THE CONTRACTOR SHALL DETERMINE THE EXACT LOCATION OF ALL EXISTING UTILITIES BEFORE COMMENCING WORK. THE CONTRACTOR SHALL BE FULLY RESPONSIBLE FOR ANY AND ALL DAMAGES WHICH MIGHT BE CAUSED BY HIS FAILURE TO EXACTLY LOCATE AND PRESERVE ANY AND ALL ABOVE GROUND AND UNDERGROUND UTILITIES.

**LAYER LINETYPE LEGEND**

	EXISTING	PROPOSED
CABLE TV	TV	TV
ELECTRIC	E	E
FIBER OPTIC	FO	FO
GAS MAIN	G	G
IRRIGATION MAIN	IRR	IRR
OIL/PETRO. MAIN	O	O
OVERHEAD UTILITY	OHU	OHU
SANITARY SEWER	S	S
STORM DRAIN		
TELEPHONE	T	T
WATER MAIN	W	W
RAW WATER LINE	RWL	RWL
RIPRAP		

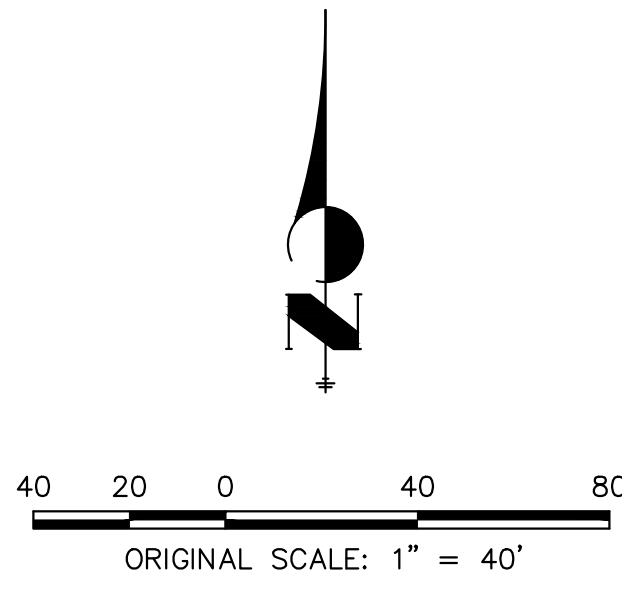

PREPARED FOR  
**SCOTT BELKNAP**  
 3603 FIRST LIGHT DRIVE  
 CASTLE ROCK, CO 80109  
 (719) 322-3556  
 SCOTT.BELKNAP@YAHOO.COM

**J.R. ENGINEERING**  
 A Western Company  
 Central 303-740-9888 • Colorado Springs 719-583-2583  
 Fort Collins 970-491-9888 • www.jrengineering.com

BY	DATE	No.	REVISION

H-SCALE	V-SCALE	DATE	DESIGNED BY	DRAWN BY	CHECKED BY
1"=40'	N/A	10/24/22	APL	APL	

**VOLLERMER RV STORAGE**  
**PRELIMINARY UTILITY PLAN**

SHEET C2 OF C2  
 JOB NO. 25251.00



X:\25251.00\Drawings\Sheet\Drawings\25251.00\UTD1.dwg, UTD1, 10/24/2022 3:02:10 PM, CS