


please establish property lines, when adjacent to residential or a row, the footcandles shall be 0.1

Eldorado Springs at Cheyenne Mountain Fil. No. 1

ADMINISTRATIVE SITE DEVELOPMENT PLAN - SITE LIGHTING PLAN

MAY, 2019

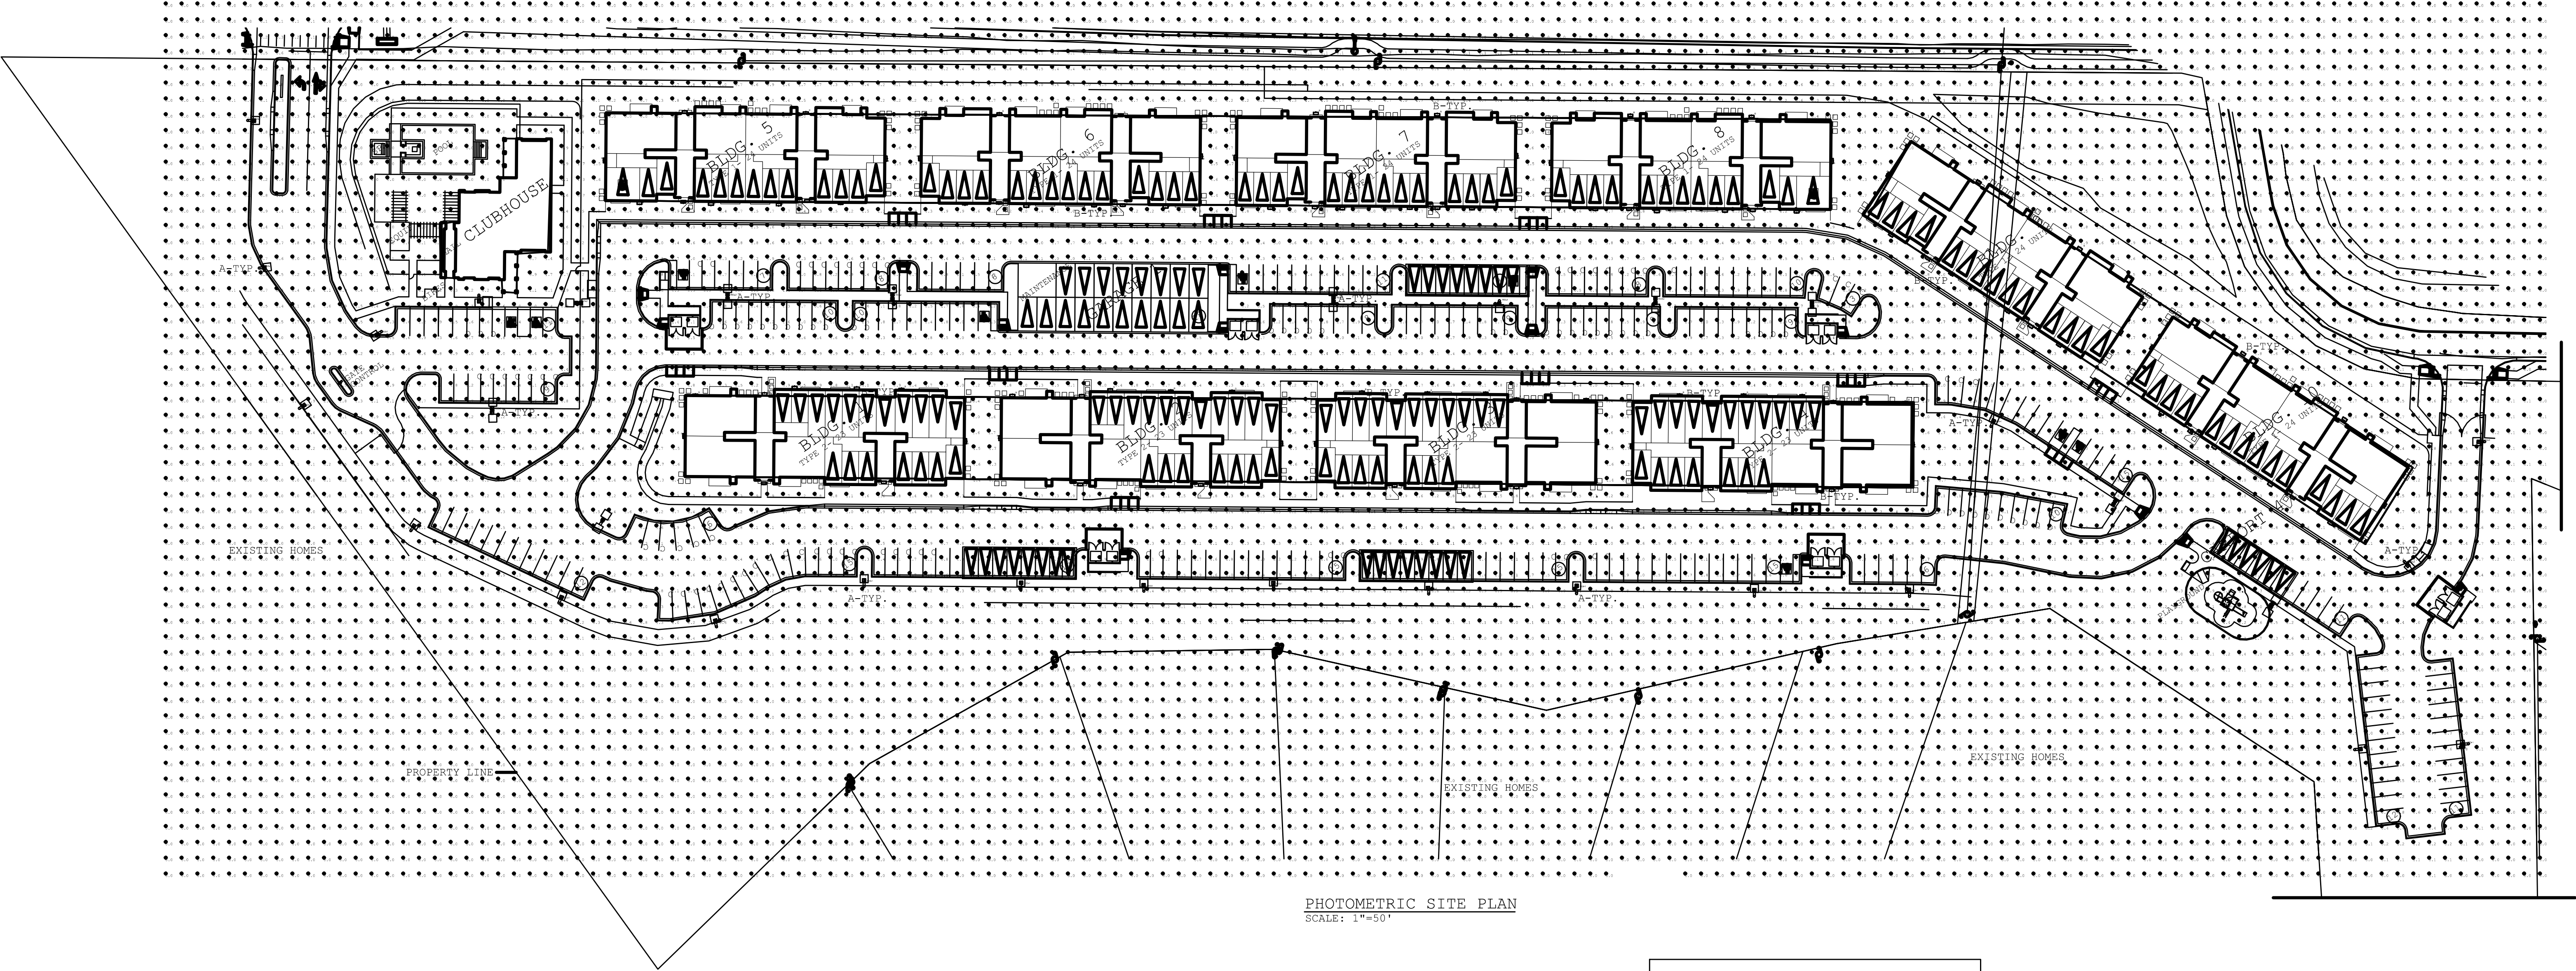

PHOTOMETRIC SITE PLAN
SCALE: 1"=50'

Luminaire Schedule						
Symbol	Qty	Label	Arrangement	Total Lamp Lumens	LLF	Description of fixture
	100	B	SINGLE	N.A.	0.900	HUBBELL: LNC2-18L-4K-070-3
	23	R53-1	SINGLE	N.A.	0.900	HUBBELL: RAR1-80L-50-5K7-3
	9	R53-2	BACK-BACK	N.A.	0.900	HUBBELL: RAR1-80L-50-5K7-3

Calculation Summary							
Label	CalcType	Units	Avg	Max	Min	Avg/Min	Max/Min
SITE	Illuminance	Fc	0.61	4.5	0.0	N.A.	N.A.

