


update, needs to be  
INDEPENDENCE  
PLACE AT  
CHEYENNE  
MOUNTAIN FIL NO 1

# Eldorado Springs at Cheyenne Mountain Fil. No. 1

## ADMINISTRATIVE SITE DEVELOPMENT PLAN - SITE LIGHTING PLAN


MAY, 2019

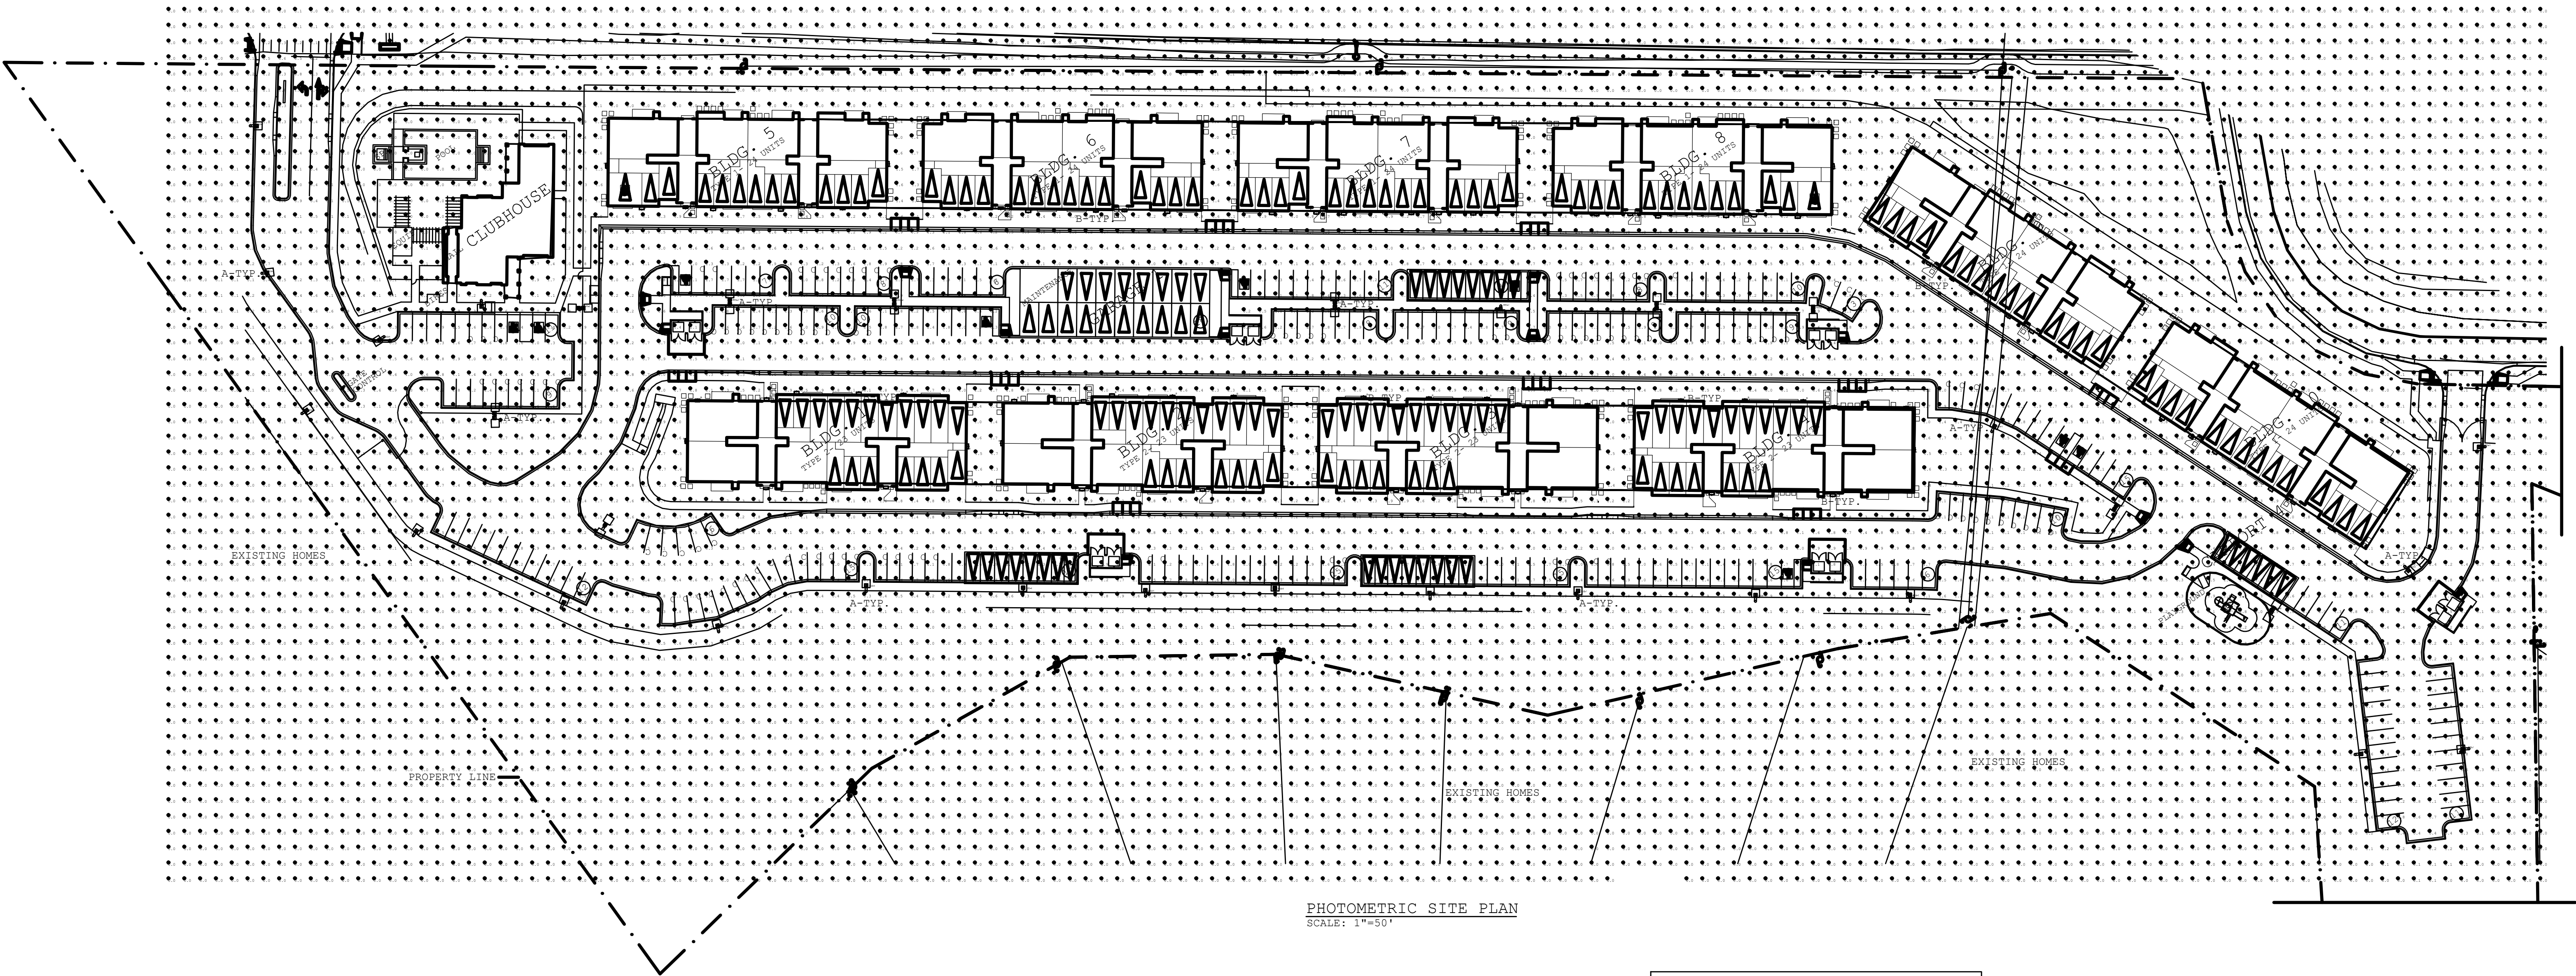

PHOTOMETRIC SITE PLAN  
SCALE: 1"=50'

Luminaire Schedule						
Symbol	Qty	Label	Arrangement	Total Lamp Lumens	LLF	Description of fixture
[Symbol]	88	B	SINGLE	N.A.	0.900	HUBBELL: LNC2-18L-4K-070-3
[Symbol]	23	R53-1	SINGLE	N.A.	0.900	HUBBELL: RAR1-80L-50-5K7-3
[Symbol]	9	R53-2	BACK-BACK	N.A.	0.900	HUBBELL: RAR1-80L-50-5K7-3

Calculation Summary							
Label	CalcType	Units	Avg	Max	Min	Avg/Min	Max/Min
SITE	Illuminance	Fc	0.62	4.5	0.0	N.A.	N.A.

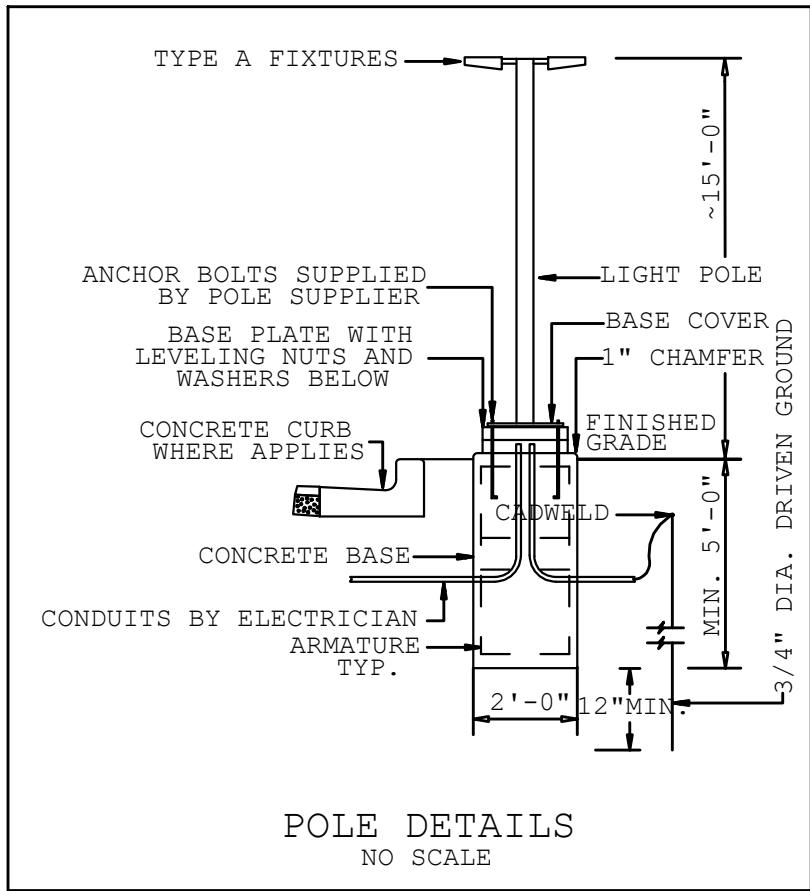

# Lighting Plan\_V2.pdf Markup Summary

---

Locked (1)

---



**Subject:** Cloud+  
**Page Label:** 1  
**Lock:** Locked  
**Author:** dsdsevigny  
**Date:** 12/17/2019 1:47:58 PM  
**Status:**  
**Color:** ■  
**Layer:**  
**Space:**

update, needs to be INDEPENDENCE PLACE AT  
CHEYENNE MOUNTAIN FIL NO 1