


THE SHOP'S AT MERIDIAN RANCH


FILING NO. 1, LOT 4

PHOTOMETRIC PLAN

EL PASO COUNTY, COLORADO.
FALCON, COLORADO

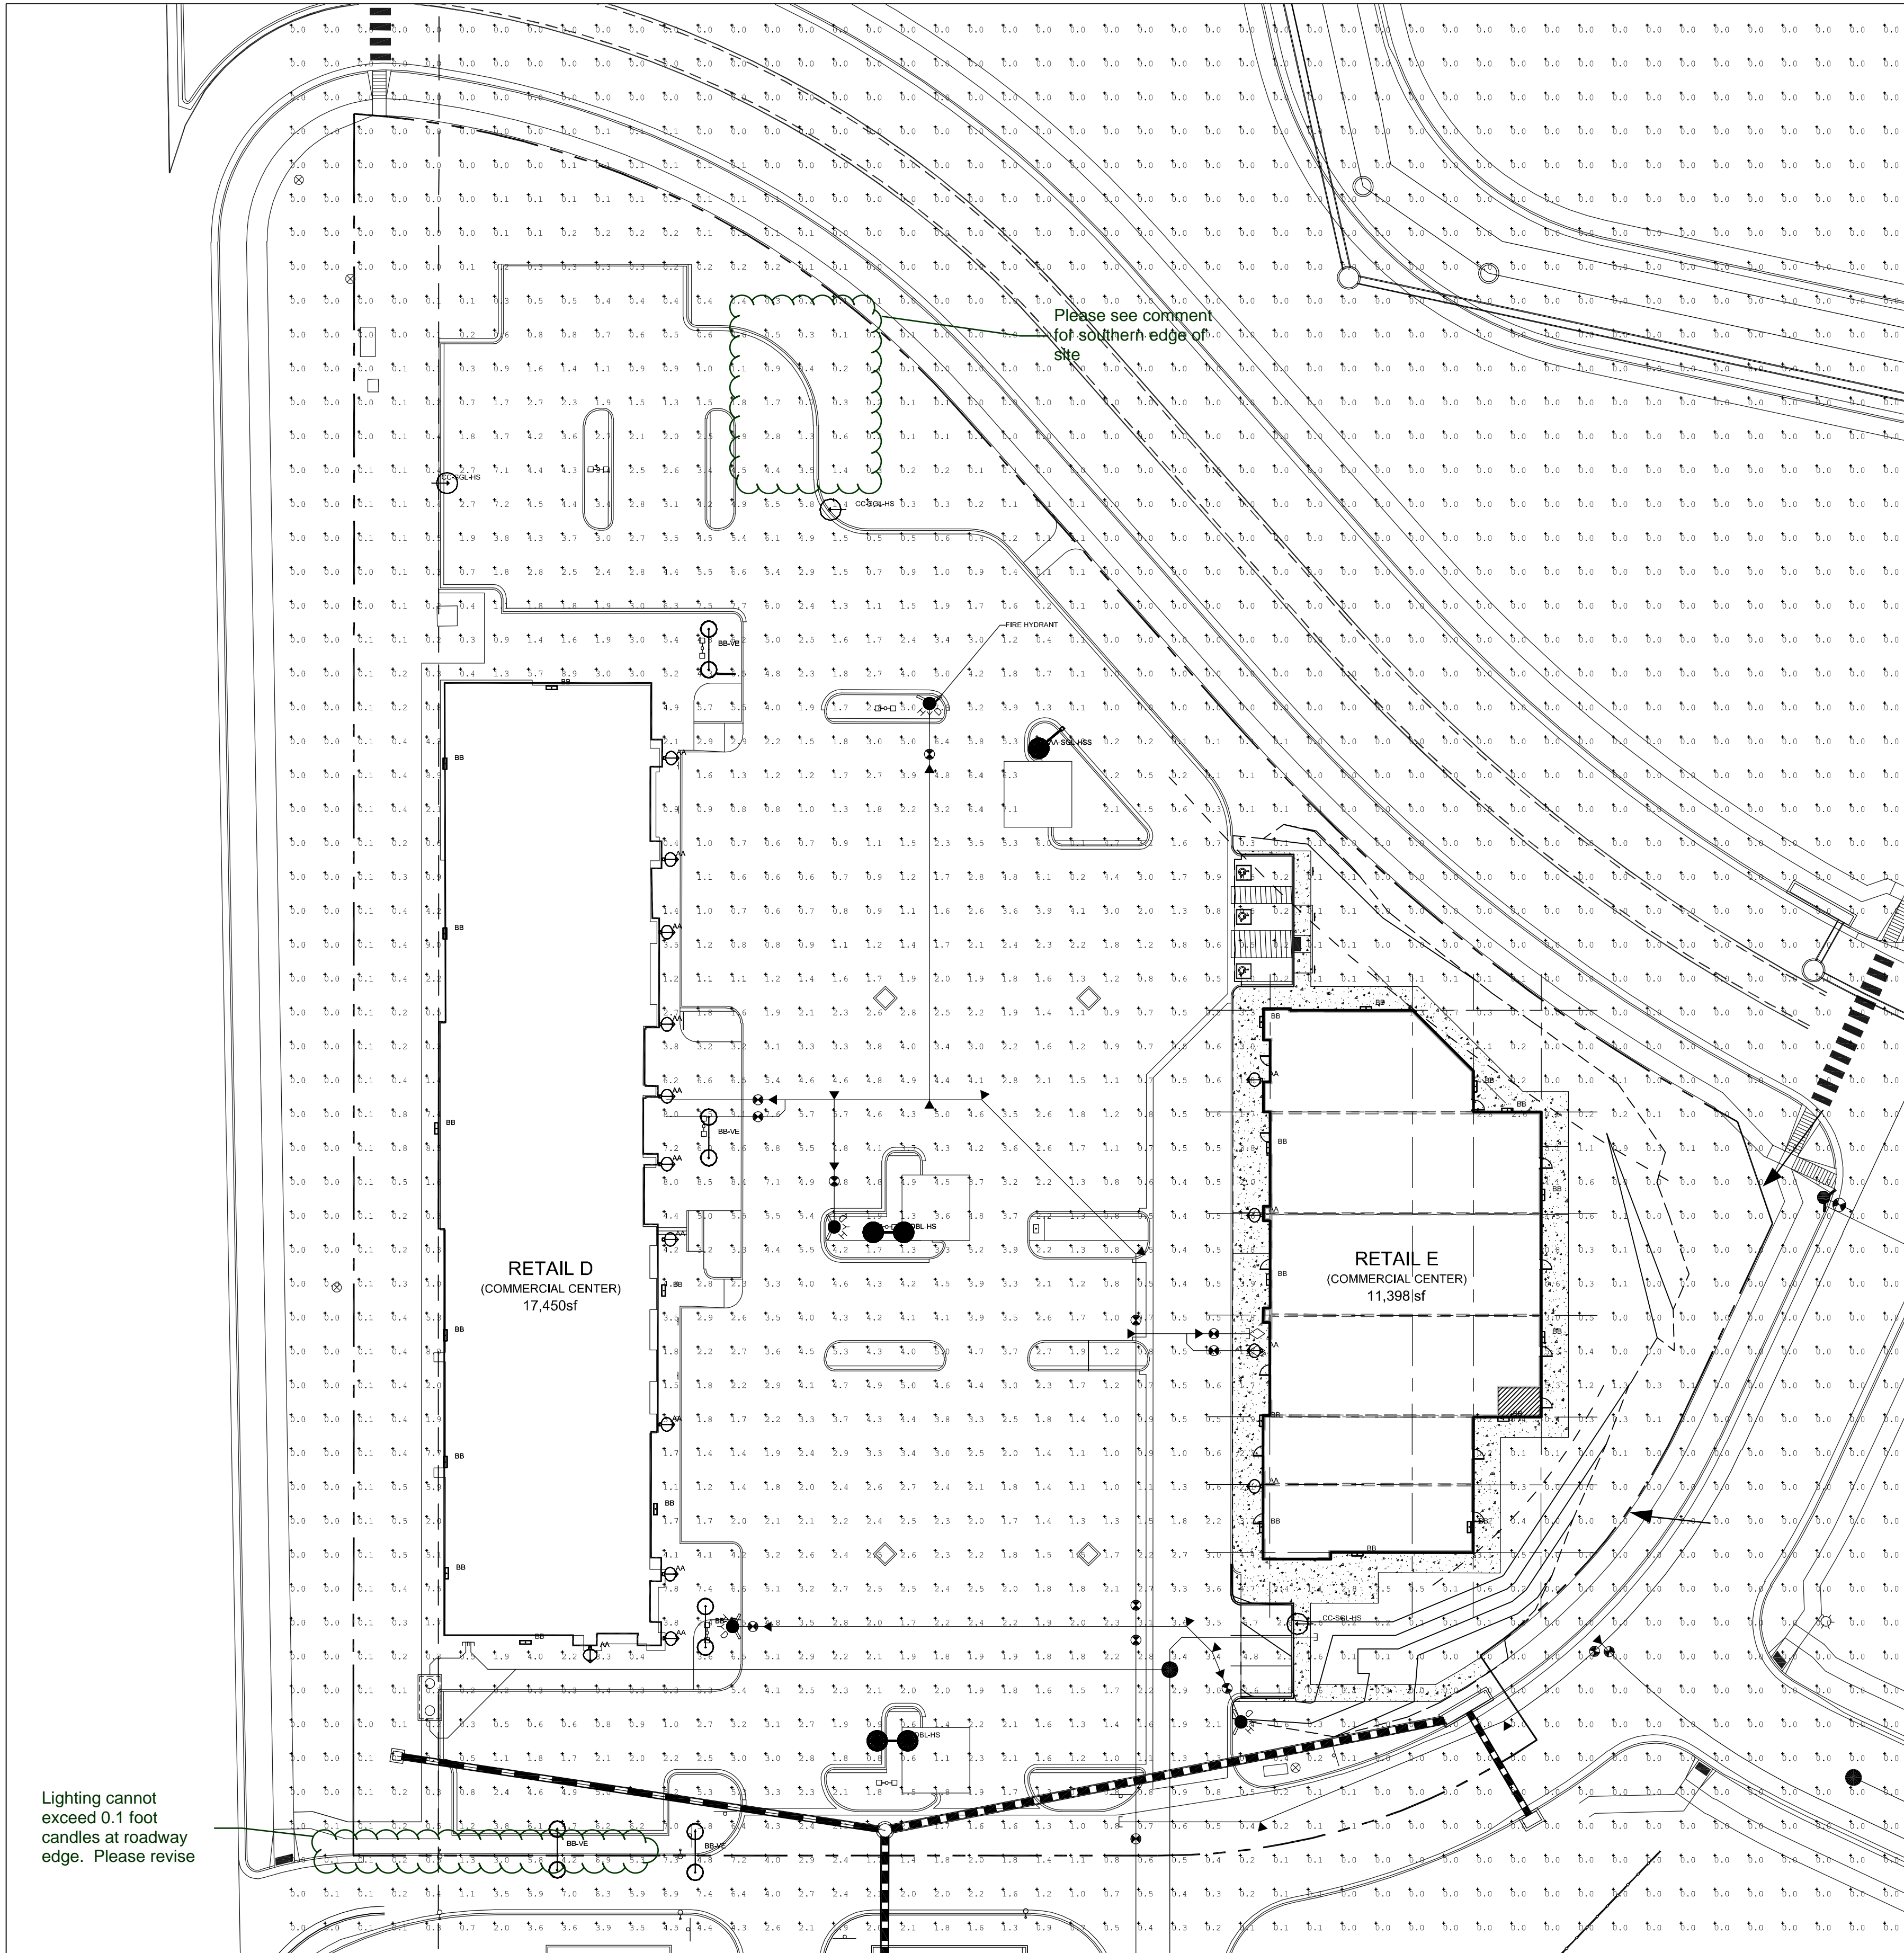

Lighting cannot exceed 0.1 foot candles at roadway edge. Please revise

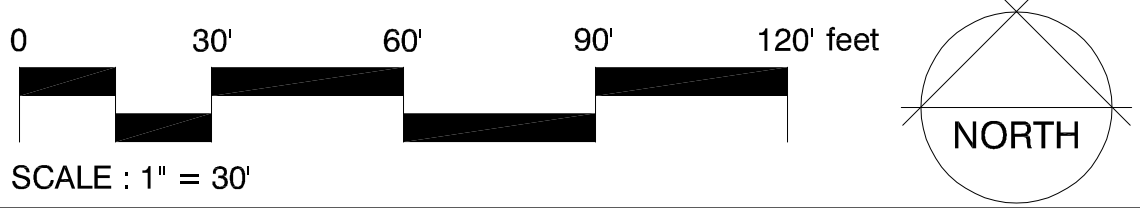

Luminaire Schedule	Qty	Label	Arrangement	Total Lamp Lumens	LLF	Description	Lum. Watts	Total Watts
AA	15	AA	SINGLE	0.900	N.A.	UCS-STR-12LED-NW	28.3	283.5
BB	23	BB	SINGLE	0.900	N.A.	VWPH4L30-730-T3-SDGL-OPT-EDD-UNV	35.7	357
AA-DBL	2	AA-DBL	BACK-BACK	0.900	N.A.	2B/CC253P70-96L4K	216.9	1735.2
AA-SGL	1	AA-SGL	SINGLE	0.900	N.A.	1A/CC253P70-96L4K	216.9	650.7
BB-VE	7	BB-VE	BACK-BACK	0.900	N.A.	2-UCM-ANG-T3-32LED-4K-700-AWT	71.3	998.2001

KIM LIGHTING 25" Arm
Type: AA-SGL-4K

Meridian Ranch
Type: AA-SGL-4K
KIM 1A/CC253P70-96L4K™/DB/NO
Voltage: 120V/60Hz/1000VA/1000W

25" Arm
Type: AA-SGL-4K

Features:
• Full-Cut-Off Light Technology
• Patent Pending Technology
• Available in 4K, 5K, 6K, 8K, 10K, 12K, 15K, 18K, 20K, 24K, 30K, 35K, 40K, 48K, 50K, 54K, 60K, 65K, 70K, 72K, 75K, 80K, 84K, 90K, 96K, 100K, 108K, 114K, 120K, 996K, 1000K

Specifications:
• Max. Height: 10' to 14' 6"

Ordering Code:
AA-SGL-4K

KIM LIGHTING 25" Arm
Type: AA-SGL-4K

Meridian Ranch
Type: AA-SGL-4K
KIM 1A/CC253P70-96L4K™/DB/NO
Voltage: 120V/60Hz/1000VA/1000W

25" Arm
Type: AA-SGL-4K

Features:
• Full-Cut-Off Light Technology
• Patent Pending Technology
• Available in 4K, 5K, 6K, 8K, 10K, 12K, 15K, 18K, 20K, 24K, 30K, 35K, 40K, 48K, 50K, 54K, 60K, 65K, 70K, 72K, 75K, 80K, 84K, 90K, 96K, 100K, 108K, 114K, 120K, 996K, 1000K

Specifications:
• Max. Height: 10' to 14' 6"

Ordering Code:
AA-SGL-4K

KIM LIGHTING 25" Arm Mounted, Curvilinear, PFC/Fluor™ LED
Type: AA-DBL

Meridian Ranch
Type: AA-DBL
KIM 2B/CC253P70-96L4K™/DB/NO
Voltage: 120V/60Hz/1000VA/1000W

25" Arm Mounted, Curvilinear, PFC/Fluor™ LED
Type: AA-DBL

Standard Features:
• Full-Cut-Off Light Technology
• Patent Pending Technology
• Available in 4K, 5K, 6K, 8K, 10K, 12K, 15K, 18K, 20K, 24K, 30K, 35K, 40K, 48K, 50K, 54K, 60K, 65K, 70K, 72K, 75K, 80K, 84K, 90K, 96K, 100K, 108K, 114K, 120K, 996K, 1000K

Specifications:
• Max. Height: 10' to 14' 6"

Ordering Code:
AA-DBL

KIM LIGHTING 25" Arm
Type: BB-VE

Meridian Ranch
Type: BB-VE
KIM 2-UCM-ANG-T3-32LED-4K-700-AWT
Voltage: 120V/60Hz/1000VA/1000W

25" Arm
Type: BB-VE

Features:
• Full-Cut-Off Light Technology
• Patent Pending Technology
• Available in 4K, 5K, 6K, 8K, 10K, 12K, 15K, 18K, 20K, 24K, 30K, 35K, 40K, 48K, 50K, 54K, 60K, 65K, 70K, 72K, 75K, 80K, 84K, 90K, 96K, 100K, 108K, 114K, 120K, 996K, 1000K

Specifications:
• Max. Height: 10' to 14' 6"

Ordering Code:
BB-VE

KIM LIGHTING 25" Arm
Type: AA

Meridian Ranch
Type: AA
KIM 1A/CC253P70-96L4K™/DB/NO
Voltage: 120V/60Hz/1000VA/1000W

25" Arm
Type: AA

Features:
• Full-Cut-Off Light Technology
• Patent Pending Technology
• Available in 4K, 5K, 6K, 8K, 10K, 12K, 15K, 18K, 20K, 24K, 30K, 35K, 40K, 48K, 50K, 54K, 60K, 65K, 70K, 72K, 75K, 80K, 84K, 90K, 96K, 100K, 108K, 114K, 120K, 996K, 1000K

Specifications:
• Max. Height: 10' to 14' 6"

Ordering Code:
AA

KIM LIGHTING 25" Arm
Type: BB

Meridian Ranch
Type: BB
KIM 2-UCM-ANG-T3-32LED-4K-700-AWT
Voltage: 120V/60Hz/1000VA/1000W

25" Arm
Type: BB

Features:
• Full-Cut-Off Light Technology
• Patent Pending Technology
• Available in 4K, 5K, 6K, 8K, 10K, 12K, 15K, 18K, 20K, 24K, 30K, 35K, 40K, 48K, 50K, 54K, 60K, 65K, 70K, 72K, 75K, 80K, 84K, 90K, 96K, 100K, 108K, 114K, 120K, 996K, 1000K

Specifications:
• Max. Height: 10' to 14' 6"

Ordering Code:
BB

YOW ARCHITECTS PC
ARCHITECTURE & PLANNING
115 S. Weber
Colorado Springs, Colorado 475-8133

Shop's @ Meridian Ranch
Site Development Plan
Meridian Road
Falcon, CO

Job No.: 18.115
Directory: Planning
File: Site development plan 4-8-19
Drawn By: DBN
Date: 6/22/2018
Revised: 10/4/2018
11/28/2018
4/8/2019

DRAWING NO. **4**
PHOTOMETRIC PLAN

company name: SHOPS AT MERIDIAN RANCH LLC
address/city/state: P.O. BOX 80036 SAN DIEGO CA 91238
phone no: