

Design Development
 Consultants @
 1310 FORD STREET
 COLORADO SPRINGS, CO 80915
 (719) 570-1456

Revisions	DATE
#	
DESCRIPTION	

CO. CTR. METRO. DISTRICT ADMINISTRATION BUILDING

9696 FLAGSTONE STREET
 COLORADO SPRINGS, CO 80916

D2-0321


DP

DATE	06-28-2021
CHECKED	-
DRAWN BY	-

FLOOR PLAN

DP-2

(C) ALL RIGHTS RESERVED

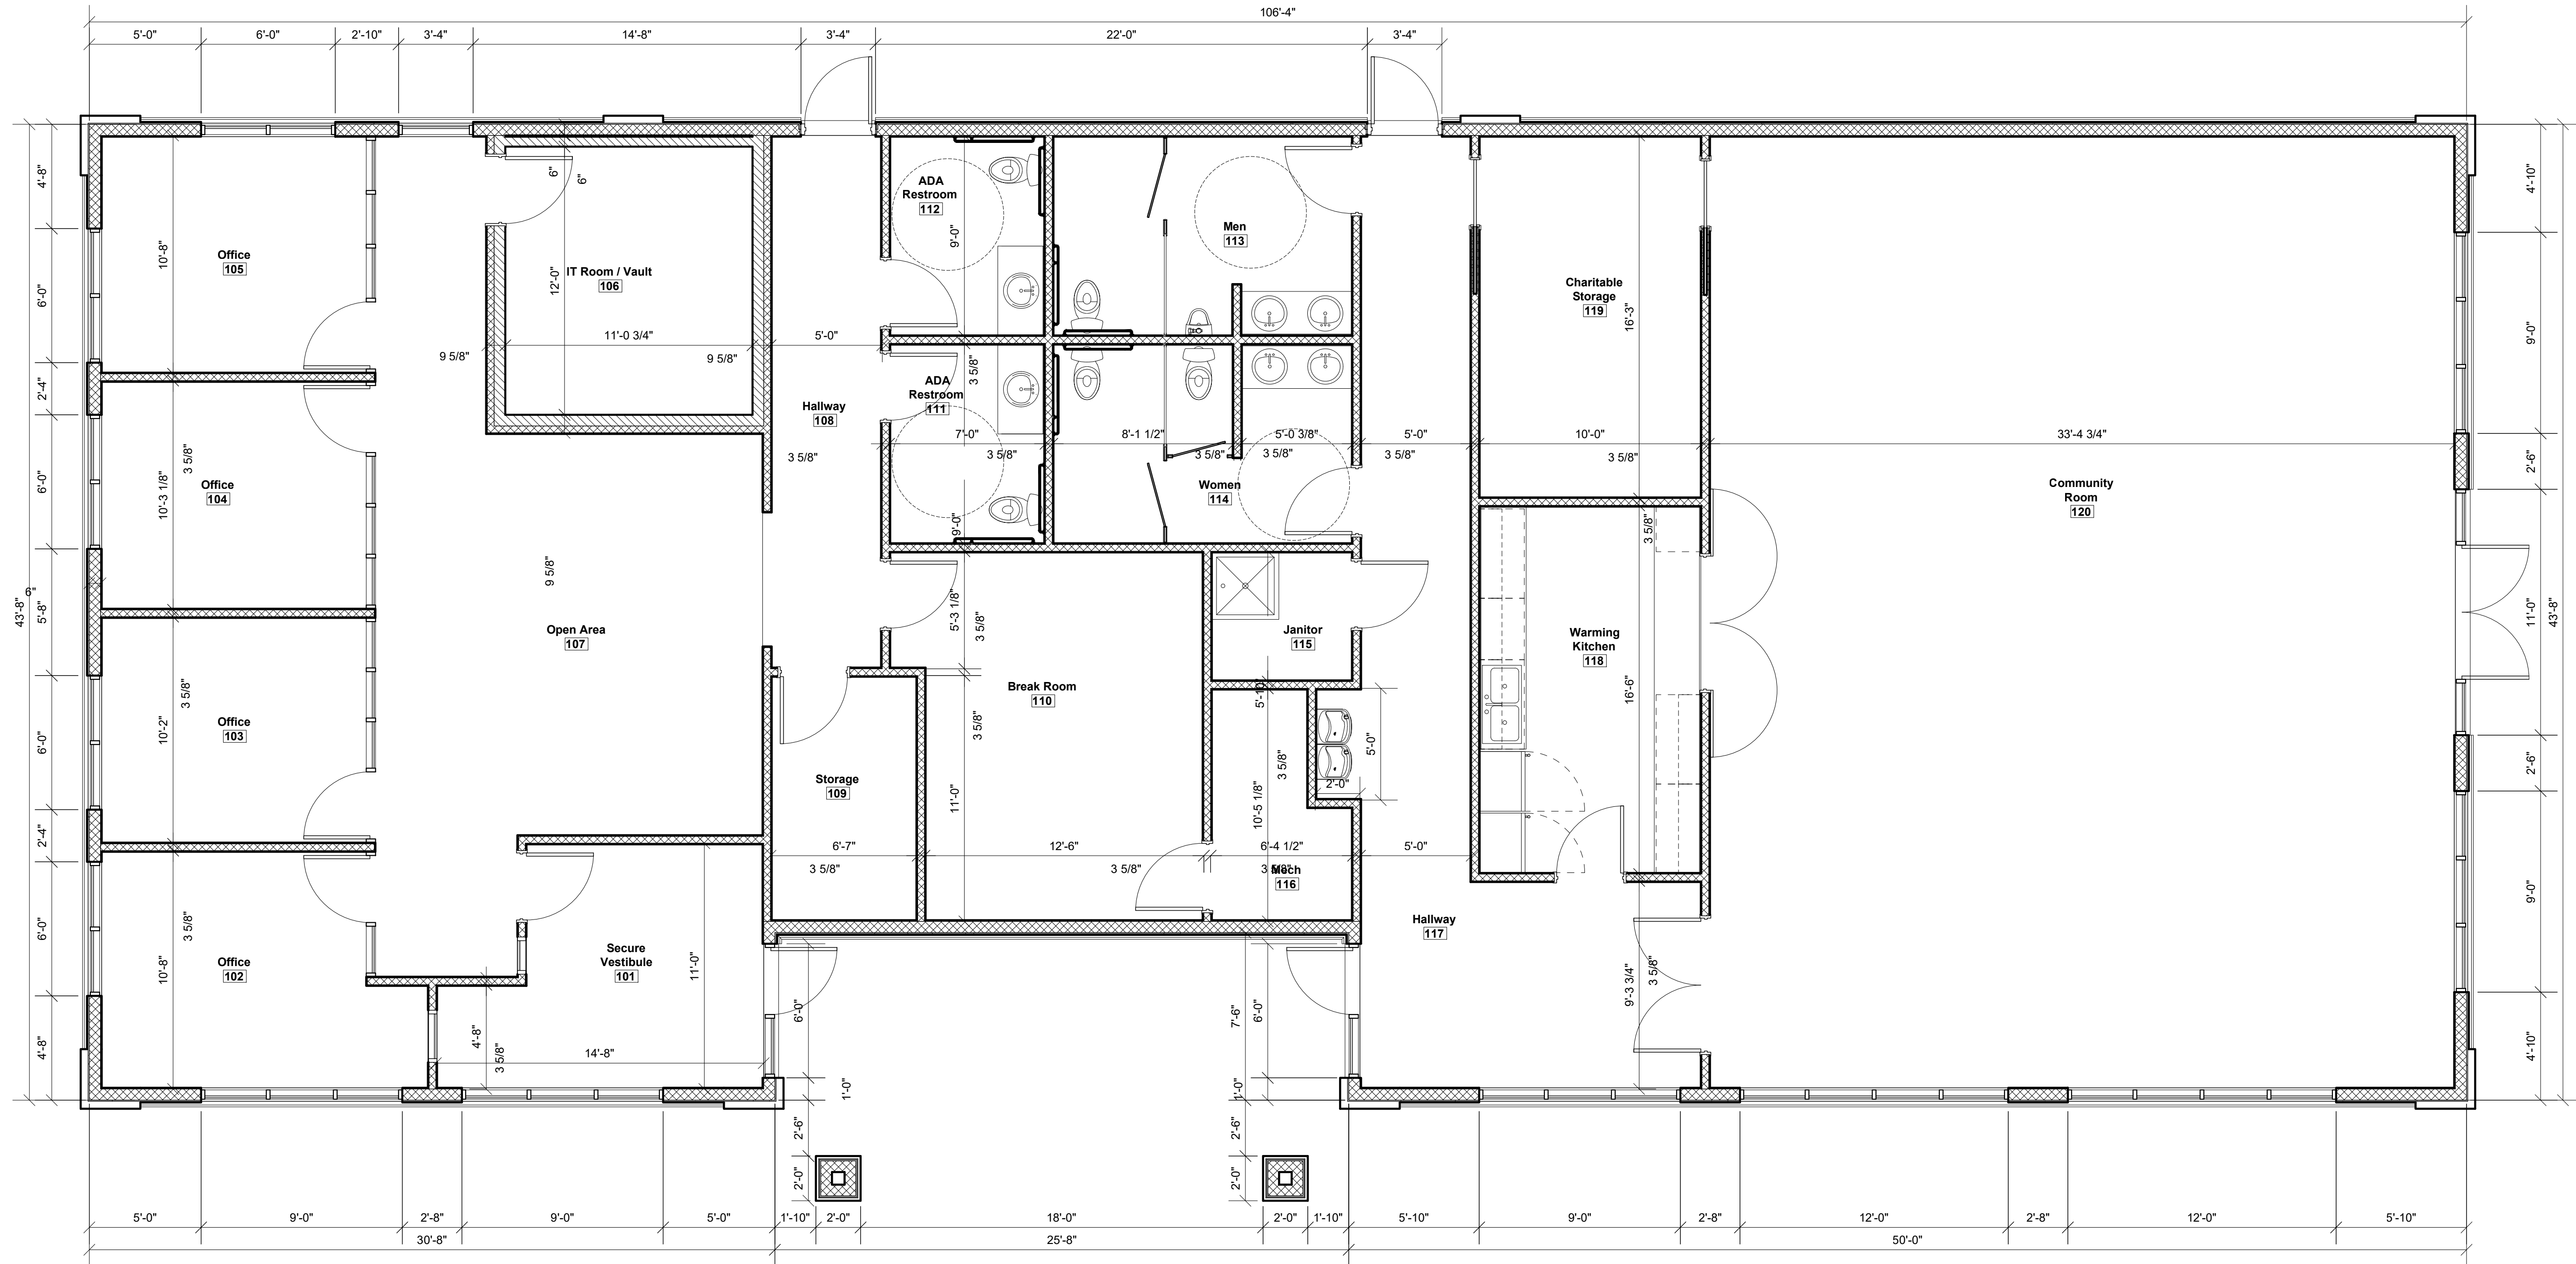

1 FLOOR PLAN
 1/4" = 1'-0"

PCD FILE #

I:\0_Plan\0321021_Plan\0321021_Plan.dwg, 11/15/2021 11:07 AM, AutoCAD Plot (General Documentation)