




**BUCHER**  
DESIGN STUDIO

architecture • planning  
12325 Oracle Blvd. Suite 101  
Colorado Springs, CO 80921  
(719) 484-0480

Brian K. Bucher, AIA  
Architect  
CO license no. C-4889  
CA license no. C 23506

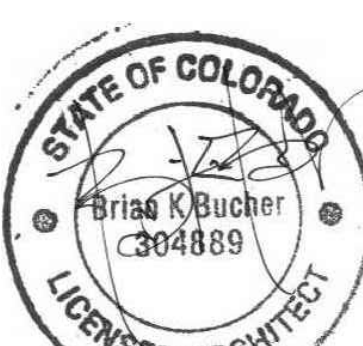

A PROPOSED  
ADDITION  
FOR

DR. HOUSER

8011 MERIDIAN PARK DR.  
FALCON, CO 80881

Sheet Title:  
**SITE  
LIGHTING PLAN**

Drawing Status:  
**SITE DEV  
SUBMITTAL**

Revisions:  
No. Description By Date

1. 1/17/22

Date: 1/17/22

Drawn by:

Checked by:


Scale: AS NOTED

Job No.:

Sheet No.:

**A0.2**

2 Of 7

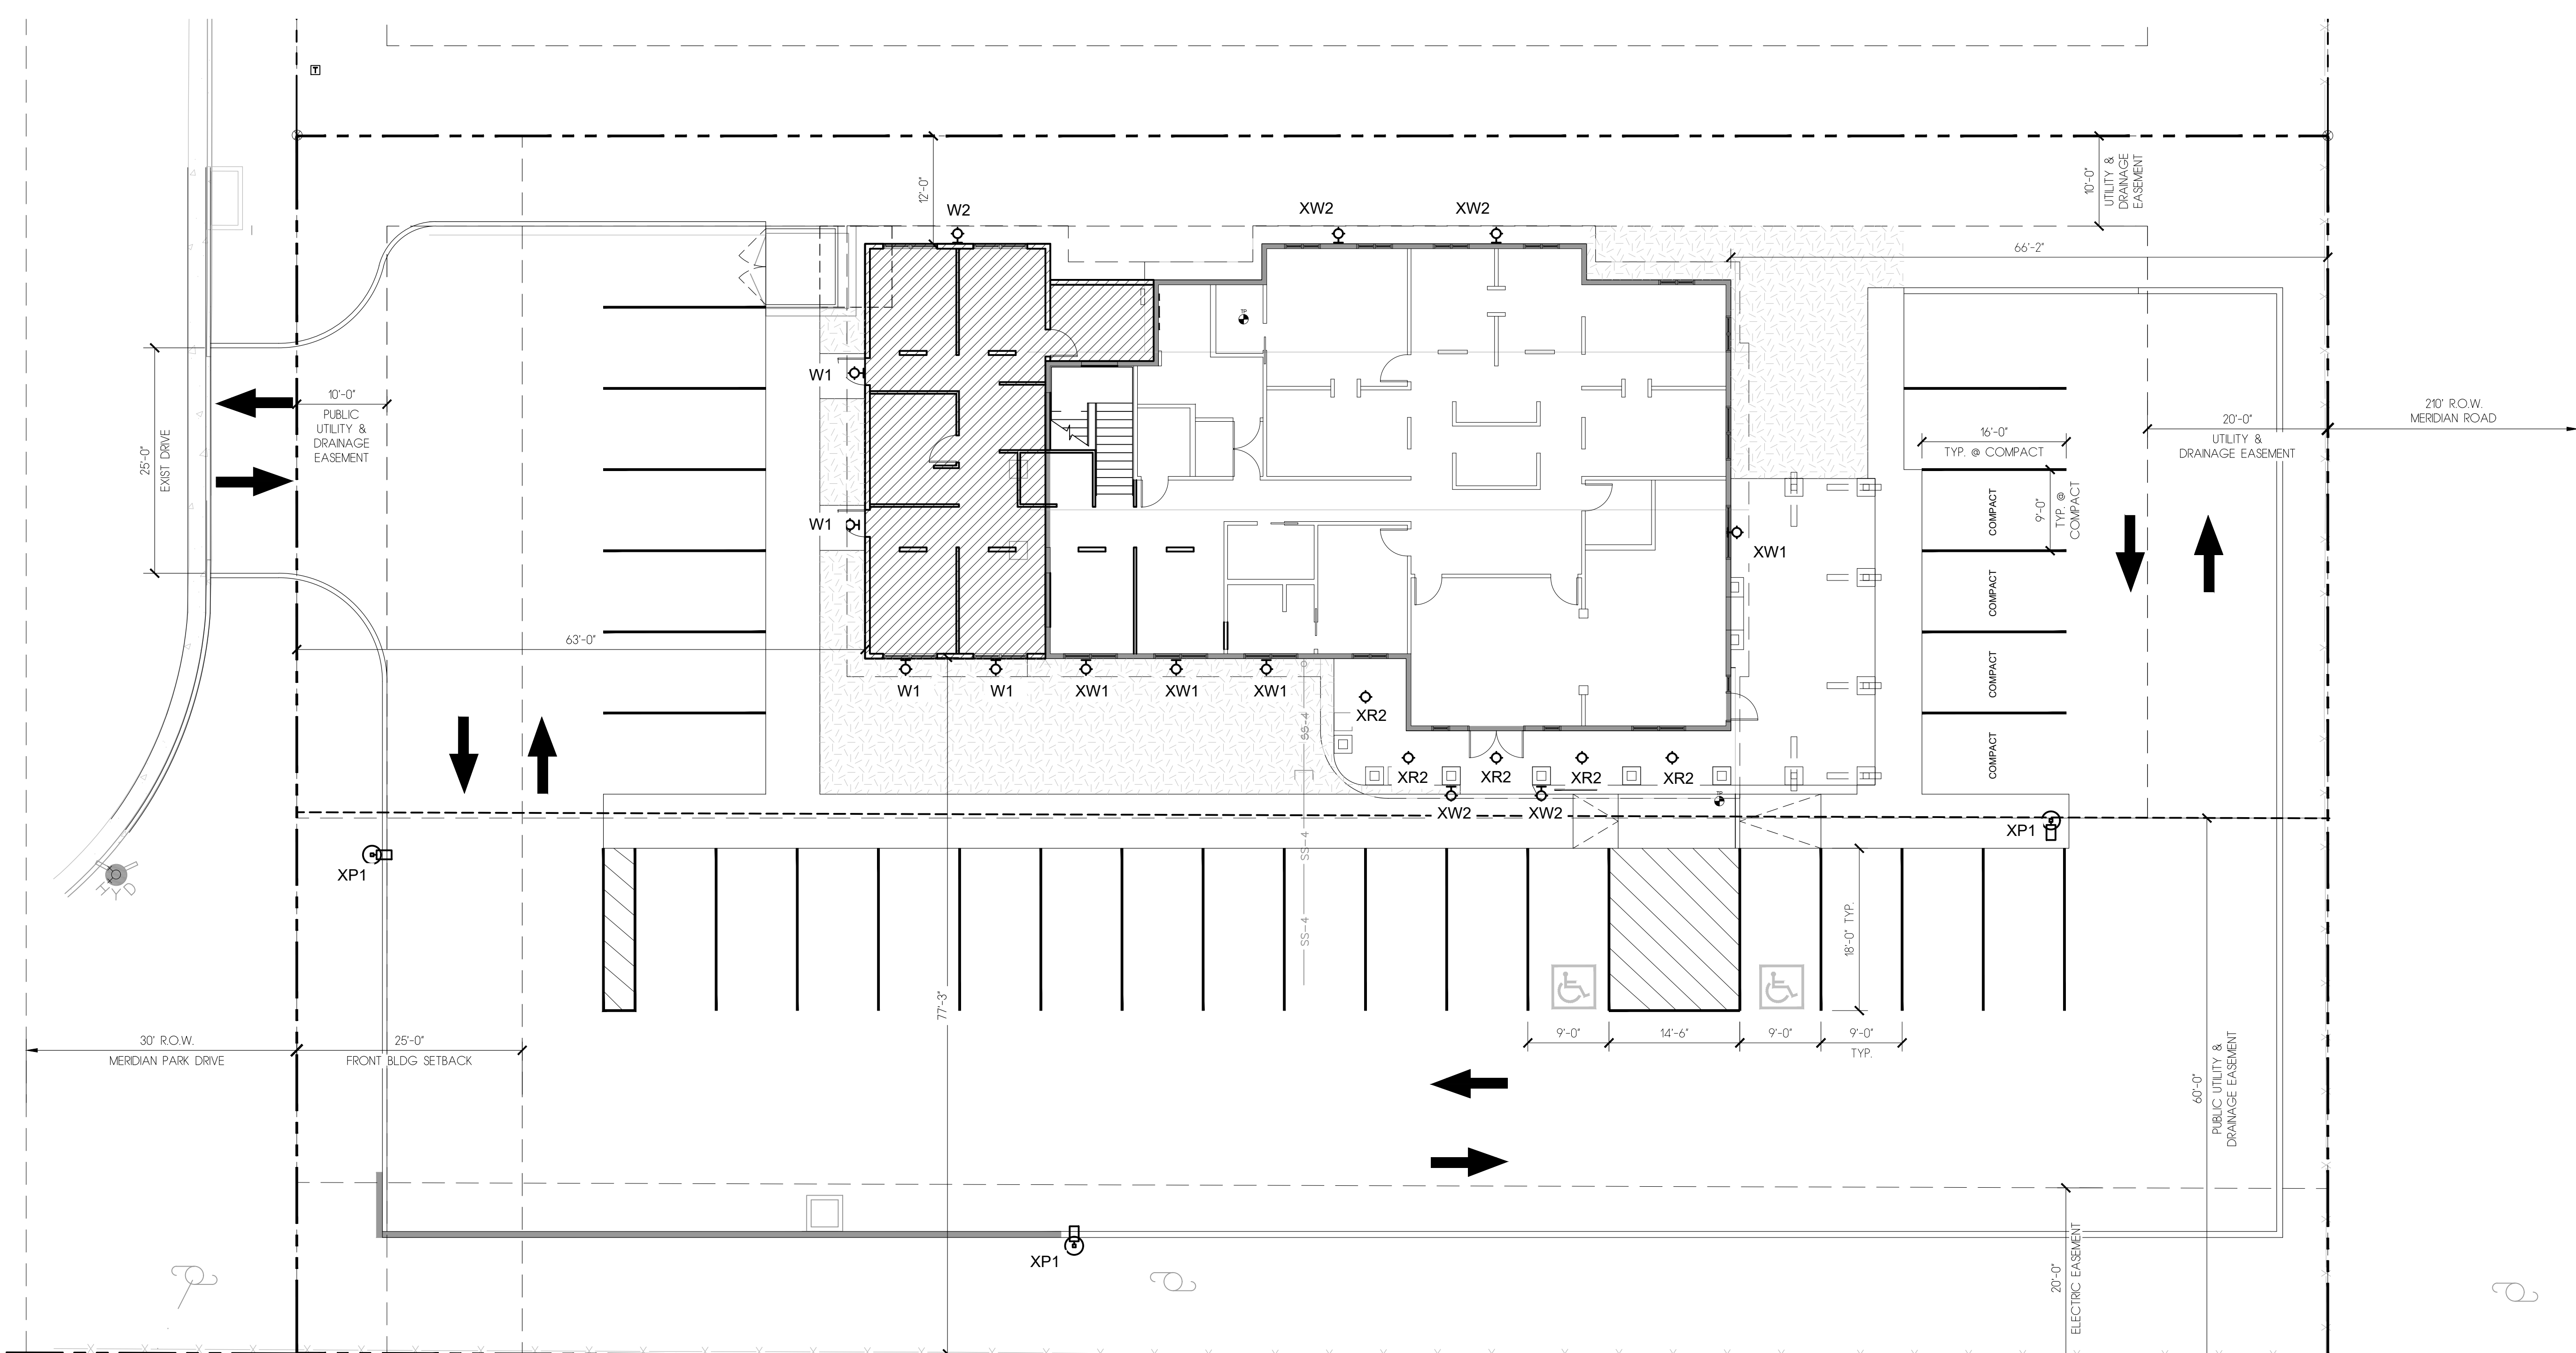

**SITE LIGHTING PLAN**  
SCALE: 1"=10'-0"

EXTERIOR LIGHTING SCHEDULE	
XP1	EXISTING POLE LIGHT- 20' HIGH 400W METAL HALIDE
XR1	EXISTING RECESSED 6" DOWN LIGHT- 22W LED CAN FIXTURE
XW1	EXISTING WALL MOUNTED LIGHT FIXTURE- 17W LED GOOSENECK TYPE FIXTURE
XW2	EXISTING WALL MOUNTED LIGHT FIXTURE- 39W LED SCOFF
W1	NEW WALL MOUNTED LIGHT FIXTURE TO MATCH EXISTING XW1
W2	NEW WALL MOUNTED LIGHT FIXTURE TO MATCH EXISTING XW2