

THIS DOCUMENT AND ITS CONTENTS ARE THE WORK PRODUCT AND PROPERTY OF 51EC, INC., WHICH RETAINS ALL COMMON LAW, STATUTORY AND OTHER RESERVED RIGHTS, INCLUDING THE COPYRIGHT.

NEW BUILD
MANCAVE RV STORAGE
BENT GRASS MEADOWS DR.
PEYTON, CO 80831

REV	DESCRIPTION	DRAWN	CHECK	APPR	DATE

ISSUANCE:

ISSUED FOR REVIEW

CLIENT:

HAMMERS CONSTRUCTION
1411 WOOLSEY HEIGHTS
COLORADO SPRINGS, CO 80915

ARCHITECT:

HAMMERS CONSTRUCTION
1411 WOOLSEY HEIGHTS
COLORADO SPRINGS, CO 80915

PROJECT NO:


5151-20-01

TITLE:

SITE PLAN
PHOTOMETRICS

SHEET NO:

E-L-001

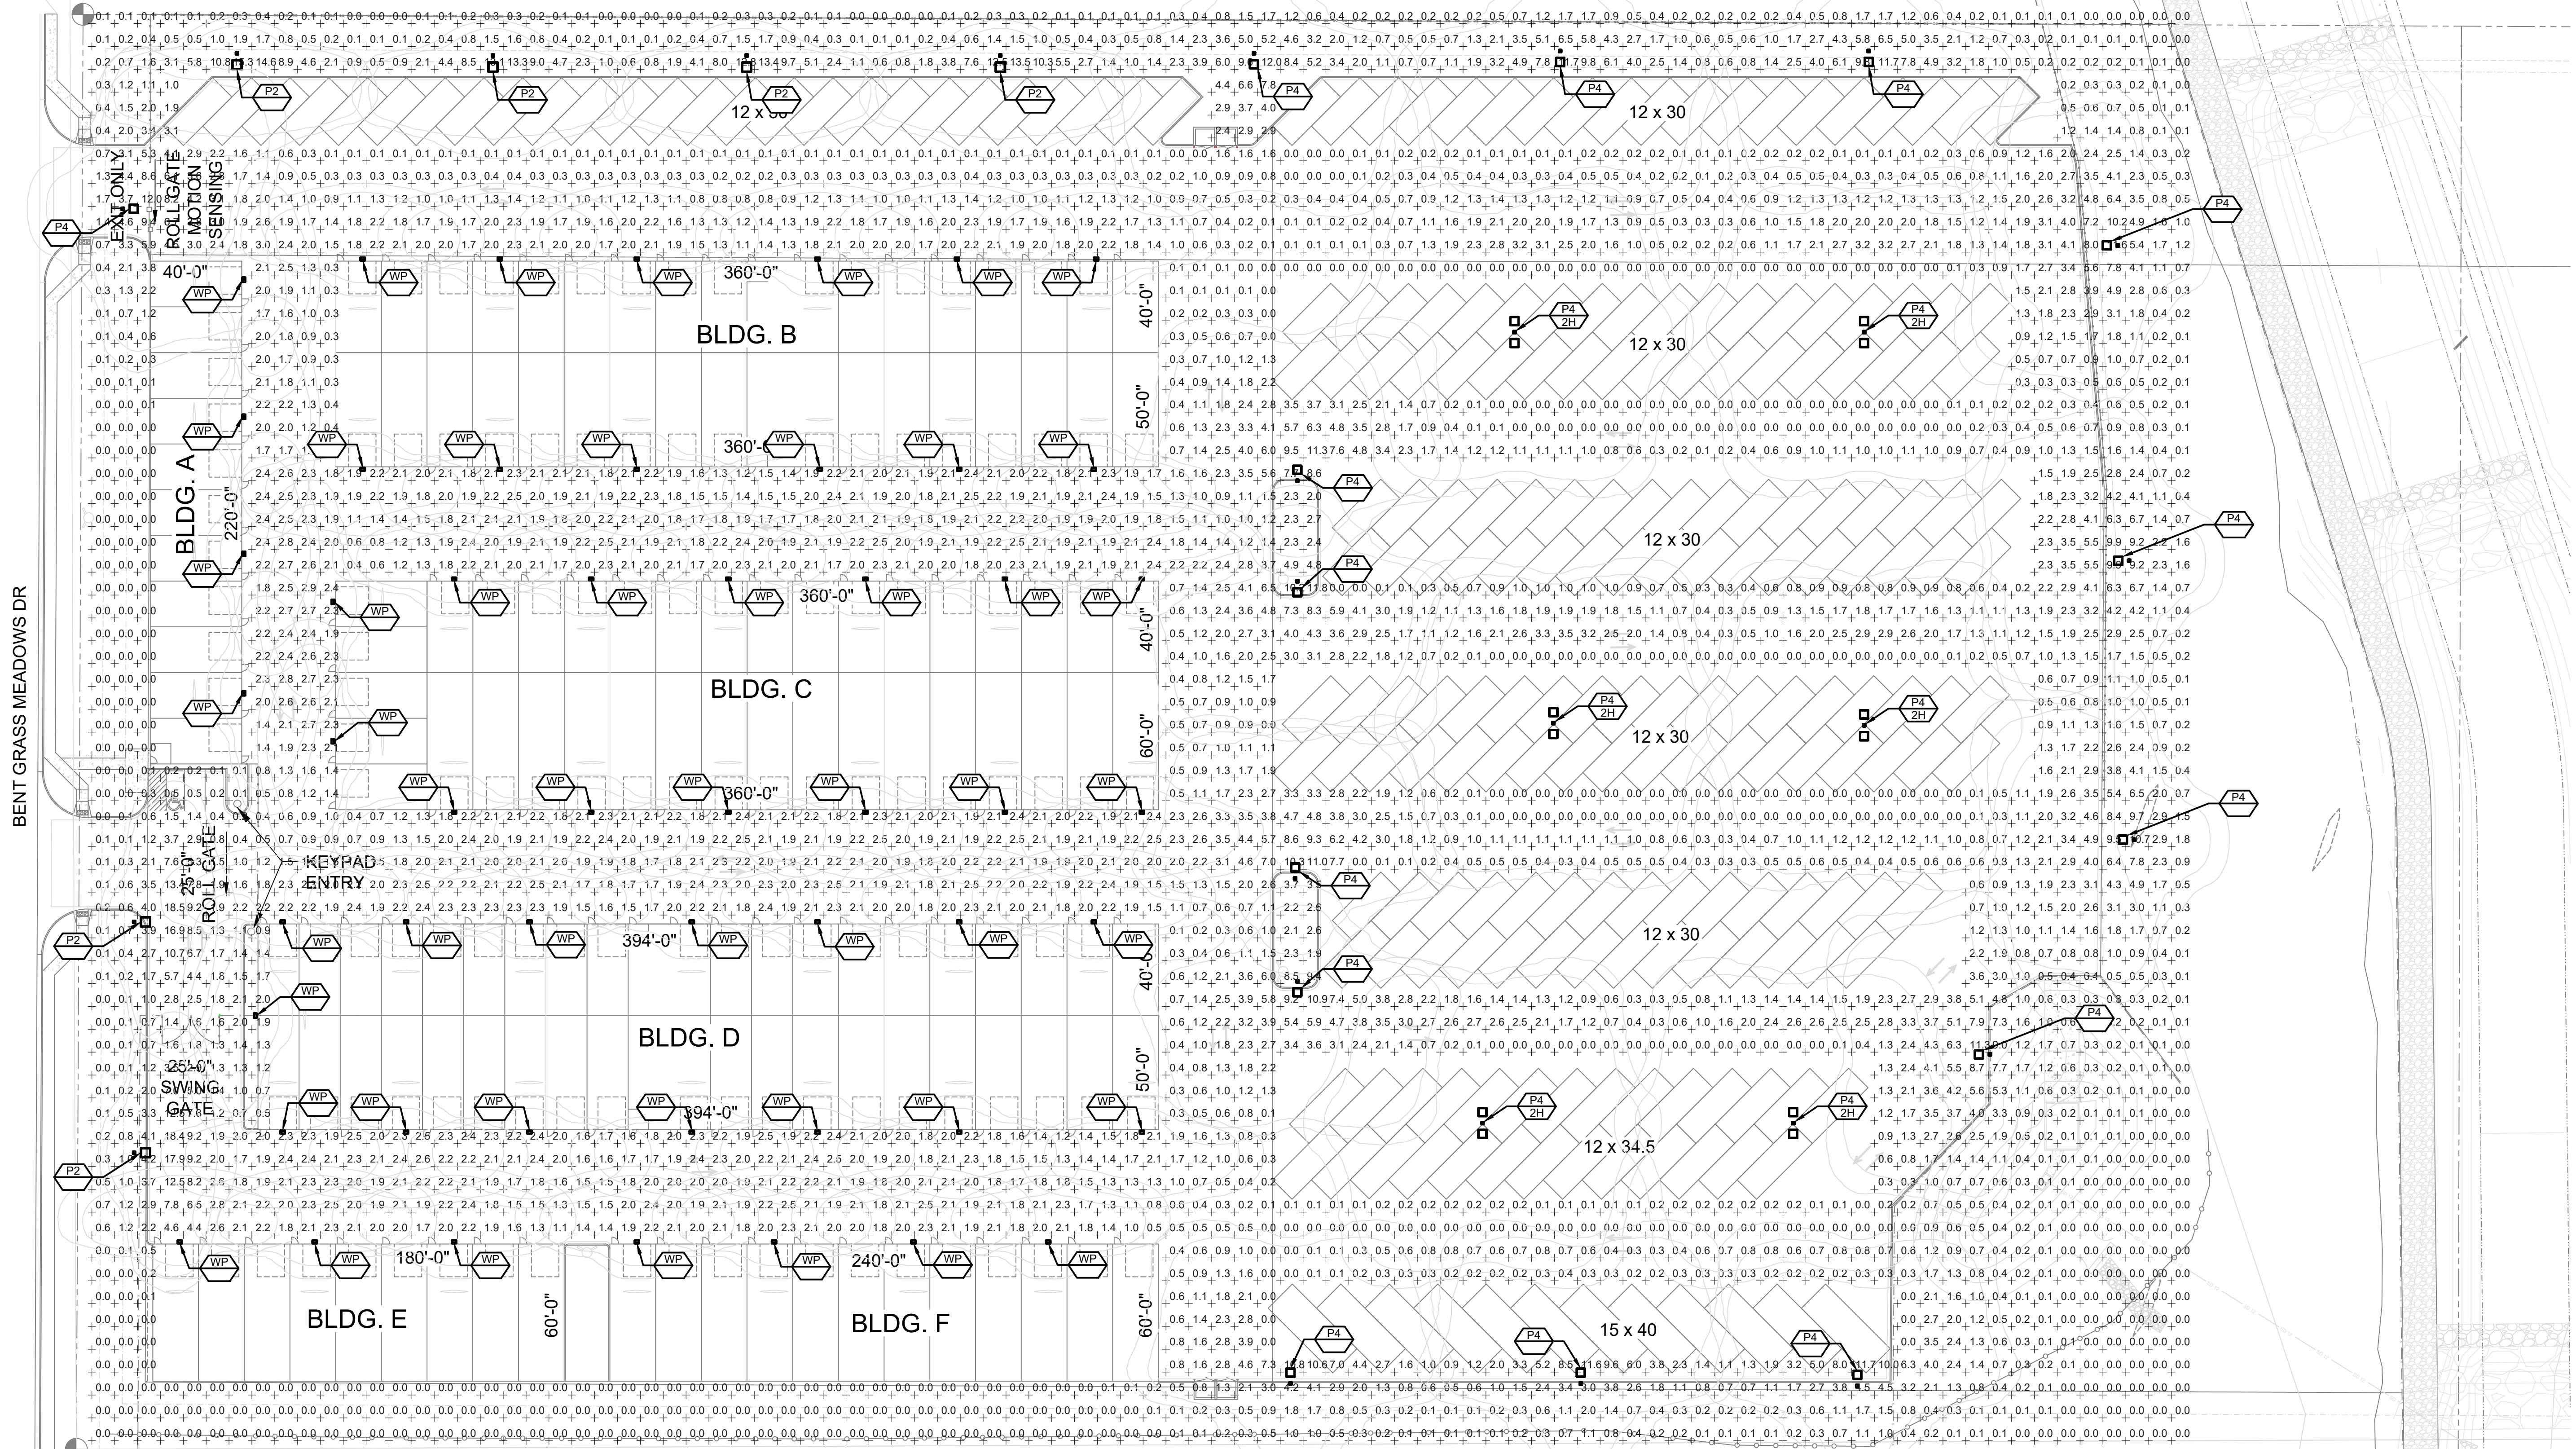

Symbol	Label	Image	Quantity	Manufacturer	Catalog Number	Description	Number Lamps	Lumens Per Lamp	Light Loss Factor	Wattage	Plot
WP	WP		52	Lithonia Lighting	WDGE2 LED P4 40K 80CRI T2M	WDGE2 LED WITH P4 - PERFORMANCE PACKAGE, 4000K, 80CRI, TYPE 2 MEDIUM OPTIC	1	4207	0.92	46.6589	
P2	P2		6	Lithonia Lighting	RSX2 LED P4 40K R2 HS	RSX LED Area Luminaire Size 2 P4 Lumen Package 4000K CCT Type R2 Distribution with HS shield	1	18970	0.92	189.54	
P4	P4		15	Lithonia Lighting	RSX2 LED P4 40K R4	RSX Area Fixture Size 2 P4 Lumen Package 4000K CCT Type R4 Distribution	1	25328	0.92	189.54	
P4-2H	P4-2H		6	Lithonia Lighting	RSX2 LED P4 40K R4	RSX Area Fixture Size 2 P4 Lumen Package 4000K CCT Type R4 Distribution	1	25328	0.92	379.08	

Statistics						
Description	Symbol	Avg	Max	Min	Max/Min	Avg/Min
Site	+	1.5 fc	18.5 fc	0.0 fc	N/A	N/A

SITE PLAN PHOTOMETRICS
SCALE: NTS

