

FURNITURE & EQUIPMENT FLOOR PLAN

SCALE: 1/4" = 1'-0"

BUILDING PLAN NOTES:

1. DIMENSIONS ARE FROM FACE OF STUD.
2. SEE THIS SHEET FOR DOOR SCHEDULES.
3. MECHANICAL, ELECTRICAL, AND PLUMBING SUBCONTRACTORS TO COMPLY W/ FIRE BLOCKING AND FIRE STOPPING REQUIREMENTS AT ALL PENETRATIONS OF RATED WALL, FLOOR/CEILING, AND ROOF/CEILING ASSEMBLIES.



FLOOR PLAN KEY NOTES:

- ◆ FLOOR DRAIN PER PLUMBING PLANS
- ◆ SINK PER PLUMBING PLANS
- ◆ WASH BASIN PER PLUMBING PLANS
- ◆ SEALED CONCRETE COUNTER TOPS (BY OWNER)
- ◆ CUSTOM GAS FIREPLACE
- ◆ SEATS, TABLES, BENCHES (BY OWNER)

EQUIPMENT PLAN KEY NOTES:


- ◆ FERMENTORS (BY OWNER)
- ◆ BREWING EQUIPMENT (BY OWNER)
- ◆ BREWING EQUIPMENT (BY OWNER)
- ◆ KEG WASHER (BY OWNER)
- ◆ WINE COOLER (BY OWNER)
- ◆ REACH-IN COOLER (BY OWNER)
- ◆ PREP TABLE (BY OWNER)
- ◆ KEGORATOR (BY OWNER)
- ◆ 10' x 8' WALK-IN COOLER (BY OWNER)

WALL TYPE DETAILS:

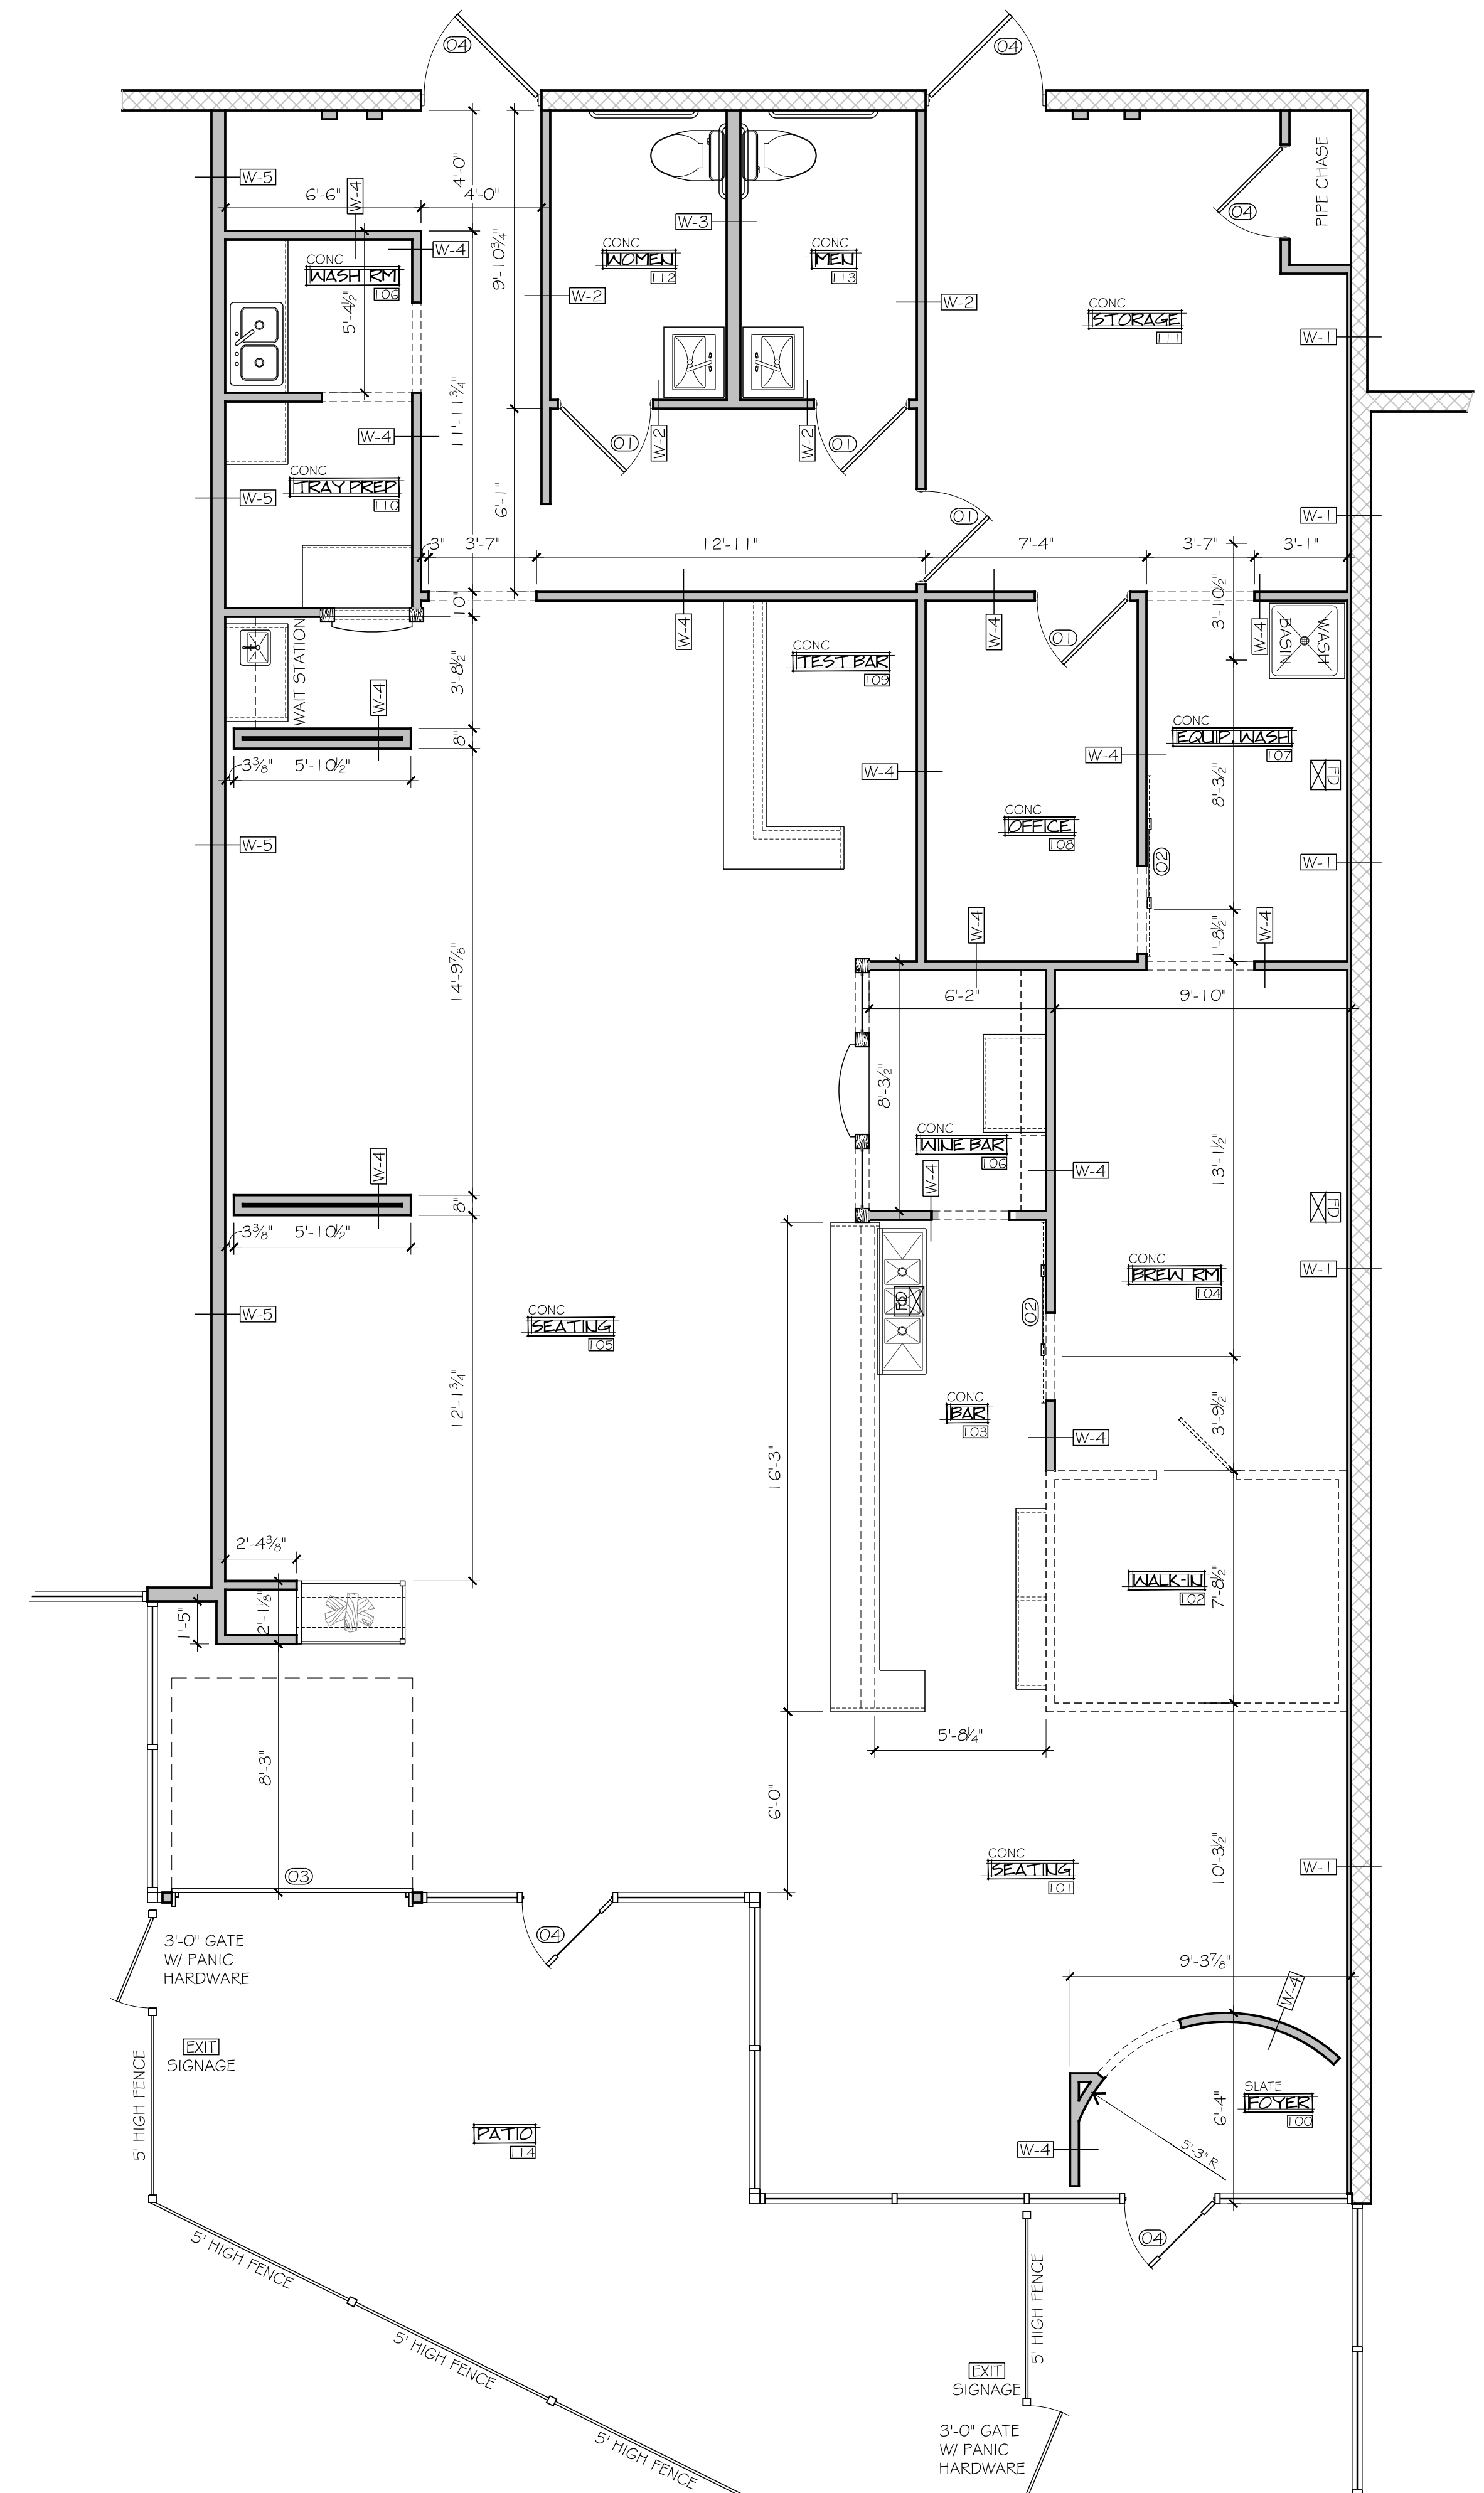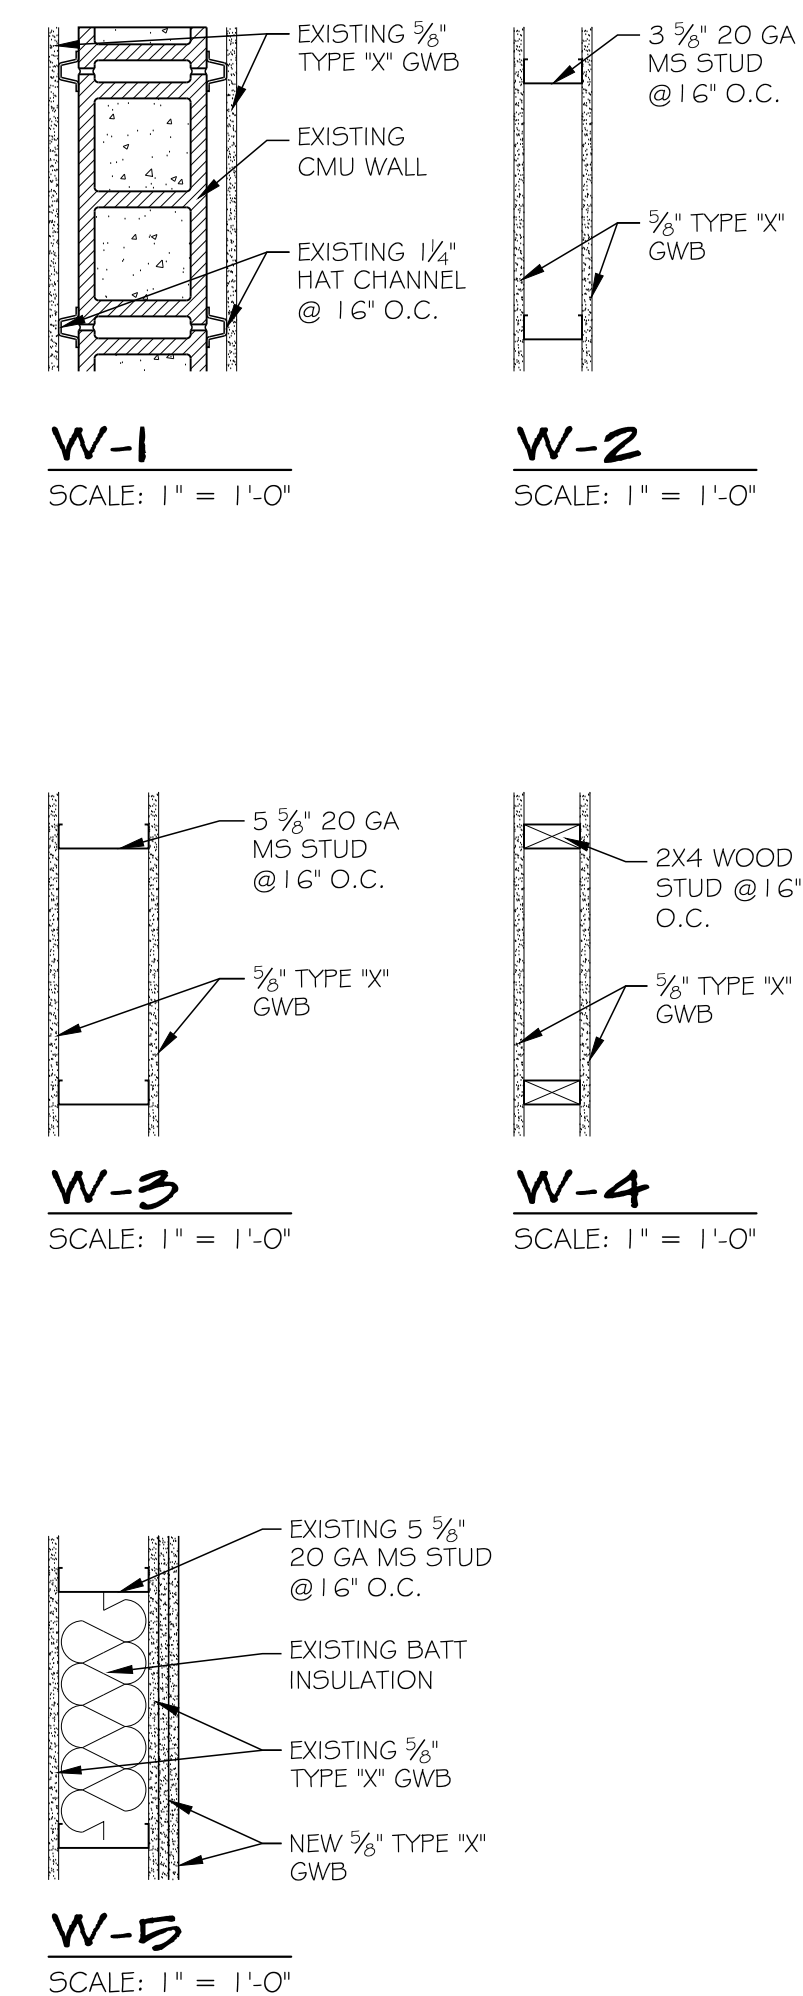


FLOOR PLAN

SCALE: 1/4" = 1'-0"

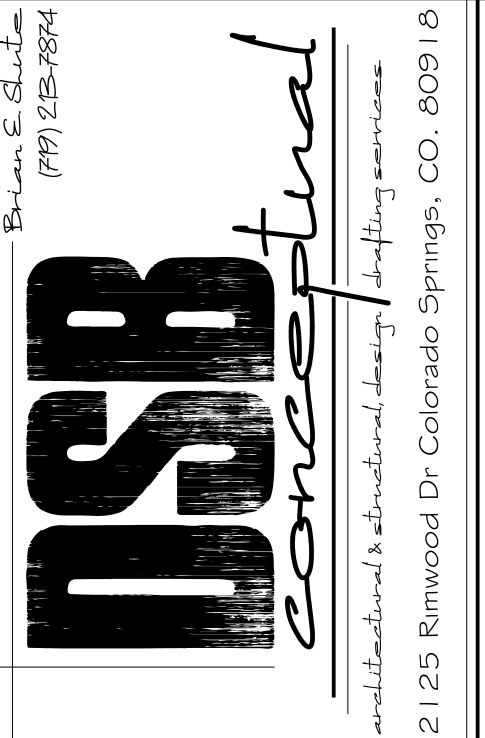

BATCH SLAPPED
 5859 PALMER PARK BLVD. CSCO 80915

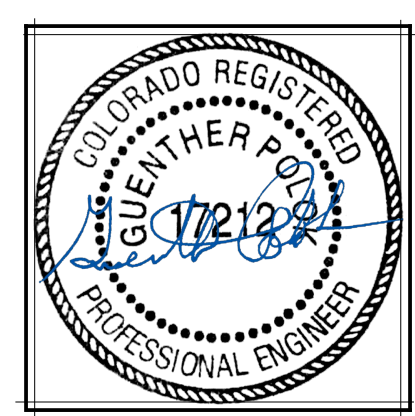

ISSUE	DATE
DRAWN BY B SHULTE	CHECKED BY G POLCK
FLOOR PLANS	
BS004-20	
A 2.0	