





PROD. FILE: P:\Harmens Construction\Grumpy Trumpsters Site\Grumpy Trumpsters - Lot 5\Electrical\Photometrics\Grumpy Trumpsters - Lot 5 - Photometrics.dwg
PLOT DATE: 06/22/20 3:51 PM
BY: JBRM4

Schedule													
Symbol	Label	Image	QTY	Manufacturer	Catalog Number	Description	Lamp	Number Lamps	Filename	Lumens per Lamp	Lumen Multiplier	LLF	Wattage
	WP1		7	Lithonia Lighting	WDGE2 LED P4 40K 80CRI VF	WDGE2 LED WITH P4 - PERFORMANCE PACKAGE, 4000K, 80CRI, VISUAL COMFORT FORWARD OPTIC		1	WDGE2_LED_P4_40K_80CRI_VF.ies	4412	1	0.92	34.96
												Efficiency	100%
												Distribution	TYPE III, VERY SHORT, BUG RATING: B1 - U0 - G1
												Polar Plot	
												Notes	

Statistics						
Description	Symbol	Avg	Max	Min	Max/Min	Avg/Min
Site	+	0.5 fc	6.9 fc	0.0 fc	N/A	N/A

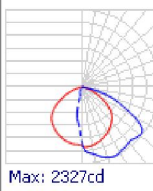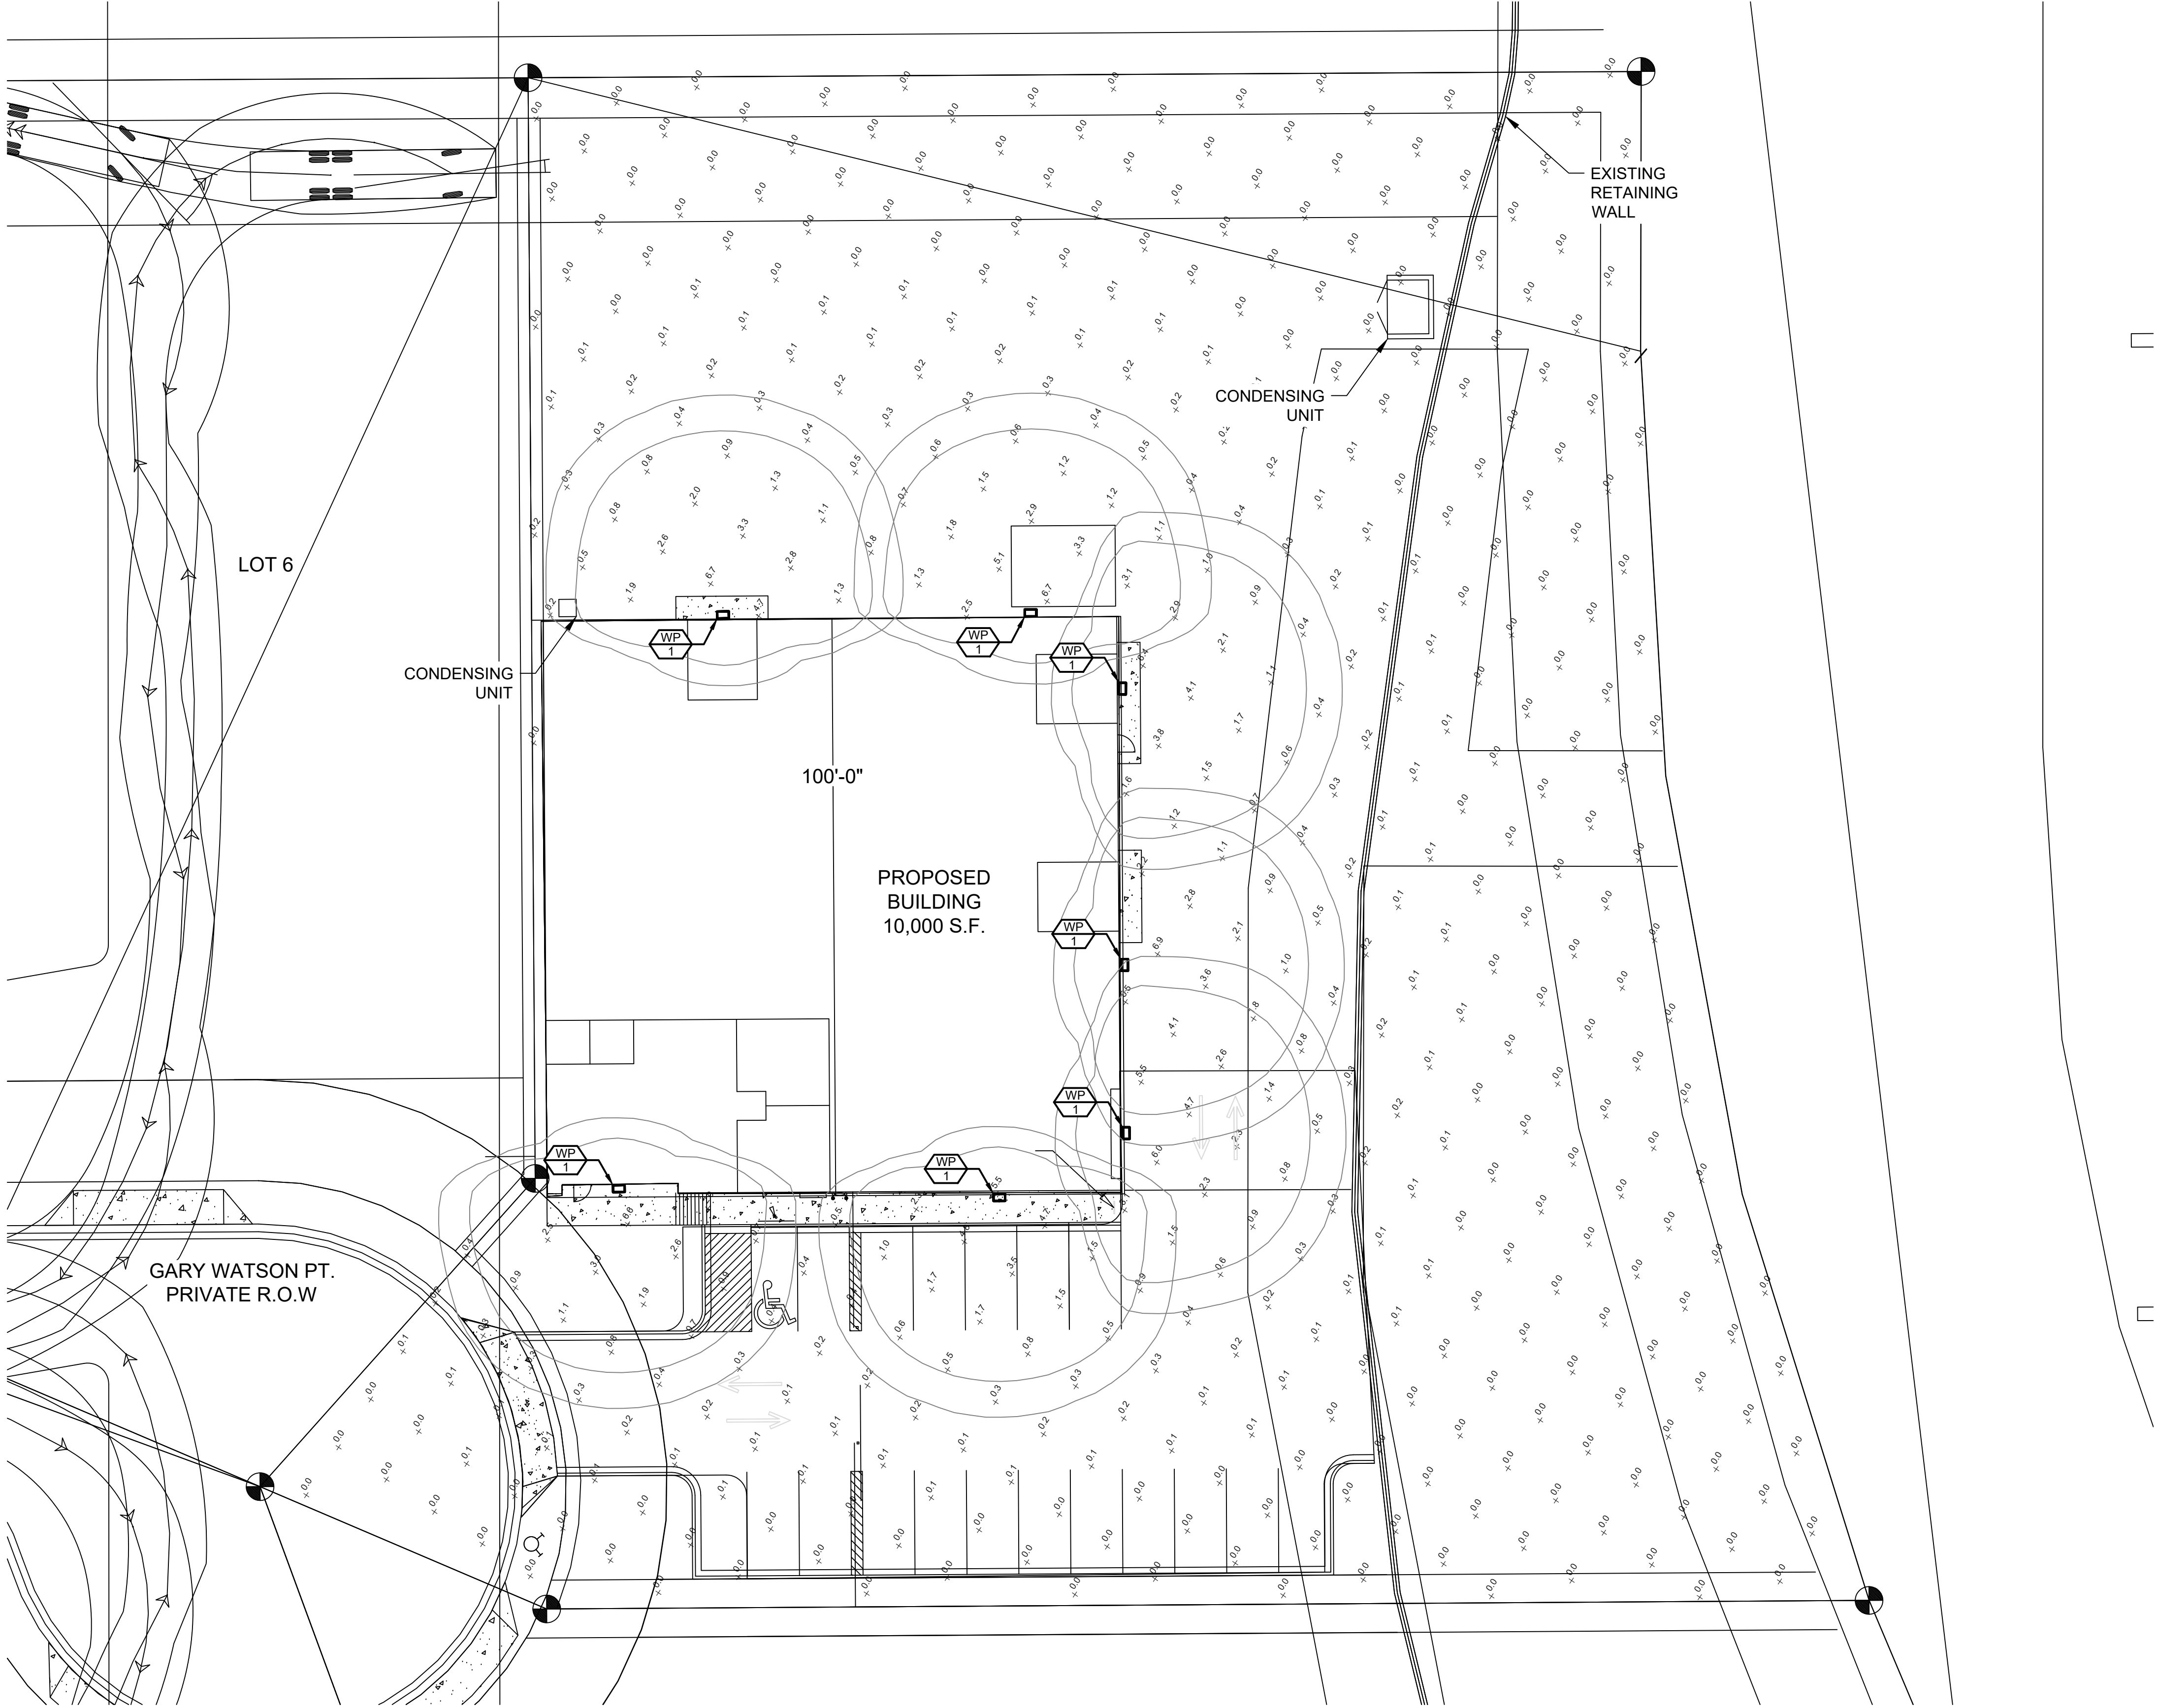

PHOTOMETRICS SITE PLAN
SCALE: NTS

THIS DOCUMENT AND ITS CONTENTS ARE THE WORK PRODUCT AND PROPERTY OF 51EC, INC., WHICH RETAINS ALL COMMON LAW, STATUTORY AND OTHER RESERVED RIGHTS, INCLUDING THE COPYRIGHT.

GRUMPY TRUMPSTERS
LOT 5
7776 GARY WATSON POINT
COLORADO SPRINGS, CO 80915

REV	DESCRIPTION	DRAWN	CHECK	APPR	DATE

ISSUANCE:	
ISSUED FOR REVIEW	
CLIENT:	
HAMMERS CONSTRUCTION 1411 WOOLSEY HEIGHTS COLORADO SPRINGS, CO 80915	
ARCHITECT:	
PROJECT NO:	
5151-20-05A	
TITLE:	
PHOTOMETRICS SITE PLAN	
SHEET NO:	
11 OF 13	

