




BSK INVESTMENTS LIGHTING PLAN EL PASO COUNTY, COLORADO

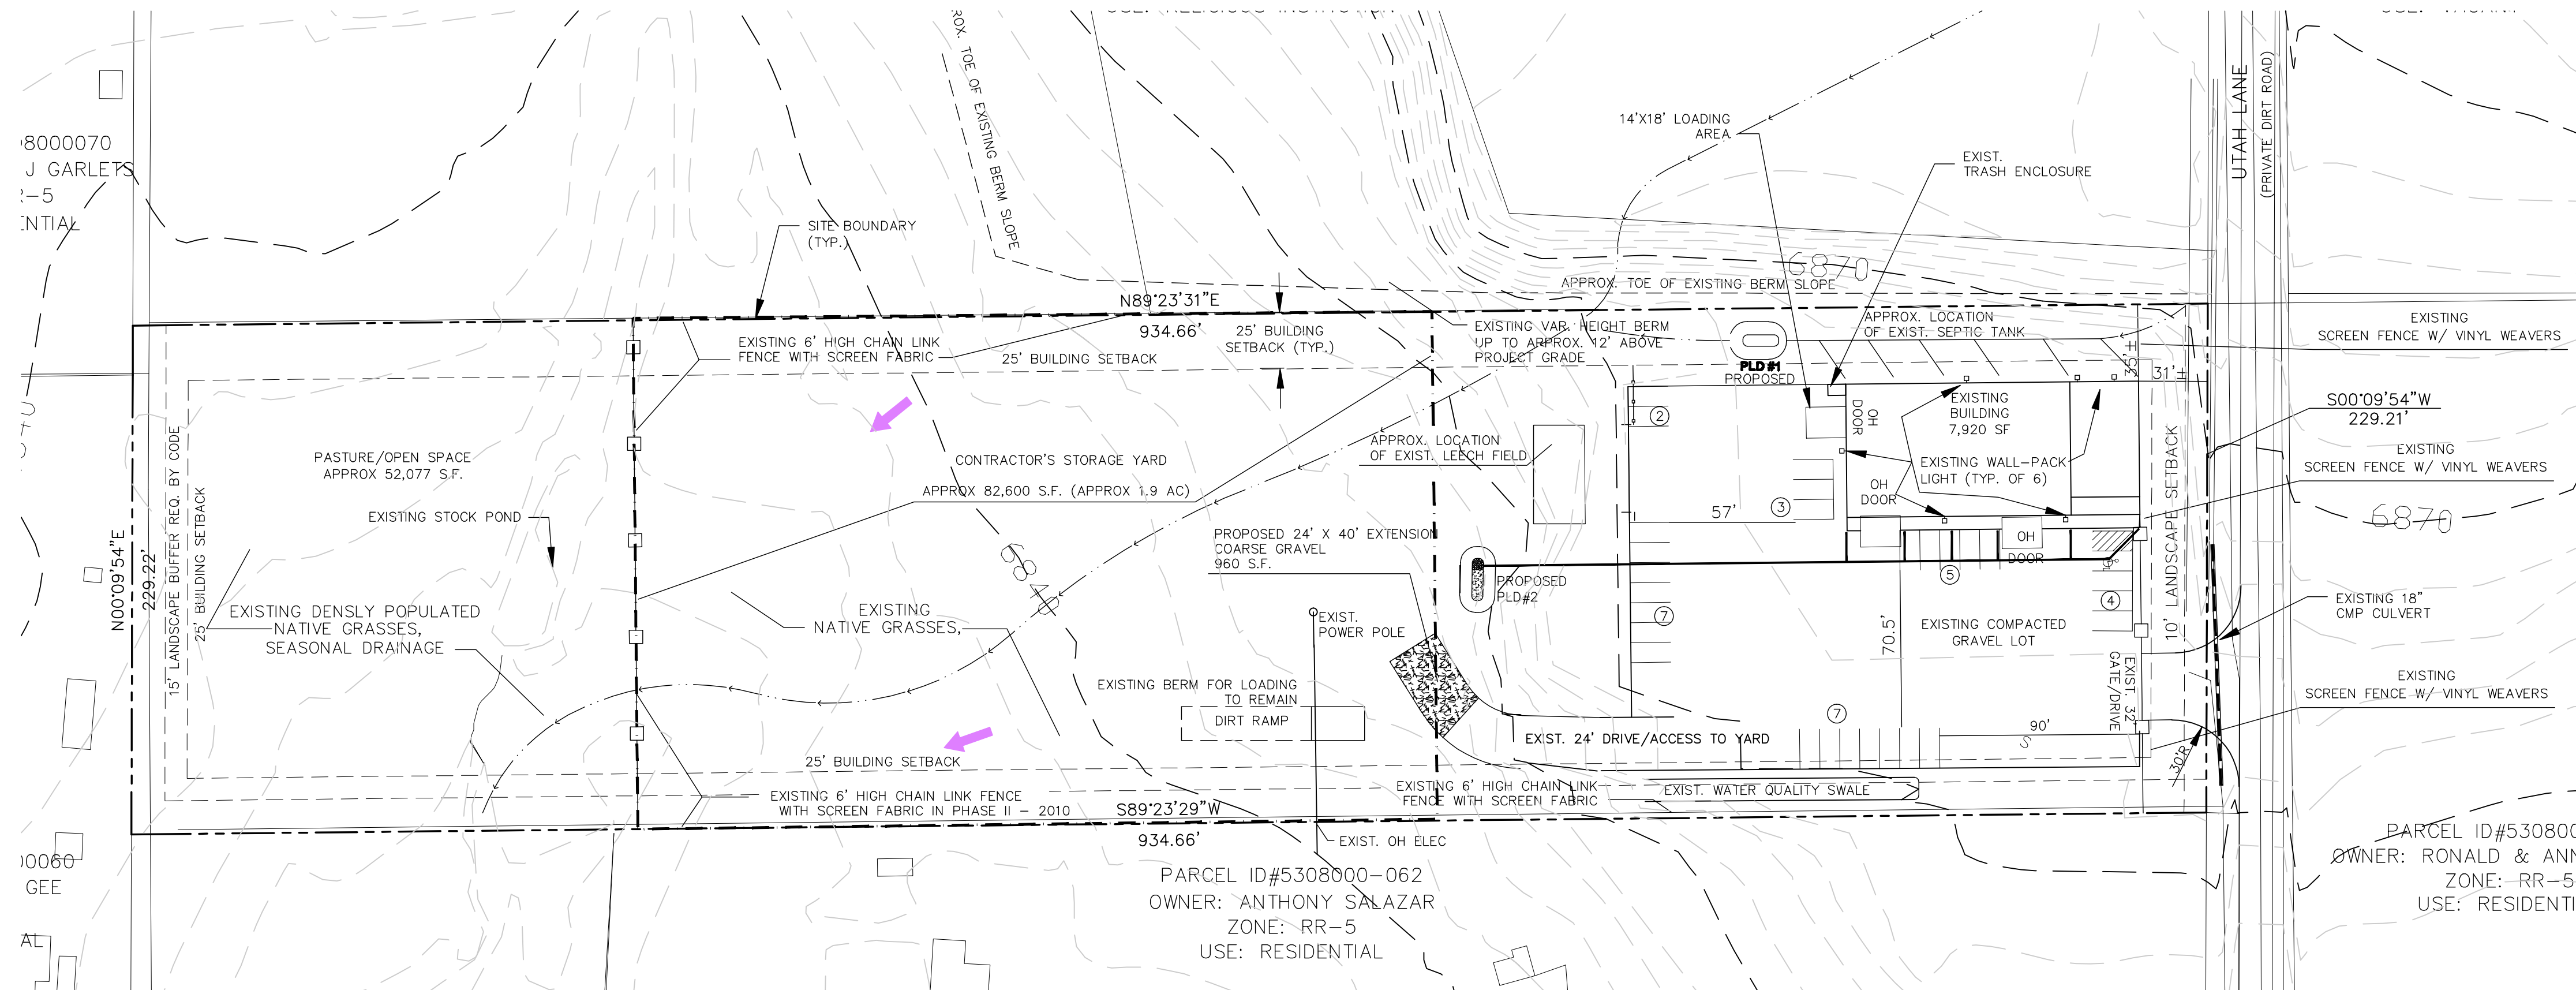


0 50 100 200
HORIZONTAL SCALE: 1"=50'

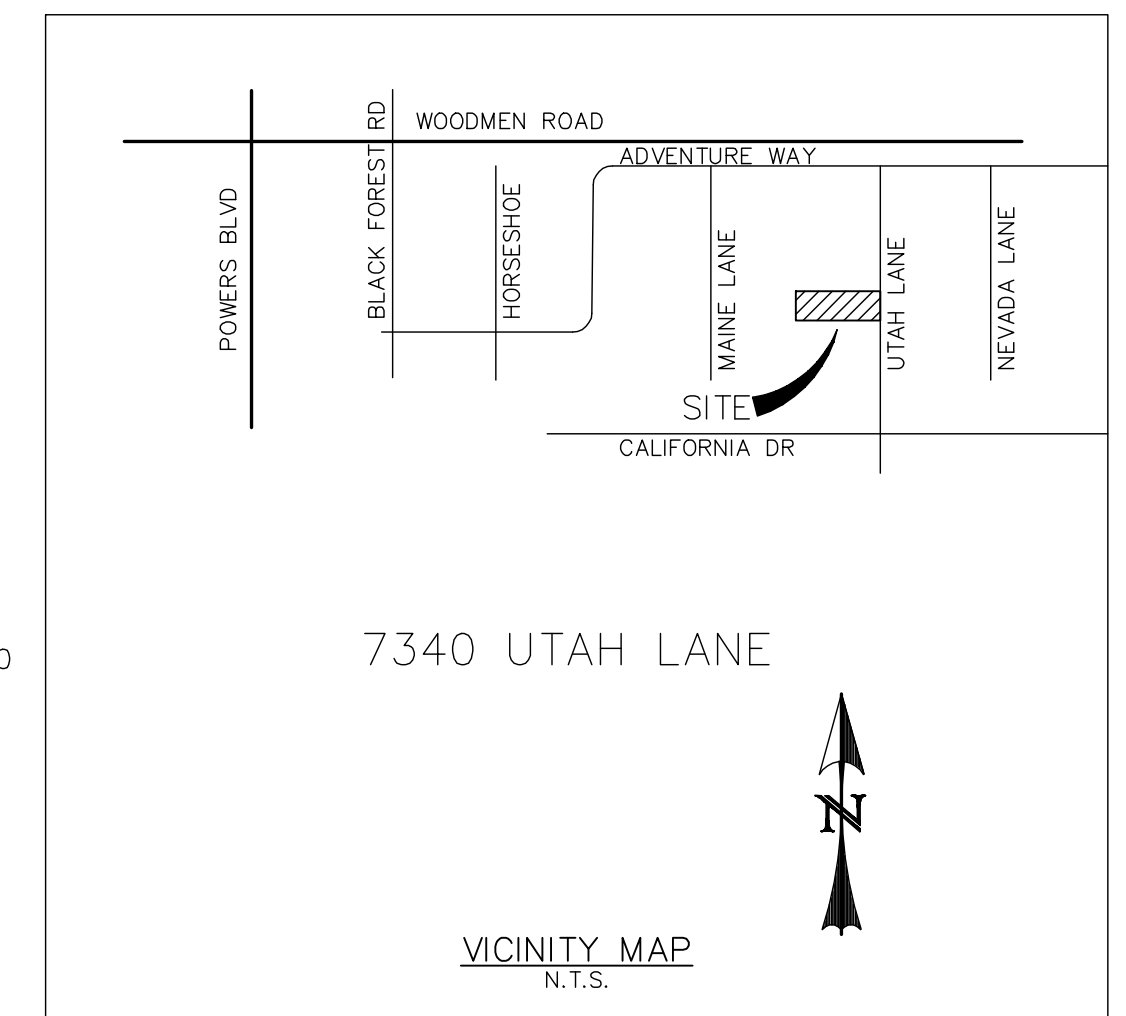


SITE PLAN 1"=50'

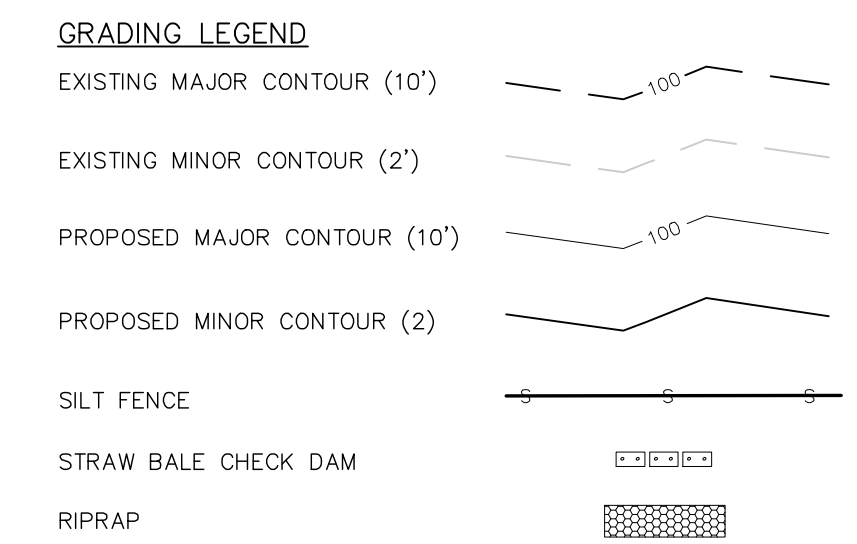

- SITE LIGHTING NOTES:**
1. ALL EXTERIOR LIGHTING IS EXISTING TO BE RETAINED, AND MOUNTED TO THE BUILDING AS SHOWN IN THE DETAIL.
 2. THERE ARE NO POLE MOUNTED OR FREE STANDING LIGHTS ON THIS SITE.
 3. ALL LIGHT BEAMS ARE CONTAINED WITHIN THE CONFINES OF THE SITE.
 4. NO NEW LIGHTING IS PROPOSED ON THIS SITE.
 5. ALL EXTERIOR LIGHTING IS FOR SECURITY PURPOSES.
 6. LIGHTING DOES NOT ILLUMINATE THE RIGHT OF WAY.
 7. LIGHT BEAMS FROM THE SECURITY LIGHTING DO NOT EXCEED THE BOUNDARIES OF THE SITE.

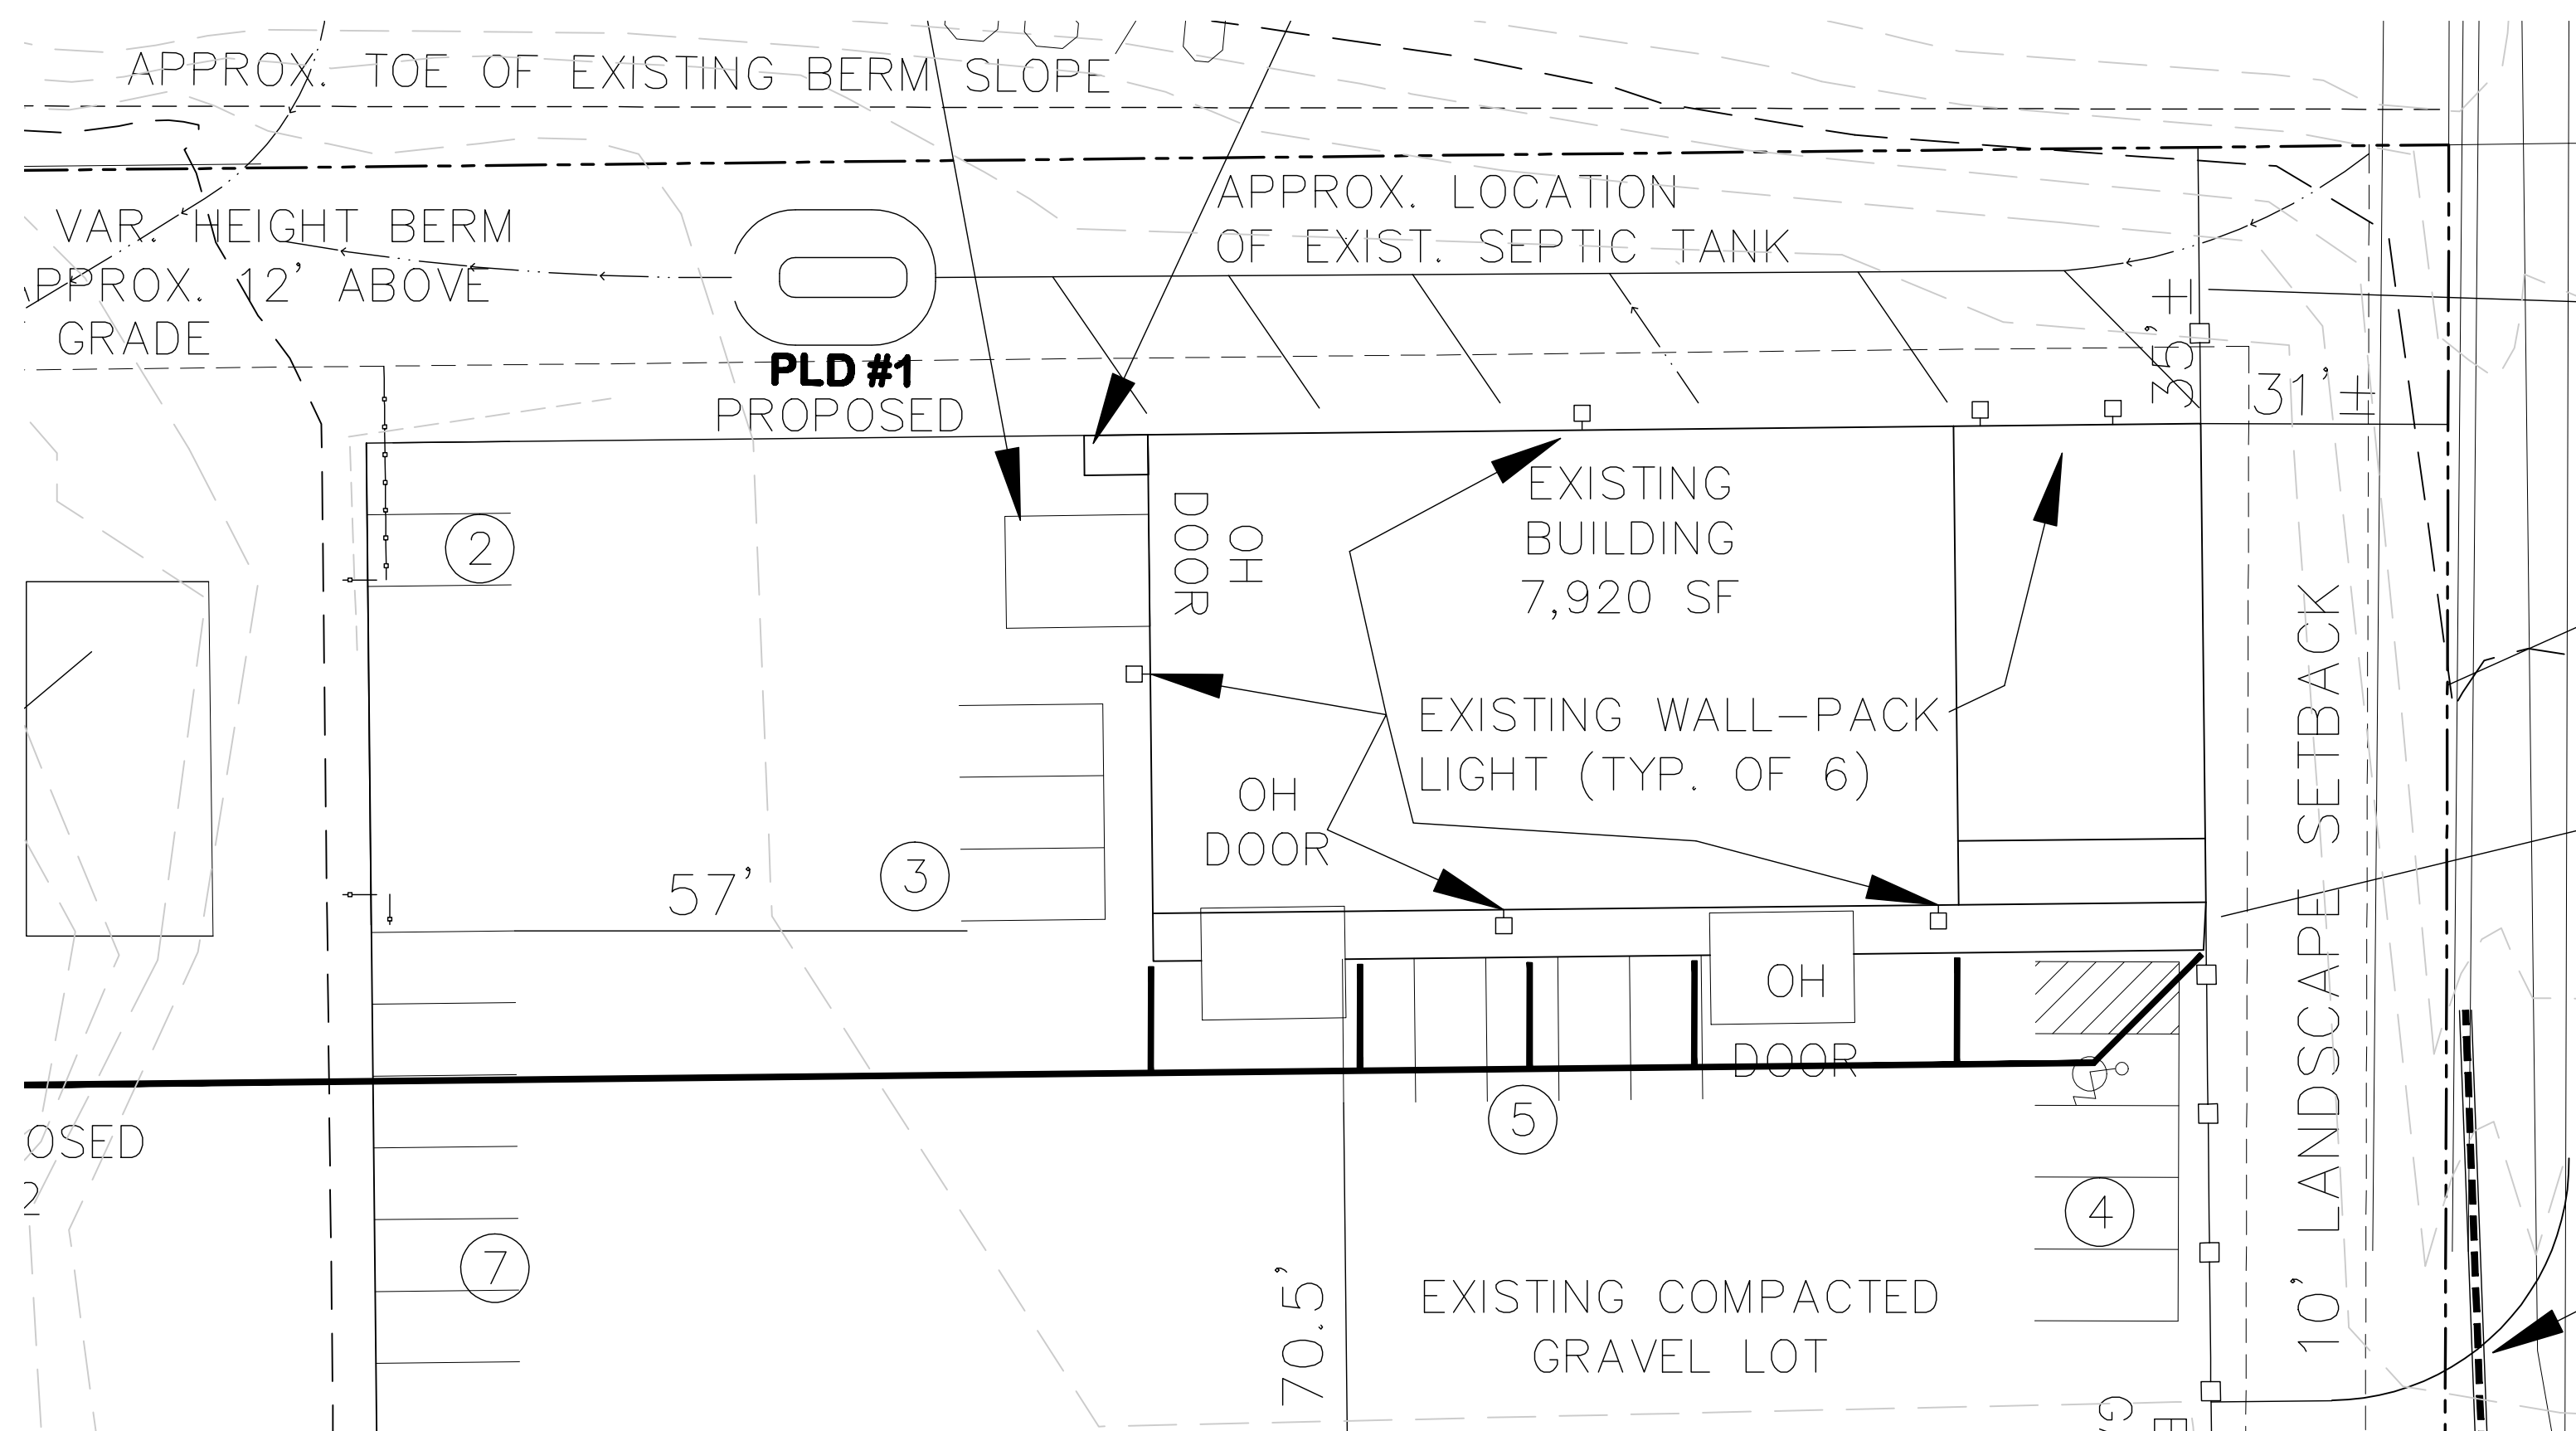

BUILDING DETAIL 1"=20'

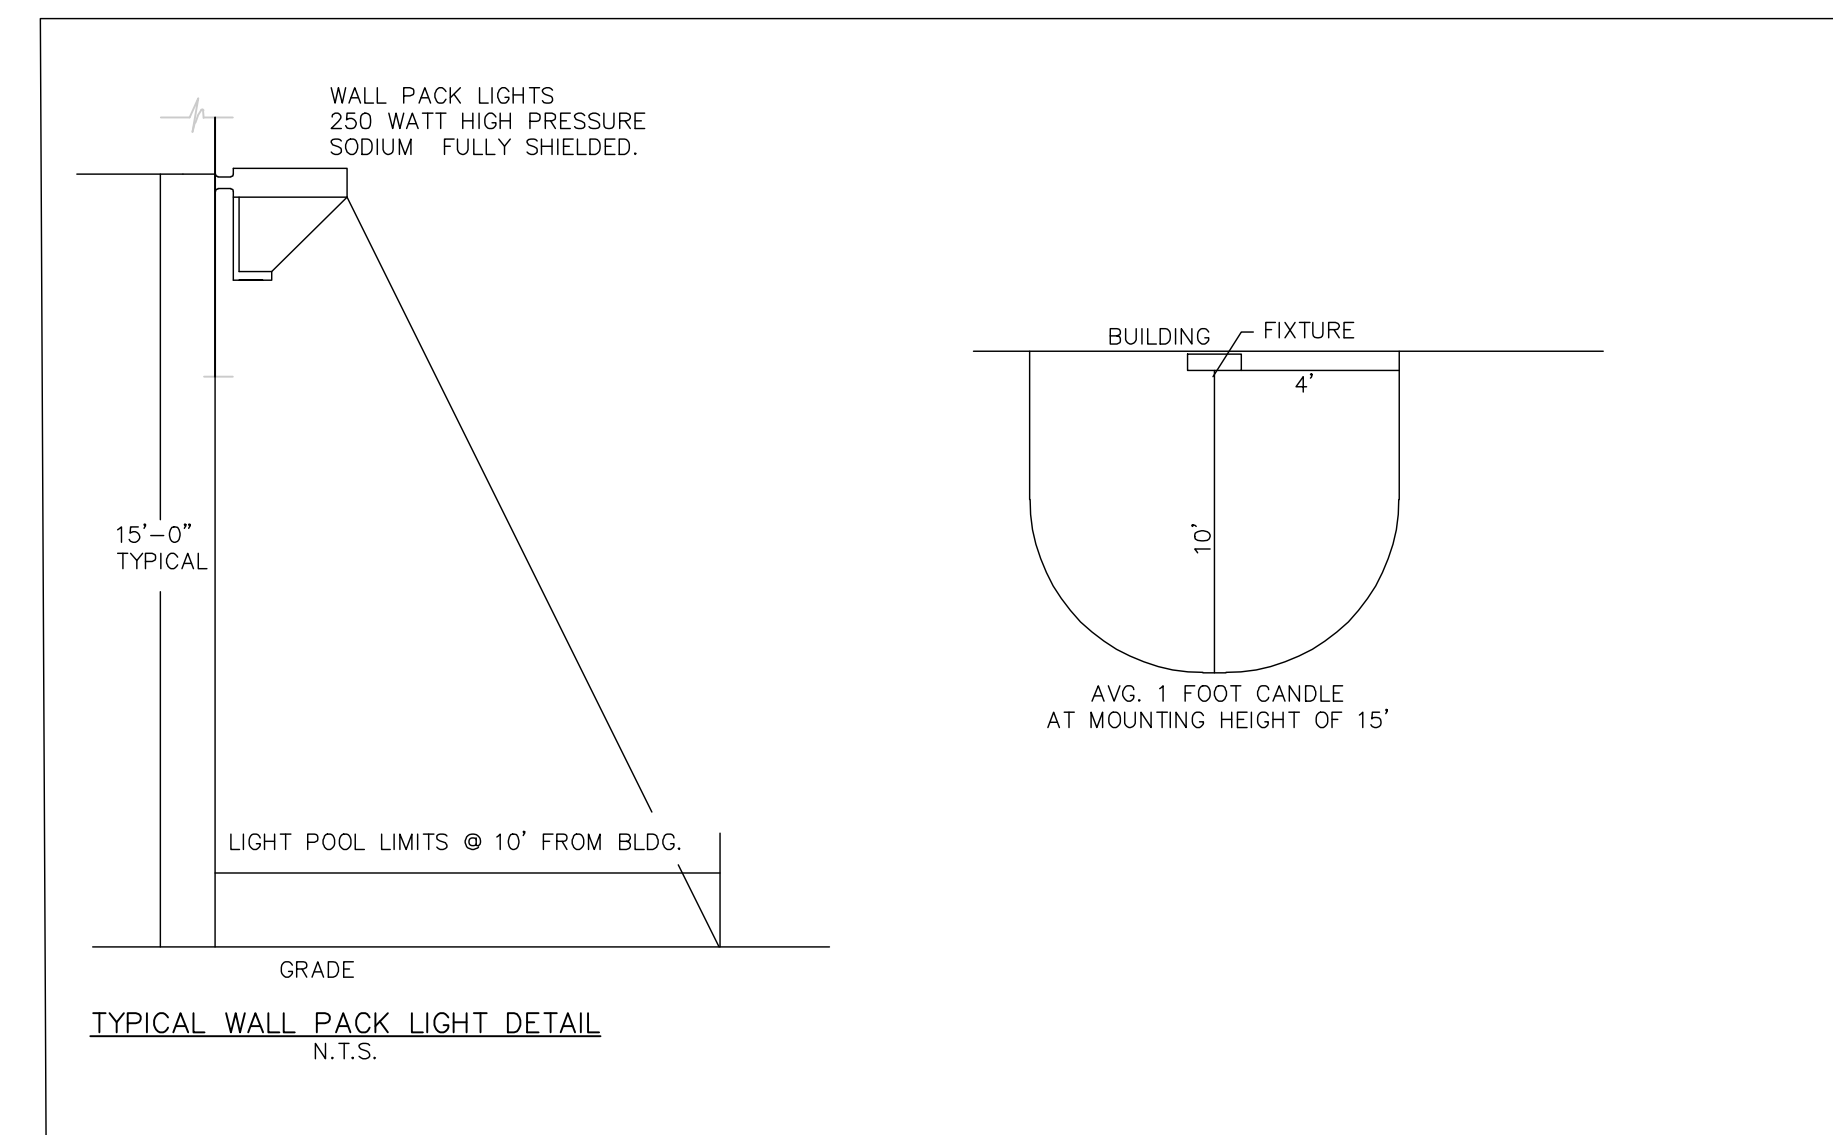

PCD FILE #: PPR 19-024

REV 07-09-2019
COUNTY COMMENTS DEBG

D. D. Greer Design Studio
13075 Sunny Slope Rd., Falcon, CO 80831
(719) 499-3874