

**BUCHER
DESIGN STUDIO**
architecture • planning

12325 Oracle Blvd., Suite 111
Colorado Springs, CO 80921
(719) 484-0480

Brian K. Bucher, AIA
Architect
CO license no. C-4889
CA license no. C 23506

A PROPOSED
OFFICE BUILDING
FOR

FALCON
FAMILY
EYE CARE

7615 MCLAUGHLIN RD
PEYTON, CO

Sheet Title:
FLOOR
PLAN

Drawing Status:
SITE DEVELOPMENT
PLAN

NOT FOR CONSTRUCTION

Revisions:

No. Description By Date

No.	Description	By	Date
1			

All ideas, designs, arrangements and plans indicated or represented by this drawing are owned by, and the property of BUCHER DESIGN STUDIO and were created, evolved and developed for use on, and in conjunction with, the specified project. None of such ideas, designs, arrangements or plans shall be used by, or disclosed to any person, firm or corporation for any purpose whatsoever without the written permission of BUCHER DESIGN STUDIO.

Date:

02/17/21

Drawn by:

Checked by:


Scale:
AS NOTED

Job No.:



Sheet No.:

2


Of 8

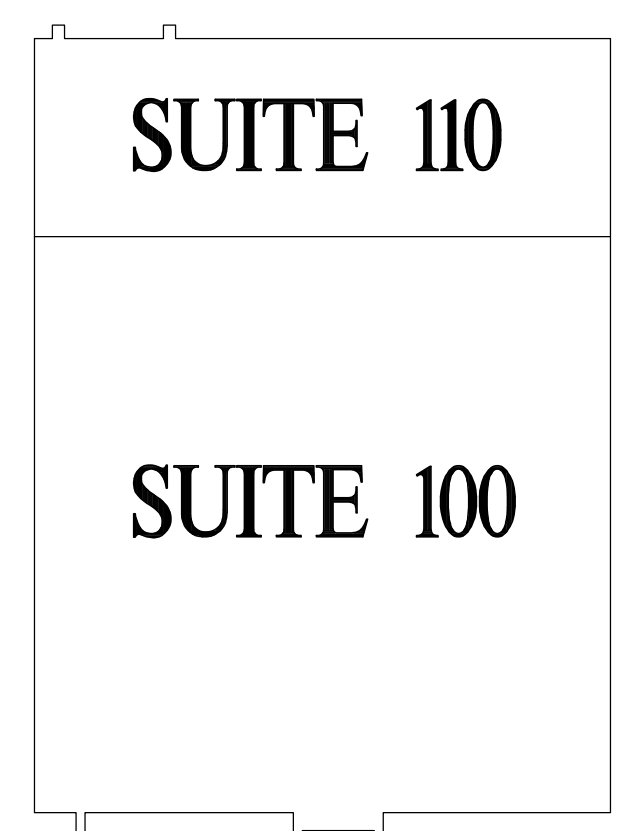

SUITE NUMBERING
SCALE: NOT TO SCALE

 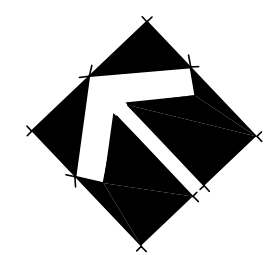

PRELIMINARY FLOOR PLAN
SCALE: 3/16"=1'-0"

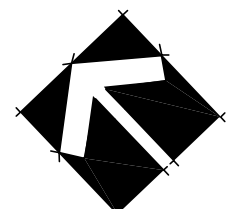

PCD FILE NO.: PPR2049