

LUMINAIRE SCHEDULE								
MARK	MANUFACTURER	MODEL	DESCRIPTION	BULB TYPE	MOUNTING	WATTS PER FIXTURE (W)	VOLTAGE (V)	NOTES
A	LITHONIA	RSX3 LED P1 40K R4	AREA LUMINAIRE	LED	POLE	194.7	120	1,2
B	LITHONIA	WDGE4 LED P4 70CRI R4 40K	WALLPACK	LED	SURFACE	146.9	120	1
C	LITHONIA	WDGE4 LED P1 70CRI R4 40K	WALLPACK	LED	SURFACE	76.2	120	1
WP1	LITHONIA	WDGE4 LED P1 70CRI R2 40K	WALLPACK	LED	SURFACE	76.2	120	
AL1	LITHONIA	DSX1 LED P8 40K 80CRI BLC3 EGS	AREA LUMINAIRE	LED	POLE	215.8	120	
NOTES:								
1 LIGHTING FIXTURE IS EXISTING AND/ OR RELOCATED.								
2 INSTALL FACTORY HOUSE SIDE SHIELD ON EXISTING AREA LUMINAIRE. COORDINATE WITH MANUFACTURER'S SPECIFICATIONS.								

CALCULATION ZONE STATISTICS						
DESCRIPTION	SYMBOL	AVERAGE (FC)	MAXIMUM (FC)	MINIMUM (FC)	MAX/ MIN (FC)	AVG/ MIN (FC)
TO PROPERTY BOUNDARY	+	1.6	38.8	0.0	N/A	N/A




WDGE4 WALLPACK LUMINAIRE
SCALE: NONE



RSX3 AREA LUMINAIRE
SCALE: NONE



DSX1 AREA LUMINAIRE
SCALE: NONE

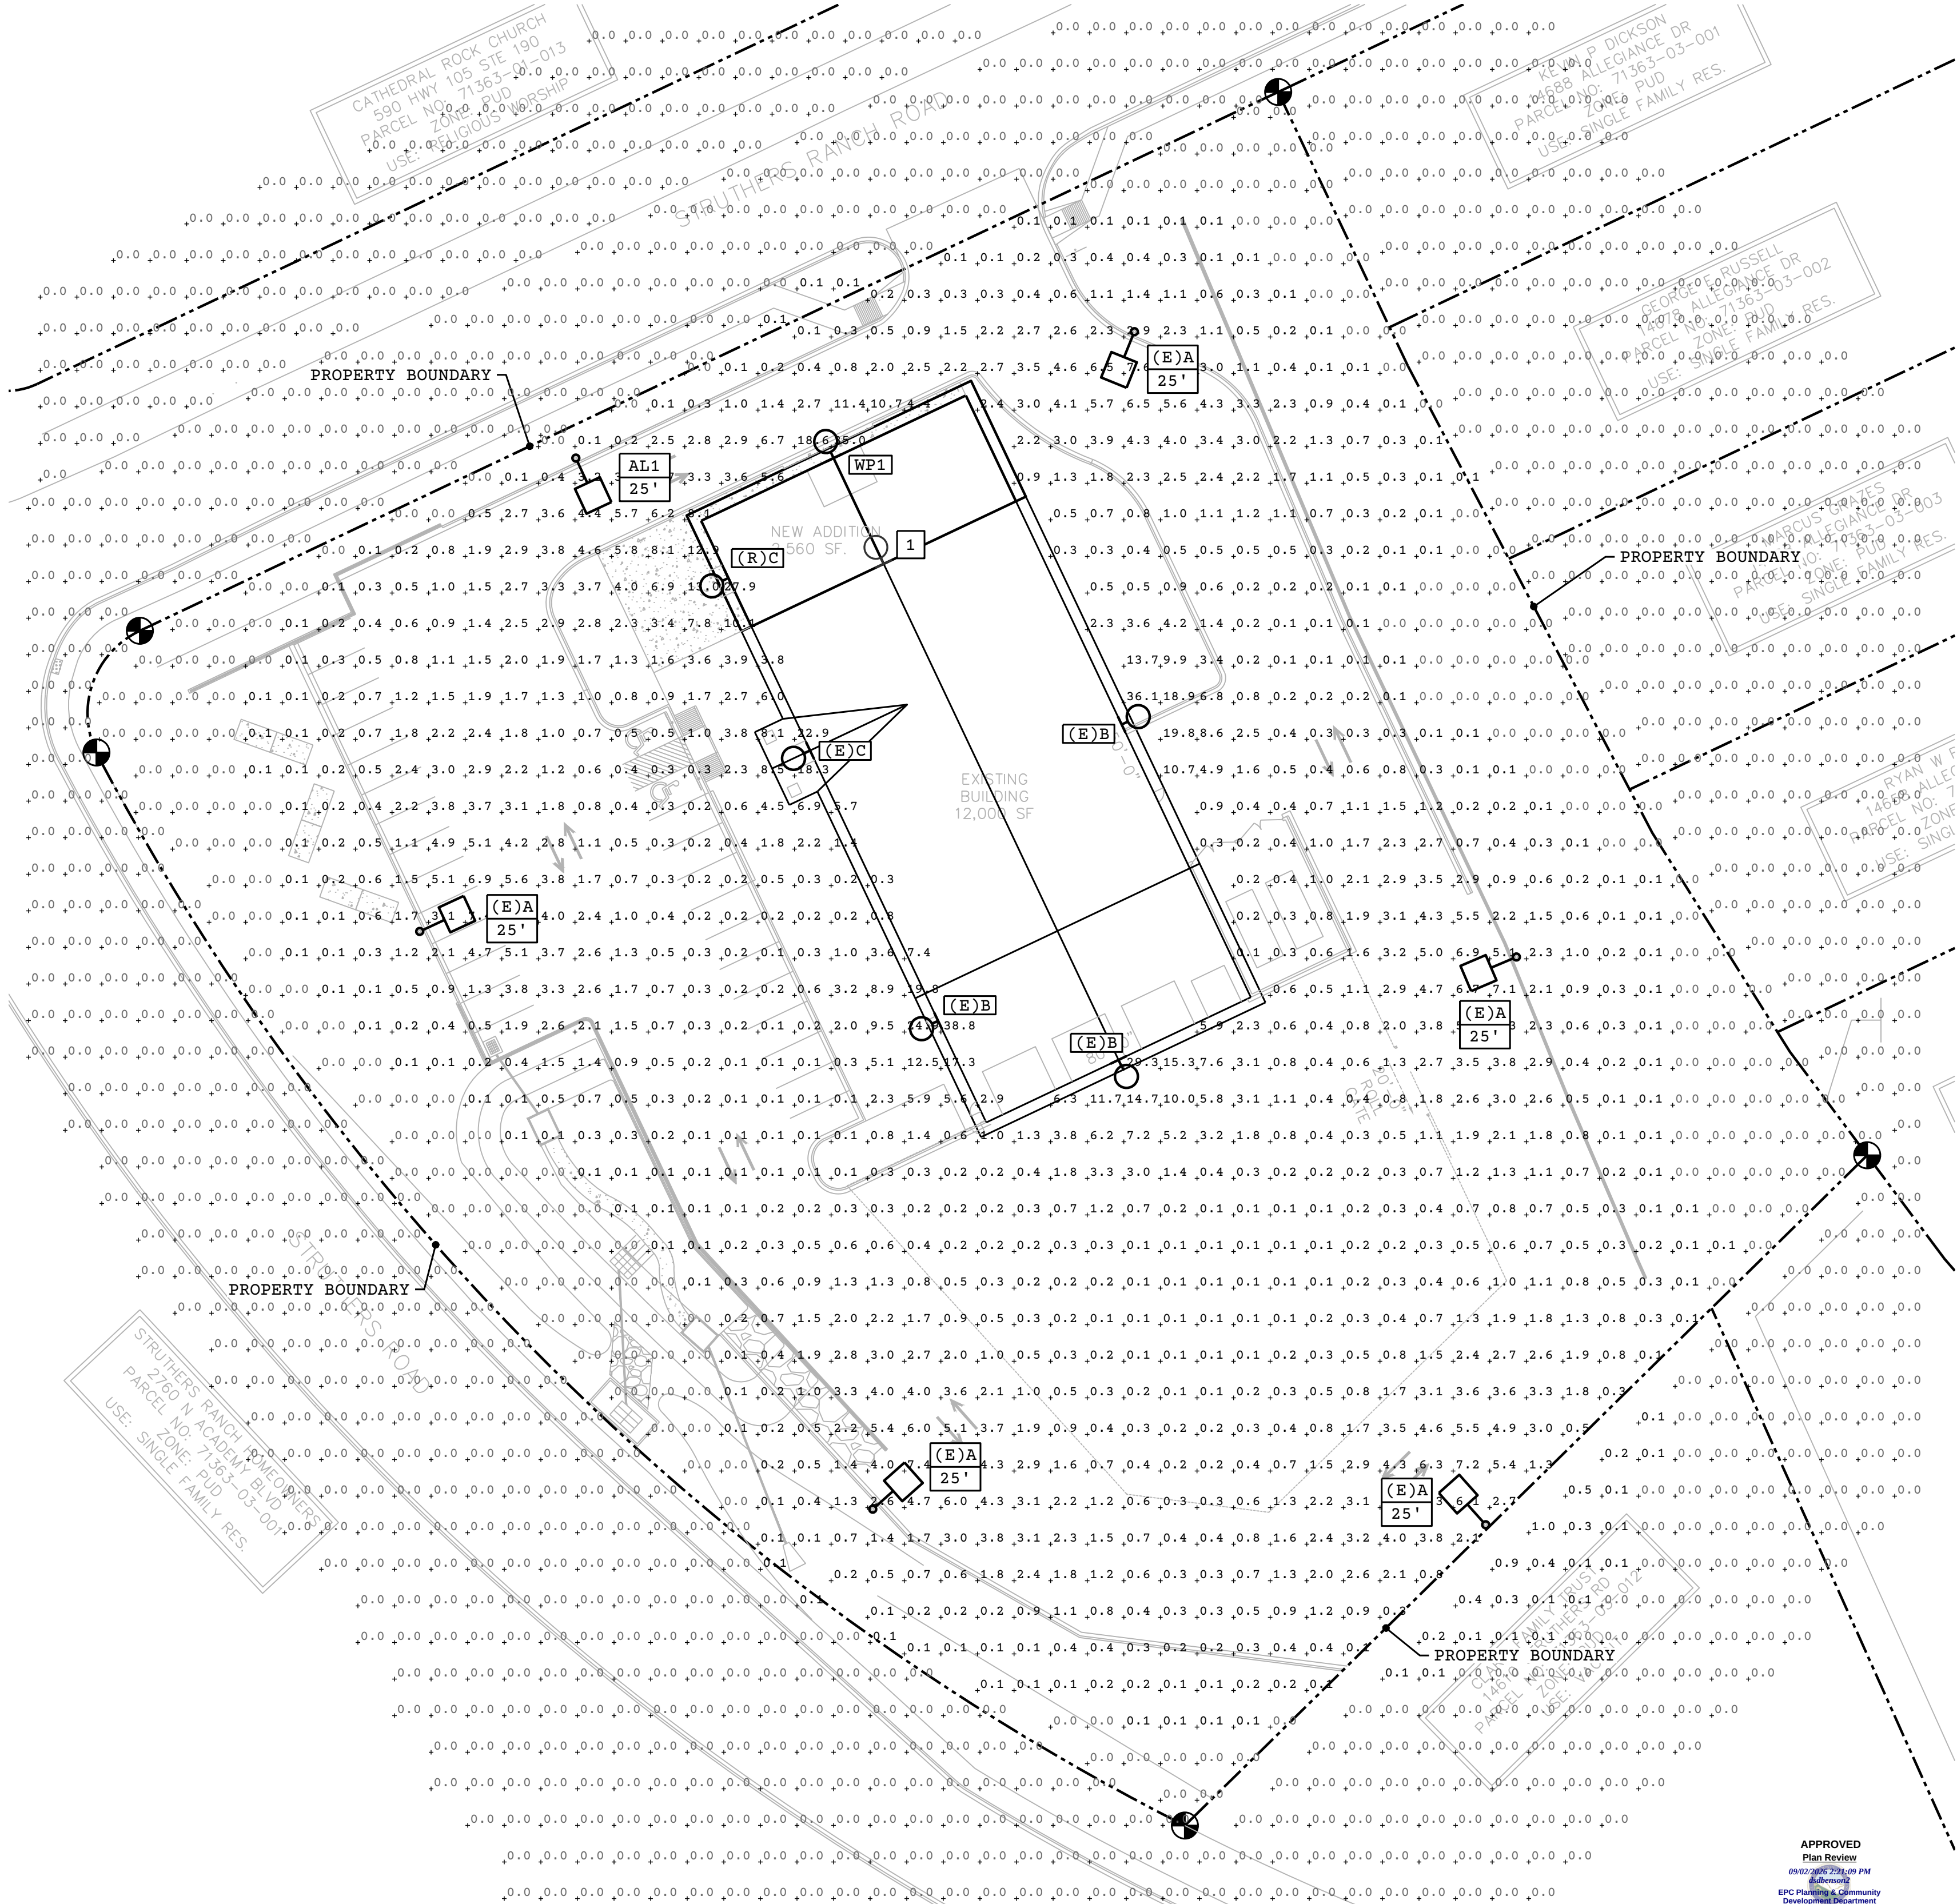

1 SITE LIGHTING PHOTOMETRIC PLAN
SCALE: 1"=30'-0"

KEYNOTES #

1. EXISTING LIGHT FIXTURE 'C' TO BE RELOCATED FROM THIS AREA.

GENERAL NOTES

- A. (E) DENOTES THAT DEVICE IS EXISTING AND TO REMAIN.
B. (R) DENOTES THAT DEVICE IS EXISTING AND TO BE RELOCATED.
C. HOUSE SIDE SHIELDS TO BE PROVIDED FOR EXISTING AREA LUMINAIRES. LIGHTING LEVELS ACROSS RESIDENTIAL PROPERTY LINES DO NOT EXCEED 0.1 FC.
D. OTHER THAN SECURITY LIGHTING, EXTERIOR LIGHTING, INCLUDING BUT NOT LIMITED TO FLOODLIGHTS USED TO LIGHT A BUILDING FACADE, SHALL BE REDUCED, ACTIVATED BY MOTION SENSOR DEVICES, OR TURNED OFF DURING THE PRINCIPAL USE'S NON-OPERATING HOURS.

HAMMERS CONSTRUCTION INC.
COMMERCIAL GENERAL CONTRACTORS SPECIALIZING IN DESIGN-BUILD
PRESIDENT: STEVE R. HAMMERS
VICE PRES: DAVID J. HAMMERS
1411 WOOLSEY HEIGHTS
COLORADO SPRINGS, CO 80915
(719) 570-1599 FAX (719) 570-7008
www.hammersconstruction.com

THIS DRAWING CONTAINS MATERIAL & INFORMATION WHICH MAY NOT BE REPRODUCED WITHOUT WRITTEN CONSENT OF HAMMERS CONSTRUCTION, INC. THESE DRAWINGS ARE INTENDED TO BE USED ONLY BY HAMMERS CONSTRUCTION & ITS REPRESENTATIVES. THESE DRAWINGS HAVE NOT BEEN PREPARED FOR ANY OTHER PURPOSE THAN TO INDICATE THE GENERAL FEATURES AND PLACEMENT OF THE PROPOSED PROJECT. COPYRIGHT © 2025 HAMMERS CONSTRUCTION

ROCKY MT. CYCLE PLAZA
BUILDING ADDITION
847 STRUTHERS RANCH RD.
COLORADO SPRINGS, CO 80921
EL PASO COUNTY, COLORADO

COLORADO LICENSED PROFESSIONAL ENGINEER
60643
08.17.2026

LOCAL GROUP
LOCALGROUPENG.COM
(719)299-2843

DATE: AUGUST 17, 2026
DRAWN BY: CCF, RAF
PROJ. MNGR: J. BUTLER
SCALE: SEE PLAN
APPROVED BY: CCF
JOB NO: 25-174

SP0.1

