


③ Label Service & FIRE LINES & PROVIDE PIPE SIZES & MATERIAL

- ① SHOW SANITARY SEWER CONNECTION TO BLDG.
- ② IF PUBLIC SANITARY WATER & SEWER SYSTEMS SUBMIT PIPE PROFILES W/ CROSSING DETAILS

④ IF PUBLIC WATER SYSTEM ADD NOTE THAT CHEROKEE RESPONSIBILITY ENDS AT MAIN TAP VALVE - SERVICE TO BLDG IS OWNER'S RESPONSIBILITY


⑤ ADD VALVES TO ISOLATE BUILDINGS

⑥ IF PUBLIC WATER & SANITARY SYSTEMS- ADD NOTE THAT OWNER RESPONSIBLE FOR PAVEMENT REPLACEMENT IF REPAIRS ARE NEEDED

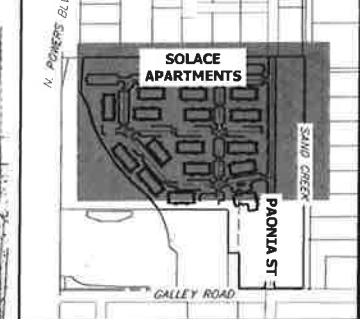

ENGINEER'S STATEMENT
 PREPARED UNDER MY SUPERVISION
 32314
 MIKE A. BRAMLETT, P.E.
 COLORADO P.E. 32314
 FOR AND ON BEHALF OF JR ENGINEERING


UNLESS SUCH TIME AS THESE DRAWINGS ARE PREPARED, THEY ARE NOT TO BE USED FOR ANY PURPOSES WITHOUT THE WRITTEN AUTHORIZATION OF JACKSON DEARBORN PARTNERS.	
JACKSON DEARBORN PARTNERS 404 S. WELLS ST. SUITE 400 CHICAGO, ILL 60607 OFFICE PHONE (734) 216-2577	PREPARED FOR JACKSON DEARBORN PARTNERS 404 S. WELLS ST. SUITE 400 CHICAGO, ILL 60607 OFFICE PHONE (734) 216-2577
JR ENGINEERING A Weisman Company Corporate: 303-440-8888 • Colorado Springs: 719-592-2888 Fort Collins: 970-451-9888 • www.jrengineering.com	PREPARED BY: JRM DESIGNED BY: JRM DRAWN BY: JRM CHECKED BY:
SOLACE AT CIMARRON HILLS - FILING NO. 1 SITE AND OVERALL UTILITY PLAN	SHEET 4 OF 32 JOB NO. 25174.00

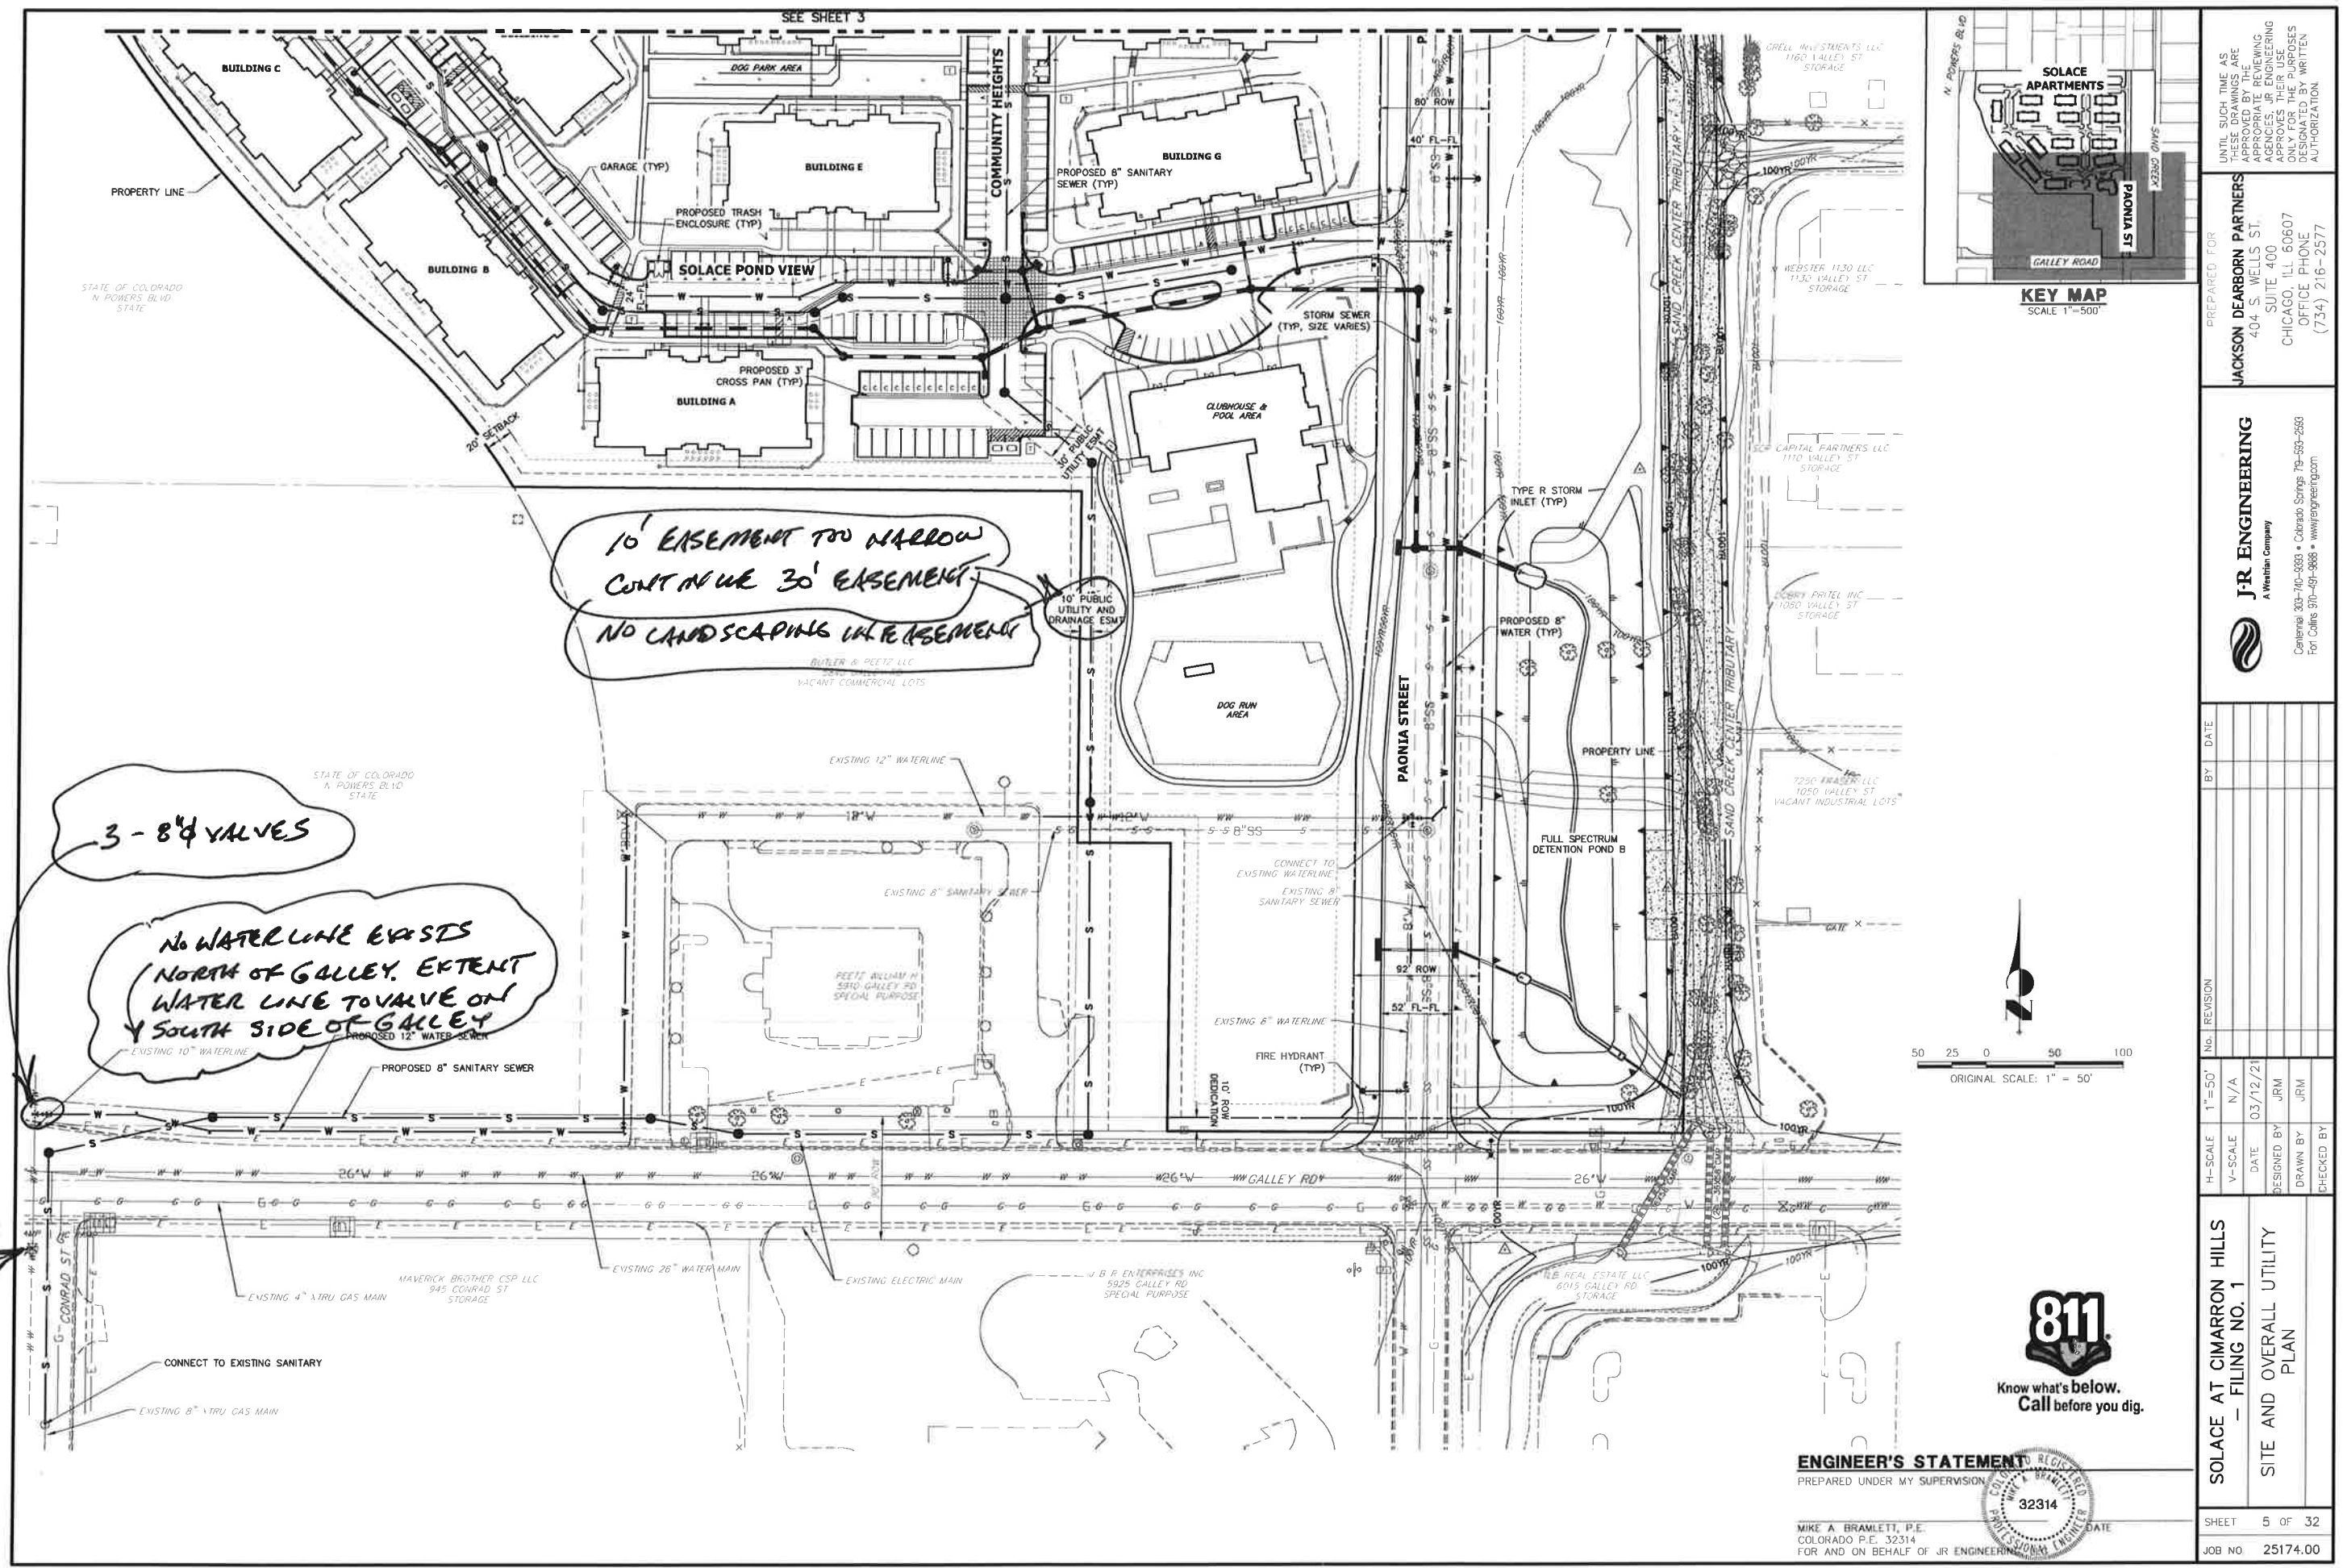

10' EASEMENT TOO NARROW
CONTINUE 30' EASEMENT
NO LANDSCAPING IN EASEMENT

3 - 8" VALVES
NO WATER LINE EXISTS
NORTH OF GALLEY. EXTENT
WATER LINE TO VALVE ON
SOUTH SIDE OF GALLEY

CONNECT
TO EXIST
VALVE

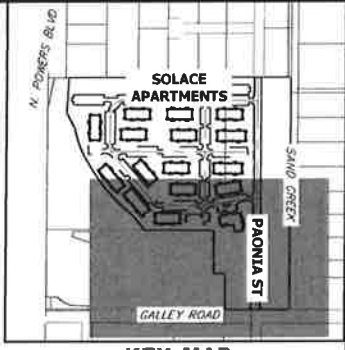

ENGINEER'S STATEMENT
PREPARED UNDER MY SUPERVISION
32314
MIKE A. BRAMLETT, P.E.
COLORADO P.E. 32314
FOR AND ON BEHALF OF JR ENGINEERING

UNTIL SUCH TIME AS THESE DRAWINGS ARE CANCELLED BY THE ENGINEERING AGENCIES, JR ENGINEERING APPROVES THEIR USE ONLY FOR THE PURPOSES DESIGNATED BY WRITTEN AUTHORIZATION.	
PREPARED FOR JACKSON DEARBORN PARTNERS 404 S. WELLS ST. SUITE 400 CHICAGO, ILL 60607 OFFICE PHONE (734) 216-2577	PREPARED BY JR ENGINEERING A Weitzman Company 303-740-0888 • Colorado Springs 719-552-2883 Fort Collins 970-491-8888 • www.jrengineering.com
No. REVISION H-SCALE 1"=50' V-SCALE N/A DATE 03/12/21 DESIGNED BY JRM DRAWN BY JRM CHECKED BY	BY DATE No. REVISION H-SCALE 1"=50' V-SCALE N/A DATE 03/12/21 DESIGNED BY JRM DRAWN BY JRM CHECKED BY
SOLACE AT CIMARRON HILLS - FILING NO. 1 SITE AND OVERALL UTILITY PLAN	
SHEET	5 OF 32
JOB NO.	25174.00