 


SOLACE OF COLORADO SPRINGS - EXTERIOR LIGHT FIXTURE SCHEDULE

EXTERIOR			
L1	Exterior wall sconce - Balconies	ABL-Lithonia Lighting	OLLWD LED P1 40K MVOLT DDB
L2	Exterior LED Wall pack - Breezeways	ABL-Lithonia Lighting	WDGE2 LED P3 40K 80CRI VW MVOLT E4WHDBLXD
L3	Exterior Surface mount LED strip @9' AFF	ABL-Lithonia Lighting	FEM L48 3000LM LPAL WD MVOLT 35K 80CRI
L4	Exterior LED Wall pack - Garages @9' AFF	ABL-Lithonia Lighting	DSXW1 LED 10C 1000 40K T3M MVOLT DBLXD
L5	Exterior LED Wall pack - Garages @9' AFF	ABL-Lithonia Lighting	WDGE3 LED P1 40K 70CRI R4 MVOLT DBLXD
L6	Exterior wall sconce - Clubhouse @7' AFF	Bega	66410 K4
(EM) DESIGNATION BEHIND TYPE MARK INDICATES THAT FIXTURE SHALL BE PROVIDED WITH 90-MINUTE BATTERY UNIT FOR EMERGENCY BACKUP. WHERE THE FIXTURE DOES NOT HAVE EMERGENCY BATTERY UNIT OPTION, IT SHALL BE ON AN EMERGENCY CIRCUIT ROUTED THROUGH INVERTER. SEE ELEC.			
SITE			
L10	Bollard Light	ABL-Lithonia Lighting	RADB LED PT5 40K SYM MVOLT BT5 BCC H36 DBLXD
L11	15' Post Top - Site	ABL-Lithonia Lighting	RADPT LED PT2 40K SYM MVOLT PT4 RSS14 DBLXD
L12	15' Post Top - Pool Deck	ABL-Lithonia Lighting	RADPT LED PT4 40K SYM MVOLT PT4 RSS14 DBLXD
L13	Parking Light - 15' (T4M)	ABL-Lithonia Lighting	DSX1 LED P4 40K T4M MVOLT SPA HS DBLXD
L14	Parking Light - 20' (T2M)	ABL-Lithonia Lighting	DSX1 LED P6 40K T2M MVOLT SPA HS DBLXD
L15	Exterior Flood Light	ABL-Lithonia Lighting	TFX2 LED 40K MVOLT YK DDBXD



1 SITE LIGHTING PLAN

SCALE: 1" = 60'-0"

Land Planning
Landscape
Architecture
Urban Design

NES

N.E.S. Inc.
619 N. Cascade Avenue, Suite 200
Colorado Springs, CO 80903

Tel. 719.471.0073
Fax 719.471.0267

www.nescolorado.com

© 2012. All Rights Reserved.

- OWNER / DEVELOPER:
JACKSON DEARBORN, LLC
404 S. WELLS STREET
SUITE # 400
CHICAGO, IL 60607
CONTACT: DANE OLAMSTEAD
TEL: 734.216.2577
- ARCHITECT:
LCM ARCHITECTS
819 SOUTH WABASH AVE
FIFTH FLOOR
CHICAGO, IL 60605
TEL: 312.913.1717
- CIVIL ENGINEER:
JR ENGINEERING
5475 TECH CENTER DRIVE
SUITE # 235
COLORADO SPRINGS, CO 80919
CONTACT: MIKE BRAMBLETT
TEL: 303.267.6240
- STRUCTURAL ENGINEER:
MARTINO & LUTH, INC
999 18TH STREET
SUITE 855 NORTH
DENVER, CO 80202
TEL: 303.260.7118
- MEP ENGINEER:
SALAS O'BRIEN
815 SOUTH WABASH AVENUE
CHICAGO, IL 60605
TEL: 312.786.4310

SOLACE
APARTMENTS

SITE DEVELOPMENT
PLAN







DATE: 11/18/2020
PROJECT MGR: PROJECT MGR
PREPARED BY: PREPARED BY

NOT FOR
CONSTRUCTION

ISSUE TYPE		
DATE:	BY:	DESCRIPTION:

SITE LIGHTING PLAN

A0.20
15 OF 28

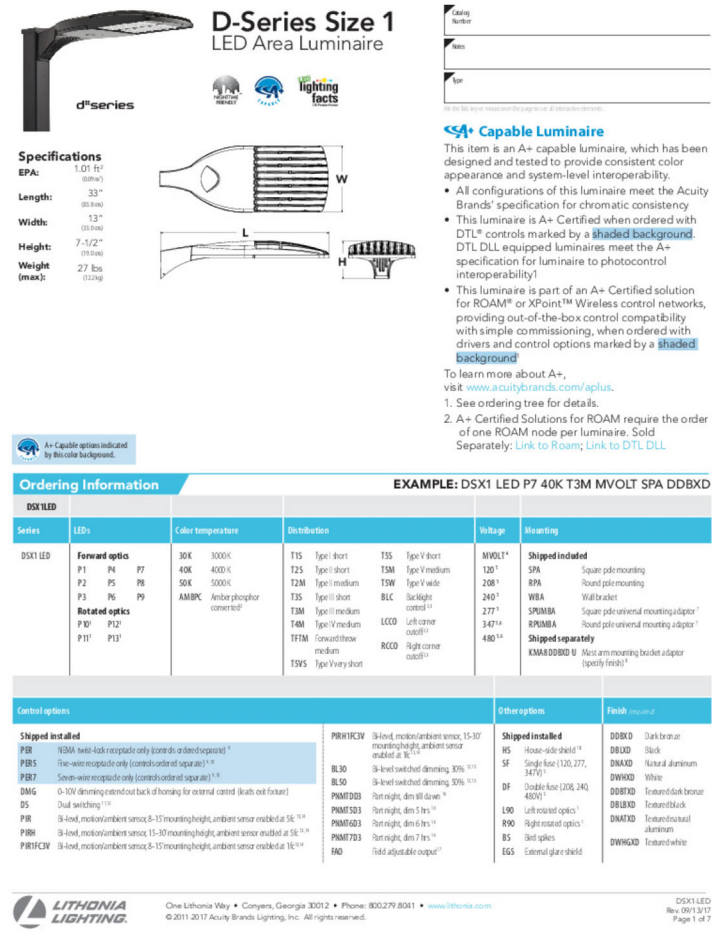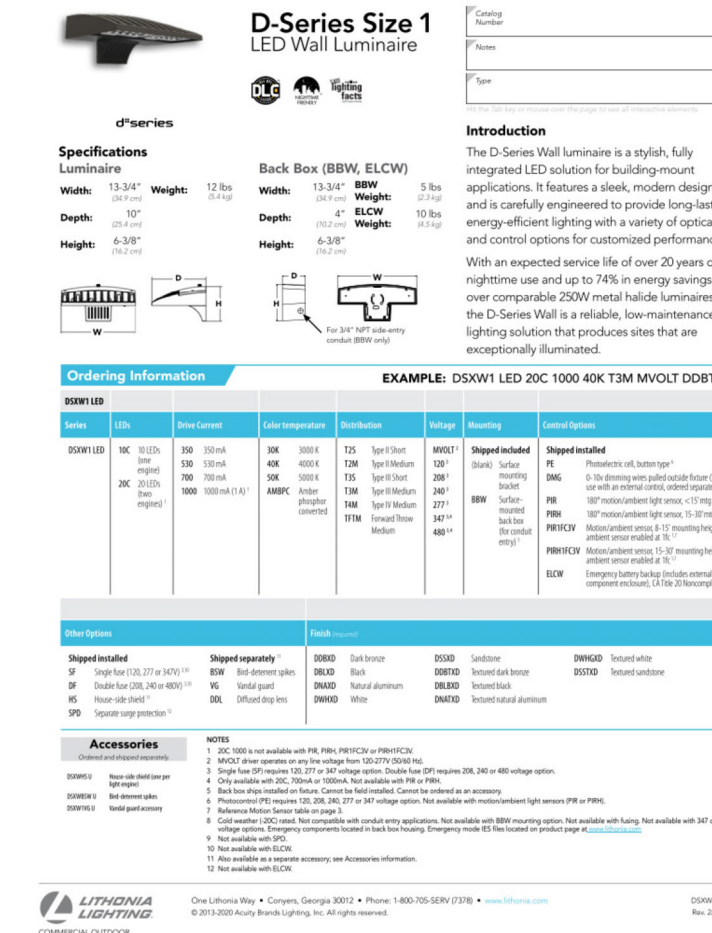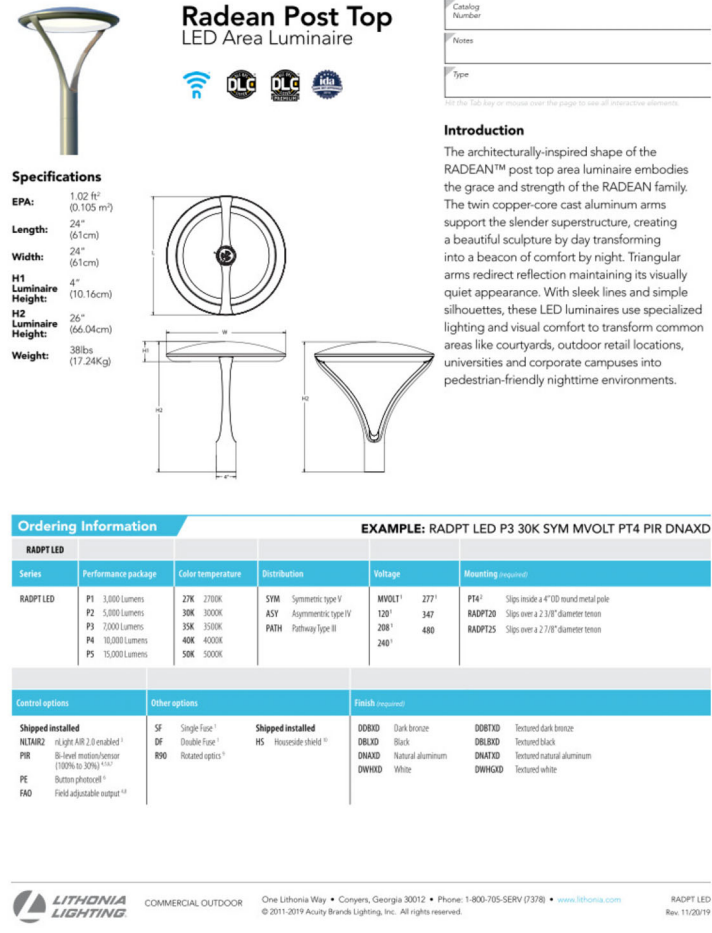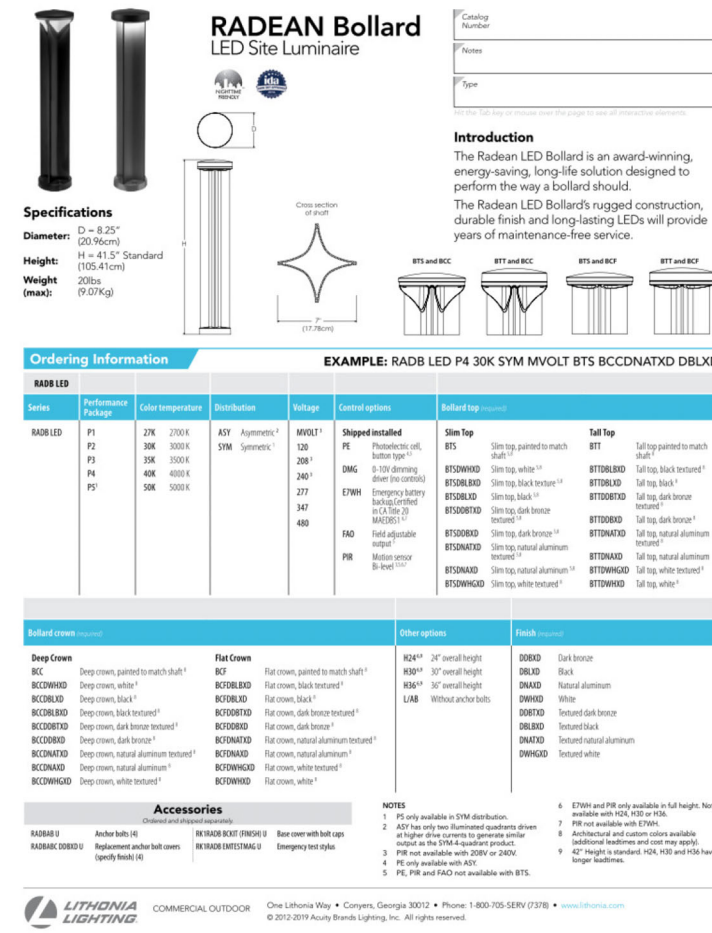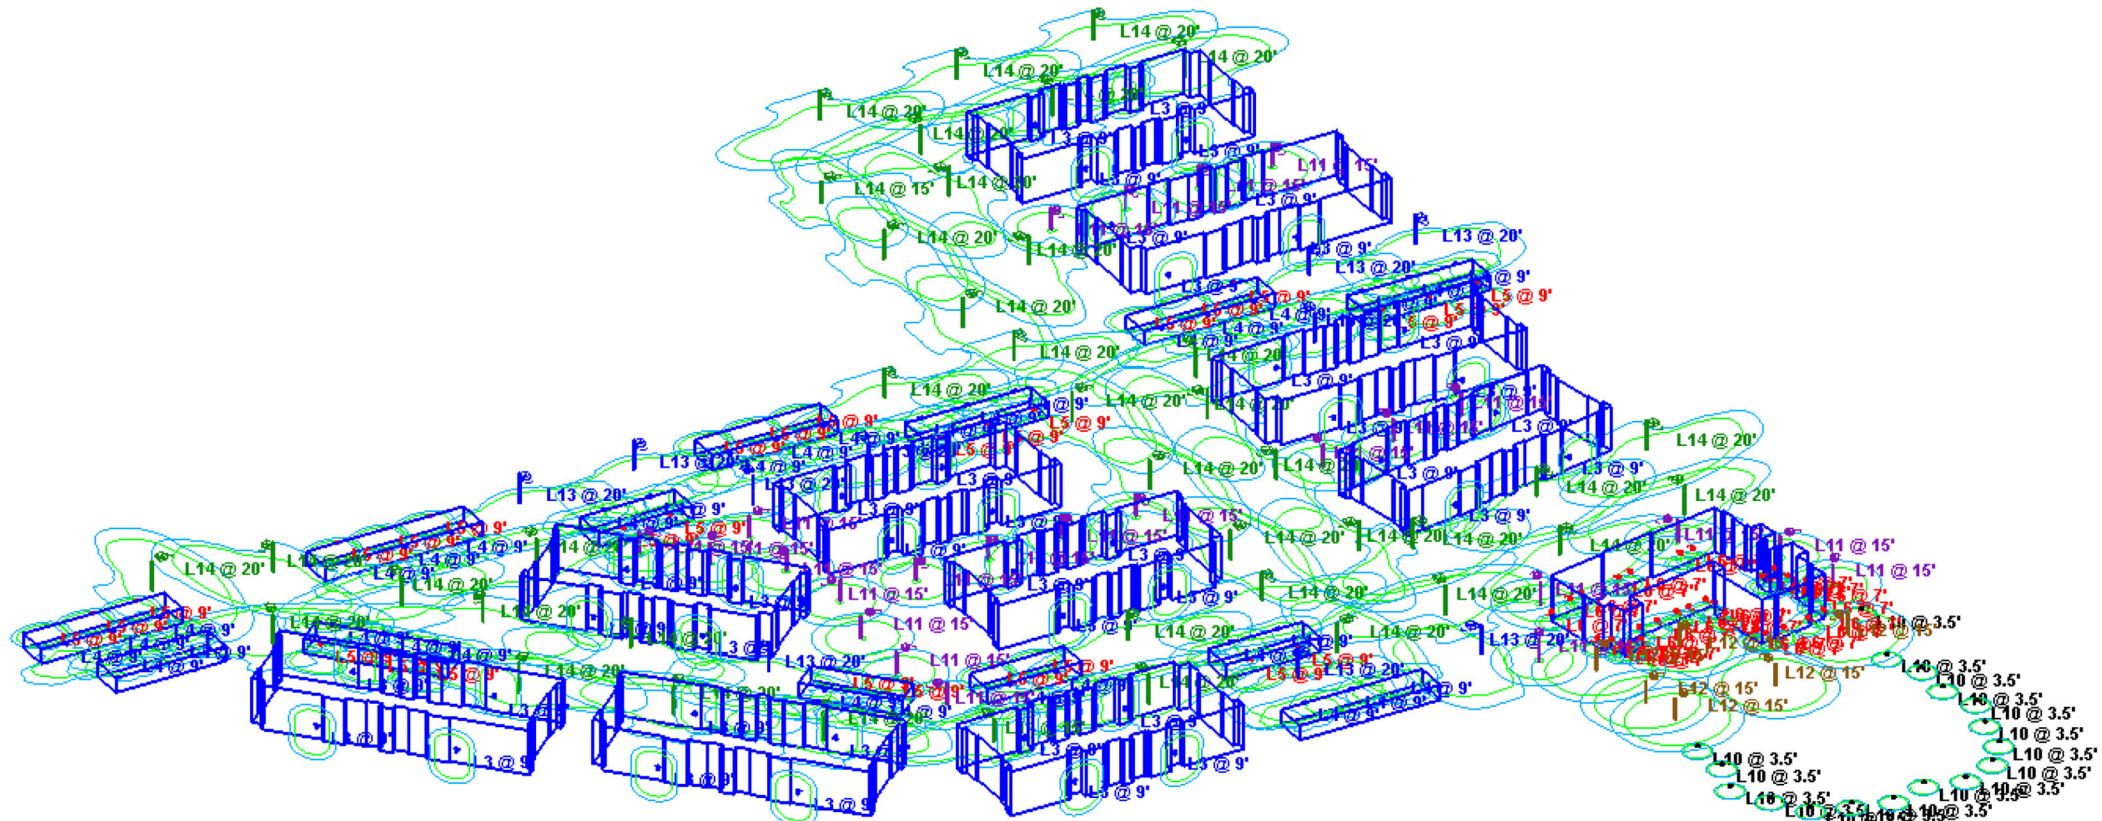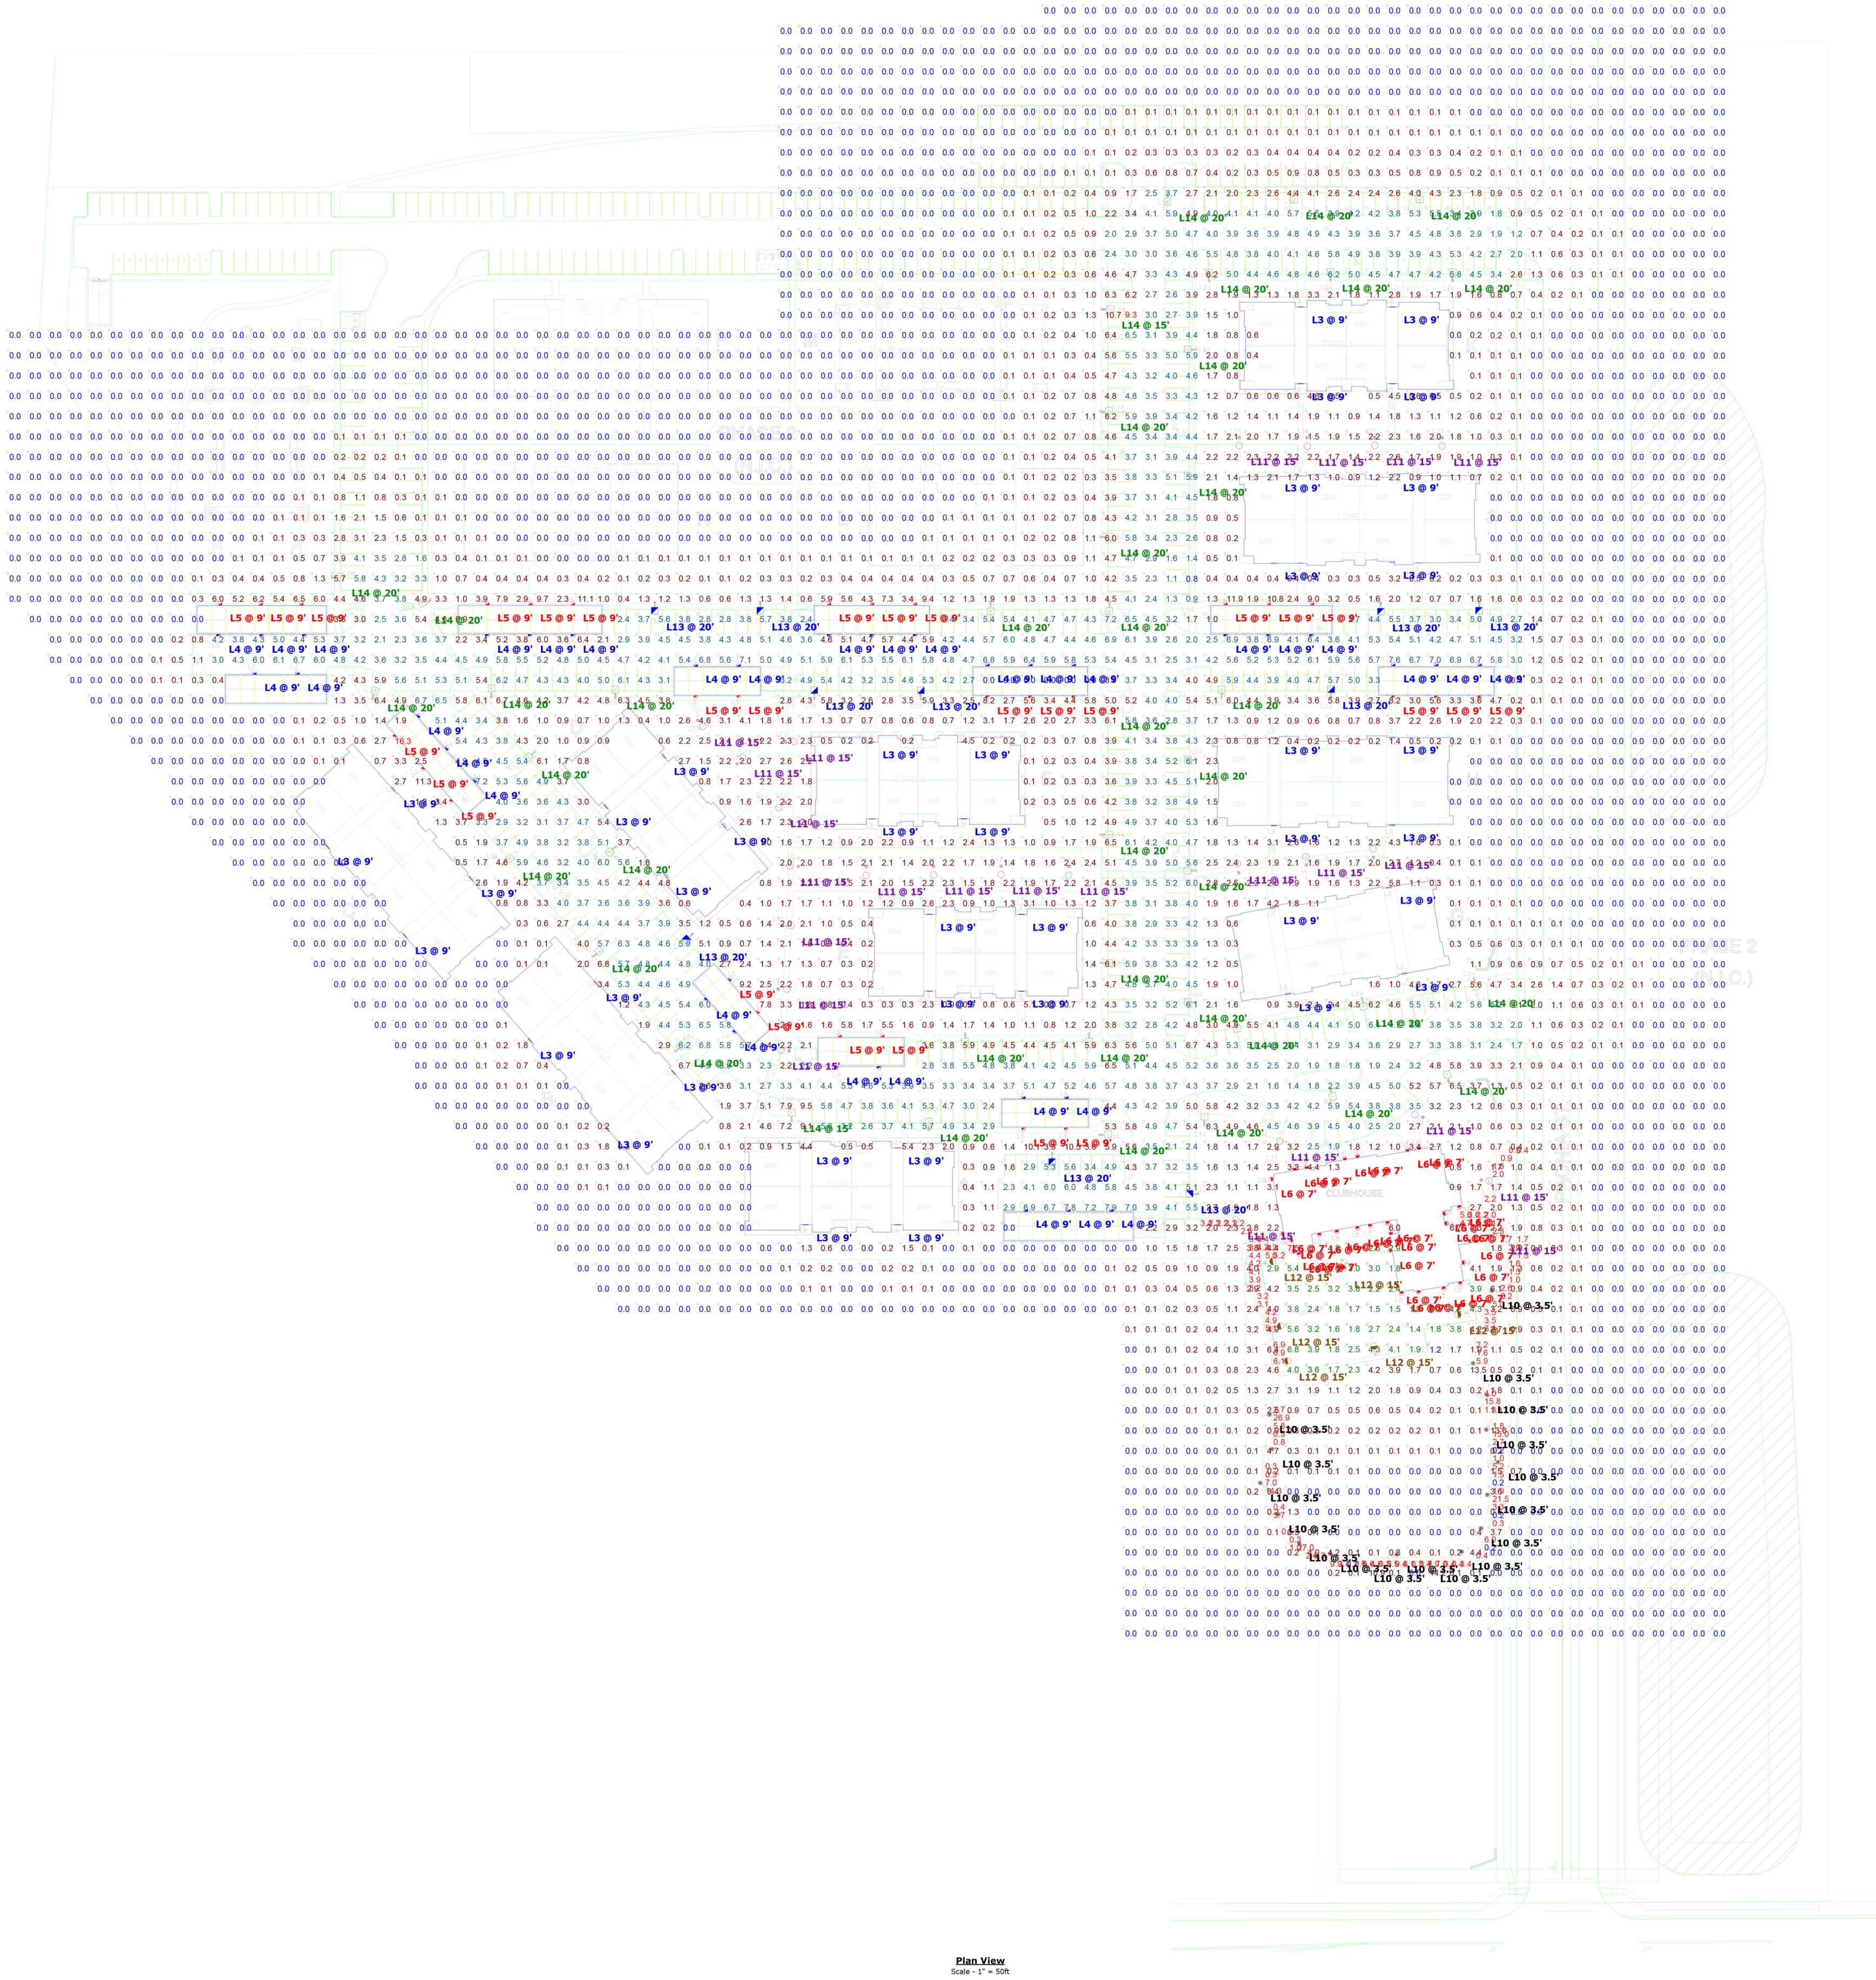

Note

1. Readings shown are based on a total LLF of as shown at grade. Data references the extrapolated performance projections in a 25c ambient based on 10,000 hrs of LED testing (per IESNA LM-80-08 and projected per IESNA TM-21-11).

2. Please refer to the "luminaire locations" for mounting heights.

3. Product information can be obtained at www.lithonia.com or through your local agency.

Statistics

Description	Symbol	Avg	Max	Min	Max/Min	Avg/Min
Bollard Walkway	◇	3.9 fc	27.0 fc	0.2 fc	135.0:1	19.5:1
Parking Summary	□	4.3 fc	9.3 fc	0.8 fc	11.6:1	5.4:1
Pool Area	✱	3.1 fc	7.5 fc	1.2 fc	6.3:1	2.6:1
Spill Light Summary	+	1.3 fc	16.3 fc	0.0 fc	N/A	N/A

Schedule

Symbol	Label	QTY	Manufacturer	Catalog Number	Description	Lamp	Number	Filename	Lumens	Wattage	LLF	Distribution
L3		40	Lithonia Lighting	FEM L48 3000LM LPAFL	FEM L48 48" 3,000 lumens, acrylic, low profile frosted lens, wide distribution, 80 CRI, 3500K	LED	1	FEM L48_3000 LPAFL_WD_80CRI_3500K	2796	18.05	0.9	DIRECT, SC=0+1.21, SC=90+1.84
L4		34	Lithonia Lighting	DSXW1 LED 1000 40K T3M MVOLT	DSXW1 LED WITH (1) 10 LED LIGHT ENGINES, TYPE T3M OPTIC, 4000K, 80 CRI, 1000LM	LED	1	DSXW1 LED WITH (1) 10 LED LIGHT ENGINES, TYPE T3M OPTIC, 4000K, 80 CRI, 1000LM	3873	38.8	0.93	TYPE IV, MEDIUM, BUG RATING: B1 - U0 - G1
L5		29	Lithonia Lighting	WDS2 LED P3 40K BORO V8	WDS2 LED WITH P3 40K BORO, VISUAL COMFORT WIDE OPTIC	LED	1	WDS2 LED P3 40K BORO V8	3213	22.55	0.95	TYPE III, VERY SHORT, BUG RATING: B1 - U0 - G1
L6		30	BEGA Converted by LUMCA	66410		LED R, 8W	1	66410, BEGA, 1, 8W	722	12	0.9	
L10		17	Lithonia Lighting	RACD LED P5 40K SYM DRLOD	RACD LED P5 40K SYM DRLOD	LED	1	RACD LED P5 40K SYM DRLOD	2215	32.31	0.89	TYPE VI, BUG RATING: B1 - U1 - G0
L11		24	Lithonia Lighting	RACD P2 40K SYM	RACD P2 40K SYM	LED	1	RACD P2 40K SYM	5169	38.0107	0.91	TYPE VI, BUG RATING: B1 - U1 - G1
L12		6	Lithonia Lighting	RACD P4 40K SYM	RACD P4 40K SYM	LED	1	RACD P4 40K SYM	11606	85.8782	0.91	TYPE VI, BUG RATING: B1 - U1 - G2
L13		10	Lithonia Lighting	DSX1 LED P6 40K T2M MVOLT P5	DSX1 LED P6 40K T2M MVOLT with house side shield	LED	1	DSX1 LED P6 40K T2M MVOLT P5	14662	163	0.92	TYPE III, SHORT, BUG RATING: B2 - U0 - G3
L14		41	Lithonia Lighting	DSX1 LED P6 40K T2M MVOLT	DSX1 LED P6 40K T2M MVOLT	LED	1	DSX1 LED P6 40K T2M MVOLT	18997	163	0.92	TYPE III, MEDIUM, BUG RATING: B3 - U0 - G3

Land Planning
Landscape
Architecture
Urban Design

NES

N.E.S. Inc.
619 N. Cascade Avenue, Suite 200
Colorado Springs, CO 80903

Tel. 719.471.0073
Fax 719.471.0267

www.nescolorado.com

© 2012. All Rights Reserved.

OWNER / DEVELOPER:
JACKSON DEARBORN, LLC

404 S. WELLS STREET
SUITE # 400
CHICAGO, IL 60607
CONTACT: DANE OLAMSTEAD
TEL: 734.216.2577

ARCHITECT:
LCM ARCHITECTS
5475 TECH WABASH AVE
FIFTH FLOOR
CHICAGO, IL 60605
TEL: 312.913.1717

CIVIL ENGINEER:
JR ENGINEERING
375 CENTER DRIVE
SUITE # 235
COLORADO SPRINGS, CO 80919
CONTACT: MIKE GRAMBLETT
TEL: 303.267.6240

STRUCTURAL ENGINEER:
MARTINO & LUTH, INC
999 18TH STREET
SUITE 855 NORTH
DENVER, CO 80202
TEL: 303.260.7118

MEP ENGINEER:
SALAS O'BRIEN
815 SOUTH WABASH AVENUE
CHICAGO, IL 60605
TEL: 312.786.4310

SOLACE
APARTMENTS
SITE DEVELOPMENT
PLAN

DATE: 11/18/2020
PROJECT MGR: PROJECT MGR
PREPARED BY: PREPARED BY

NOT FOR
CONSTRUCTION

ISSUE TYPE

DATE: BY: DESCRIPTION:

SITE PHOTOMETRIC
STUDY

A0.21