



2 XWM WALLPACK (WP1) & (WP2)
DP-46 SCALE: NONE

LIGHT FIXTURE SCHEDULE

MARK	MANUFACTURER	MODEL	LAMP			MOUNTING	DESCRIPTION	VOLTAGE	TOTAL		NOTES
			QTY.	WATT	TYPE				WATTS	NOTES	
WP1	LSI INDUSTRIES, INC	XWM-FT-LED-12L-40	1	77	LED	WALL	WALL PACK LED	120	77	1,2	
WP2	LSI INDUSTRIES, INC	XWM-FT-LED-15L-40	1	98	LED	WALL	WALL PACK LED	120	98	1,2	

- NOTES:
 1) LIGHTING FIXTURE TO BE CONTROLLED VIA LIGHTING CONTROL PANEL WITH TIME CLOCK AND PHOTOCELL.
 2) CONFIRM ALL LIGHT FIXTURE SELECTIONS WITH TENANT PRIOR TO ORDERING. THIS INCLUDES COLORS, COLOR TEMPERATURES, MANUFACTURER, ETC.

CALCULATION ZONE STATISTICS

DESCRIPTION	SYMBOL (fc)	AVERAGE (fc)	MAXIMUM (fc)	MINIMUM (fc)	MAX./MIN. (fc)	AVG./MIN. (fc)
DRIVE WAY/SIDE WALKS	+	8.8	20.4	1.1	18.5:1	8.0:1
LOT LINE	+	.1	2.7	0.0	-	-

LIGHT FIXTURE NOTE:

ALL LIGHTING FIXTURES SHALL BE FULL CUT-OFF OR HAVE SHIELDING TO REDUCE OFF-SITE LIGHTING IMPACTS ONTO ADJACENT PROPERTIES AND ROADWAYS. ALL EXTERIOR LIGHTING SHALL BE ARRANGED TO MITIGATE LIGHT DIRECTED AWAY FROM ADJACENT PROPERTIES AND ANY PUBLIC RIGHT-OF-WAY. AN AMENDMENT TO THIS PLAN MAY BE REQUIRED IF THE LIGHTING TYPE IS CHANGED.

CLIENT:

ARCHITECT:

cShea
onsulting, LLC
 MECHANICAL + ELECTRICAL + PLUMBING
 4445 Northpark Dr. Suite 200
 Colorado Springs, CO 80907
 csheaconsulting.com
 Project #: 24-7349

REVIEW ONLY
 NOT FOR
 CONSTRUCTION
 5.8.2024

OWNERSHIP OF INSTRUMENTS OF SERVICE

All Drawings, Reports, Plans, Specifications, Computer Files (including CAD files), field information, notes, sketches, and other design materials prepared by the Engineer and his/her consultants as instruments of service shall remain the property of the Engineer. The Engineer shall retain all common law, statutory and other reserved rights, including the Copyright therein.

-PLATTE SELF-STORAGE PHOTOMETRIC-
 6001 East Platte Ave,
 Colorado Springs, Colorado 80915

FULL SET ISSUE HISTORY:


1	REVIEW SET	5.8.2024
---	------------	----------

△ SHEET REVISION:

PROJECT #: 24-7349
 DRAWN BY: SH
 CHECKED BY: MRM

SHEET

DP-46

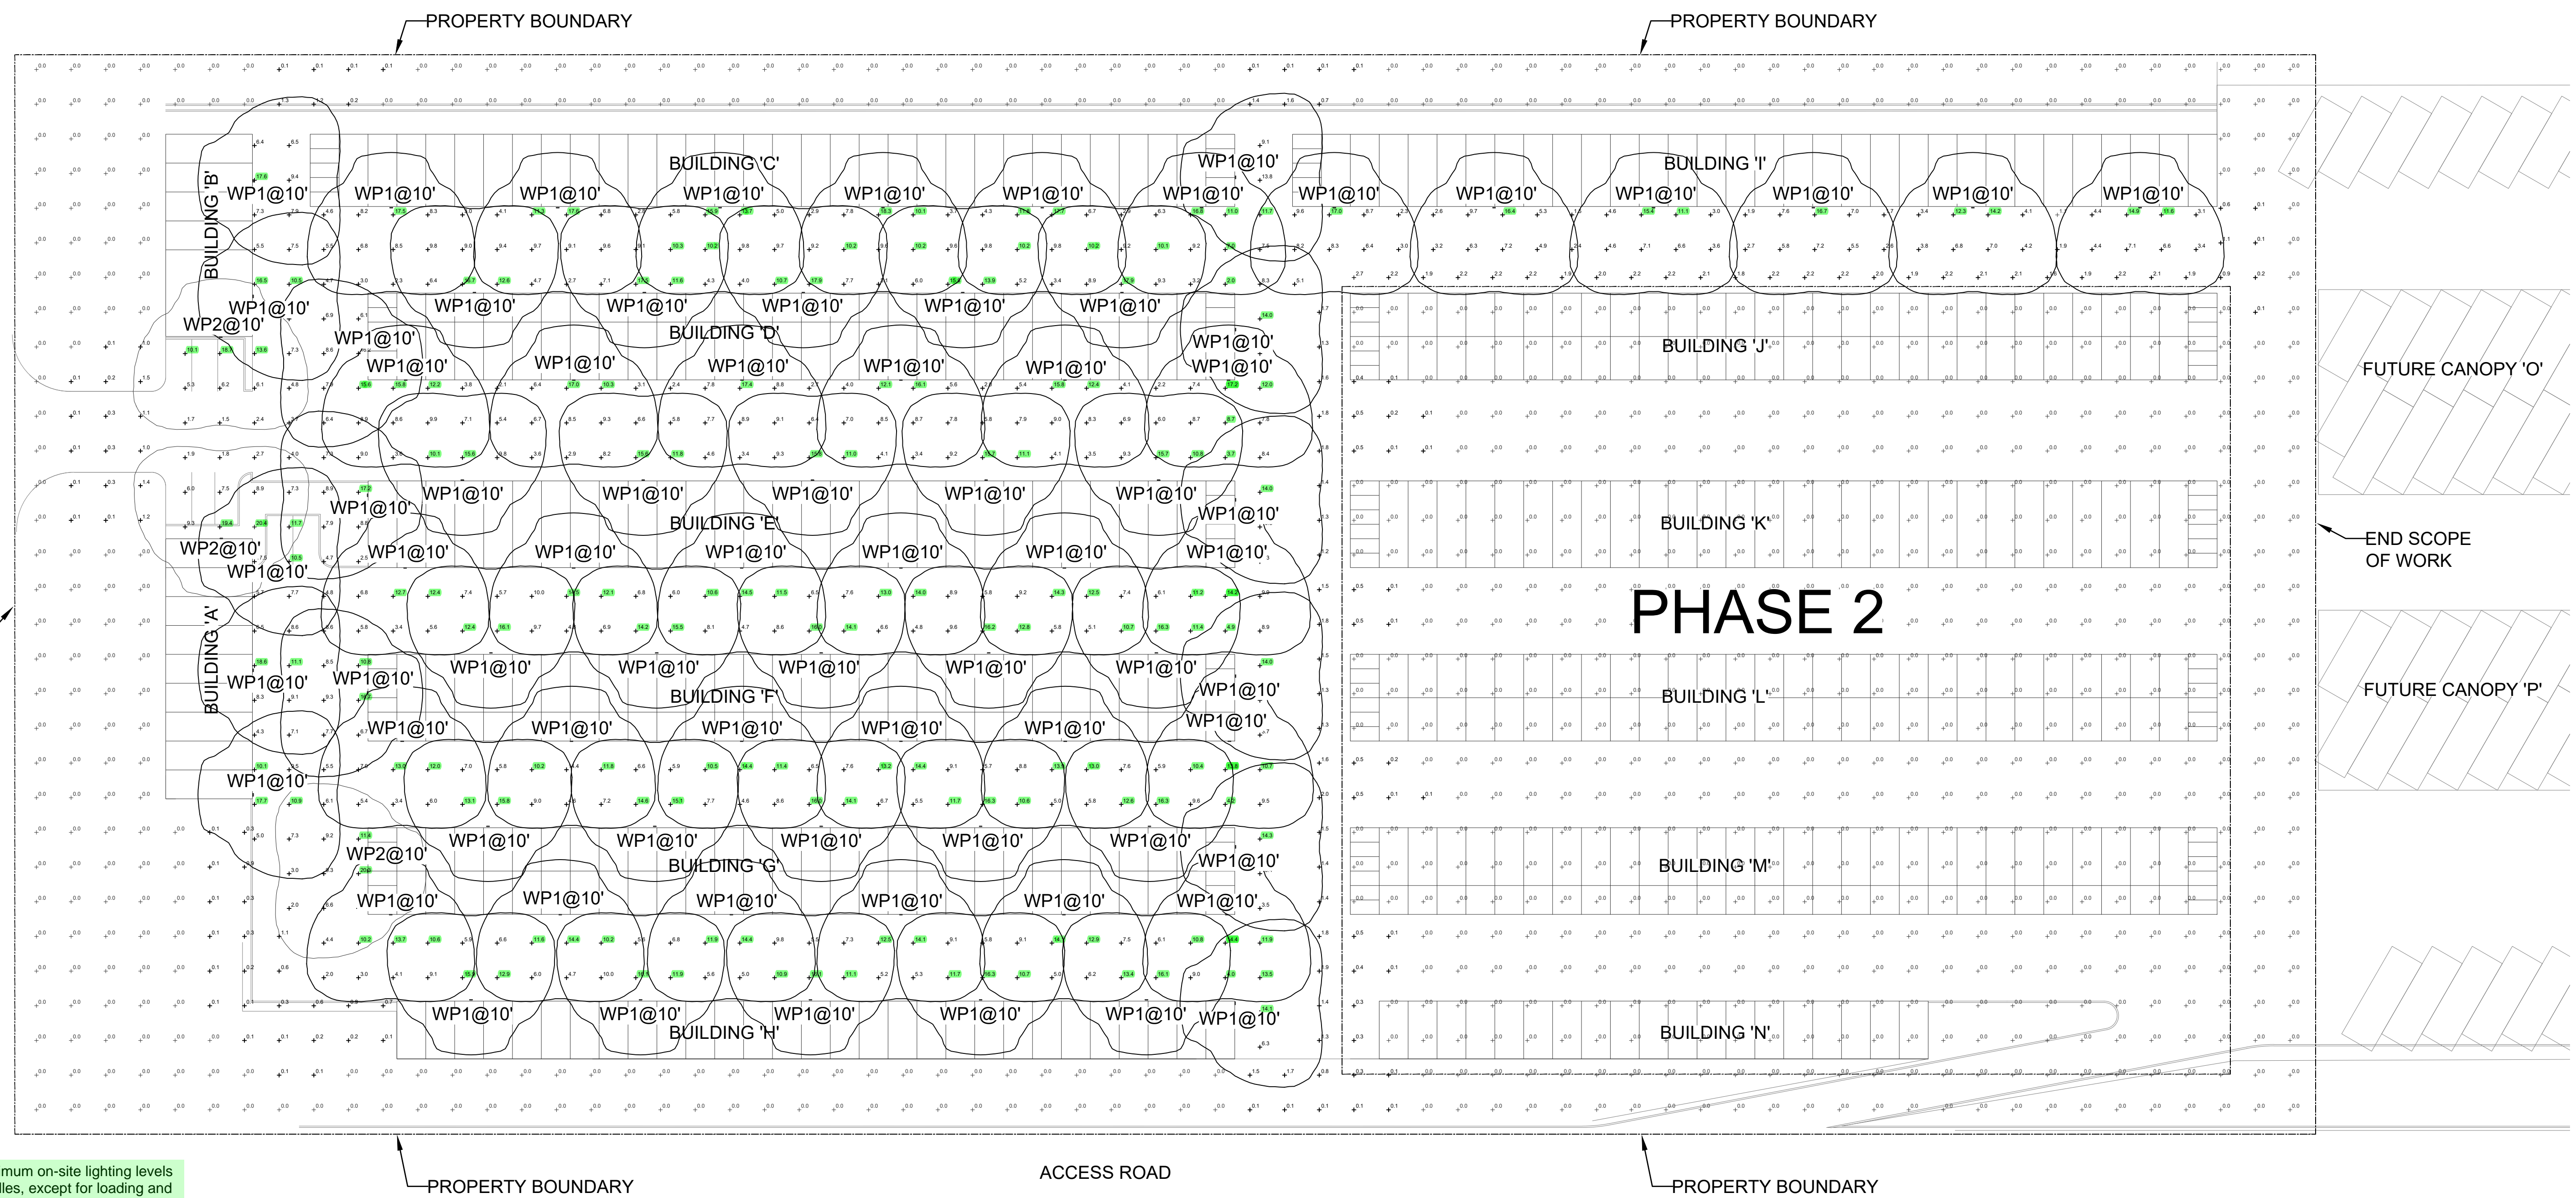

Per Section 6.2.3.B.1.d. Maximum on-site lighting levels shall not exceed 10 foot candles, except for loading and unloading platforms where the maximum lighting level shall be 20 foot candles.

1 SITE PHOTOMETRIC PLAN
 DP-46 SCALE: 1/30"=1'-0"

