




NORTH ELEVATION

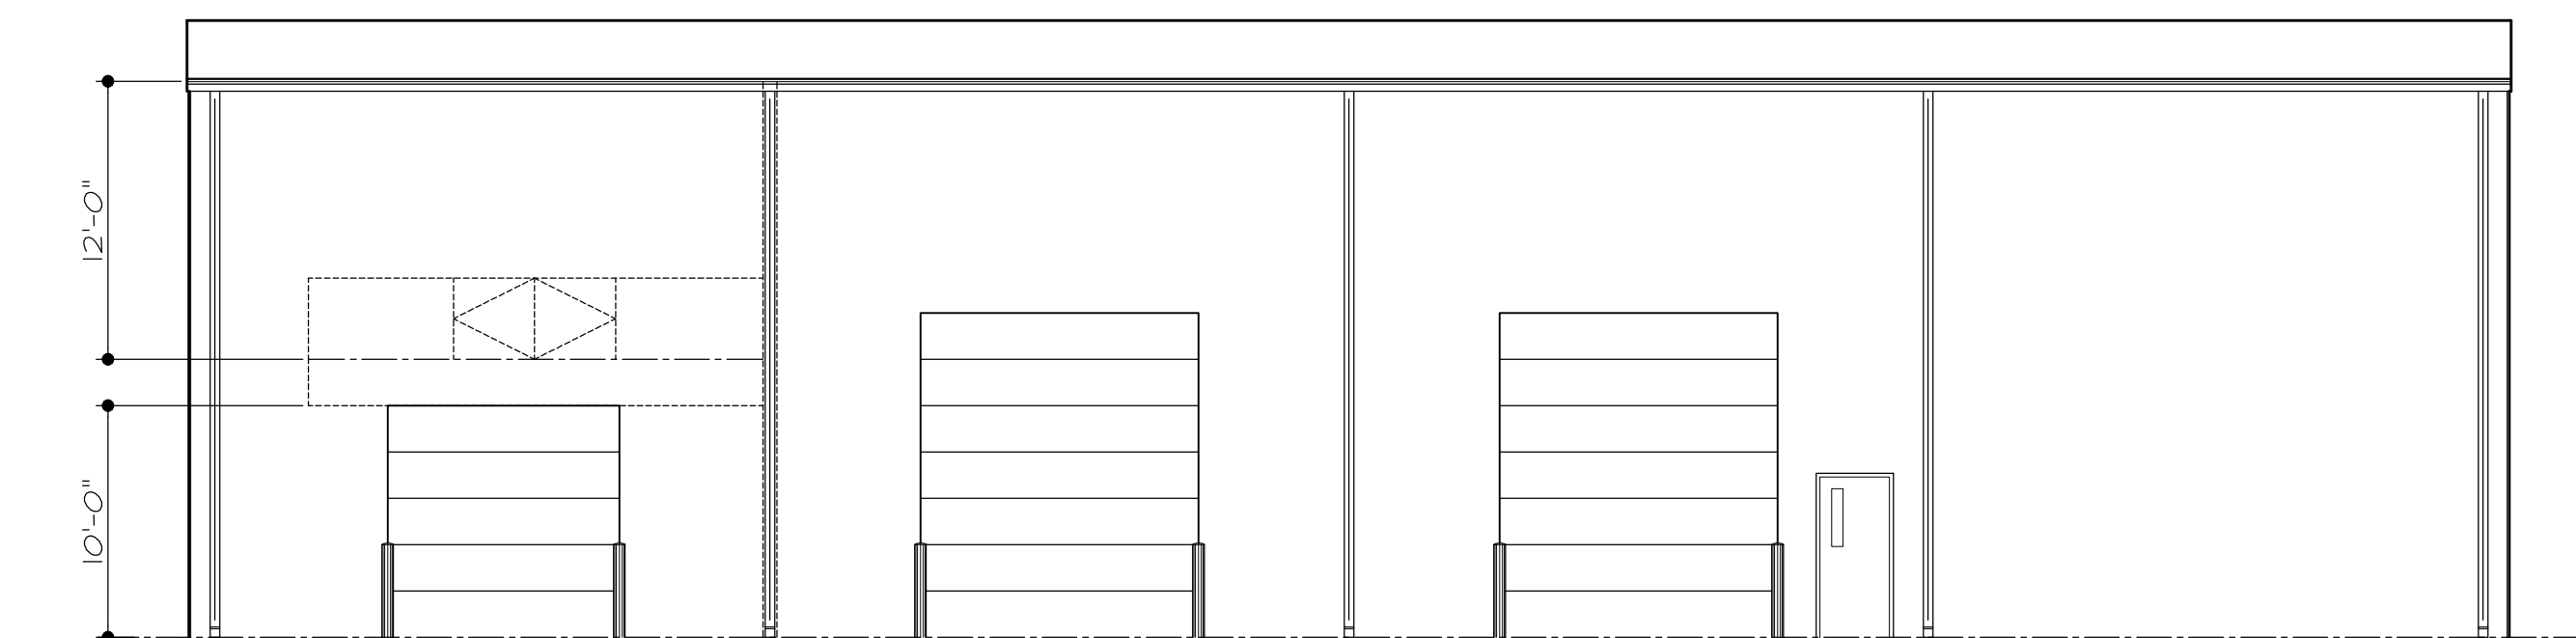

WEST ELEVATION

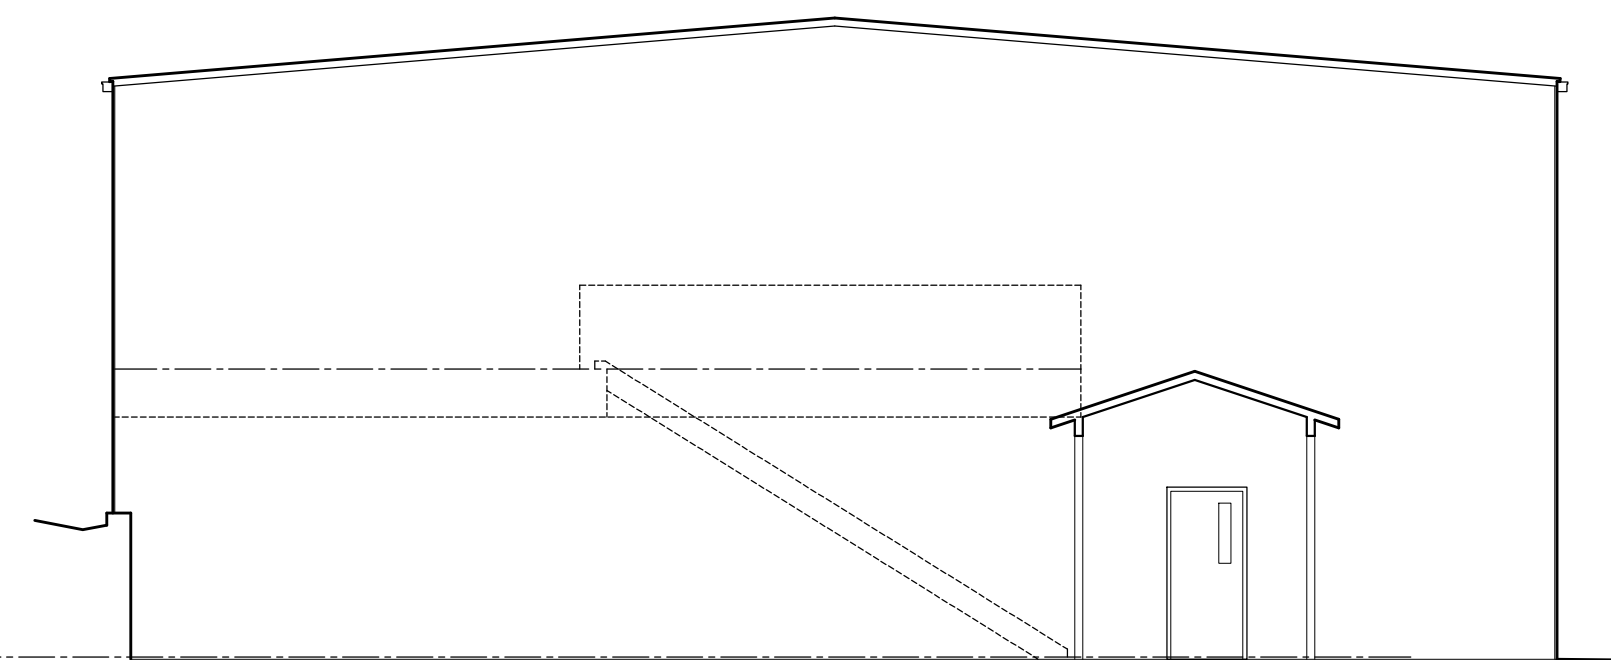

EAST ELEVATION

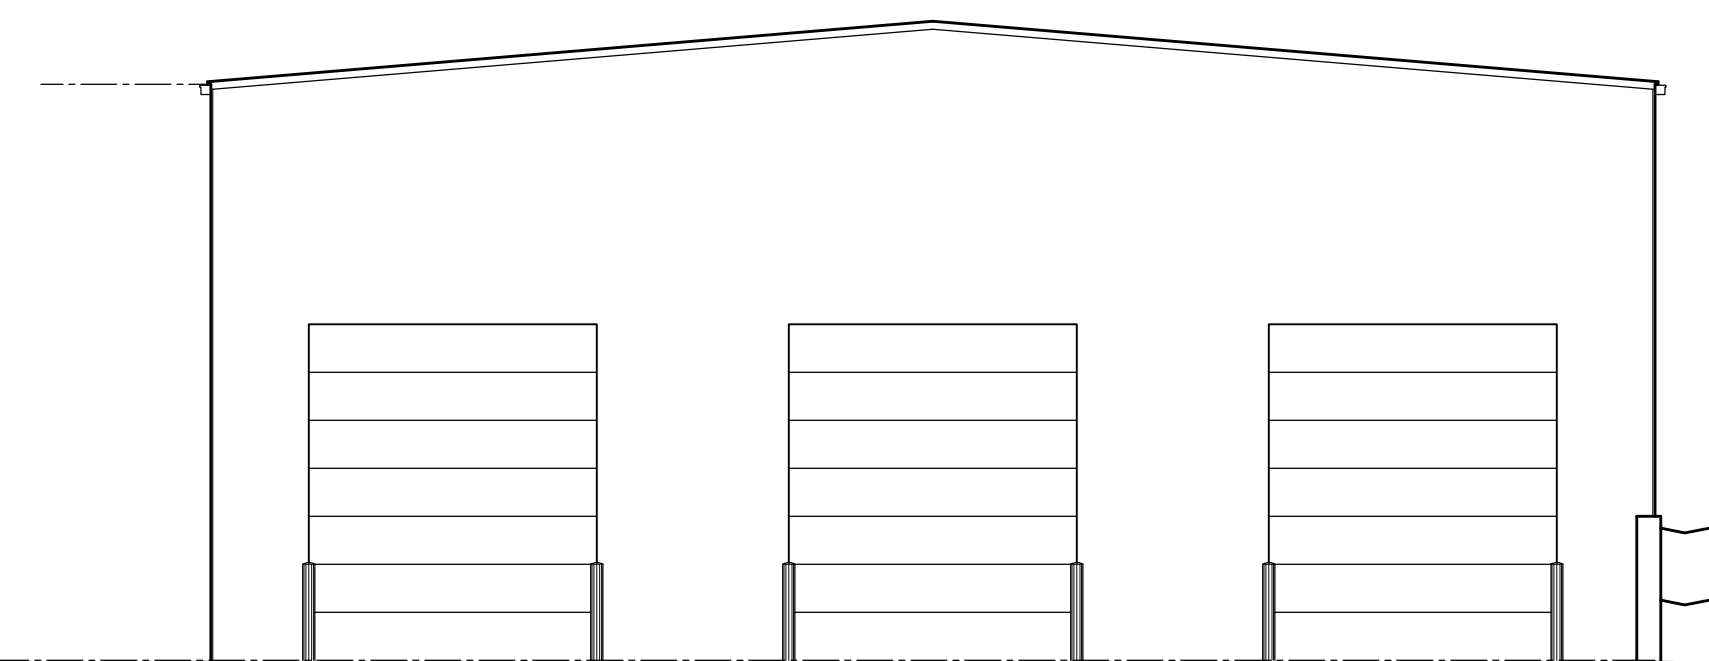

SOUTH ELEVATION

EXTERIOR ELEVATIONS

SCALE: 1/8" = 1'-0"

EXTERIOR ELEVATION NOTES


- 1) SEE GENERAL NOTES ON SHEET T5-1.
- 2) SEE ASSEMBLY NOTES ON SHEET A-1.
- 3) SEE MECHANICAL, PLUMBING & ELECTRICAL PLANS.

Where are the elevations for the existing structures?

Contractor :

COPYRIGHT 2019 LGA STUDIOS. THIS DOCUMENT AND ITS CONTENTS ARE THE PROPERTY OF AND MAY NOT BE REPRODUCED WITHOUT THE WRITTEN PERMISSION OF LGA STUDIOS. ALL RIGHTS RESERVED.

Michael W. Hentschel, RA, CSI
MWH & ASSOCIATES
Consulting Architectural Services
Larry Gilliland, LEED AP, CSI, CPBD
201 East Las Animas Street Suite 113
Colorado Springs, CO 80903
Office: (719) 635-0880
Cell: (719) 684-7000
LGA Studios
www.lgastudios.com

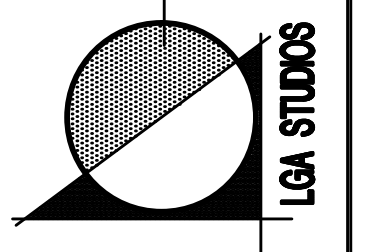

ARACO Concrete Contractors
New Maintenance Building
7470 SOUTHWOOD DRIVE
FOUNTAIN, COLORADO 80817

Project No. LGA18-1605
(14)M-H-17-01P-C02
File No. A4.1EL-C
Drawn: MWH
Checked: MWH, LG
Issued: 08/26/17
Revisions:

EXTERIOR ELEVATIONS
SCALE: AS NOTED
Sheet Number:
A4.1
OF 2 SHEETS

PRELIMINARY REVIEW ONLY
NOT FOR CONSTRUCTION