


Symbol	Qty	Label	Arrangement	Total Lamp Lumens	LLF
⌈	1	MLLG-AL-LED-WPFC2-50-50 IESNA	SINGLE	N.A.	1,000
⌋	2	MLLG-AL-LED-WPFC2-30-50 IESNA	SINGLE	N.A.	1,000

Label	Units	Avg	Max	Min	Avg/Min	Max/Min
Parking Lot	Fc	0.04	20.1	0.0	N.A.	N.A.

Label	X	Y	Z	Orient	Tilt
MLLG-AL-LED-WPFC2-50-50 IESNA	358	451	20	90	0
MLLG-AL-LED-WPFC2-30-50 IESNA	393	427	8	0	0
MLLG-AL-LED-WPFC2-30-50 IESNA	327	347	8	180	0

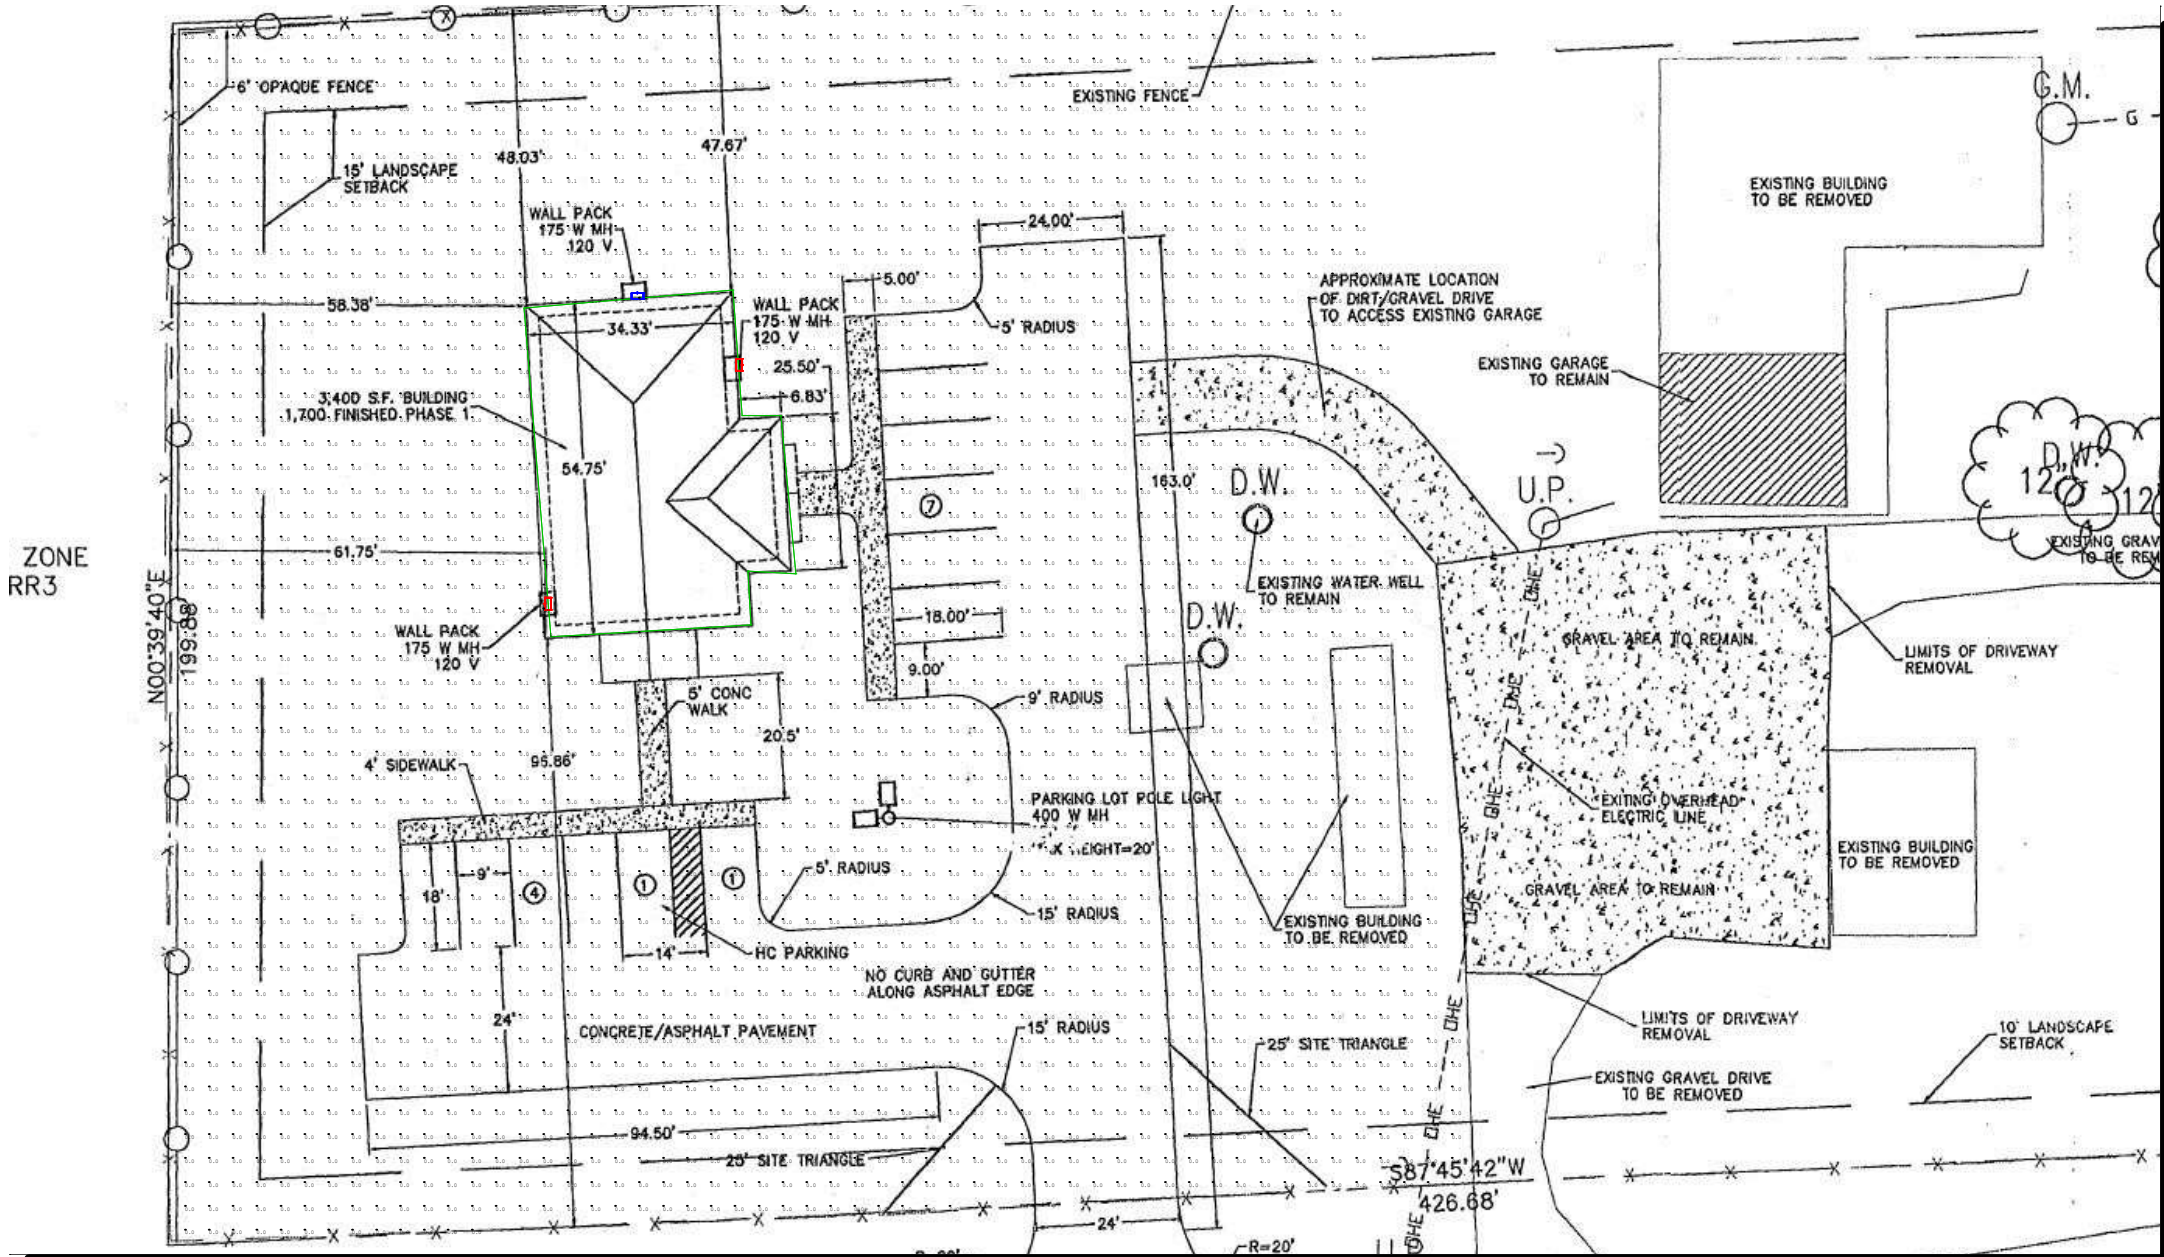

ZONE RR3

Leann Wilson Office Building

Page 1 of 1

DATE: 5/25/2021

REF NO. Leann Wilson Office Building AGI

SCALE: AS SHOWN

Lighting Specialist

Tyler Greene

tgreene@ledlighting supply.com

DRK Enterprises LLC / LED Lighting Supply  
1 Chestnut Street, 4M  
Nashua, NH 03060  
(888) 423-3191  
www.ledlightingsupply.com



AG328 Version 19.150

NOTES:  
1) MOUNTING DETAILS TO BE DETERMINED AT JOBSITE BY OTHERS.  
2) CALCULATIONS SHOW THE EFFECT OF SHADOWING CAUSED BY OBJECTS WITHIN THE AREA.  
3) READINGS SHOWN ARE MAINTAINED HORIZONTAL FOOTCANDLES TAKEN AS SHOWN IN NUMERIC SUMMARY.  
4) FIXTURE ORIENTATION IS SUCH THAT 0 IS TO THE RIGHT OF THE DRAWING AND 90 IS TO THE TOP OF THE DRAWING AS SHOWN.  
5) TILT ANGLE IS THE RAISING AND LOWERING OF THE FIXTURE HEAD.  
6) THE LAYOUT DRAWING MUST BE COORDINATED WITH THE SITE LOCATION FOR CORRECT FIXTURE ORIENTATION.  
7) CHECK GRAPHIC SCALE. DOCUMENTS PRINTED OR PLOTTED FROM ELECTRONIC FILES MAY OCCUR AT OTHER THAN THE DESIRED OR ASSUMED GRAPHIC SCALES. IT IS THE RESPONSIBILITY OF THE RECIPIENT TO VERIFY THAT THE PRINTED OR PLOTTED 1"=0' SCALE DRAWING IS PRINTED TO SCALE.  
8) LUMINAIRE LUMENS = LUMENS LEAVING LUMINAIRE WITH EFFICIENCY CONSIDERED.  
9) You should not expect the same lighting results indicated by the lighting plan if the fixture is swapped out for another fixture.  
NOTICE: THIS DRAWING IS THE EXCLUSIVE PROPERTY OF DRK ENTERPRISE LLC/LED LIGHTING SUPPLY (LLS). DISTANCE CONSIDERATIONS ARE SUCH THAT THE DRAWING WILL BE TREATED AS AN ACCURATE REPRESENTATION OF THE PROJECT. DRK ENTERPRISE LLC/LED LIGHTING SUPPLY (LLS) IS NOT BEING HELD RESPONSIBLE FOR THE OPERATION OF UNITS FURNISHED BY LLS. IT IS TO BE RETURNED UPON REQUEST AND IS NOT TO BE COMMUNICATED, DISCLOSED OR COPIED, EXCEPT AS EXPRESSLY AUTHORIZED BY DRK ENTERPRISE LLC/LED LIGHTING SUPPLY.  
NOTICE: THE INTENT OF THIS LIGHTING LAYOUT IS TO SUGGEST THE BEST UTILIZATION OF LIGHTING FIXTURES PROVIDED BY DRK ENTERPRISE LLC/LED LIGHTING SUPPLY. IT IS PROVIDED USING FIXTURE PHOTOMETRICS FURNISHED BY DRK ENTERPRISE LLC/LED LIGHTING SUPPLY. ANY VARIATION IN FIXTURE PERFORMANCE FROM PERFORMANCE SHOWN IN IES FILE IS THE RESPONSIBILITY OF THE MANUFACTURER. IT'S USE FOR ANY OTHER PURPOSE IS NOT AUTHORIZED BY DRK ENTERPRISE LLC/LED LIGHTING SUPPLY.