
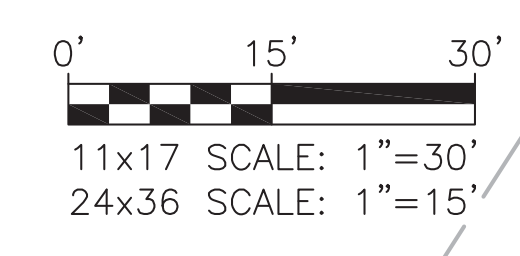


2018/10/30 12:50 PM By: RMM u:\JDS-Hydro\Project Files\136 4-Way Ranch\136.23 LS Site Development Plan\Drawings\13623_7_Lighting.dwg

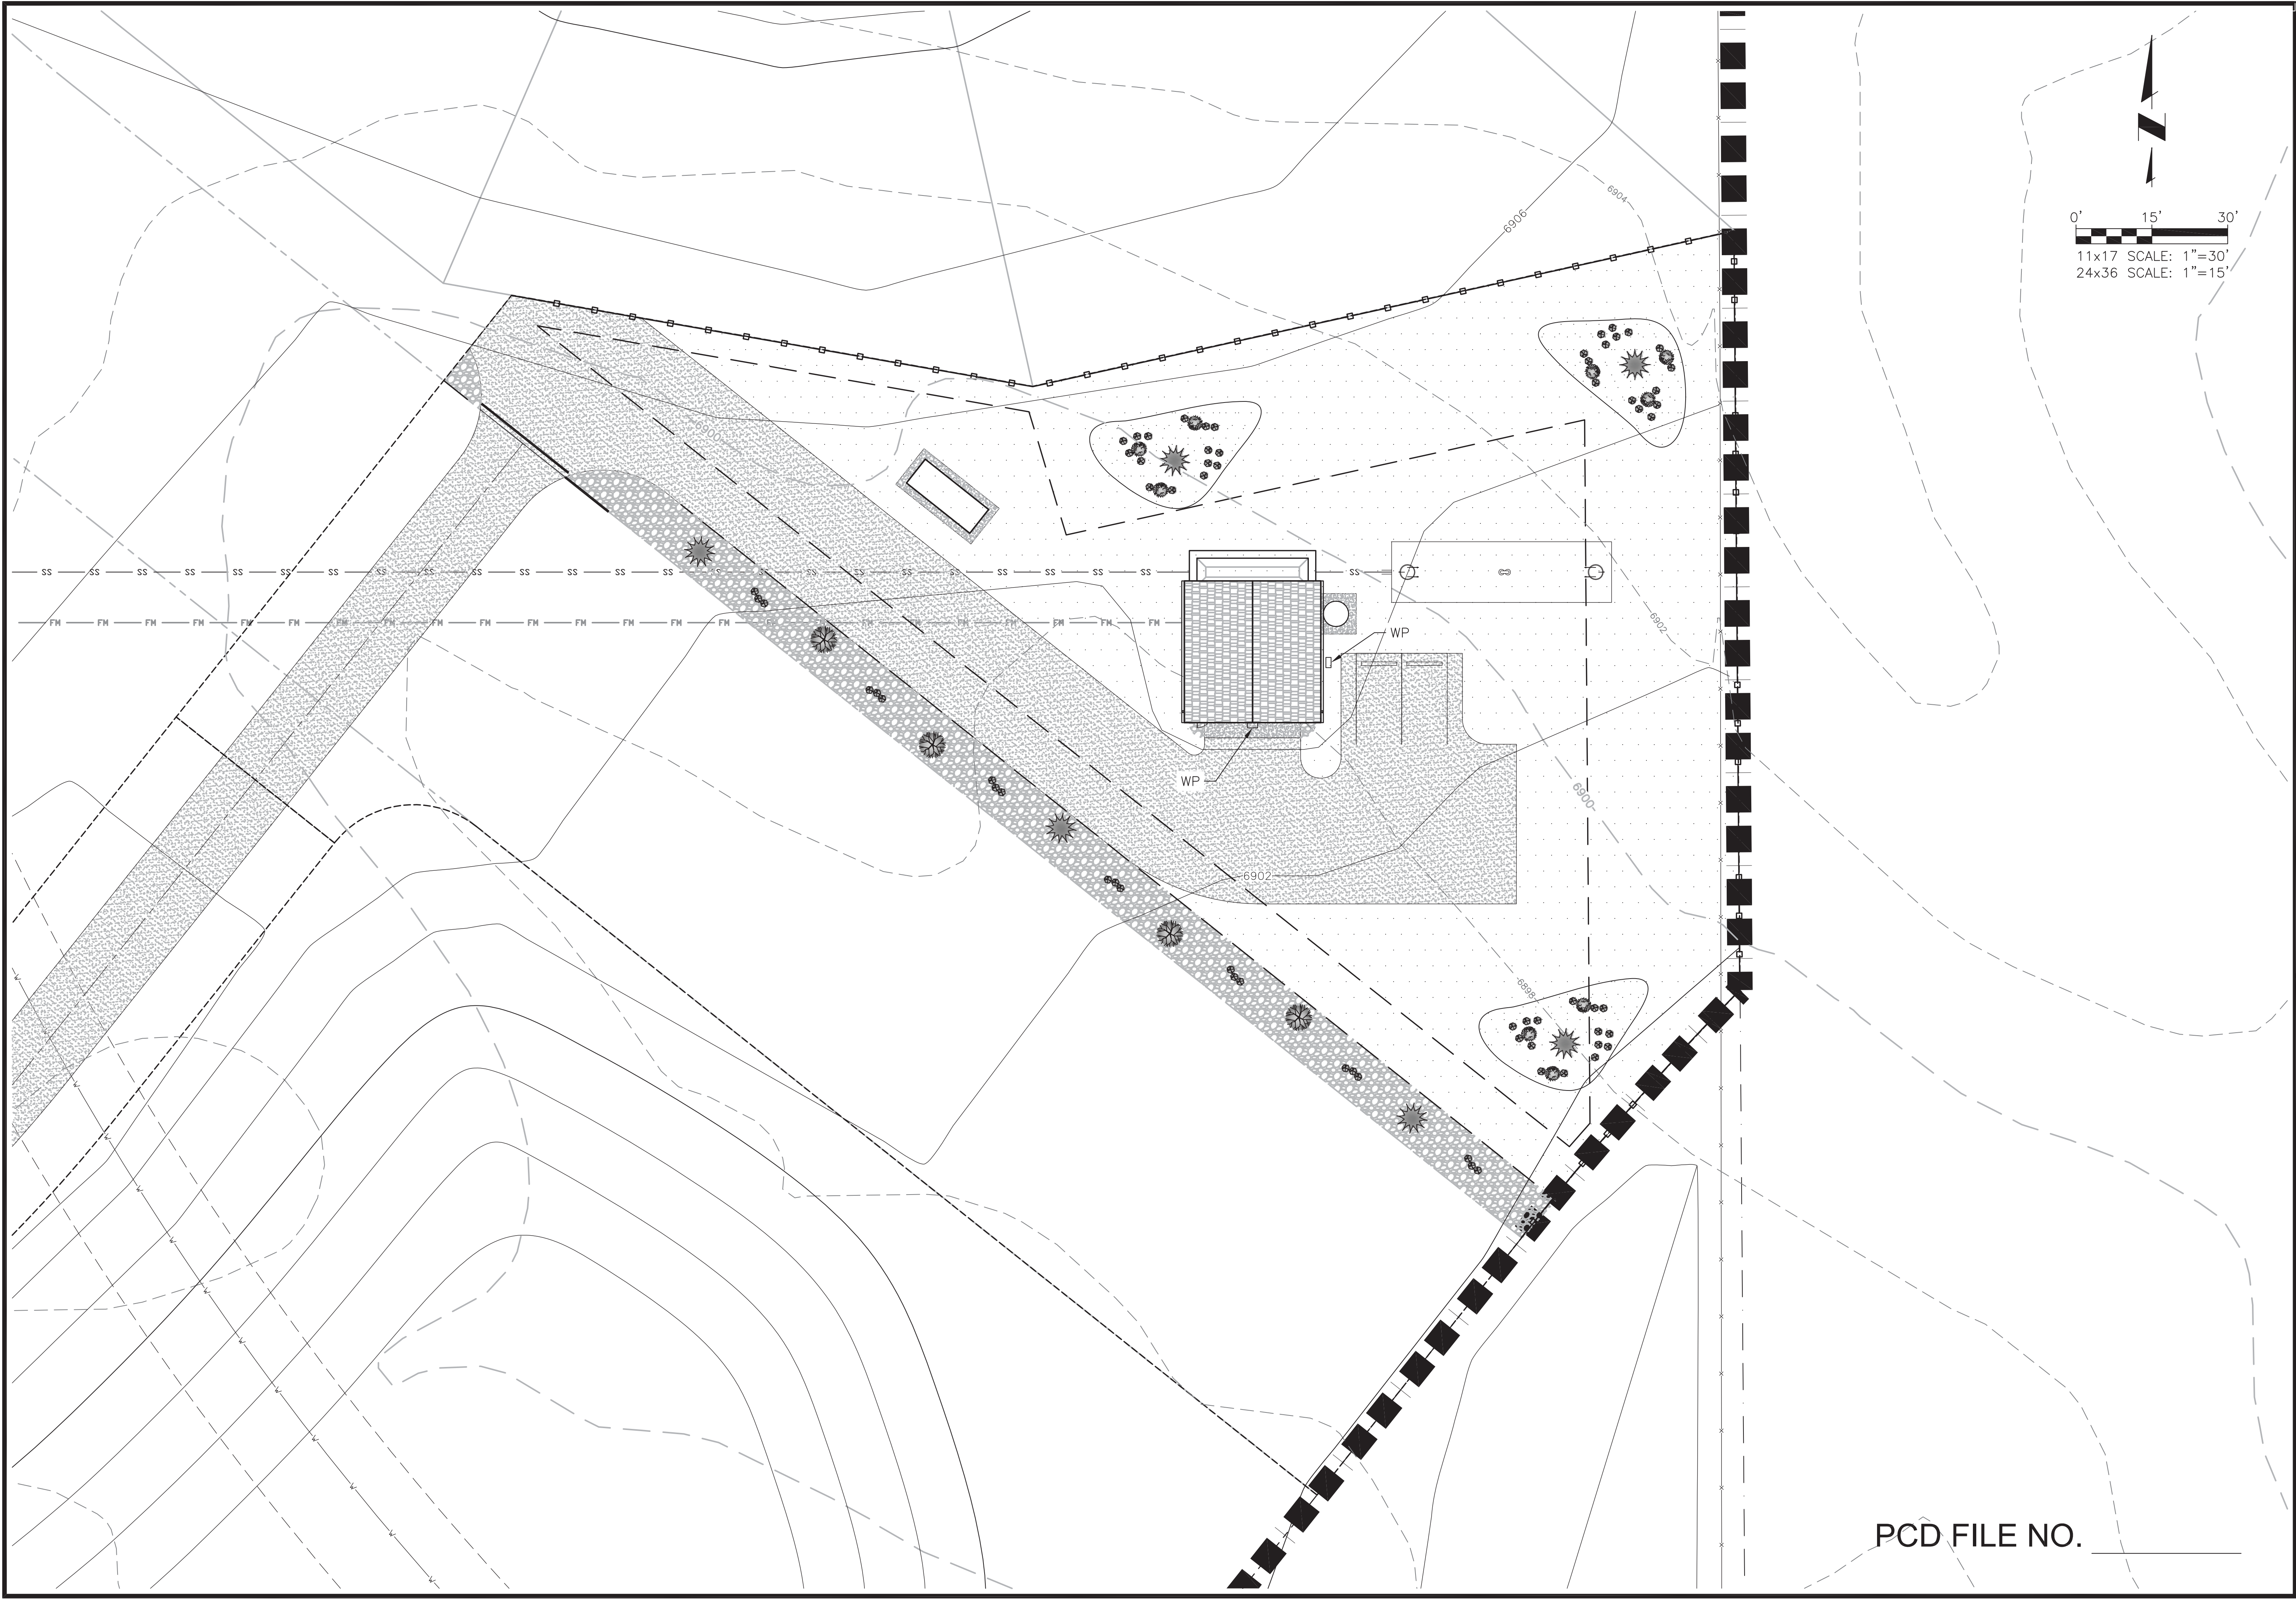

4-WAY RANCH METROPOLITAN DISTRICT
LIFT STATION SITE DEVELOPMENT PLAN
LIGHTING PLAN

NO.	DESCRIPTION	BY	APP.	DATE
1				
2				
3				
4				
5				
6				
7				

100% DESIGN DRAWINGS

Project No.: 136.23
 Date: 10/25/18
 Design: RMM
 Drawn: GGM/RMM
 Check: JPM

LP1
 SHEET 3 OF 5

PCD FILE NO. _____

JDS-HYDRO CONSULTANTS, INC.
 545 EAST PIKES PEAK AVENUE, SUITE 300
 COLORADO SPRINGS, COLORADO 80903
 (719) 227-0072
DESIGNER, THE CONTRACTOR SHALL VERIFY ALL DIMENSIONS AND ELEVATIONS FOR ANCHORS SHALL BE REPORTED TO JDS-HYDRO CONSULTANTS, INC. JDS-HYDRO ASSUMES NO LIABILITY FOR UNAUTHORIZED CHANGES AND/OR REVISIONS MADE TO PLANS.