

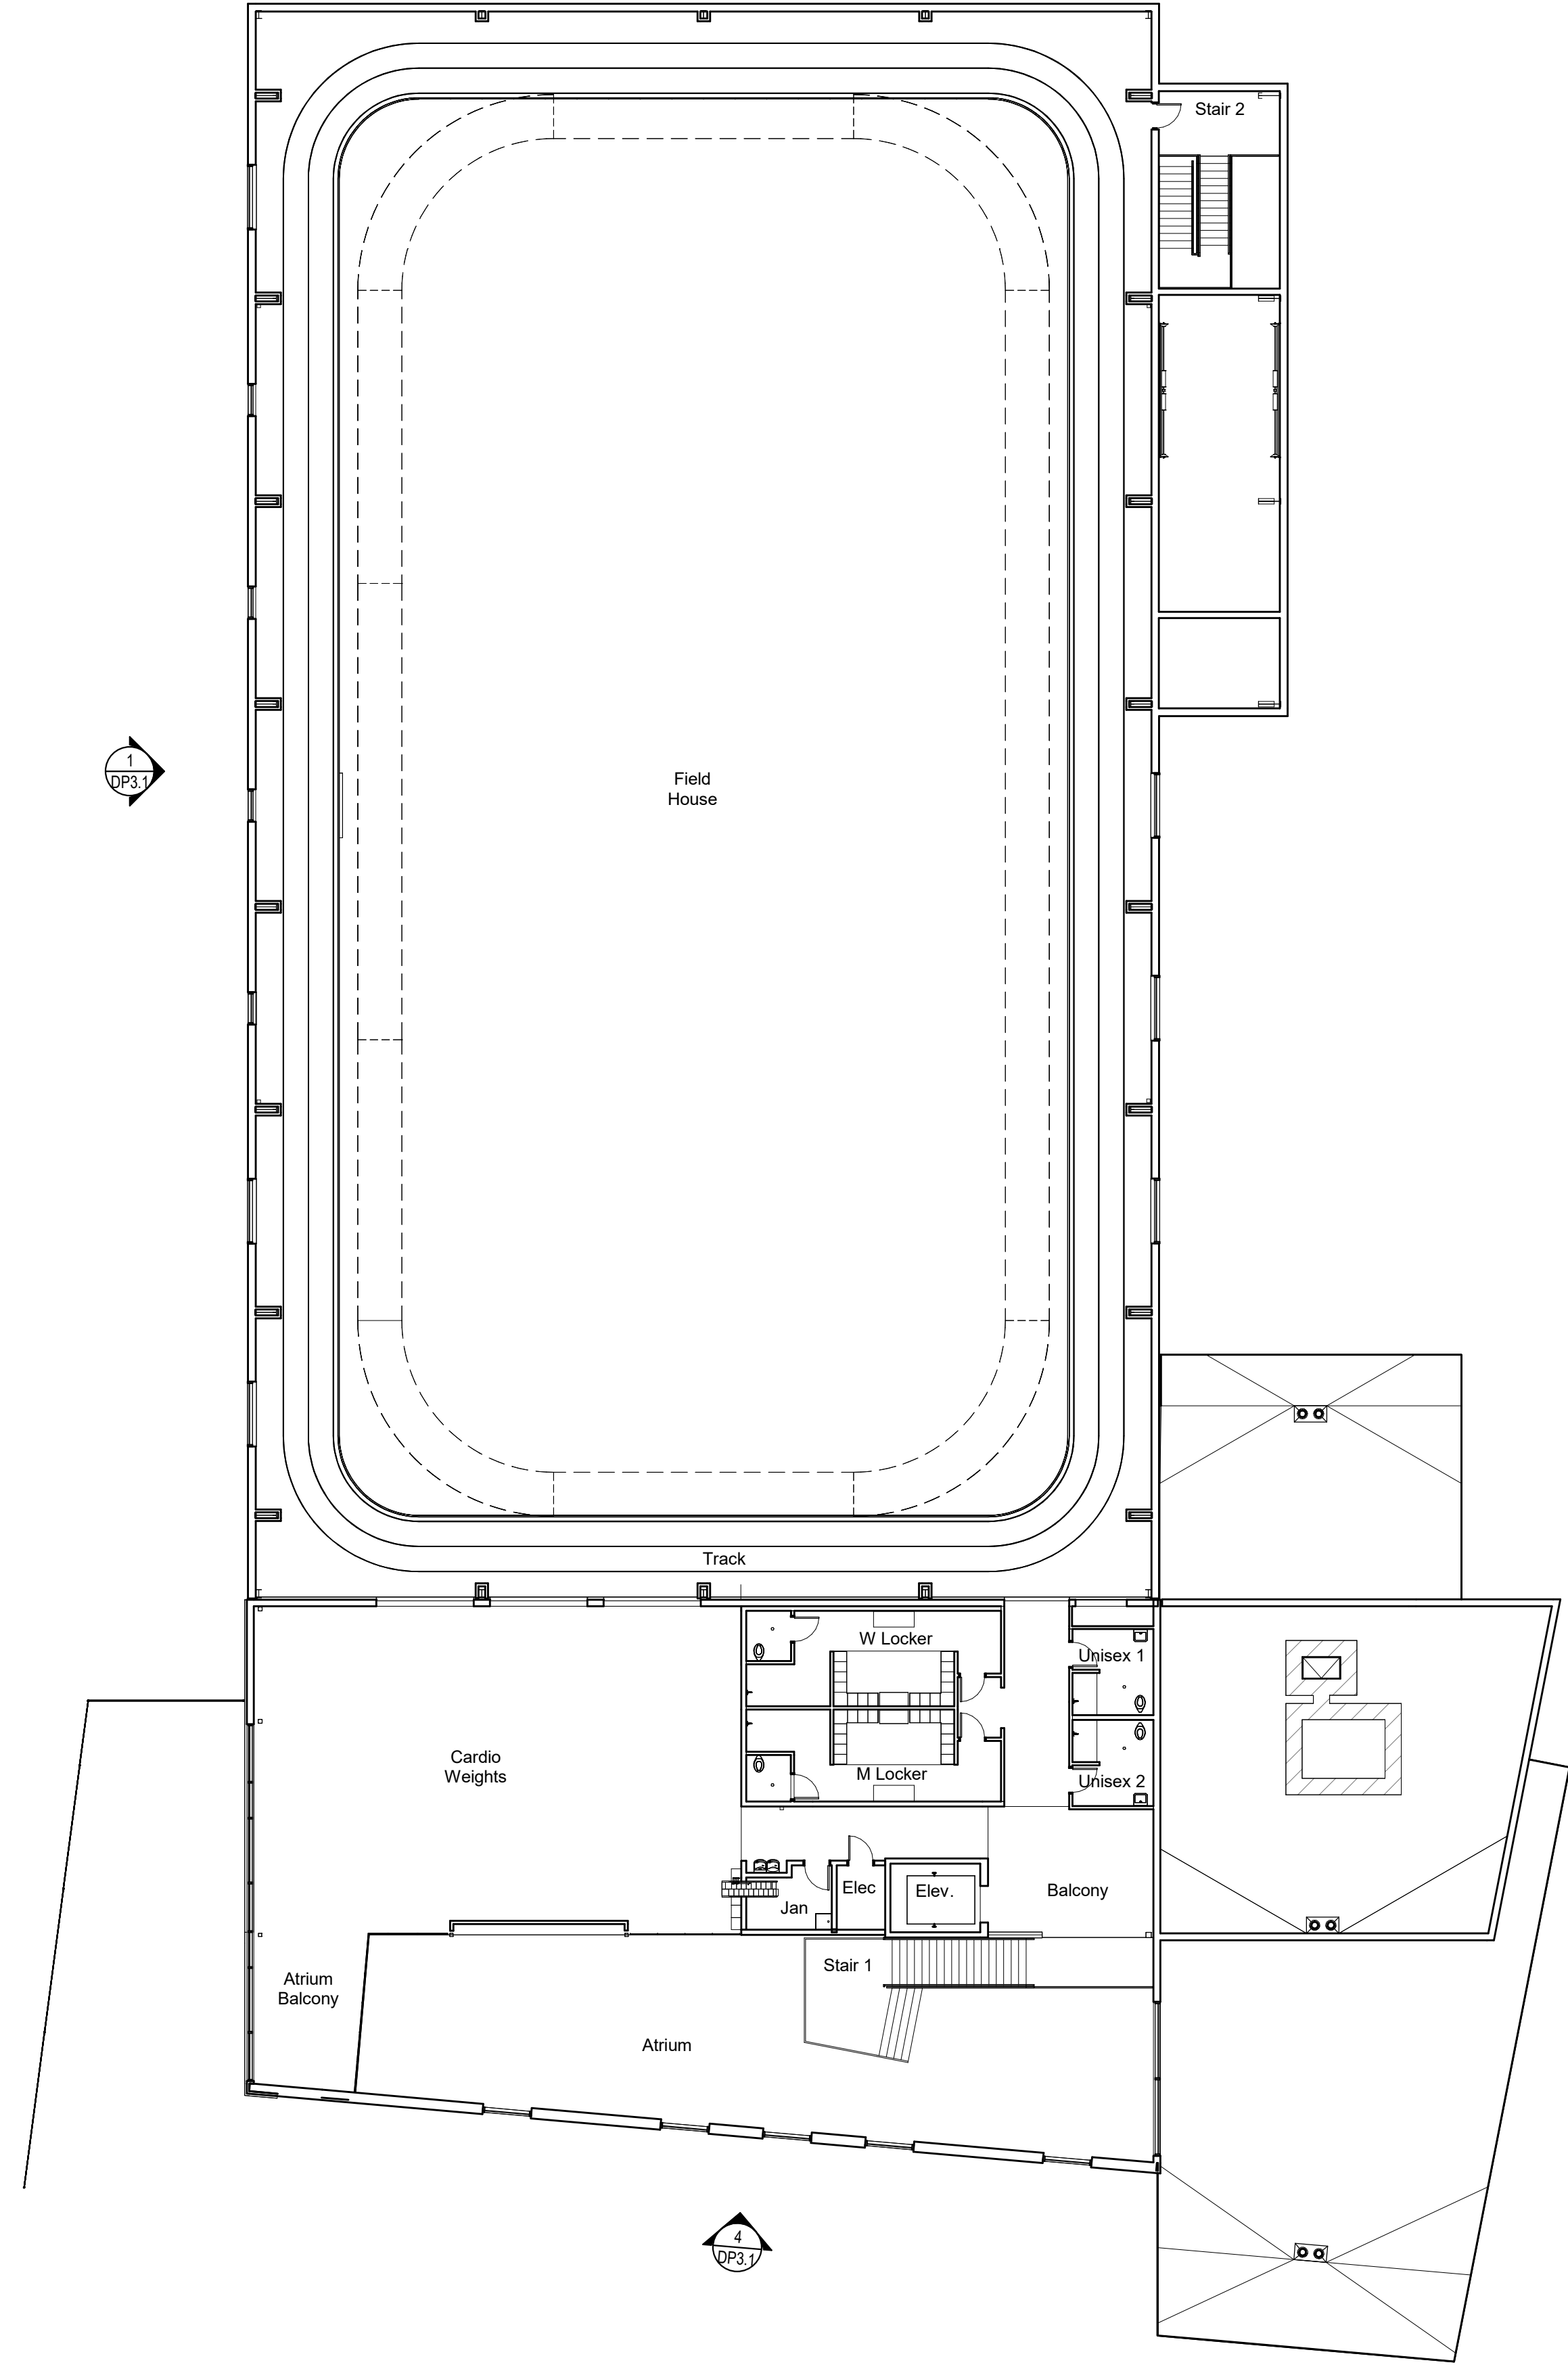


2/21/2024 9:53:12 AM

17 Mezzanine  
Scale: 1/16" = 1'-0"

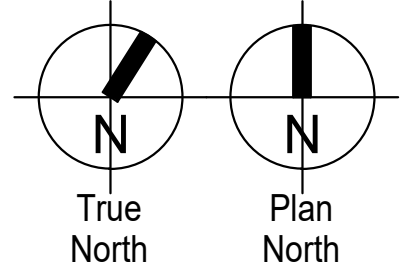

9 Main Level  
Scale: 1/16" = 1'-0"

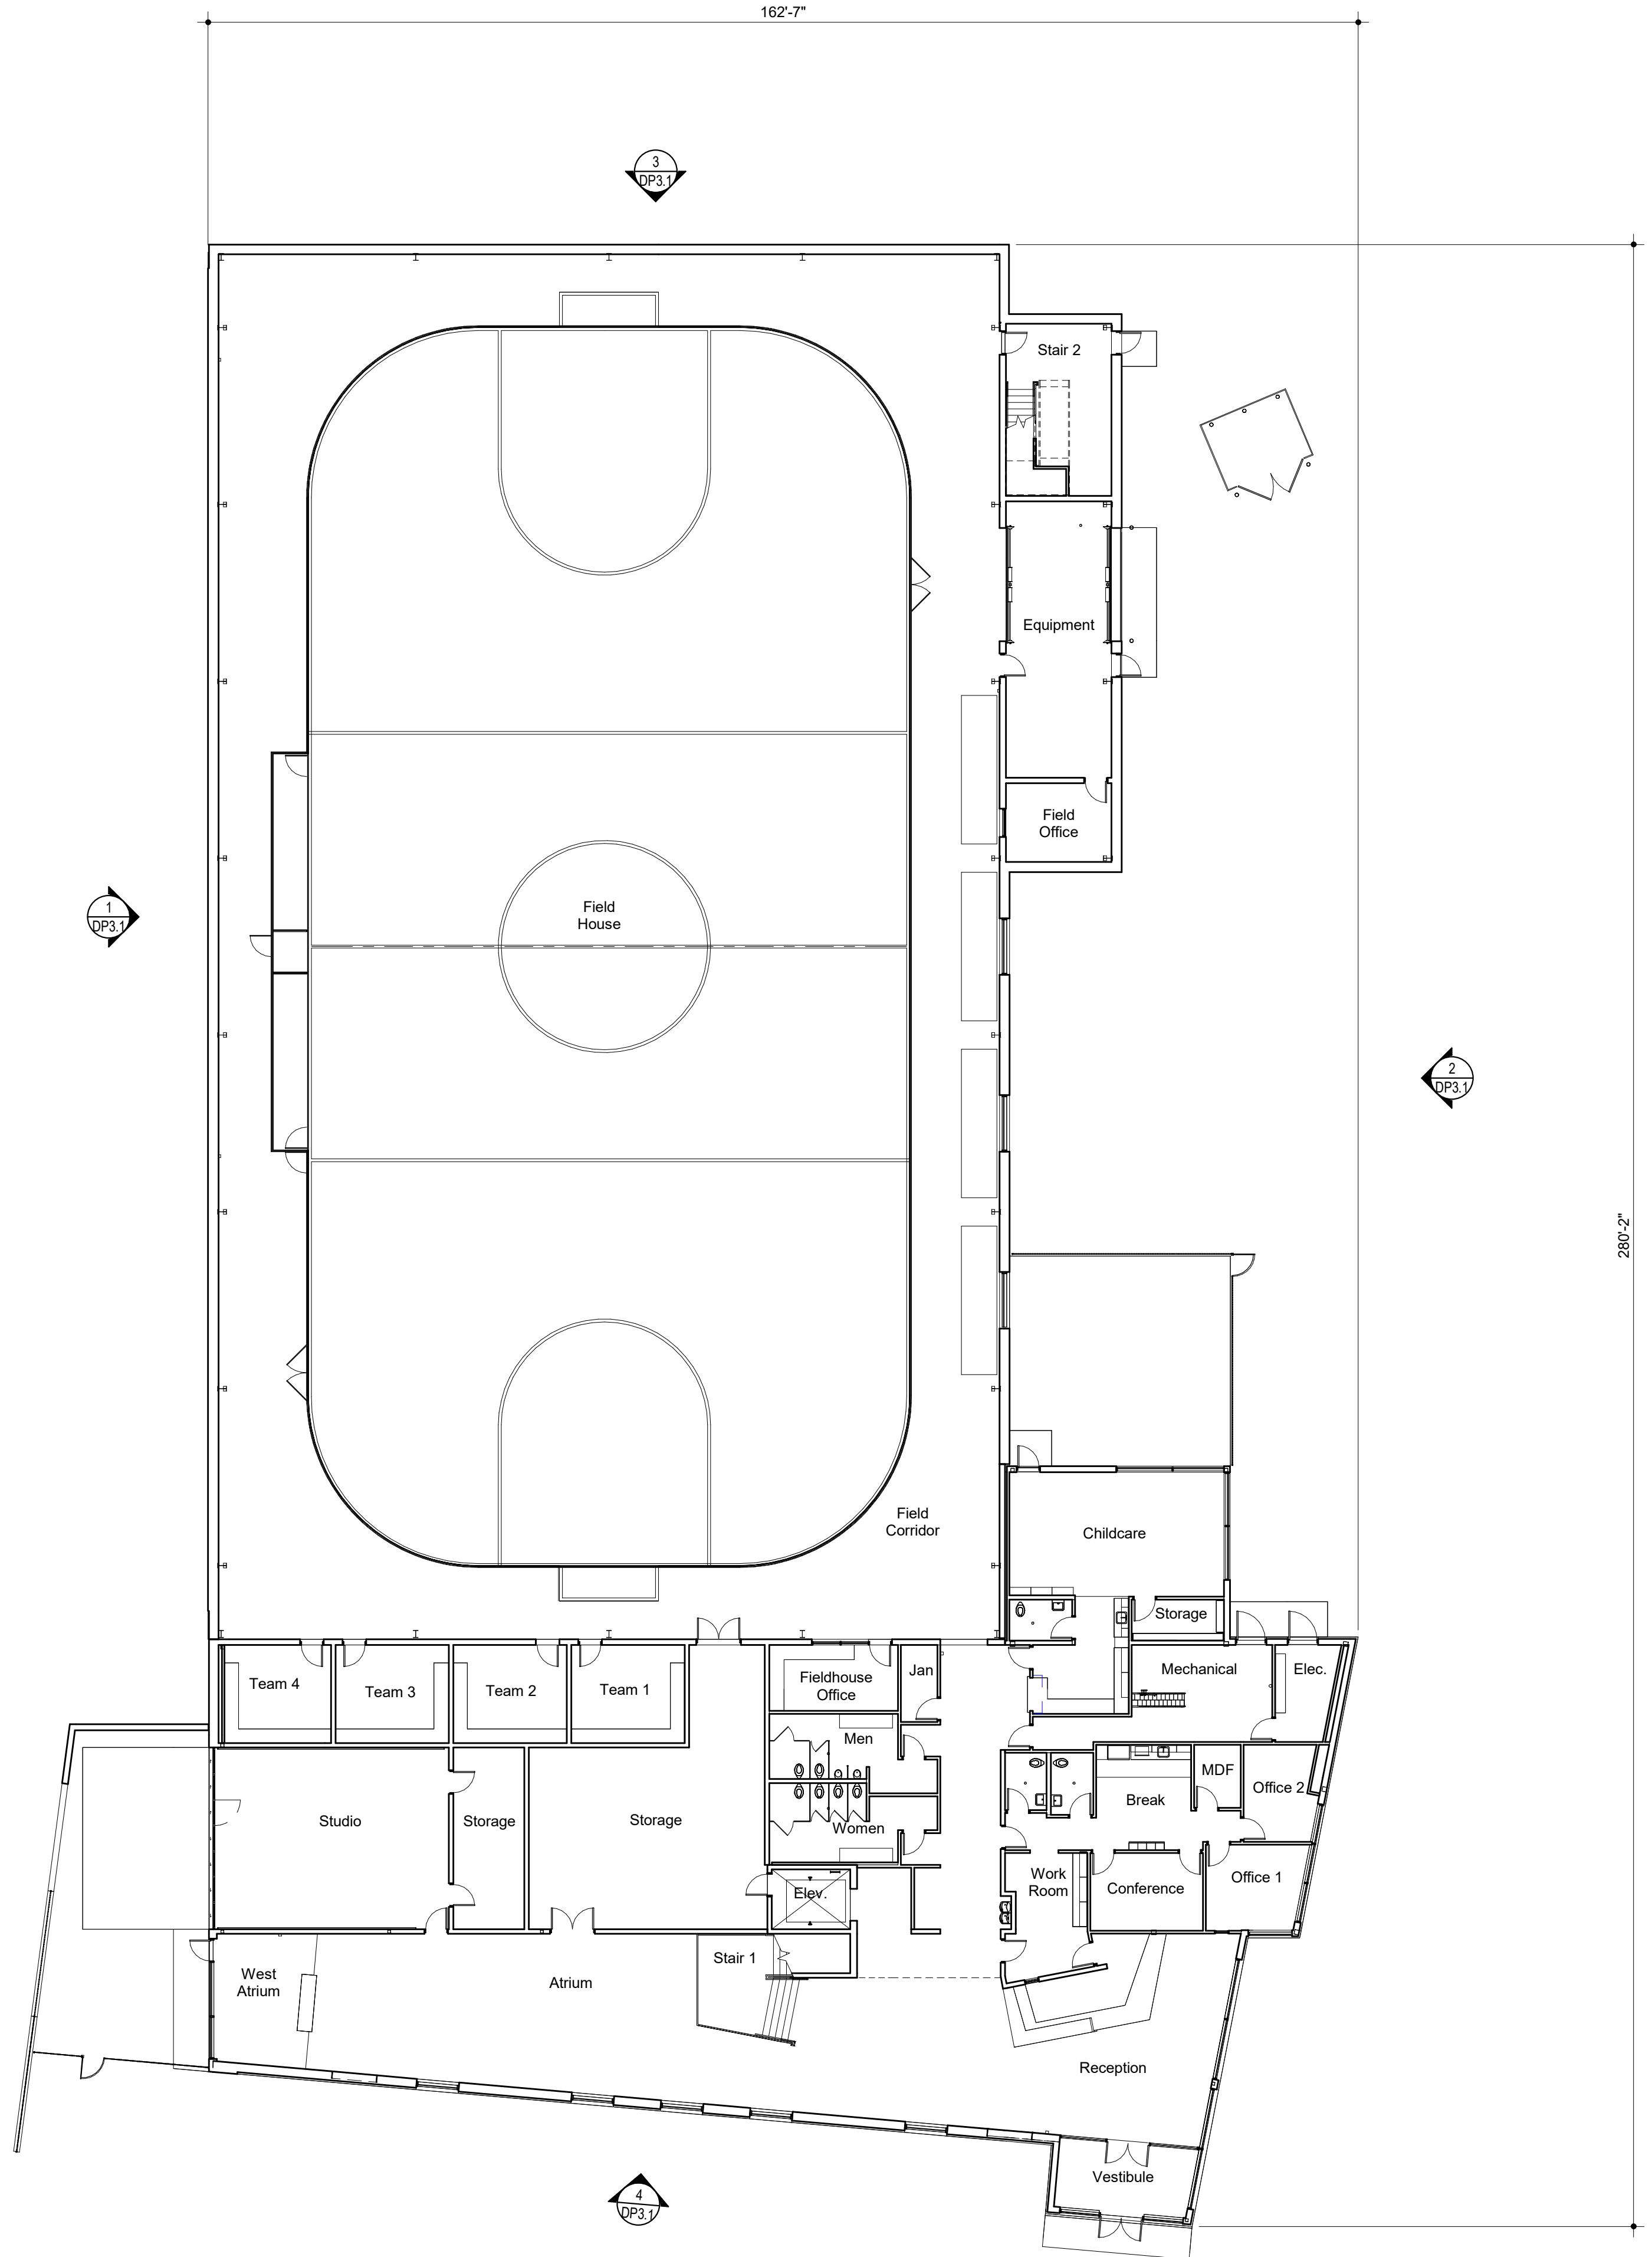

**L K A P A R T N E R S**  
I N C O R P O R A T E D  
A Professional Corporation for Architecture and Planning  
430 North Tejon Street Suite 208  
Colorado Springs Colorado 80903  
tele: 719.473.8446 fax: 719.473.8448  
web: www.lkapartners.com

© Copyright 2024 The LKA Partners, Inc. This document and the information contained herein may not be reproduced or excerpted from without the express written permission of The LKA Partners, Inc. Unauthorized copying, disclosure or construction use are prohibited by copyright law.


**Meridian Ranch Fieldhouse**  
Meridian Service Metro District  
Rainbow Bridge Dr  
Payton, CO 80831

**El Paso County**  
Major Commercial Site  
Development Plan


Drawn: \_\_\_\_\_ SLH  
Checked: \_\_\_\_\_ DKO  
Issued: \_\_\_\_\_ 02/21/24  
Revised: \_\_\_\_\_

Floor Plans

**DP2.2**  
Project No. 23-012  
The LKA Partners Incorporated

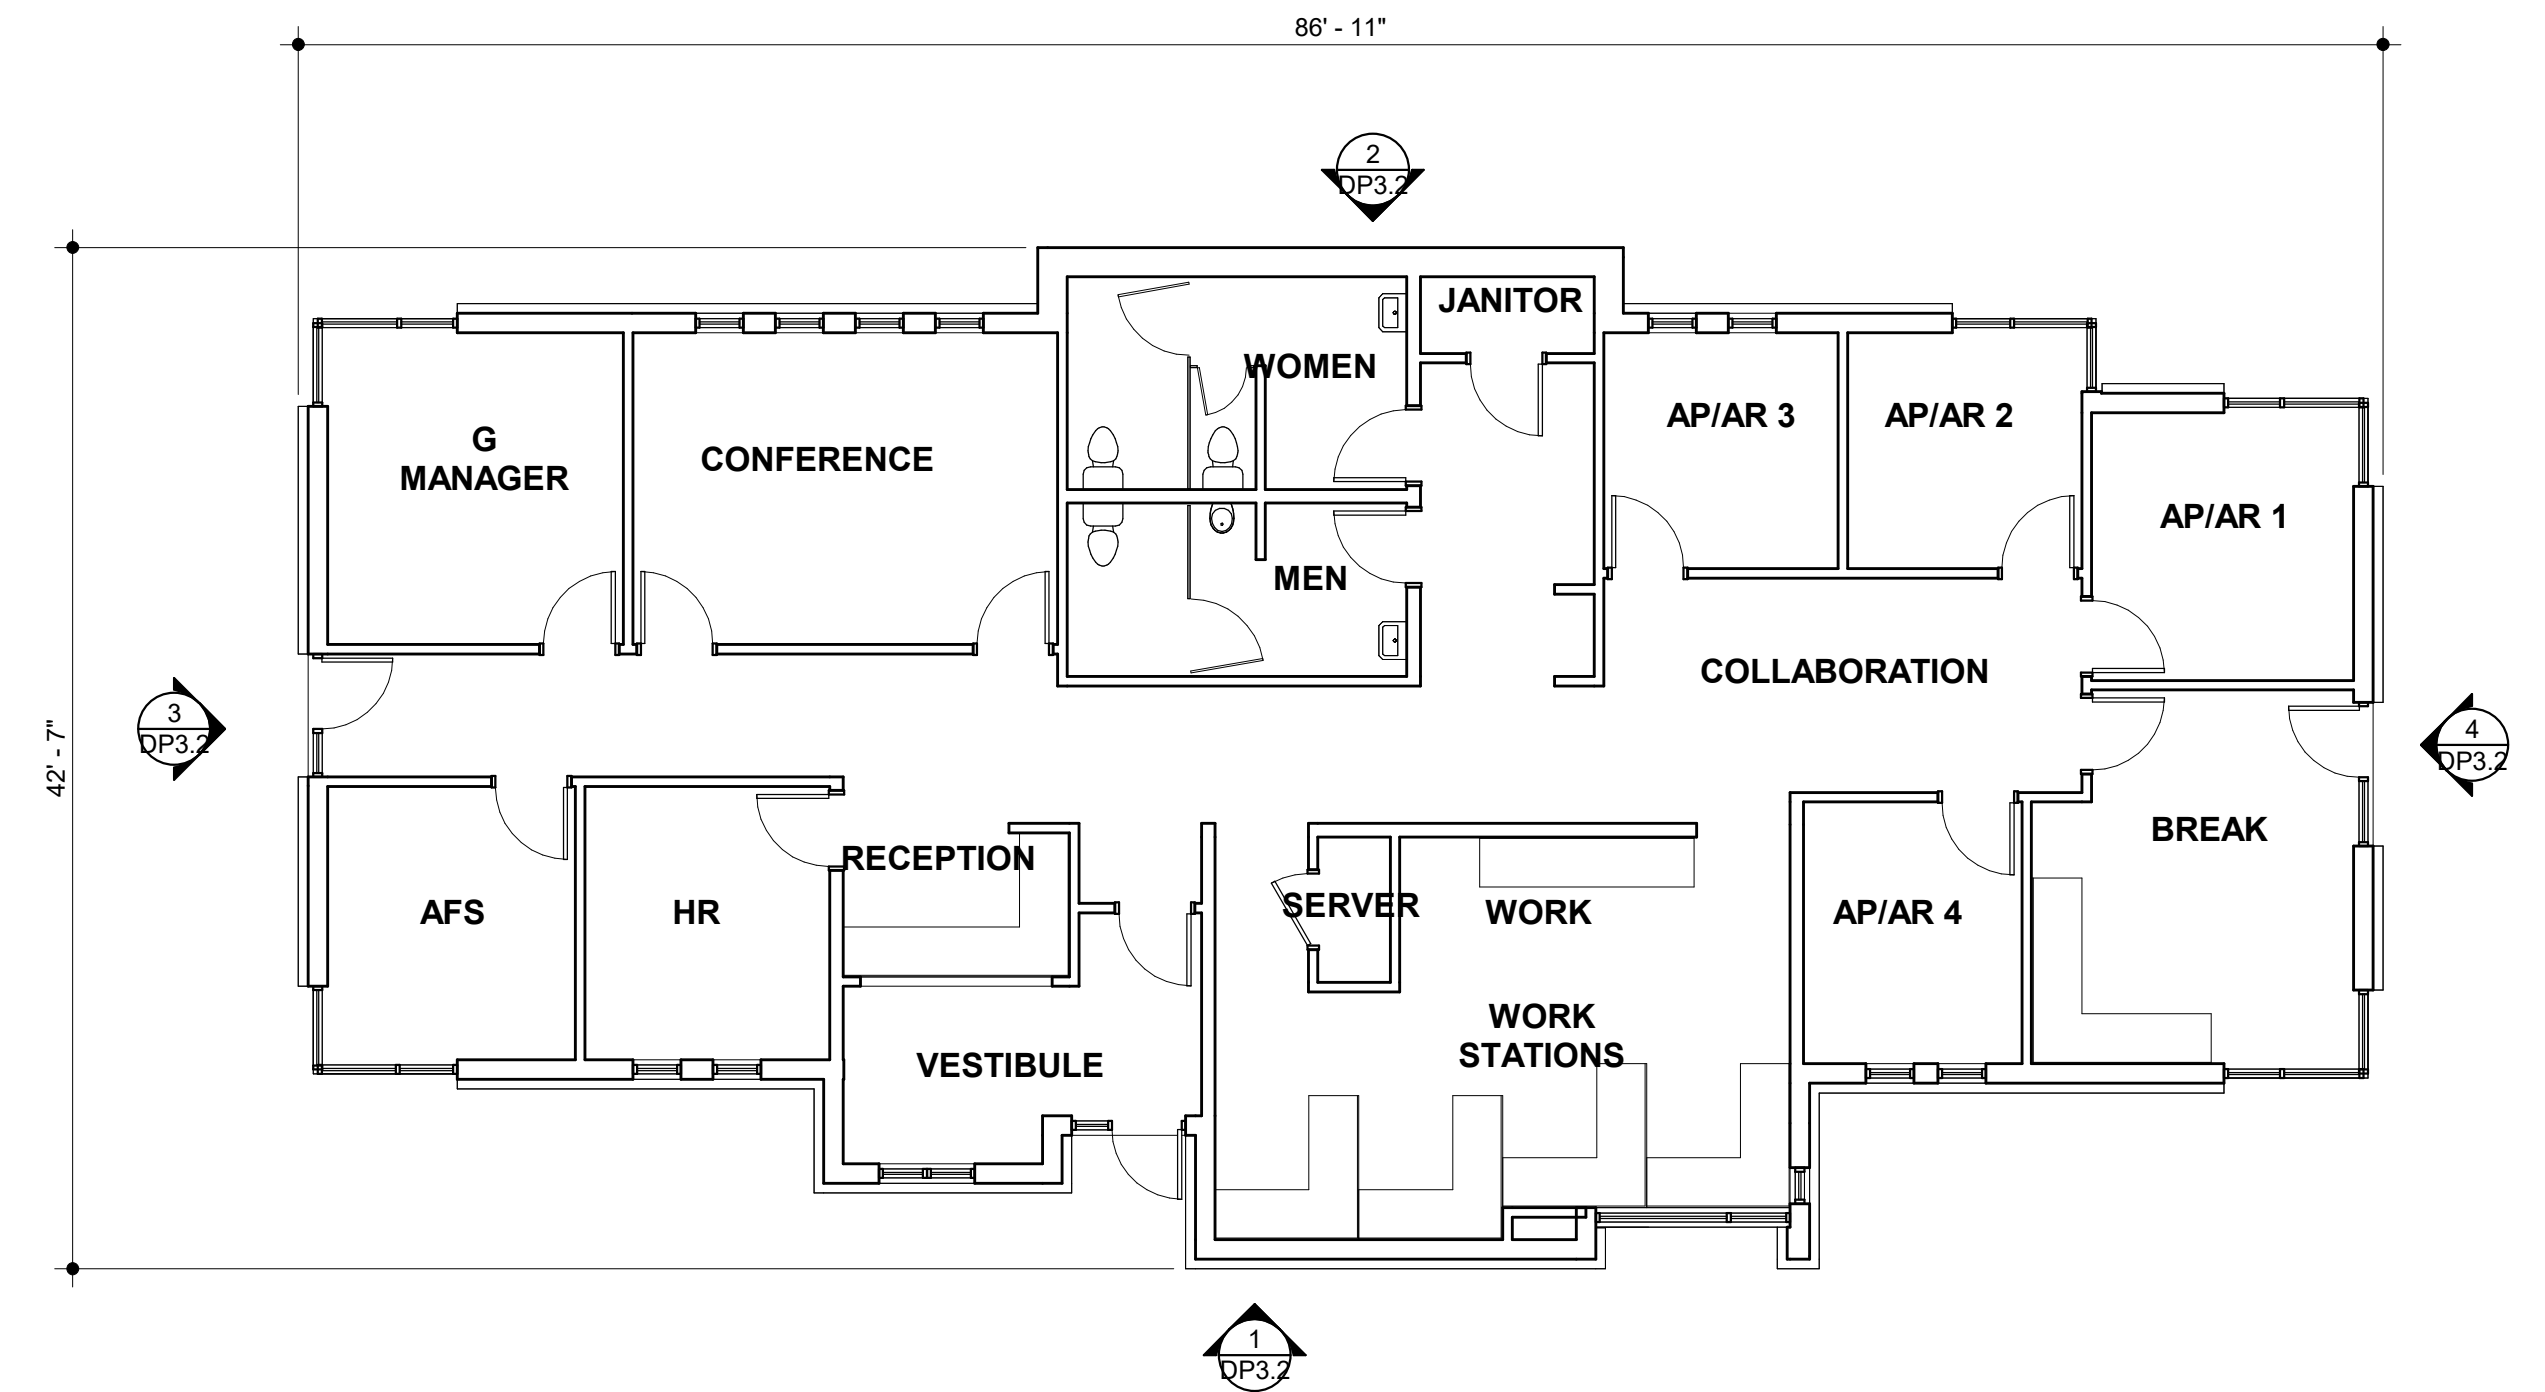

**1** Floor Plan  
Scale: 1/8" = 1'-0"

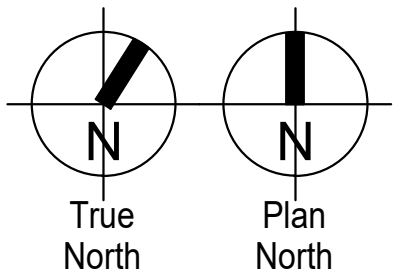

© Copyright 2024 The LKA Partners, Inc. This document and the information contained herein may not be reproduced or excerpted from without the express written permission of The LKA Partners, Inc. Unauthorized copying, disclosure or construction use are prohibited by copyright law.

# Meridian Service Metropolitan District Offices

Meridian Service Metro District  
Rainbow Bridge Dr  
Payton, CO 80831

## El Paso County Major Commercial Site Development Plan

Drawn: SLH  
Checked: DKO  
Issued: 12/31/19  
Revised:

Office Building Plan

**DP2.3**  
Project No. 23-014  
The LKA Partners Incorporated

**L K A P A R T N E R S**  
I N C O R P O R A T E D  
A Professional Corporation for Architecture and Planning  
430 North Tejon Street Suite 208  
Colorado Springs Colorado 80903  
tele: 719.473.8448 fax: 719.473.8448  
web: www.lkapartners.com