
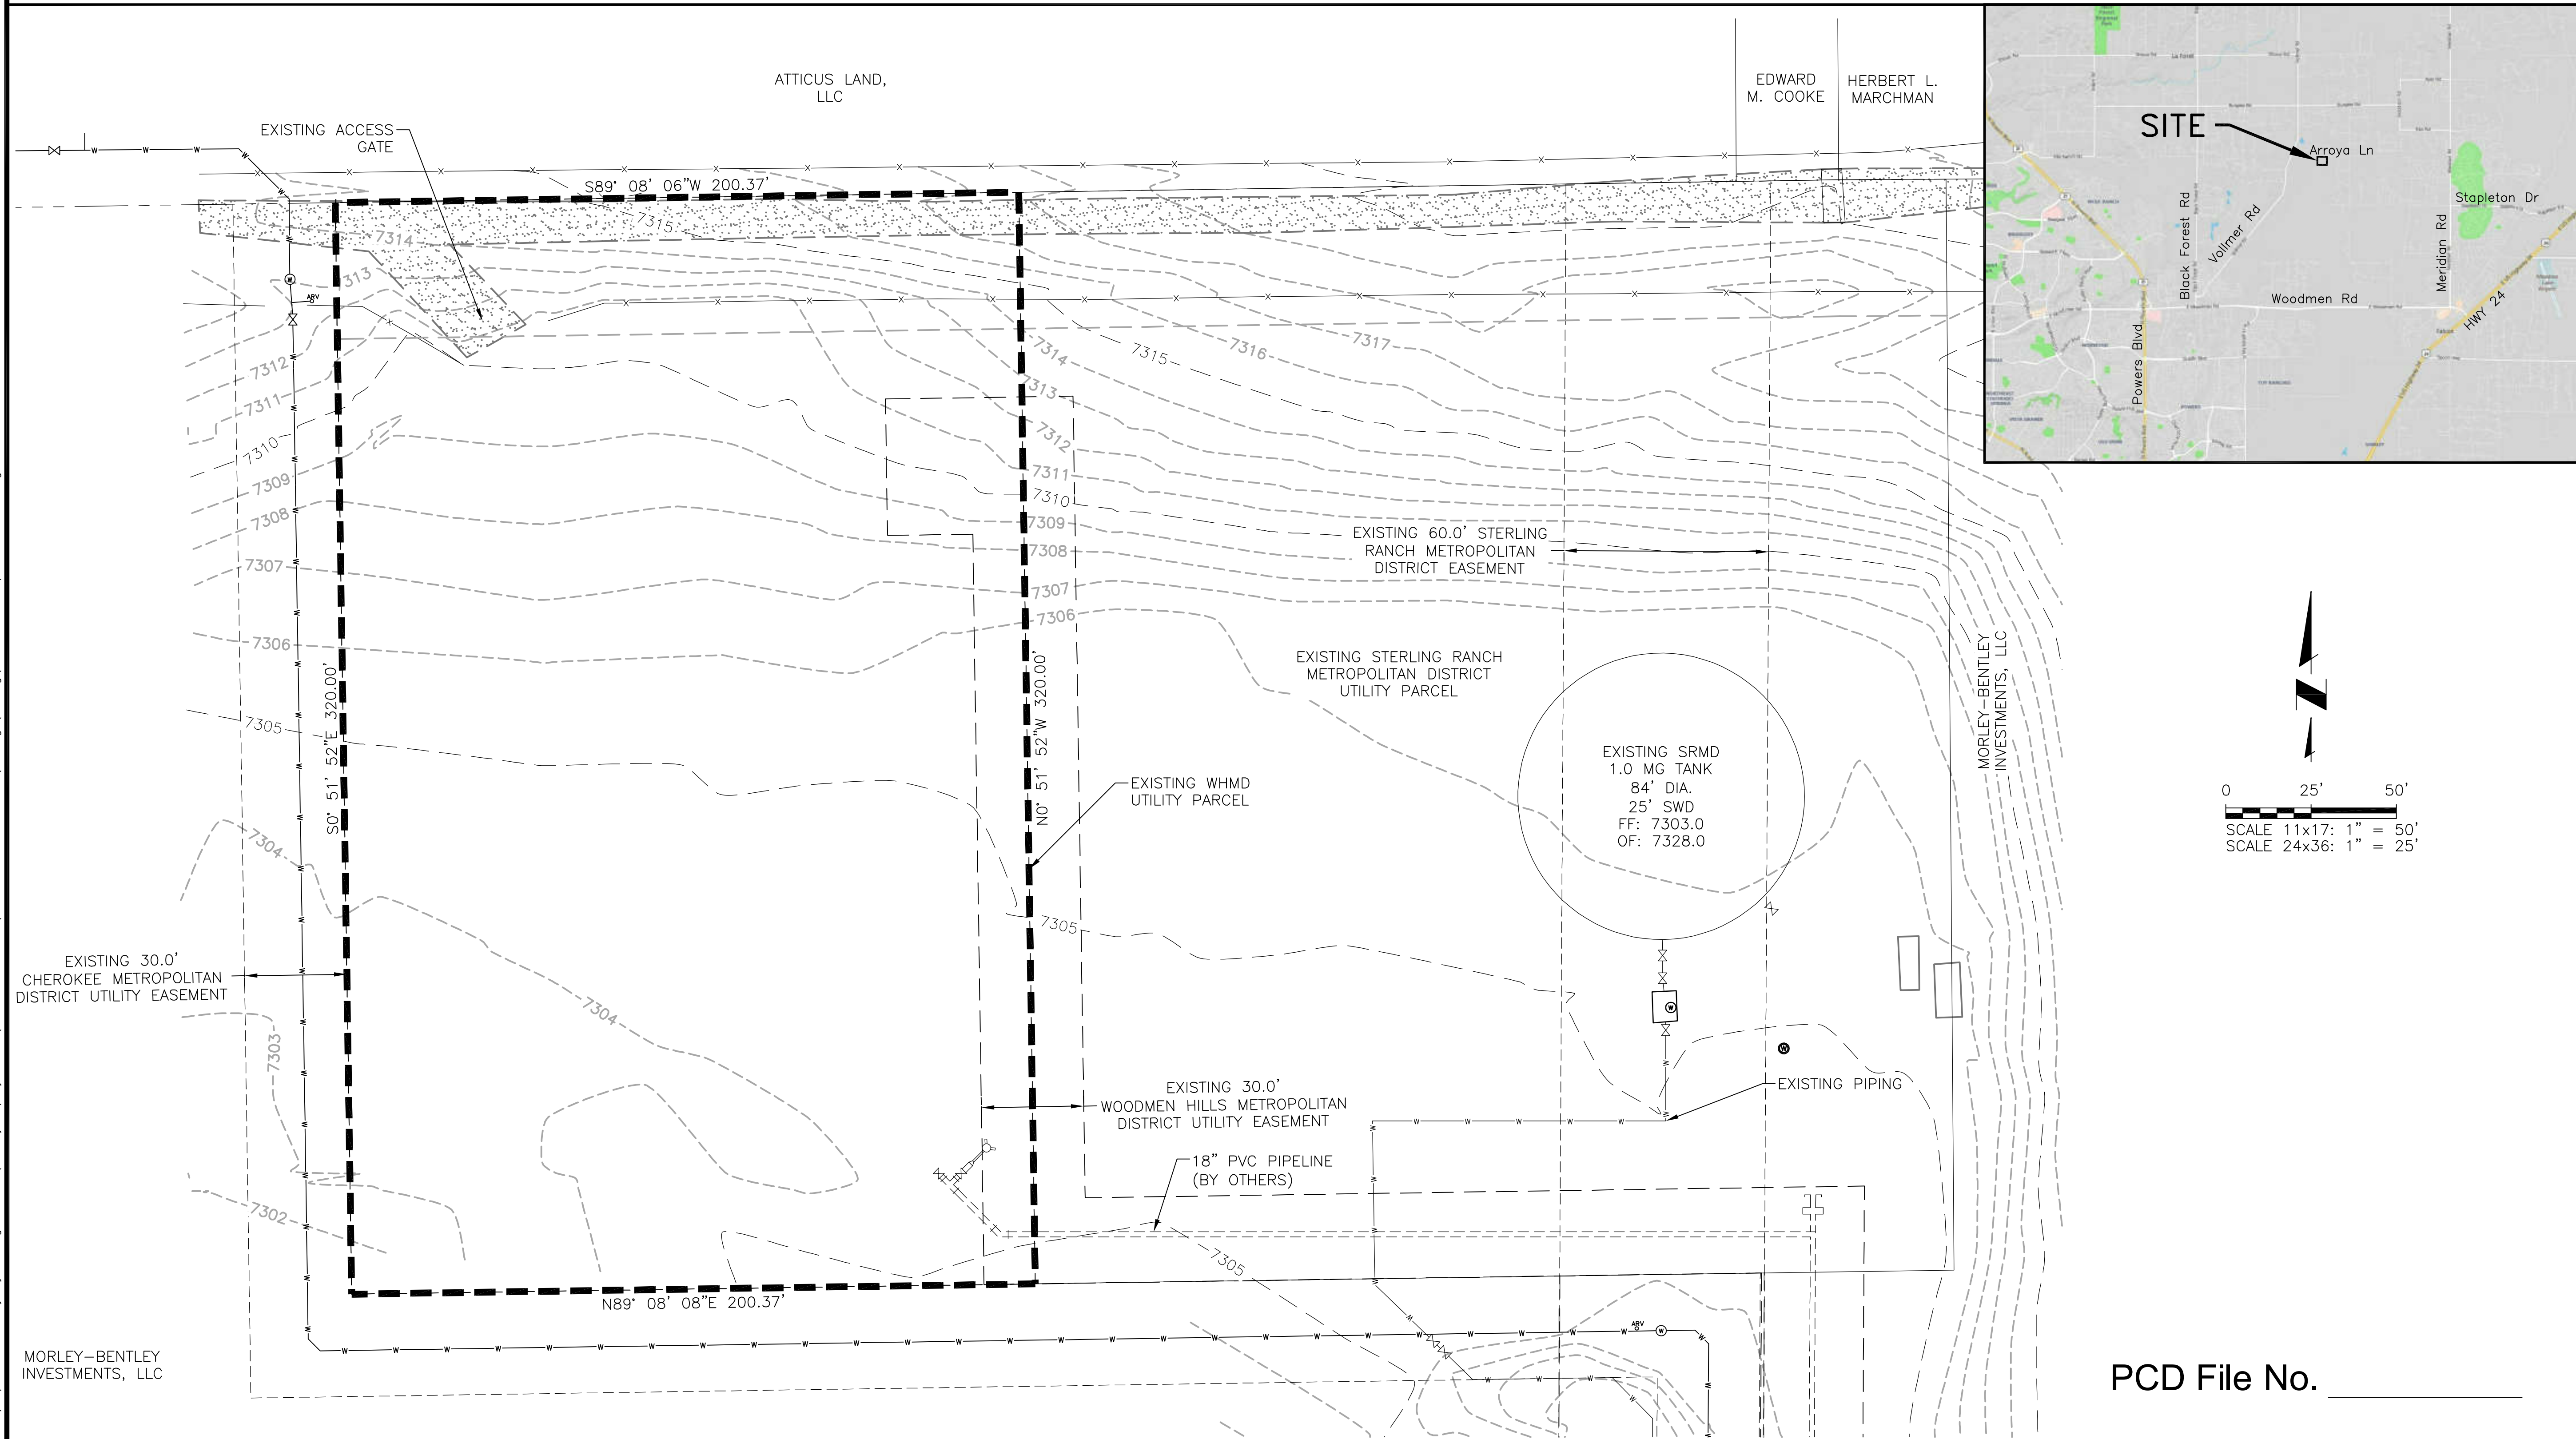
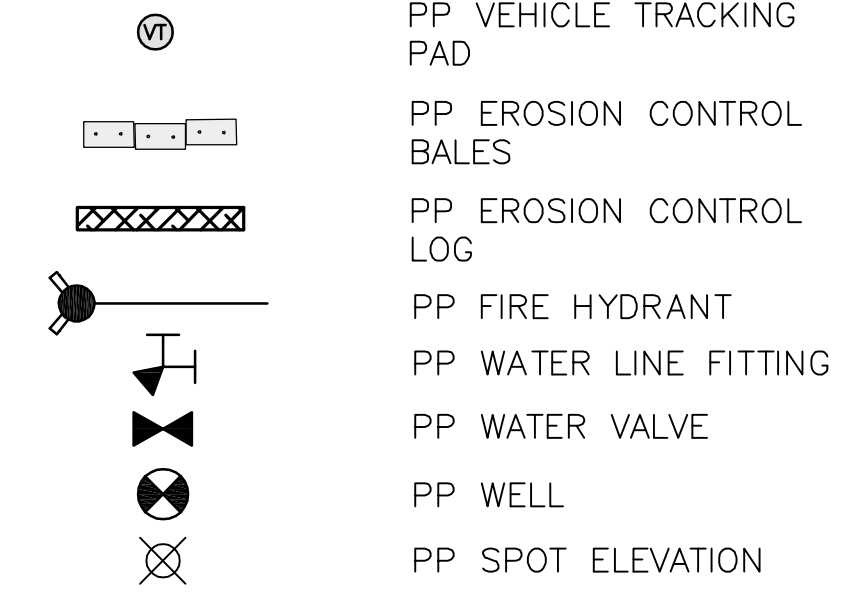
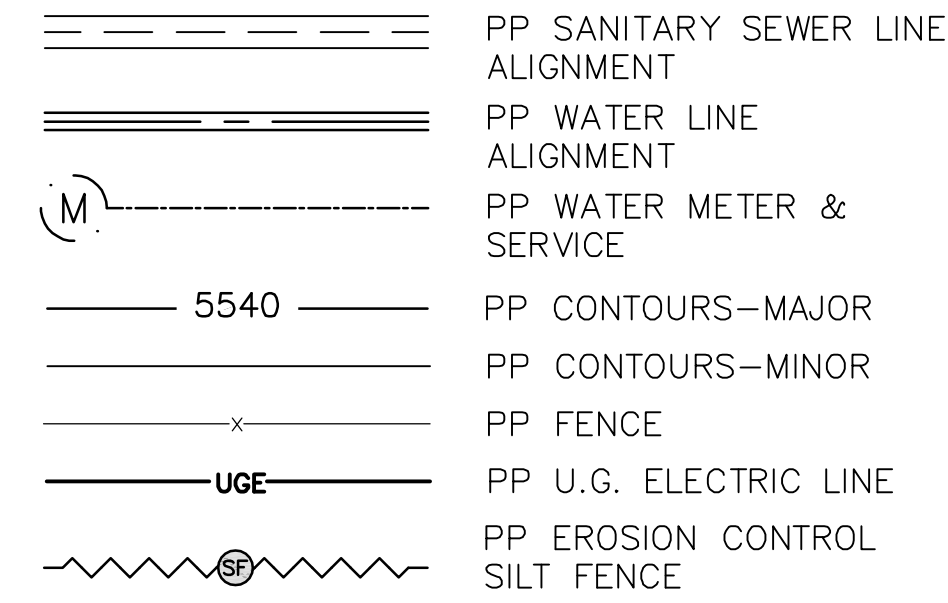
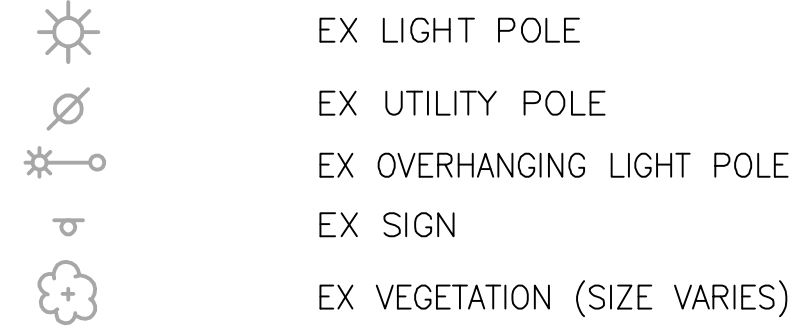
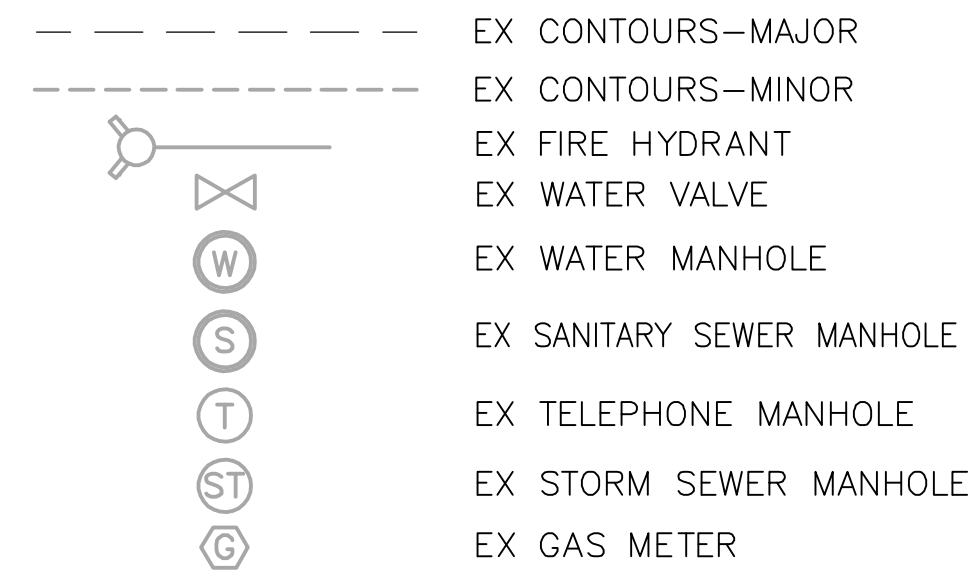


## LEGEND

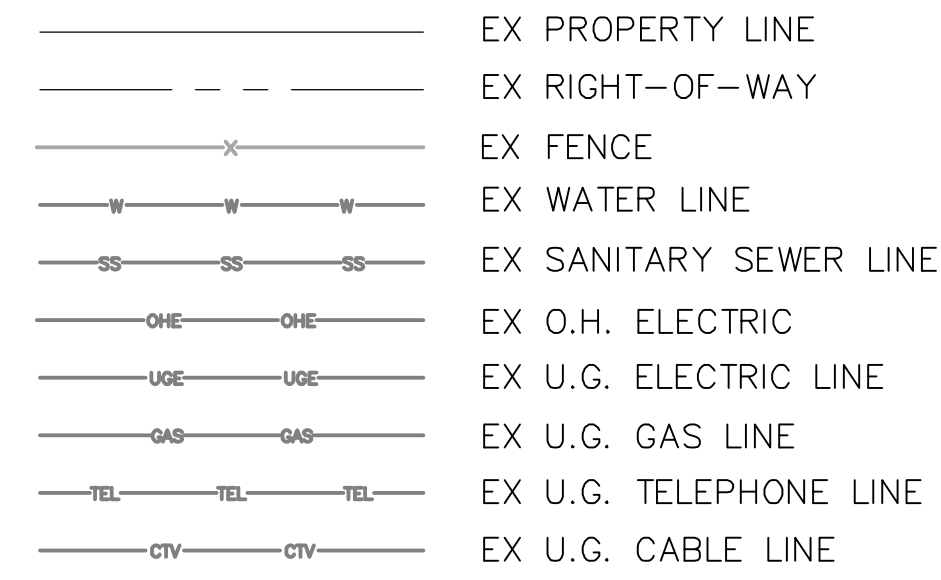

PCD File No.

**JDS-HYDRO**  
CONSULTANTS, INC.  
5540 TECH CENTER DR., SUITE 100  
COLORADO SPRINGS, COLORADO 80919  
(719) 227-0072

WOODMEN HILLS METROPOLITAN DISTRICT  
WEST CONCRETE WATER STORAGE TANK  
EXISTING SITE PLAN

REVIEWS				
NO.	DESCRIPTION	BY	APP.	DATE
1				
2				
3				
4				
5				
6				
7				

[illegible]

Project No.: 112.112
Date: 04/24/20
Design: RMM
Drawn: RMM
Check: JPM

C1  
SHEET 2 OF 28

J:\JDS-Hydro\Project\_Files\112 Woodmen Hills\112.112 West Water Tank\Drawings\Working\112112\_TcBuild\112112\_1\_Civil.dwg  
2020/04/28 1:01 PM By: Ryan Mangino

LEGEND



- EX PROPERTY LINE  
EX RIGHT-OF-WAY  
EX FENCE  
EX WATER LINE  
EX SANITARY SEWER LINE  
EX O.H. ELECTRIC  
EX U.G. ELECTRIC LINE  
EX U.G. GAS LINE  
EX U.G. TELEPHONE LINE  
EX U.G. CABLE LINE

- EX CONTOURS-MAJOR  
EX CONTOURS-MINOR  
EX FIRE HYDRANT  
EX WATER VALVE  
EX WATER MANHOLE  
EX SANITARY SEWER MANHOLE  
EX TELEPHONE MANHOLE  
EX STORM SEWER MANHOLE  
EX GAS METER

- EX LIGHT POLE  
EX UTILITY POLE  
EX OVERHANGING LIGHT POLE  
EX SIGN  
EX VEGETATION (SIZE VARIES)

- PP SANITARY SEWER LINE ALIGNMENT  
PP WATER LINE ALIGNMENT  
PP WATER METER & SERVICE  
PP CONTOURS-MAJOR  
PP CONTOURS-MINOR  
PP FENCE  
PP U.G. ELECTRIC LINE  
PP EROSION CONTROL SILT FENCE

- PP VEHICLE TRACKING PAD  
PP EROSION CONTROL BALES  
PP EROSION CONTROL LOG  
PP FIRE HYDRANT  
PP WATER LINE FITTING  
PP WATER VALVE  
PP WELL  
PP SPOT ELEVATION

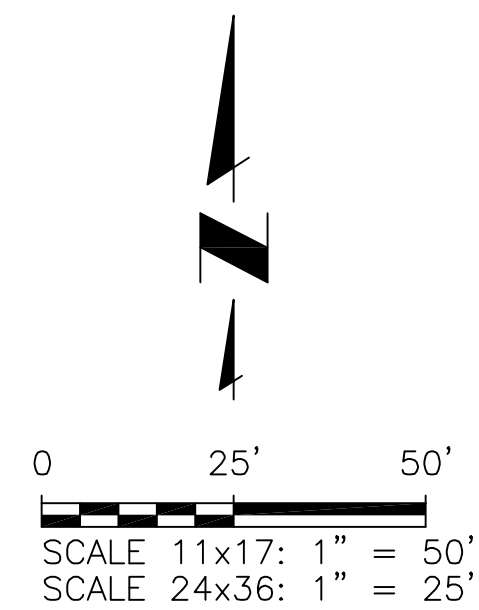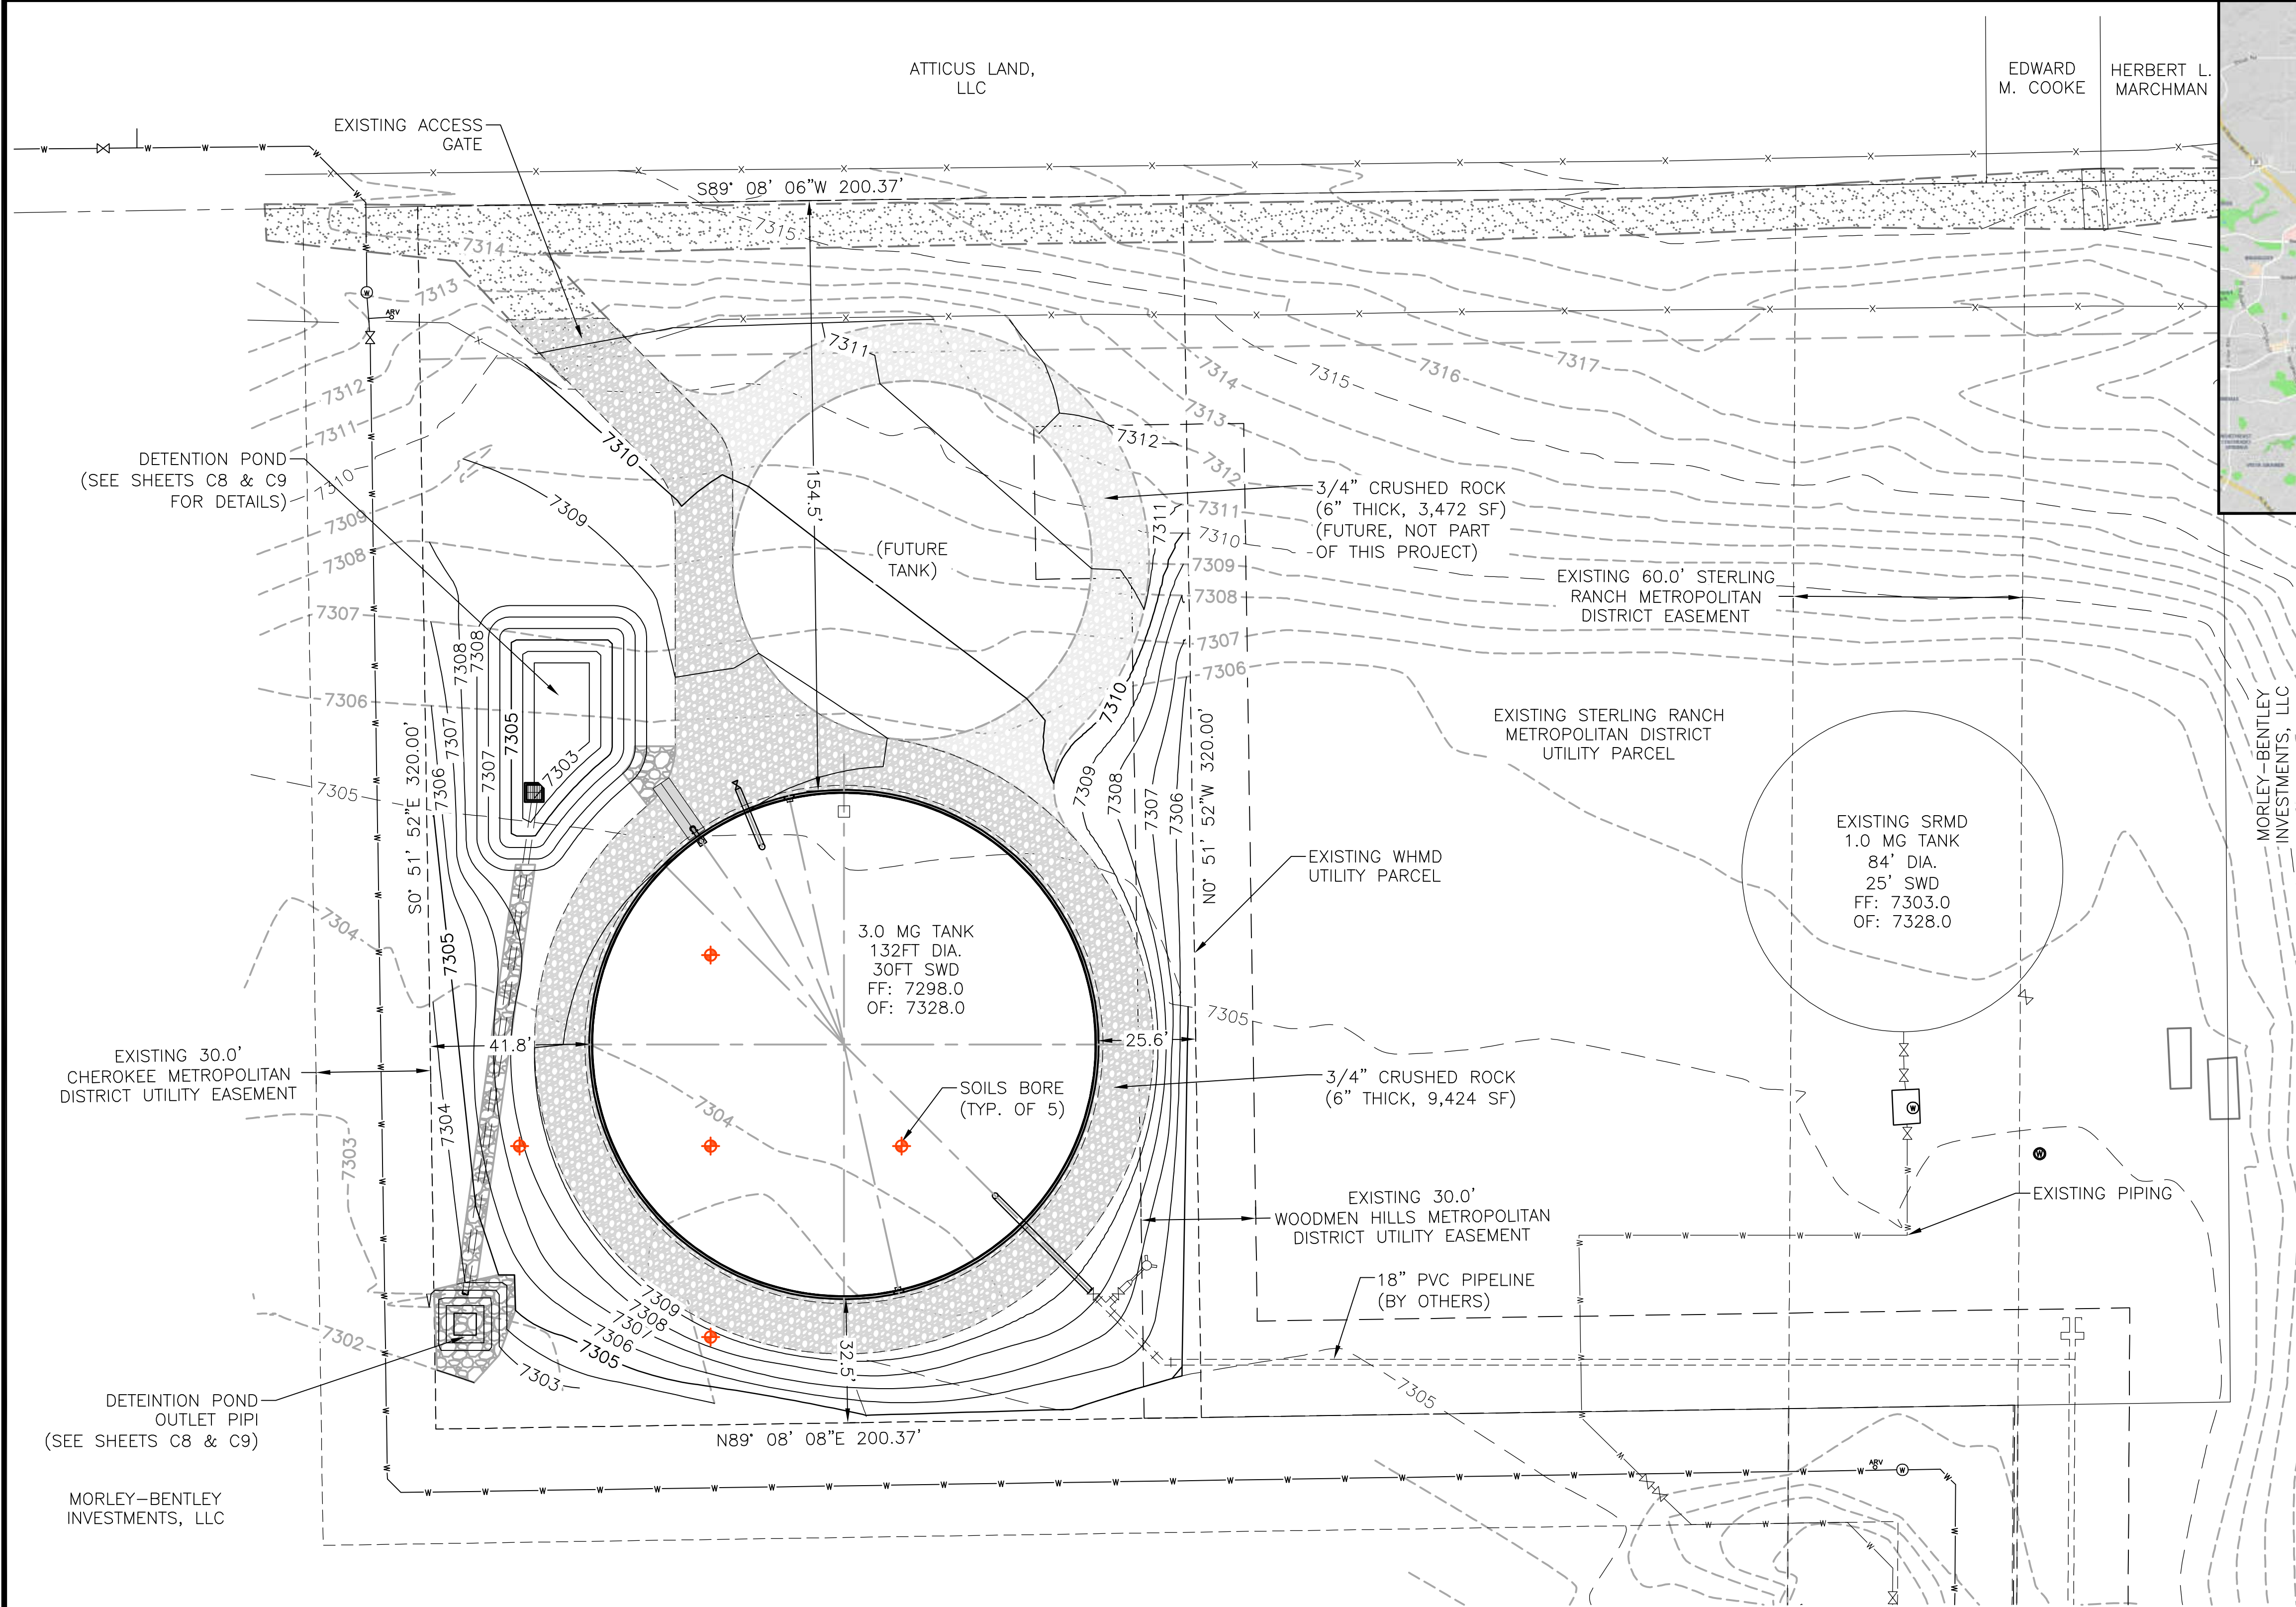

PCD File No. \_\_\_\_\_

**JDS-HYDRO** CONSULTANTS, INC.  
5540 TECH CENTER DR., SUITE 100  
COLORADO SPRINGS, COLORADO 80919  
(719) 227-0072

**WOODMEN HILLS METROPOLITAN DISTRICT**  
WEST CONCRETE WATER STORAGE TANK  
PROPOSED SITE PLAN

REVISIONS			
NO.	DESCRIPTION	BY	DATE
1			
2			
3			
4			
5			
6			
7			

100% DESIGN  
DRAWINGS

Project No.: 112.112  
Date: 04/24/20  
Design: RMM  
Drawn: RMM  
Check: JPM

C2  
SHEET 3 OF 28

