



ISSUE RECORD		
DATE	REV.	DESCRIPTION
12/24/2023		ENTITLEMENT SET

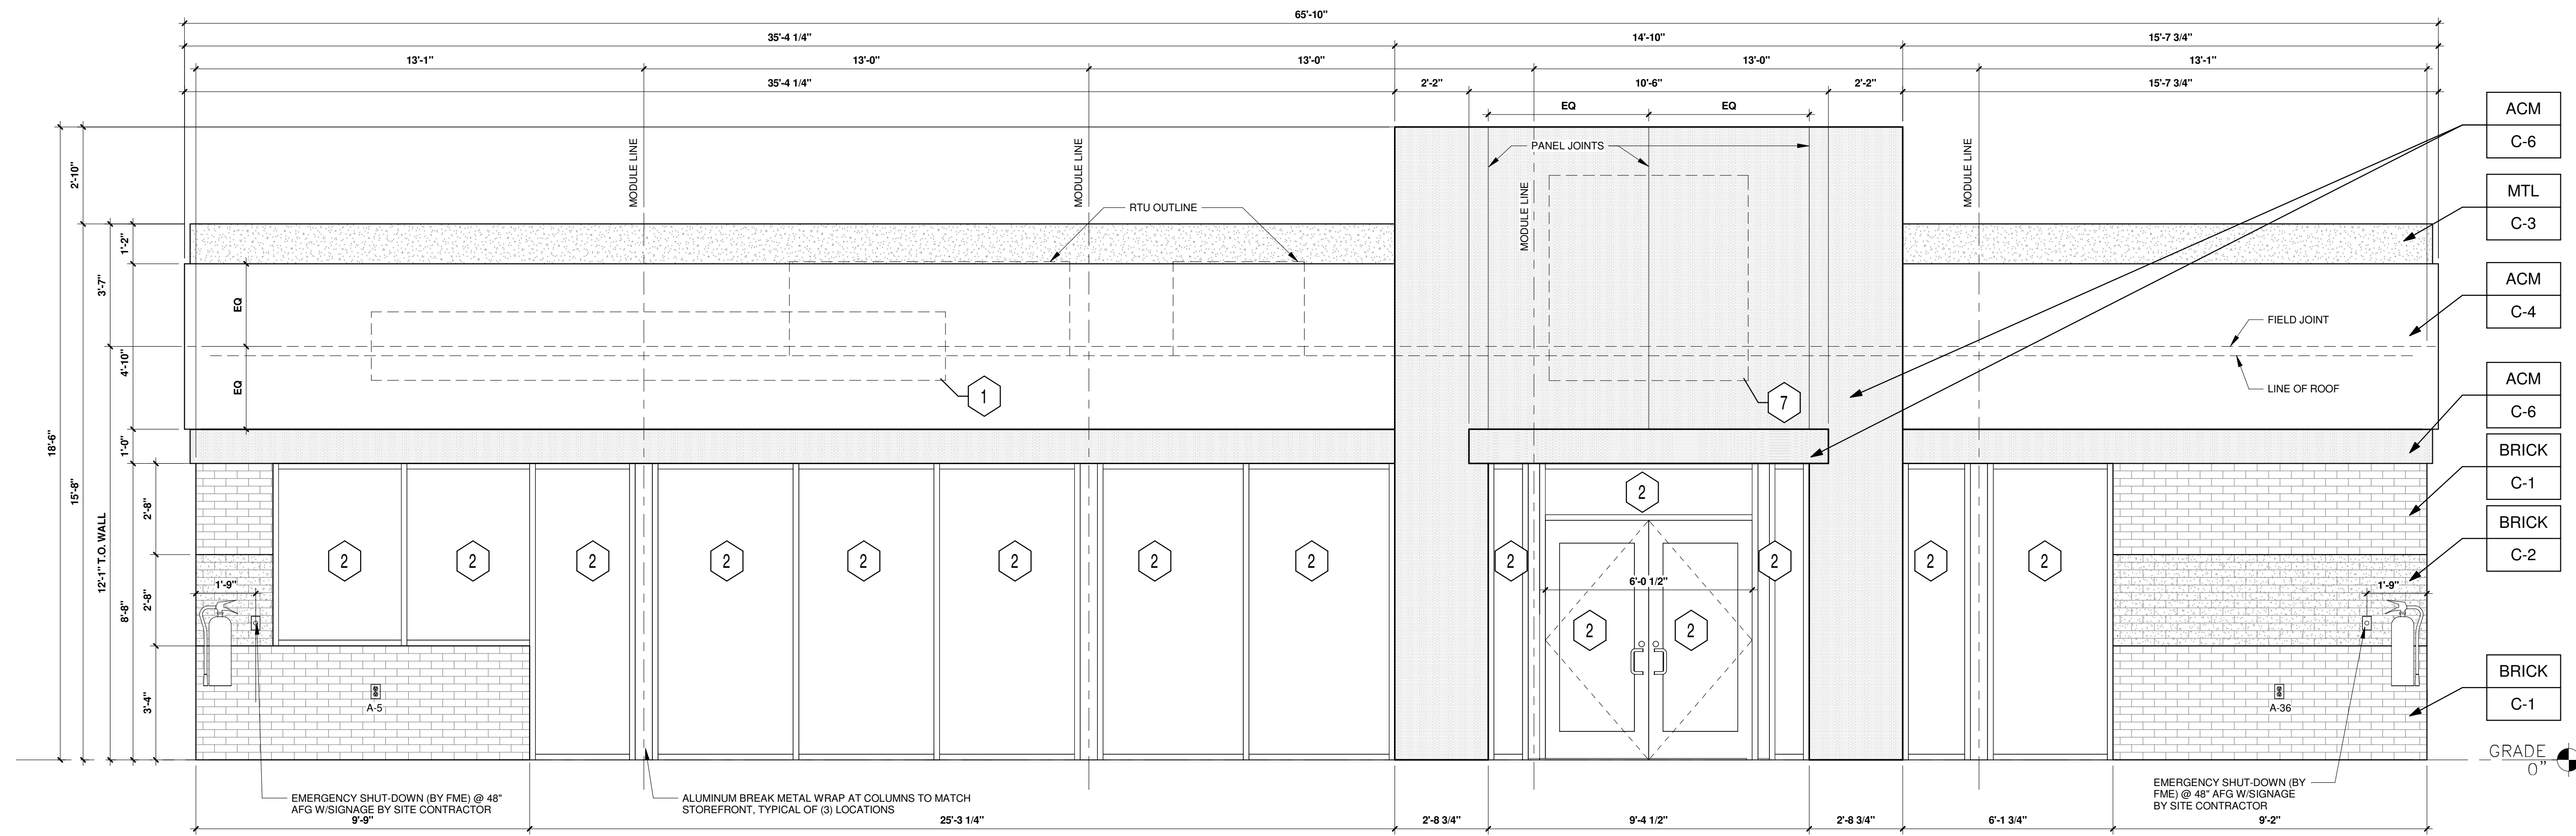

1 NORTH ELEVATION
3/8" = 1'-0"

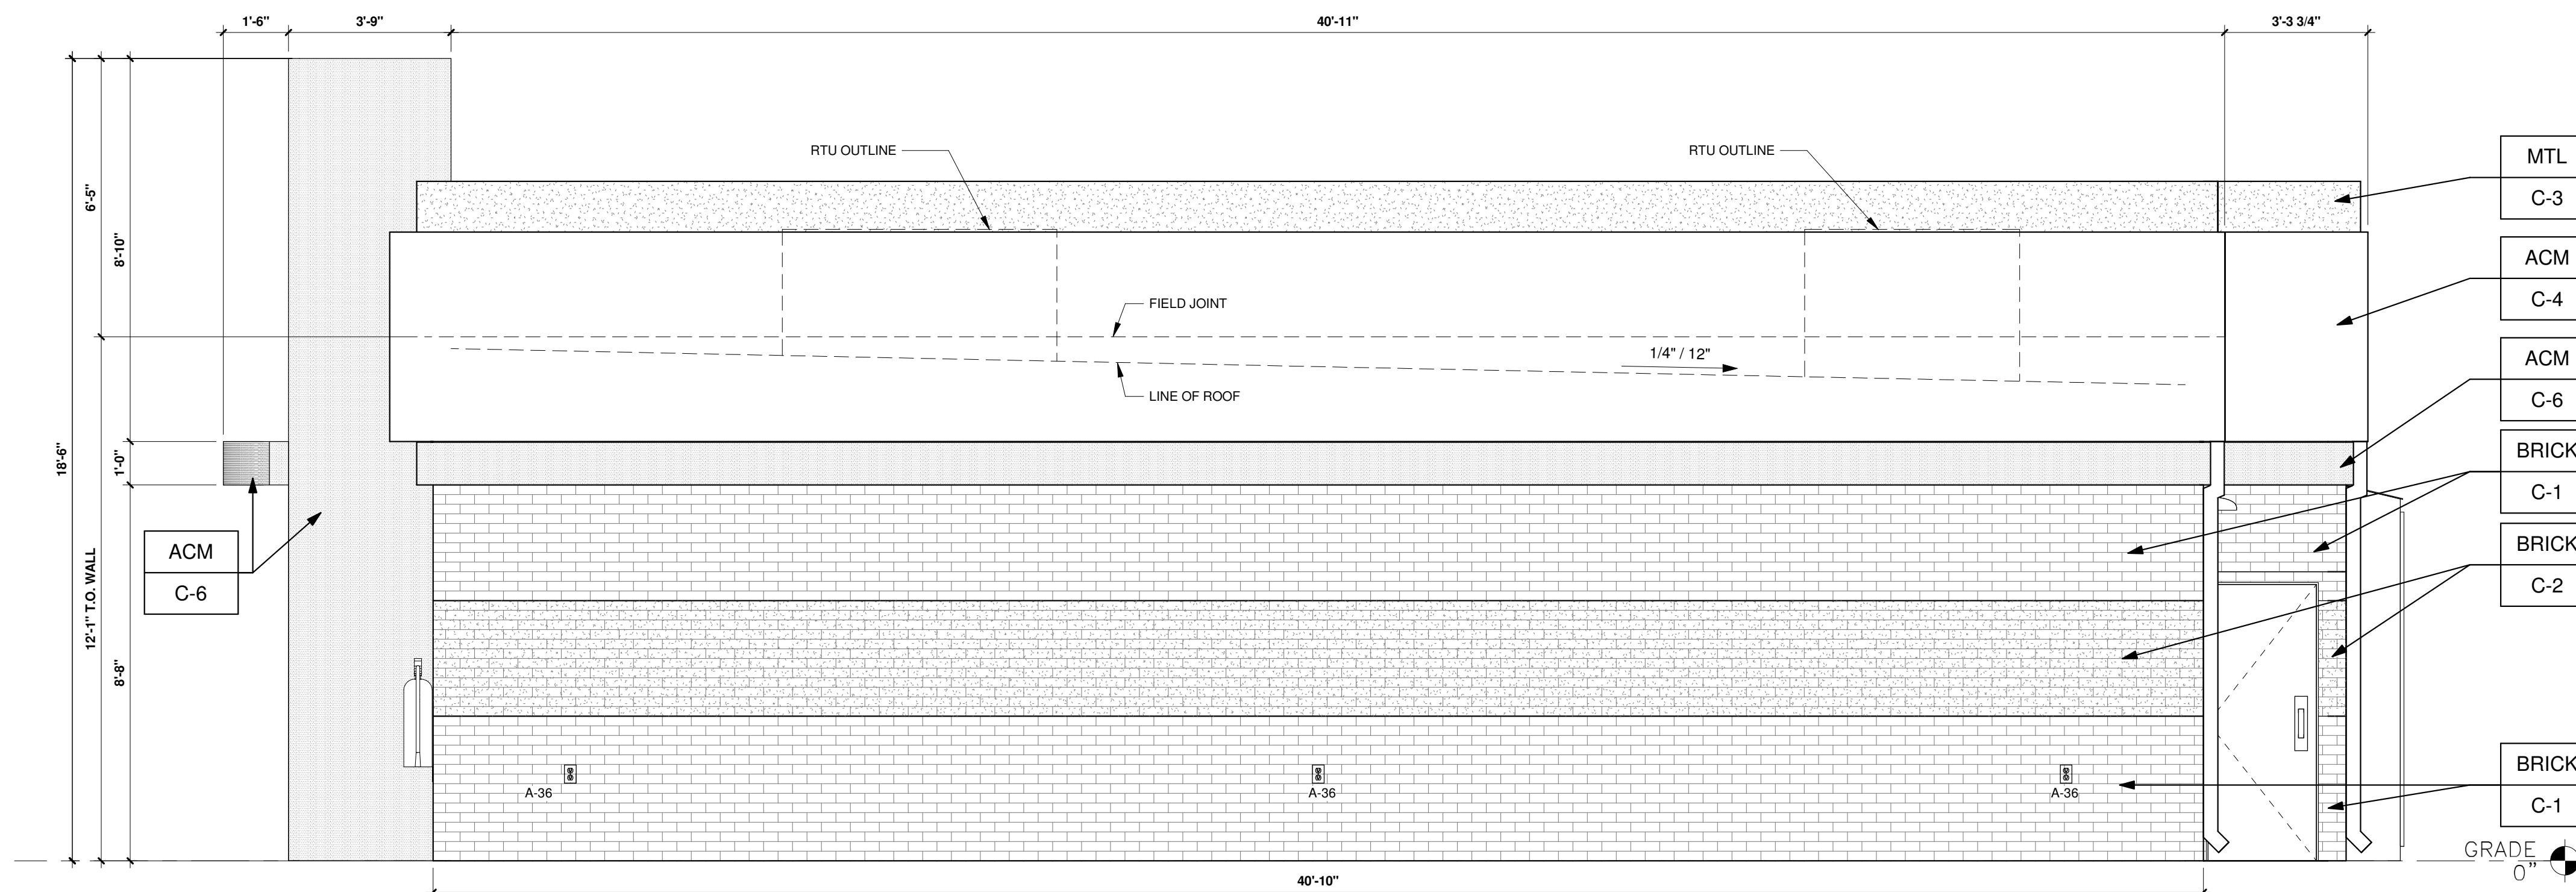

2 WEST ELEVATION
3/8" = 1'-0"

KEYED NOTES:

- 1 ROUTED LETTER LOGO SIGNAGE ————— BY FMS
- 2 CLEAR ANODIZED ALUMINUM STOREFRONT SYSTEM ————— C-7
KAWNEER, YKK OR EQUAL
- 3 EXTERIOR LIGHTING, REFER TO LIGHTING PLAN ————— SHEET EL2
- 4 4" x 4" PAINTED METAL DOWNSPOUTS ————— C-3
- 5 DOORS (EXTERIOR SIDE) AND DOOR FRAMES PAINTED ————— C-3
- 6 OPEN —————
- 7 MURPHY STAR LOGO SIGNAGE ————— BY SIGN CONTRACTOR

EXTERIOR FINISHES:

- ACM ACM (3MM THICKNESS) ————— BY FMS
- BRICK THIN BRICK ————— BY FMS
- MTL 20 GA. SHEET METAL (UNLESS NOTED OTHERWISE) ————— BY FMS

EXTERIOR PAINT/COLORS:

- C-1 THIN BRICK VENEER - LIGHT SANDSTONE VELOUR BY ENDICOTT (WIRE CUT FINISH) WITH ENDURA MAX PREBLENDED GREY COLOR GROUT ————— BY FMS
- C-2 THIN BRICK VENEER - IVORY BLEND VELOUR BY ENDICOTT (WIRE CUT FINISH) WITH ENDURA MAX PREBLENDED GREY COLOR GROUT ————— BY FMS
- C-3 'DORMER BROWN' SW #7521 ————— BY FMS
- C-4 REYNOBOND #4 NATURAL BRUSHED ALUMINUM BY ARCONIC ————— BY FMS
- C-5 OPEN —————
- C-6 'PROGRAM RED' BY ALPOLIC ————— BY FMS
- C-7 CLEAR ANODIZED ALUMINUM STOREFRONT ————— BY FMS

PROFESSIONAL SEAL

PROFESSIONAL IN CHARGE

SCOTT LOIKITS

PROJECT MANAGER

RASHMIKA PATEL

QUALITY CONTROL

CHRIS CERBO

DRAWN BY

SS

PROJECT NAME

MURPHY USA

MURPHY OIL CONVENIENCE STORE

MERIDIAN RD & EASTONVILLE RD, FALCON COLORADO 80831

FREY MOSS STRUCTURE

1801 Rockdale Industrial Blvd.
Conyers, Georgia 30012
Voice: (800) 366-6385
Fax: (770) 483-6037

FMS JOB NUMBER
GXXMXXXXXX
FMS MODEL NUMBER
XXXXXX

PROJECT NUMBER
20230059.5

SHEET TITLE


ARCHITECTURAL ELEVATIONS (BUILDING)

SHEET NUMBER


01

PROTO V3.1 03/01/2023
2800 SQ. FT. BUILDING

ISSUE RECORD	
DATE	REV. DESCRIPTION
12/28/2023	ENTITLEMENT SET

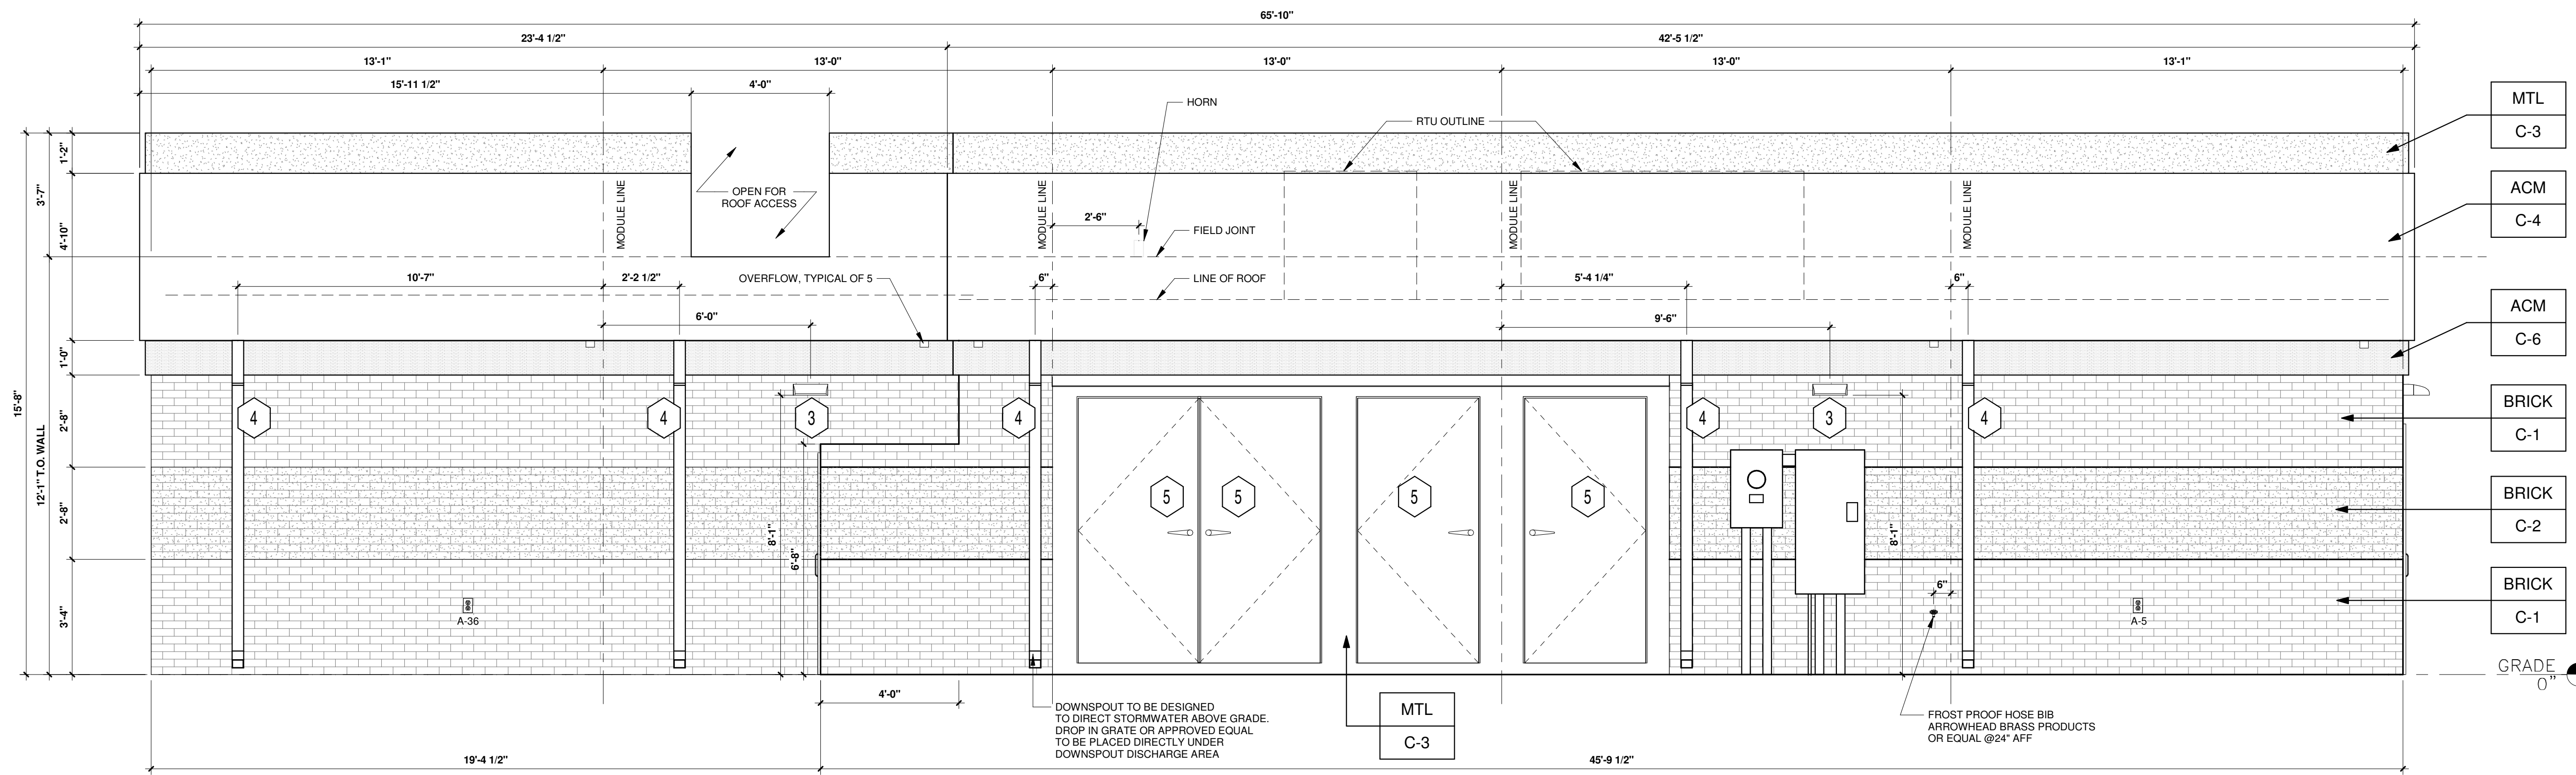

3 SOUTH ELEVATION - EASTONVILLE ROAD
3/8" = 1'-0"

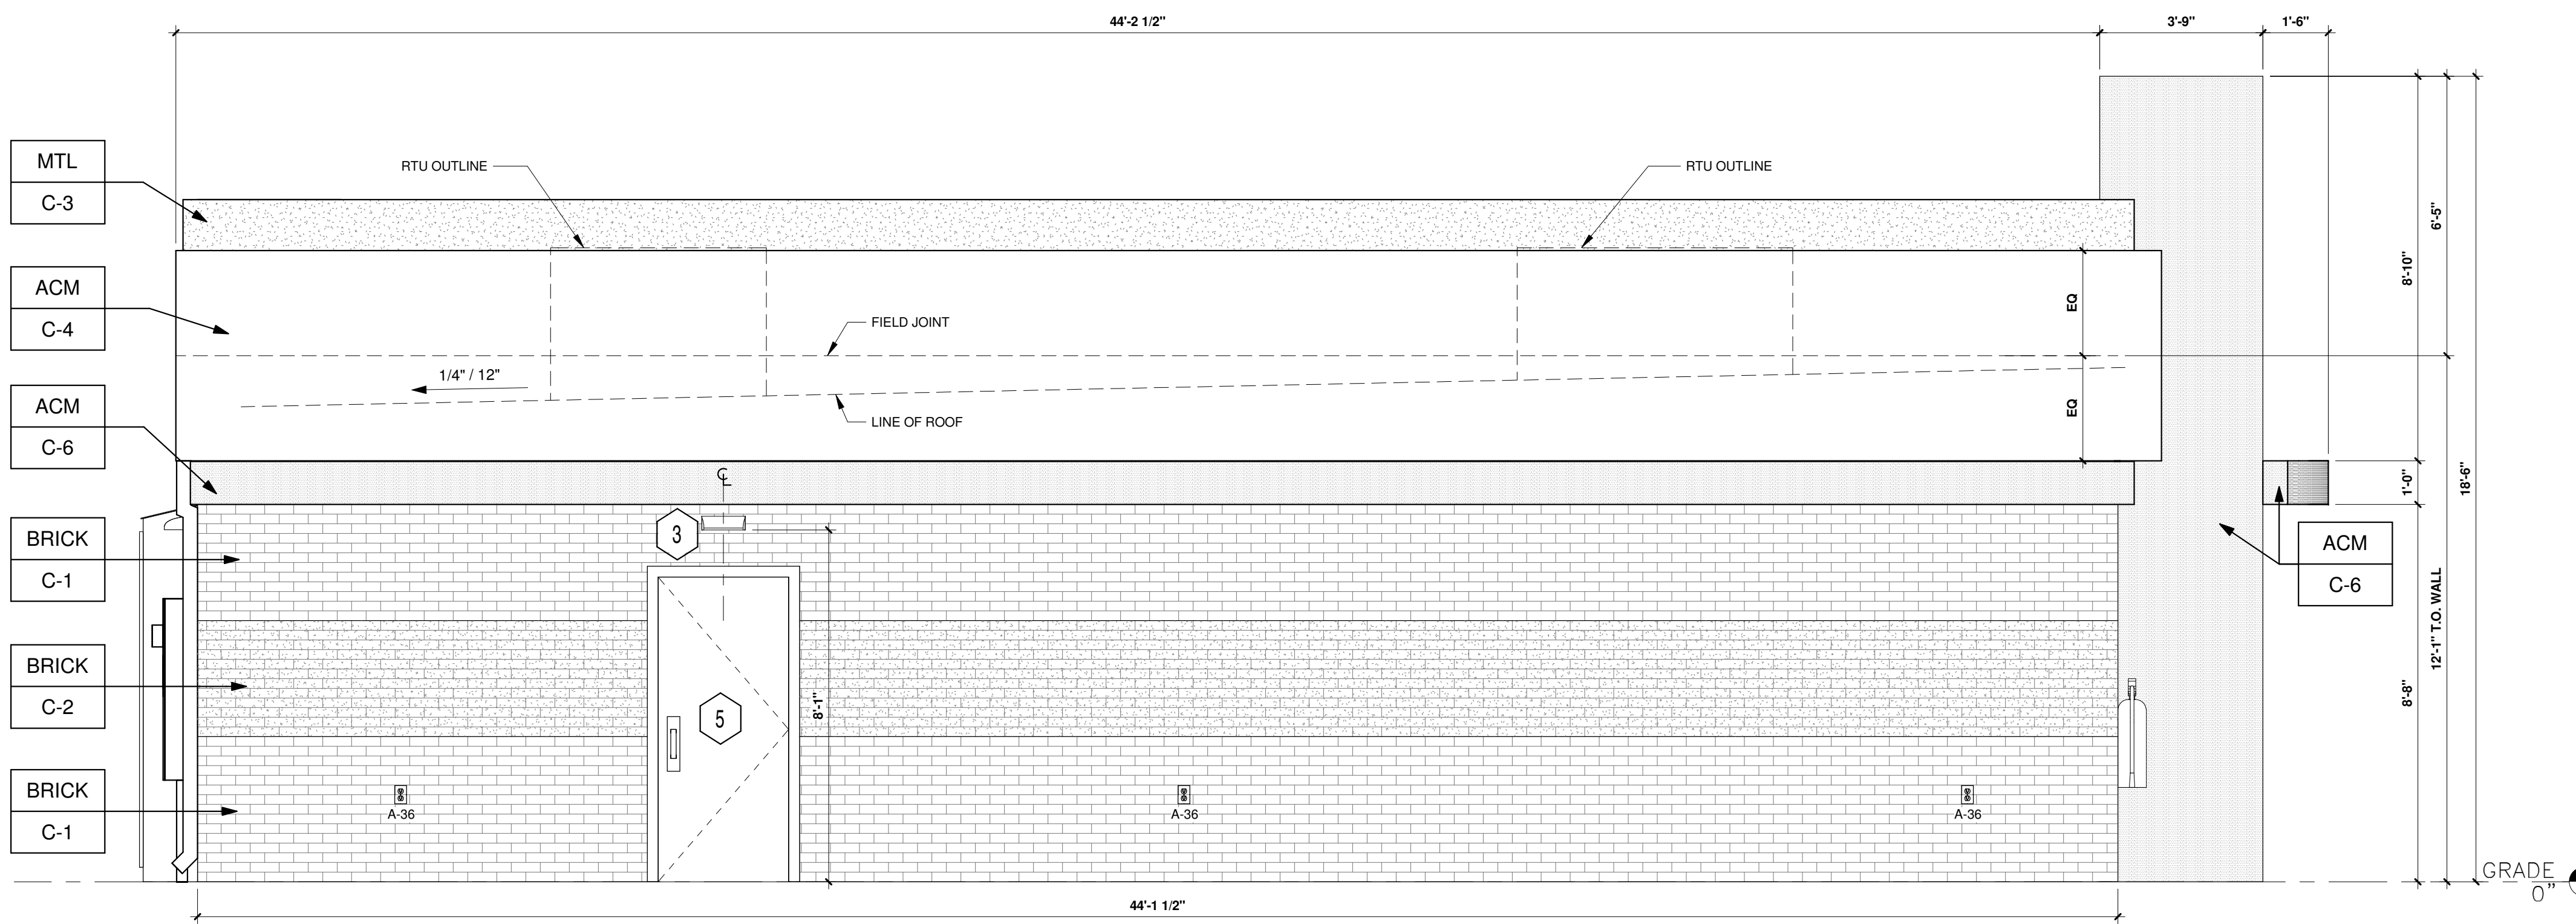

4 EAST ELEVATION - MERIDIAN ROAD
3/8" = 1'-0"

KEYED NOTES:

- 1 ROUTED LETTER LOGO SIGNAGE BY FMS
- 2 CLEAR ANODIZED ALUMINUM STOREFRONT SYSTEM KAWNEER, YKK OR EQUAL C-7
- 3 EXTERIOR LIGHTING, REFER TO LIGHTING PLAN SHEET EL2
- 4 4" x 4" PAINTED METAL DOWNSPOUTS C-3
- 5 DOORS (EXTERIOR SIDE) AND DOOR FRAMES PAINTED C-3
- 6 OPEN
- 7 MURPHY STAR LOGO SIGNAGE BY SIGN CONTRACTOR

EXTERIOR FINISHES:

- ACM ACM (3MM THICKNESS) BY FMS
- BRICK THIN BRICK BY FMS
- MTL 20 GA. SHEET METAL (UNLESS NOTED OTHERWISE) BY FMS

EXTERIOR PAINT/COLORS:

- C-1 THIN BRICK VENEER - LIGHT SANDSTONE VELOUR BY ENDICOTT (WIRE CUT FINISH) WITH ENDURA MAX PREBLENDED GREY COLOR GROUT BY FMS
- C-2 THIN BRICK VENEER - IVORY BLEND VELOUR BY ENDICOTT (WIRE CUT FINISH) WITH ENDURA MAX PREBLENDED GREY COLOR GROUT BY FMS
- C-3 'DORMER BROWN' SW #7521 BY FMS
- C-4 REYNOBOND #4 NATURAL BRUSHED ALUMINUM BY ARCONIC BY FMS
- C-5 OPEN
- C-6 'PROGRAM RED' BY ALPOLIC BY FMS
- C-7 CLEAR ANODIZED ALUMINUM STOREFRONT BY FMS

PROFESSIONAL SEAL

PROFESSIONAL IN CHARGE

SCOTT LOIKITS
PROJECT MANAGER
RASHMIKA PATEL
QUALITY CONTROL
CHRIS CERBO
DRAWN BY
SS

PROJECT NAME

MURPHY USA

MURPHY OIL CONVENIENCE STORE
MERIDIAN RD & EASTONVILLE RD,
FALCON
COLORADO 80831

FREY MOSS STRUCTURE

1801 Rockdale Industrial Blvd.
Conyers, Georgia 30012
Voice: (800) 366-6385
Fax: (770) 483-6037

FMS JOB NUMBER
GXXMXXXXXX
FMS MODEL NUMBER
XXXXXX

PROJECT NUMBER
20230059.5

SHEET TITLE

ARCHITECTURAL ELEVATIONS (BUILDING)

SHEET NUMBER


02




www.greenbergfarrow.com
251 West 30th Street
10th Floor
New York, New York 10001
t: 917.689.2729

COPYRIGHT NOTICE
This drawing is the property of the above referenced Professional and is not to be used for any purpose other than the specific project and site named herein, and cannot be reproduced in any manner without the express written permission from the Professional.


ISSUE RECORD	
DATE	REV. DESCRIPTION
12/28/2023	ENTITLEMENT SET

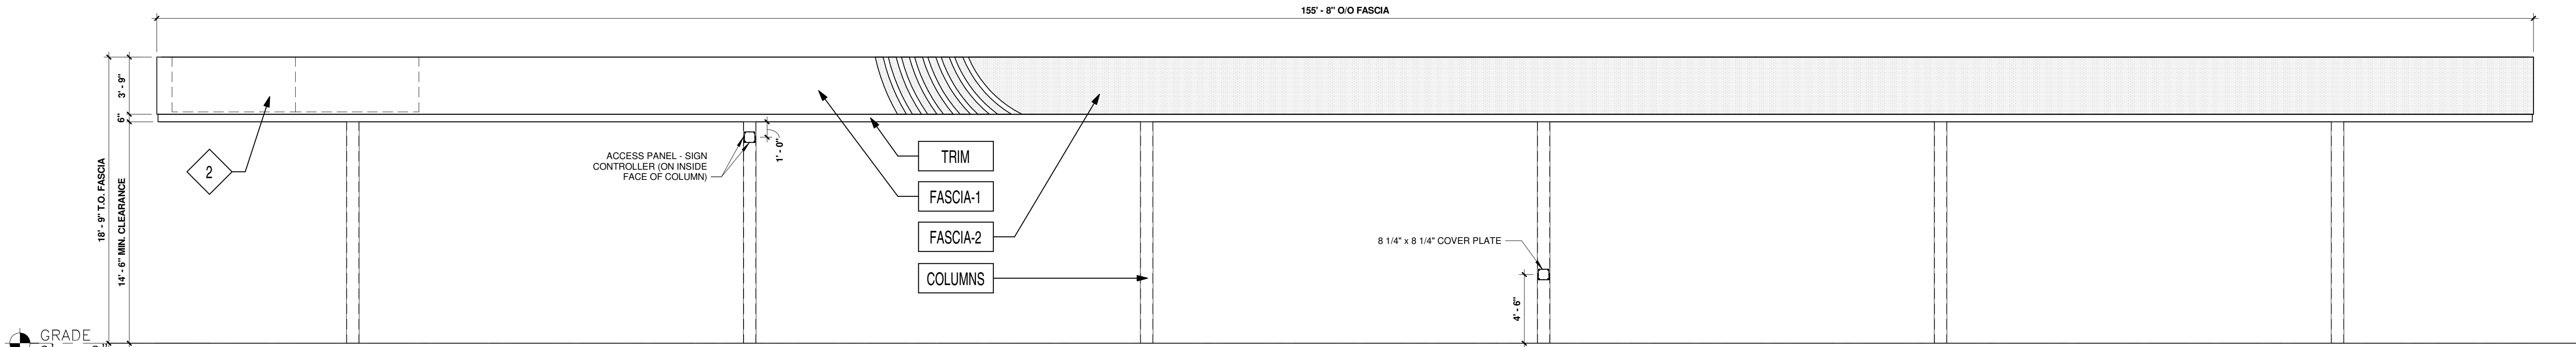


1 NORTH ELEVATION
3/16" = 1'-0"

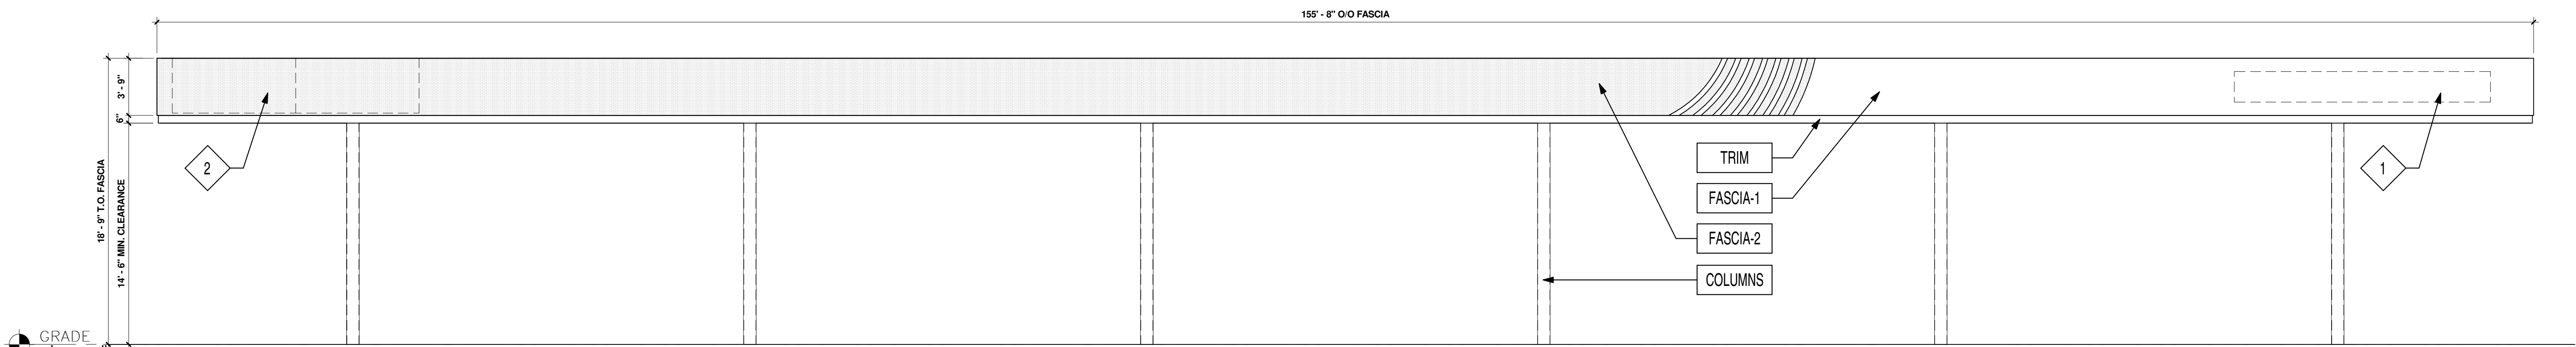

2 SOUTH ELEVATION - EASTONVILLE ROAD
3/16" = 1'-0"

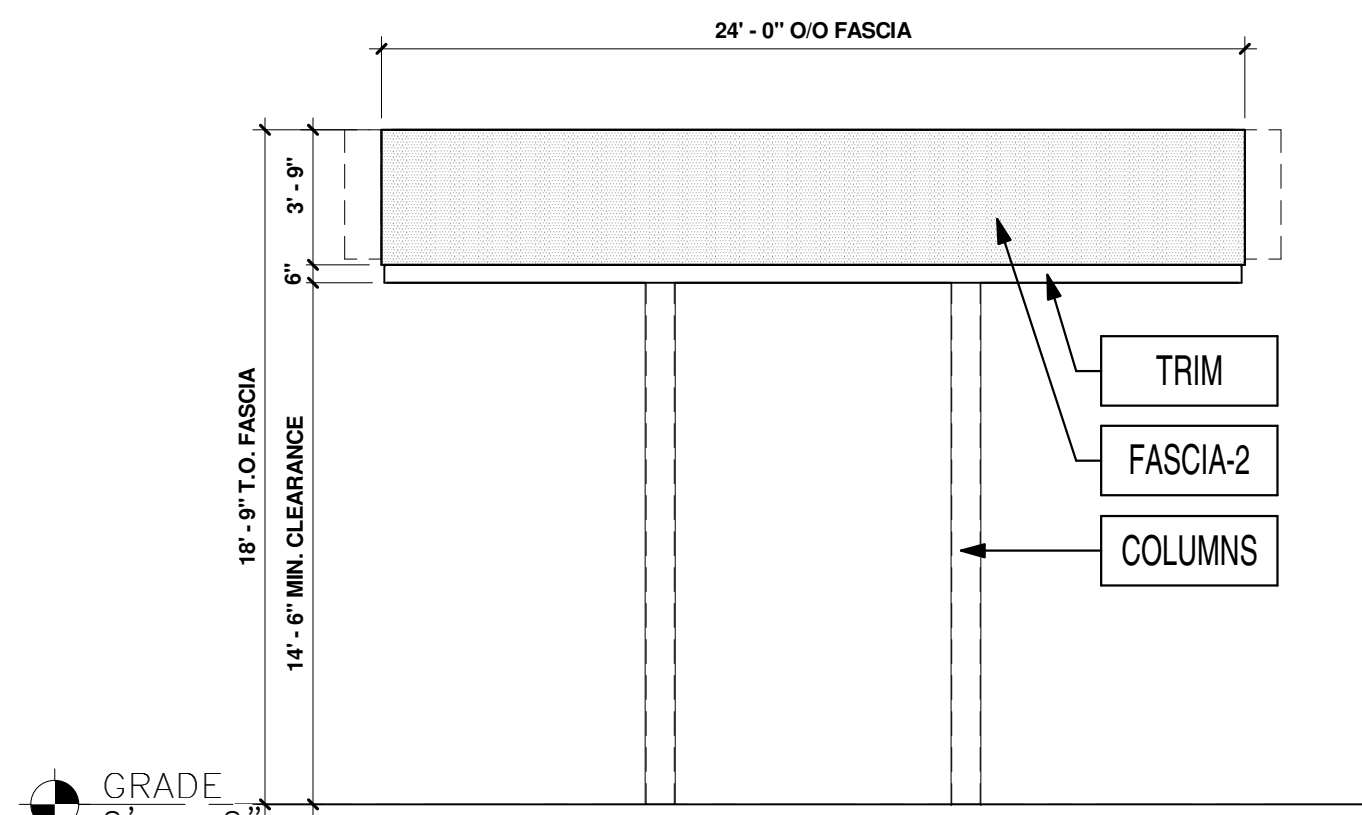

3 WEST ELEVATION
3/16" = 1'-0"

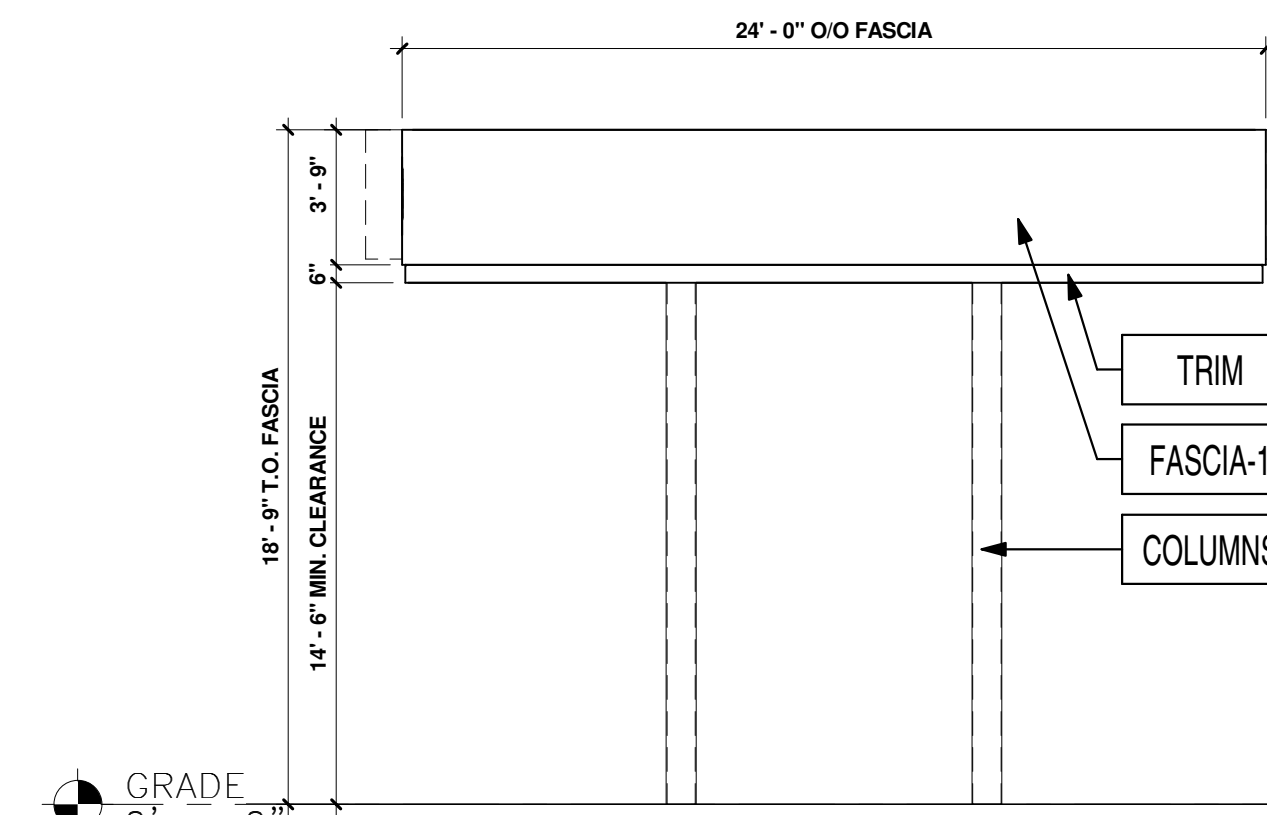

4 EAST ELEVATION - MERIDIAN ROAD
3/16" = 1'-0"

KEYED NOTES		FINISH SCHEDULE			
1	MURPHY LOGO SIGN	FASCIA-1	ACM (ALUMINUM COMPOSITE MATERIAL) ACM FASCIA "BRUSHED ALUMINUM"	FURNISHED & INSTALLED BY FMS	
2	CANOPY PRICE SIGNS	FASCIA-2	ACM (ALUMINUM COMPOSITE MATERIAL) ACM FASCIA "PROGRAM RED"	FURNISHED & INSTALLED BY FMS	
		TRIM	20 GA. SHEET METAL	6" HT PRE-FINISHED METAL ACCENT BAND "PURE WHITE" SW #7005	FURNISHED & INSTALLED BY FMS
		COLUMNS	SEE STRUCTURAL DRAWINGS	PAINTED "DORMER BROWN" SW #7521	FURNISHED & INSTALLED BY FMS

PROFESSIONAL SEAL

PROFESSIONAL IN CHARGE
SCOTT LOIKTS

PROJECT MANAGER
RASHMIKA PATEL

QUALITY CONTROL
CHRIS CERBO

DRAWN BY
SS

PROJECT NAME



MURPHY OIL FUEL FACILITY CANOPY
MERIDIAN RD & EASTONVILLE RD, FALCON COLORADO 80831



1801 Rockdale Industrial Blvd.
Conyers, Georgia 30012
Voice: (800) 366-6385
Fax: (770) 483-6037
FMS JOB NUMBER
GXXMXXXXX
FMS MODEL NUMBER
XXXXXX

PROJECT NUMBER
20230059.5

SHEET TITLE

ARCHITECTURAL ELEVATIONS (CANOPY)

SHEET NUMBER

03