

File Path: Q:\DEN\Projects\100810.00 CFA Powers & Palmer\CAD\CDS\100810 - C0.0 - CD - COVER SHEET & GN.dwg Last
Saved By: CHRISTIAN SCHILDER
1/31/2025 9:59 AM
00-LS-0000-A101-SHEET NAME



Know what's below.
Call before you dig.

LEGEND:

	PROPERTY LINE
	WATER METER
	IRRIGATION METER
	GREASE TRAP
	SINGLE CLEANOUT
	TWO-WAY CLEANOUT
	TRANSFORMER
	STORM INLET
	STORM MANHOLE
	LIGHT POLE
	PROPOSED TRAFFIC SIGN
	PAVEMENT STRIPING
	PARKING STALL COUNT
	FIRE LINE
	WATER LINE
	SANITARY SEWER
	GAS SERVICE
	ELECTRIC SERVICE
	TELEPHONE SERVICE
	STORM SEWER
	PROPOSED MAJOR CONTOUR
	PROPOSED MINOR CONTOUR
	EX STORM MANHOLE
	EX SANITARY MANHOLE
	EX STORM INLET
	EX LIGHT POLE
	EX UNDERGROUND ELECTRIC
	EX GAS SERVICE
	EX WATER LINE
	EX STORM SEWER
	EX SANITARY SEWER
	EX TELEPHONE SERVICE
	EX GUARDRAIL
	EX FIRE HYDRANT
	EX TRAFFIC SIGN
	EX MAJOR CONTOUR
	EX MINOR CONTOUR
	EX TREE
	EX IRRIGATION VALVE
	EX WATER VALVE
	EX TELEPHONE BOX
	EX ELECTRIC BOX
	EX RECLAIMED WATER MAIN
	EX STORM SEWER
	PROPOSED SIDEWALK CHASE

BASIS OF BEARINGS:

BEARINGS ARE ASSUMED AND ARE BASED UPON THE WEST LINE OF THE SOUTHWEST QUARTER OF SECTION 6, TOWNSHIP 14 SOUTH, RANGE 65 WEST, OF THE 6TH PRINCIPAL MERIDIAN, COUNTY OF EL PASO, STATE OF COLORADO AS BEARING S00°28'23"E A DISTANCE OF 2639.11 FEET BETWEEN THE MONUMENTS SHOWN HEREON.

BENCHMARK:

COLORADO SPRINGS MONUMENT PW 13, FOUND 2" FIMS CAP, STAMPED "PW 12" FLUSH WITH CONCRETE SURFACE, SOUTH OF THE INTERSECTION OF VICTOR PLACE AND NORTH POWERS BOULEVARD, ELEV. = 6350.64 NAVD 88

ABBREVIATION LEGEND

TW	GRADE AT TOP OF WALL
BG	GRADE AT BOTTOM OF WALL
PC	POINT OF CURVE
PT	POINT OF TANGENT
Δ	DELTA, HORIZONTAL CURVE DIRECTION CHANGE
C&G	CURB AND GUTTER
CL	CENTERLINE
FL	FLOWLINE
DBL	DOUBLE
C.O.	CLEAN OUT
K	RATE OF CURVATURE
AD	ABSOLUTE GRADE DIFFERENCE IN %
VC	VERTICAL CURVE
PVC	POINT OF VERTICAL CURVE
PVT	POINT OF VERTICAL TANGENT
PVI	POINT OF VERTICAL INTERSECTION
PI	POINT OF TANGENT INTERSECTION
ROW	RIGHT OF WAY
PVMT	PAVEMENT
HP	HIGH POINT
LP	LOW POINT
PCR	POINT OF CURB RETURN
PCC	POINT OF COMPOUND CURVE
PRC	POINT OF REVERSE CURVE
EX. EX.	EXISTING
PR. PR.	PROPOSED
ME	MATCH EXISTING
TC	BACK TOP OF CURB
FG	FINISHED GRADE
STA	STATION
EL. ELEV	ELEVATION
FF	FINISHED FLOOR
TC	TOP OF CONCRETE
B/P	BOTTOM OF PIPE
T/P	TOP OF PIPE
Ø	DIAMETER
UE	UTILITY EASEMENT
ESMT	EASEMENT
HCL	HORIZONTAL CONTROL LINE
N	NORTH/NORTHING
E	EAST/EASTING
W	WEST
S	SOUTH
R	RADIUS
LC	LENGTH OF CORD
LF	LENGTH FOOT
L	LENGTH
CB	CHORD BEARING

CONSTRUCTION DOCUMENTS CHICK-FIL-A POWERS & PALMER

PORTION OF LOT 1, BLOCK 1, WALDORF SUBDIVISION
LOCATED IN THE SOUTHWEST QUARTER OF THE SOUTHWEST QUARTER OF SECTION 6
TOWNSHIP 14 SOUTH, RANGE 65 WEST OF THE 6th P.M.
CITY OF COLORADO SPRINGS, COUNTY OF EL PASO, STATE OF COLORADO



VICINITY MAP
(1"= 500')

OWNER
CHICK-FIL-A, INC.
5200 BUFFINGTON ROAD
ATLANTA, GA 30349-2998
(404) 765-8000
CONTACT: MR. STEVE SCHWARTZ

CIVIL ENGINEER
MERRICK & COMPANY
5970 GREENWOOD PLAZA BLVD.
GREENWOOD VILLAGE, CO 80111
(303) 353-3359
CONTACT: MR. JONATHAN T. KILLINGSWORTH, PE

SITE ARCHITECT
150 PAULARINO AVE, BUILDING D, SUITE 270
COSTA MESA, CA 92626
(844) 804-7700
CONTACT: MR. SERGIO RAMOS

SURVEYOR
MERRICK & COMPANY
5970 GREENWOOD PLAZA BLVD.
GREENWOOD VILLAGE, CO 80111
(303) 353-3612
CONTACT: MRS. ERIKA ZIMMERMAN

FIRE DEPARTMENT
CITY OF COLORADO SPRINGS FIRE DEPARTMENT
2880 INTERNATIONAL CIRCLE, SUITE 200
COLORADO SPRINGS, CO 80910
(719) 385-7351

WATER & SANITARY SEWER
CHEROKEE METRO DISTRICT
6250 PALMER PARK BOULEVARD
COLORADO SPRINGS, CO 80915
(719) 668-7467

STORM DRAINAGE
EL PASO COUNTY DEPARTMENT OF PUBLIC WORKS
3275 AKERS DRIVE
COLORADO SPRINGS, CO 80922
(719) 520-6460

TELEPHONE COMPANY
LUMEN
10235 SOUTH 51ST STREET
PHOENIX, AZ 85044
(719) 955-2230

GAS COMPANY
COLORADO SPRINGS UTILITIES - GAS
2880 INTERNATIONAL CIR. SUITE 210
COLORADO SPRINGS, CO 80947
(719) 668-7865

ELECTRIC COMPANY
COLORADO SPRINGS UTILITIES - ELECTRIC
2880 INTERNATIONAL CIR. SUITE 210
COLORADO SPRINGS, CO 80947
(719) 668-3242

CDs for public improvements only

Note TIS comments will inform CDs and additional signing and striping sheet may be necessary based on comments in the TIS

Please see comments on the following sheets for where these respective sheets should be placed.

Sheet List Table		
Sheet Number	Sheet Description	Sheet Title
1	C0.0	COVER SHEET
2	C0.1	GENERAL NOTES
3	C1.0	DEMO PLAN
4	C2.0	SITE PLAN
5	C3.0	GRADING PLAN
6	PS1.0	UTILITY PLAN
7	PS1.1	STORM P&P
8	C9.0	CFA STANDARD DETAILS
9	C9.1	CFA STANDARD DETAILS
10	C9.2	CFA STANDARD DETAILS
11	C9.3	CFA STANDARD DETAILS
12	C9.4	DETAILS
13		LANDSCAPE COVER
14		LANDSCAPE PLAN
15		LANDSCAPE DETAILS

Merrick comment response
noted in blue text box with
white background



Chick-fil-A
5200 Buffington Road
Atlanta, Georgia 30349-2998



FOR AND ON BEHALF OF
MERRICK AND COMPANY

CONSTRUCTION DOCUMENTS

CHICK-FIL-A POWERS & PALMER PARK

SEC OF POWERS BLVD AND PALMER
PARK BLVD COLORADO SPRINGS, CO 80915

FSR#05934

BUILDING TYPE / SIZE: P12 LS LRG
RELEASE: vX.YY.MM

REVISION SCHEDULE
NO. DATE DESCRIPTION

CONSULTANT PROJECT #

PRINTED FOR

DATE 01/31/2024

DRAWN BY CSS

SHEET

COVER SHEET

SHEET NUMBER

C0.0

File Path: Q:\DEN\Projects\00810.00 CFA Powers & Palmer\CAD\CDS\100810 - C0.0 - CD - COVER SHEET & GN.dwg Last
Saved By: CHRISTIAN SCHILDER
1/31/2025 9:59 AM
00-LS-0000-A101-SHEET NAME



Know what's below.
Call before you dig.


GENERAL NOTES:

- DESCRIPTION OF PROPOSED ARCHITECTURAL STYLE AND MATERIALS
- PUBLIC LAND DEDICATION (PLD) TABLE OR STATEMENT WITH CALCULATIONS OF PLD (REQUIRED AND PROVIDED)
- RESIDENTIAL SUBDIVISIONS: LIST PROPOSED SUBDIVISION QUALITY ENHANCEMENTS
- STATEMENT THAT AN OWNER'S ASSOCIATION WILL BE FORMED FOR COMMON AND RIGHT-OF-WAY LANDSCAPE MAINTENANCE (FOR RESIDENTIAL SUBDIVISIONS AND MULTIPLE LOT NON-RESIDENTIAL PROJECTS)
- STATEMENT THAT THE ADJACENT PROPERTY OWNER OR ASSIGNS MAINTAINS THE LANDSCAPING INCLUDING RIGHT-OF-WAY LANDSCAPING
- THE PROPOSED SITE PLAN INCLUDED IN THIS PLAN SET IS CONCEPTUAL IN NATURE. THE FINAL CIVIL SITE DESIGN FOR THE REQUIRED PUBLIC/PRIVATE IMPROVEMENTS (INCLUDING BUT NOT LIMITED TO ROADWAY SECTIONS, SIDEWALKS, WATER, SANITARY SEWER, STORM SEWER, DRAINAGE, OTHER GENERAL INFRASTRUCTURE, ETC.) AND THE ASSOCIATED EASEMENTS AND RIGHT-OF-WAY FOR THOSE IMPROVEMENTS SHALL BE DETERMINED WITH THE SUBDIVISION PLAT, DEVELOPER'S AGREEMENT AND CIVIL CONSTRUCTION DRAWINGS. THESE IMPROVEMENTS SHALL BE DESIGNED AND CONSTRUCTED IN ACCORDANCE WITH THE STANDARDS AND SPECIFICATIONS FOR PUBLIC AND PRIVATE IMPROVEMENTS AND BASED UPON APPROVED MASTER PLANS APPROVED AT THE TIME OF THE RECORDATION OF THE DEVELOPER'S AGREEMENT.


MERRICK GENERAL NOTES:

- THE OWNER SHALL BE RESPONSIBLE FOR RECORDING AS-BUILT INFORMATION ON A SET OF RECORD DRAWINGS KEPT ON THE CONSTRUCTION SITE, AND AVAILABLE TO THE LOCAL ENTITY'S INSPECTOR AT ALL TIMES.
- THE PROJECT PLANS AND SPECIFICATIONS AS SIGNED AND SEALED BY A PROFESSIONAL ENGINEER, FOR AND ON BEHALF OF MERRICK AND COMPANY, REPRESENT THE FINAL CONSTRUCTION DOCUMENTS FOR THIS PROJECT. THE USE OF ANY ELECTRONIC OR OTHER MEDIA PURPORTING TO REPRESENT THE FINAL CONSTRUCTION DOCUMENTS FOR THIS PROJECT SHALL NOT BE RELIED UPON AS FINAL CONSTRUCTION DOCUMENTS. SHOULD THERE BE A CONFLICT BETWEEN SEALED DRAWINGS AND ELECTRONIC OR OTHER MEDIA FILES, THE SEALED DRAWINGS SHALL GOVERN. EACH USER OF ANY ELECTRONIC OR OTHER MEDIA WAIVES AND RELEASES MERRICK FROM ALL ACTIONS, CLAIMS, DAMAGES, ACTIONS, OBLIGATIONS AND LIABILITIES OF ANY KIND OR NATURE WITH RESPECT TO THE ELECTRONIC OR OTHER MEDIA FILES.
- NOTHING CONTAINED IN THE CONTRACT DOCUMENTS SHALL CREATE, NOR SHALL BE CONSTRUED TO CREATE ANY CONTRACTUAL RELATIONSHIP BETWEEN THE ENGINEER AND THE CONTRACTOR OR ANY SUBCONTRACTOR.
- THE PROJECT PLANS AND SPECIFICATIONS ARE INTENDED TO PROVIDE THE COMPLETED PROJECT IN A COMPLETE AND OPERABLE CONDITION. THE CONTRACTOR SHALL FURNISH AND INSTALL ALL MATERIALS AND PROVIDE ALL LABOR NECESSARY TO COMPLETE THE PROJECT IN A NEAT AND WORKMANLIKE MANNER, INCLUDING ALL INCIDENTALS NECESSARY TO COMPLETE THE WORK, WITHOUT ADDITIONAL COST TO THE OWNER.
- UPON COMPLETION OF CONSTRUCTION, THE SITE SHALL BE CLEANED AND RESTORED TO A CONDITION EQUAL TO, OR BETTER THAN, THAT WHICH EXISTED BEFORE CONSTRUCTION OR TO THE GRADES AND CONDITION AS REQUIRED BY THESE PLANS. EXISTING FENCES, TREES, STREETS, SIDEWALKS, CURBS AND GUTTERS, LANDSCAPING, STRUCTURES, AND IMPROVEMENTS DESTROYED, DAMAGED OR REMOVED DUE TO CONSTRUCTION OF THIS PROJECT SHALL BE REPLACED OR RESTORED IN LIKE KIND AT THE OWNER'S EXPENSE, UNLESS OTHERWISE INDICATED ON THESE PLANS.
- DEVIATIONS FROM THESE PLANS AND SPECIFICATIONS WITHOUT PRIOR WRITTEN APPROVAL OF THE OWNER OR HIS DESIGNATED REPRESENTATIVE MAY CAUSE THE WORK TO BE DEEMED UNACCEPTABLE.
- MERRICK & COMPANY IS NOT RESPONSIBLE FOR CONSTRUCTION MEANS, METHODS, TECHNIQUES, SEQUENCES OR PROCEDURES OR FOR SAFETY PRECAUTIONS OR PROGRAMS UTILIZED IN CONNECTION WITH THE WORK. MERRICK WILL NOT BE RESPONSIBLE FOR THE CONTRACTOR'S FAILURE TO CARRY OUT THE WORK IN ACCORDANCE WITH THE CONTRACT DOCUMENTS.
- WHEN APPLICABLE, THE OWNER SHALL HAVE ONSITE AT ALL TIMES, EACH OF THE FOLLOWING:
 - THE NOTICE OF INTENT (NOI)
 - BEST MANAGEMENT PRACTICES (BMP) MAINTENANCE FOLDER
 - UP TO DATE STORMWATER MANAGEMENT PLAN (SWMP) THAT ACCURATELY REPRESENTS CURRENT FIELD CONDITIONS
 - ONE (1) SIGNED COPY OF THE APPROVED PLANS
 - ONE (1) COPY OF THE APPROPRIATE STANDARDS AND SPECIFICATIONS
 - A COPY OF ANY PERMITS AND EXTENSION AGREEMENTS NEEDED FOR THE JOB.
- ALL MATERIALS, WORKMANSHIP, AND CONSTRUCTION OF PUBLIC IMPROVEMENTS SHALL MEET OR EXCEED THE STANDARDS AND SPECIFICATIONS SET FORTH IN THE CITY OF LONE TREE STANDARDS AND APPLICABLE STATE AND FEDERAL REGULATIONS. WHERE THERE IS CONFLICT BETWEEN THESE PLANS AND THE SPECIFICATIONS, OR ANY APPLICABLE STANDARDS, THE MOST RESTRICTIVE STANDARD SHALL APPLY. ALL WORK SHALL BE INSPECTED AND APPROVED BY THE LOCAL ENTITY.
- DO NOT SCALE DRAWINGS. DIMENSIONS FOR LAYOUT AND CONSTRUCTION ARE NOT TO BE SCALED FROM ANY DRAWING. IF PERTINENT DIMENSIONS ARE NOT SHOWN, CONTACT THE DESIGNER FOR CLARIFICATION, AND ANNOTATE THE DIMENSION ON THE AS-BUILT RECORD DRAWINGS.
- THE BOUNDARY AND TOPOGRAPHIC INFORMATION ON THESE PLANS IS TAKEN FROM FIELD SURVEYS PREPARED BY MERRICK AND COMPANY DATED AUGUST 14, 2024. CONTRACTOR TO FIELD VERIFY EXISTING TOPOGRAPHY OF THE DOUGLAS COUNTY PEDESTRIAN BRIDGE IMPROVEMENTS PRIOR TO BEGINNING CONSTRUCTION. NOTIFY ENGINEER OF RECORD IMMEDIATELY IF ANY DISCREPANCIES ARE FOUND.
- THE CONTRACTOR SHALL COMPLY WITH THE RECOMMENDATIONS OF THE GEOTECHNICAL ENGINEERING EXPLORATION AND ANALYSIS REPORT COMPLETED DECEMBER 31, 2024 BY GILES ENGINEERING ASSOCIATES, INC.
- THE CONTRACTOR SHALL OBTAIN ALL PERMITS NECESSARY TO COMPLETE THE WORK AND SHALL COMPLY WITH ALL LOCAL, STATE AND FEDERAL REGULATIONS. A COPY OF ALL PERMITS SHALL BE MAINTAINED ON-SITE AT ALL TIMES.
- THE CONTRACTOR IS RESPONSIBLE FOR SAFETY OF ALL PERSONNEL AND EQUIPMENT ON THE PROJECT SITE AT ALL TIMES, AND IS NOT LIMITED TO NORMAL WORKING HOURS. ALL WORK SHALL BE PERFORMED IN ACCORDANCE WITH ALL LOCAL, STATE AND FEDERAL SAFETY AND HEALTH REGULATIONS.
- IF, DURING THE CONSTRUCTION PROCESS, CONDITIONS ARE ENCOUNTERED WHICH COULD INDICATE A SITUATION THAT IS NOT IDENTIFIED IN THE PLANS OR SPECIFICATIONS, THE OWNER SHALL CONTACT THE DESIGNER AND THE LOCAL ENTITY ENGINEER IMMEDIATELY.
- ALL REFERENCES TO ANY PUBLISHED STANDARDS SHALL REFER TO THE LATEST REVISION OF SAID STANDARD, UNLESS SPECIFICALLY STATED OTHERWISE.
- THERE SHALL BE NO WORK PERFORMED ON WEEKENDS OR HOLIDAYS, UNLESS ACCEPTED AND APPROVED IN WRITING AND IN ADVANCE BY THE OWNER, ENGINEER, AND LOCAL JURISDICTION.
- MAINTAIN EMERGENCY VEHICLE ACCESS TO AND THROUGH THE PROJECT SITE AT ALL TIMES.
- ACCESS TO PRIVATE PROPERTY AND BUSINESSES SHALL BE MAINTAINED AT ALL TIMES. CONTRACTOR TO PROVIDE ALTERNATIVE MEANS OF INGRESS AND EGRESS TO PRIVATE PROPERTY AND BUSINESS LOCATIONS AS NECESSARY TO PROVIDE FOR THE TIMELY COMPLETION OF THE PROJECT.
- THE CONTRACTOR SHALL CALL THE NATIONWIDE UTILITY CONTACT NUMBER (811) OR LOCAL UTILITY LOCATE SERVICE, TO REQUEST LOCATES OF ALL UNDERGROUND UTILITIES AT LEAST 72 HOURS PRIOR TO COMMENCEMENT OF ANY LAND DISTURBING ACTIVITY.
- THE CONTRACTOR SHALL BE RESPONSIBLE FOR THE LOCATION AND PROTECTION OF ALL EXISTING UTILITIES, INCLUDING DEPTH, THE TYPE, SIZE, LOCATION AND NUMBER OF ALL KNOWN UNDERGROUND UTILITIES ARE APPROXIMATE ONLY AND ARE NOT RELIABLE FOR CONSTRUCTION PURPOSES. THE UTILITIES SHOWN ON THE PLANS ARE FROM THE BEST AVAILABLE INFORMATION AND MAY NOT INCLUDE ALL UTILITIES THAT EXIST ON THE PROJECT SITE. IT SHALL BE THE RESPONSIBILITY OF THE OWNER TO VERIFY THE EXISTENCE AND LOCATION OF ALL UNDERGROUND UTILITIES ALONG THE ROUTE OF THE WORK BEFORE COMMENCING NEW CONSTRUCTION. THE OWNER SHALL BE RESPONSIBLE FOR UNKNOWN UNDERGROUND UTILITIES.

- APPROXIMATE WHEN SHOWN ON THE DRAWINGS. ALL UTILITY INSTALLATIONS WITHIN OR ACROSS THE ROADBED OF NEW RESIDENTIAL ROADS MUST BE COMPLETED PRIOR TO THE FINAL STAGES OF ROAD CONSTRUCTION. FOR THE PURPOSES OF THESE STANDARDS, ANY WORK EXCEPT C/G ABOVE THE SUBGRADE IS CONSIDERED FINAL STAGE WORK. ALL SERVICE LINES MUST BE STUBBED TO THE PROPERTY LINES AND MARKED SO AS TO REDUCE THE EXCAVATION NECESSARY FOR BUILDING CONNECTIONS.
- A STATE CONSTRUCTION DEWATERING WASTEWATER DISCHARGE PERMIT IS REQUIRED IF DEWATERING IS REQUIRED IN ORDER TO INSTALL UTILITIES OR BEFORE WATER IS DISCHARGED INTO A STORM SEWER, CHANNEL, IRRIGATION DITCH OR ANY WATERS OF THE UNITED STATES.
- THE OWNER SHALL COORDINATE AND COOPERATE WITH THE LOCAL ENTITY, AND ALL UTILITY COMPANIES INVOLVED, WITH REGARD TO RELOCATIONS, ADJUSTMENTS, EXTENSIONS AND REARRANGEMENTS OF EXISTING UTILITIES DURING CONSTRUCTION, AND TO ASSURE THAT THE WORK IS ACCOMPLISHED IN A TIMELY FASHION AND WITH A MINIMUM DISRUPTION OF SERVICE. THE OWNER SHALL BE RESPONSIBLE FOR CONTACTING, IN ADVANCE, ALL PARTIES AFFECTED BY ANY DISRUPTION OF ANY UTILITY SERVICE AS WELL AS THE UTILITY COMPANIES. IN GENERAL, STORM SEWER AND SANITARY SEWER SHOULD BE CONSTRUCTED PRIOR TO INSTALLATION OF THE WATER LINES AND DRY UTILITIES.
- THE CONTRACTOR SHALL BE RESPONSIBLE FOR PROTECTING ALL UTILITIES DURING CONSTRUCTION AND FOR COORDINATING WITH THE APPROPRIATE UTILITY COMPANY FOR ANY UTILITY CROSSINGS REQUIRED.
- THE CONTRACTOR SHALL VERIFY SITE CONDITIONS, EXISTING TOPOGRAPHIC DATA, AND LOCATIONS OF ALL UTILITIES PRIOR TO INITIATING CONSTRUCTION. THE CONTRACTOR SHALL PROTECT ALL EXISTING UTILITIES AND STRUCTURES ON THE PROJECT SITE. ANY DAMAGE TO EXISTING UTILITIES OR STRUCTURES, WHETHER SHOWN OR NOT ON THE PROJECT PLANS SHALL BE REPAIRED OR REPLACED AT THE CONTRACTOR'S EXPENSE AT NO ADDITIONAL COST TO THE OWNER. NOTIFY ENGINEER AND OWNER OF ANY DISCREPANCIES FOUND PRIOR TO INITIATING ANY WORK.
- ANY DISRUPTION IN UTILITIES SHALL BE COORDINATED AT LEAST 48 HOURS IN ADVANCE WITH THE UTILITY OWNER, PROJECT OWNER, EMERGENCY PROVIDERS, ALL IMPACTED LOCAL RESIDENTS, AND IMPACTED BUSINESS OWNERS. METHOD OF NOTIFICATION SHALL BE SUBJECT TO APPROVAL OF THE PROJECT OWNER AND AFFECTED UTILITY.
- THE CONTRACTOR IS RESPONSIBLE FOR RESTORATION OF SURFACE CONDITIONS DISTURBED BY CONSTRUCTION ACTIVITIES TO THE SATISFACTION OF THE OWNER, PROPERTY OWNER, AFFECTED UTILITY, AND/OR LOCAL JURISDICTION. ALL SURFACE AND UTILITY RESTORATION SHALL BE REPLACED WITH LIKE KIND, SIZE, AND TYPE OF IMPROVEMENT THAT EXISTED PRIOR TO INITIATING CONSTRUCTION AT NO ADDITIONAL EXPENSE TO THE PROJECT OWNER.
- OVERLOT GRADING CONSTRUCTION MUST COMPLY WITH THE STATE OF COLORADO PERMITTING PROCESS FOR "STORM WATER DISCHARGES ASSOCIATED WITH CONSTRUCTION ACTIVITY." CONTACT THE COLORADO DEPARTMENT OF PUBLIC HEALTH & ENVIRONMENT, WATER QUALITY CONTROL DIVISION, PHONE (303) 692-3500.
- PAVING SHALL NOT START UNTIL A SOILS REPORT AND PAVEMENT DESIGN IS ACCEPTED BY THE LOCAL ENTITY ENGINEER AND SUBGRADE COMPACTION TESTS ARE TAKEN AND ACCEPTED BY THE LOCAL ENTITY ENGINEER.
- THE OWNER SHALL BE RESPONSIBLE FOR OBTAINING SOILS TESTS WITHIN THE PUBLIC RIGHT-OF-WAY AFTER RIGHT OF WAY GRADING AND ALL UTILITY TRENCH WORK IS COMPLETE. IF THE FINAL SOILS/PAVEMENT DESIGN REPORT DOES NOT CORRESPOND WITH THE RESULTS OF THE ORIGINAL GEOTECHNICAL REPORT, THE OWNER SHALL BE RESPONSIBLE FOR A RE-DESIGN OF THE SUBJECT PAVEMENT SECTION OR, THE OWNER MAY USE THE LOCAL ENTITY'S DEFAULT PAVEMENT THICKNESS SECTION(S). REGARDLESS OF THE OPTION USED, ALL FINAL SOILS/PAVEMENT DESIGN REPORTS SHALL BE PREPARED BY A LICENSED PROFESSIONAL ENGINEER. THE FINAL REPORT SHALL BE SUBMITTED TO THE INSPECTOR A MINIMUM OF TEN (10) WORKING DAYS PRIOR TO PLACEMENT OF BASE AND ASPHALT. PLACEMENT OF BASE AND ASPHALT SHALL NOT OCCUR UNTIL THE ENGINEERING DIVISION APPROVES THE FINAL REPORT.
- ALL ROAD CONSTRUCTION IN AREAS DESIGNATED AS WILD FIRE HAZARD AREAS SHALL BE DONE IN ACCORDANCE WITH THE CONSTRUCTION CRITERIA AS ESTABLISHED IN THE WILD FIRE HAZARD AREA MITIGATION REGULATIONS IN FORCE AT THE TIME OF FINAL PLAT APPROVAL.
- THE ENGINEER MAKES NO REPRESENTATION OR GUARANTEE REGARDING EARTHWORK QUANTITIES OR THAT THE EARTHWORK FOR THIS PROJECT WILL BALANCE DUE TO VARIOUS FIELD CONDITIONS, CHANGING SOIL TYPES, ALLOWABLE CONSTRUCTION TOLERANCES AND CONSTRUCTION METHODS THAT ARE BEYOND THE CONTROL OF THE ENGINEER.
- TRAFFIC CONTROL STANDARDS FOR THIS PROJECT SHALL COMPLY WITH THE MANUAL ON UNIFORM TRAFFIC CONTROL DEVICES, LATEST EDITION. A TRAFFIC CONTROL PLAN APPROVED BY THE LOCAL ENTITY EXERCISING JURISDICTION SHALL BE OBTAINED BY THE CONTRACTOR AT NO ADDITIONAL EXPENSE TO THE OWNER.
- THE OWNER SHALL SUBMIT A CONSTRUCTION TRAFFIC CONTROL PLAN, IN ACCORDANCE WITH MUTCD, TO THE APPROPRIATE RIGHT-OF-WAY AUTHORITY, (LOCAL ENTITY, COUNTY OR STATE), FOR APPROVAL, PRIOR TO ANY CONSTRUCTION ACTIVITIES WITHIN, OR AFFECTING, THE RIGHT-OF-WAY. THE OWNER SHALL BE RESPONSIBLE FOR PROVIDING ANY AND ALL TRAFFIC CONTROL DEVICES AS MAY BE REQUIRED BY THE CONSTRUCTION ACTIVITIES.
- SAW CUT ALL JOINTS IN EXISTING PAVEMENTS. SAW CUT JOINTS IN CURB AND GUTTER SECTIONS SHALL BE CONTINUOUS THROUGH THE CURB HEAD.
- INSTALL SEDIMENTATION AND EROSION CONTROL MEASURES PRIOR TO INITIATING ANY WORK ON THE PROJECT SITE. MAINTAIN ALL EROSION CONTROL MEASURES UNTIL FINAL ACCEPTANCE BY A CITY OF LONE TREE GESC INSPECTOR.
- ALL STRUCTURAL EROSION CONTROL MEASURES SHALL BE INSTALLED, AT THE LIMITS OF CONSTRUCTION AND AT AREAS WITH DISTURBED SOIL, ON- OR OFF-SITE, PRIOR TO ANY OTHER GROUND-DISTURBING ACTIVITY. ALL EROSION CONTROL MEASURES SHALL BE MAINTAINED IN GOOD REPAIR BY THE OWNER, UNTIL SUCH TIME AS THE ENTIRE DISTURBED AREAS IS STABILIZED WITH HARD SURFACE OR LANDSCAPING.
- THE OWNER SHALL BE RESPONSIBLE FOR INSURING THAT NO MUD OR DEBRIS SHALL BE TRACKED ONTO THE EXISTING PUBLIC STREET SYSTEM. MUD AND DEBRIS MUST BE REMOVED BY THE END OF EACH WORKING DAY BY AN APPROPRIATE MECHANICAL METHOD (I.E. MACHINE BROOM SWEEP, LIGHT DUTY FRONT-END LOADER, ETC.) OR AS APPROVED BY THE LOCAL ENTITY STREET INSPECTOR.
- ALL WASTE MATERIALS SHALL BE PROPERLY DISPOSED OF IN AN APPROVED LANDFILL PERMITTED TO ACCEPT THAT PARTICULAR TYPE OF WASTE.
- WHERE CONFLICTS EXIST BETWEEN GENERAL NOTES AND THE NOTES OF SPECIFIC GOVERNING JURISDICTIONS, THE GREATER STANDARD OR REQUIREMENT SHALL PREVAIL. WHERE CONFLICTS BETWEEN THE PLANS AND SPECIFICATIONS AND THE NOTES OR REQUIREMENTS OF SPECIFIC GOVERNING JURISDICTIONS OCCUR, THE CONTRACTOR SHALL NOTIFY THE ENGINEER OR OWNER IMMEDIATELY AND REQUEST CLARIFICATION.
- CONTRACTOR RESPONSIBLE FOR PROVIDING STRUCTURAL DESIGN OF PROPOSED RETAINING WALL AND PROCESSING STRUCTURAL DRAWINGS THROUGH CITY OF LONE TREE PUBLIC WORKS. CONTRACTOR SHALL VERIFY THAT ADDITIONS TO EXISTING WALL SHALL FIT WITH PROPOSED WALL.
- A COLORADO PE SIGNED/SEALED RETAINING WALL DESIGN MUST BE PREPARED AND SUBMITTED TO THE CITY (ATTENTION PUBLIC WORKS/ENGINEERING) IF ANY PORTION OF THE EXISTING RETAINING WALL IS DAMAGED AND IN NEED OF REPLACEMENT. ENGINEER OF RECORD TO BE NOTIFIED IMMEDIATELY IN THE EVENT THE EXISTING RETAINING WALL IS DAMAGED.
- IN THE EVENT A RETAINING WALL IS TO BE CONSTRUCTED THE CITY WILL "RECEIVE AND PLACE ON FILE" THE DESIGN REPORT. WHILE THE CITY MAY SCAN THE REPORT FOR GENERAL CONTENT AND APPARENT SUFFICIENCY OF DOCUMENTATION, THE CITY WILL NOT DO AN ENGINEERING REVIEW FOR ADEQUACY OF THE DESIGN NOR ISSUE A FORMAL APPROVAL. THE RESPONSIBILITY FOR THE ADEQUACY OF WALL DESIGN WILL REST WITH THE PE SIGNED/SEALED THE DESIGN.
- IN THE EVENT A RETAINING WALL IS TO BE CONSTRUCTED, DURING CONSTRUCTION OF THE WALL, THE DEVELOPER/CONTRACTOR SHALL PROVIDE, VIA A THIRD PARTY ENTITY, SUFFICIENT INSPECTION/DOCUMENTATION TO BE ABLE TO PROVIDE TO THE CITY (ATTENTION PUBLIC WORKS/ENGINEERING) A PE SIGNED/SEALED POST CONSTRUCTION CERTIFICATION THAT THE WALL(S) WERE CONSTRUCTED IN GENERAL CONFORMANCE WITH THE SUBMITTED PE SIGNED/SEALED DESIGN.
- THE NOTED CONSTRUCTION CERTIFICATION MUST BE SUBMITTED TO THE CITY PRIOR TO ISSUANCE OF FINAL CERTIFICATE(S) OF OCCUPANCY.
- THE CITY (VIA PUBLIC WORKS/ENGINEERING WILL "RECEIVE AND PLACE ON FILE" THE PE SIGNED/SEALED POST CONSTRUCTION WALL CERTIFICATION.
- ALL EXISTING AND PROPOSED VALVE AND MANHOLE COVERS SHALL BE ADJUSTED TO FINAL PAVEMENT GRADE DURING CONSTRUCTION. SEWER RIM ELEVATIONS SHOWN ARE APPROXIMATE AND ARE NOT TO BE TAKEN AS FINAL ELEVATIONS. THE PIPELINE CONTRACTOR SHALL USE CONCRETE ADJUSTMENT RINGS TO ALLOW FOR LATER ADJUSTMENT TO MATCH FINAL PAVEMENT ELEVATIONS.
- THE MAXIMUM CROSS SLOPE FOR ANY SIDEWALK SHALL NOT EXCEED 2.00%. THE MAXIMUM LONGITUDINAL GRADE SHALL NOT EXCEED 5.00%, EXCEPT WHERE SPECIFICALLY NOTED AS "RAMPS". ANYWHERE ON THIS PROJECT, "RAMPS", EXCEPT FOR CURB RAMPS, SHALL NOT HAVE A SLOPE EXCEEDING 1:12 AND SHALL HAVE APPROVED PEDESTRIAN HAND RAIL ON BOTH SIDES OF THE RAMP.
- ALL EXTERIOR STEPS SHALL HAVE RISER HEIGHTS AS NOTED ON THE GRADING PLAN AND 12-INCH TREAD DEPTHS (UNLESS OTHERWISE NOTED).
- TREADS SHALL HAVE A SLOPE OF ONE PERCENT AND SHALL HAVE A 1/2-INCH RADIUS ON THE NOSING.
- LANDINGS SHALL HAVE A MAXIMUM SLOPE, IN ANY DIRECTION, OF TWO PERCENT AND SHALL NOT BE LESS THAN FIVE FEET WIDE IN ANY DIRECTION.

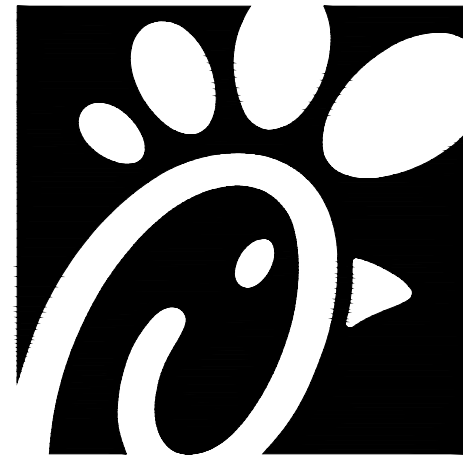

Chick-fil-A
5200 Buffington Road
Atlanta, Georgia 30349-2998

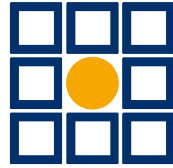

MERRICK®

5970 GREENWOOD PLAZA BLVD
GREENWOOD VILLAGE, CO 80111
303-751-0741

FOR AND AND ON-BEHALF OF
MERRICK AND COMPANY

CHICK-FIL-A
POWERS & PALMER PARK
SEC OF POWERS BLVD AND PALMER
PARK BLVD COLORADO SPRINGS, CO 80915

FSR#05934

BUILDING TYPE / SIZE: P12 LS LRG
RELEASE: vX.YY.MM

REVISION SCHEDULE
NO. DATE DESCRIPTION

CONSULTANT PROJECT #

PRINTED FOR

DATE 01/31/2024

DRAWN BY CSS

SHEET

GENERAL NOTES


SHEET NUMBER

C0.1

File Path: Q:\DEN\Projects\100810.00 CFA Powers & Palmer\CADDs\100810 - C1.0 - CD - DEMO PLAN.dwg Last Saved
By: CHRISTIAN SCHILDER
1/31/2025 9:59 AM
00-LS-0000-A101-SHEET NAME



POWERS BOULEVARD
(174' R.O.W.)
REC. NO. 202065502

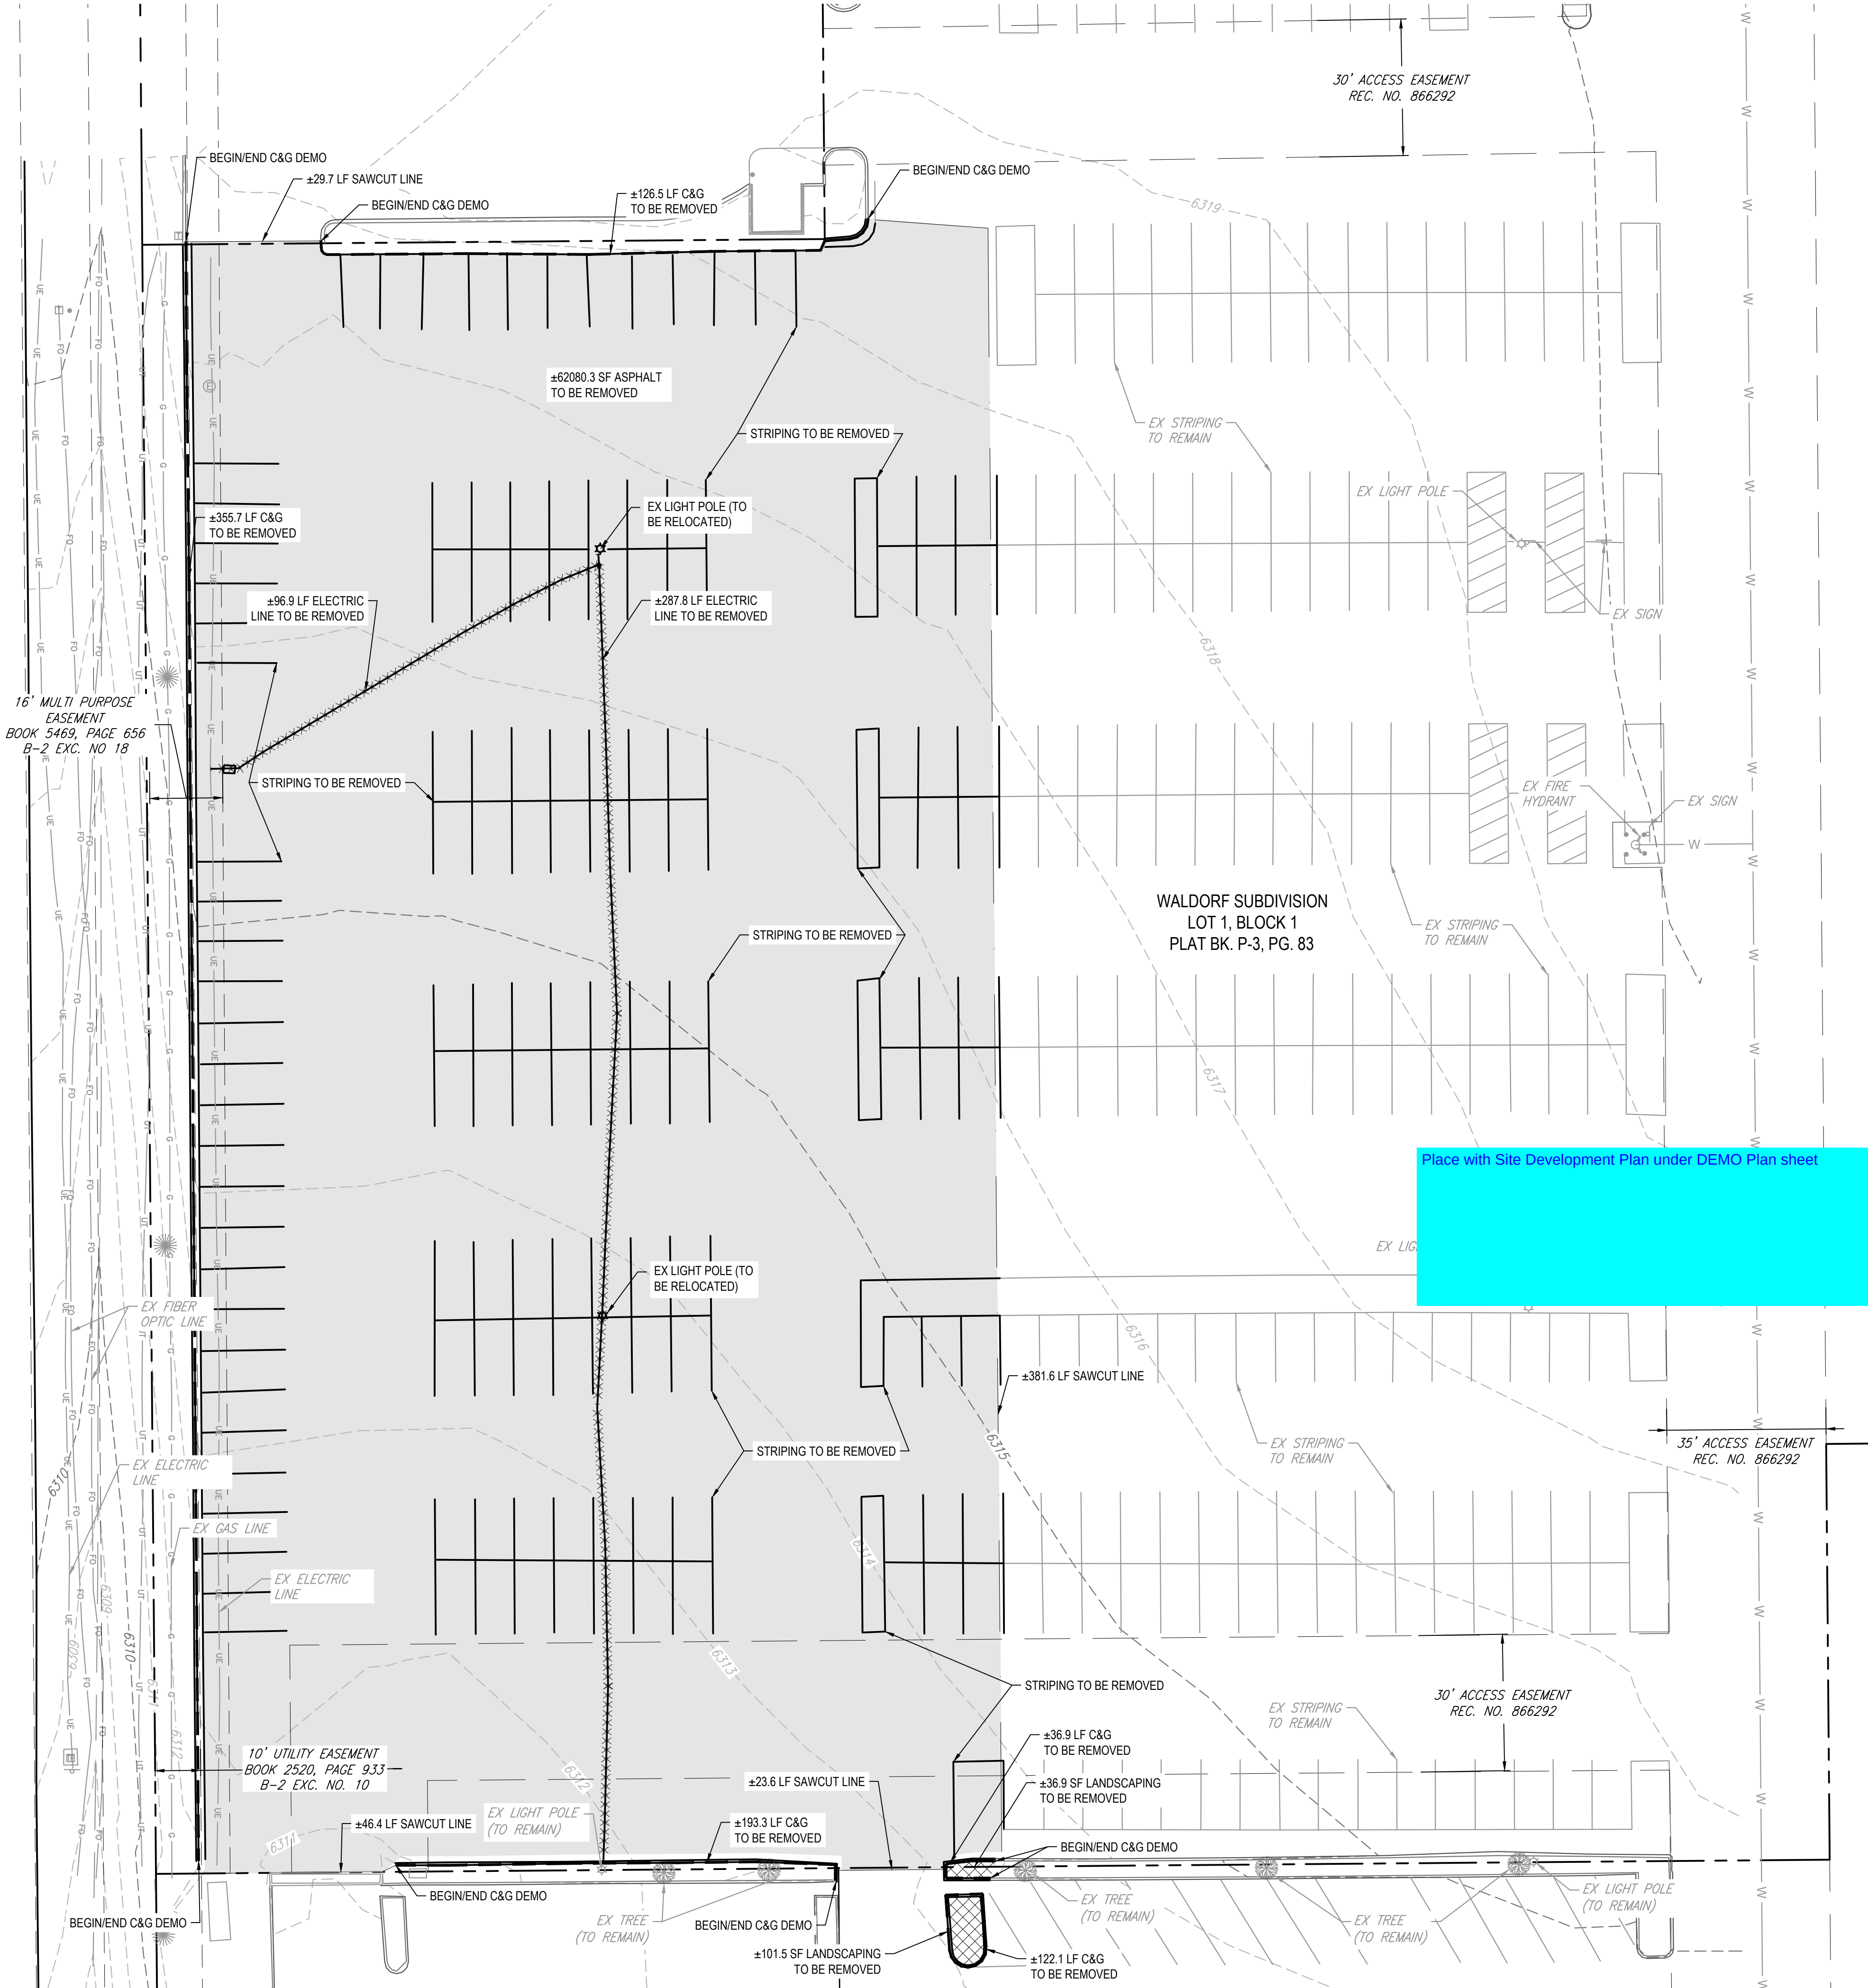

NOTES:


1. CONTRACTOR TO VERIFY HORIZONTAL AND VERTICAL LOCATION OF ALL UTILITIES PRIOR TO COMMENCING CONSTRUCTION ACTIVITIES.
2. CONTRACTOR TO PROTECT IN PLACE ALL FEATURES TO REMAIN.
3. CONTRACTOR TO INSTALL ALL STORM CONTROL MEASURES PRIOR TO COMMENCING DEMOLITION.
4. CONTRACTOR SHALL RELOCATE AND/OR ADJUST ELEVATIONS OF EXISTING UTILITIES AS NECESSARY TO ENSURE COMPLETION OF PROPOSED IMPROVEMENT AND NOT INTERFERE WITH OTHER UTILITIES, ROADWAY OR PEDESTRIAN FACILITIES. UTILITY ON GRADE MUST BE LOCATED WITHIN LANDSCAPE AREAS. CONTRACTOR TO COORDINATE WITH EACH UTILITY PURVEYOR TO CONFIRM CONTRACTOR/PURVEYOR RESPONSIBILITIES OF RELOCATION OF EXISTING UTILITIES.

LEGEND:

- PROPERTY LINE
- EX UTILITY TO BE REMOVED
- EX CURB TO BE REMOVED
- SAWCUT LINE
- EX ASPHALT TO BE REMOVED
- EX LANDSCAPE AREA TO BE REMOVED

ITEM TO BE REMOVED	QUANTITY	
ASPHALT	62,080	SF
CURB & GUTTER	835	LF
SAWCUT	481	LF
LANDSCAPING	138	SF
ELECTRIC LINE	385	LF
LIGHT POLE	2	EACH

Placed with Site Development Plan, Named DEMO PLAN sheet, Page 3

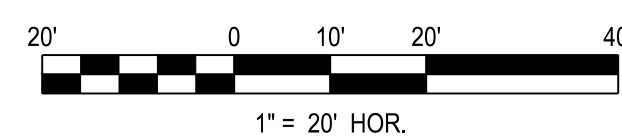

CONSTRUCTION DOCUMENTS

CHICK-FIL-A
POWERS & PALMER PARK
SEC OF POWERS BLVD AND PALMER
PARK BLVD COLORADO SPRINGS, CO 80915

FSR#05934

BUILDING TYPE / SIZE: P12 LS LRG
RELEASE: vX.YY.MM

REVISION SCHEDULE		
NO.	DATE	DESCRIPTION

CONSULTANT PROJECT #
PRINTED FOR
DATE 01/31/2024
DRAWN BY CSS
SHEET
DEMO PLAN

SHEET NUMBER

C1.0

Chick-fil-A
5200 Buffington Road
Atlanta, Georgia 30349-2998

MERRICK®
5970 GREENWOOD PLAZA BLVD
GREENWOOD VILLAGE, CO 80111
303-751-0741


FOR AND ON BEHALF OF
MERRICK AND COMPANY



POWERS BOULEVARD
(174' R.O.W.)
REC. NO. 202065502

10.0" UTILITY EASEMENT
BOOK 2520, PAGE 9.33
B-2 EXC. NO. 10

10.0" UTILITY EASEMENT
BOOK 2520, PAGE 9.33
B-2 EXC. NO. 10

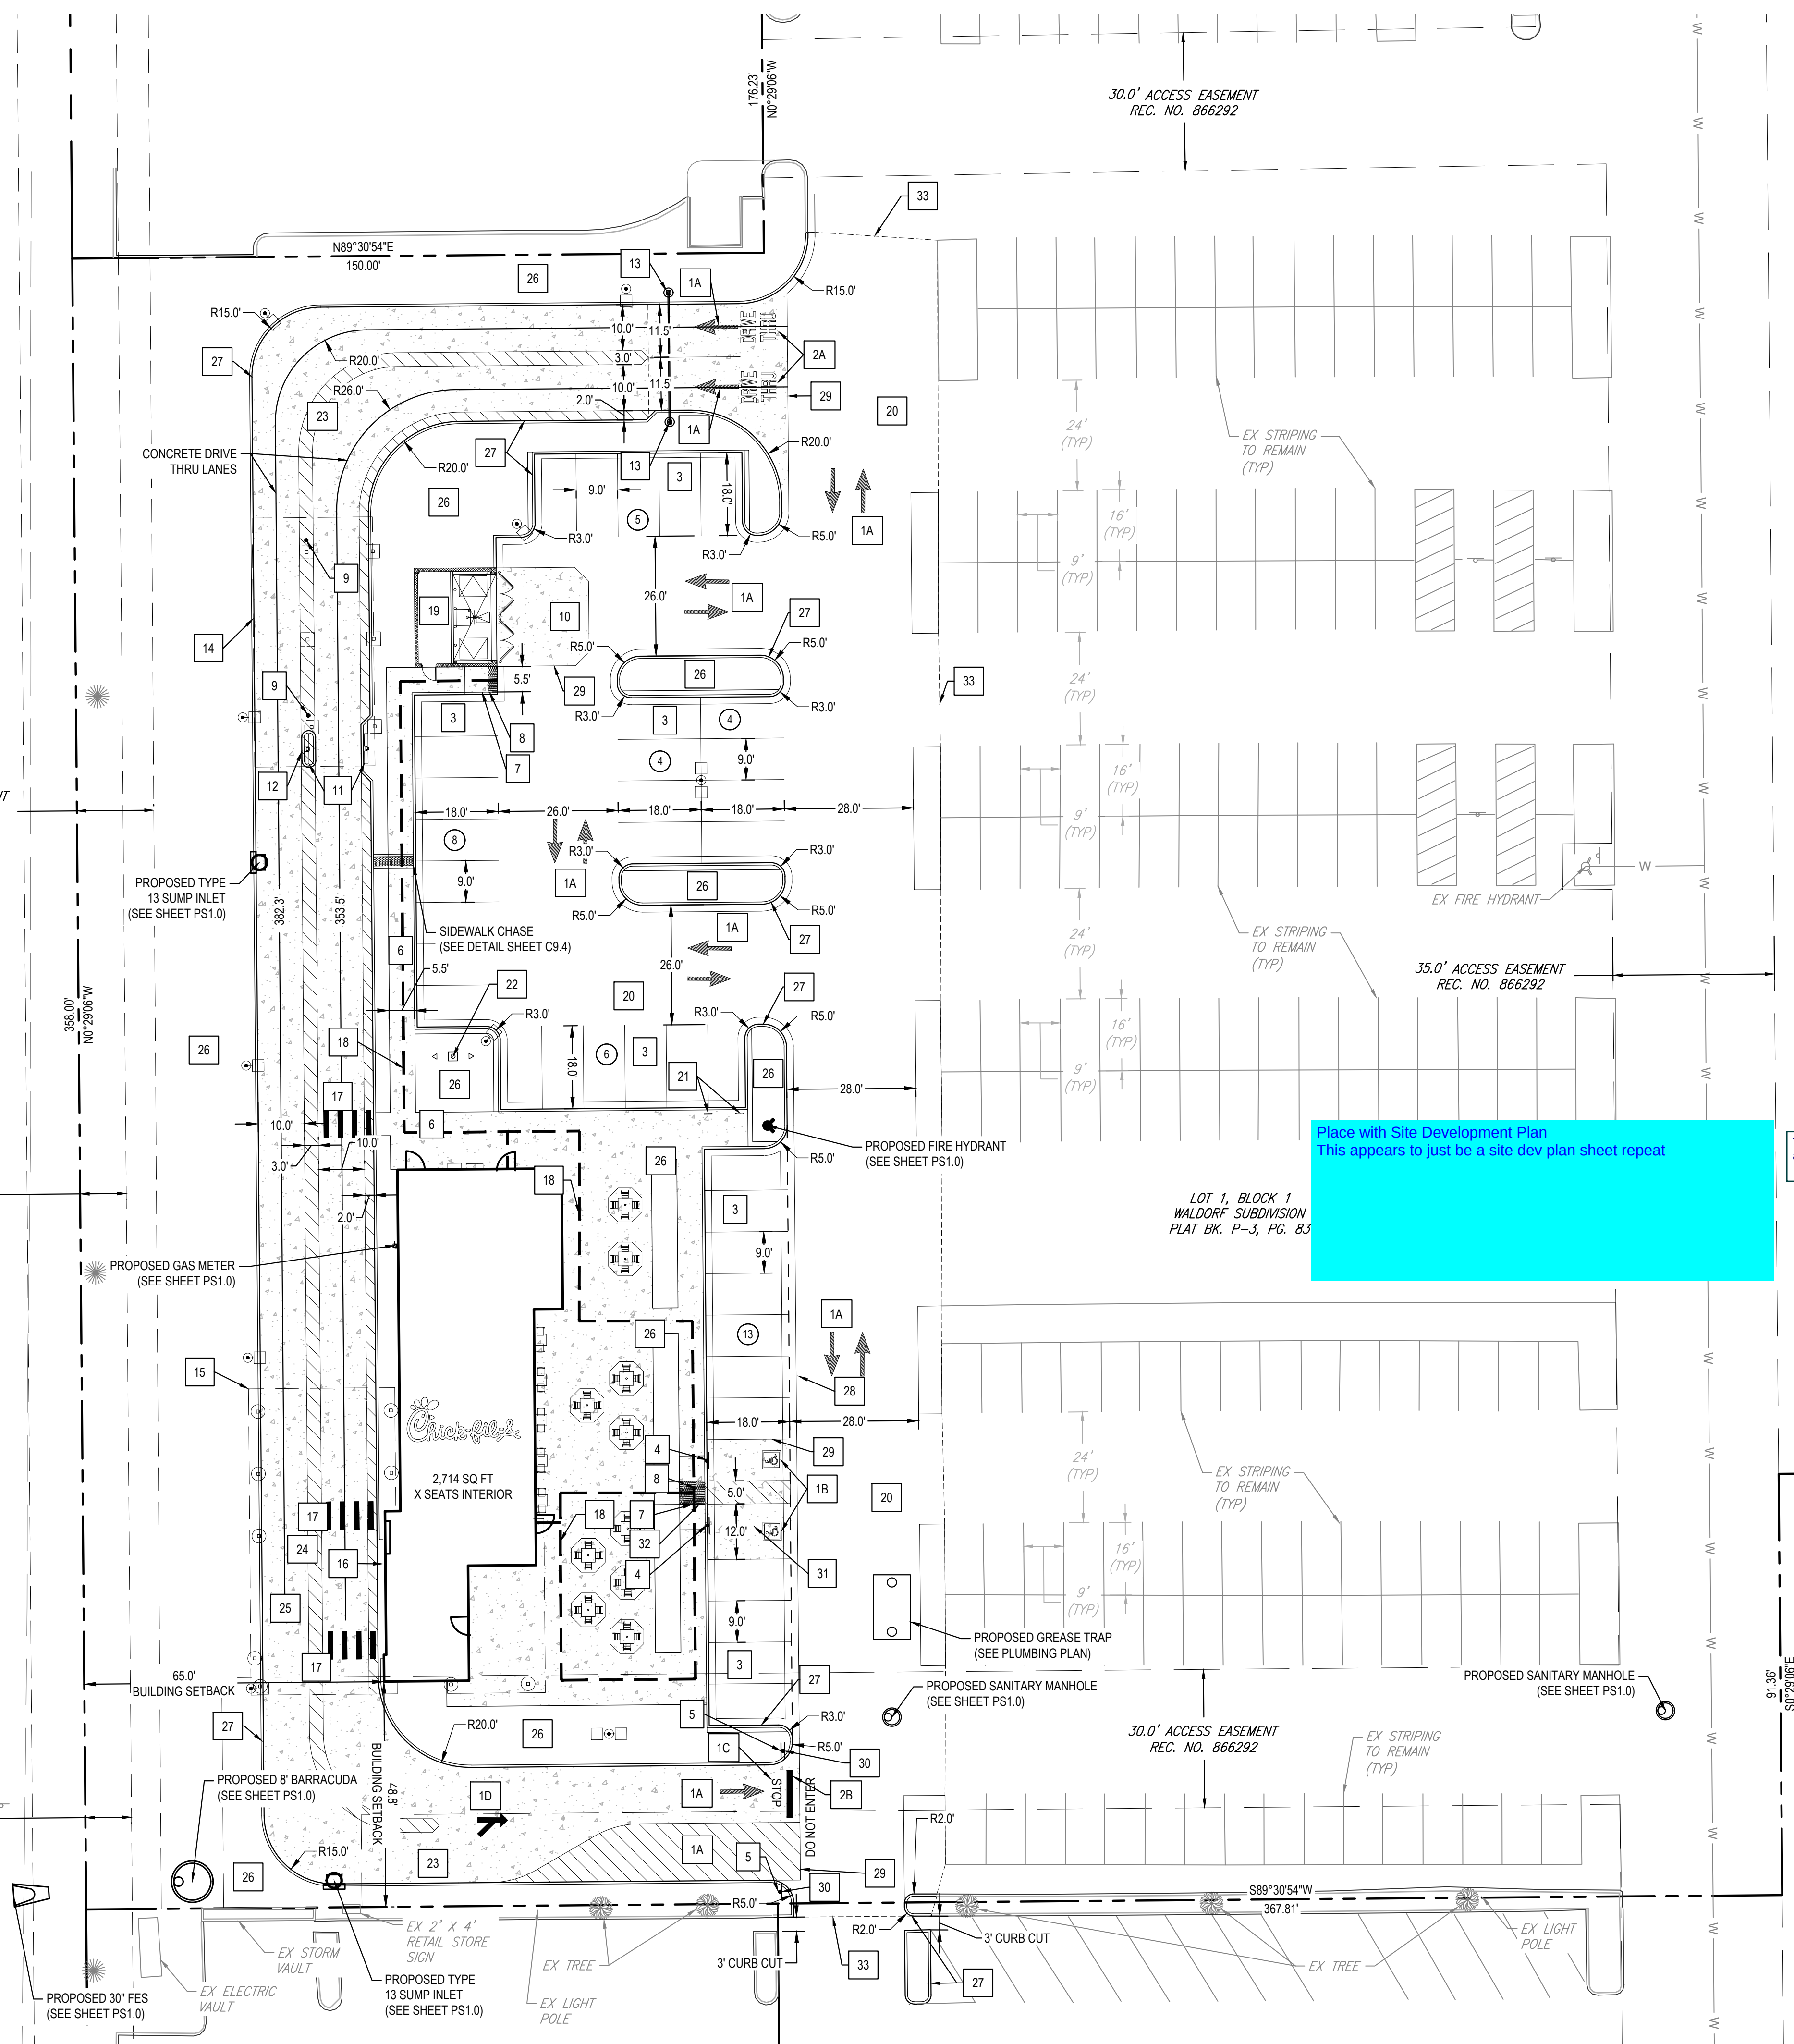


NOTES:

- ALL DIMENSIONS ARE FROM FLOWLINE UNLESS OTHERWISE NOTED.
- REFER TO ARCHITECTURE PLANS FOR CANOPY INFORMATION.
- REFER TO SIGNAGE PACKAGE FOR ALL SITE AND CHICK-FIL-A SIGN DETAILS.
- ALL CURB ALONG CONCRETE DRIVE THROUGH TO BE MONOLITHICALLY POURED WITH DRIVE THROUGH.
- STRIPING ON ASPHALT TO BE WHITE PAINT AND STRIPING ON CONCRETE TO BE YELLOW PAINT.


SITE PLAN DESIGN NOTES & KEY PLAN

- PAVEMENT MARKINGS - 1
 - DIRECTIONAL ARROW
 - ACCESSIBILITY SYMBOL
 - STOP
 - MULTILANE DIRECTIONAL ARROW
- PAVEMENT MARKINGS - 2
 - DRIVE-THRU
 - STOP BAR
- 90 DEGREE PARKING STRIPING
- ACCESSIBLE PARKING SIGN
- STOP SIGN
- CONCRETE SIDEWALK
- SIDEWALK ACCESSIBLE RAMP
- DETECTABLE WARNING DEVICE
- CONCRETE BOLLARD
- CONCRETE APRON @ TRASH ENCLOSURE
- MENU BOARD LOOP DETECTION SYSTEM
- DRIVE-THRU ORDER POINT ISLAND
- DRIVE-THRU CLEARANCE BAR
- ORDER POINT CANOPY
- MEAL DELIVERY CANOPY
- TORMAX DOOR
- CROSSWALK MARKINGS
- ACCESSIBLE ACCESS PATH
- SCREENED REFUSE ENCLOSURE (SEE ARCH PLANS)
- TYPICAL HMAC PAVEMENT SECTION
- BIKE RACKS
- FLAG POLE
- CONCRETE PAVEMENT DRIVE-THRU LANE
- DRIVE-THRU PLAN - FLUSH WITH FFE
- DRIVE-THRU ISOMETRIC
- LANDSCAPED AREA
- CONCRETE CURB & GUTTER
- CONCRETE CROSS PAN
- PAVEMENT EDGE DETAIL
- DO NOT ENTER SIGN
- CONCRETE PAVEMENT
- CURB RAMP w/ FLARED SIDES
- SAWCUT LINE
- X PARKING STALL COUNT

PROJECT DATA TABLE		
ITEM	REQUIRED	PROPOSED
ZONING	CC	CC
PROPERTY AREA		
GROSS SF		91,912
GROSS AC		2.11
BUILDING SQ FT		5,663
PATIO SQ FT		558
BUILDING + PATIO SQ FT		6,221
PARKING		
CALCULATION	6,221 S.F. / 150 S.F. PER STALL	
STANDARD STALLS	40	72
ACCESSIBLE STALLS	2	4
TOTAL	42	76
BICYCLE	3	4
BUILDING SET BACK (FT)		
NORTH	0	0
SOUTH	0	0
EAST	0	0
WEST	25	25
LANDSCAPE SET BACK (FT)		
NORTH	0	0
SOUTH	0	0
EAST	0	0
WEST	25	25

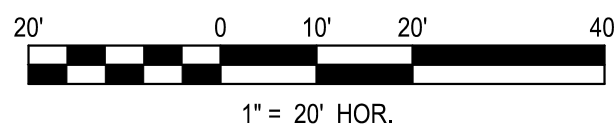

CONSTRUCTION DOCUMENTS

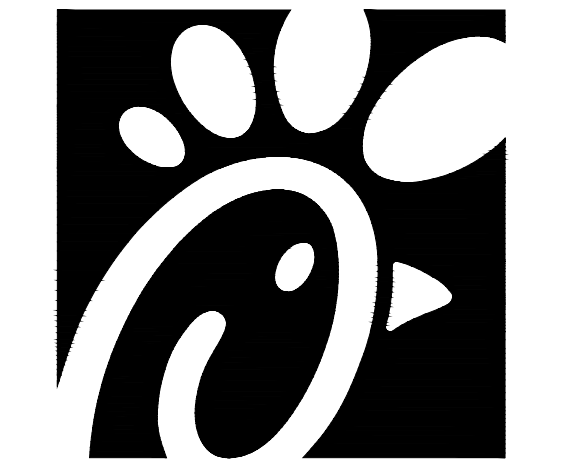

Chick-fil-A
5200 Buffington Road
Atlanta, Georgia 30349-2998



FOR AND ON BEHALF OF
MERRICK AND COMPANY

CHICK-FIL-A
POWERS & PALMER PARK
SEC OF POWERS BLVD AND PALMER
PARK BLVD COLORADO SPRINGS, CO 80915

FSR#05934

BUILDING TYPE / SIZE: P12 LS LRG
RELEASE: VX.YY.MM

REVISION SCHEDULE
NO. DATE DESCRIPTION

CONSULTANT PROJECT #

PRINTED FOR

DATE 01/31/2024


DRAWN BY CSS

SHEET

SITE PLAN

SHEET NUMBER

C2.0

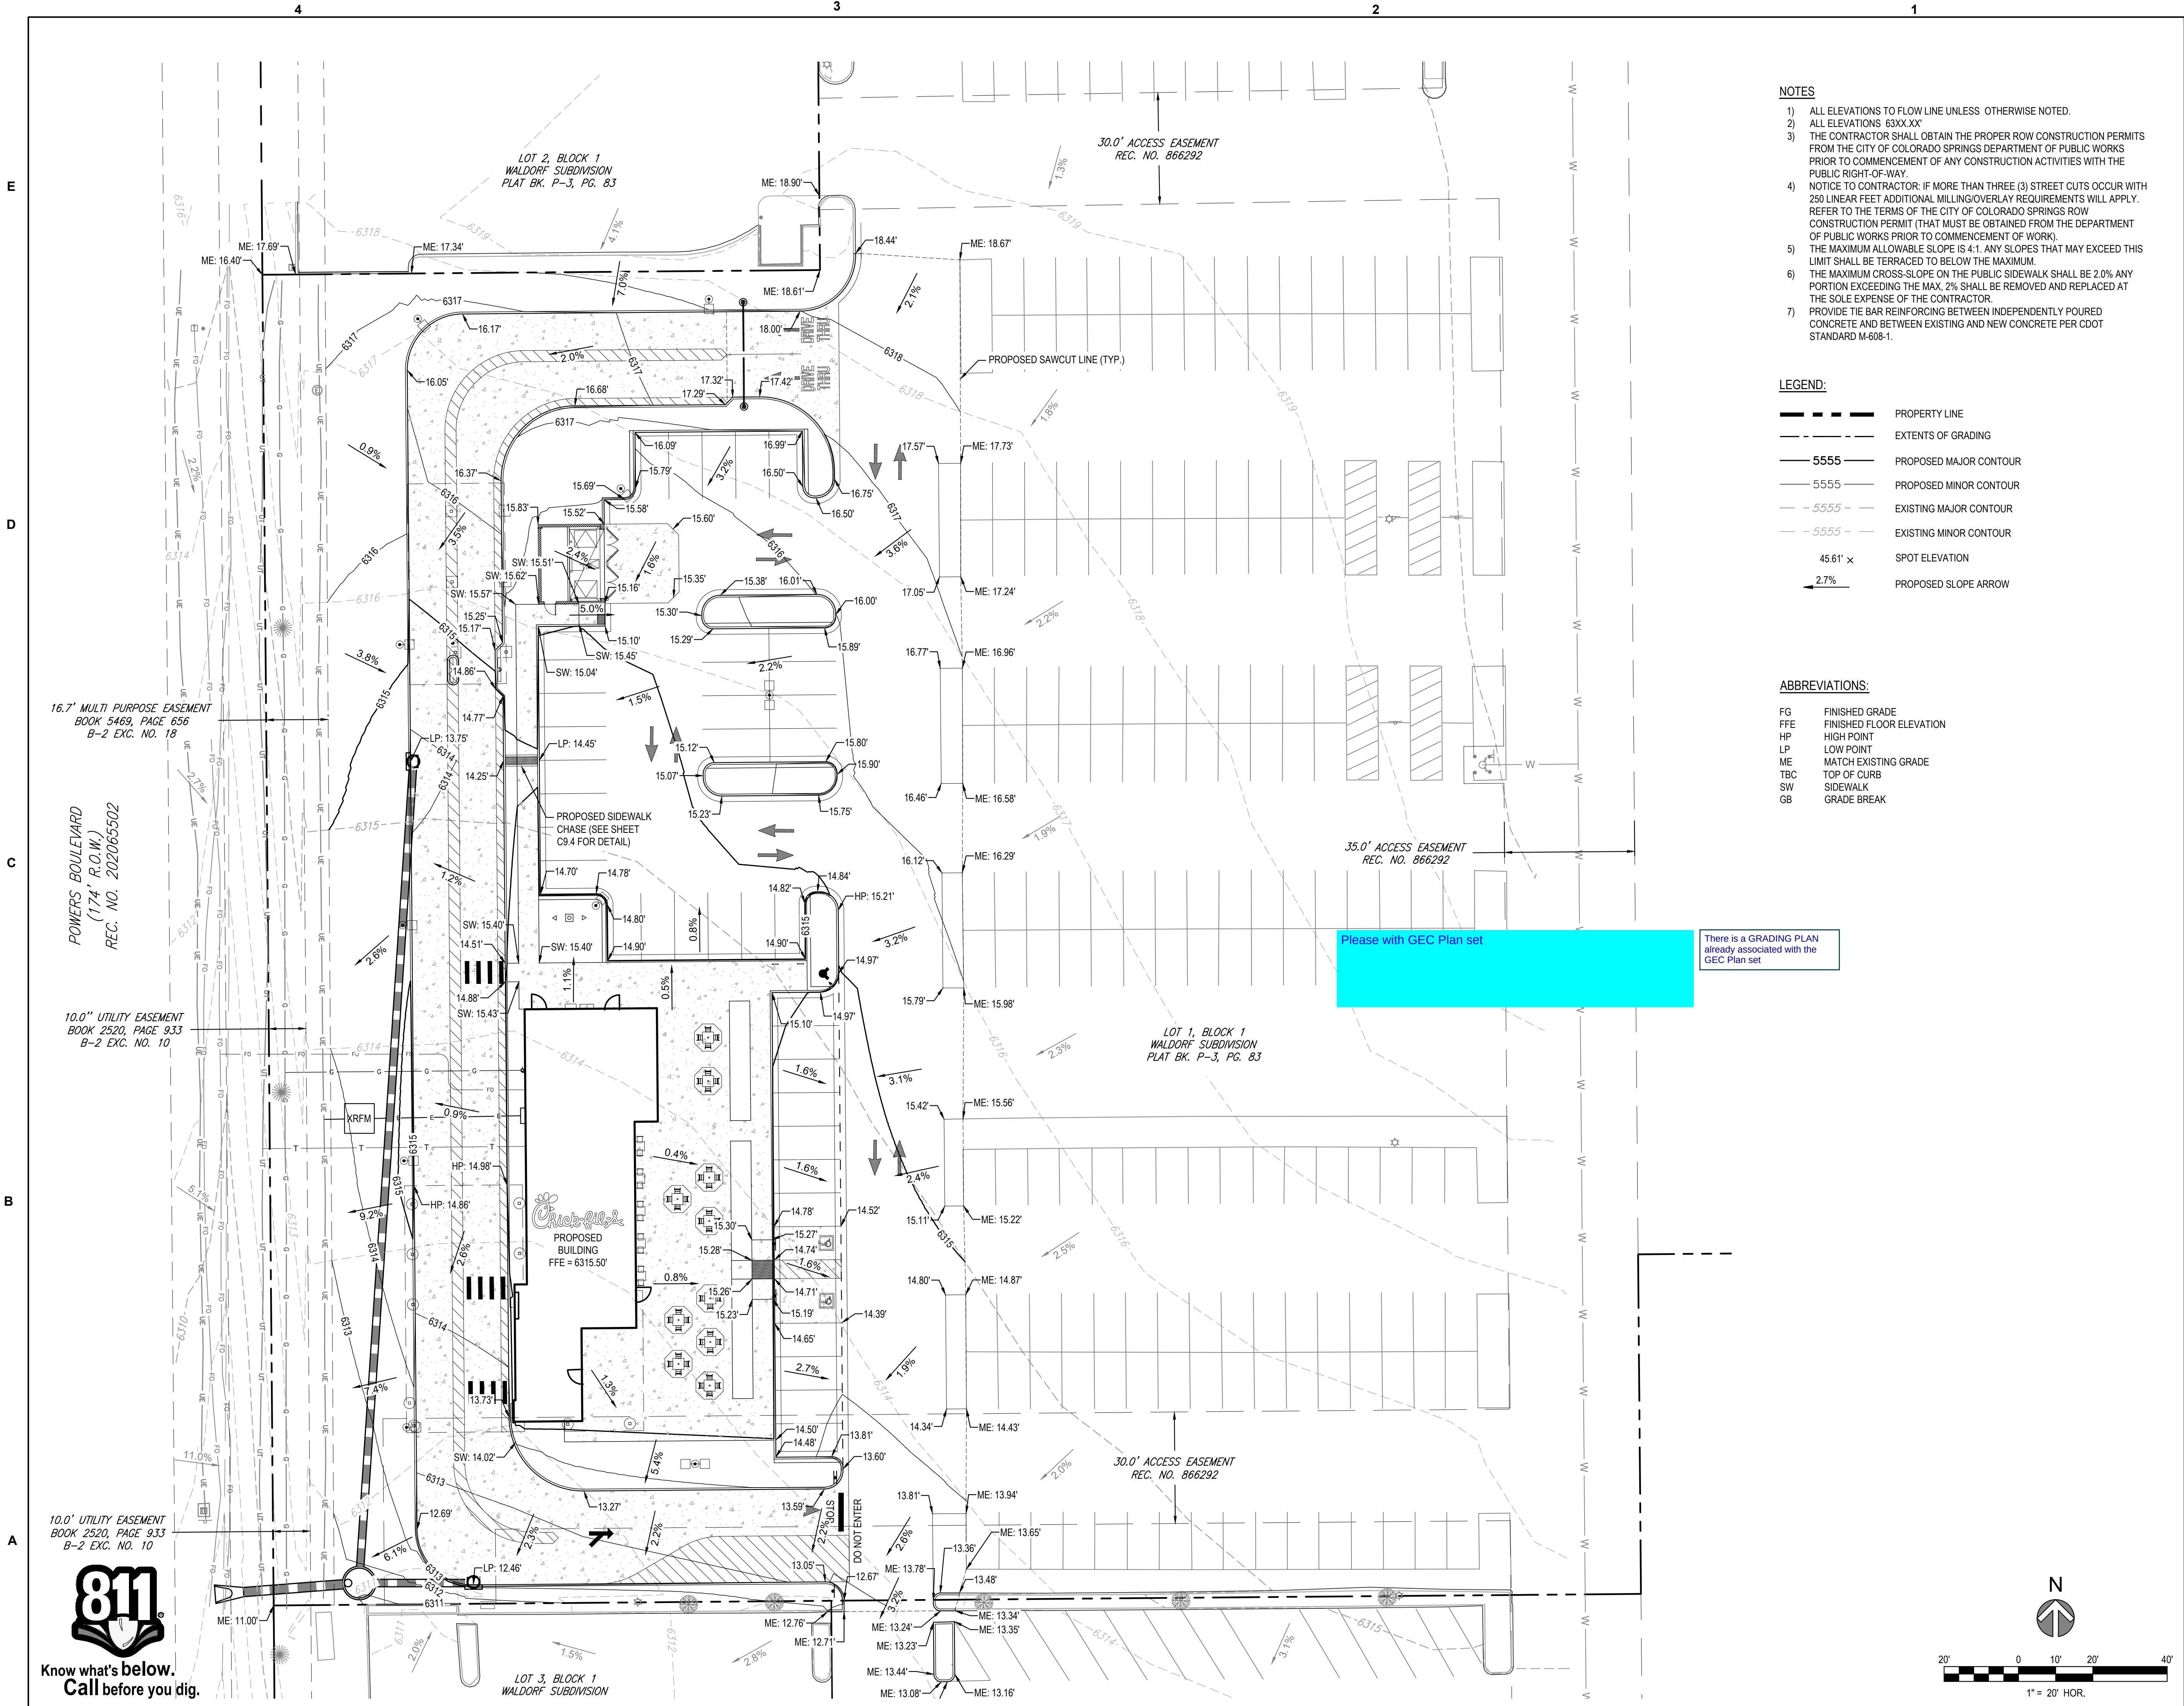

NOTES


- 1) ALL ELEVATIONS TO FLOW LINE UNLESS OTHERWISE NOTED.
- 2) ALL ELEVATIONS 63XX.XX
- 3) THE CONTRACTOR SHALL OBTAIN THE PROPER ROW CONSTRUCTION PERMITS FROM THE CITY OF COLORADO SPRINGS DEPARTMENT OF PUBLIC WORKS PRIOR TO COMMENCEMENT OF ANY CONSTRUCTION ACTIVITIES WITH THE PUBLIC RIGHT-OF-WAY.
- 4) NOTICE TO CONTRACTOR: IF MORE THAN THREE (3) STREET CUTS OCCUR WITH 250 LINEAR FEET ADDITIONAL MILLING/OVERLAY REQUIREMENTS WILL APPLY. REFER TO THE TERMS OF THE CITY OF COLORADO SPRINGS ROW CONSTRUCTION PERMIT (THAT MUST BE OBTAINED FROM THE DEPARTMENT OF PUBLIC WORKS PRIOR TO COMMENCEMENT OF WORK).
- 5) THE MAXIMUM ALLOWABLE SLOPE IS 4:1. ANY SLOPES THAT MAY EXCEED THIS LIMIT SHALL BE TERRACED TO BELOW THE MAXIMUM.
- 6) THE MAXIMUM CROSS-SLOPE ON THE PUBLIC SIDEWALK SHALL BE 2.0% ANY PORTION EXCEEDING THE MAX. 2% SHALL BE REMOVED AND REPLACED AT THE SOLE EXPENSE OF THE CONTRACTOR.
- 7) PROVIDE TIE BAR REINFORCING BETWEEN INDEPENDENTLY POURED CONCRETE AND BETWEEN EXISTING AND NEW CONCRETE PER CDOT STANDARD M-608-1.

LEGEND:

---	PROPERTY LINE
- - - -	EXTENTS OF GRADING
5555	PROPOSED MAJOR CONTOUR
5555	PROPOSED MINOR CONTOUR
- 5555 -	EXISTING MAJOR CONTOUR
- 5555 -	EXISTING MINOR CONTOUR
45.61' x	SPOT ELEVATION
2.7%	PROPOSED SLOPE ARROW


ABBREVIATIONS:

FG	FINISHED GRADE
FFE	FINISHED FLOOR ELEVATION
HP	HIGH POINT
LP	LOW POINT
ME	MATCH EXISTING GRADE
TBC	TOP OF CURB
SW	SIDEWALK
GB	GRADE BREAK

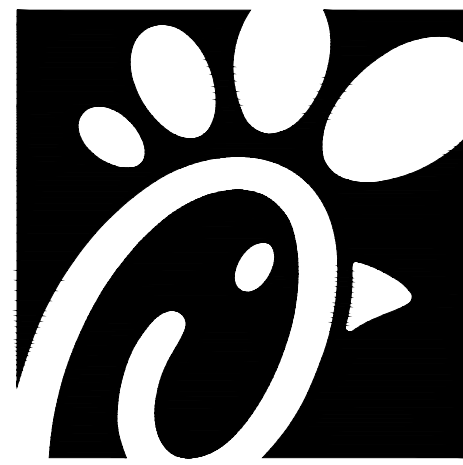

Chick-fil-A

Chick-fil-A
5200 Buffington Road
Atlanta, Georgia 30349-2998

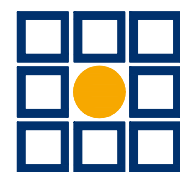

MERRICK®

5970 GREENWOOD PLAZA BLVD
GREENWOOD VILLAGE, CO 80111
303-751-0741

FOR AND ON BEHALF OF
MERRICK AND COMPANY

CONSTRUCTION DOCUMENTS

CHICK-FIL-A POWERS & PALMER PARK

SEC OF POWERS BLVD AND PALMER
PARK BLVD COLORADO SPRINGS, CO 80915

FSR#05934

BUILDING TYPE / SIZE: P12 LS LRG
RELEASE: V.X.YY.MM

REVISION SCHEDULE
NO. DATE DESCRIPTION

CONSULTANT PROJECT #

PRINTED FOR

DATE 01/31/2024


DRAWN BY CSS

SHEET

GRADING PLAN



SHEET NUMBER

C3.0

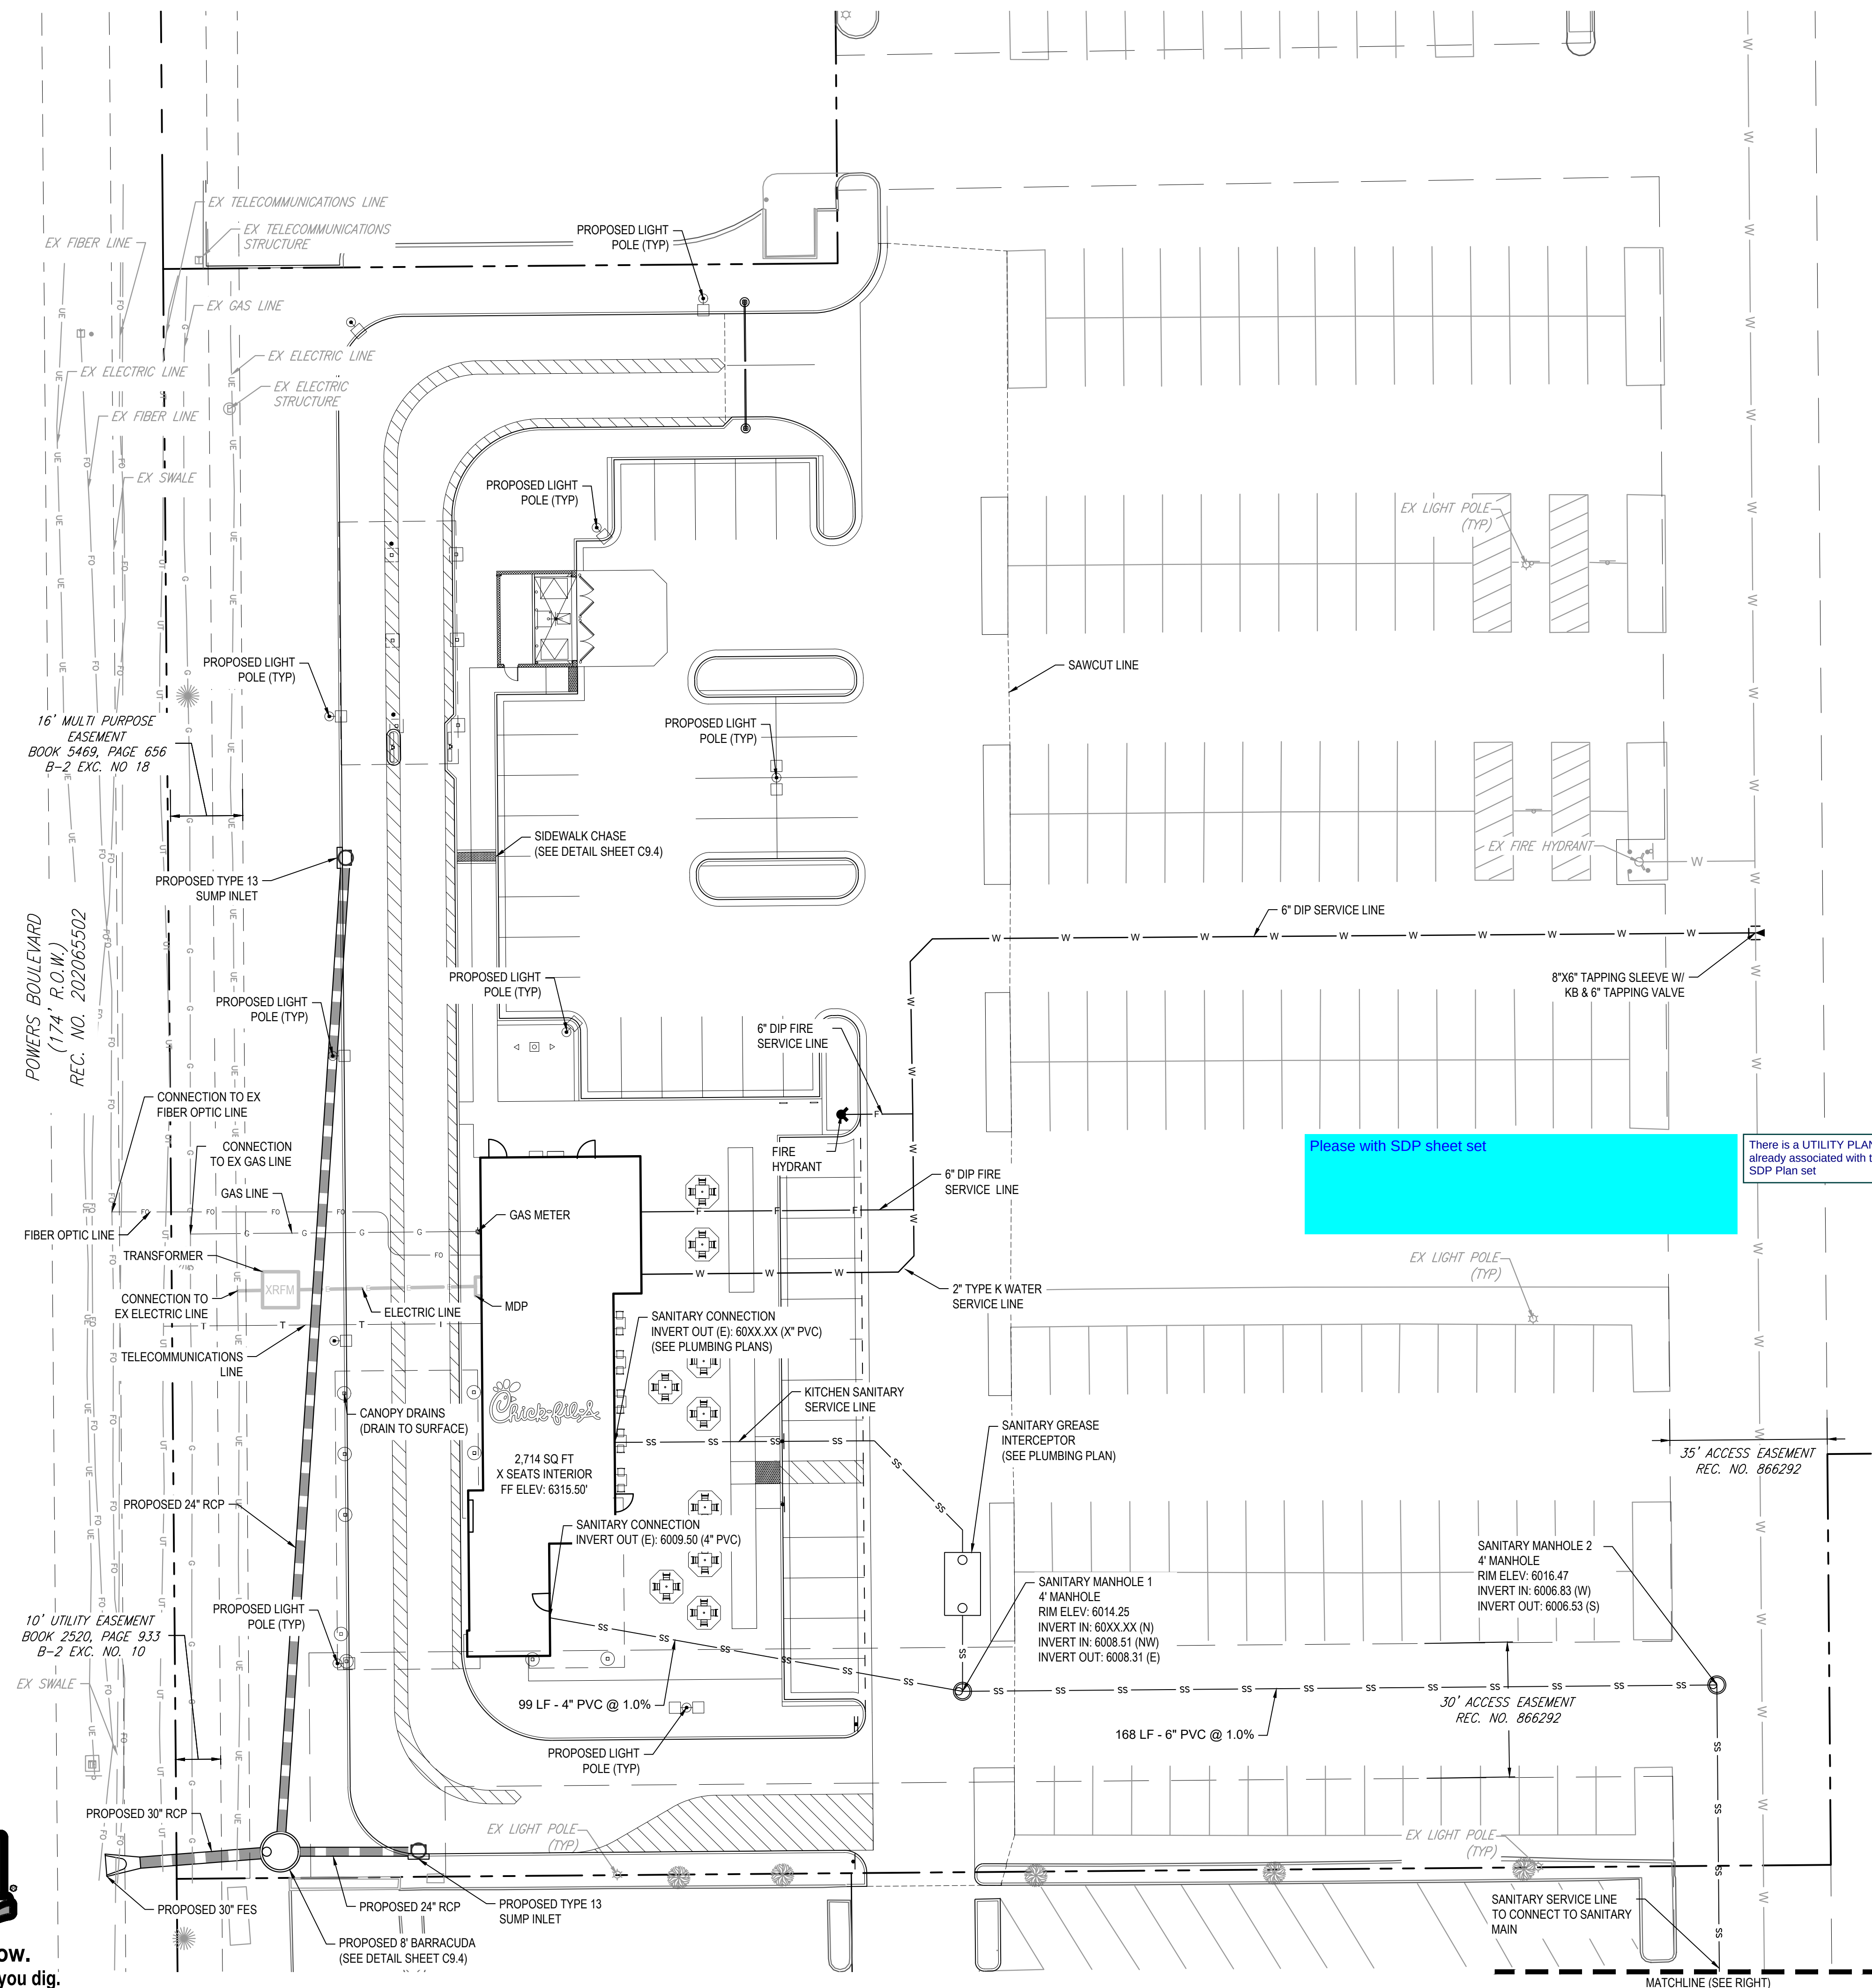

NOTES:

1. REFER TO THE COVER SHEET FOR STANDARDS NOTES, LEGEND, AND ABBREVIATIONS.
2. CONTRACTOR TO FIELD VERIFY VERTICAL AND HORIZONTAL LOCATION PRIOR TO COMMENCING CONSTRUCTION. NOTIFY ENGINEER IF DEPTH OF EXISTING SERVICE LINE VARIES BY MORE THAN 3" FROM ELEVATION SHOWN.
3. SANITARY LINE TO BE SURVEYED AND DATA COLLECTED IN FUTURE SUBMITTAL.

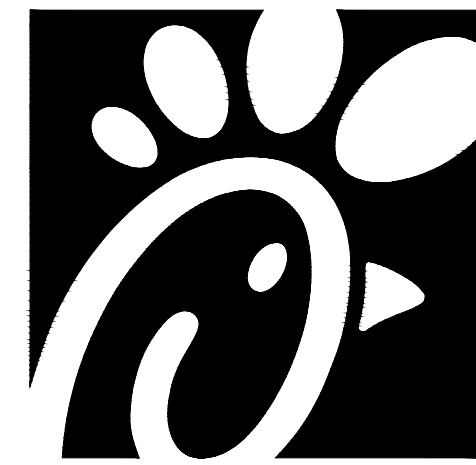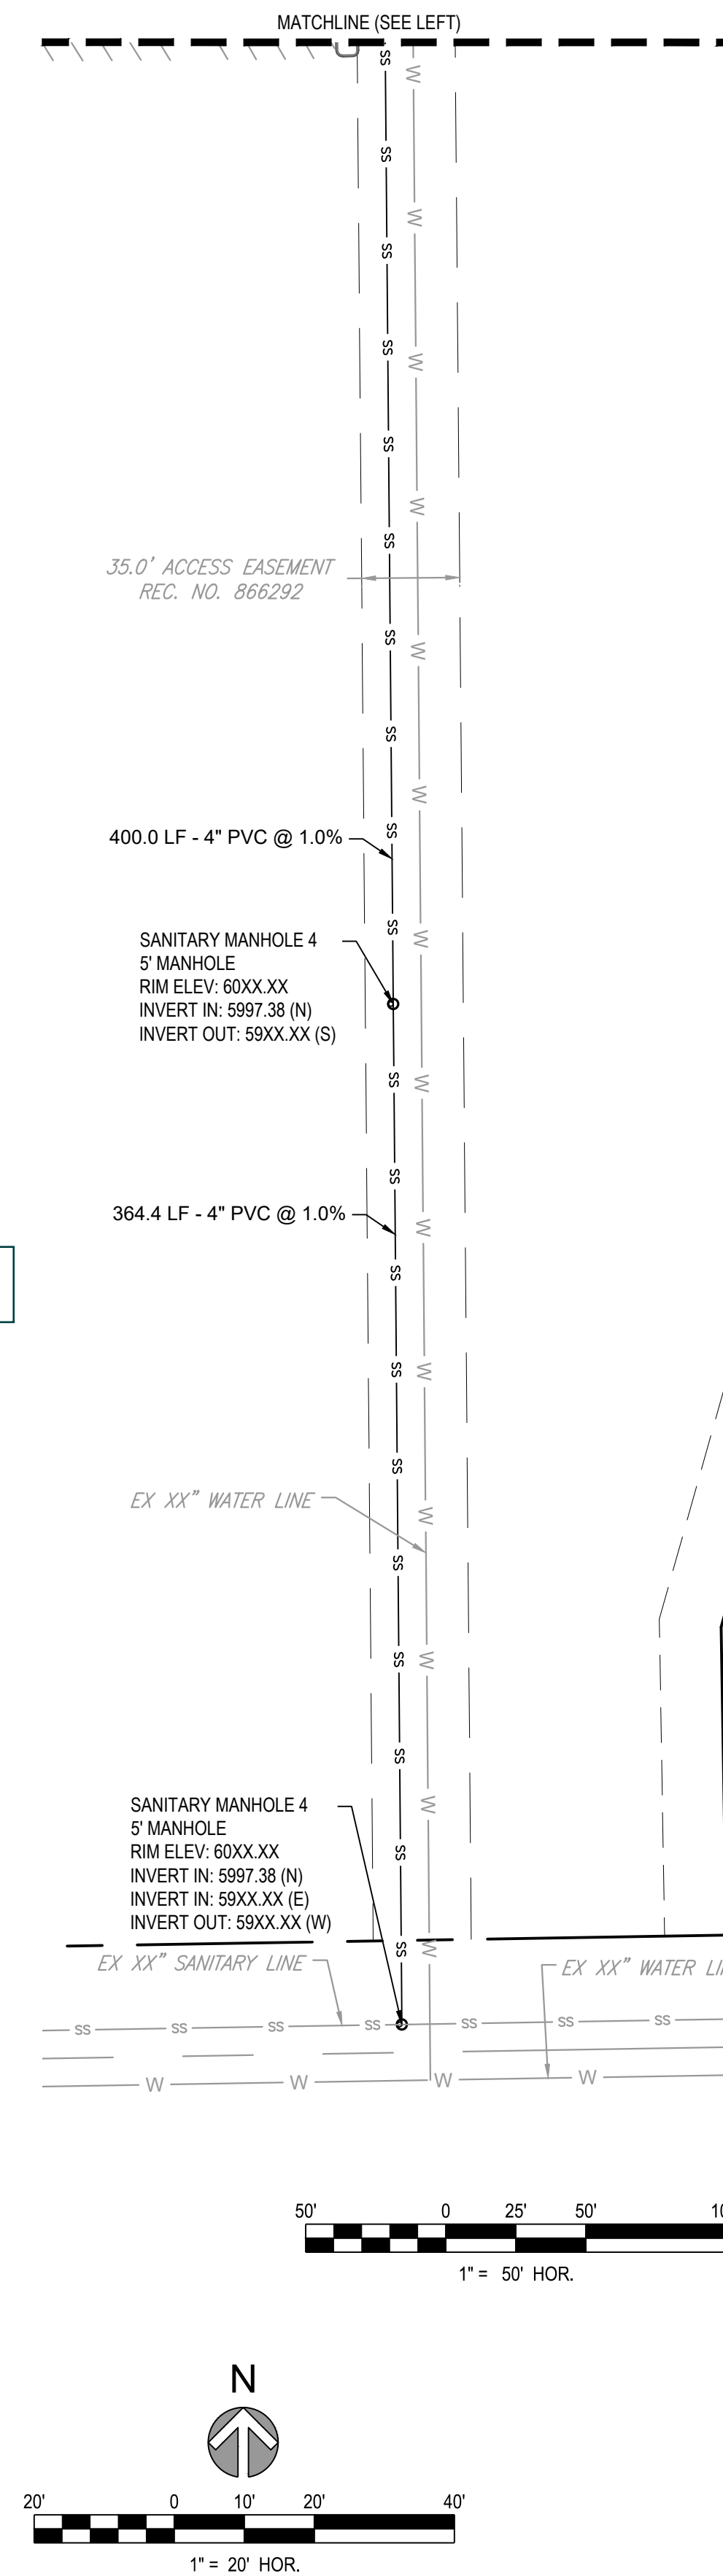

Chick-fil-A
5200 Buffington Road
Atlanta, Georgia 30349-
2998



FOR AND ON-BEHALF OF
MERRICK AND COMPANY

CHICK-FIL-A

**SEC OF POWERS BLVD AND PALMER
PARK BLVD COLORADO SPRINGS, CO 80915**

FSR#05934

BUILDING TYPE / SIZE: P12 LS LRG
RELEASE: vX.YY.MM

REVISION SCHEDULE		
NO.	DATE	DESCRIPTION

CONSULTANT PROJECT #	
PRINTED FOR	
DATE	01/31/2024
DRAWN BY	CSS
SHEET	
UTILITY PLAN	



SHEET NUMBER

PS1.0

File Path: Q:\DEN\Projects\100810.00 CFA Powers & Palmer\CAD\CDS\100810 - C4.0 - CD - STORM P&P.dwg Last Saved
By: CHRISTIAN SCHILDER
1/31/2025 10:00 AM
00-LS-0000-A101-SHEET NAME




Know what's below.
Call before you dig.

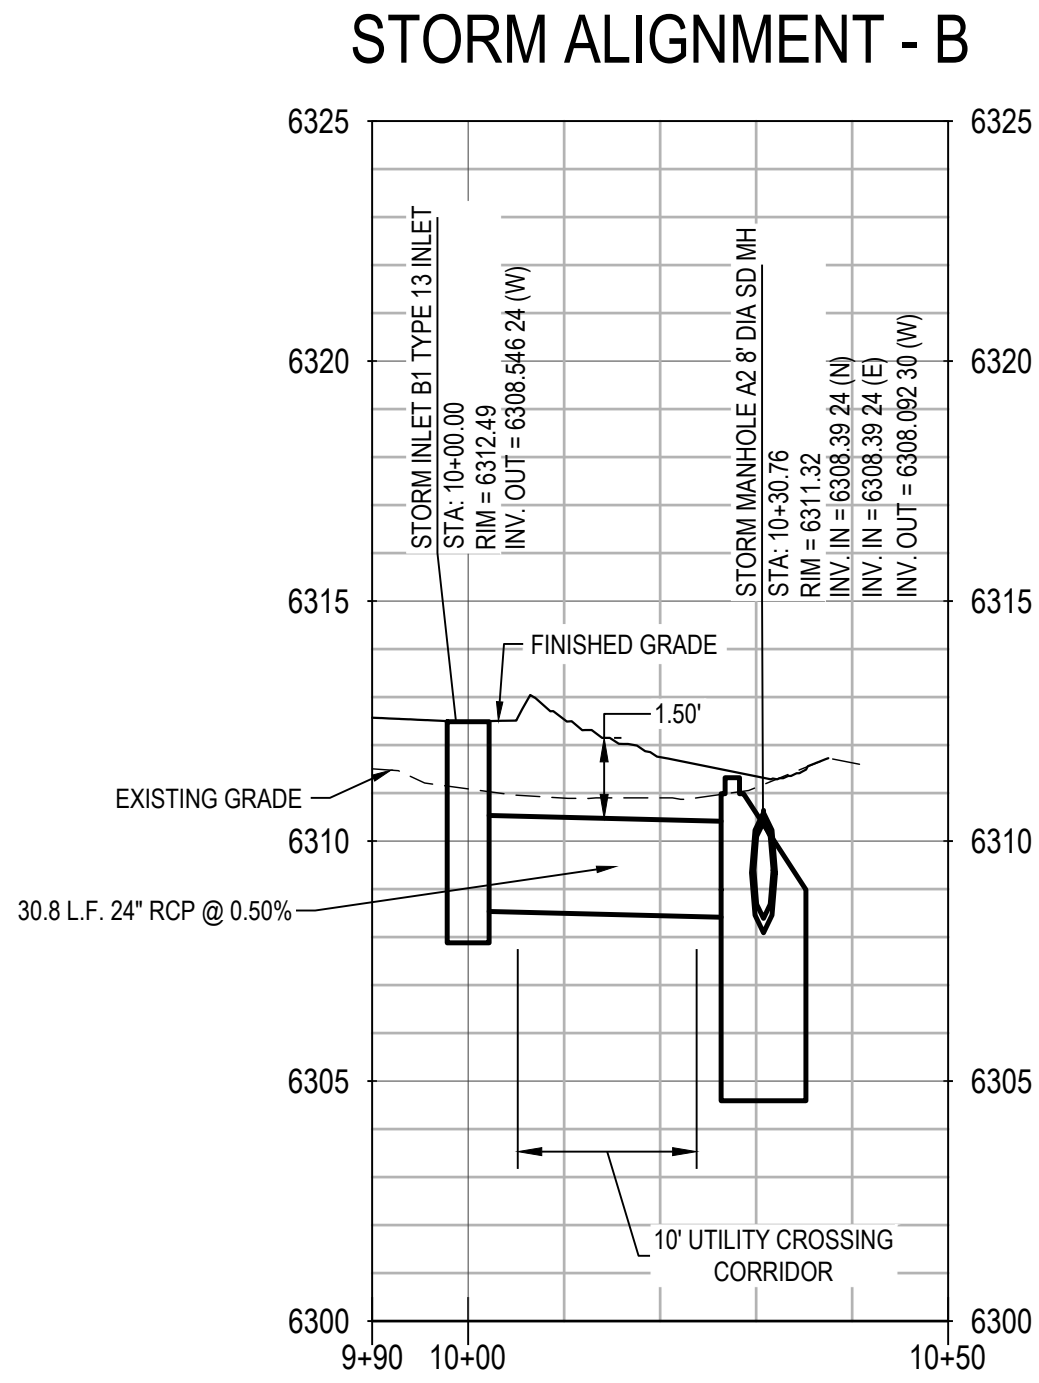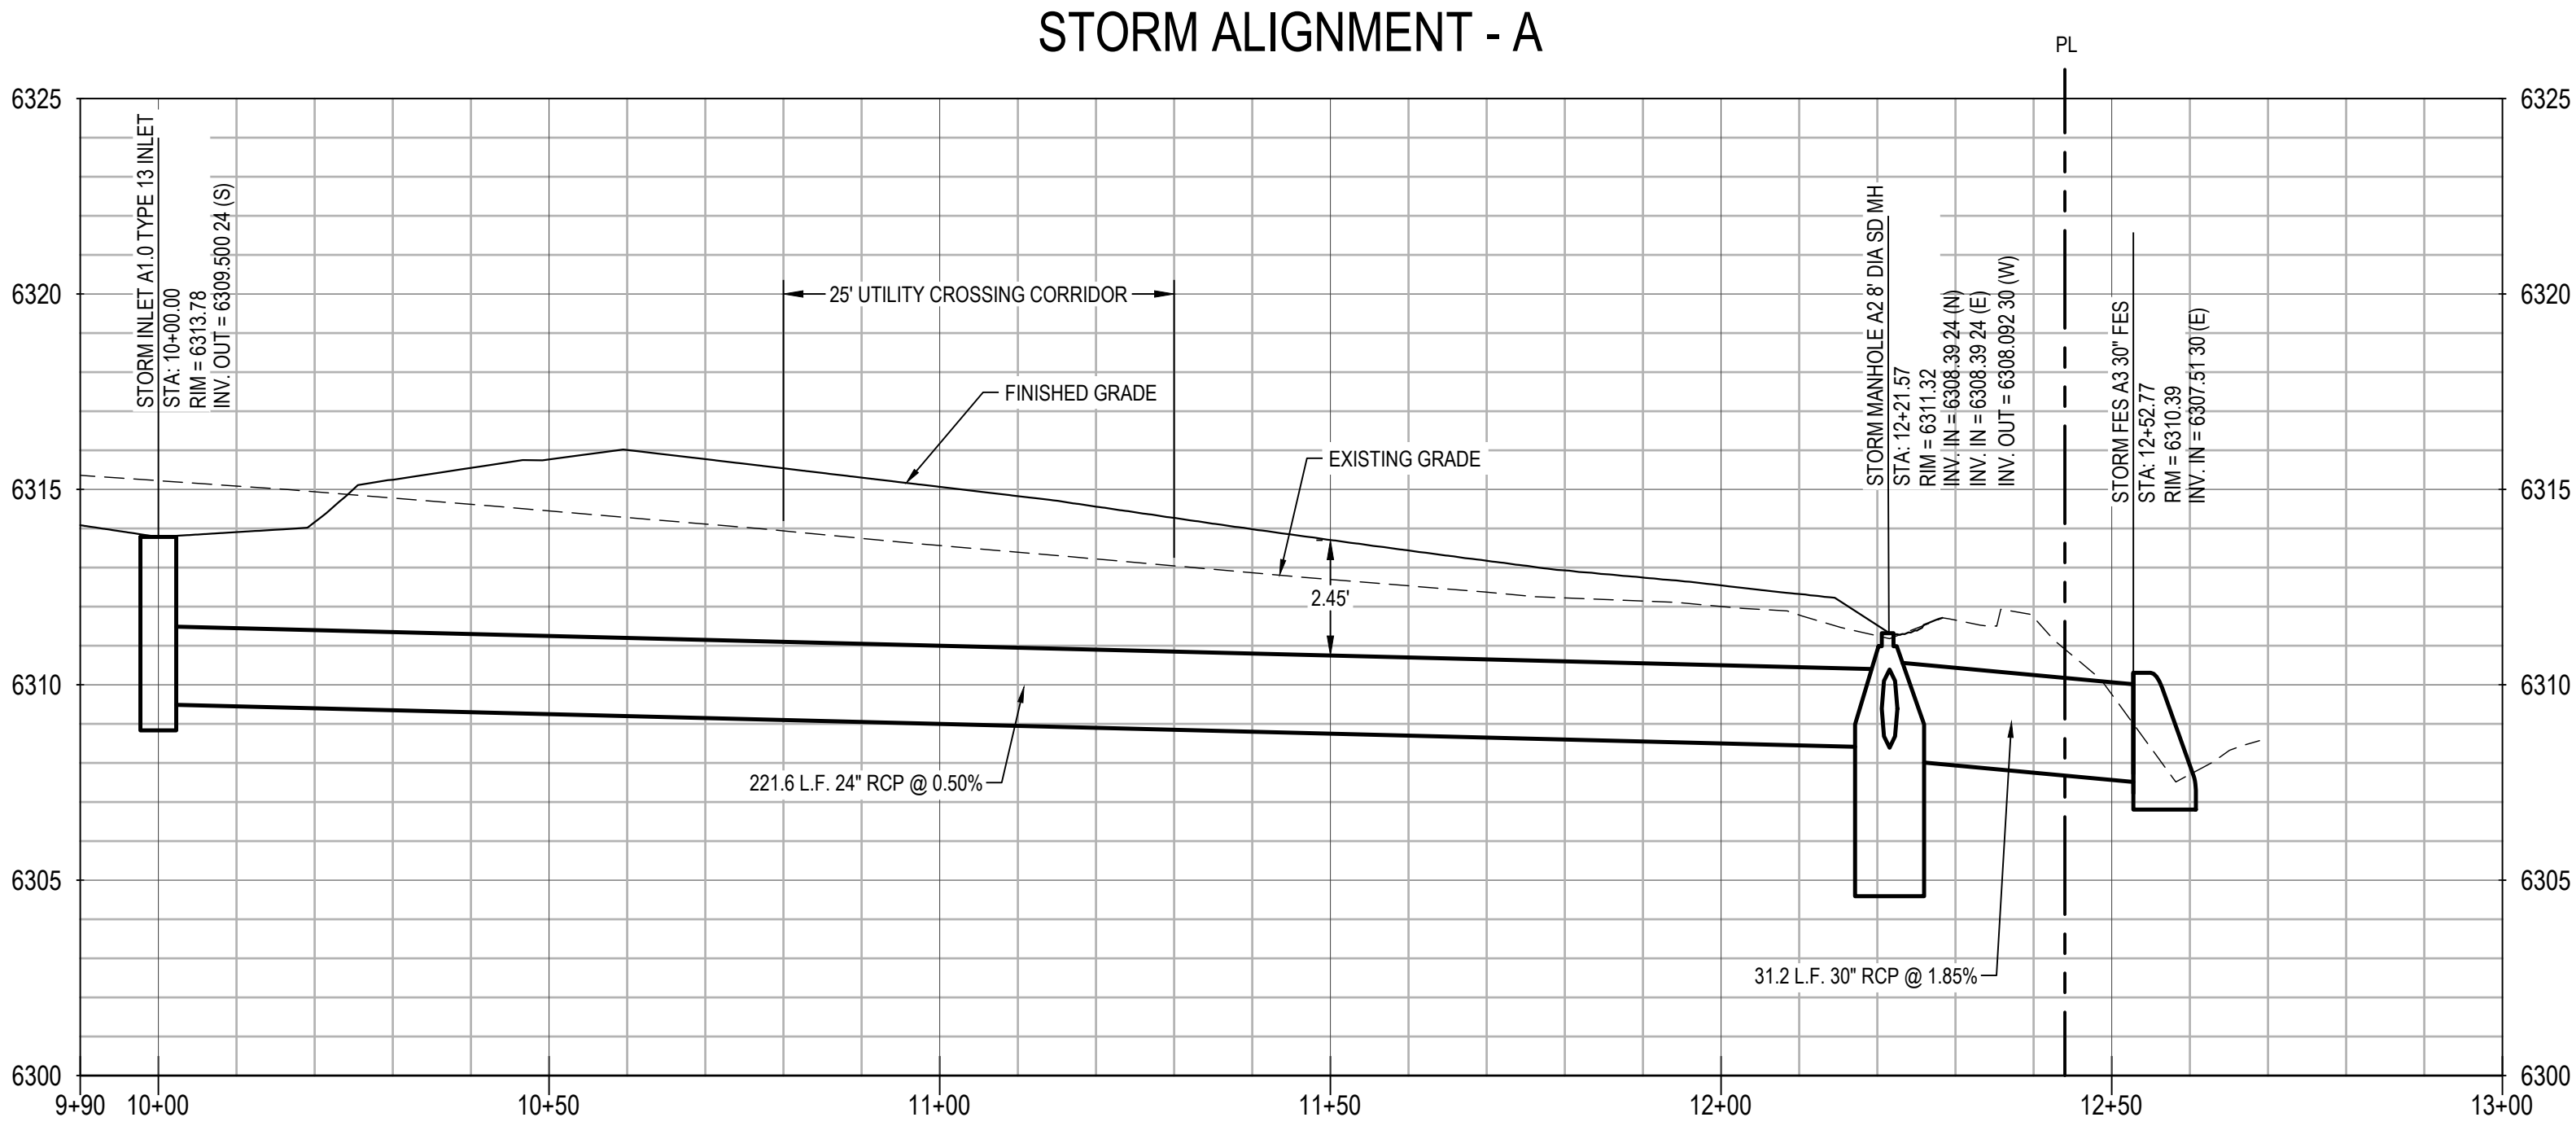

Place with GEC Plan set

Storm P&P Placed in GEC
Plan set - Page 5

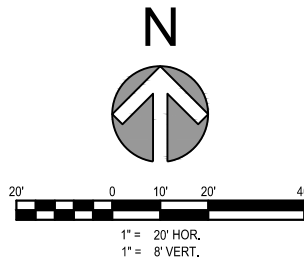

PROFILE LEGEND		
---	EXISTING GROUND AT PIPE CENTERLINE	
---	PROPOSED GRADE AT PIPE CENTERLINE	

NOTES:

1. VERIFY UTILITY CROSSING ELEVATIONS IN THE FIELD.
- 1.1. ELECTRIC CROSSINGS TO BE VERIFIED
- 1.2. FIBER CROSSINGS TO BE VERIFIED
- 1.3. TELECOMMUNICATIONS CROSSINGS TO BE VERIFIED
- 1.4. GAS CROSSINGS TO BE VERIFIED
2. ADS STANDARD DETAILS ON PAGE SHEET C9.4
3. SIDEWALK CHASE DETAILS ON SHEET C9.4
4. TYPE 13 INLET DETAILS ON SHEET C9.4



Chick-fil-A

Chick-fil-A
5200 Buffington Road
Atlanta, Georgia 30349-2998



FOR AND ON BEHALF OF
MERRICK AND COMPANY

CONSTRUCTION DOCUMENTS

CHICK-FIL-A
POWERS & PALMER PARK
SEC OF POWERS BLVD AND PALMER
PARK BLVD COLORADO SPRINGS, CO 80915

FSR#05934

BUILDING TYPE / SIZE: P12 LS LRG
RELEASE: VX.YY.MM

REVISION SCHEDULE		
NO.	DATE	DESCRIPTION

CONSULTANT PROJECT #

PRINTED FOR




DATE 01/31/2024

DRAWN BY CSS

SHEET STORM P&P










SHEET NUMBER

   PS1.1



place with SDP sheet set

Added to SDP Plan Set

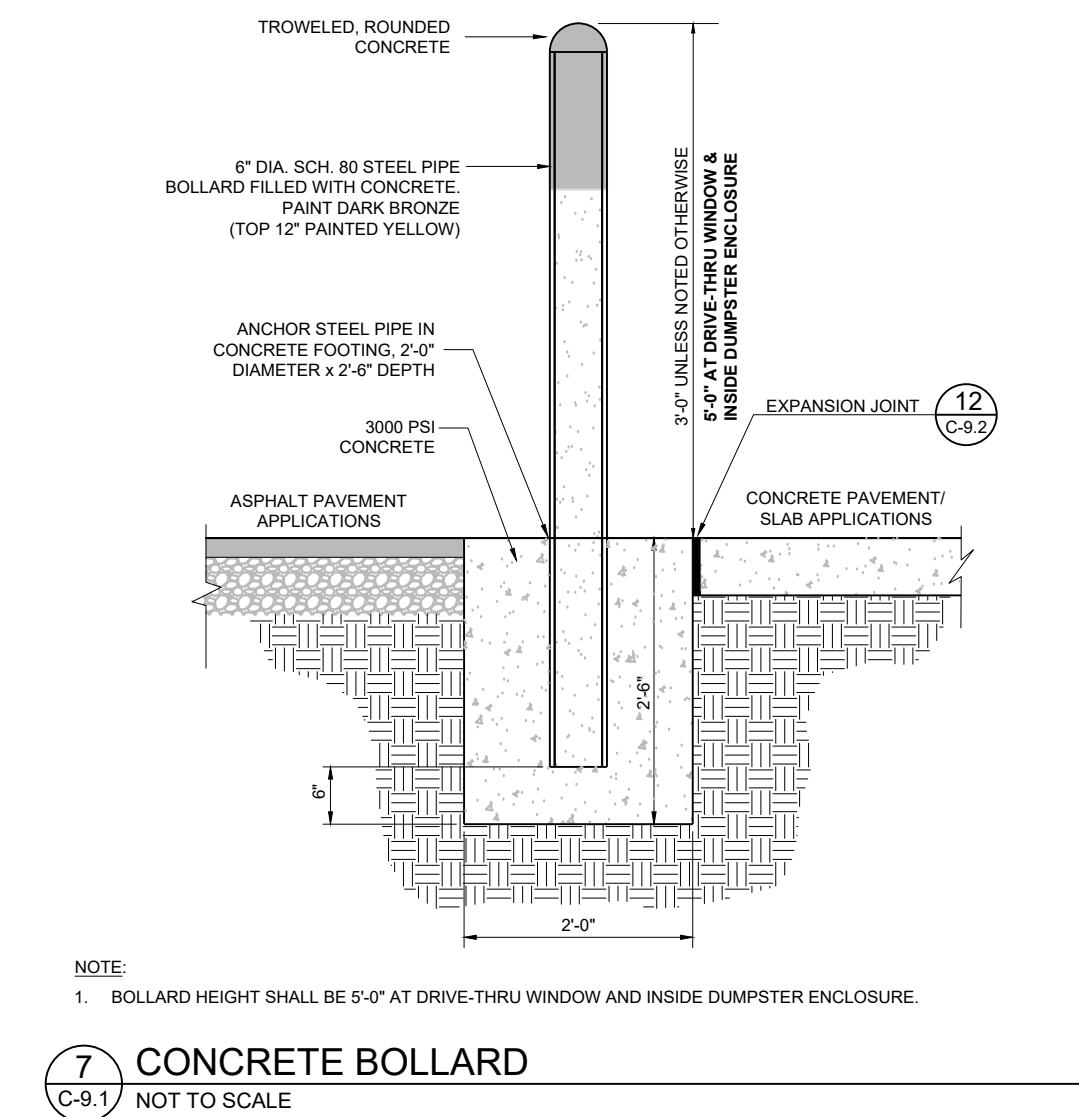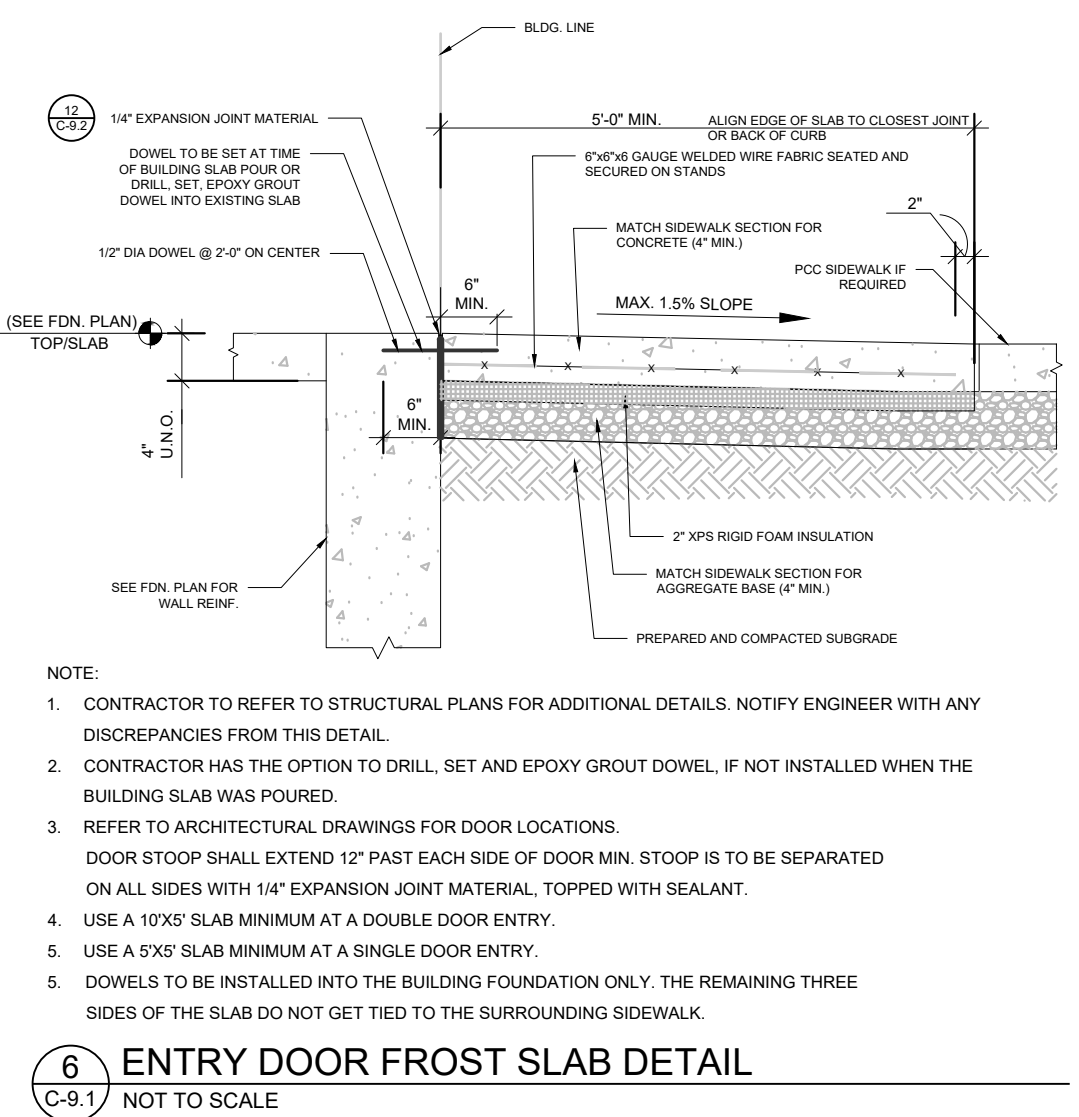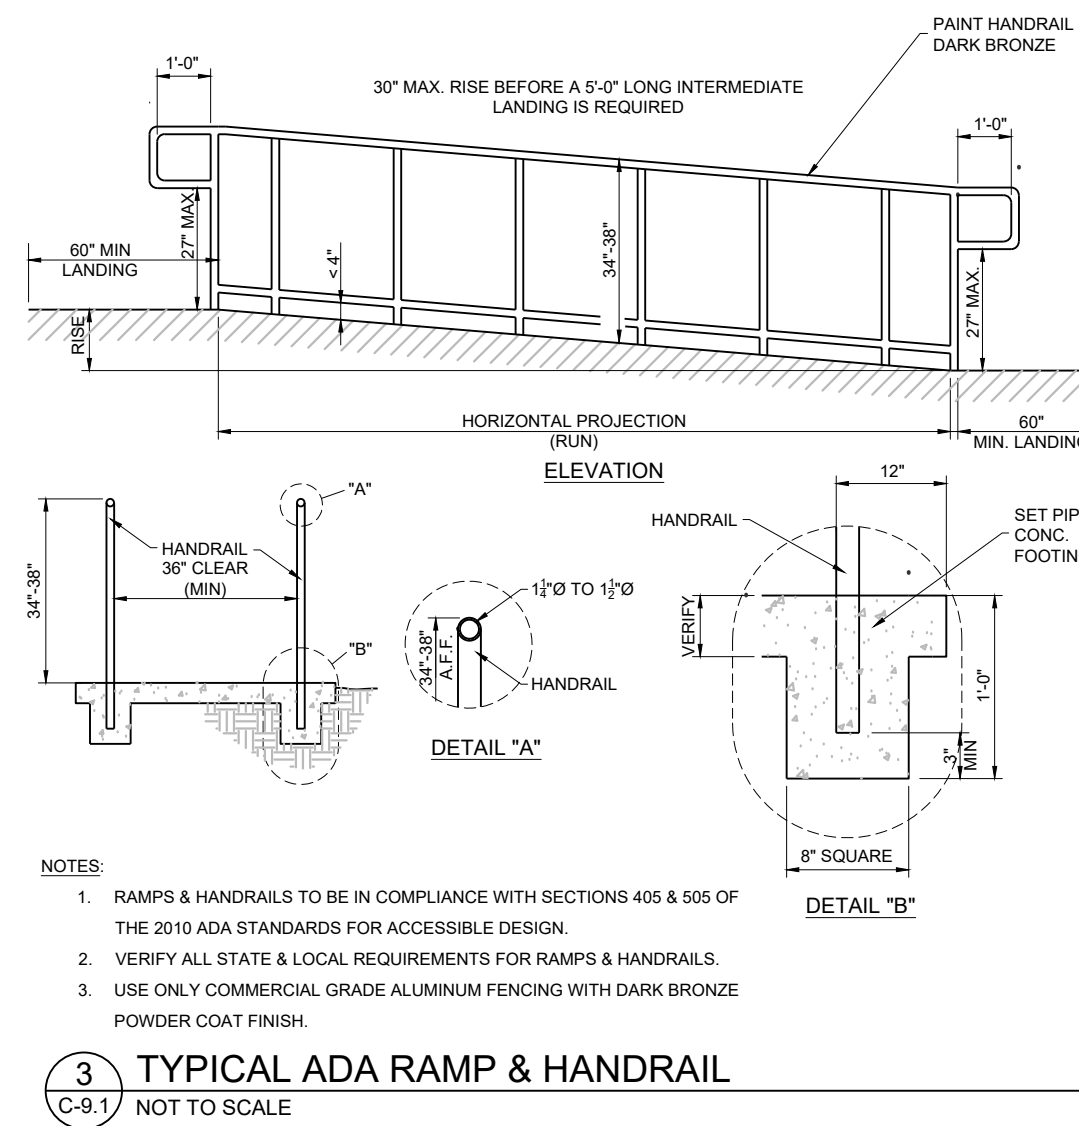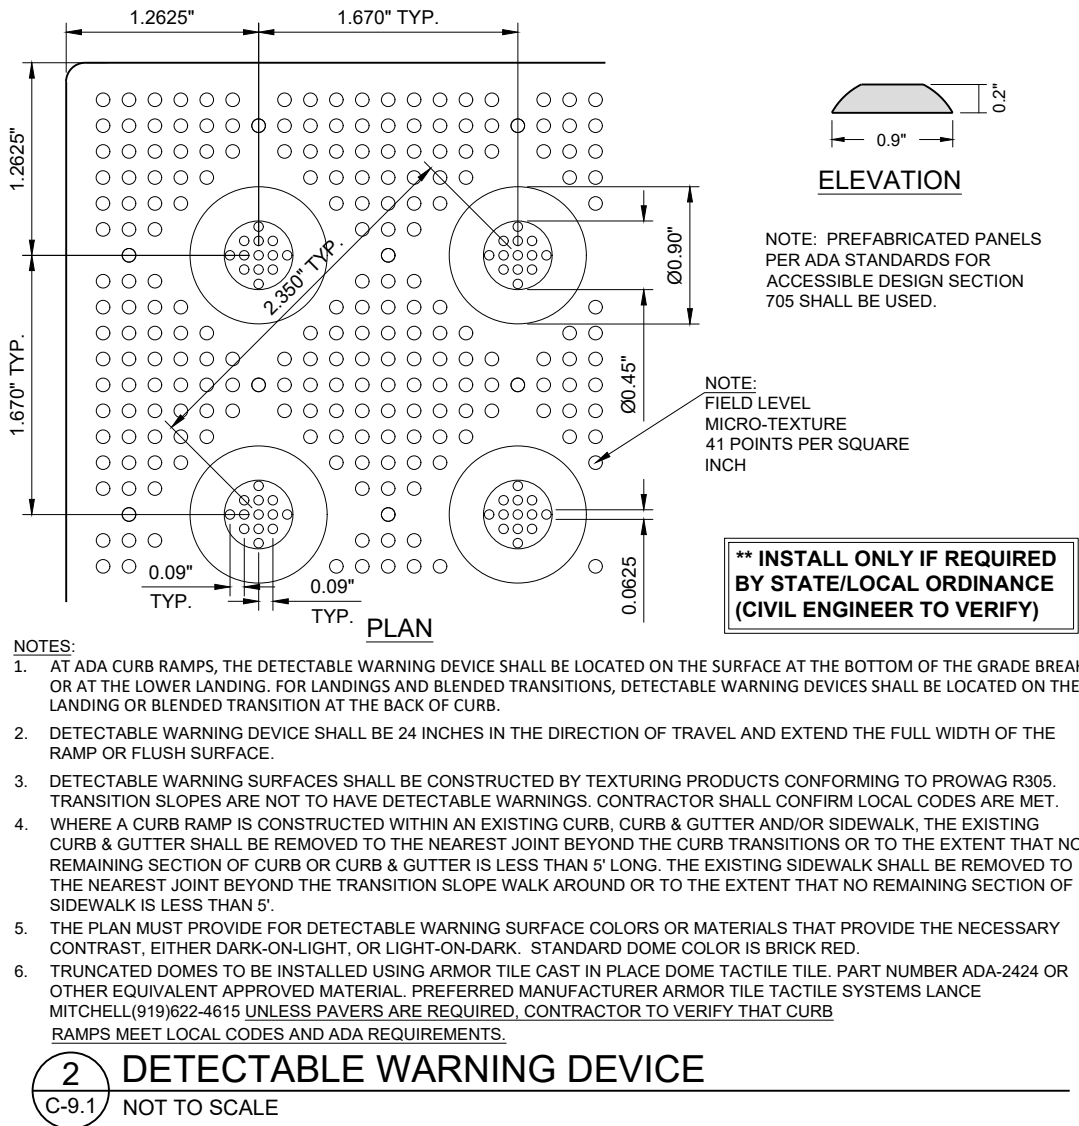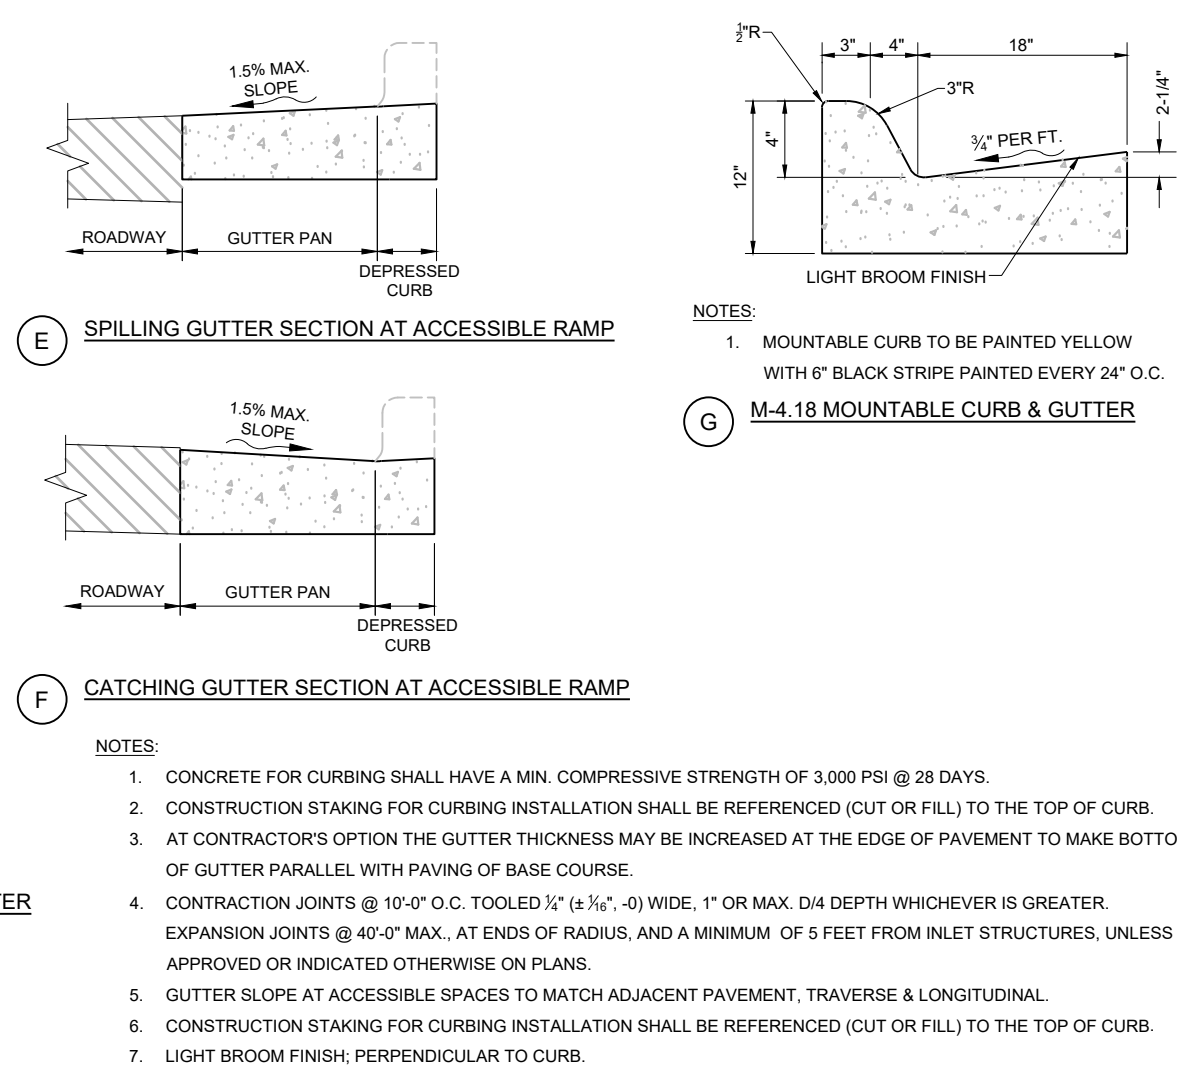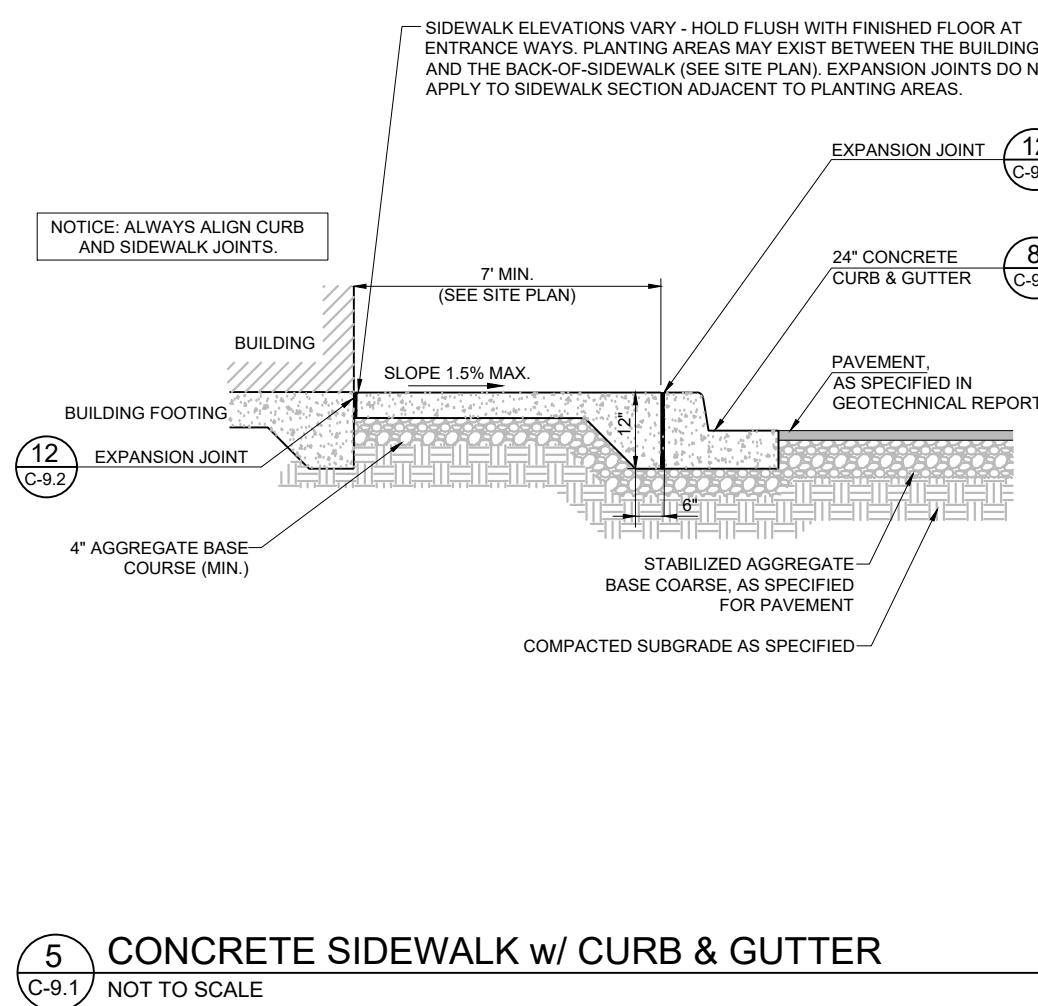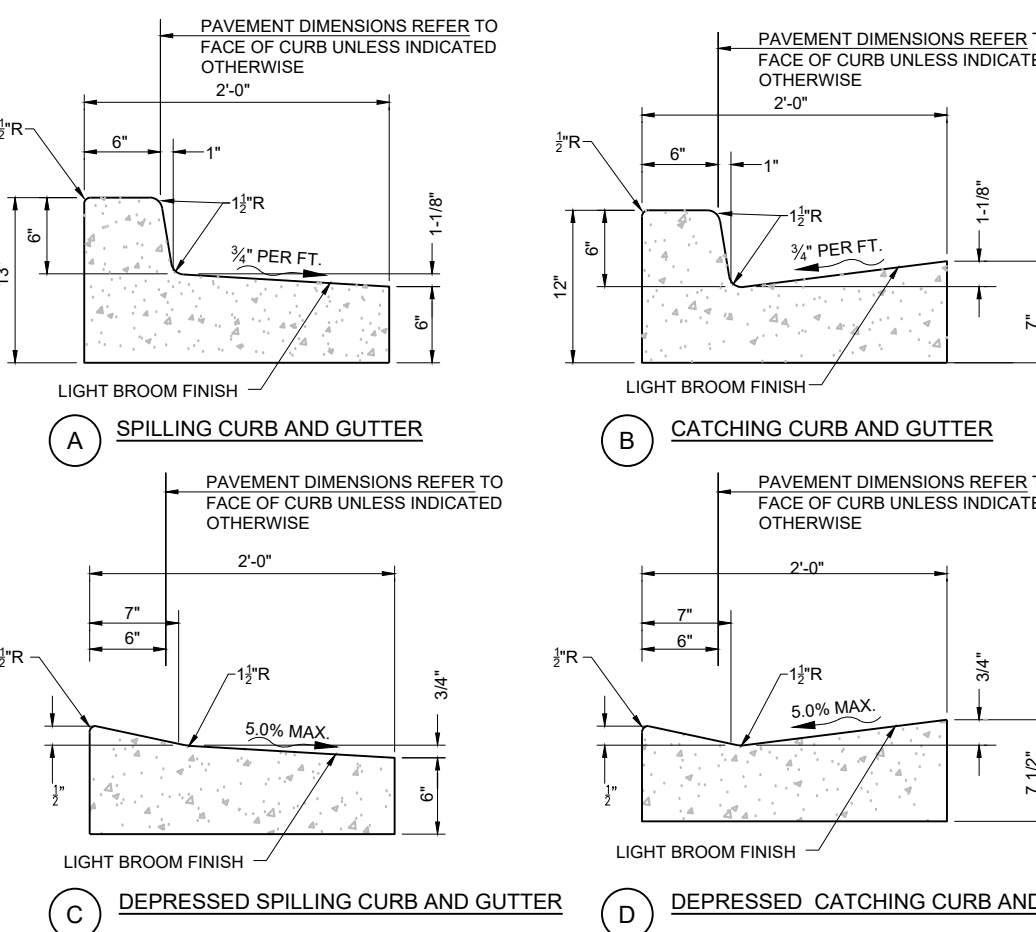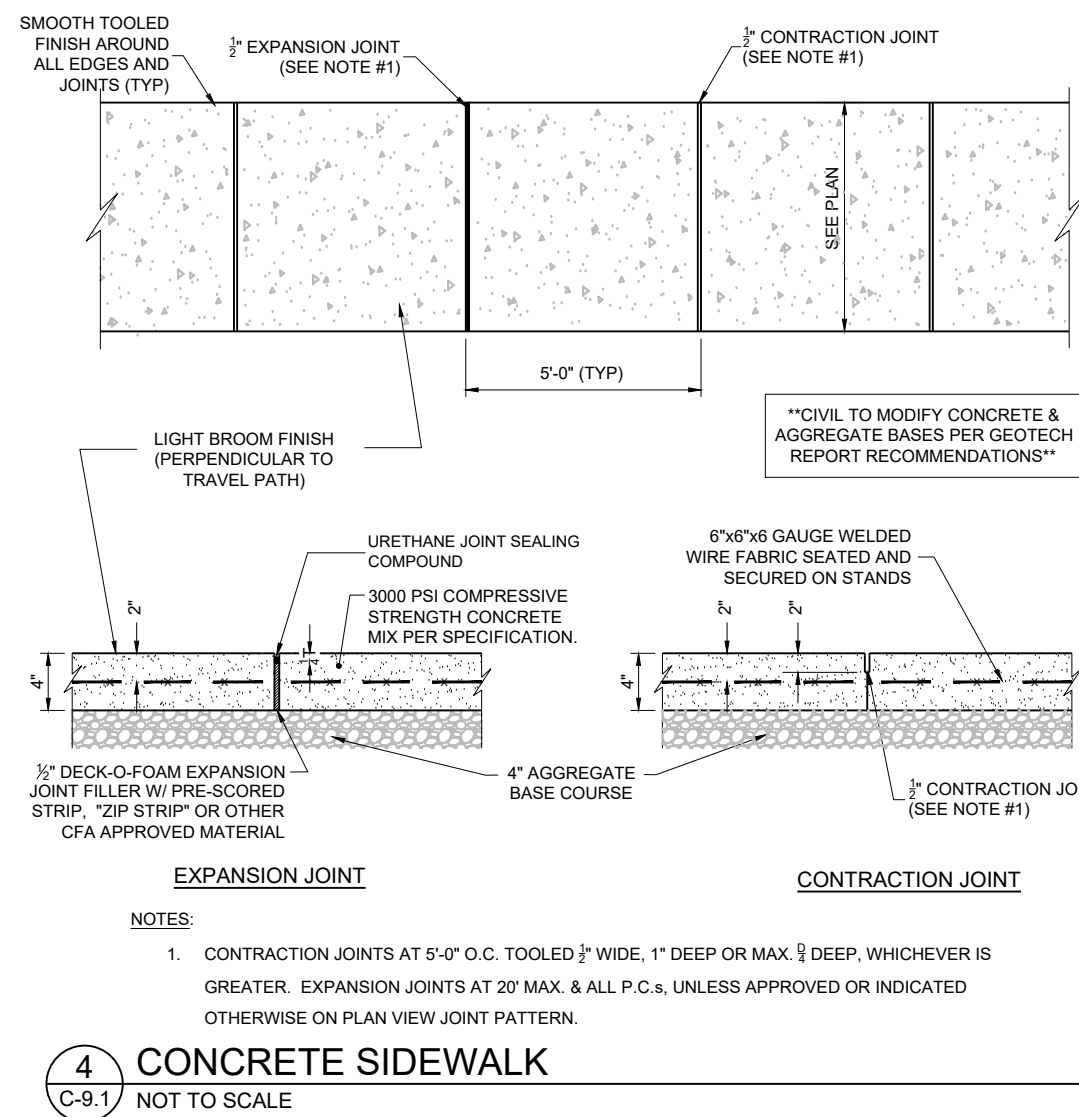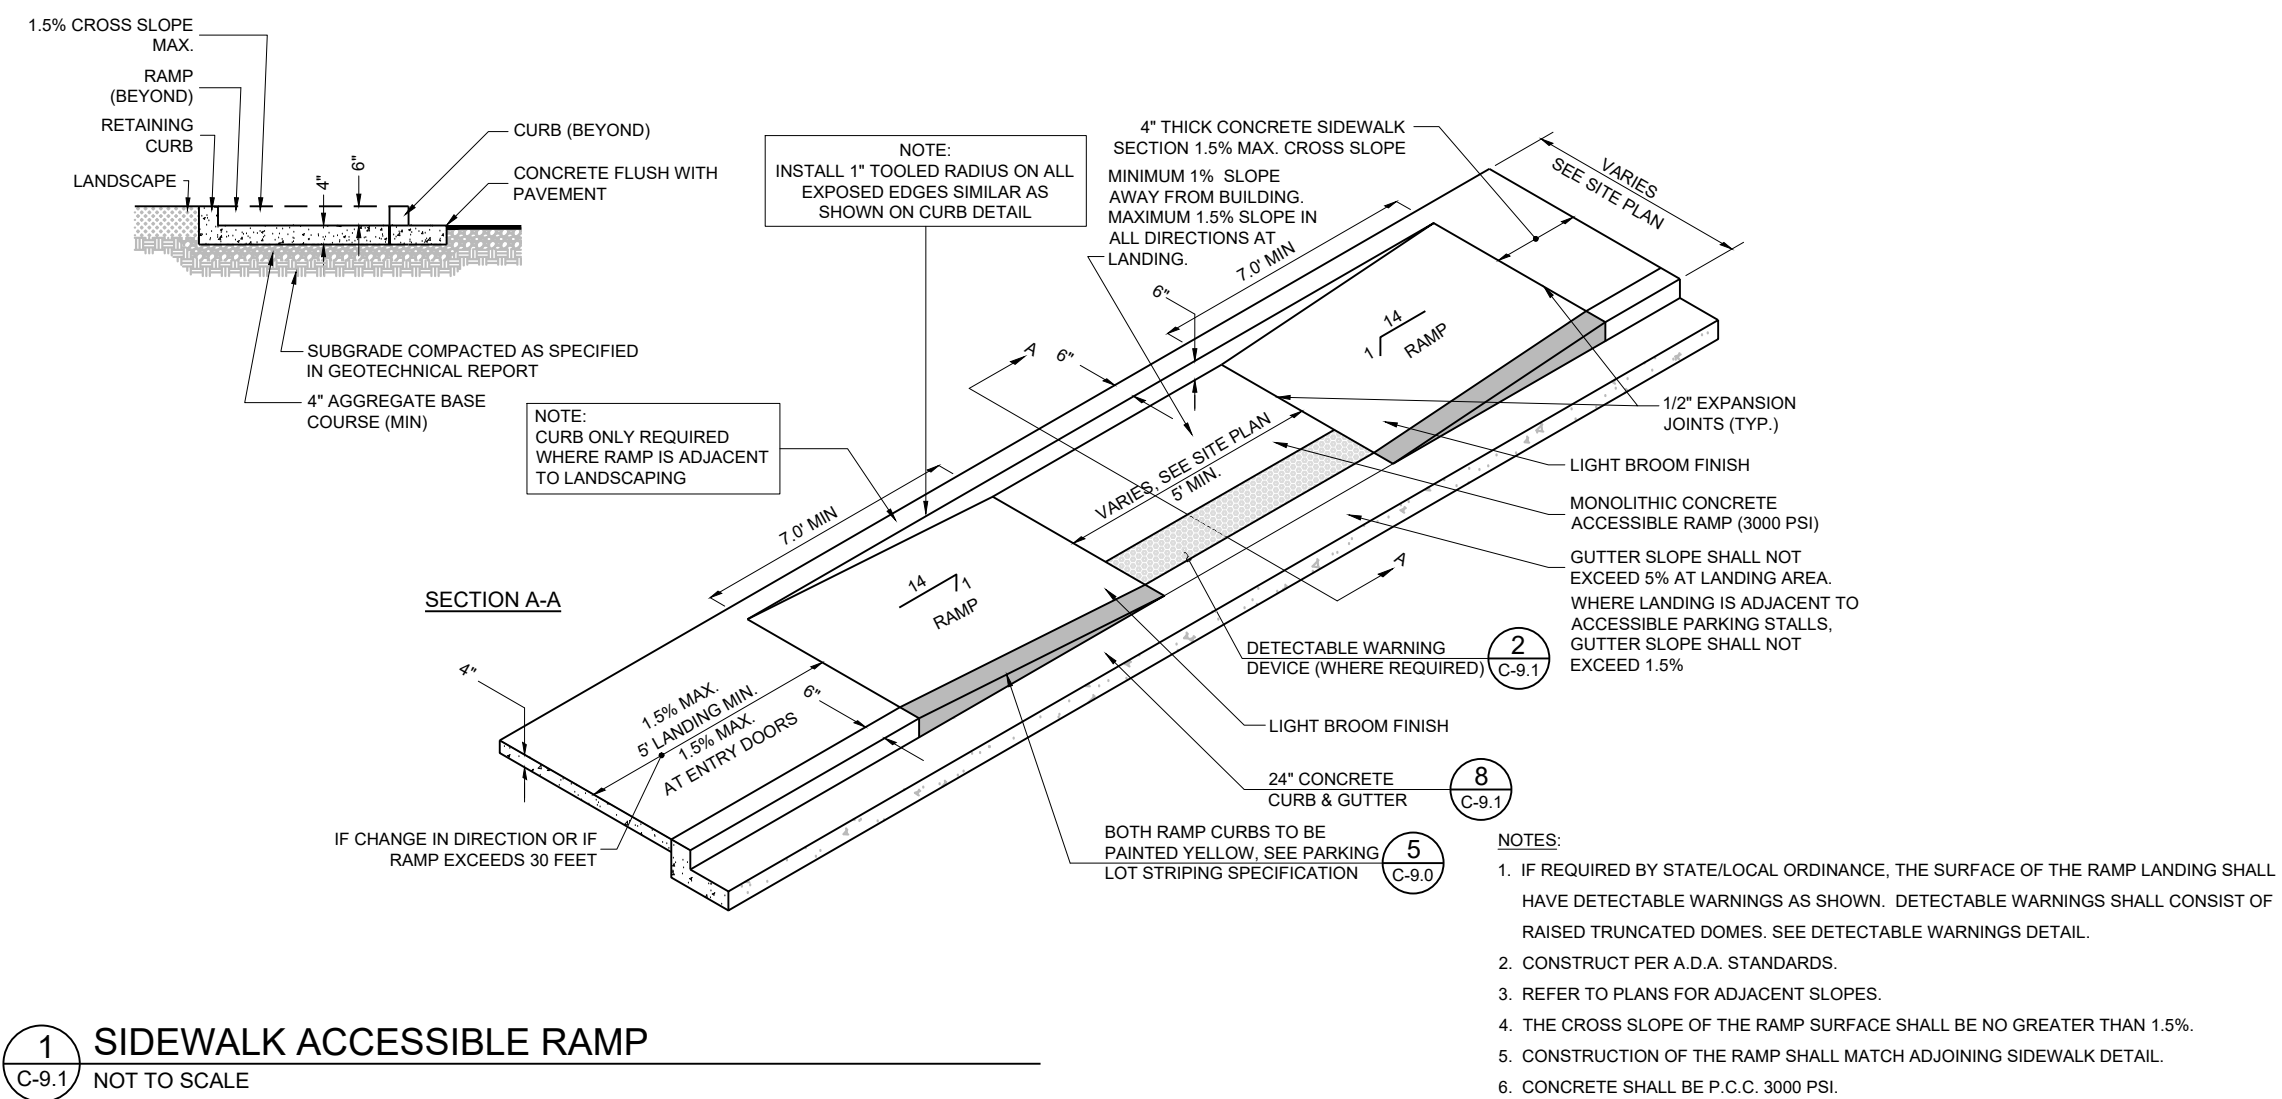

Chick-fil-A
5200 Buffington Road
Atlanta, Georgia 30349-2998

MERRICK
5970 GREENWOOD PLAZA BLVD
GREENWOOD VILLAGE, CO 80111
303-751-0741

FOR AND AND ON-BEHALF OF
MERRICK AND COMPANY

CHICK-FIL-A
POWERS & PALMER PARK
SEC OF POWERS BLVD AND PALMER
PARK BLVD COLORADO SPRINGS, CO 80915

FSR#05934

BUILDING TYPE / SIZE: P12 LS LRG
RELEASE: vX.YY.MM

REVISION SCHEDULE
NO. DATE DESCRIPTION


CONSULTANT PROJECT #
PRINTED FOR
DATE 01/31/2024
DRAWN BY CSS
SHEET
CFA STANDARD
DETAILS
SHEET NUMBER

C9.1



Know what's below.
Call before you dig.

File Path: Q:\DENProjects\100810.00 CFA Powers & Palmer\CAD\CDA\100810 - C4.0 - CD - STANDARD DETAILS.dwg Last
Saved By: CHRISTIAN SCHILDER
1/31/2025 10:01 AM
00-LS-0000-A 101-SHEET NAME

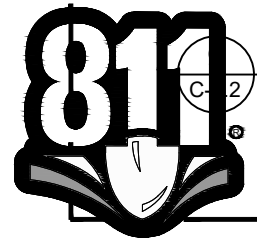


Know what's below.
Call before you dig.

CONTRACTION JOINT

NOT TO SCALE


- NOTES:
- JOINT SPACING TO BE 12' x 12' WITH EVERY OTHER JOINT BEING AN EXPANSION JOINT.
 - GENERAL CONTRACTOR SHALL REFERENCE GEOTECHNICAL REPORT FOR PAVEMENT SECTION REQUIREMENTS.

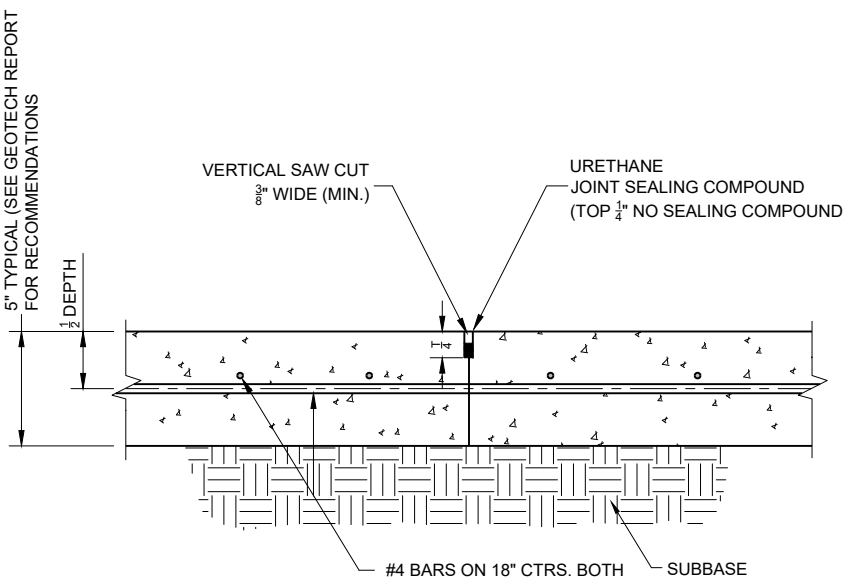

KEYED CONSTRUCTION JOINT

NOT TO SCALE


- NOTES:
- GENERAL CONTRACTOR SHALL REFERENCE GEOTECHNICAL REPORT FOR PAVEMENT SECTION REQUIREMENTS.

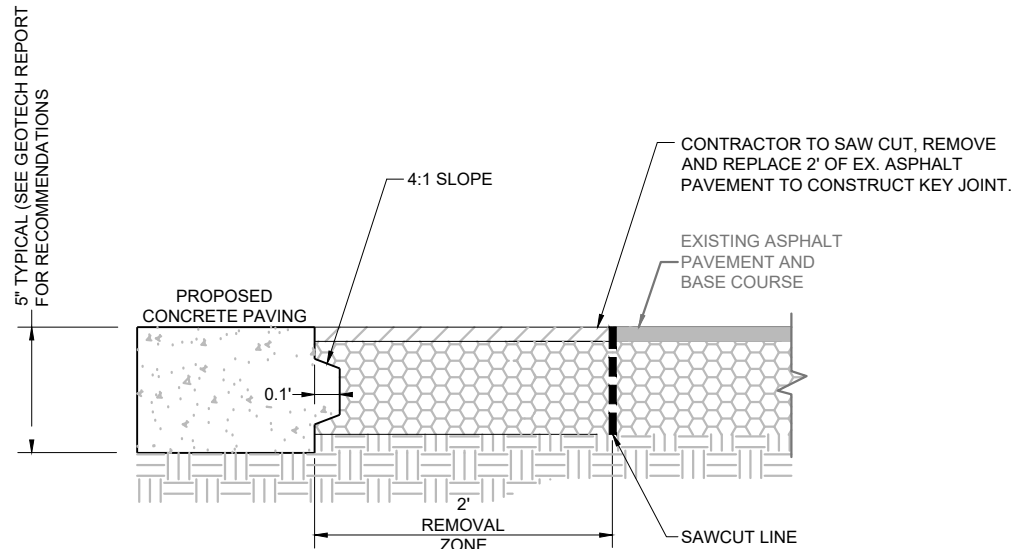

LONGITUDINAL BUTT JOINT

NOT TO SCALE


- NOTES:
- NO. 8 SMOOTH DOWEL BAR MAY BE USED IN 8 INCH AND 6 INCH PAVEMENT THICKNESS.
 - LONGITUDINAL BUTT CONSTRUCTION MAY BE UTILIZED IN PLACE OF LONGITUDINAL HINGED (KEYWAY) JOINT AT CONTRACTORS OPTION.
 - DOWEL BARS SHALL BE DRILLED & EPOXIED INTO PAVEMENT HORIZONTALLY BY USE OF MECHANICAL EQUIP.
 - PUSHING DOWEL BARS INTO WET CONCRETE NOT ACCEPTABLE.

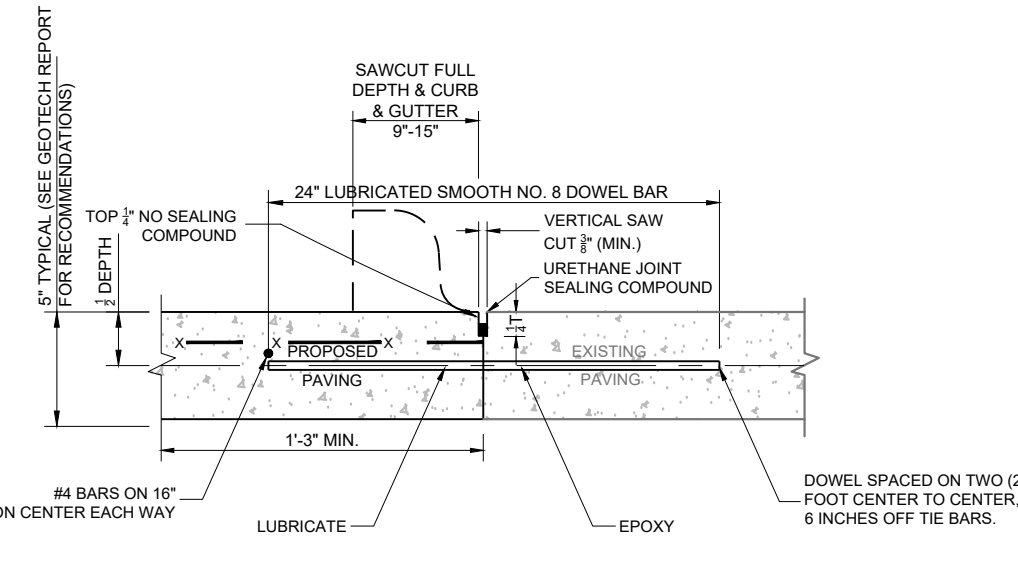

EXPANSION JOINT

NOT TO SCALE


- NOTES:
- NO. 5 SMOOTH DOWEL BAR MAY BE USED IN 5 INCH AND 6 INCH PAVEMENT THICKNESS.
 - LONGITUDINAL BUTT CONSTRUCTION MAY BE UTILIZED IN PLACE OF LONGITUDINAL HINGED (KEYWAY) JOINT AT CONTRACTORS OPTION.
 - DOWEL BARS SHALL BE DRILLED INTO PAVEMENT HORIZONTALLY BY USE OF A MECHANICAL EQUIPMENT.
 - DRILLING BY HAND IS NOT ACCEPTABLE, PUSHING DOWEL BARS INTO WET CONCRETE NOT ACCEPTABLE.
 - JOINT SPACING TO BE 24'x24' (EVERY OTHER JOINT)

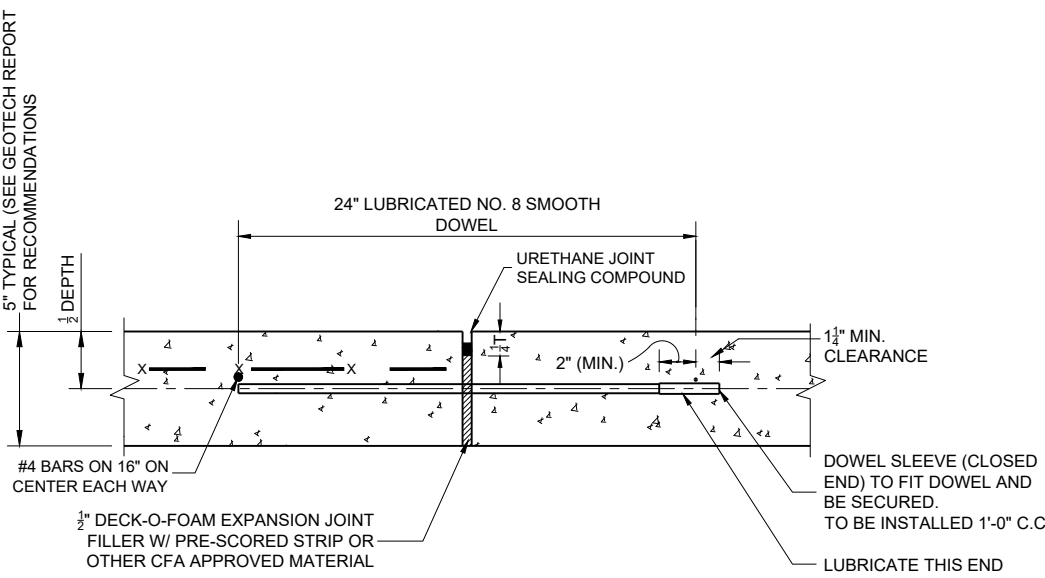

TRANSVERSE AND LONGITUDINAL CONTRACTION JOINT

NOT TO SCALE


- NOTE:
- GENERAL CONTRACTOR SHALL REFERENCE GEOTECHNICAL REPORT FOR PAVEMENT SECTION REQUIREMENTS.

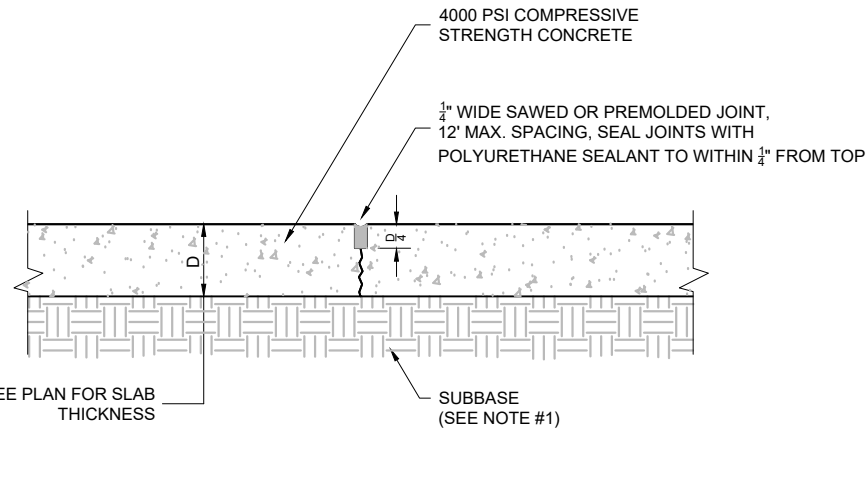

TRANSVERSE AND LONGITUDINAL DOWELED CONSTRUCTION JOINT

NOT TO SCALE


- NOTE:
- GENERAL CONTRACTOR SHALL REFERENCE GEOTECHNICAL REPORT FOR PAVEMENT SECTION REQUIREMENTS.

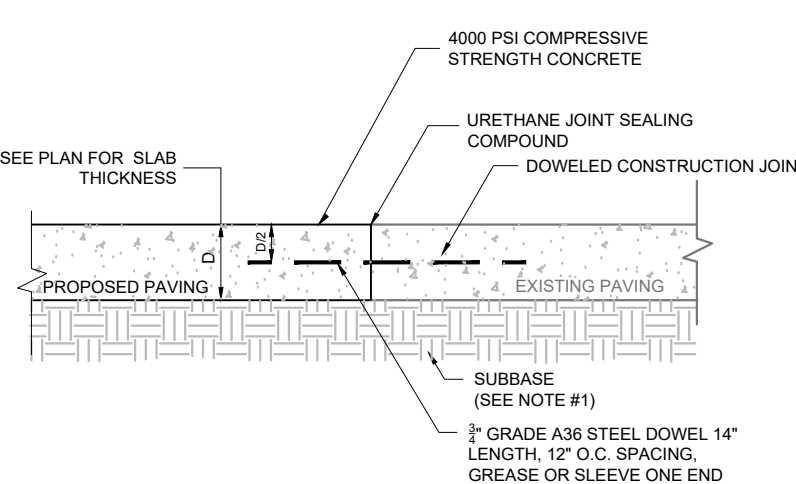

CONCRETE PAVEMENT DRIVE-THRU LANE

NOT TO SCALE


- NOTE:
- GENERAL CONTRACTOR SHALL REFERENCE GEOTECHNICAL REPORT FOR PAVEMENT SECTION REQUIREMENTS.
 - MINIMUM PAVEMENT THICKNESS SHALL BE 6" CONCRETE, 4" AGGREGATE BASE.

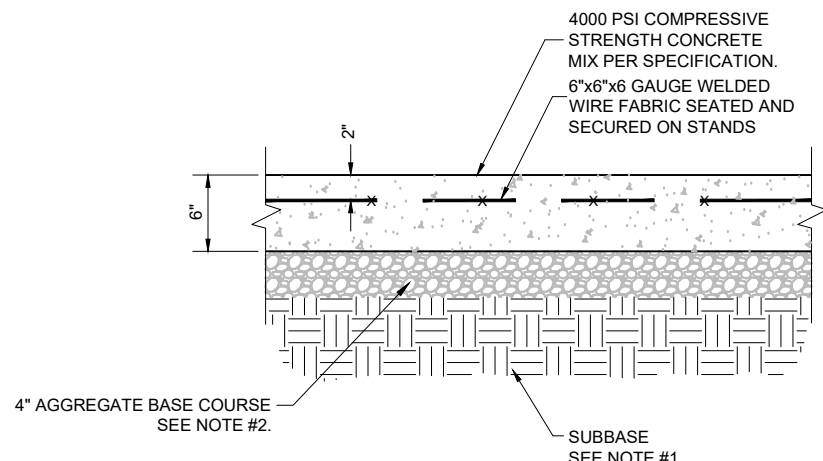

BUTT JOINT

NOT TO SCALE


- NOTES:
- DESIGN PER GEOTECH REPORT PREPARED BY _____, DATED _____.
 - PAVEMENTS & SUBGRADES INCLUDING MATERIALS & COMPACTION SHALL MEET STANDARDS & SPECIFICATIONS OF THE GOVERNING DEPARTMENT OF TRANSPORTATION.
 - JOINTING & SPACING SHALL BE PER CONCRETE JOINT DETAILS.
 - CONCRETE SHALL HAVE A MIN. COMPRESSIVE STRENGTH OF 4,000 PSI @ 28 DAYS.

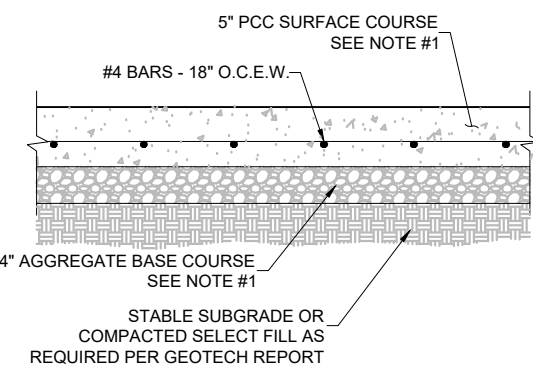

CONCRETE PAVEMENT

NOT TO SCALE


- NOTE:
- GENERAL CONTRACTOR SHALL REFERENCE GEOTECHNICAL REPORT FOR PAVEMENT SECTION REQUIREMENTS.
 - MINIMUM PAVEMENT THICKNESS SHALL BE 5" CONCRETE, 4" AGGREGATE BASE.

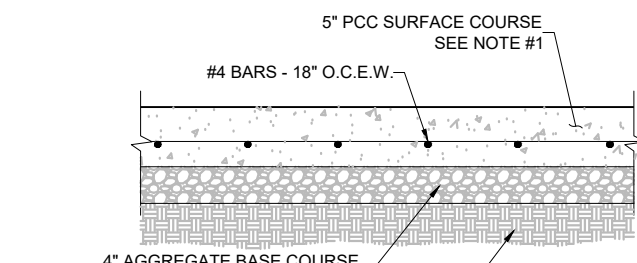

TYPICAL HMAC PAVEMENT SECTION

NOT TO SCALE


- NOTE:
- GENERAL CONTRACTOR SHALL REFERENCE SITE SPECIFIC GEOTECHNICAL REPORT FOR PAVEMENT, AGGREGATE, AND SUBGRADE SECTION REQUIREMENTS.
 - MINIMUM PAVEMENT THICKNESS SHOULD BE 8" GRADED AGGREGATE BASE, 2.5" ASPHALT PAVEMENT BINDER, 1.5" ASPHALT PAVEMENT SURFACE COURSE, AND TACK COAT.

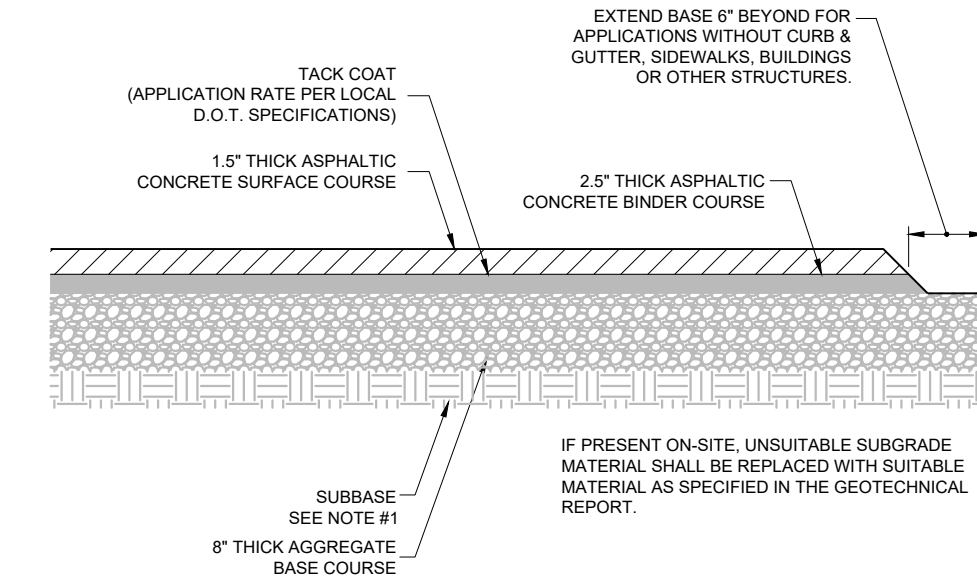

CONCRETE APRON AT TRASH ENCLOSURE

NOT TO SCALE

- NOTE:
- GENERAL CONTRACTOR SHALL REFERENCE GEOTECHNICAL REPORT FOR PAVEMENT SECTION REQUIREMENTS.

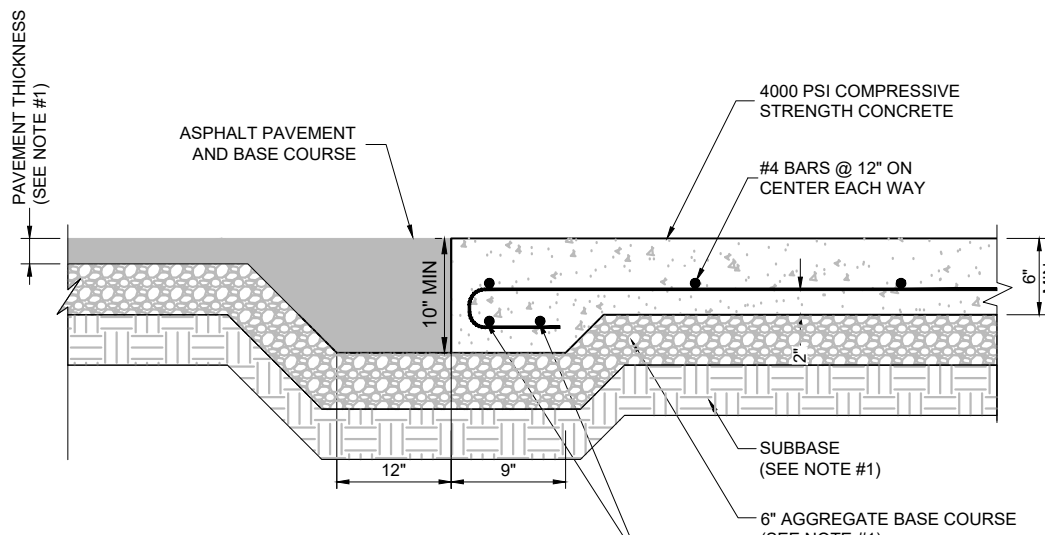

2

3

4

1



Chick-fil-A
5200 Buffington Road
Atlanta, Georgia 30349-2998



5970 GREENWOOD PLAZA BLVD
GREENWOOD VILLAGE, CO 80111
303-751-0741

FOR AND AND ON-BEHALF OF
MERRICK AND COMPANY

CHICK-FIL-A
POWERS & PALMER PARK
SEC OF POWERS BLVD AND PALMER
PARK BLVD COLORADO SPRINGS, CO 80915

FSR#05934

BUILDING TYPE / SIZE: P12 LS LRG
RELEASE: vX.YY.MM

REVISION SCHEDULE
NO. DATE DESCRIPTION

CONSULTANT PROJECT #
PRINTED FOR
DATE 01/31/2024
DRAWN BY CSS
SHEET
CFA STANDARD
DETAILS
SHEET NUMBER

C9.2




Know what's below.
Call before you dig.

8 CLEAN-OUT (OUTSIDE OF BUILDING)


NOTE: SEE PLUMBING PLANS FOR GREASE TRAP DETAIL.

- NOTES:
- SEE PLUMBING PLANS FOR GREASE TRAP DETAIL.
 - CLEAN-OUT COVERS SHALL BE PROVIDED ON ALL CLEAN-OUTS REGARDLESS OF LOCATION.
 - CONCRETE COLLAR ALSO REQUIRED FOR SINGLE CLEAN-OUTS IN PAVEMENT.

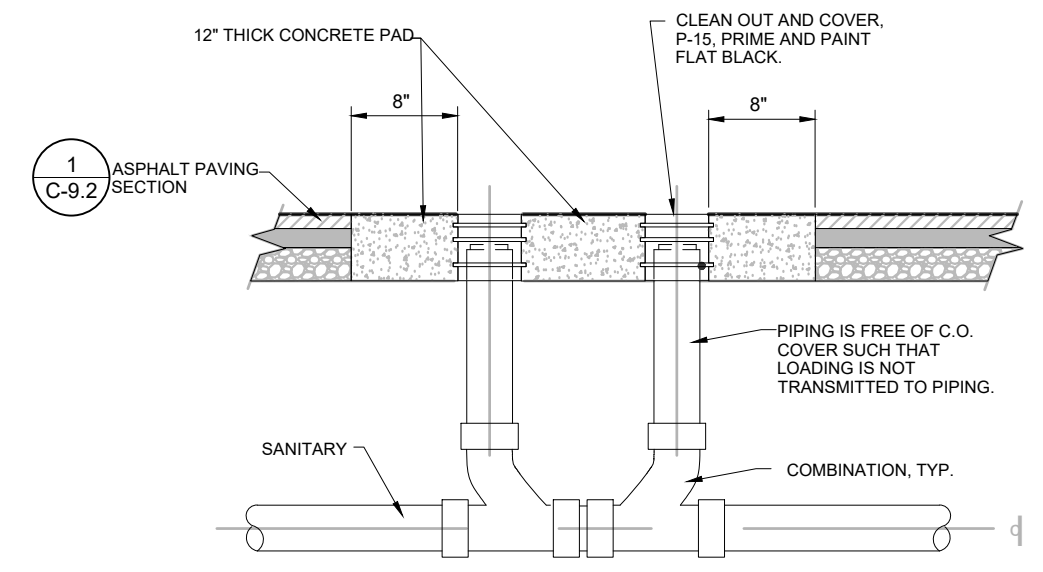


9 THICKENED PAVEMENT @ STRUCTURES

NOTE: SEE PLUMBING PLANS FOR GREASE TRAP DETAIL.

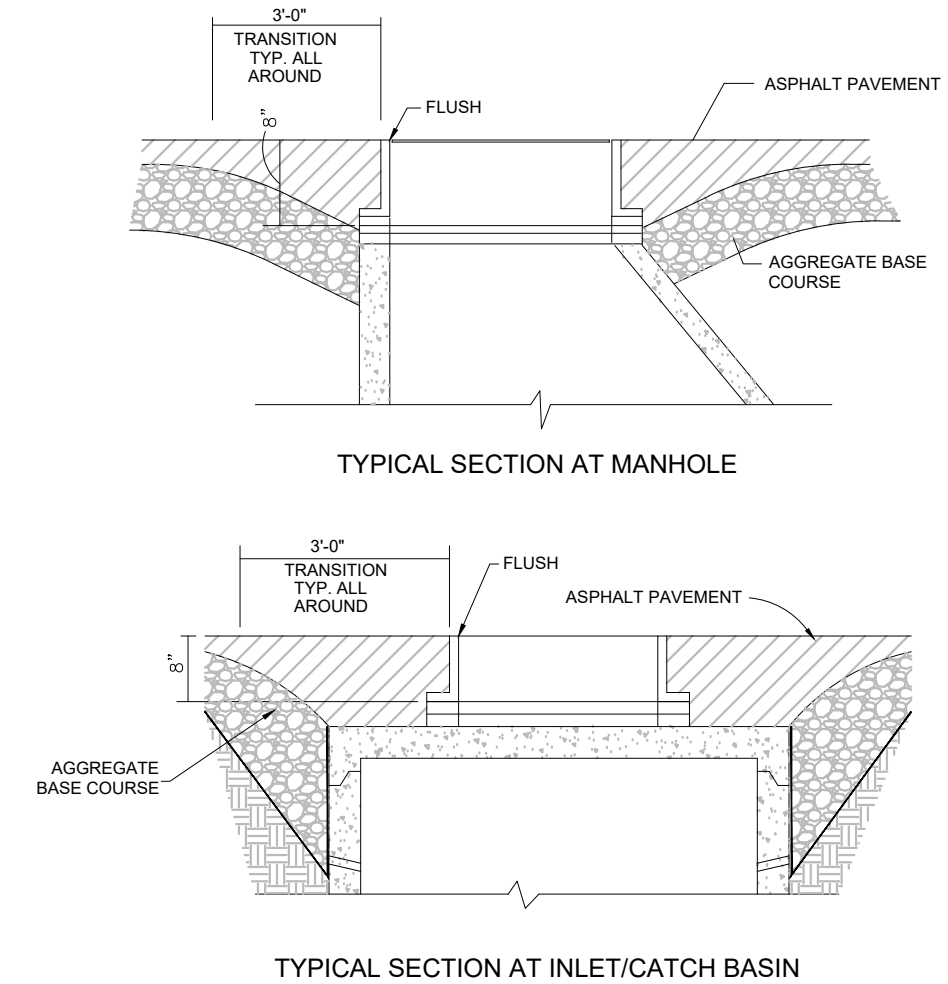


10 STORM STRUCTURE WEEP HOLE DETAILS

NOTE: SEE PLUMBING PLANS FOR GREASE TRAP DETAIL.

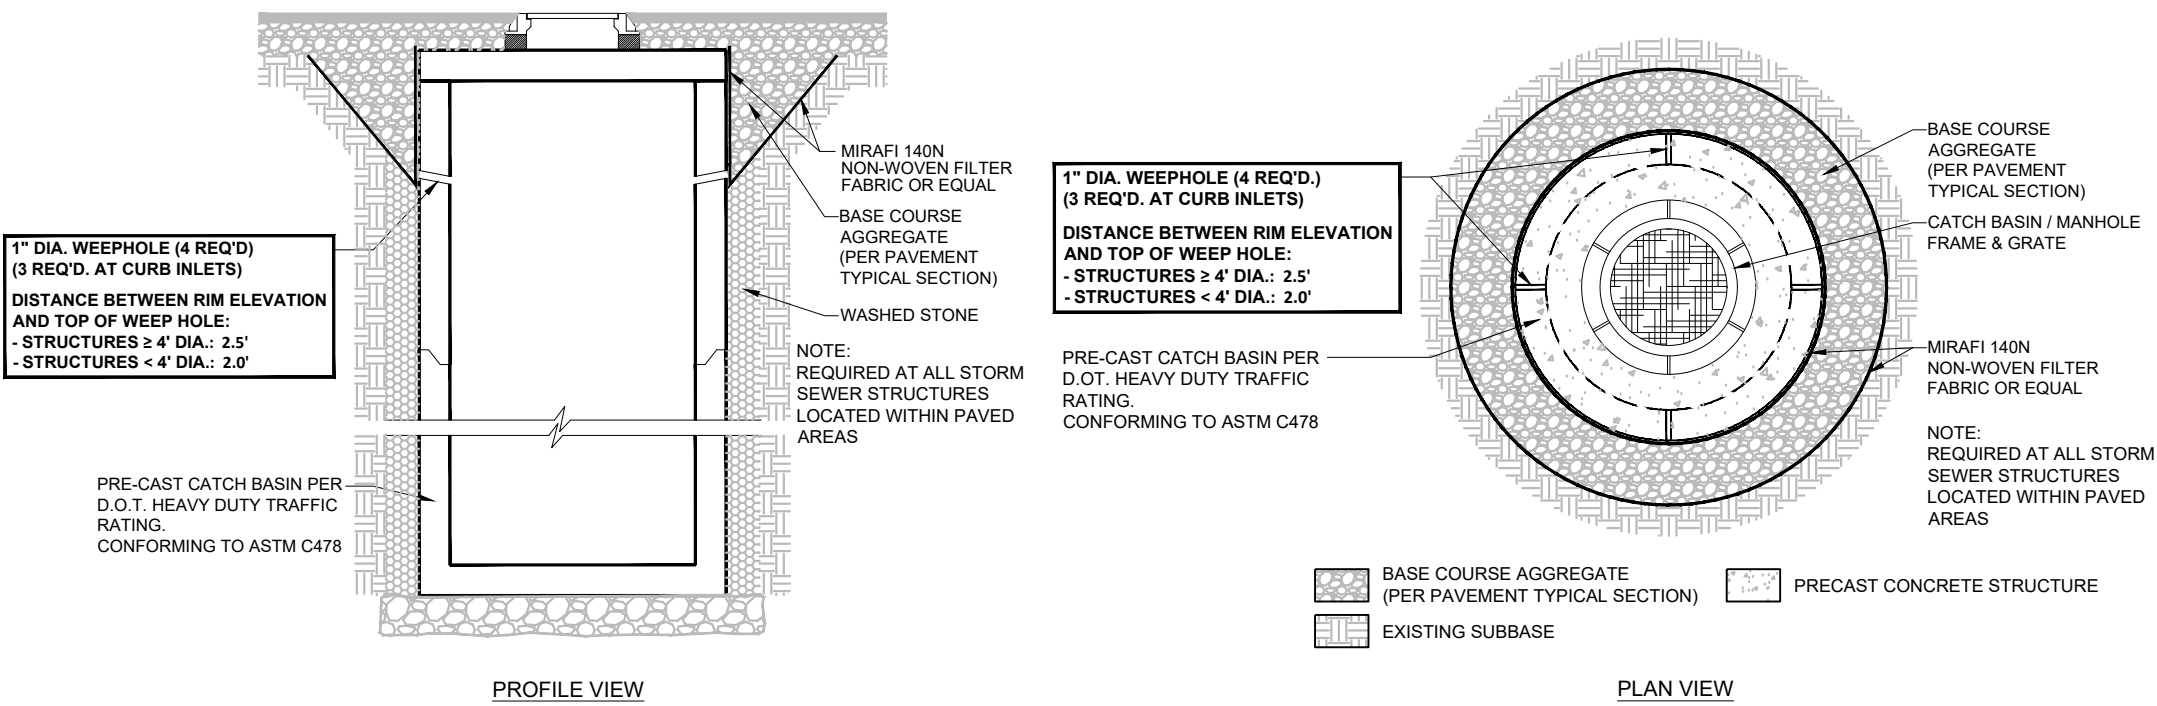


5 BUILDING DOWNSPOUT CONNECTION

- NOTES:
- FOR ALL DEPTHS OF COVER LESS THAN TWO (2) FEET, PIPE MUST BE SCHEDULE 40 PVC. FOR DEPTHS OF COVER GREATER THAN TWO (2) FEET, FLEXIBLE PIPE MAY BE USED. REFER TO SPECIFICATIONS FOR ALLOWABLE PIPE TYPES.
 - A WATERTIGHT CONNECTION SHALL BE MAINTAINED WITH ANY TRANSITION FROM SCHEDULE 40 PVC PIPE TO ANY OTHER PIPE TYPE.
 - THE DOWNSPOUT COLLECTOR DRAIN SHALL BE INSTALLED BEFORE THE DOWNSPOUTS ARE INSTALLED ON THE BUILDING.
 - IF NECESSARY, ADJUST FOOTING TO ALLOW DOWNSPOUT TO BE INSTALLED TIGHT AGAINST BUILDING.

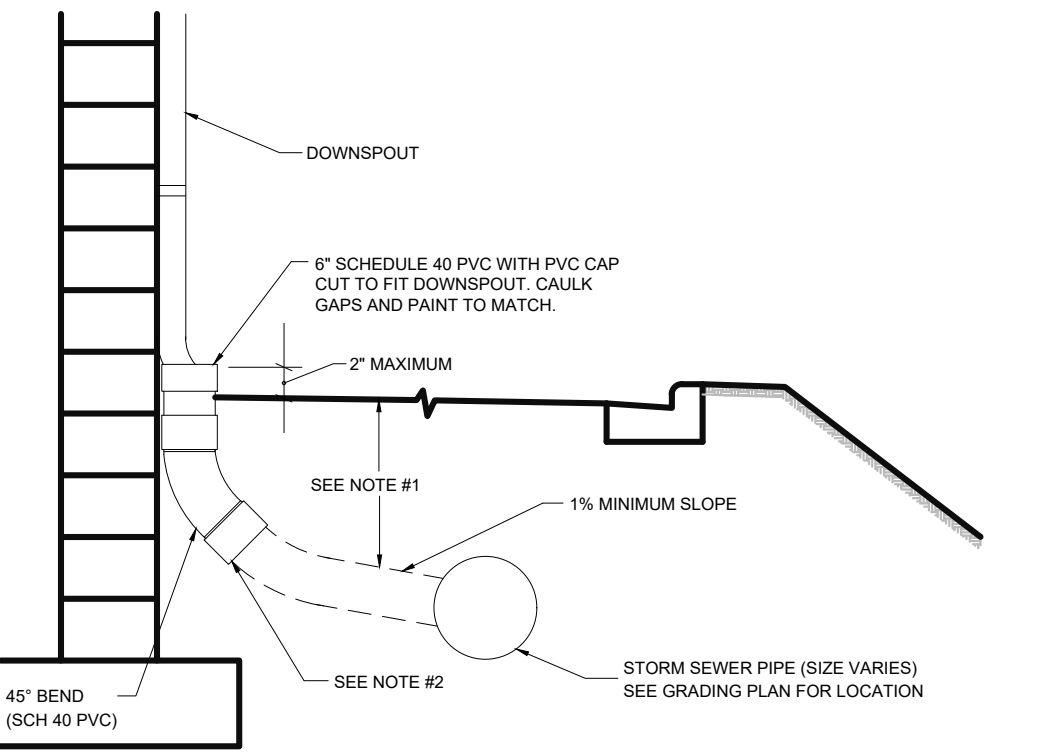


6 CANOPY DOWNSPOUT CONNECTION

- NOTES:
- CANOPY FOOTING SHALL BE A MINIMUM 2'-0" BELOW DRIVE-THRU LANE PAVEMENT SURFACE. REFER TO CIVIL PLANS FOR EXACT CANOPY FOOTING ELEVATIONS.
 - FLEXIBLE FITTING (NON-SHEAR FERNOCO) TO BE UTILIZED BETWEEN PIPE TRANSITIONS AS NECESSARY.
 - CONTRACTOR TO COORDINATE COLUMN DOWNSPOUT ORIENTATION WITH CANOPY VENDOR. ADJUST DOWNSPOUT PIPING AS NECESSARY TO MAKE CONNECTION TO COLLECTOR PIPE.

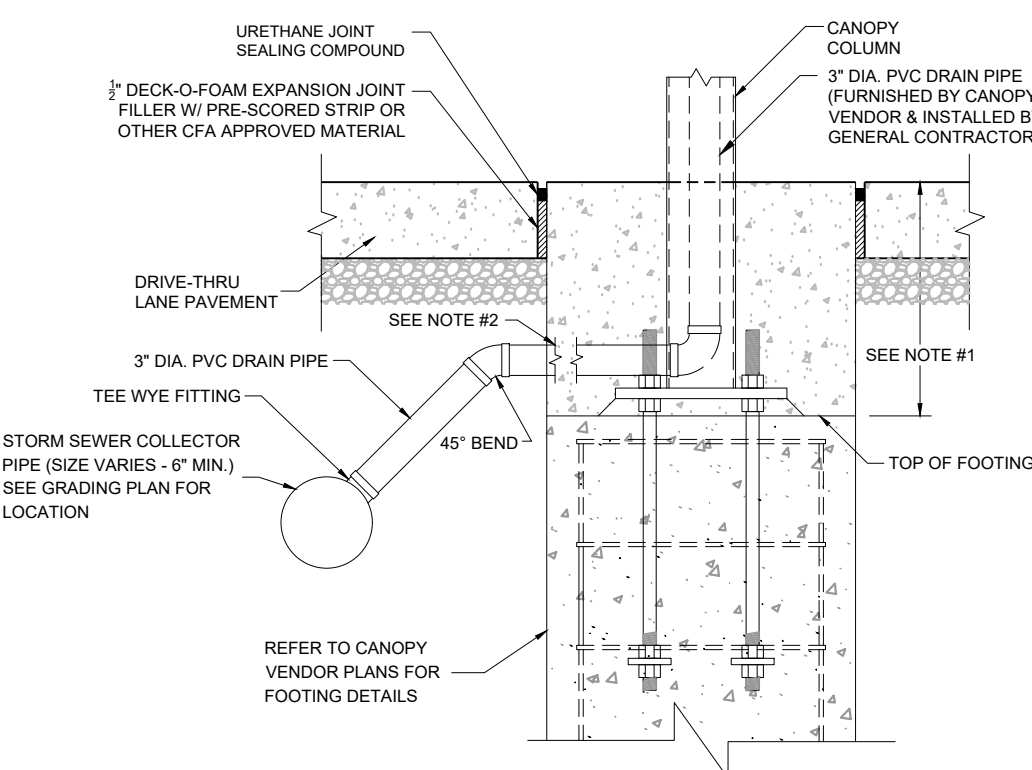

7 SCREENED REFUSE ENCLOSURE


- REFUSE ENCLOSURE PLAN NOTES:
- SEE SITE PLAN FOR LAYOUT OF CONCRETE APPROACH PAD.
 - SEE GRADING PLAN FOR ELEVATIONS ON DUMPSTER PAD & DRAINAGE OF INTERIOR TRASH ENCLOSURE.
 - PROVIDE POSITIVE DRAINAGE ON APPROACH PAD AWAY FROM DUMPSTER. (SEE GRADING PLAN)
 - SEE ARCHITECTURAL PLANS FOR ADDITIONAL DIMENSIONS & DETAILS ON ENCLOSURE; COORDINATE & VERIFY SIZE WITH ARCHITECT & STRUCTURAL ENGINEER.
 - GENERAL CONTRACTOR SHALL DRILL HOLES FOR GATE PINS IN BOTH THE OPEN & CLOSED POSITION.

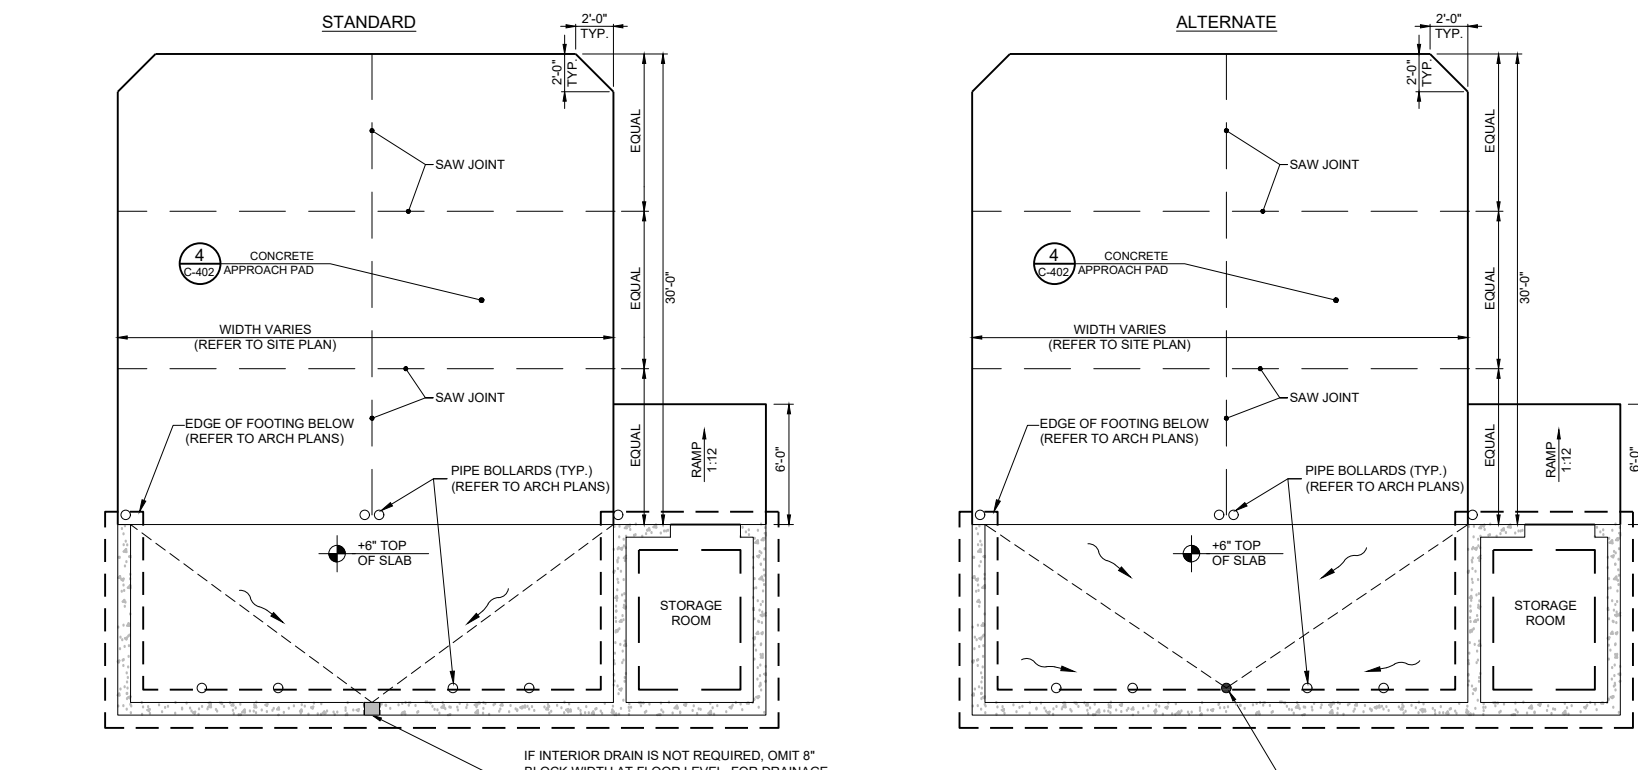

CONTRACTOR TO REFER TO CIVIL PLANS FOR ORIENTATION & LOCATION OF STORAGE ROOM & RAMP.


1 DRIVE-THRU PLAN - FLUSH WITH FFE

- NOTE:
- ALL ELEVATIONS ON THIS DETAIL ARE RELATIVE TO FFE = 0'.
 - FOR LC FOOTPRINT DECREASE LANDING FROM 38' TO 30'. LANDING SHOULD REMAIN CENTERED ON DRIVE-THRU WINDOW.

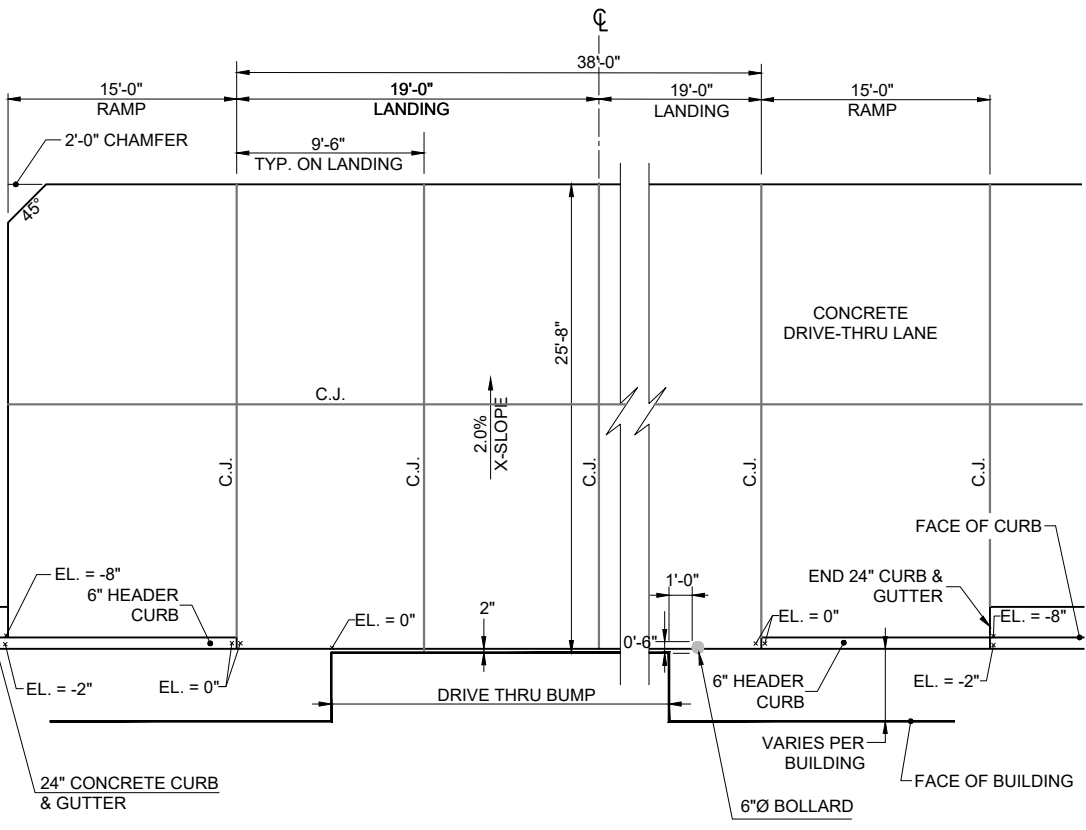


2 DRIVE-THRU ISOMETRIC

- NOTE:
- GENERAL CONTRACTOR SHALL REFERENCE GEOTECHNICAL REPORT FOR PAVEMENT SECTION REQUIREMENTS.
 - FOR LC FOOTPRINT DECREASE LANDING FROM 38' TO 30'. LANDING SHOULD REMAIN CENTERED ON DRIVE-THRU WINDOW.

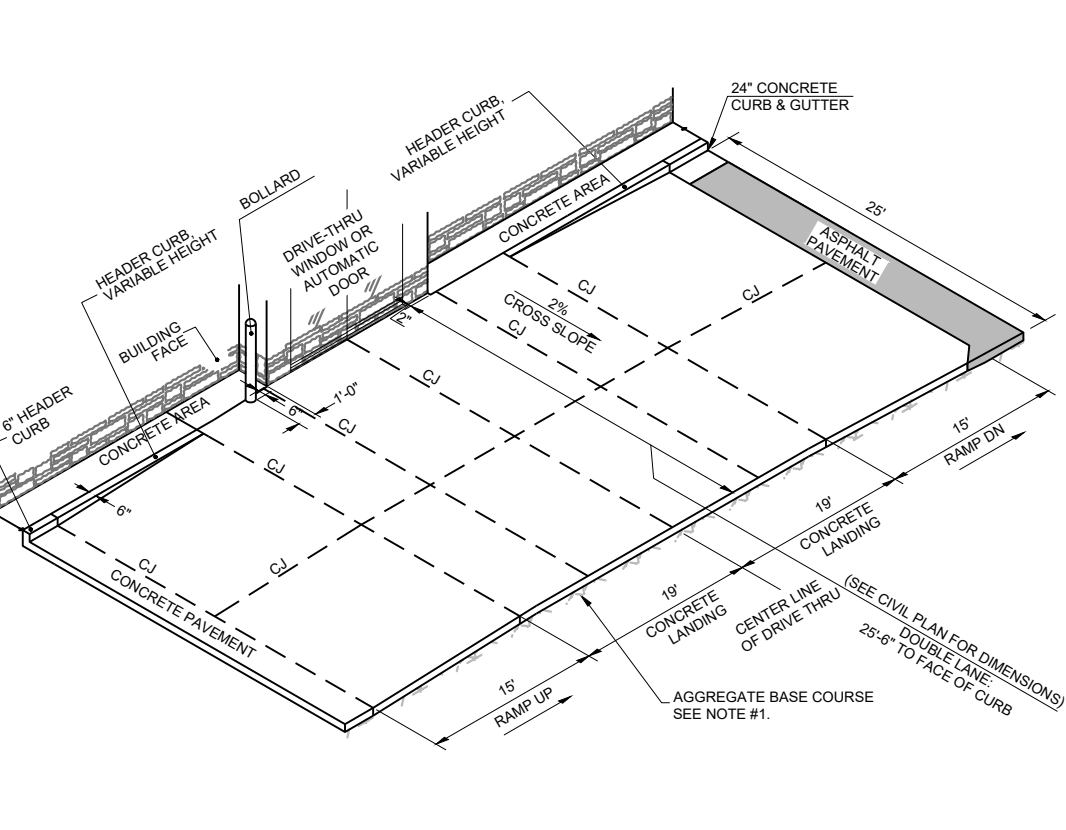


3 DRIVE-THRU ORDER POINT ISLAND

- NOTE:
- GENERAL CONTRACTOR SHALL REFERENCE GEOTECHNICAL REPORT FOR PAVEMENT SECTION REQUIREMENTS.
 - FOR LC FOOTPRINT DECREASE LANDING FROM 38' TO 30'. LANDING SHOULD REMAIN CENTERED ON DRIVE-THRU WINDOW.

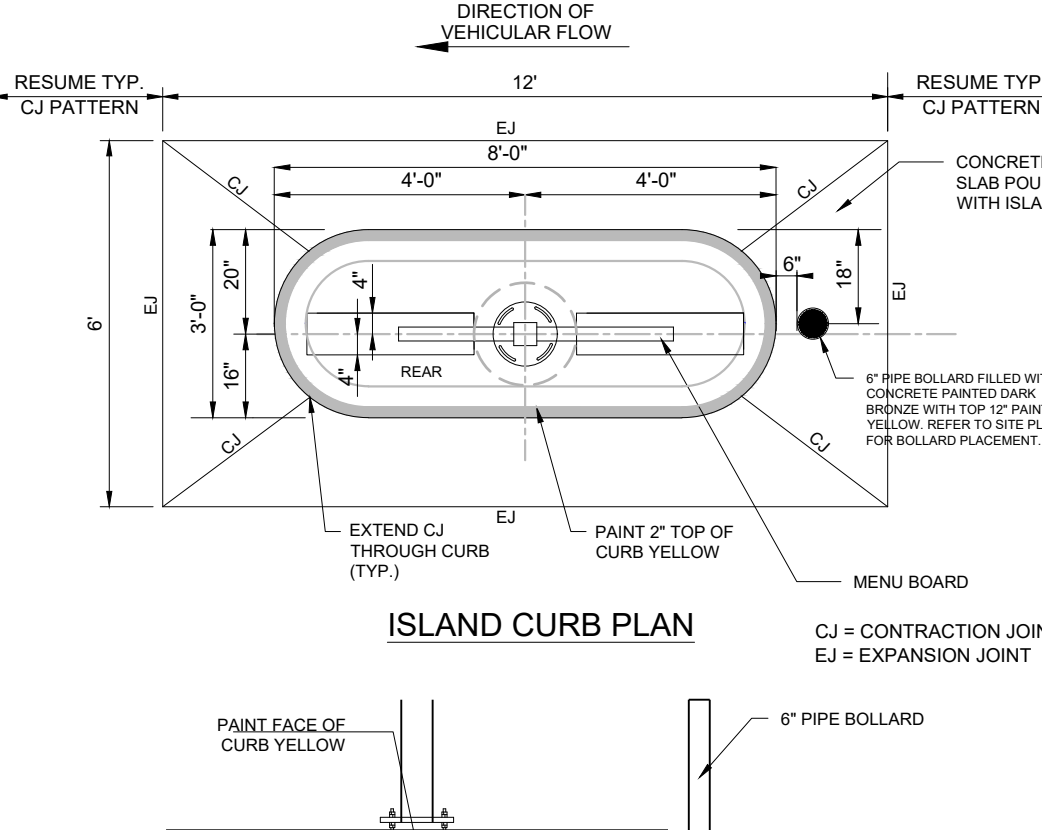

4 MENU BOARD LOOP DETECTION SYSTEM

- NOTES:
- LOOP DETECTOR IS PROVIDED BY HME.
 - FOLLOW MANUFACTURER'S RECOMMENDATIONS FOR INSTALLATION.

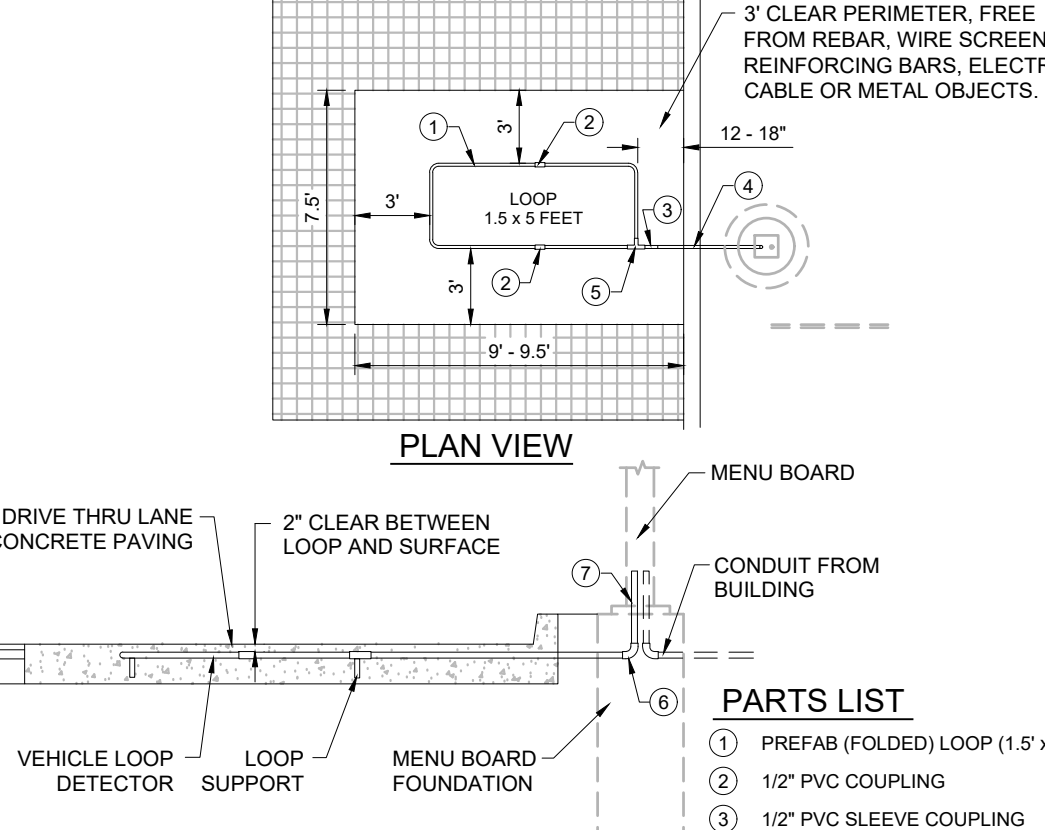

CONSTRUCTION DOCUMENTS

CHICK-FIL-A

POWERS & PALMER PARK

SEC OF POWERS BLVD AND PALMER
PARK BLVD COLORADO SPRINGS, CO 80915

FSR#05934

BUILDING TYPE / SIZE: P12 LS LRG
RELEASE: vX.YY.MM

REVISION SCHEDULE
NO. DATE DESCRIPTION


CONSULTANT PROJECT #
PRINTED FOR
DATE 01/31/2024
DRAWN BY CSS
SHEET
CFA STANDARD
DETAILS
SHEET NUMBER

C9.3

FOR AND AND ON-BEHALF OF
MERRICK AND COMPANY



Chick-fil-A
5200 Buffington Road
Atlanta, Georgia 30349-2998

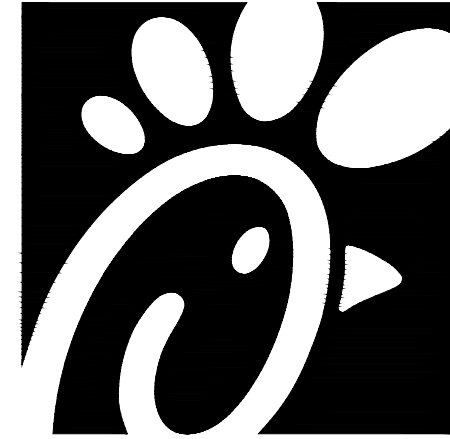


GENERAL NOTES:
1. CONSTRUCTION DETAILS TO BE ADDED IN FUTURE SUBMITTAL.



Know what's below.
Call before you dig.



Chick-fil-A
5200 Buffington Road
Atlanta, Georgia 30349-2998

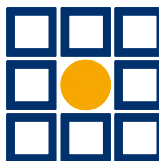

MERRICK®

5970 GREENWOOD PLAZA BLVD
GREENWOOD VILLAGE, CO 80111
303-751-0741

FOR AND AND ON-BEHALF OF
MERRICK AND COMPANY

CONSTRUCTION DOCUMENTS

CHICK-FIL-A
POWERS & PALMER PARK

SEC OF POWERS BLVD AND PALMER
PARK BLVD COLORADO SPRINGS, CO 80915

FSR#05934

BUILDING TYPE / SIZE: P12 LS LRG
RELEASE: vX.YY.MM

REVISION SCHEDULE		
NO.	DATE	DESCRIPTION

CONSULTANT PROJECT #	
PRINTED FOR	
DATE	01/31/2024
DRAWN BY	CSS
SHEET	
DETAILS	

SHEET NUMBER

C9.4

File Path: Q:\DEN\Projects\00810.00 CFA Powers & Palmer\LANDSCAPE\11-LA-CAD\11-LA-SHEETS\CDL01P 01
COVERSHEET.dwg Last Saved By: BOONE.LITTLE
1/31/2025 10:01 AM
00-LS-0000-A101-SHEET NAME



Know what's below.
Call before you dig.

GENERAL NOTES

1. THE CONTRACTOR SHALL FOLLOW ALL PLANS AS CLOSELY AS POSSIBLE. ANY DISCREPANCY IN THE PLAN VS. THE FIELD CONDITIONS SHALL BE REPORTED TO THE OWNER OR OWNER'S REPRESENTATIVE IMMEDIATELY.
2. ALL WORK SHALL BE CONFINED TO THE AREA WITHIN THE CONSTRUCTION LIMITS AS SHOWN ON THE PLANS. ANY AREAS OR IMPROVEMENTS DISTURBED OUTSIDE THESE LIMITS SHALL BE RETURNED TO THEIR ORIGINAL CONDITION AT THE CONTRACTOR'S EXPENSE. IN THE EVENT THE CONTRACTOR REQUIRES A MODIFICATION TO THE CONSTRUCTION LIMITS, WRITTEN PERMISSION MUST BE OBTAINED FROM THE OWNER OR OWNERS REPRESENTATIVE PRIOR TO ANY DISTURBANCE OUTSIDE OF THE LIMITS OF WORK.
3. THE CONTRACTOR SHALL BE RESPONSIBLE FOR UTILITY LOCATORS PRIOR TO START OF ANY REMOVALS OR CONSTRUCTION. THE CONTRACTOR IS RESPONSIBLE FOR THE COST TO REPAIR ANY UTILITIES OR EXISTING SITE FEATURES DAMAGED DUE TO CONSTRUCTION ACTIVITIES.
4. THE CONTRACTOR SHALL OBTAIN, AT HIS EXPENSE, ALL PERMITS WHICH ARE NECESSARY TO PERFORM THE PROPOSED WORK.
5. DO NOT DISTURB EXISTING PAVING, LIGHTING, LANDSCAPE, OR IRRIGATION THAT EXISTS ADJACENT TO THE SITE UNLESS OTHERWISE NOTED ON PLANS.
6. CONTRACTOR IS RESPONSIBLE FOR ANY DAMAGE CAUSED TO EXISTING SITE CONDITIONS.
7. THE CONTRACTOR SHALL PROVIDE A STAKED LAYOUT OF ALL SITE IMPROVEMENTS FOR INSPECTION BY THE OWNER'S REPRESENTATIVE AND MAKE MODIFICATIONS AS REQUESTED AT NO ADDITIONAL COST TO THE OWNER.
8. THE CONTRACTOR, HIS SUCCESSORS AND ASSIGNEES SHALL BE RESPONSIBLE FOR THE INSTALLATION, MAINTENANCE AND REPLACEMENT OF ALL LANDSCAPING MATERIALS SHOWN OR INDICATED ON THE APPROVED LANDSCAPE PLAN.
9. SIGHT TRIANGLES SHALL REMAIN UNOBSTRUCTED BY PLANT MATERIAL, OR ANY OTHER VISUAL OBSTACLE, OVER 30" IN HEIGHT.
10. ALL UTILITY EASEMENTS SHALL REMAIN UNOBSTRUCTED AND FULLY ACCESSIBLE ALONG THEIR ENTIRE LENGTH FOR THE MAINTENANCE EQUIPMENT ENTRY.
11. ANY MAJOR CHANGES MADE TO THE SITE PLAN AS A RESULT OF FIELD CONDITIONS SHALL BE ON THE AS-BUILTS OF THE CONSTRUCTION DRAWING SET, AS BUILT CONSTRUCTION DRAWINGS FOR THE LANDSCAPE, HARDSCAPE, LIGHTING WILL BE SUBMITTED, BY CONTRACTOR, TO THE OWNER, AS REQUESTED.
12. THE CLEANING OF CONCRETE TRUCK DELIVERY CHUTES SHALL BE PERFORMED AT DESIGNATED LOCATION BY THE GENERAL CONTRACTOR OR OWNER. THE DISCHARGE OF WATER CONTAINING WASTE CONCRETE TO THE STORM SEWER SYSTEM IS PROHIBITED.
13. GENERAL CONTRACTOR OR OWNER WILL DESIGNATE STAGING AND STORAGE FOR CONTRACTOR.

GRADING AND EROSION CONTROL NOTES

GRADING NOTES:

1. GENERAL CONTRACTOR WILL CONTOUR SUBGRADE TO ±3" PRIOR TO START OF LANDSCAPE CONTRACTOR'S WORK.
2. CALL UTILITY LOCATORS PRIOR TO START OF ANY REMOVALS OR CONSTRUCTION. THE CONTRACTOR IS RESPONSIBLE FOR THE COST TO REPAIR ANY UTILITIES OR EXISTING SITE FEATURES DAMAGED DUE TO CONSTRUCTION ACTIVITIES.
3. FINAL GRADES SHALL BE ESTABLISHED BY THE GENERAL CONTRACTOR. IF EXISTING CONDITIONS DIFFER, PLEASE NOTIFY THE OWNER'S REPRESENTATIVE PRIOR TO PROCEEDING WITH WORK. CONTACT OWNER'S REPRESENTATIVE FOR APPROVAL AFTER ROUGH GRADES HAVE BEEN ESTABLISHED.
4. THE LANDSCAPE CONTRACTOR RESPONSIBLE FOR FINAL FINE GRADE FREE OF ROCK AND DEBRIS.
5. ALL AREAS SHALL BE FINISH GRADE TO ACHIEVE POSITIVE DRAINAGE AWAY FROM THE BUILDINGS, WALLS AND WALKS.

EROSION CONTROL NOTES:

1. REFERENCE EROSION CONTROL PLANS FOR PROJECT STANDARDS AND GUIDELINES. THESE NOTES ARE FOR THE LANDSCAPE CONTRACTOR TO MEET THOSE STANDARDS DURING THEIR PHASE OF CONSTRUCTION.
2. THE CONTRACTOR IN COORDINATION WITH THE GENERAL CONTRACTOR AND/OR THEIR AUTHORIZED AGENTS SHALL REMOVE ALL SEDIMENT, MUD, AND CONSTRUCTION DEBRIS THAT MAY ACCUMULATE IN THE FLOW LINE AND THE PUBLIC RIGHTS-OF-WAY AS A RESULT OF THIS SITE DEVELOPMENT. SAID REMOVAL SHALL BE CONDUCTED IN A TIMELY MANNER.
3. THE CONTRACTOR IN COORDINATION WITH THE GENERAL CONTRACTOR SHALL PREVENT SEDIMENT, DEBRIS AND ALL OTHER POLLUTANTS FROM ENTERING THE STORM SEWER SYSTEM DURING ALL DEMOLITION OR CONSTRUCTION OPERATIONS THAT ARE PART OF THIS PROJECT.
4. THE CONTRACTOR SHALL BE HELD RESPONSIBLE FOR REMEDIATION OF ANY ADVERSE IMPACTS TO ADJACENT WATERWAYS, WETLANDS, ETC., RESULTING FROM WORK DONE AS PART OF THIS PROJECT.
5. WOOD STAKES MAY BE USED. CONTRACTOR MAY NOT USE REBAR, STEEL STAKES, OR STEEL FENCE POSTS TO STAKE DOWN STRAW OR HAY BALES OR TO SUPPORT SILT FENCING USED AS AN EROSION CONTROL MEASURE.

LANDSCAPE NOTES

LANDSCAPE

1. THE CONTRACTOR SHALL FOLLOW ALL PLANS AS CLOSELY AS POSSIBLE. ANY DISCREPANCY IN THE PLAN VS. THE FIELD CONDITIONS SHALL BE REPORTED TO THE OWNER OR OWNER'S REPRESENTATIVE IMMEDIATELY.
2. REFER TO QUANTITIES SHOWN GRAPHICALLY IF DISCREPANCIES EXIST BETWEEN WRITTEN AND GRAPHIC QUANTITIES.
3. ALL PLANT MATERIALS WILL CONFORM TO THE MINIMUM GUIDELINES ESTABLISHED BY THE AMERICAN STANDARD FOR NURSERY STOCK, CURRENT EDITION, PUBLISHED BY THE AMERICAN ASSOCIATION OF NURSERYMEN, INC.
4. ALL PLANTS WILL BE BALLED AND BURLAPPED OR CONTAINER GROWN. BARE ROOT OF SPADED PLANTS WILL NOT BE ACCEPTED.
5. ALL PLANTS, PRODUCTS AND MATERIALS WILL BE INSPECTED AND APPROVED BY THE OWNERS REPRESENTATIVE IF REQUESTED BY OWNER. THIS WILL BE DETERMINED DURING THE BID PROCESS.
6. THE CONTRACTOR SHALL WARRANTY THE PLANT MATERIAL, WORKMANSHIP, AND THE IRRIGATION SYSTEM FOR A PERIOD OF ONE YEAR.

TURF AND NATIVE SEED AREAS

7. TURF GRASS TO BE RTF® WATER SAVER® SOD TALL FESCUE FROM GREEN VALLEY TURF COMPANY. ANY SUBSTITUTES OR CHANGES WILL REQUIRE WRITTEN REQUEST FOR APPROVAL FROM THE OWNERS REPRESENTATIVE.
8. BIOCOMP FROM A-1 ORGANICS (OR APPROVED EQUAL) TO ALL SOD AND PLANTING AREAS AT A RATE OF 4 CUBIC YARDS PER 1,000 S.F.
9. IF PROPOSED NATIVE SEED MIX AS SHOWN ON PLANS. ANY SUBSTITUTES OR CHANGES WILL REQUIRE WRITTEN REQUEST FOR APPROVAL FROM THE OWNERS REPRESENTATIVE.
10. BIOSOIL APPLIED TO ALL SEEDED AREAS AT A RATE OF 3 LBS PER 1,000 S.F.
11. CONTRACTOR IS RESPONSIBLE FOR IMPLEMENTING EROSION CONTROL MEASURES ON SEEDED SLOPES EXCEEDING 3:1.
12. THE LANDSCAPE CONTRACTOR SHALL BE RESPONSIBLE FOR THE ESTABLISHMENT OF NATIVE SEEDED AREAS (NATURALIZED AREAS). AFTER A PERIOD OF ONE YEAR, THERE SHOULD BE SIGNIFICANT COVERAGE OF THE SEEDED AREA WITH BARE SPOTS NOT EXCEEDING NINE SQUARE FEET IN SIZE. BARE SPOTS SHALL BE RE-SEEDED AND MULCHED TO IMPROVE THE GRASS STAND. THE AREA SHALL BE MAINTAINED AS WEED FREE THE ENTIRE TIME. MOWING, PULLING, AND CHEMICAL METHODS MAY BE USED TO CONTROL WEEDS AND PREVENT REDEVELOPMENT OF SEED HEADS ON THE WEED PLANT.

TREES

13. REFER TO THE PLANTING DETAILS AND PLANT SCHEDULE AS SHOWN ON THE PLAN FOR FURTHER INFORMATION.
14. REFER TO QUANTITIES SHOWN GRAPHICALLY IF DISCREPANCIES EXIST BETWEEN WRITTEN AND GRAPHIC QUANTITIES.
15. ALL TREES LOCATED IN THE UTILITY EASEMENT WILL BE REQUIRED TO BE HAND DUG PER THE TREE PLANTING DETAIL. CONTRACTOR IS RESPONSIBLE FOR IDENTIFYING EXISTING GAS LINE PRIOR TO INSTALLATION OF TREES AND FLAGGING THE GAS LINE LOCATION.
16. TREES IN COBBLE/ROCK MULCH AREAS TO RECEIVE 4' DIAMETER OF WOOD MULCH AS SHOWN IN PLANTING DETAILS.

PLANTING BED AREAS


17. REFER TO THE PLANTING DETAILS AND PLANT SCHEDULE AS SHOWN ON THE PLAN FOR FURTHER INFORMATION.
18. REFER TO QUANTITIES SHOWN GRAPHICALLY IF DISCREPANCIES EXIST BETWEEN WRITTEN AND GRAPHIC QUANTITIES.
19. BIOCOMP FROM A-1 ORGANICS (OR APPROVED EQUAL) TO ALL SOD AND PLANTING AREAS AT A RATE OF 4 CUBIC YARDS PER 1,000 S.F., A MINIMUM 8" TILLED.
20. WOVEN LANDSCAPE FABRIC INSTALLED UNDER ALL ROCK AREAS FOR WEED CONTROL. ROCK MULCH 4"-8" GLACIER WHITE COBBLE FROM PIONEER SAND OR APPROVED EQUAL. ANY SUBSTITUTES OR CHANGES WILL REQUIRE WRITTEN REQUEST FOR APPROVAL FROM THE OWNERS REPRESENTATIVE.
21. ALL ANNUAL AND PERENNIAL BEDS ARE TO BE MULCHED WITH 3" DEPTH CEDAR WOOD MULCH. NO WEED CONTROL FABRIC IS REQUIRED IN GROUNDCOVER BEDS. MULCH SAMPLE TO BE APPROVED BY OWNERS REPRESENTATIVE.
22. 4" SURE-LOC ALUMINUM LANDSCAPE EDGER (OR APPROVED EQUAL) TO BE USED BETWEEN ALL LANDSCAPE TRANSITION AREAS WITH A ROLLED TOP AND GREEN FINISH.
23. EDGER IS REQUIRED BETWEEN MULCHED AREAS AND ROCK AREAS WITHIN PLANTING BEDS.
24. ALL PLANTS WILL BE BALLED AND BURLAPPED OR CONTAINER GROWN. BARE ROOT OF SPADED PLANTS WILL NOT BE ACCEPTED.

IRRIGATION NOTES


1. ALL TURF AREAS TO BE IRRIGATED WITH AN AUTOMATIC POPUP SPRINKLER SYSTEM. ALL SHRUB BEDS TO BE IRRIGATED WITH AUTOMATIC DRIP IRRIGATION SYSTEM. THE IRRIGATION SYSTEM TO BE ADJUSTED TO MEET THE NEEDS OF INDIVIDUAL PLANT MATERIAL.
2. IRRIGATION SYSTEM TO BE ADJUSTED AS NEEDED FOR PLANT ESTABLISHMENT FOR A PERIOD OF AT LEAST 1 YEAR.
3. ADJUSTMENTS TO BE MADE AFTER ESTABLISHMENT BASED ON SPECIFIC PLANT REQUIREMENTS.
4. DESIGN OF IRRIGATION SYSTEMS TO MEET OR EXCEED LOCAL REQUIREMENTS AND INDUSTRY STANDARDS. CONSTRUCTION DOCUMENTS SUITABLE FOR DEVELOPMENT COORDINATION TO BE PROVIDED.
5. IRRIGATION SYSTEM TO BE DESIGNED USING APPROPRIATE COMPONENTS FOR PLANT MATERIAL AND WILL INCLUDE A SMART ET CONTROLLER AND RAIN SENSOR. EFFICIENT IRRIGATION SYSTEMS INCLUDING RAIN AND WIND SENSORS, CONTROLLERS ACCESSING WEATHER STATIONS, OR OTHER ALTERNATIVE METHODS THAT ADJUST IRRIGATION BASED OFF OF WEATHER EVENTS WILL BE INSTALLED

2

1

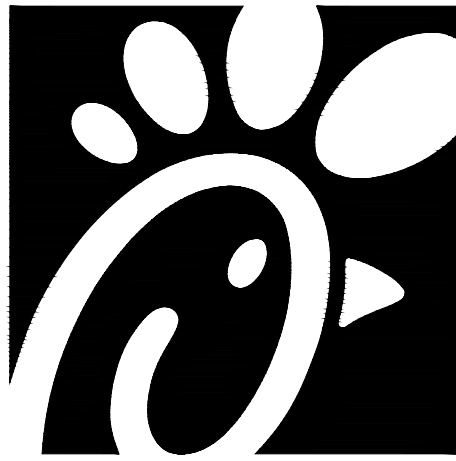

Chick-fil-A
5200 Buffington Road
Atlanta, Georgia 30349-2998

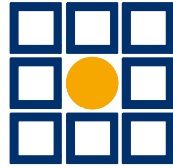

MERRICK®

5970 GREENWOOD PLAZA BLVD
GREENWOOD VILLAGE, CO 80111
303-751-0741

FOR AND ON BEHALF OF
MERRICK AND COMPANY

CHICK-FIL-A
POWERS & PALMER PARK
SEC OF POWERS BLVD AND PALMER
PARK BLVD COLORADO SPRINGS, CO 80915

FSR#05934

BUILDING TYPE / SIZE: P12 LS LRG
RELEASE: vX.YY.MM

REVISION SCHEDULE

NO.	DATE	DESCRIPTION
-----	------	-------------

CONSULTANT PROJECT #

PRINTED FOR

DATE 01/31/2024

DRAWN BY CSS

SHEET

LANDSCAPE COVER

SHEET NUMBER

13


4

3













2


1

File Path: Q:\DEN\Projects\100810.00 CFA Powers & Palmer\LANDSCAPE\11-LA-CAD\11-LA-SHEETS\CDLP 02 LANDSCAPE
PLAN.dwg Last Saved By: BOONELITTLE
1/31/2025 10:01 AM
00-LS-0000-A101-SHEET NAME

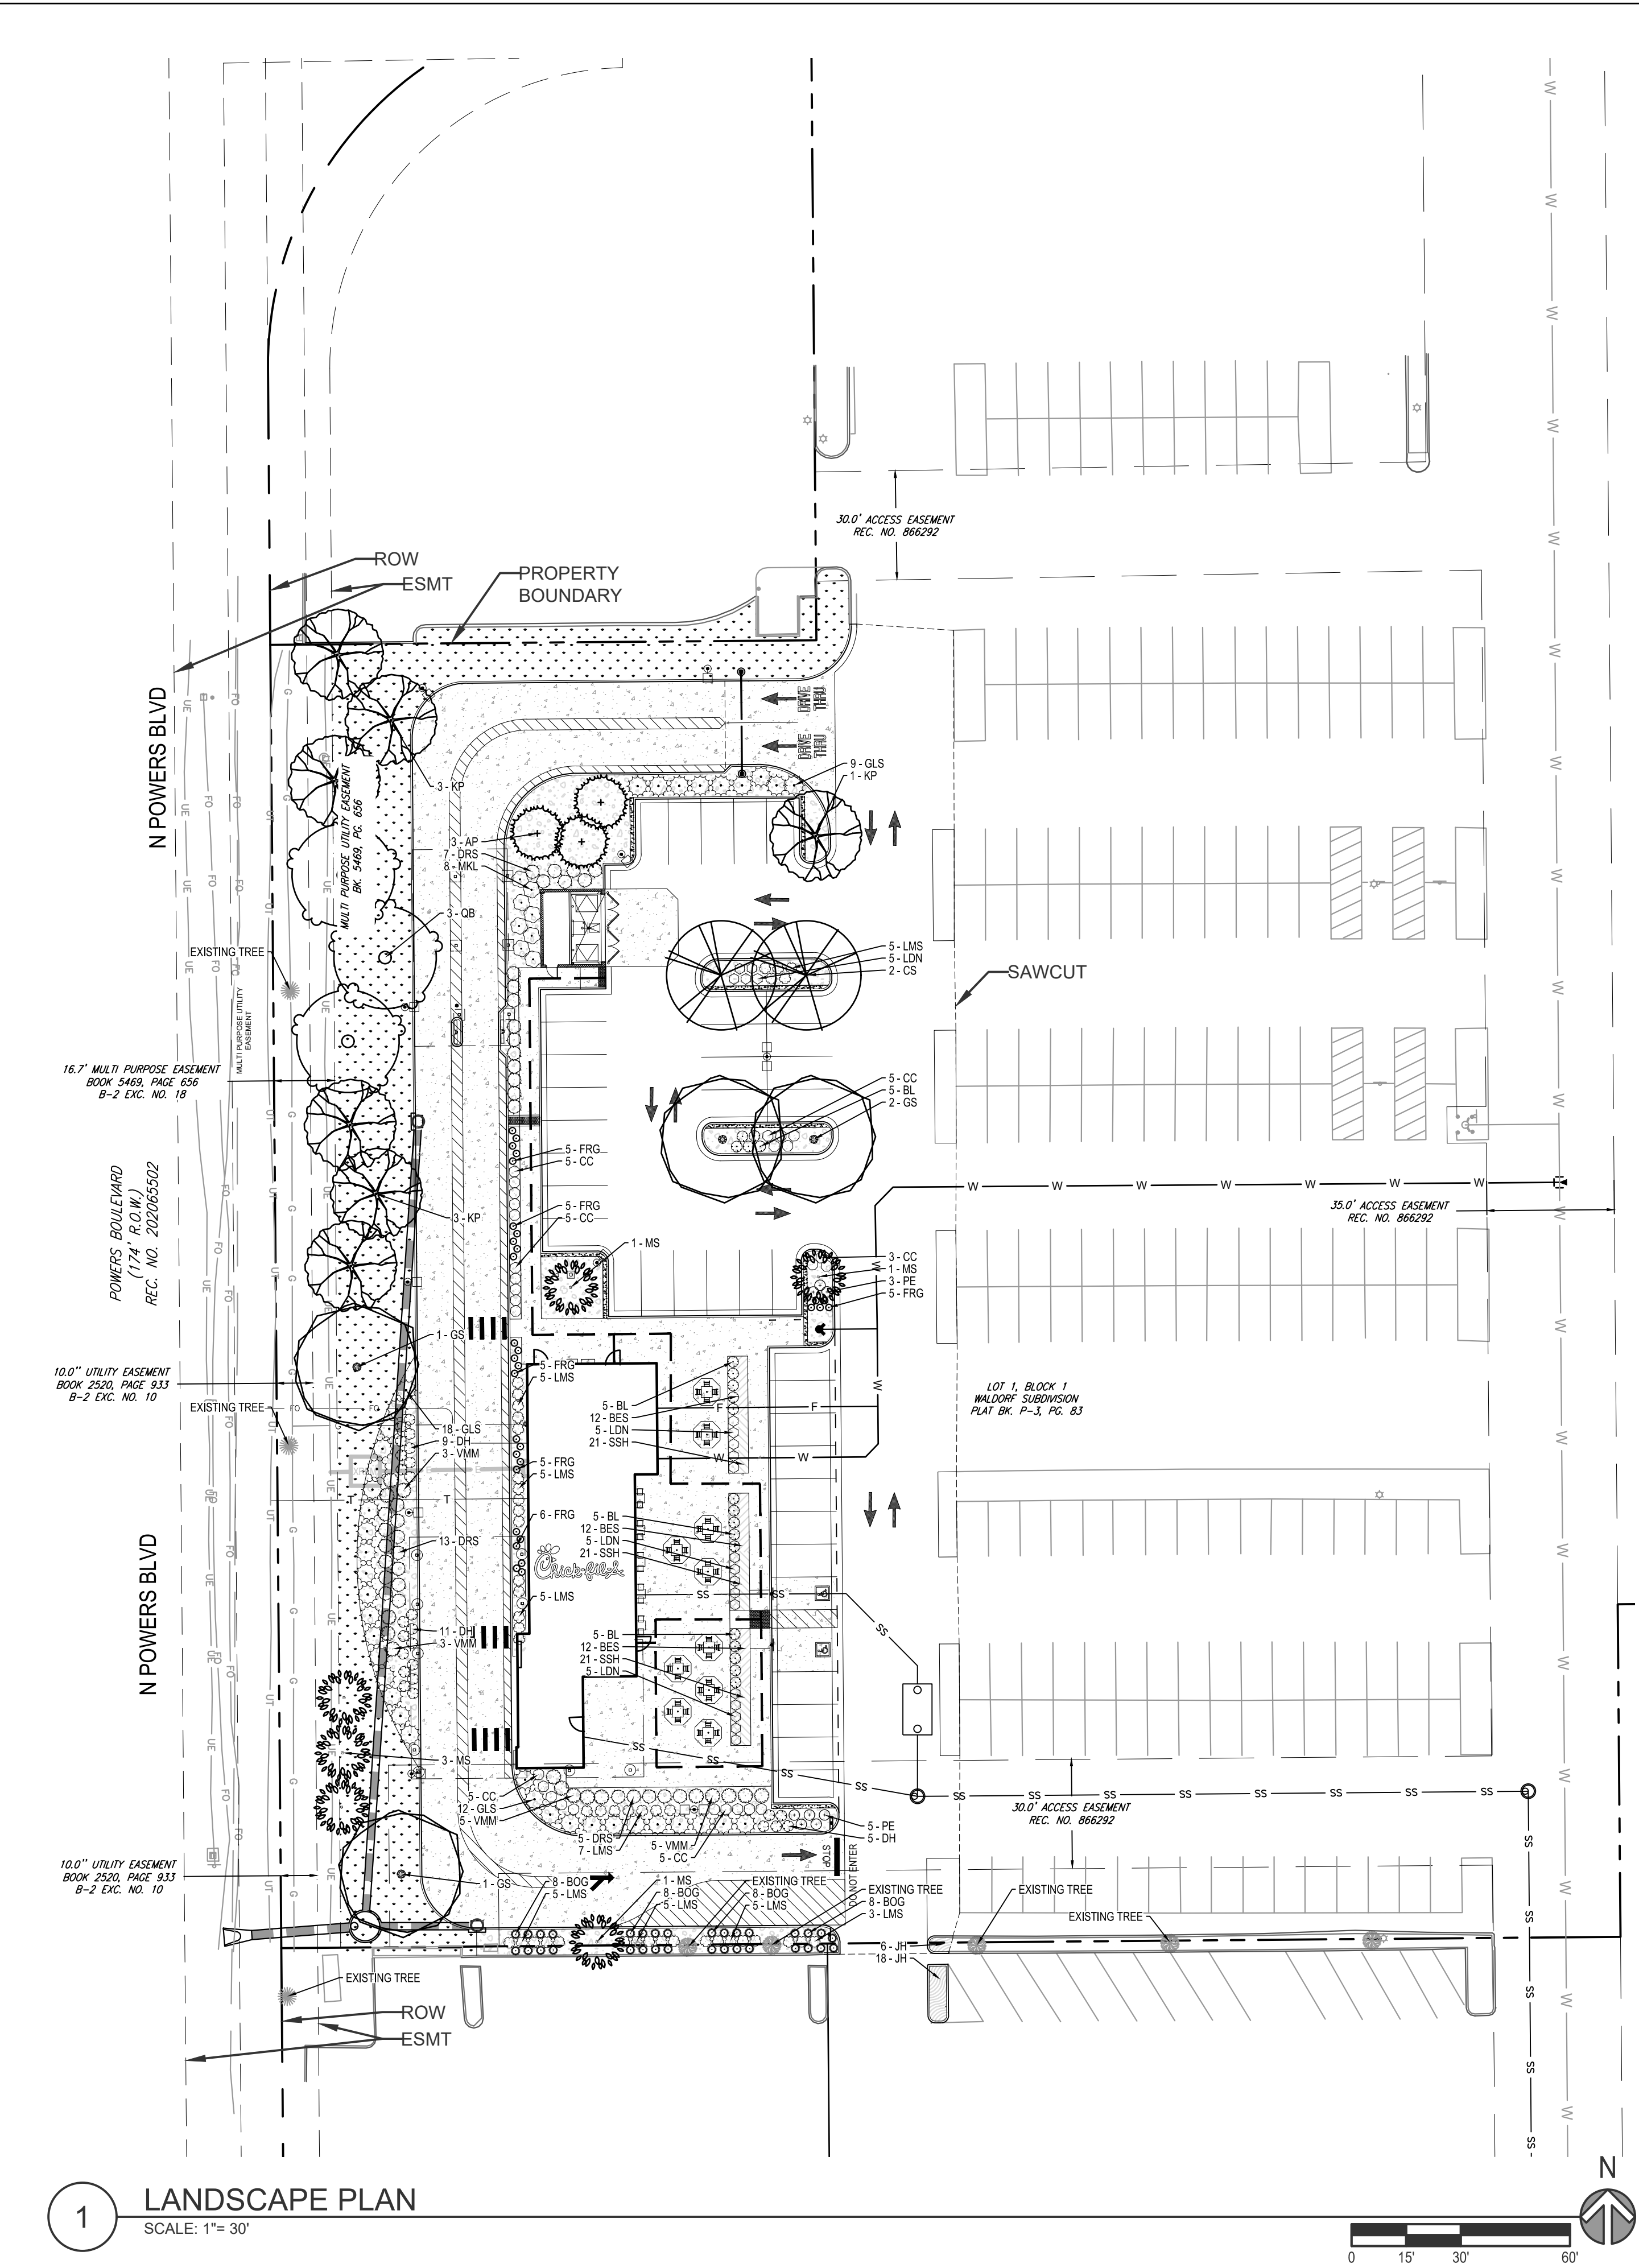

PLANT SCHEDULE

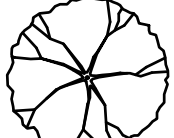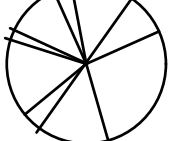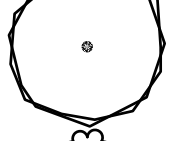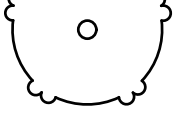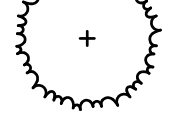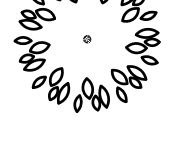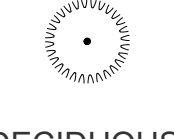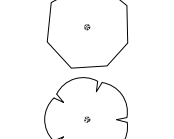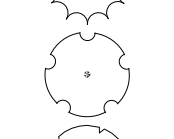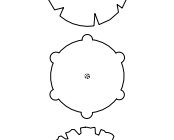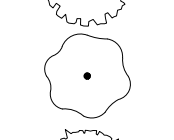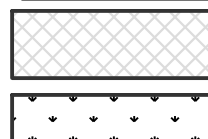SYMBOL	CODE	QTY	COMMON NAME	BOTANICAL NAME	SIZE	SPACING
DECIDUOUS TREES						
	KP	7	GOLDEN RAIN TREE	KOELREUTERIA PANICULATA	1.5" CAL.	
	CS	2	NORTHERN CATALPA	CATALPA SPECIOSA	1.5" CAL.	
	GS	4	SHADEMASTER HONEY LOCUST	GLEDITSIA TRIACANTHOS INERMIS 'SHADEMASTER'	1.5" CAL.	
	QB	3	SWAMP WHITE OAK	QUERCUS BICOLOR	1.5" CAL.	
EVERGREEN TREES						
	AP	3	AUSTRIAN PINE	PINUS NIGRA	6' HT.	
ORNAMENTAL TREES						
	MS	6	SPRING SNOW CRABAPPLE	MALUS X 'SPRING SNOW'	1.5" CAL.	
EVERGREEN SHRUBS						
	PE	8	PALOUSE MUGO PINE	PINUS MUGO 'PALOUSE'	5 GAL.	
ORNAMENTAL GRASSES						
	BOG	32	BLUE OAT GRASS	HELICTOTRICHON SEMPERVIRENS	5 GAL.	
	FRG	31	KARL FOERSTER FEATHER REED GRASS	CALAMAGROSTIS X ACUTIFLORA 'KARL FOERSTER'	5 GAL.	
DECIDUOUS SHRUBS						
	CC	28	BLUE MIST SPIREA	CARYOPTERIS X CLANDONENSIS	5 GAL.	
	DH	25	GOLD STAR BUSH CINQUEFOIL	DASIPHORA FRUTICOSA 'GOLD STAR'	5 GAL.	
	GLS	39	GRO-LOW FRAGRANT SUMAC	RHUS AROMATICA 'GRO-LOW'	5 GAL.	
	LMS	45	LIMEMOUND® SPIREA	SPIRAEA X BUMALDA 'LIMEMOUND'	5 GAL.	
	BL	20	LIMONCELLO™ BARBERRY	BERBERIS THUNBERGII 'BAILERIN'	5 GAL.	
	LDN	20	LITTLE DEVIL™ DWARF NINEBARK	PHYSOCARPUS OPULIFOLIUS 'DONNA MAY'	5 GAL.	
	VMM	16	MINI MAN™ DWARF MANCHURIAN VIBURNUM	VIBURNUM BUREJAETICUM 'P017S'	5 GAL.	
	MKL	8	MISS KIM KOREAN LILAC	SYRINGA PATULA 'MISS KIM'	5 GAL.	
	DRS	35	RUSSIAN SAGE	PEROVSKIA ABROTANOIDES	5 GAL.	
GROUND COVERS						
	WM	176 SF	WOOD MULCH - WASHINGTON RED CEDAR		--	
	SM	8,662 SF	ARKANSAS VALLEY FOOTHILLS SEED MIX		--	
	BES	36	BLACK-EYED SUSAN	R. FULGIDA 'GOLDSTRUM'	1 GAL HT 30-36" SPD 18-24"	24" o.c.
	CR	180 SF	CRUSHER FINES		--	
	SSH	63	DWARF SHASTA DAISY	LEUCANTHEMUM COMPACT 'SNOW LADY'	1 GAL HT 18-30" SPD 12-20"	18" o.c.
	JH	24	HUGHES CREEPING JUNIPER	JUNIPERUS HORIZONTALIS 'HUGHES'	1 GAL.	24" o.c.
	RM	6,212 SF	ROCK MULCH - SEE LANDSCAPE NOTES SHEET		--	

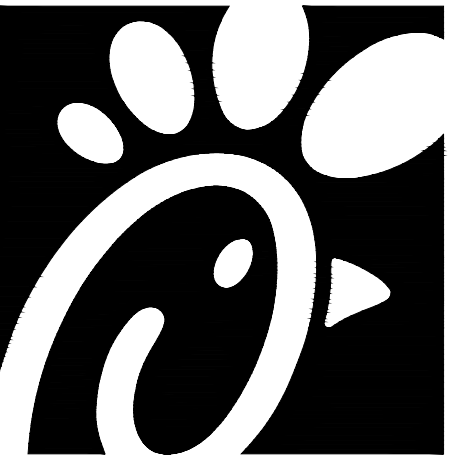

Chick-fil-A
5200 Buffington Road
Atlanta, Georgia 30349-2998



5970 GREENWOOD PLAZA BLVD
GREENWOOD VILLAGE, CO 80111
303-751-0741

FOR AND ON BEHALF OF
MERRICK AND COMPANY

CONSTRUCTION DOCUMENTS

CHICK-FIL-A
POWERS & PALMER PARK
SEC OF POWERS BLVD AND PALMER
PARK BLVD COLORADO SPRINGS, CO 80915

FSR#05934

BUILDING TYPE / SIZE: P12 LS LRG
RELEASE: vX.YY.MM

REVISION SCHEDULE

NO. DATE DESCRIPTION

CONSULTANT PROJECT #

PRINTED FOR

DATE 01/31/2024

DRAWN BY CSS

SHEET

LANDSCAPE PLAN

SHEET NUMBER

14


File Path: Q:\DEN\Projects\100810.00 CFA Powers & Palmer\LANDSCAPE\11-LA-CAD\1-LA-SHEETS\CDLP 03 LANDSCAPE
DETAILS.dwg Last Saved By: BOONELITTLE
1/31/2025 10:01 AM
00-LS-0000-A101-SHEET NAME



Know what's below.
Call before you dig.

4 STEEL EDGER


1" = 1'-0" MSD-P-06

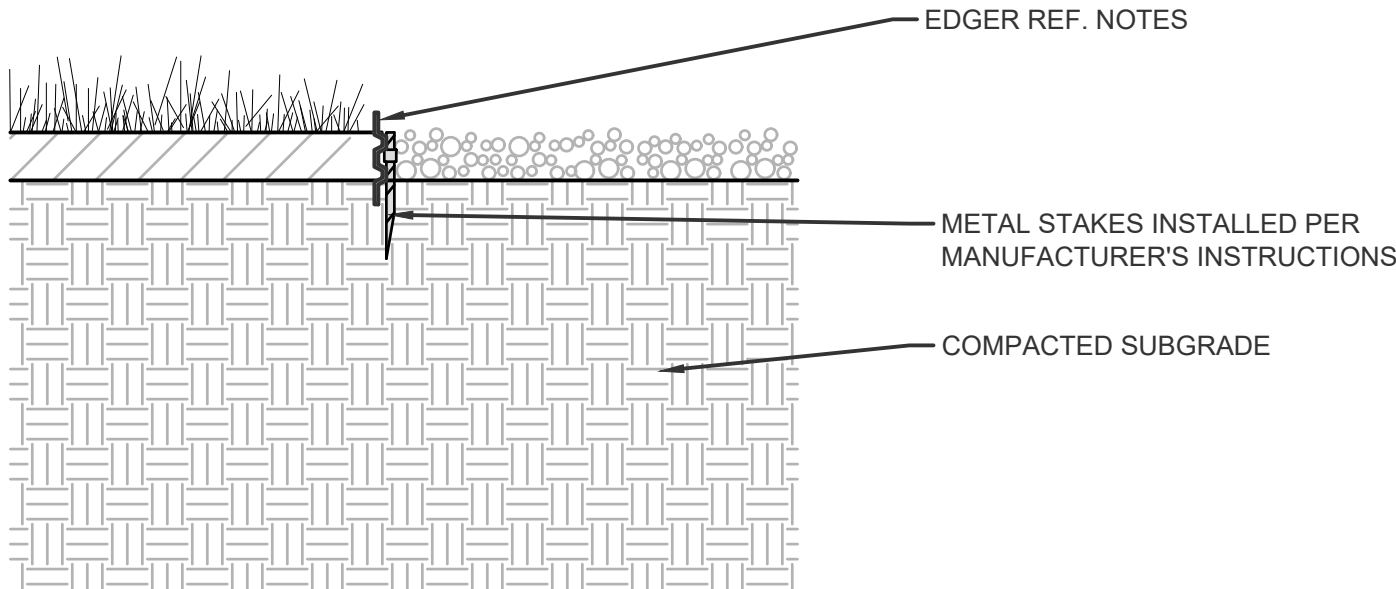

1 TREE PLANTING DETAIL


SCALE: NTS MSD-P-01

- NOTES:
1. SET ALL EDGING ABOVE FINISHED GRADE AS SHOWN.
 2. EDGING SHALL ABUT ALL CONCRETE CURBS AND WALKS PERPENDICULAR, & FLUSH WITH GRADES OF CONCRETE.
 3. INSTALLATION TO BE COMPLETED IN ACCORDANCE WITH MANUFACTURE'S SPECIFICATIONS.
 4. THERE SHALL BE NO EXPOSED SHARP/ JAGGED EDGES.
 5. FOR PRODUCT ORDERING, DIVIDE NUMBER OF FEET NEEDED BY 9.33 TO OBTAIN THE NUMBER OF 10' PIECES NEEDED.
 6. REF. PLANS FOR LOCATING EDGING
 7. 4" SURE-LOC ALUMINUM LANDSCAPE EDGER (OR APPROVED EQUAL) TO BE USED BETWEEN ALL LANDSCAPE TRANSITION AREAS WITH A ROLLED TOP AND GREEN FINISH.
 8. EDGER IS REQUIRED BETWEEN MULCHED AREAS AND ROCK AREAS WITHIN PLANTING BEDS.

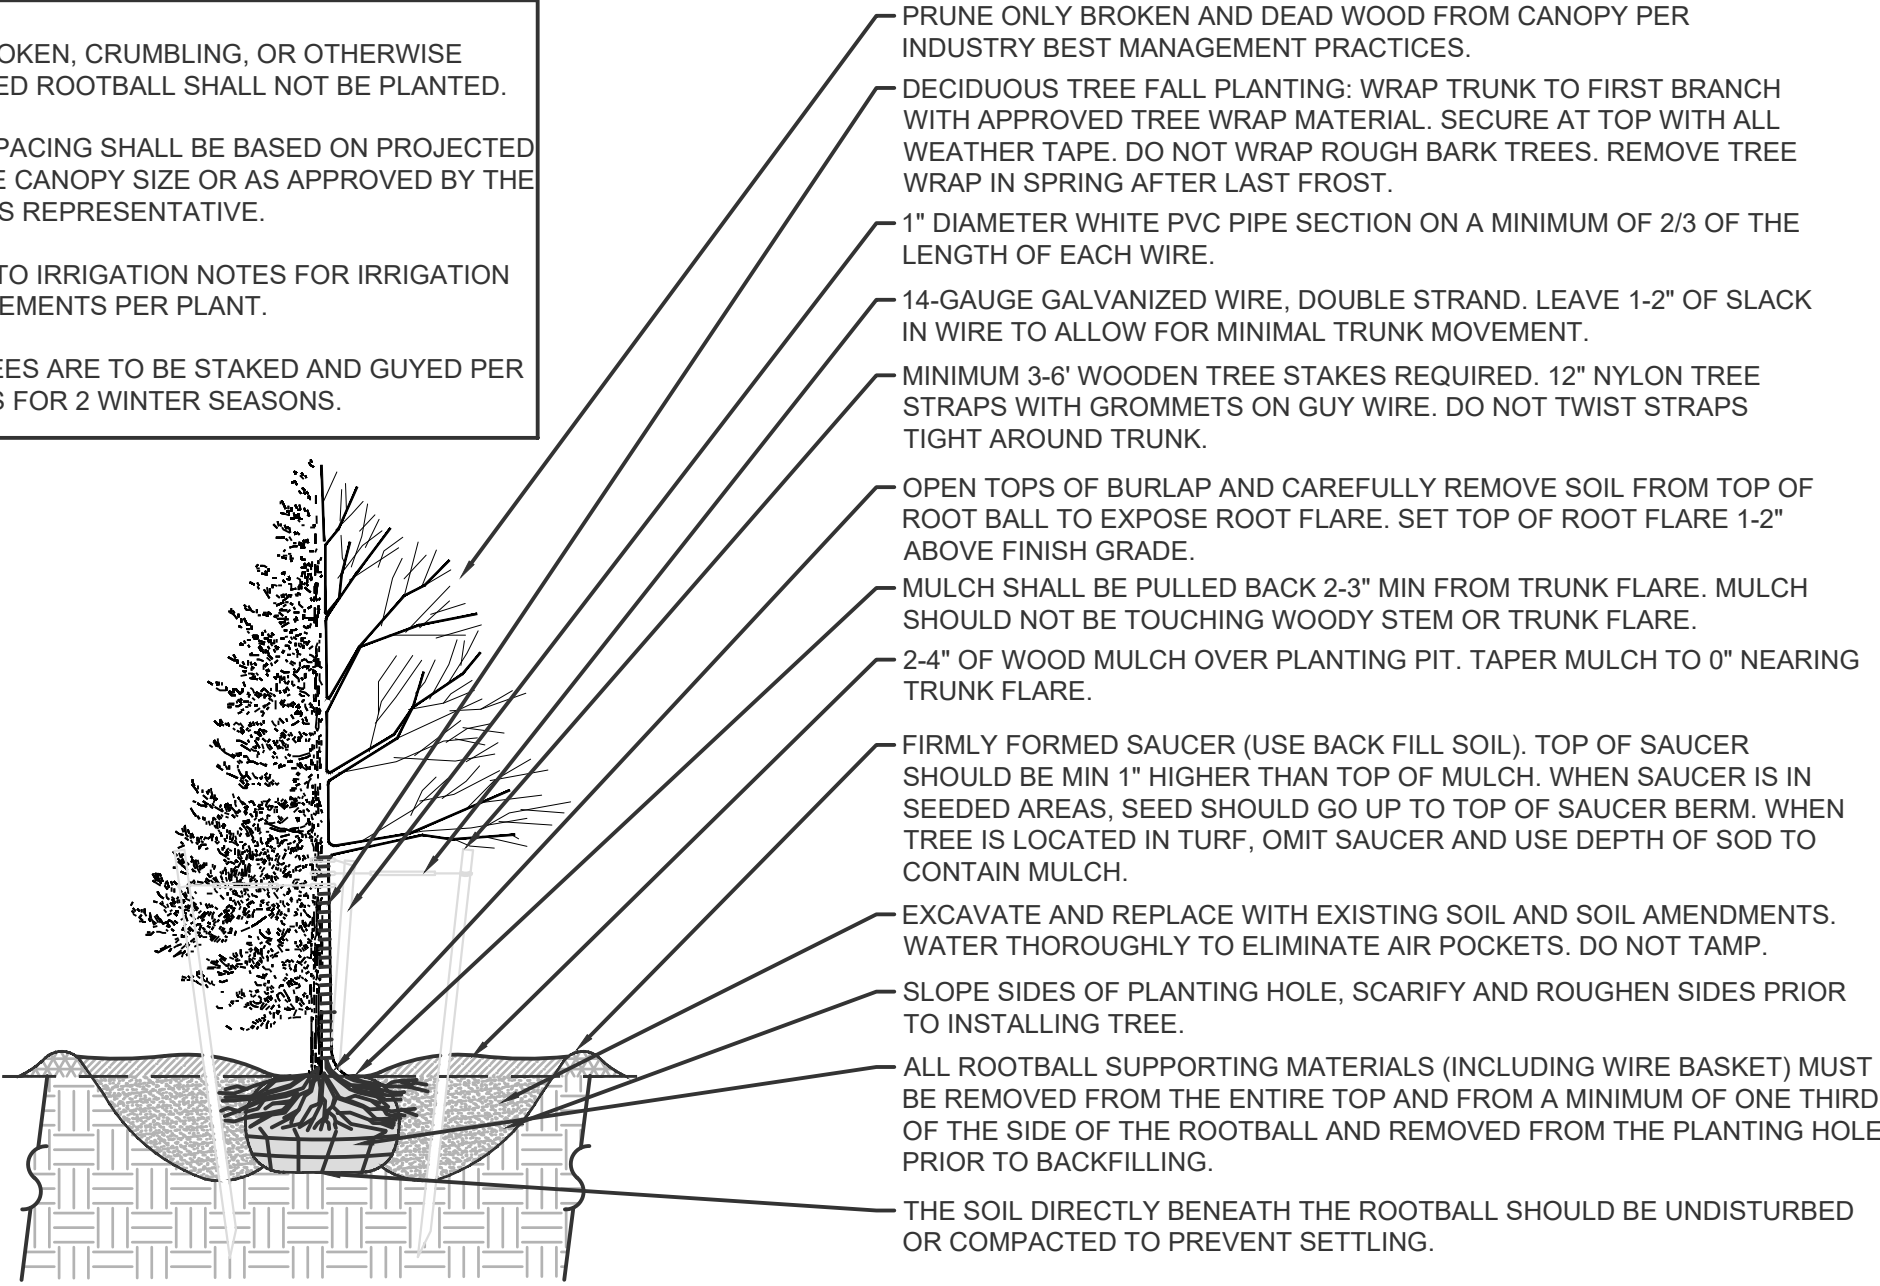


2 SHRUB PLANTING DETAIL

SCALE: NTS MSD-P-02

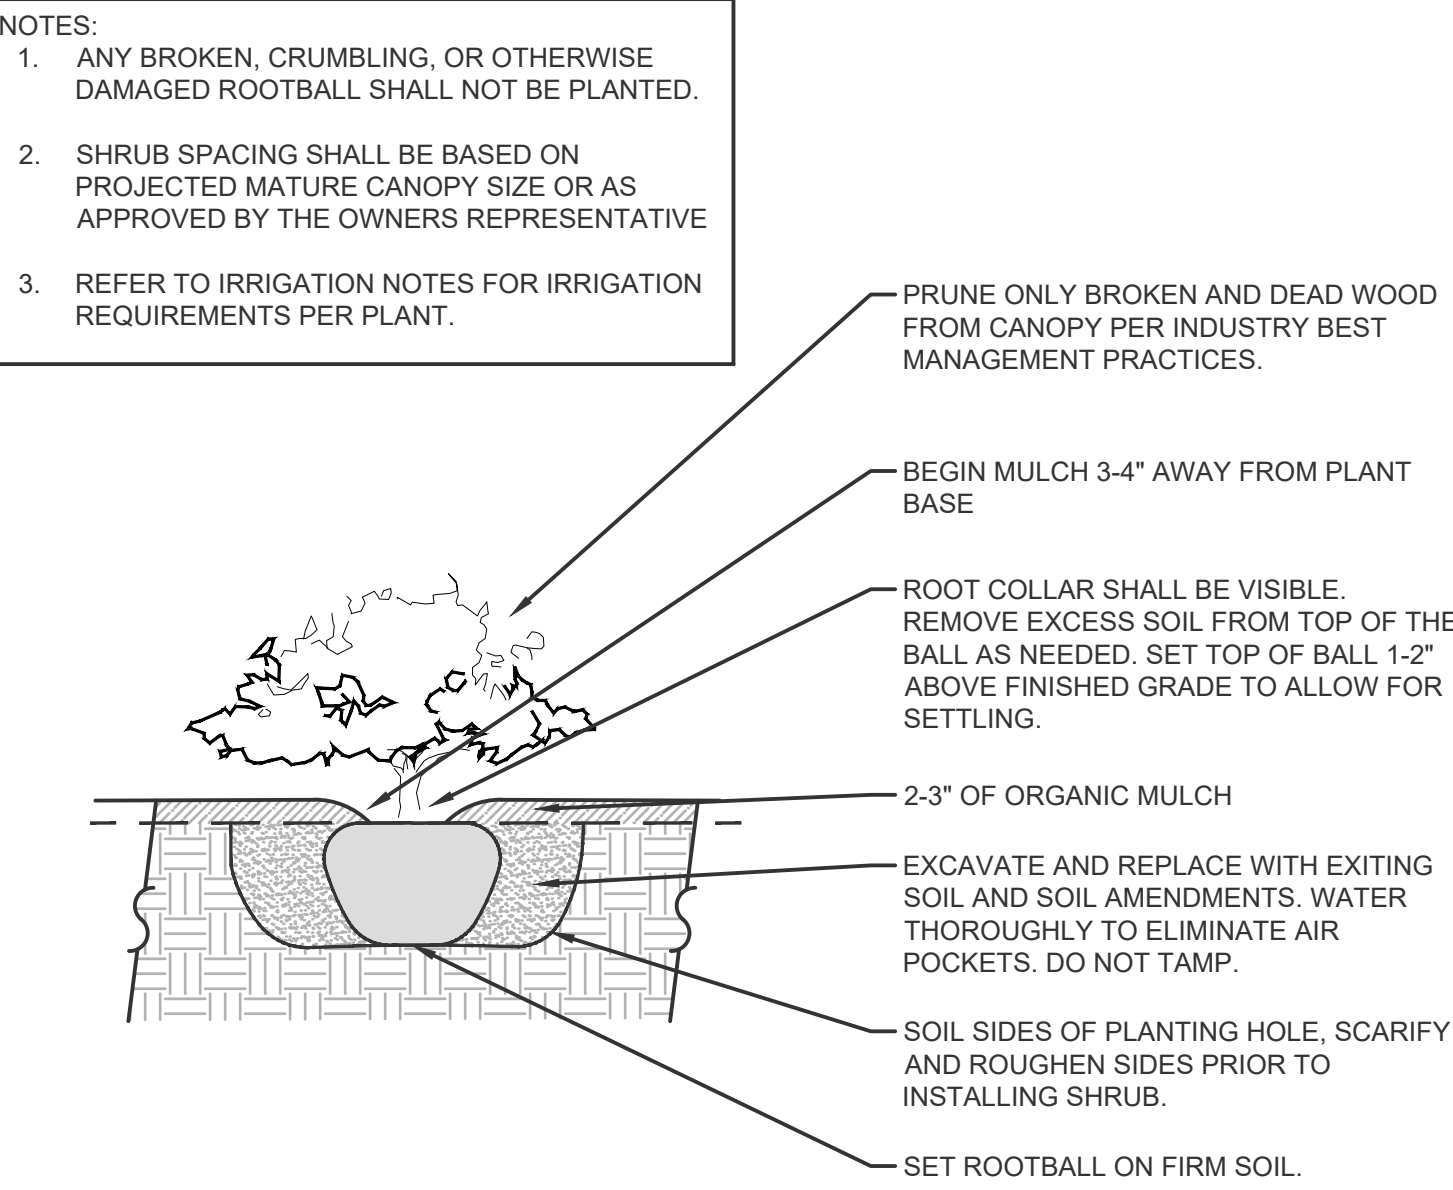

3 PERENNIAL & ORNAMENTAL GRASS TRIANGULATION

1" = 1'-0" MSD-P-03

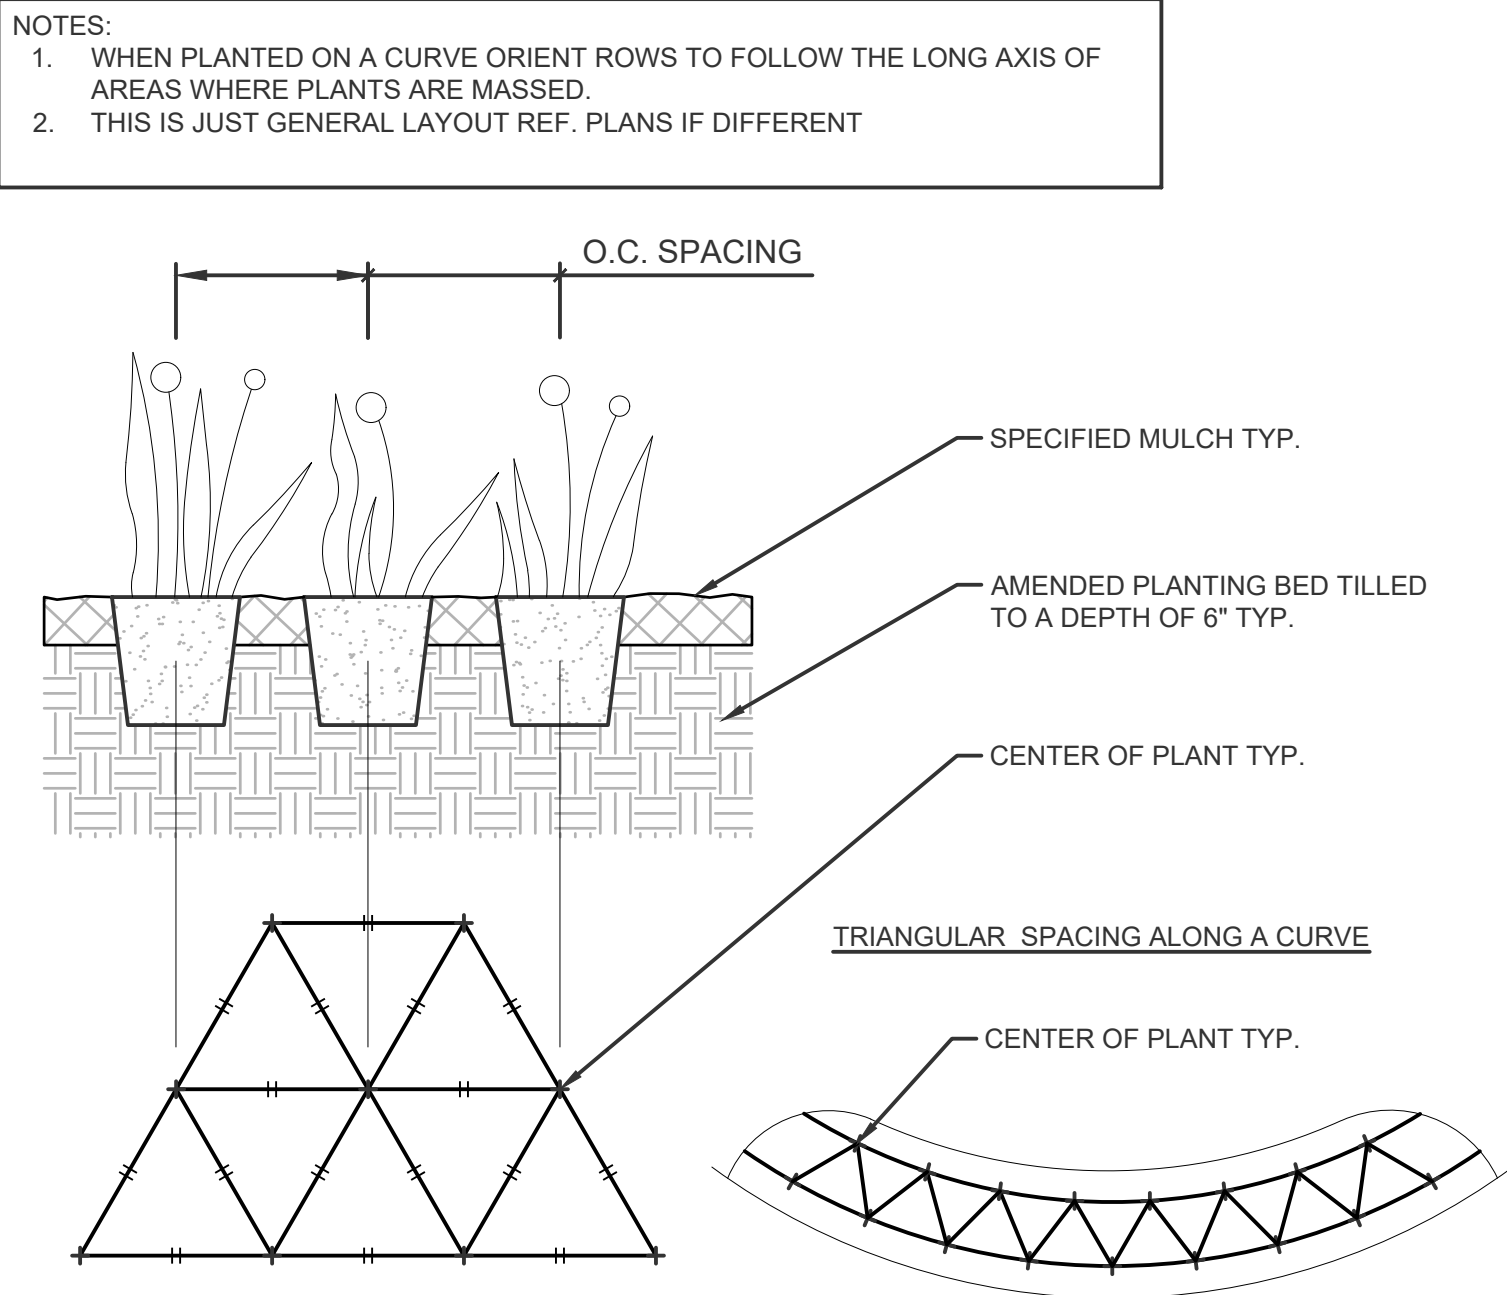

CONSTRUCTION DOCUMENTS

CHICK-FIL-A
POWERS & PALMER PARK
SEC OF POWERS BLVD AND PALMER
PARK BLVD COLORADO SPRINGS, CO 80915

FSR#05934

BUILDING TYPE / SIZE: P12 LS LRG
RELEASE: vX.YY.MM

REVISION SCHEDULE
NO. DATE DESCRIPTION

CONSULTANT PROJECT #

PRINTED FOR

DATE 01/31/2024


DRAWN BY CSS

SHEET

LANDSCAPE DETAILS

SHEET NUMBER

15

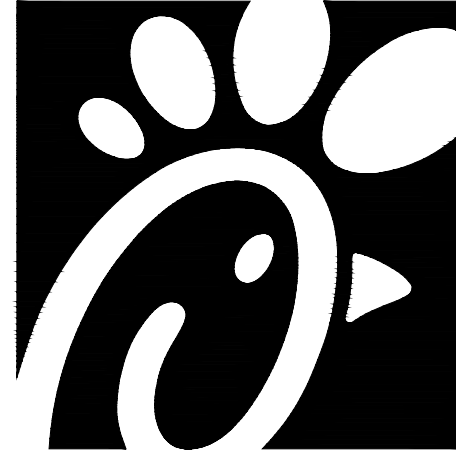

Chick-fil-A

Chick-fil-A
5200 Buffington Road
Atlanta, Georgia 30349-2998



FOR AND ON BEHALF OF
MERRICK AND COMPANY