


2022/01/14 2:06 PM By: Gwendolyn (Gwen) Bdl\Projects\326 COA\326.01 Trails At Aspen Ridge Water System Imp\Drawings\Working\3\_Civil\32601\_C Sheets.dwg

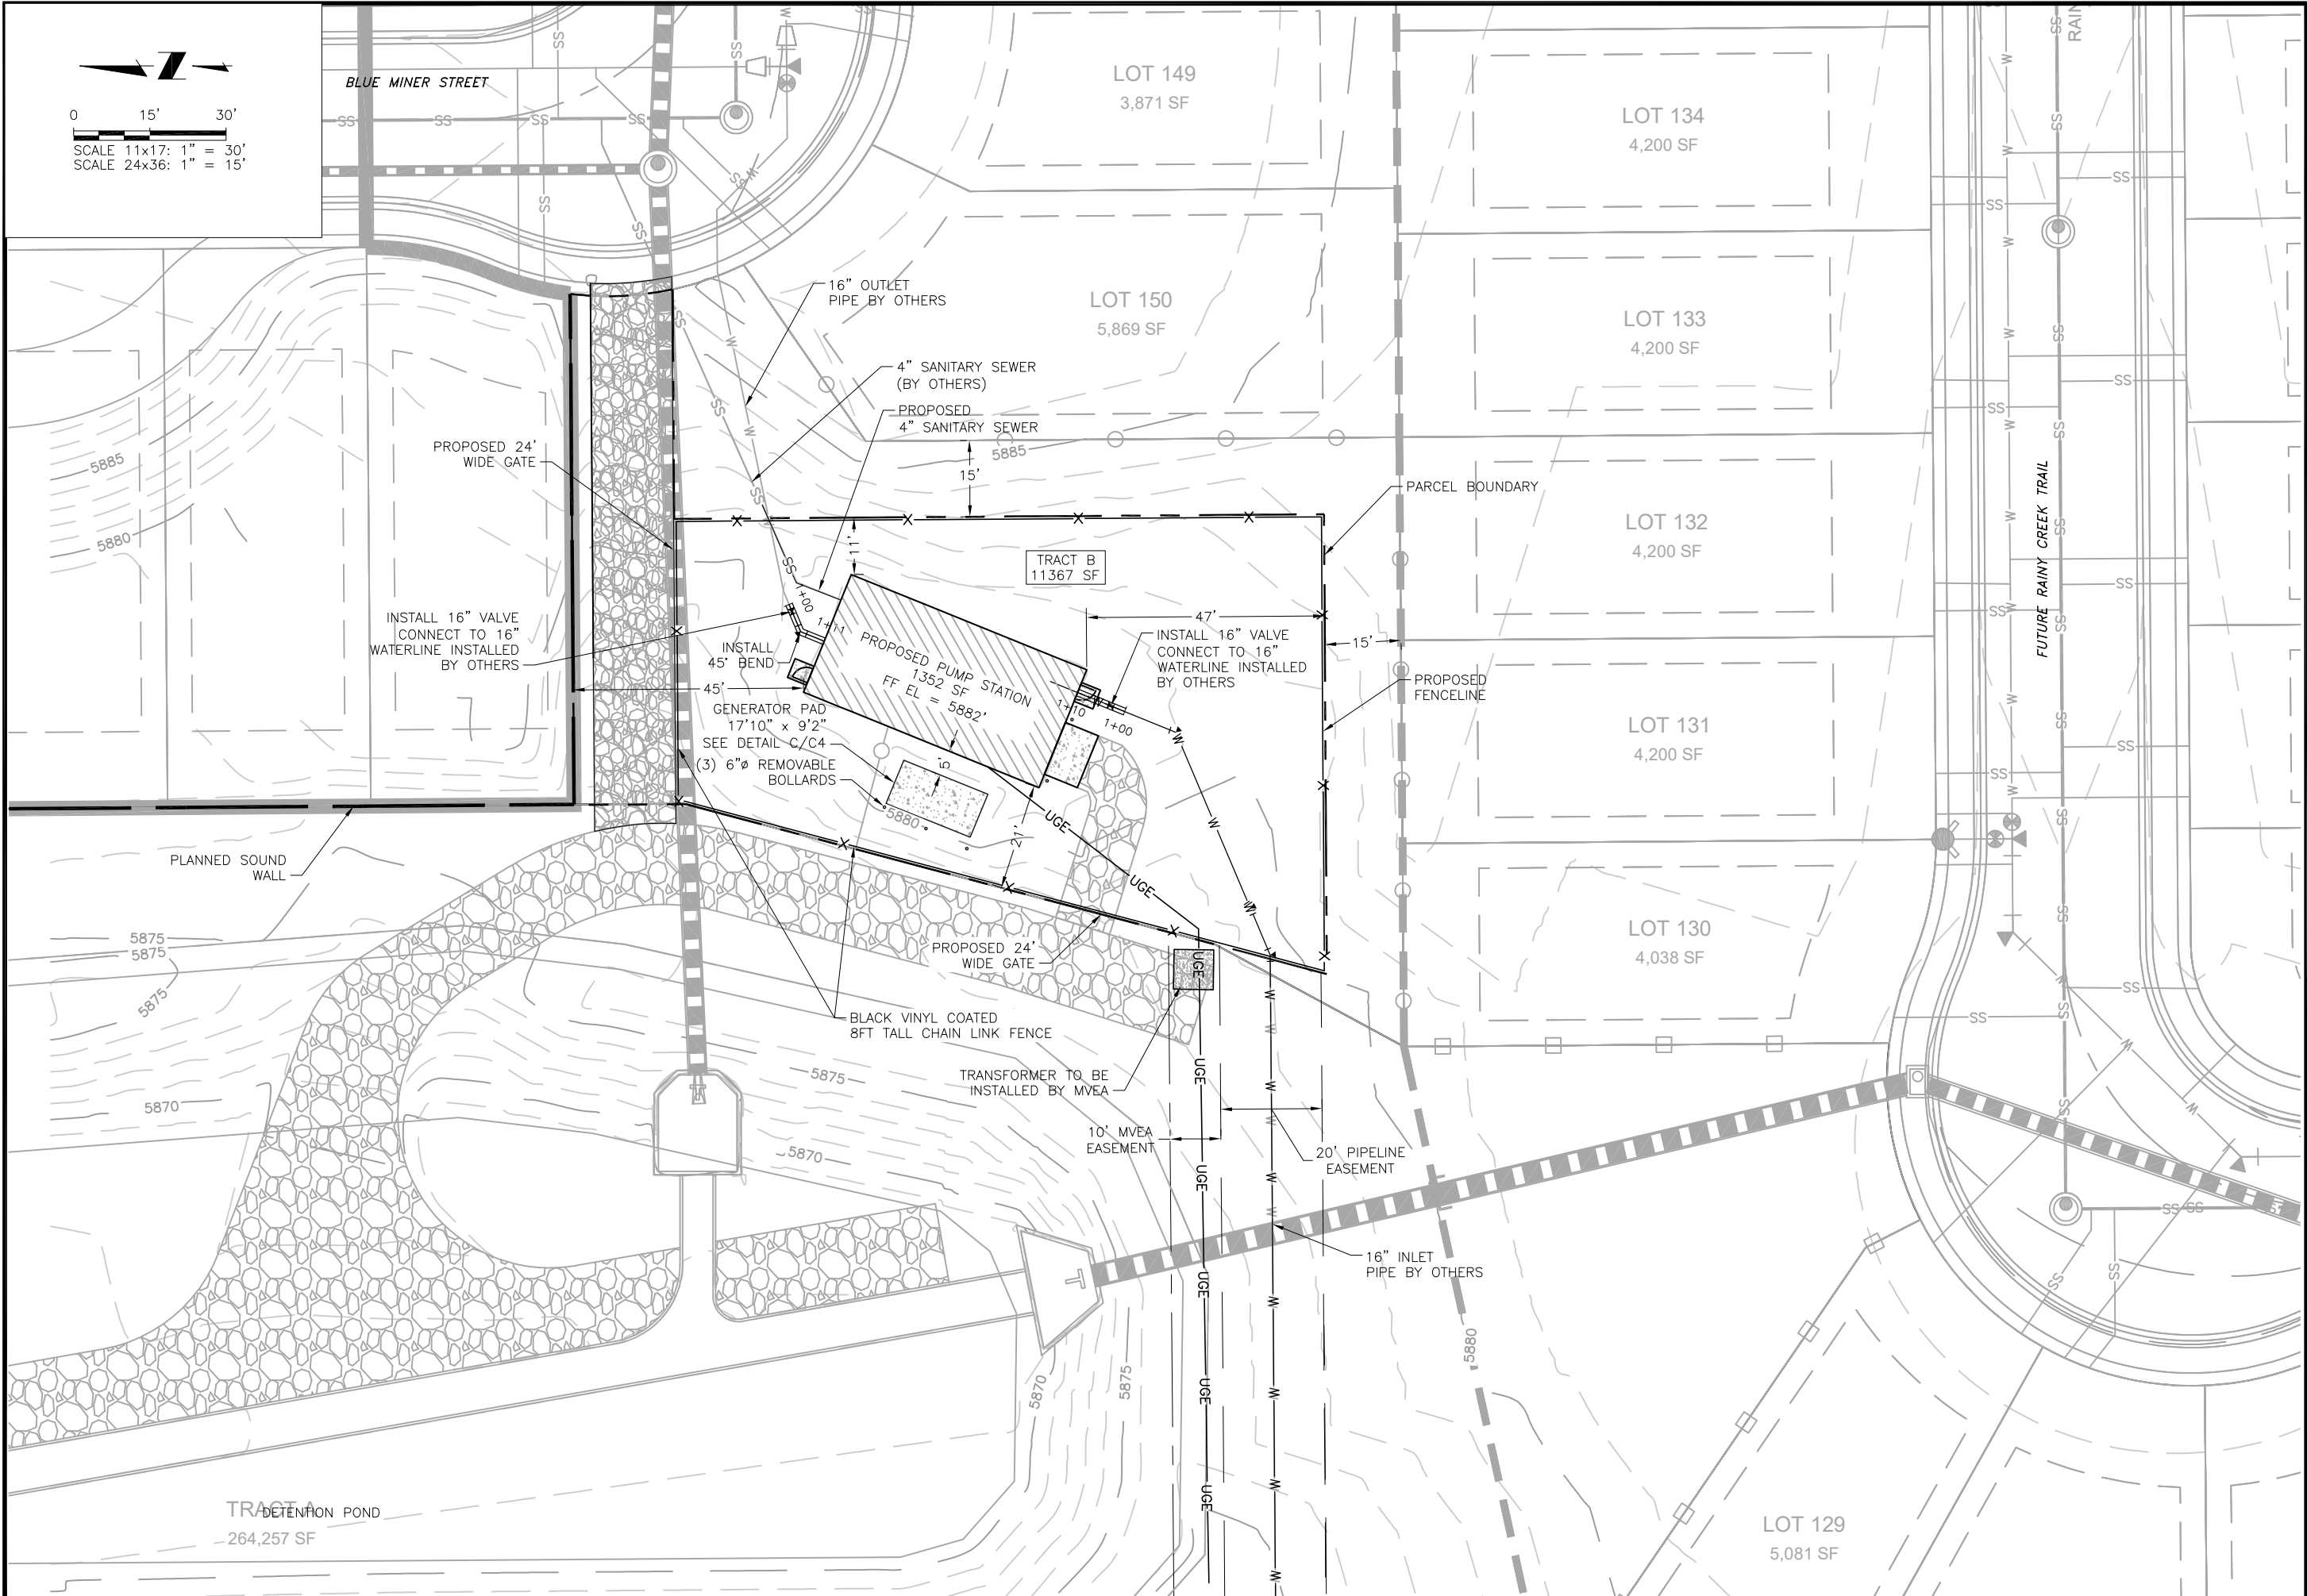

JD5-HYDRO

CONSULTANTS, INC.

5540 TECH CENTER DR., SUITE 100

COLORADO SPRINGS, COLORADO 80919

(719) 227-0072

DISCLAIMER: THE CONTRACTOR SHALL VERIFY ALL DIMENSIONS. ANY ERRORS OR OMISSIONS SHALL BE REPORTED TO JD5-HYDRO CONSULTANTS, INC. JD5-HYDRO ASSUMES NO LIABILITY FOR UNAUTHORIZED CHANGES AND/OR REVISIONS MADE TO PLANS.

WIDEFIELD WATER AND SANITATION

TRAILS AT ASPEN RIDGE WATER SYSTEM IMPROVEMENTS

SITE PLAN

NO.	DESCRIPTION	BY	APP.	DATE
1				
2				
3				
4				
5				
6				
7				

80% DESIGN DRAWINGS

Project No.: 102.130

Date: 11/19/21

Design: GJD

Drawn: SNW/ACH

Check: JPM

C2

SHEET 6 OF 38