

WSEO SUBMITTAL

PROPRIETARY AND CONFIDENTIAL
 TO BE REPRODUCED IN COLOR
 PRINT SIZE: ARCH D
 ISSUE BY: JSC
 DATE: 08/26/24
 SCALE: AS SHOWN
 DWG #

E103

DWG TITLE:
SITE LIGHTING PLAN - SECTIONS 1, 2

GENERAL NOTES



- 1 THE PROJECT DOES NOT INCLUDE ANY REGULARLY SCHEDULED DAYTIME LIGHTING.
- 2 TEMPORARY LIGHTING IS LIMITED TO LOCATIONS IDENTIFIED HERE WITHIN AND WILL ONLY BE ALLOWED FOR MAINTENANCE OF THE FACILITY.
- 3 DURING OPERATION, THE PROJECT WILL ABIDE BY EL PASO COUNTY LIGHTING ORDINANCE AT ALL TIMES INCLUDING LUMEN LIMITATIONS AT PROPERTY LINES.
- 4 NO LIGHTING IS PROPOSED FOR CONSTRUCTION.
- 5 LIGHTING SHALL NOT EXCEED 0.1 FOOT CANDLES AT PROPERTY BOUNDARY. AVERAGE LUMINESCENCE AT PROPERTY BOUNDARY = 0.00 FOOT CANDLES

LEGEND


- PROJECT FENCE
- PROPERTY BOUNDARY
- SITE ACCESS ROAD
- EXISTING CSU ROAD
- STAGING/PARKING AREA
- TRACKER ARRAY OUTLINE
- POWER STATION
- O&M SHED

KEYNOTES


- 1 SUBSTATION CONTROL BUILDING
- 2 POWER STATION (TYPICAL)
- 3 TRACKER BLOCK (TYPICAL)
- 4 O&M SHED
- 5 40'x8' BATTERY ENERGY STORAGE CONTAINER (TYPICAL)

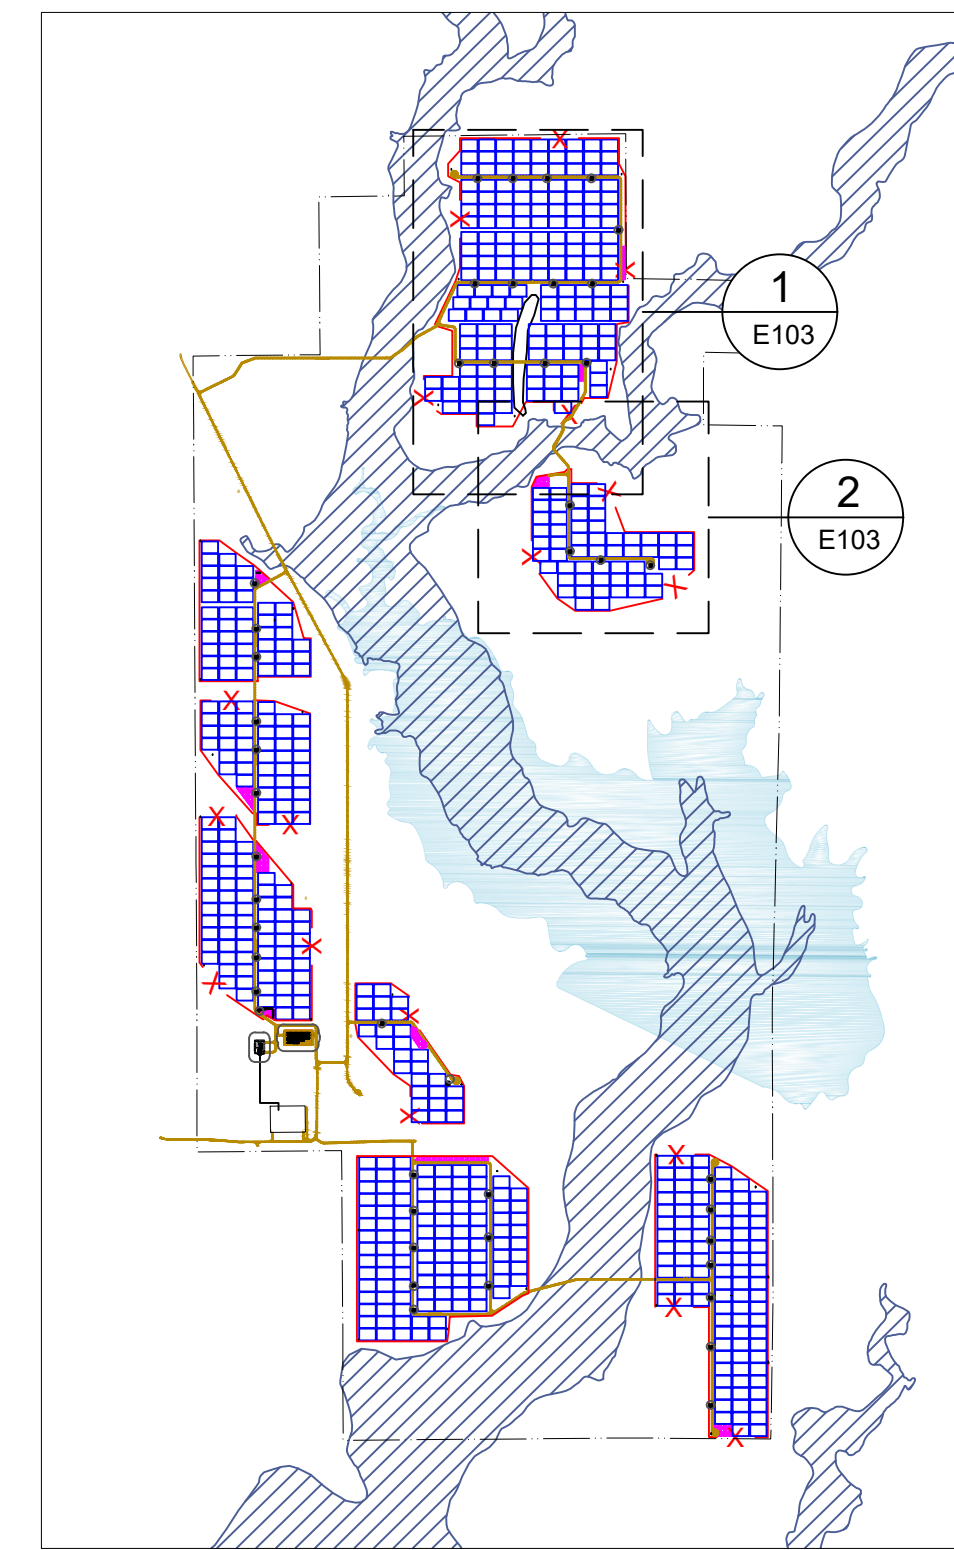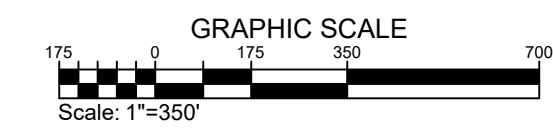


3 REFERENCE MAP
 E103 SCALE: NTS

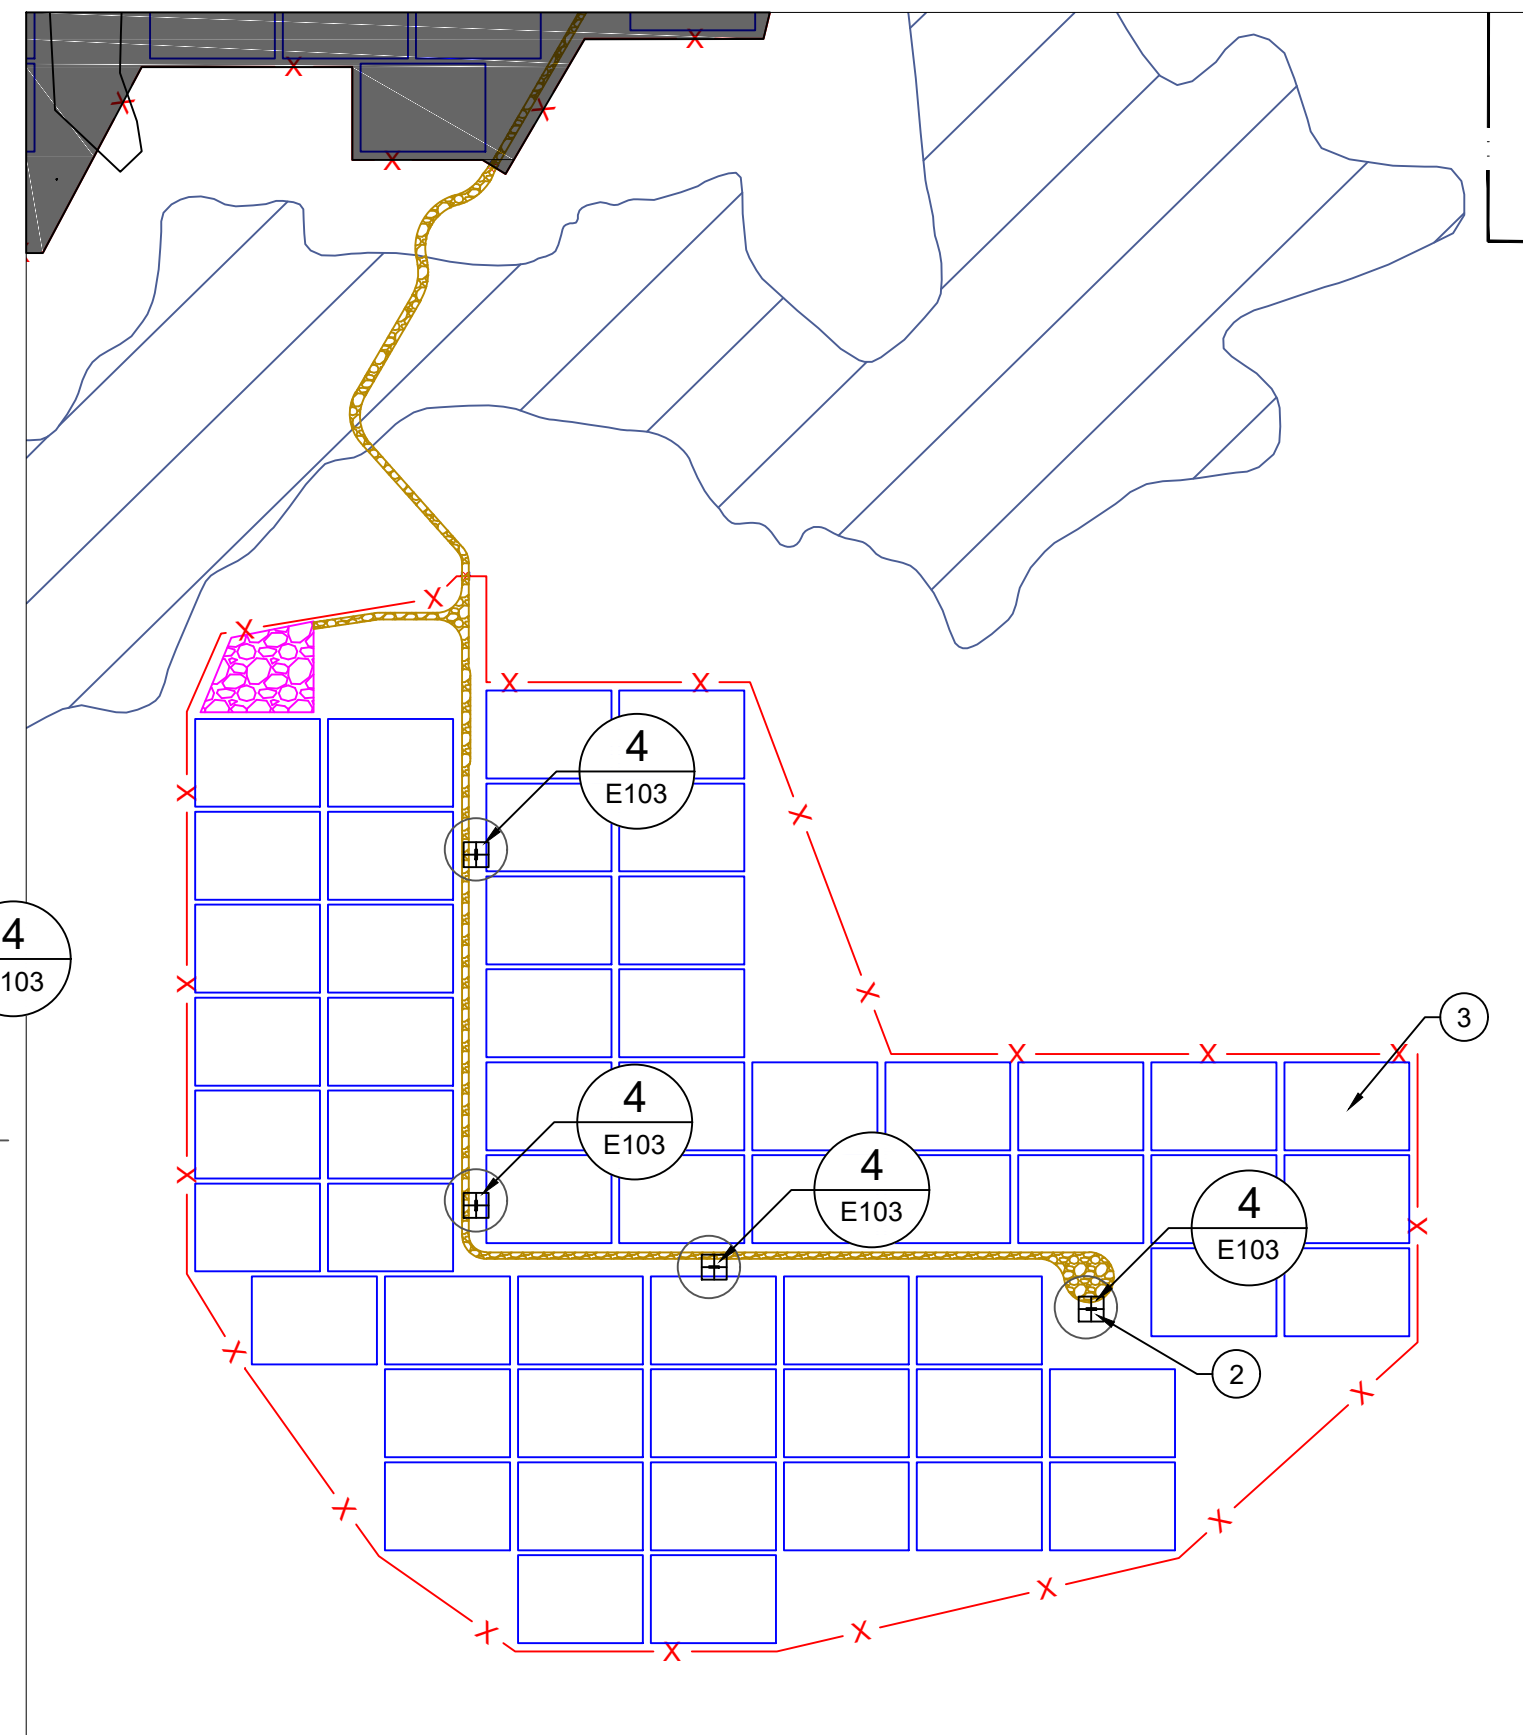


2 SECTION 1 - PLAN VIEW
 E103 SCALE: 1"=350'

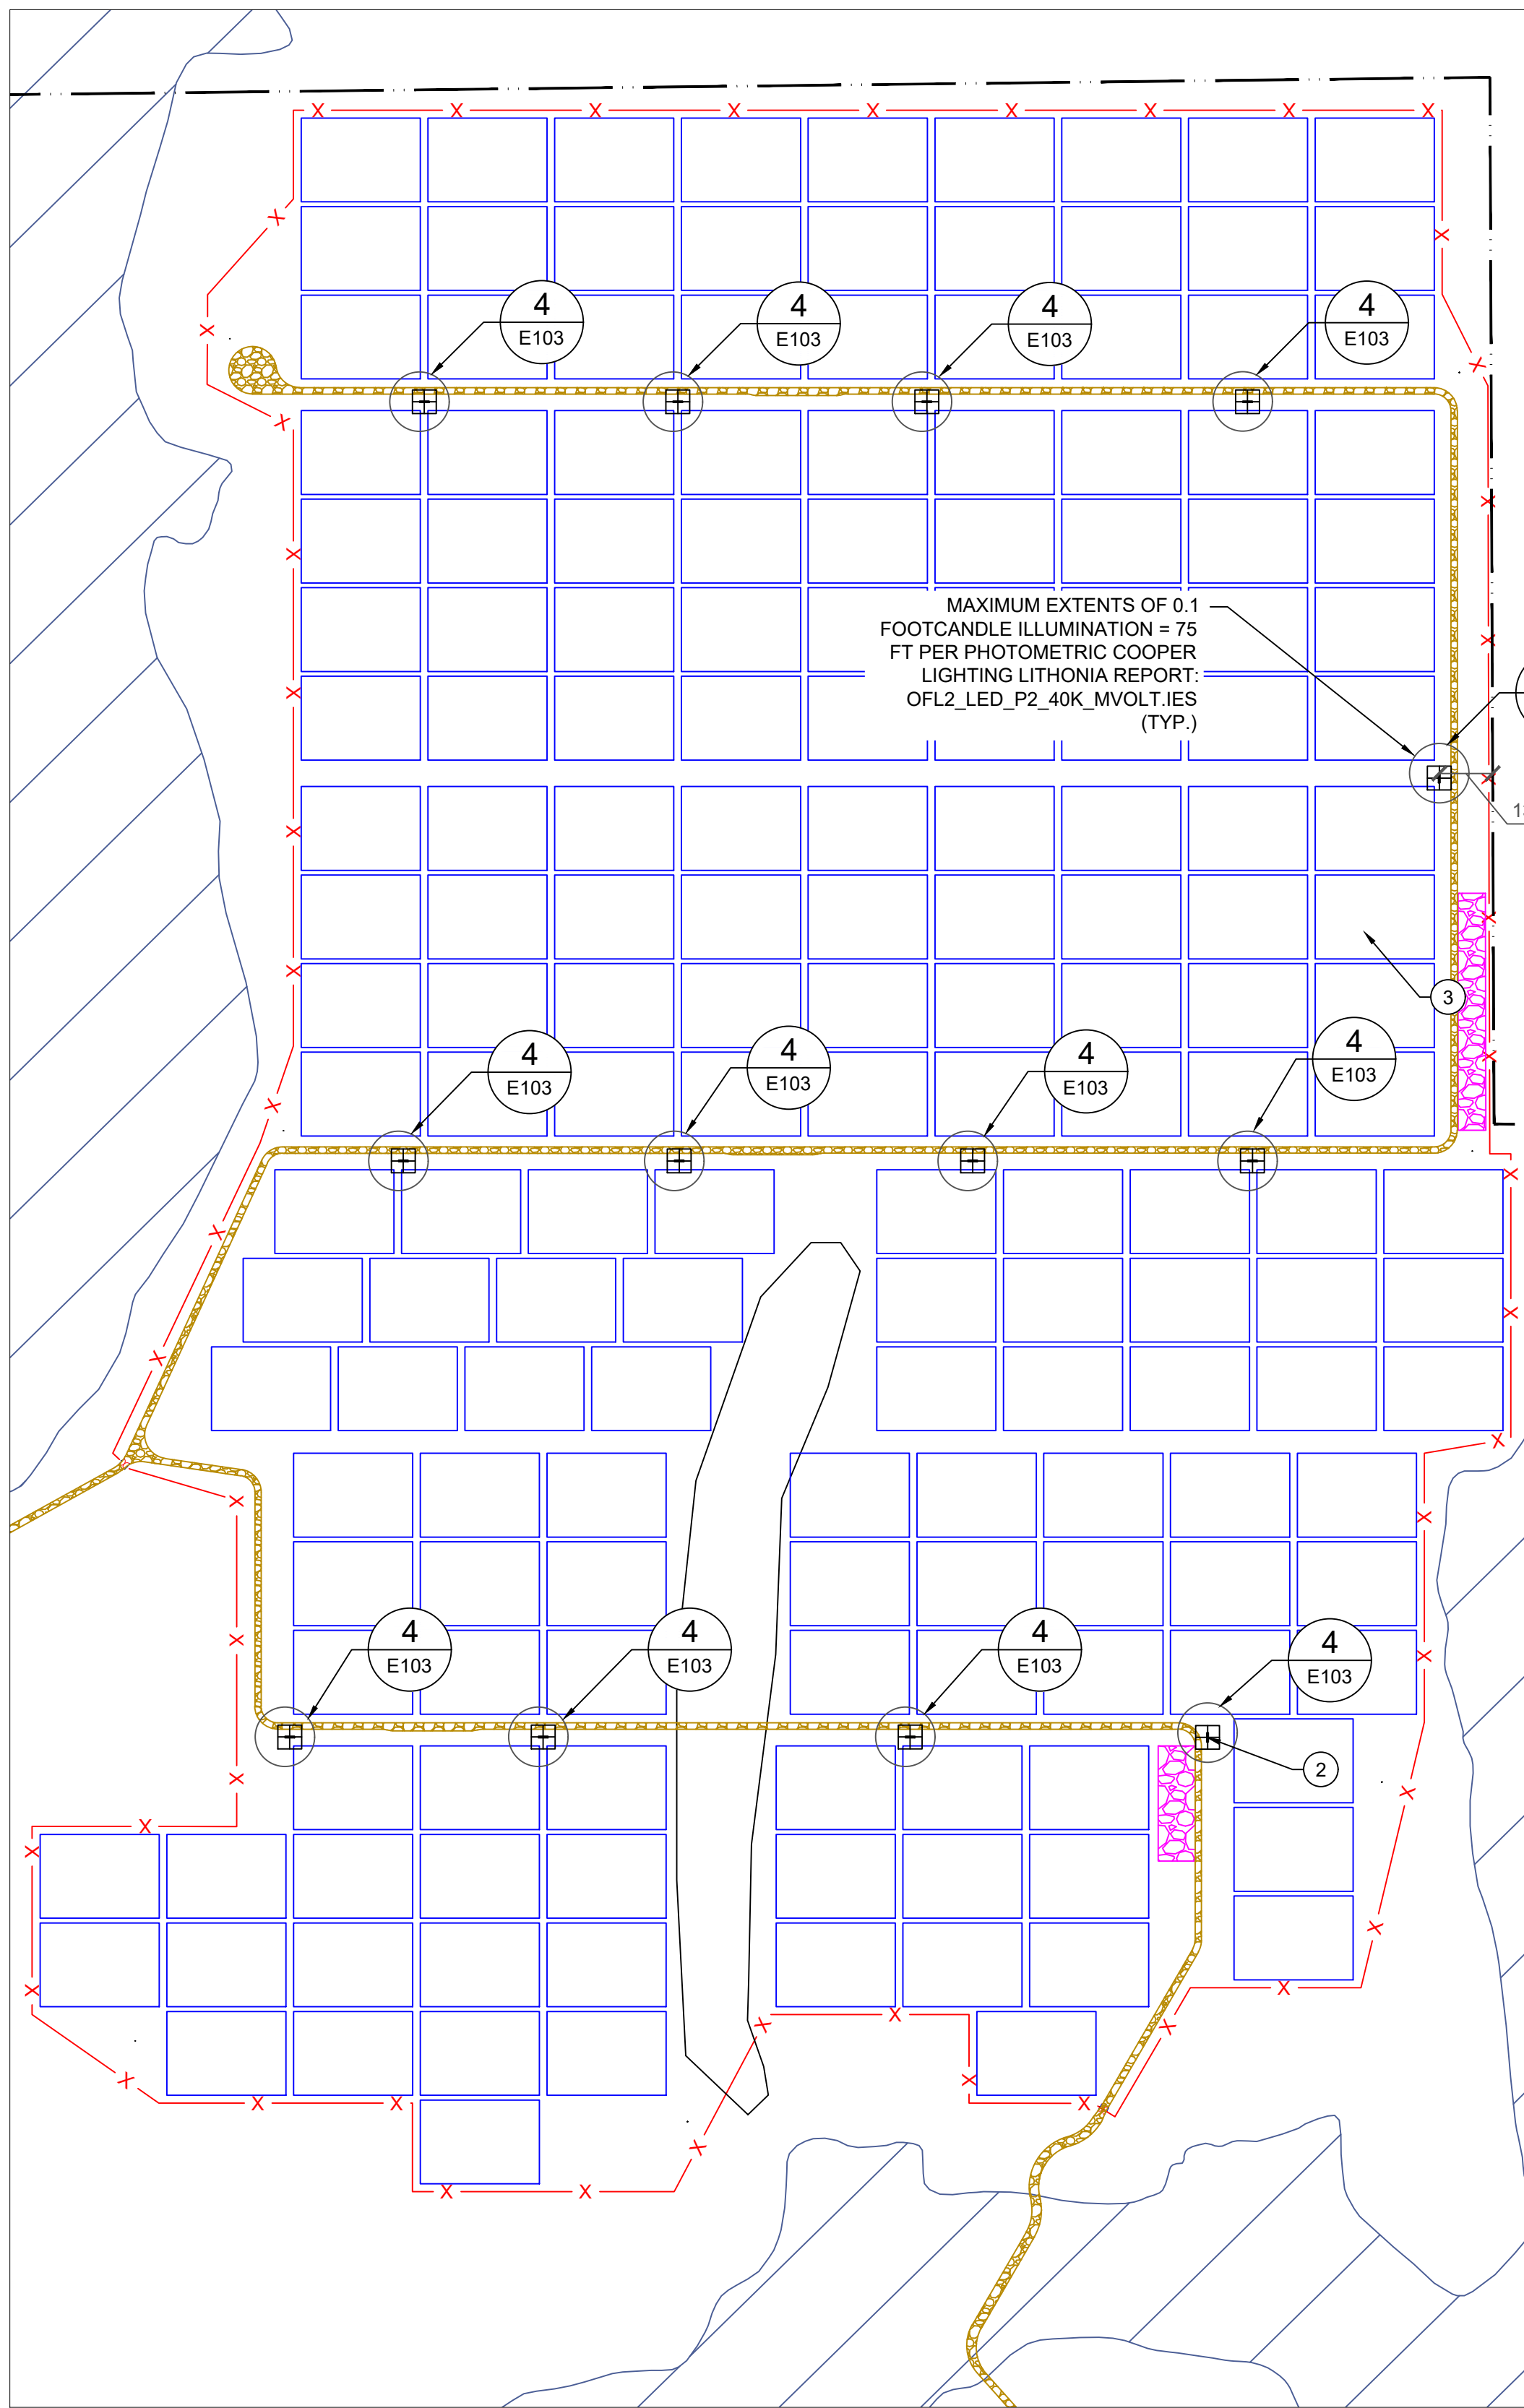

1 SECTION 2 - PLAN VIEW
 E103 SCALE: 1"=350'

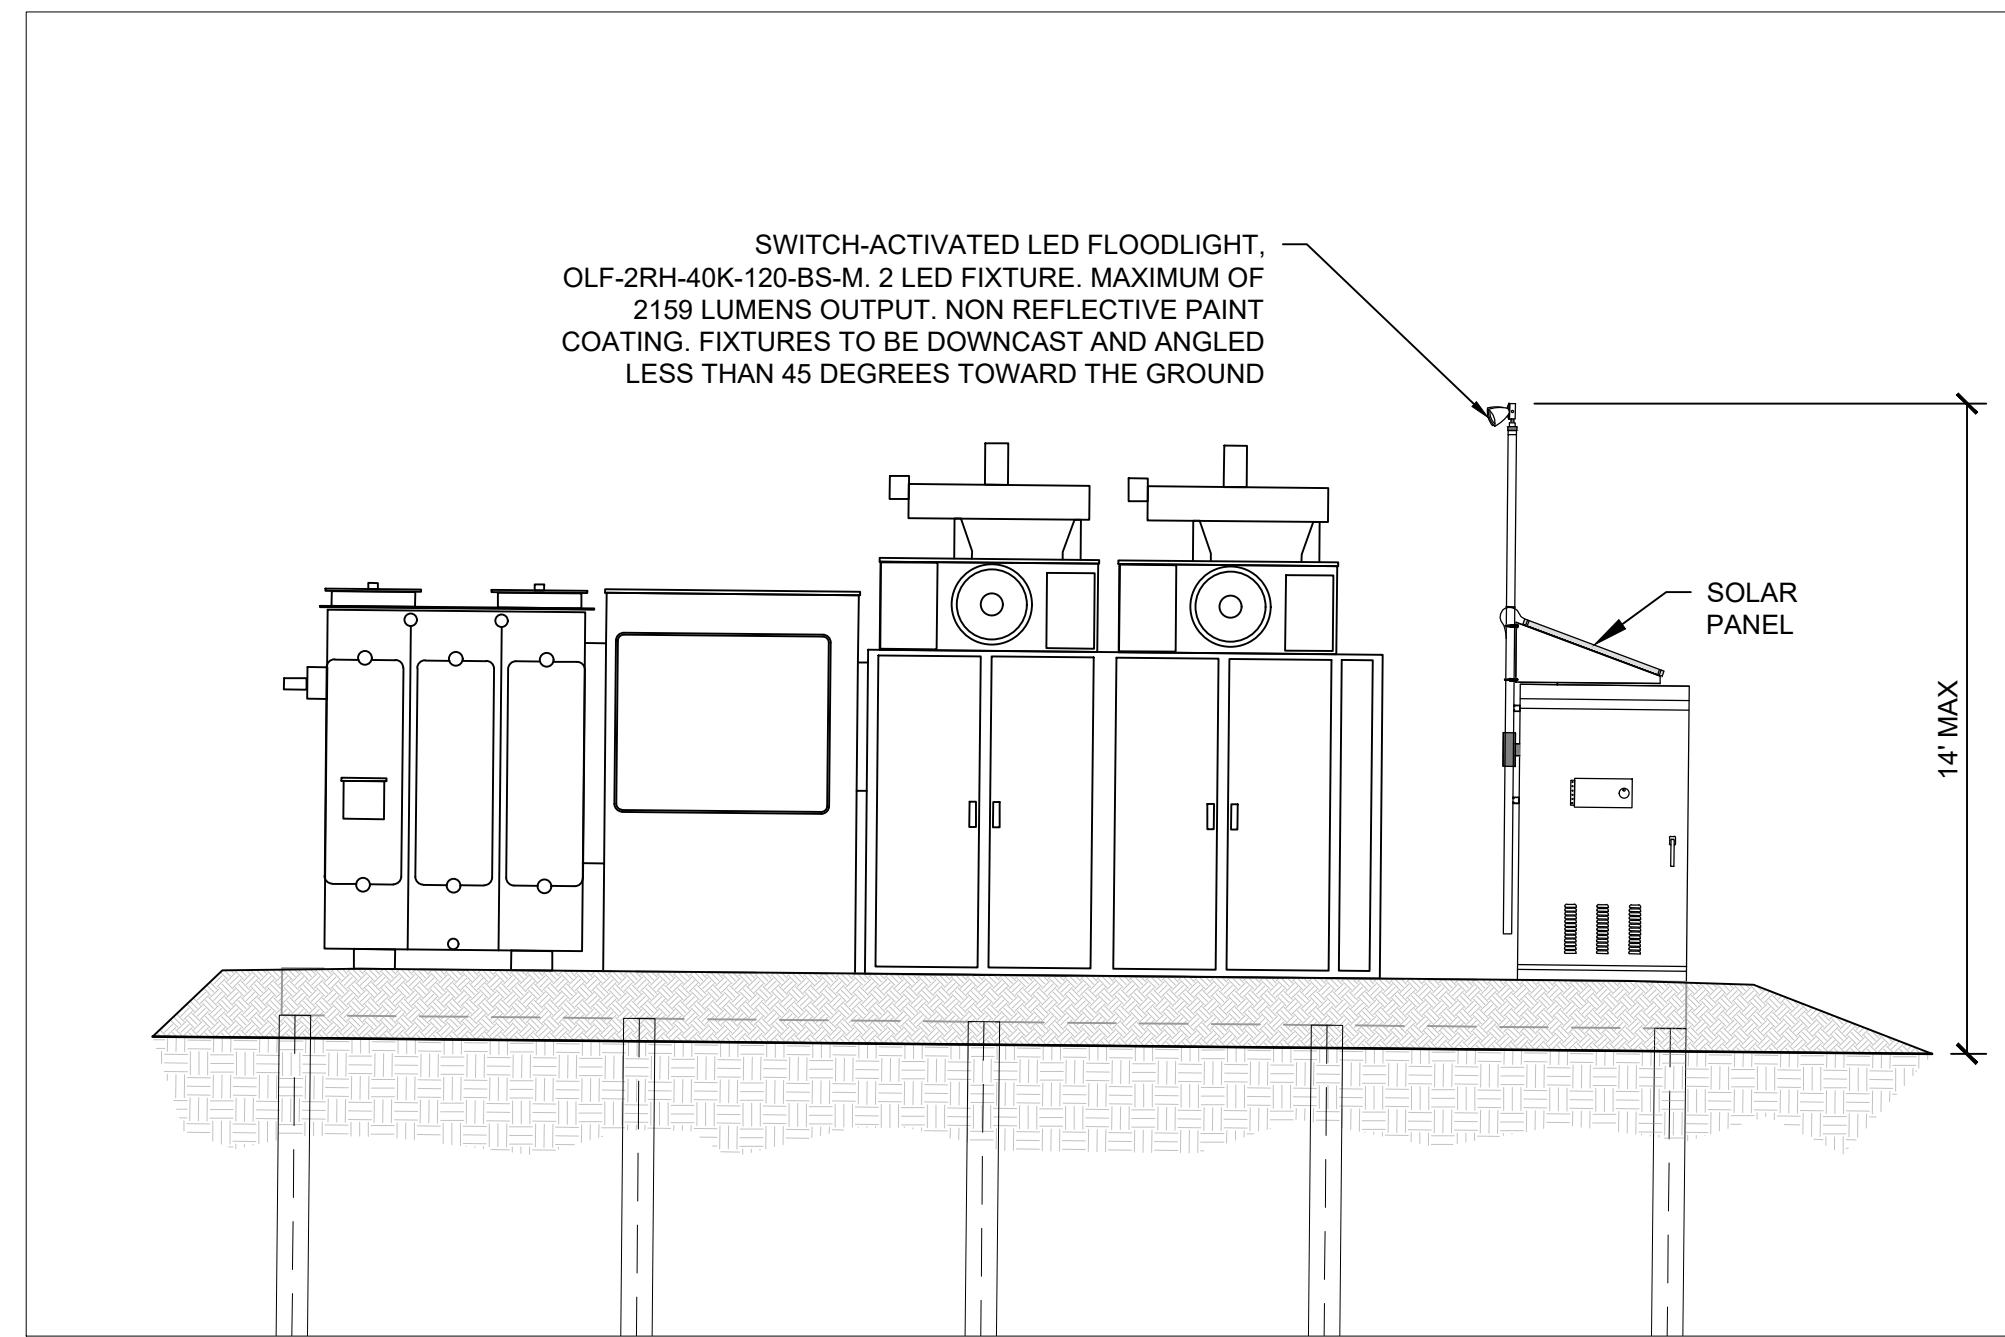

4 POWER STATION FLOODLIGHT
 E103 SCALE: NTS

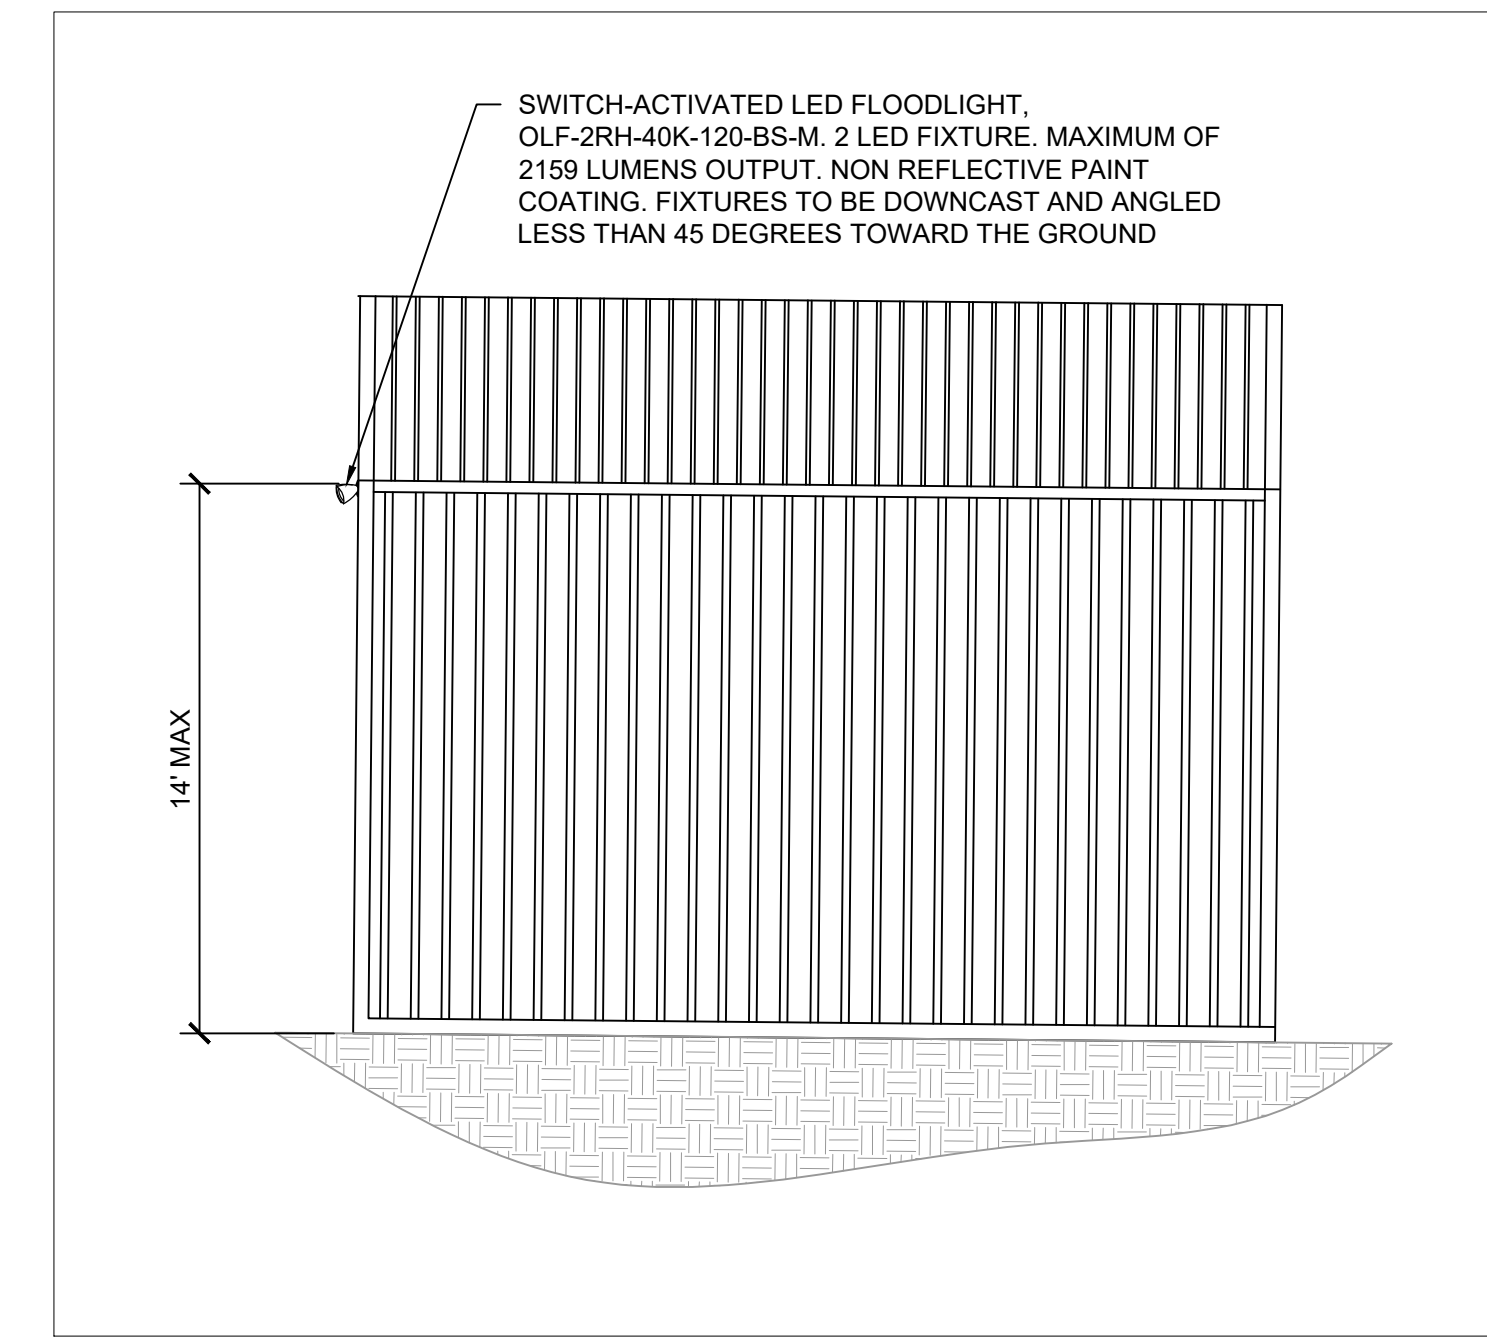

5 O&M SHED FLOODLIGHT
 E103 SCALE: NTS

REV.	DATE	DESCRIPTION	BY	CHKD.
1	08/12/2021	XXX	XXX	XXX
2	08/12/2021	XXX	XXX	XXX
3	08/12/2021	XXX	XXX	XXX
4	08/12/2021	XXX	XXX	XXX
5	08/12/2021	XXX	XXX	XXX

DRAWN BY: DGD LATEST REV: A

WSEO SUBMITTAL


PROPRIETARY AND CONFIDENTIAL
 TO BE REPRODUCED IN COLOR
 PRINT SIZE: ARCH D
 SUBMITTAL: 2021
 SCALE: 1/8"=1'-0"
 SCALE: NTS
 DWG.#

E104
 DWG TITLE:
 SITE LIGHTING PLAN -
 SECTIONS 3, 4, 5


- GENERAL NOTES**
- 1 THE PROJECT DOES NOT INCLUDE ANY REGULARLY SCHEDULED DAYTIME LIGHTING.
 - 2 TEMPORARY LIGHTING IS LIMITED TO LOCATIONS IDENTIFIED HERE WITHIN AND WILL ONLY BE ALLOWED FOR MAINTENANCE OF THE FACILITY.
 - 3 DURING OPERATION, THE PROJECT WILL ABIDE BY EL PASO COUNTY LIGHTING ORDINANCE AT ALL TIMES INCLUDING LUMEN LIMITATIONS AT PROPERTY LINES.
 - 4 NO LIGHTING IS PROPOSED FOR CONSTRUCTION.
 - 5 LIGHTING SHALL NOT EXCEED 0.1 FOOT CANDLES AT PROPERTY BOUNDARY. AVERAGE LUMINESCENCE AT PROPERTY BOUNDARY = 0.00 FOOT CANDLES

- LEGEND**
- PROJECT FENCE
 - PROPERTY BOUNDARY
 - SITE ACCESS ROAD
 - EXISTING CSU ROAD
 - STAGING/PARKING AREA
 - TRACKER ARRAY OUTLINE
 - POWER STATION
 - O&M SHED


- KEYNOTES**
- 1 SUBSTATION CONTROL BUILDING
 - 2 POWER STATION (TYPICAL)
 - 3 TRACKER BLOCK (TYPICAL)
 - 4 O&M SHED
 - 5 40'x8' BATTERY ENERGY STORAGE CONTAINER (TYPICAL)

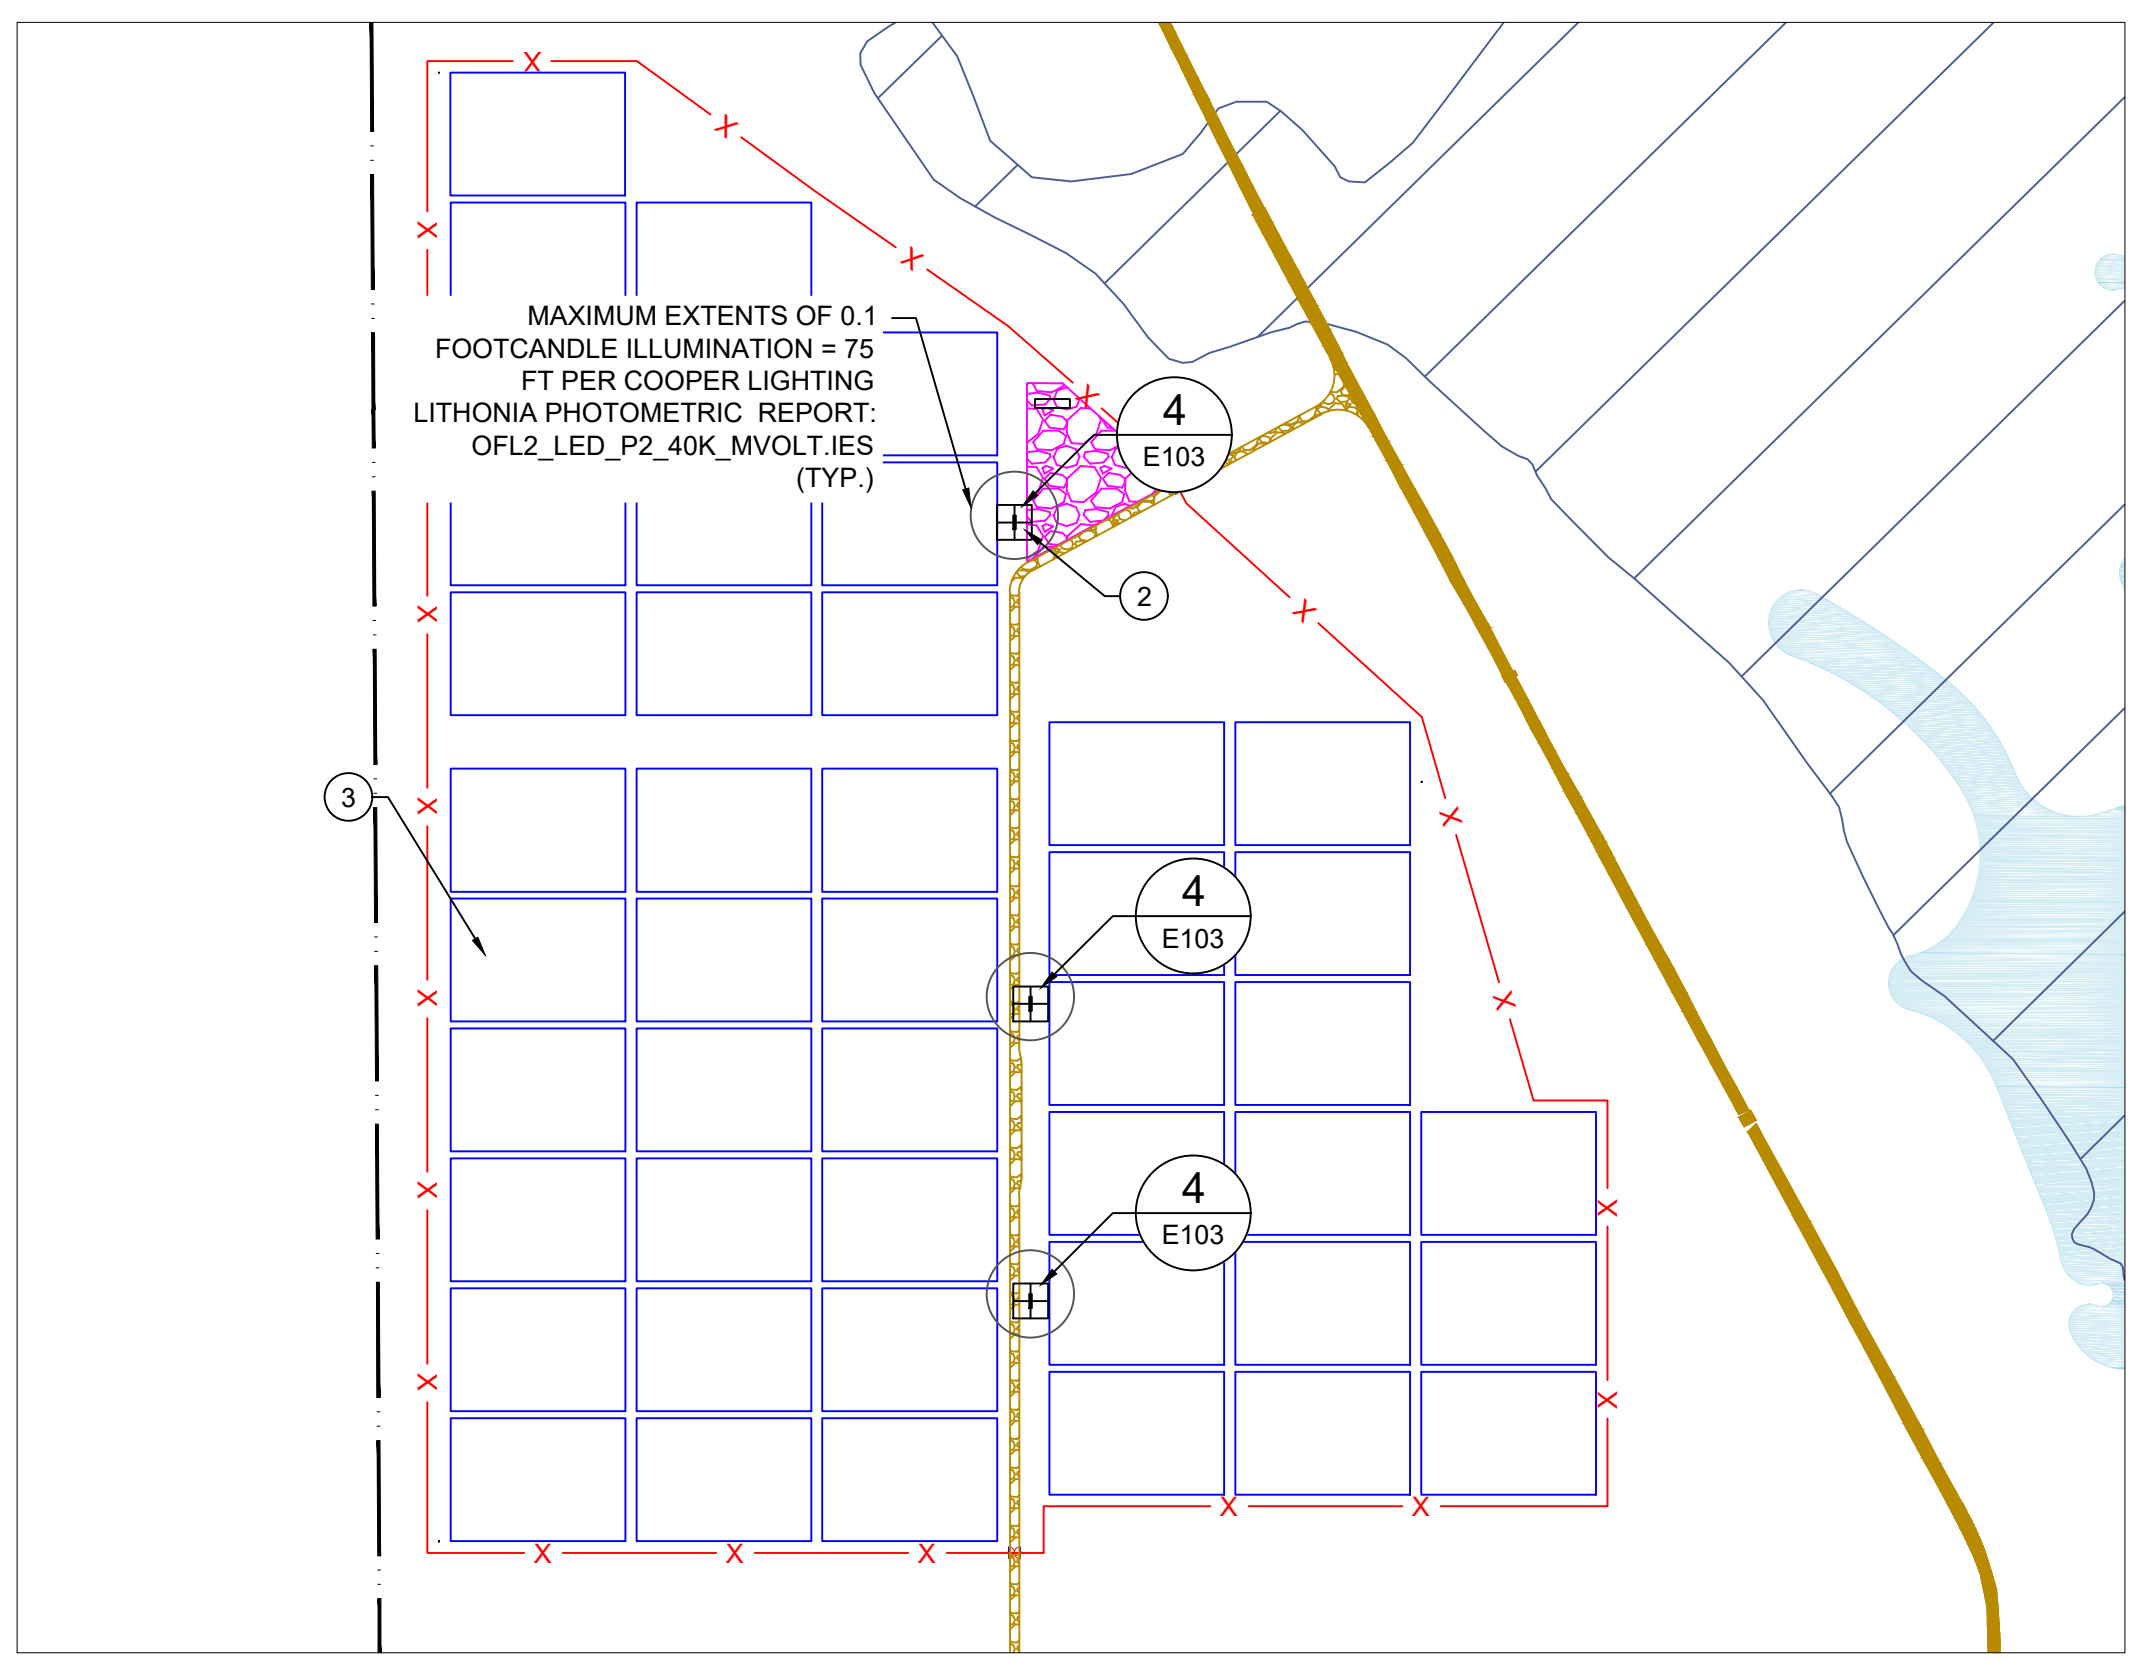


1 SECTION 3 - PLAN VIEW
 E104 SCALE: 1"=325'

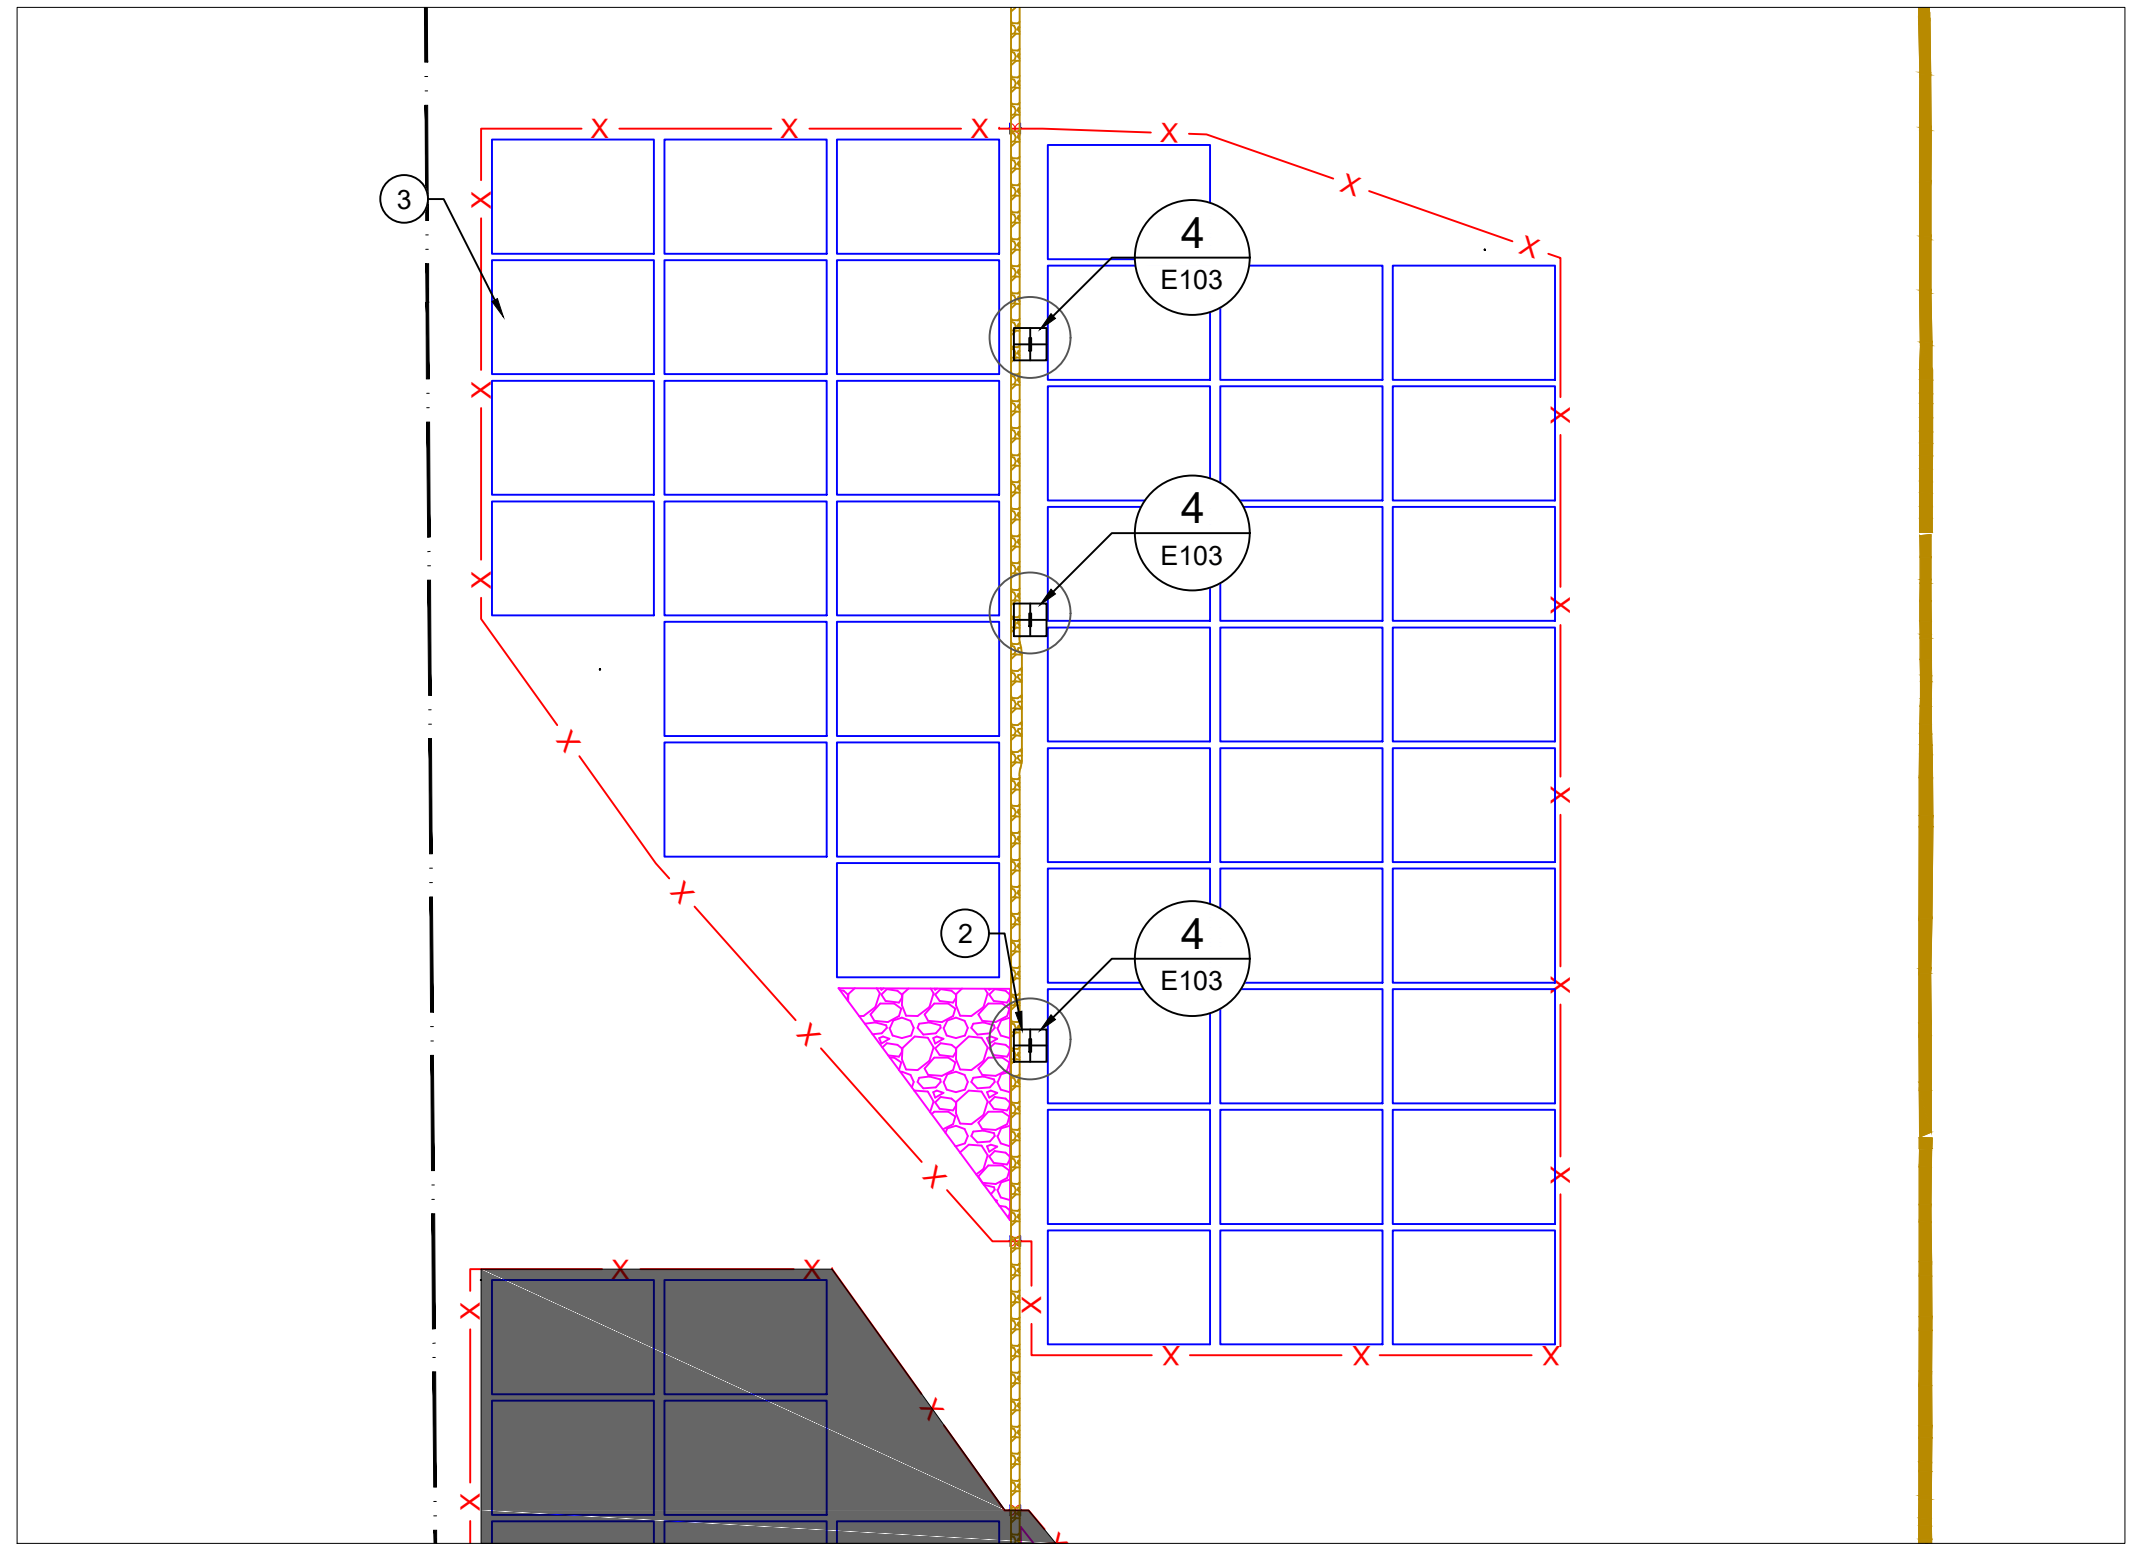

2 SECTION 4 - PLAN VIEW
 E104 SCALE: 1"=325'

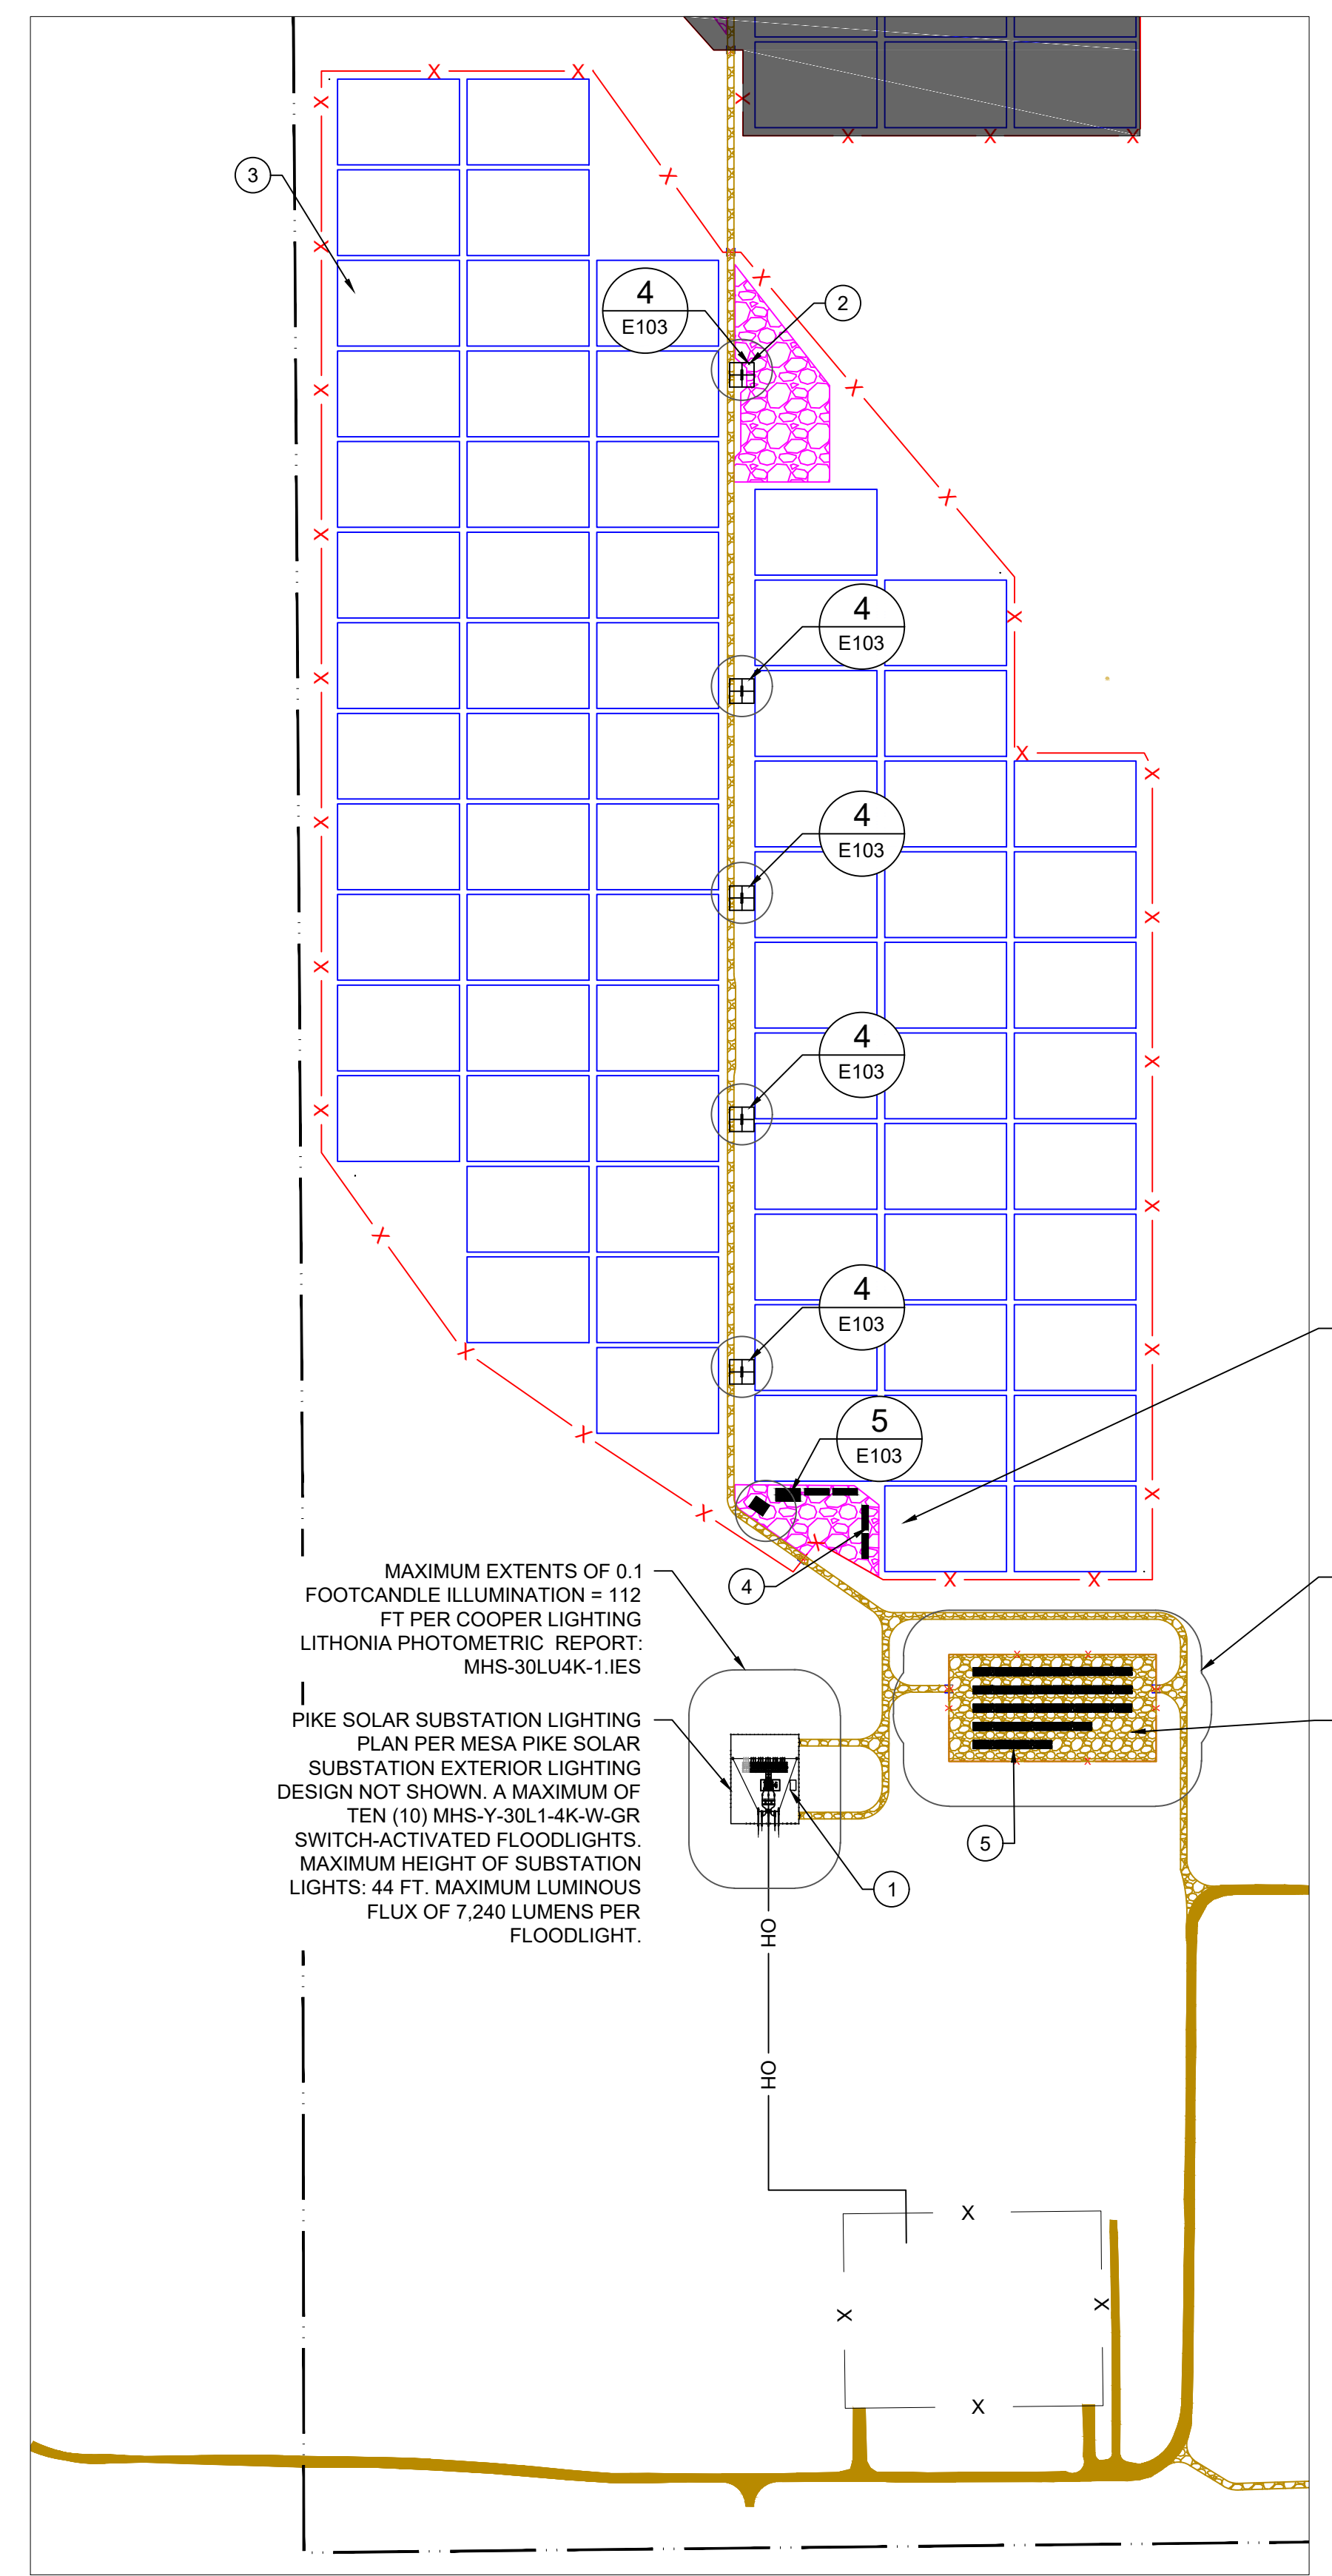

3 SECTION 5 - PLAN VIEW
 E104 SCALE: 1"=325'

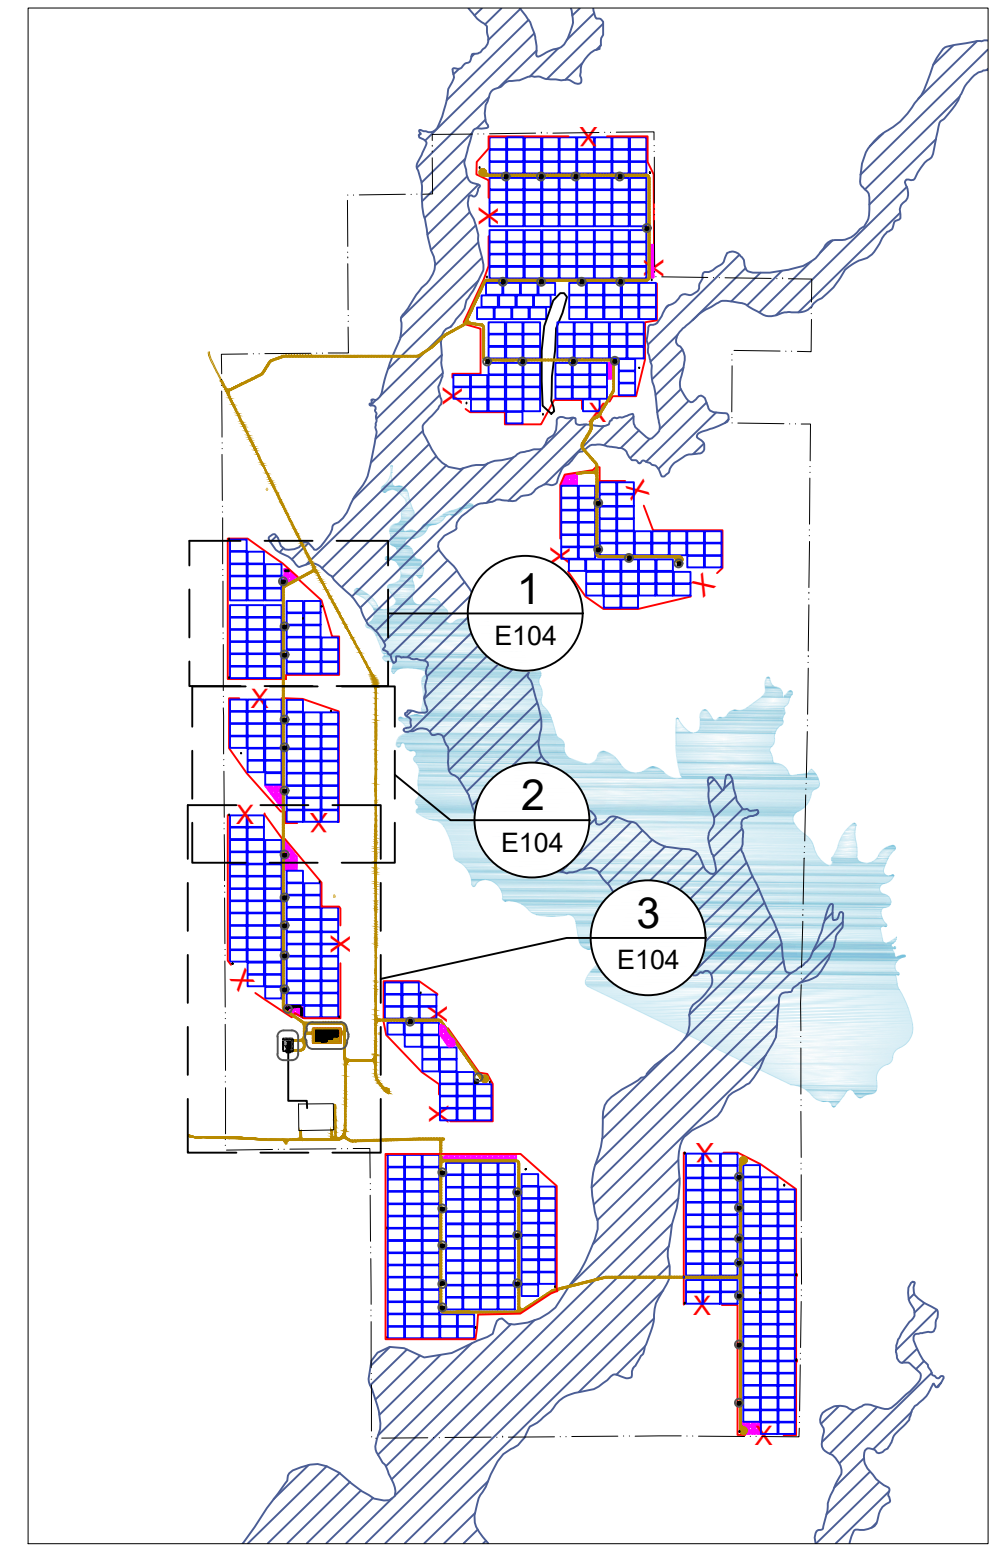

4 REFERENCE MAP
 E104 SCALE: NTS

6. Site lighting, where is the service for the site lighting coming from? Are there to be new meters? Please clarify. If new meters show the locations so that a new address can be assigned..

PPRBD comment

REV.	DATE	DESCRIPTION
1	08/12/2021	ISSUE FOR PERMIT
2	08/12/2021	ISSUE FOR PERMIT
3	08/12/2021	ISSUE FOR PERMIT
4	08/12/2021	ISSUE FOR PERMIT
5	08/12/2021	ISSUE FOR PERMIT
6	08/12/2021	ISSUE FOR PERMIT
7	08/12/2021	ISSUE FOR PERMIT
8	08/12/2021	ISSUE FOR PERMIT
9	08/12/2021	ISSUE FOR PERMIT
10	08/12/2021	ISSUE FOR PERMIT
11	08/12/2021	ISSUE FOR PERMIT
12	08/12/2021	ISSUE FOR PERMIT
13	08/12/2021	ISSUE FOR PERMIT
14	08/12/2021	ISSUE FOR PERMIT
15	08/12/2021	ISSUE FOR PERMIT
16	08/12/2021	ISSUE FOR PERMIT
17	08/12/2021	ISSUE FOR PERMIT
18	08/12/2021	ISSUE FOR PERMIT
19	08/12/2021	ISSUE FOR PERMIT
20	08/12/2021	ISSUE FOR PERMIT
21	08/12/2021	ISSUE FOR PERMIT

DRAWN BY: DGD LATEST REV: A

GENERAL NOTES



- 1 THE PROJECT DOES NOT INCLUDE ANY REGULARLY SCHEDULED DAYTIME LIGHTING.
- 2 TEMPORARY LIGHTING IS LIMITED TO LOCATIONS IDENTIFIED HERE WITHIN AND WILL ONLY BE ALLOWED FOR MAINTENANCE OF THE FACILITY.
- 3 DURING OPERATION, THE PROJECT WILL ABIDE BY EL PASO COUNTY LIGHTING ORDINANCE AT ALL TIMES INCLUDING LUMEN LIMITATIONS AT PROPERTY LINES.
- 4 NO LIGHTING IS PROPOSED FOR CONSTRUCTION.
- 5 LIGHTING SHALL NOT EXCEED 0.1 FOOT CANDLES AT PROPERTY BOUNDARY. AVERAGE LUMINESCENCE AT PROPERTY BOUNDARY = 0.00 FOOT CANDLES

LEGEND


- PROJECT FENCE
- PROPERTY BOUNDARY
- SITE ACCESS ROAD
- EXISTING CSU ROAD
- STAGING/PARKING AREA
- TRACKER ARRAY OUTLINE
- POWER STATION
- O&M SHED

KEYNOTES


- ##
- 1 SUBSTATION CONTROL BUILDING
- 2 POWER STATION (TYPICAL)
- 3 TRACKER BLOCK (TYPICAL)
- 4 O&M SHED
- 5 40'x8' BATTERY ENERGY STORAGE CONTAINER (TYPICAL)

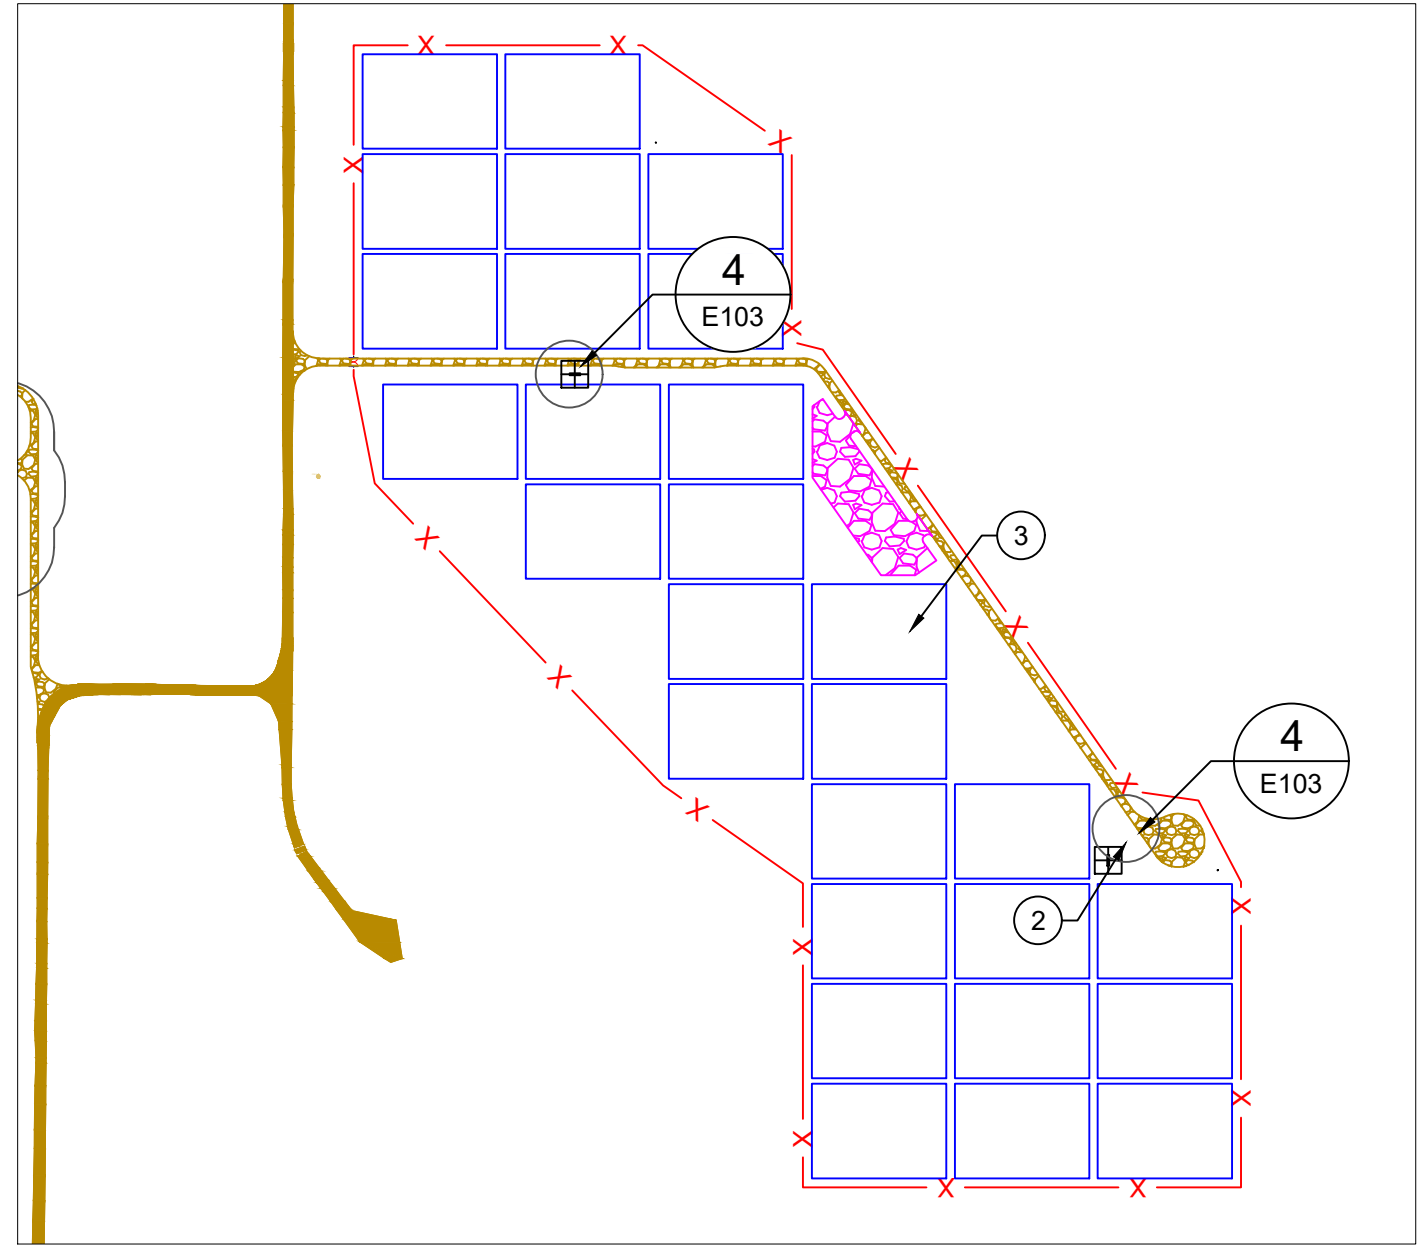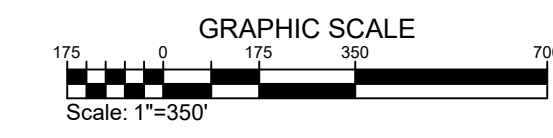


1 SECTION 6 - PLAN VIEW
 E105 SCALE: 1"=400'

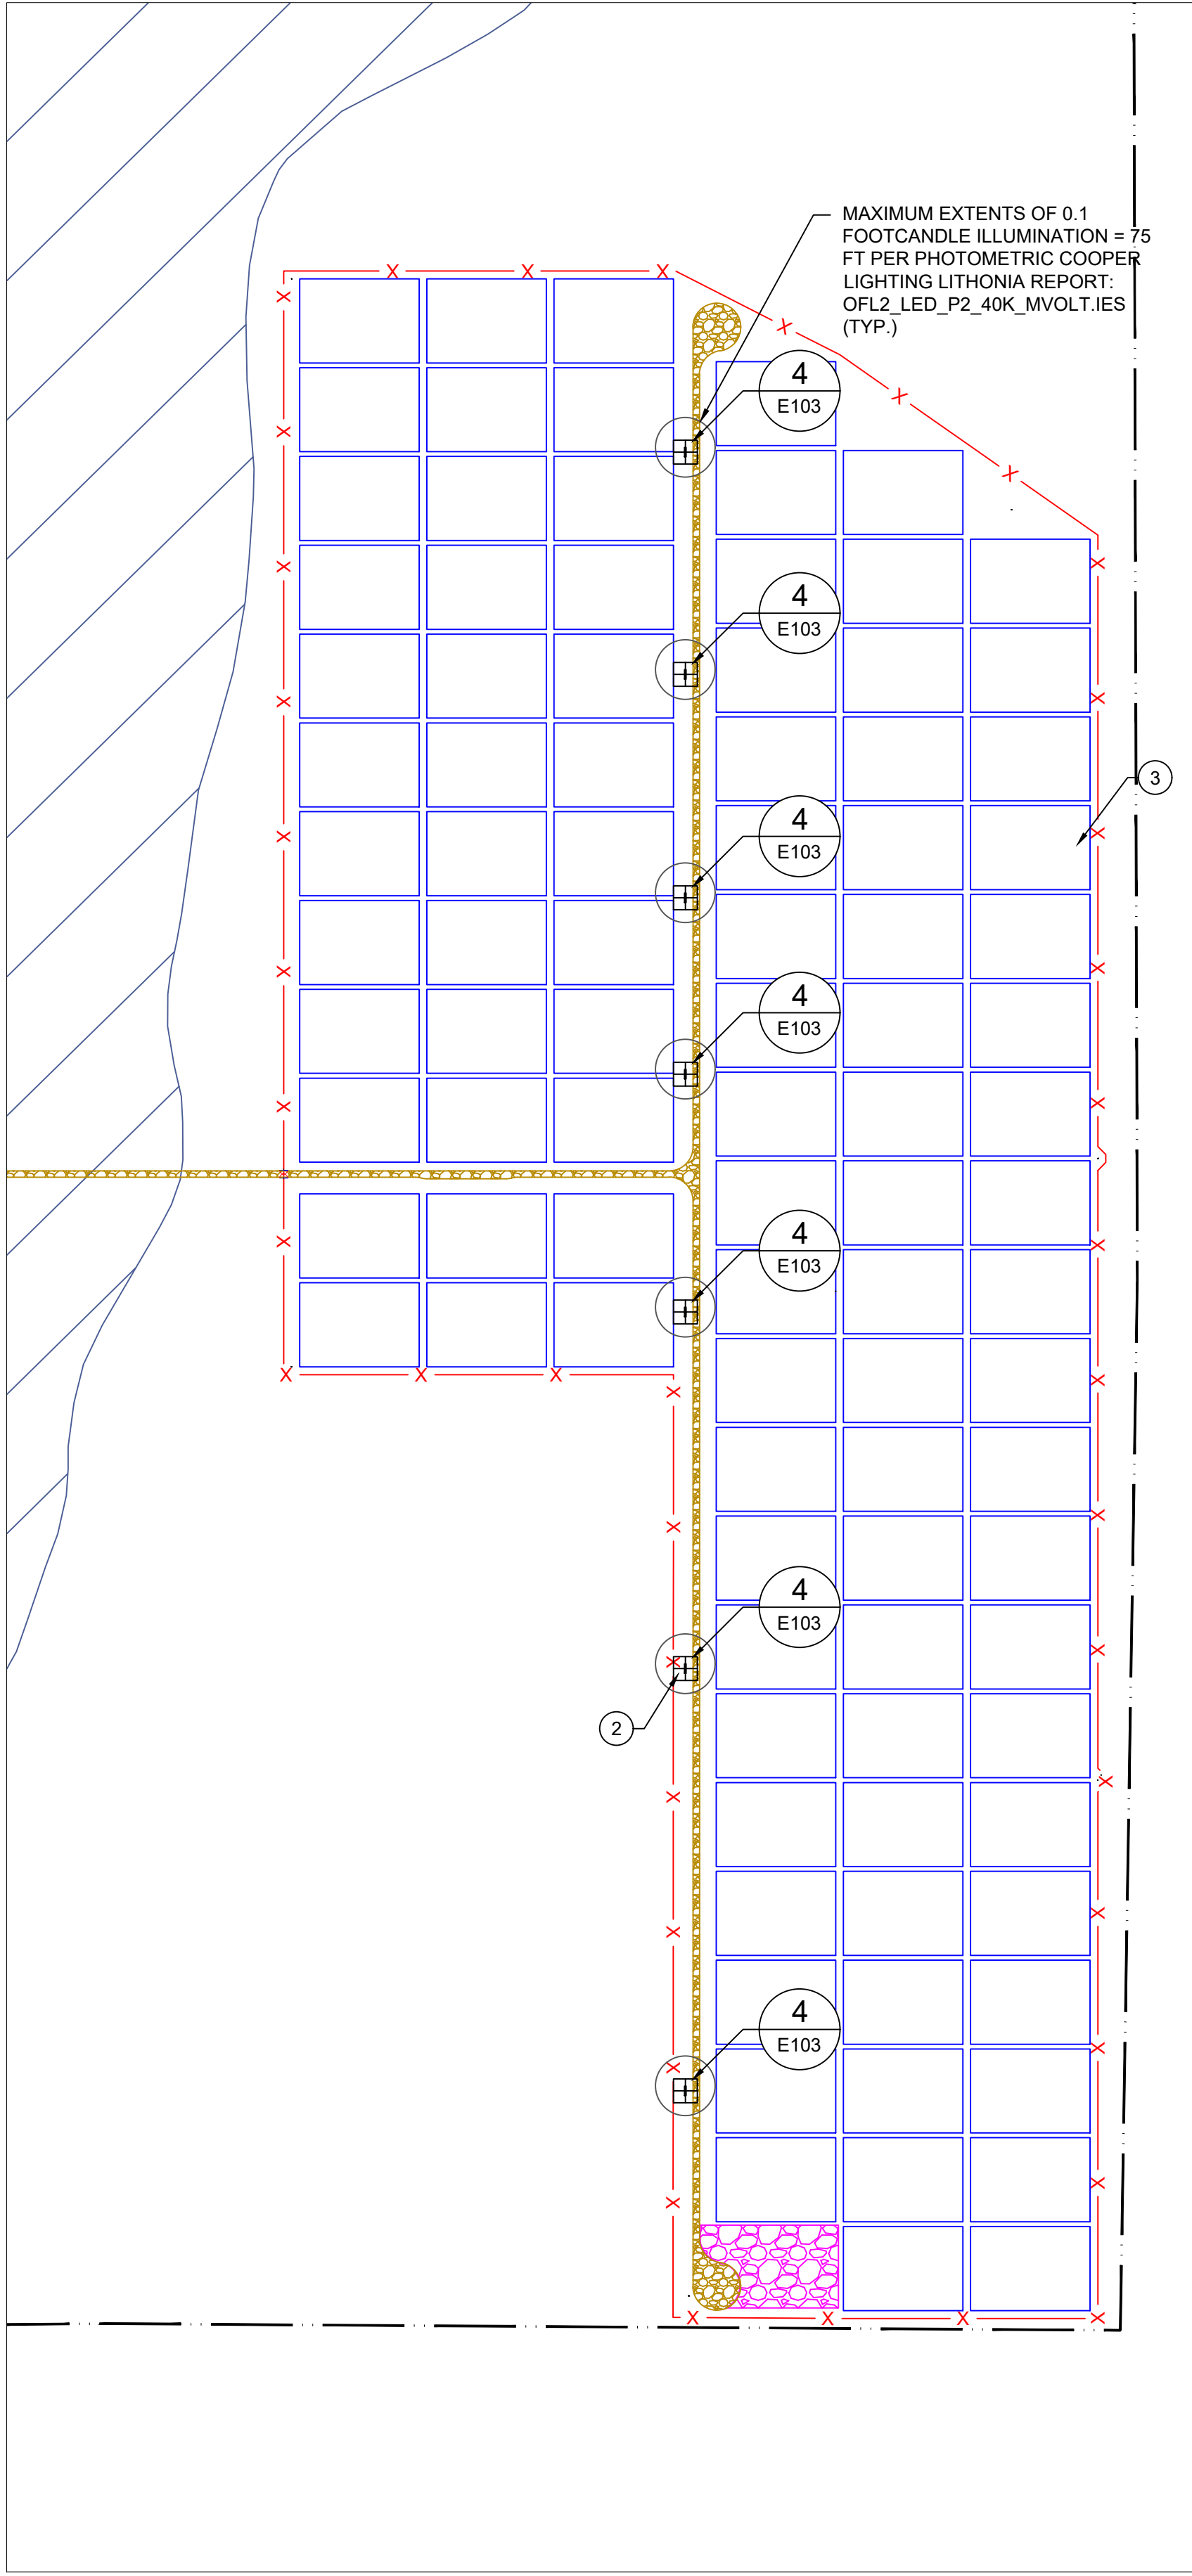

3 SECTION 8 - PLAN VIEW
 E105 SCALE: 1"=300'

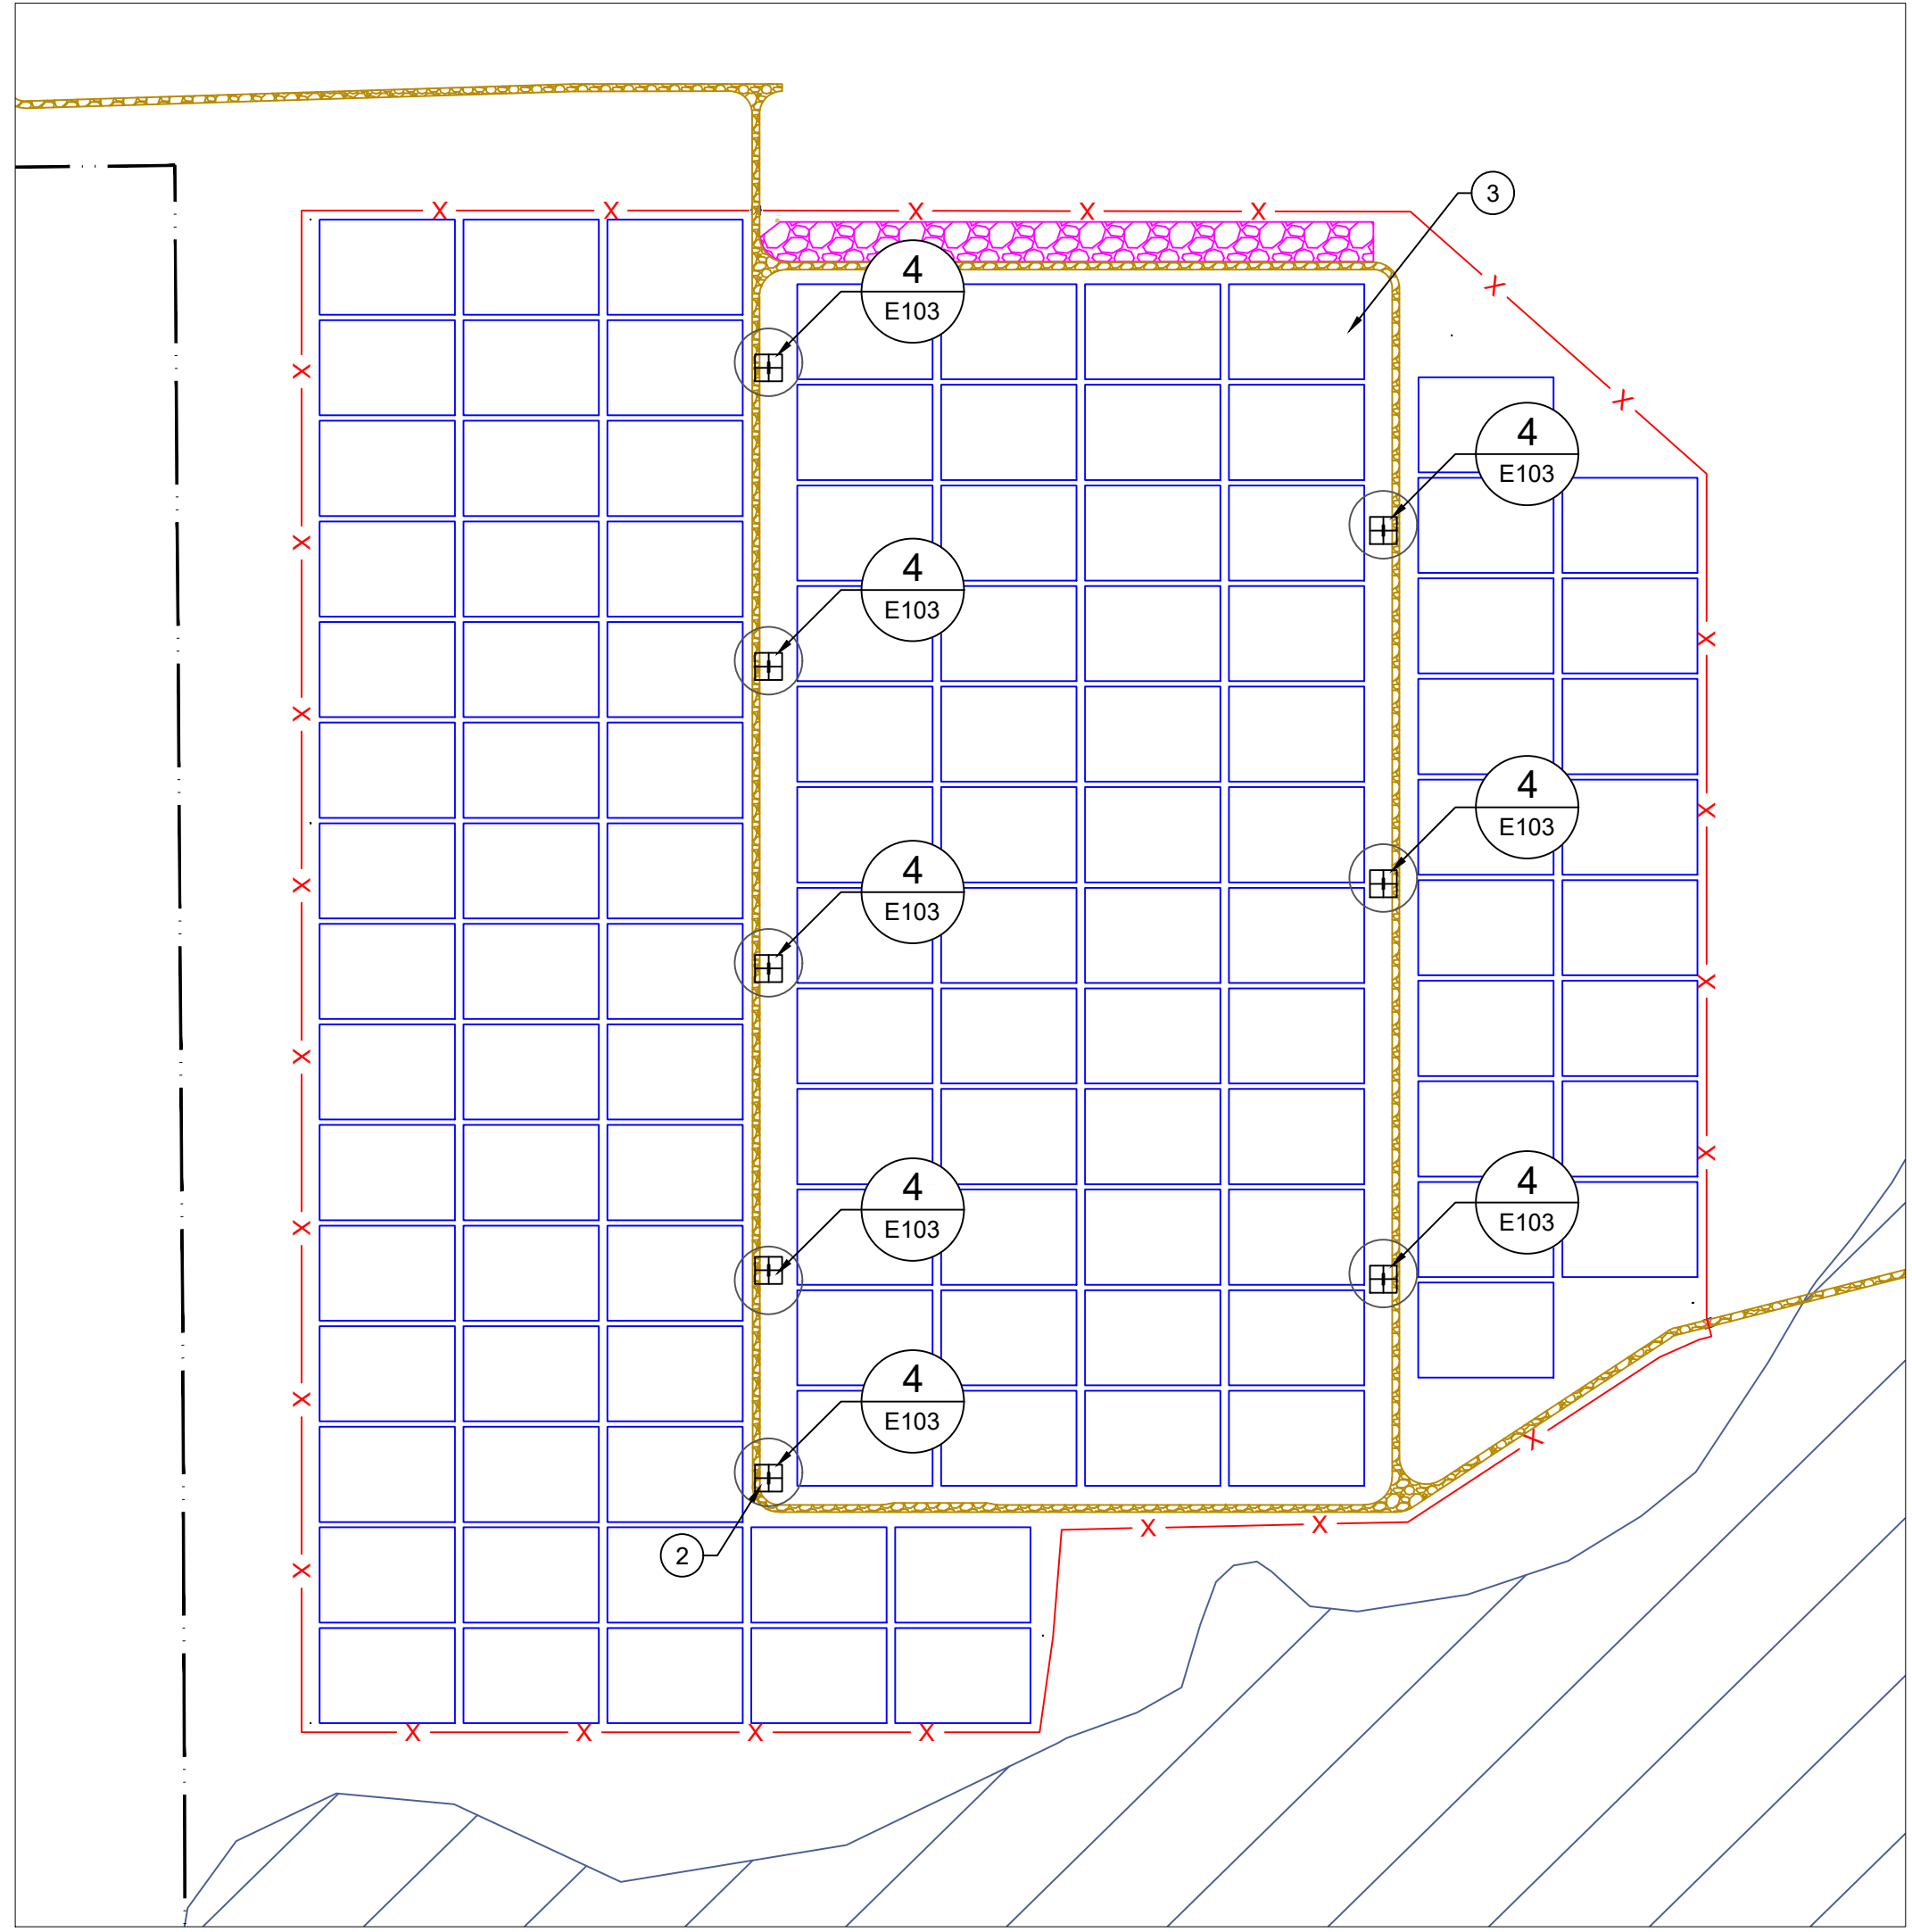

2 SECTION 7 - PLAN VIEW
 E105 SCALE: 1"=350'

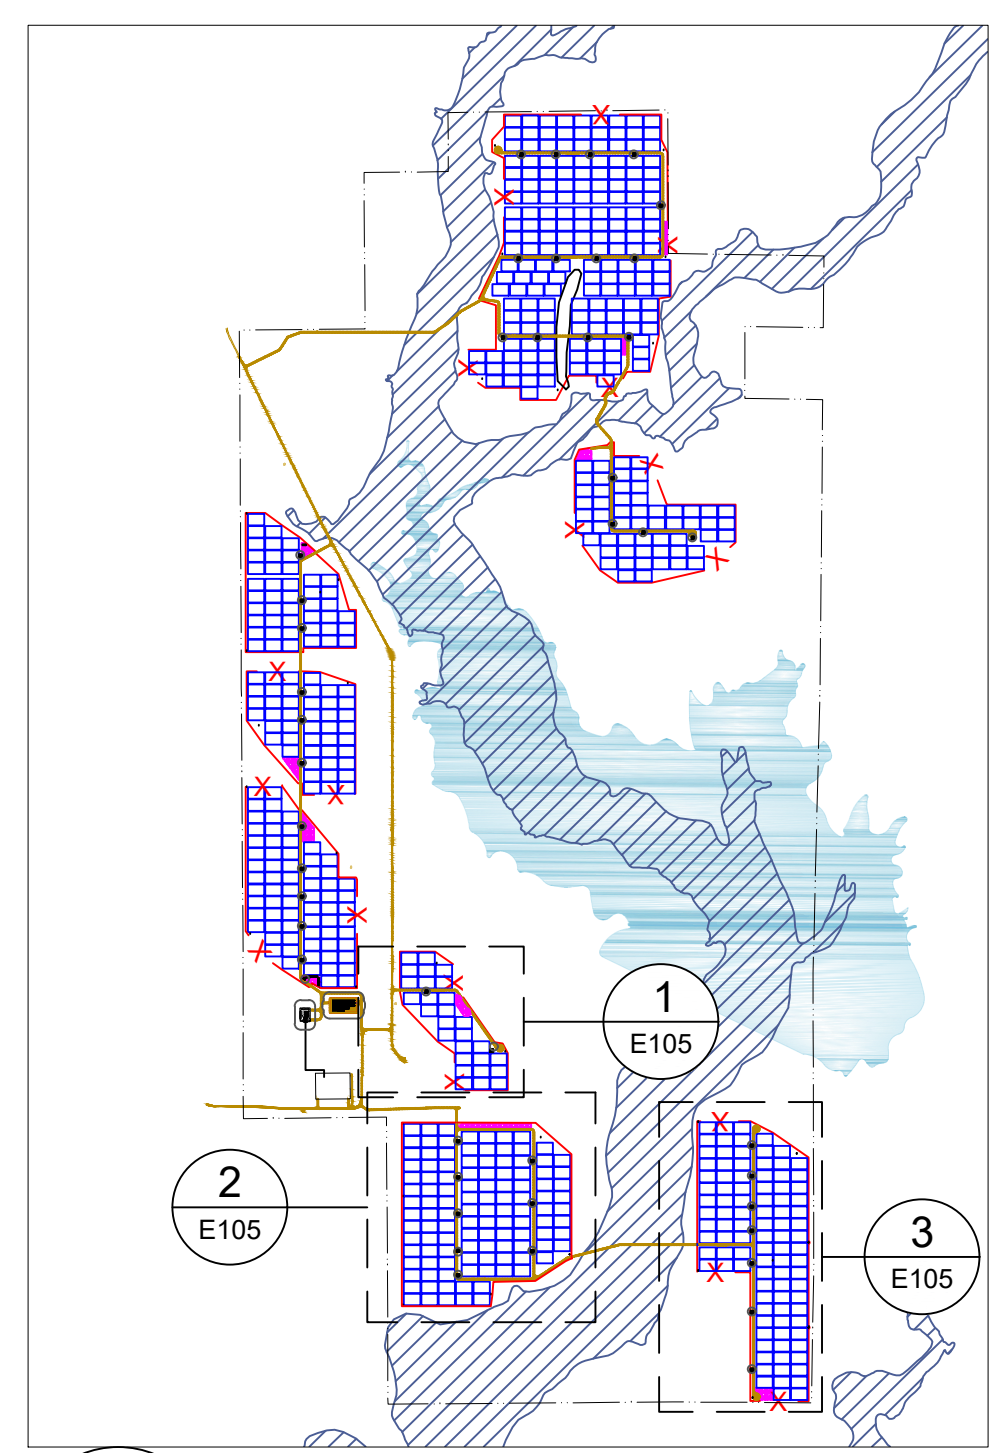

4 REFERENCE MAP
 E105 SCALE: NTS

WSEO SUBMITTAL

PROPRIETARY AND CONFIDENTIAL
 NOT TO BE REPRODUCED OR COPIED
 PRINT SIZE: ARCH D
 RESOLUTION: 300
 SCALE: 1"=350'
 SCALE: AS SHOWN
 DWG #

E105

DWG TITLE:
SITE LIGHTING PLAN - SECTIONS 6, 7, 8

Lighting_V2.pdf Markup Summary 12-8-2021

dsdparsons (2)



Subject: Text Box
Page Label: [2] E104 Site Lighting Plan-E104 Site Lighting Plan - Sections 3 4 5
Author: dsdparsons
Date: 12/8/2021 11:58:28 AM
Status:
Color: ■
Layer:
Space:

6. Site lighting, where is the service for the site lighting coming from? Are there to be new meters? Please clarify. If new meters show the locations so that a new address can be assigned..



Subject: Callout
Page Label: [2] E104 Site Lighting Plan-E104 Site Lighting Plan - Sections 3 4 5
Author: dsdparsons
Date: 12/8/2021 11:58:40 AM
Status:
Color: ■
Layer:
Space:

PPRBD comment