


LIGHT FIXTURE SCHEDULE									
TYPE	MFR	CATALOG NO.	LAMPS		MTG	DESCRIPTION	NOTES	VOLTS	TOTAL WATTS
			LUMENS	COLOR TEMP					
FL	LITHONIA	QTE LED P2 40K 120 THK DDB	4,000	3500K	RECESSED	LED FLOOD LIGHT FOR FLAG POLE		120	39.8
L50	ECOSENSE	L50 E 12 04 04 80 MULT-120	302	4000K	WALL	LOGO WALL WASH LIGHT		120	4
WL	LUMINAIRE LED	OLW 23	2613	5000K	WALL	WALL MOUNTED LED UPDATED OPTICS		120	32.98
WS	LITHONIA	OLW14	1493	5000K	WALL	GENERAL PURPOSE LED WALLPACK		120	18
PP	LITHONIA	RSX1 LED P2 50K R4 HS	7245	5000K	POLE & BASE 20' POLE 3' BASE	RSX AREA FIXTURE SIZE 1 P2 LUMEN PACKAGE 500K CCT TYPE R4 DISTRIBUTION WITH HS SHIELD		120	72.9
PP2	LITHONIA	RSX1 LED P2 50K R4 HS	7245	5000K	POLE & BASE 20' POLE 3' BASE	REX AREA FIXTURE SIZE 1 P2 LUMEN PACKAGE 5000K CCT TYPE R4 DISTRIBUTION WITH HS SHIELD		120	146.9

Statistics						
Description	Symbol	Avg	Max	Min	Max/Min	Avg/Min
Beyond Property	+	0.0 fc	0.1 fc	0.0 fc	N/A	N/A
Calc Zone #2	+	0.6 fc	12.5 fc	0.0 fc	N/A	N/A

GENERAL NOTES:

- ALL SITE AND BUILDING LIGHTS TO BE CONTROLLED BY TIME CLOCK.
- ALL LIGHTS TO BE FULL CUT-OFF.

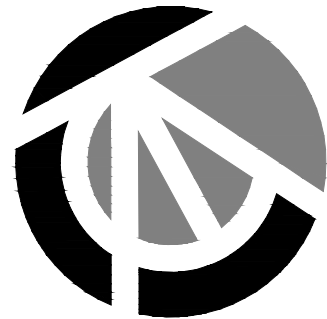

Chavez Tiffany & Ayers
Engineering Corporation

611 North Nevada Avenue
Colorado Springs, Colorado 80903
P (719)636-0021

FALCON FIRE
PROTECTION DISTRICT
7020 OLD MERIDIAN ROAD
PEYTON, COLORADO


ISSUE HISTORY:

REVISION	COMMENTS	DATE
1		9/22/2020

DRAWN BY	MTC
CHECKED BY	JJA
DATE	7/27/20

DRAWING TITLE
DEVELOPMENT PLAN

DRAWING NO.
DP-1

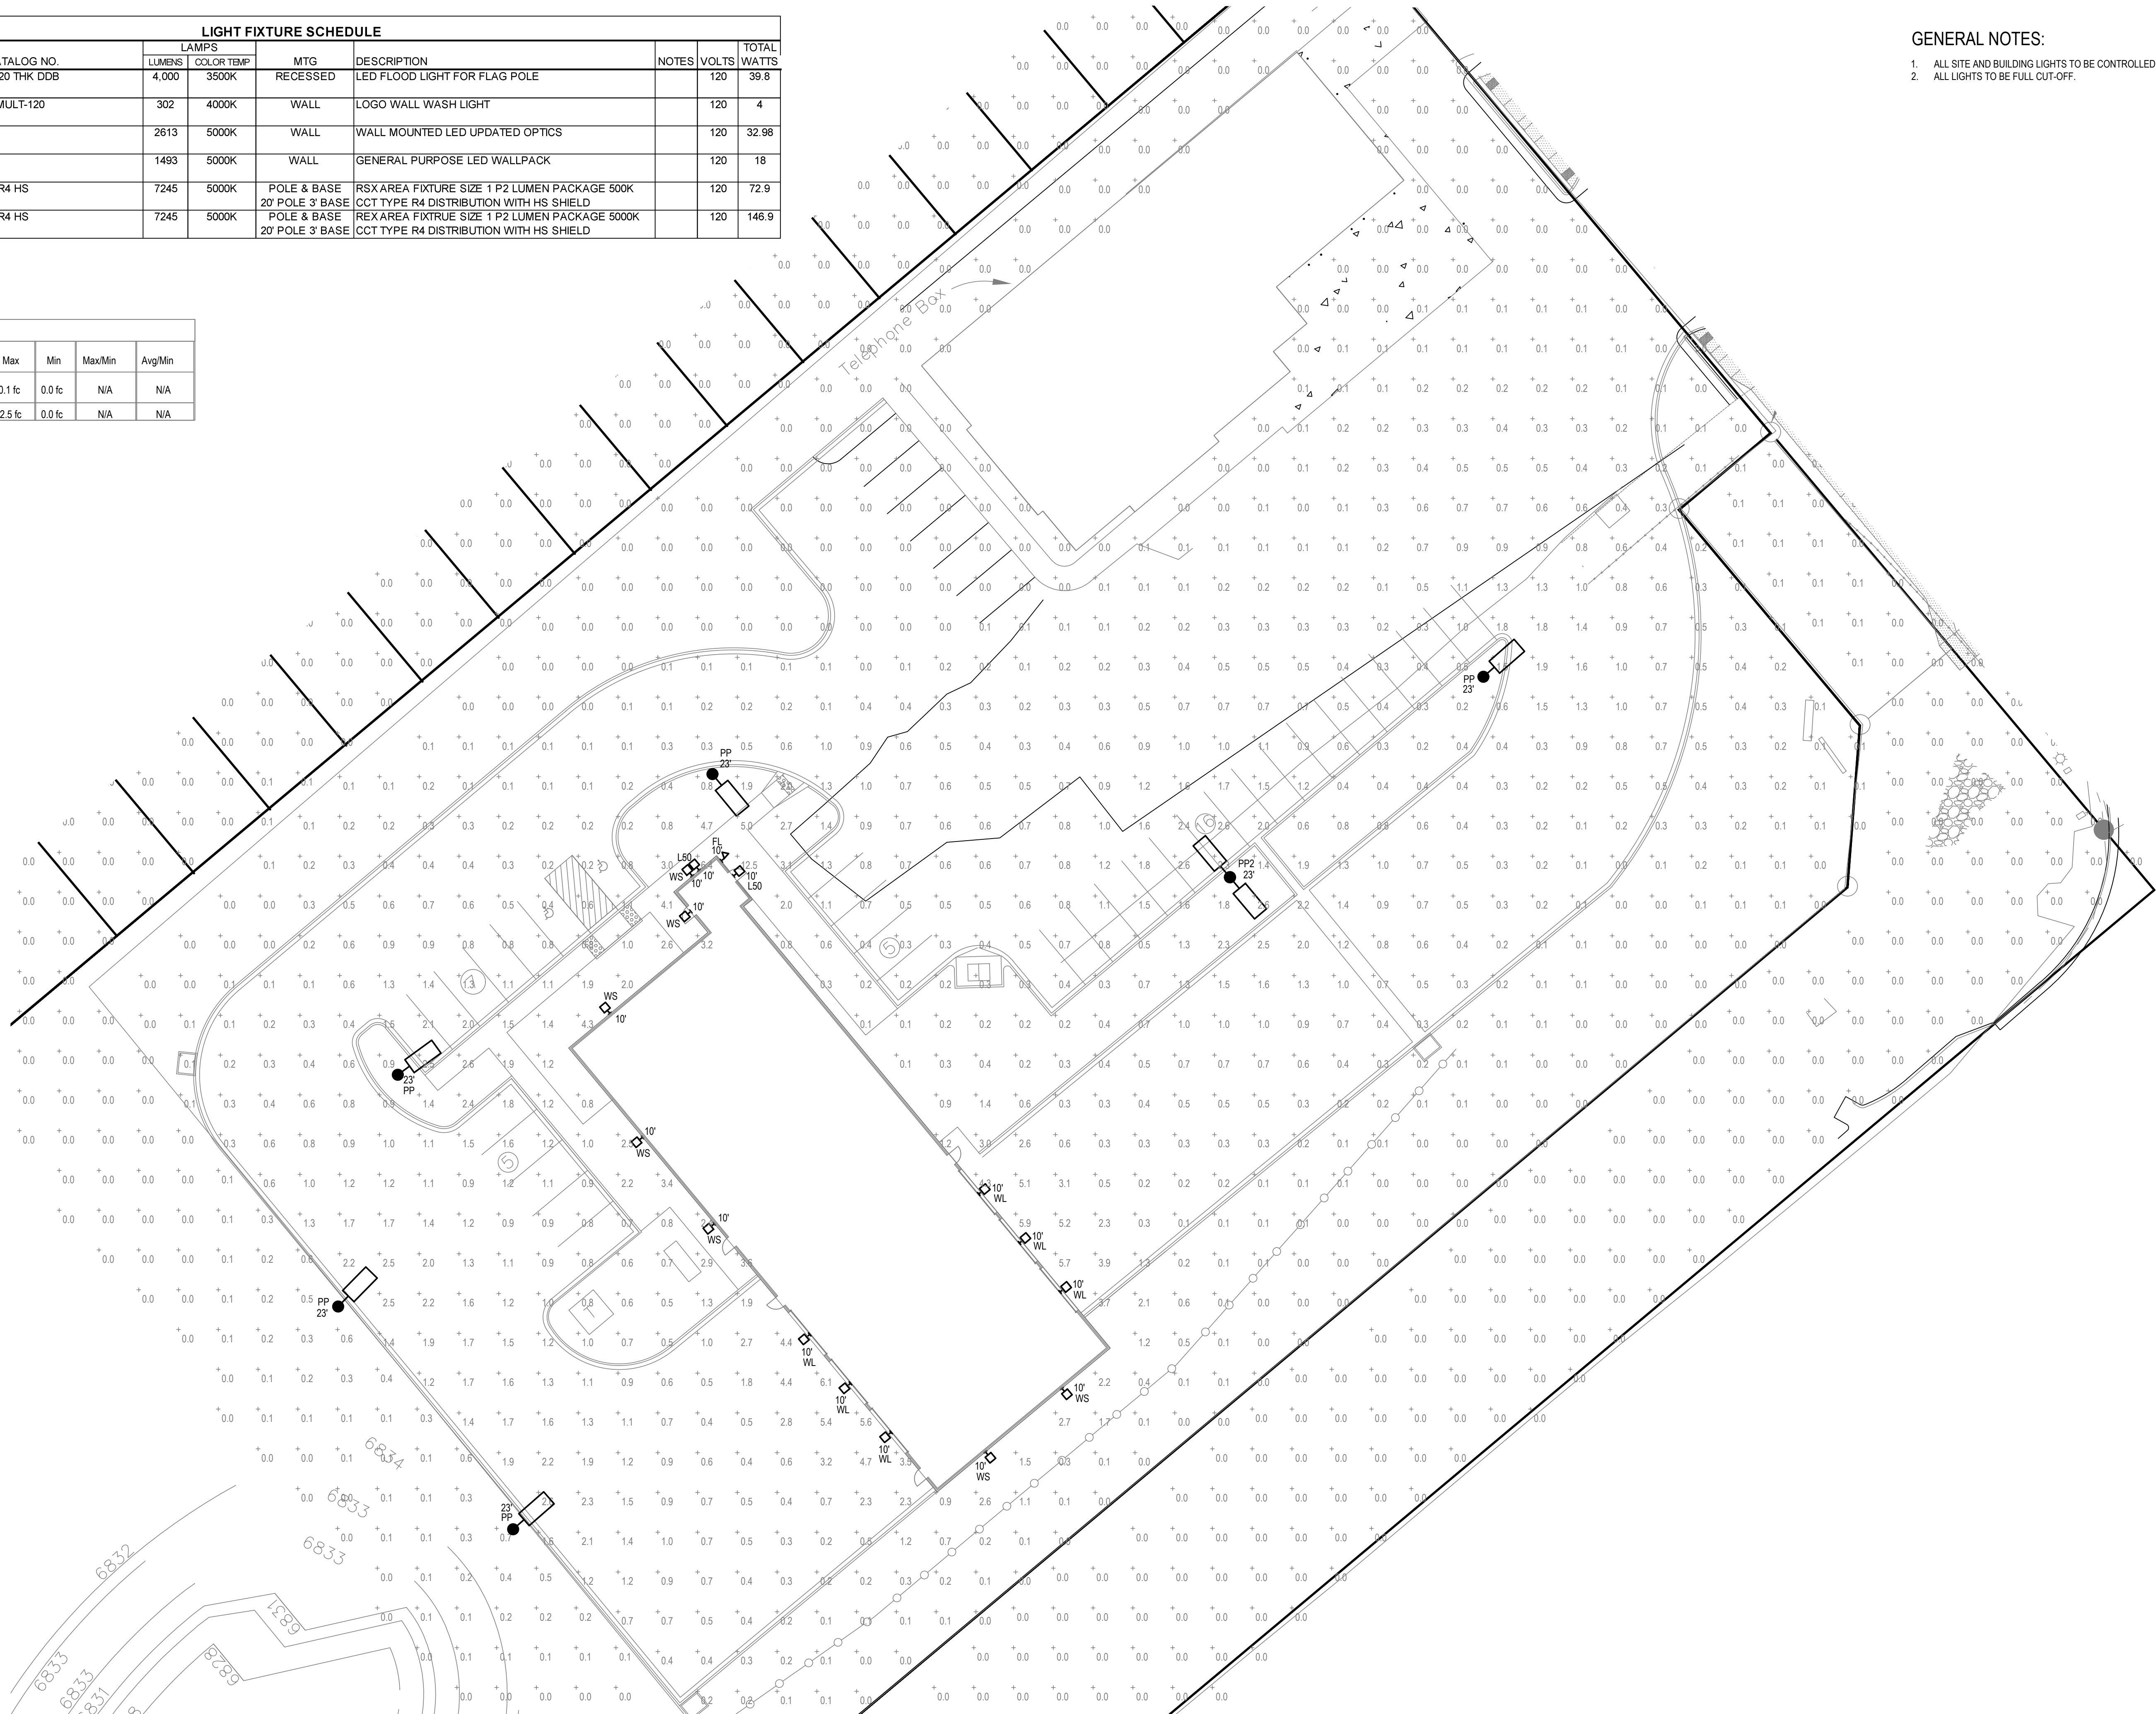

1
DP-1
SCALE: 1"=20'-0"

