

LIGHT FIXTURE SCHEDULE (SITE)

BUILDING EXTERIOR LIGHTING						
TYPE MARK	DESCRIPTION	HEIGHT	MANUFACTURER	CATALOG #	WATTS	LUMENS
L1	Exterior Wall Sconce (Balconies)	-	Acuity - Lithonia Lighting	OLLWD LED P1 40K MVOLT DDB		
L2-EM	Exterior LED Wall Pack (Breezeways)	-	Acuity - Lithonia Lighting	WDGE2 LED P2 40K 80CRI VW MVOLT E4WHDBLXD		
L3	Exterior Surface Mount LED Strip	9'	Acuity - Lithonia Lighting	FEM L48 3000LM LPAFL WD MVOLT 80CRI 35K	18.05	2,766
L4	Exterior LED Wall Pack (Garages)	9'	Acuity - Lithonia Lighting	DSXW1 LED 10C 1000 40K T3M MVOLT DBLXD		
L5	Exterior LED Wall Pack (Garages)	9'	Acuity - Lithonia Lighting	WDGE2 LED P3 40K 80CRI VW MVOLT DBLXD	22.55	3,213
L6	Exterior Wall Sconce (Clubhouse)	7'	Bega	66410 K4		

(EM) DESIGNATION BEHIND TYPE MARK INDICATES THAT FIXTURE SHALL BE PROVIDED WITH 90-MINUTE BATTERY UNIT FOR EMERGENCY BACKUP. WHERE THE FIXTURE DOES NOT HAVE EMERGENCY BATTERY UNIT OPTION, IT SHALL BE ON AN EMERGENCY CIRCUIT ROUTED THROUGH INVERTER. SEE ELEC.

SITE LIGHTING						
TYPE MARK	DESCRIPTION	HEIGHT	MANUFACTURER	CATALOG #	WATTS	LUMENS
L10	Bollard Light	-	Acuity - Lithonia Lighting	RADB LED PT5 40K SYM MVOLT BTS BCC H36 DBLXD		
L12	15' Post Top - Site	15'	Acuity - Lithonia Lighting	RADPT LED P4 40K SYM MVOLT PT4 RSS14 DBLXD	85.68	11,606
L12-D	15' Post Top - Site	15'	Acuity - Lithonia Lighting	RADPT LED P1 40K PATH HS MVOLT PT4 RSS14 DBLXD	25.4	2,380
	Straight Round Pole	15'	Acuity - Lithonia Lighting	RSS 14 4B PT DBLXD		
L13	Parking Light (T4M)	20'	Acuity - Lithonia Lighting	DSX1 LED P6 40K T4M MVOLT SPA HS DBLXD		
L14	Parking Light (T2M)	20'	Acuity - Lithonia Lighting	DSX1 LED P6 40K T2M MVOLT SPA HS DBLXD	163	18,997
	Square Straight Steel Pole	20'	Acuity - Lithonia Lighting	SSS 25 5G DM19AS VD DBLXD		

**1 SITE LIGHTING PLAN (PHASE 2)**  
SCALE: 1/64" = 1'-0"



819 S. WABASH AVENUE  
CHICAGO, ILLINOIS 60605  
312-913-1717 FAX 913-1727

OWNER / DEVELOPER:  
**JACKSON DEARBORN, LLC**

404 S. WELLS STREET  
SUITE # 400  
CHICAGO, IL 60607  
CONTACT: DANE OLMSTEAD  
TEL: 774.216.2577

CIVIL ENGINEER:  
**KIMLEY HORN**

2N NEVADA AVENUE  
SUITE # 308  
COLORADO SPRINGS, CO 80903  
TEL: 720.636.8306

STRUCTURAL ENGINEER:  
**MARTINO & LUTH, INC**

999 18TH STREET  
SUITE 855 NORTH  
DENVER, CO 80202  
TEL: 303.260.7118

MEP ENGINEER:  
**SALAS O'BRIEN**

815 SOUTH WABASH AVENUE  
CHICAGO, IL 60605  
TEL: 312.786.4310

LANDSCAPE ARCHITECT:  
**KIMLEY HORN**

2 N NEVADA AVE., SUITE 308,  
COLORADO SPRINGS, CO 80903  
TEL: 720.636.8306

*Solace*  
at Cimarron Hills  
GALLEY AND POWERS RD  
COLORADO SPRINGS, CO 80915

SUBMITTAL DATE:

REVISION DATE:

Job Number: 0614.0010

STAMP:





EXPIRES: 10/31/2023

Sheet Title:  
**SITE LIGHTING PLAN**

Sheet Number:

**A0.03**

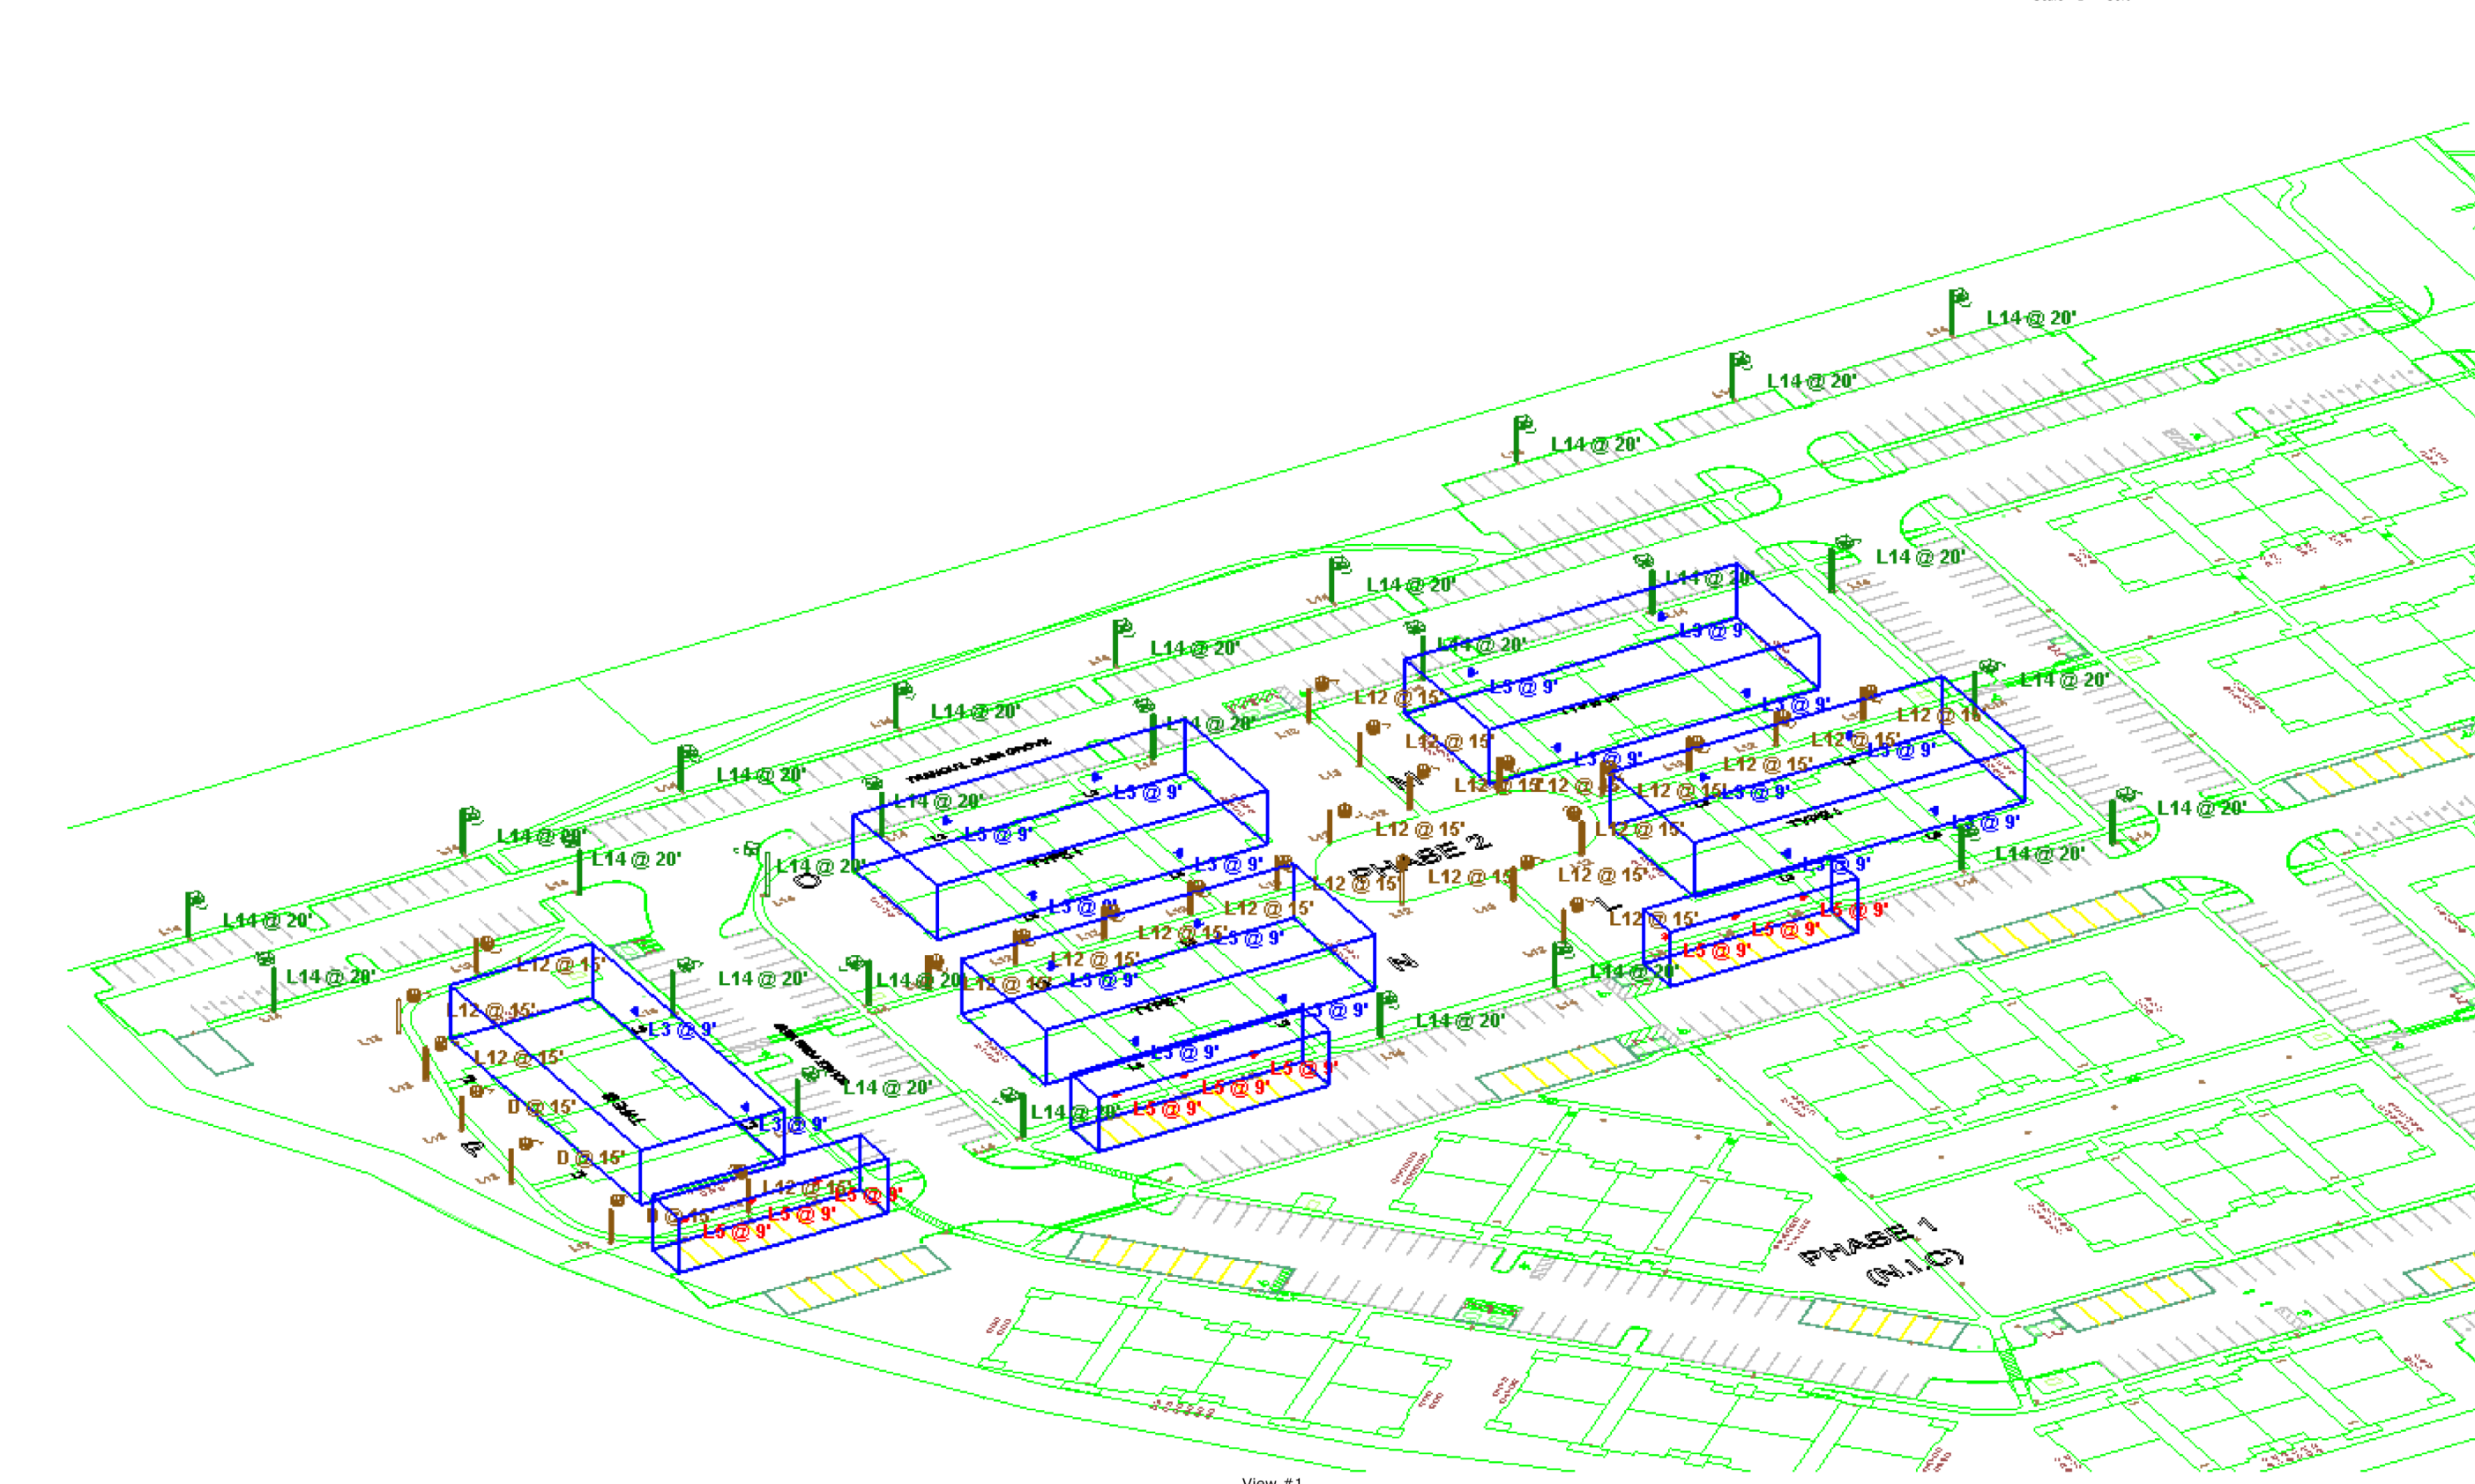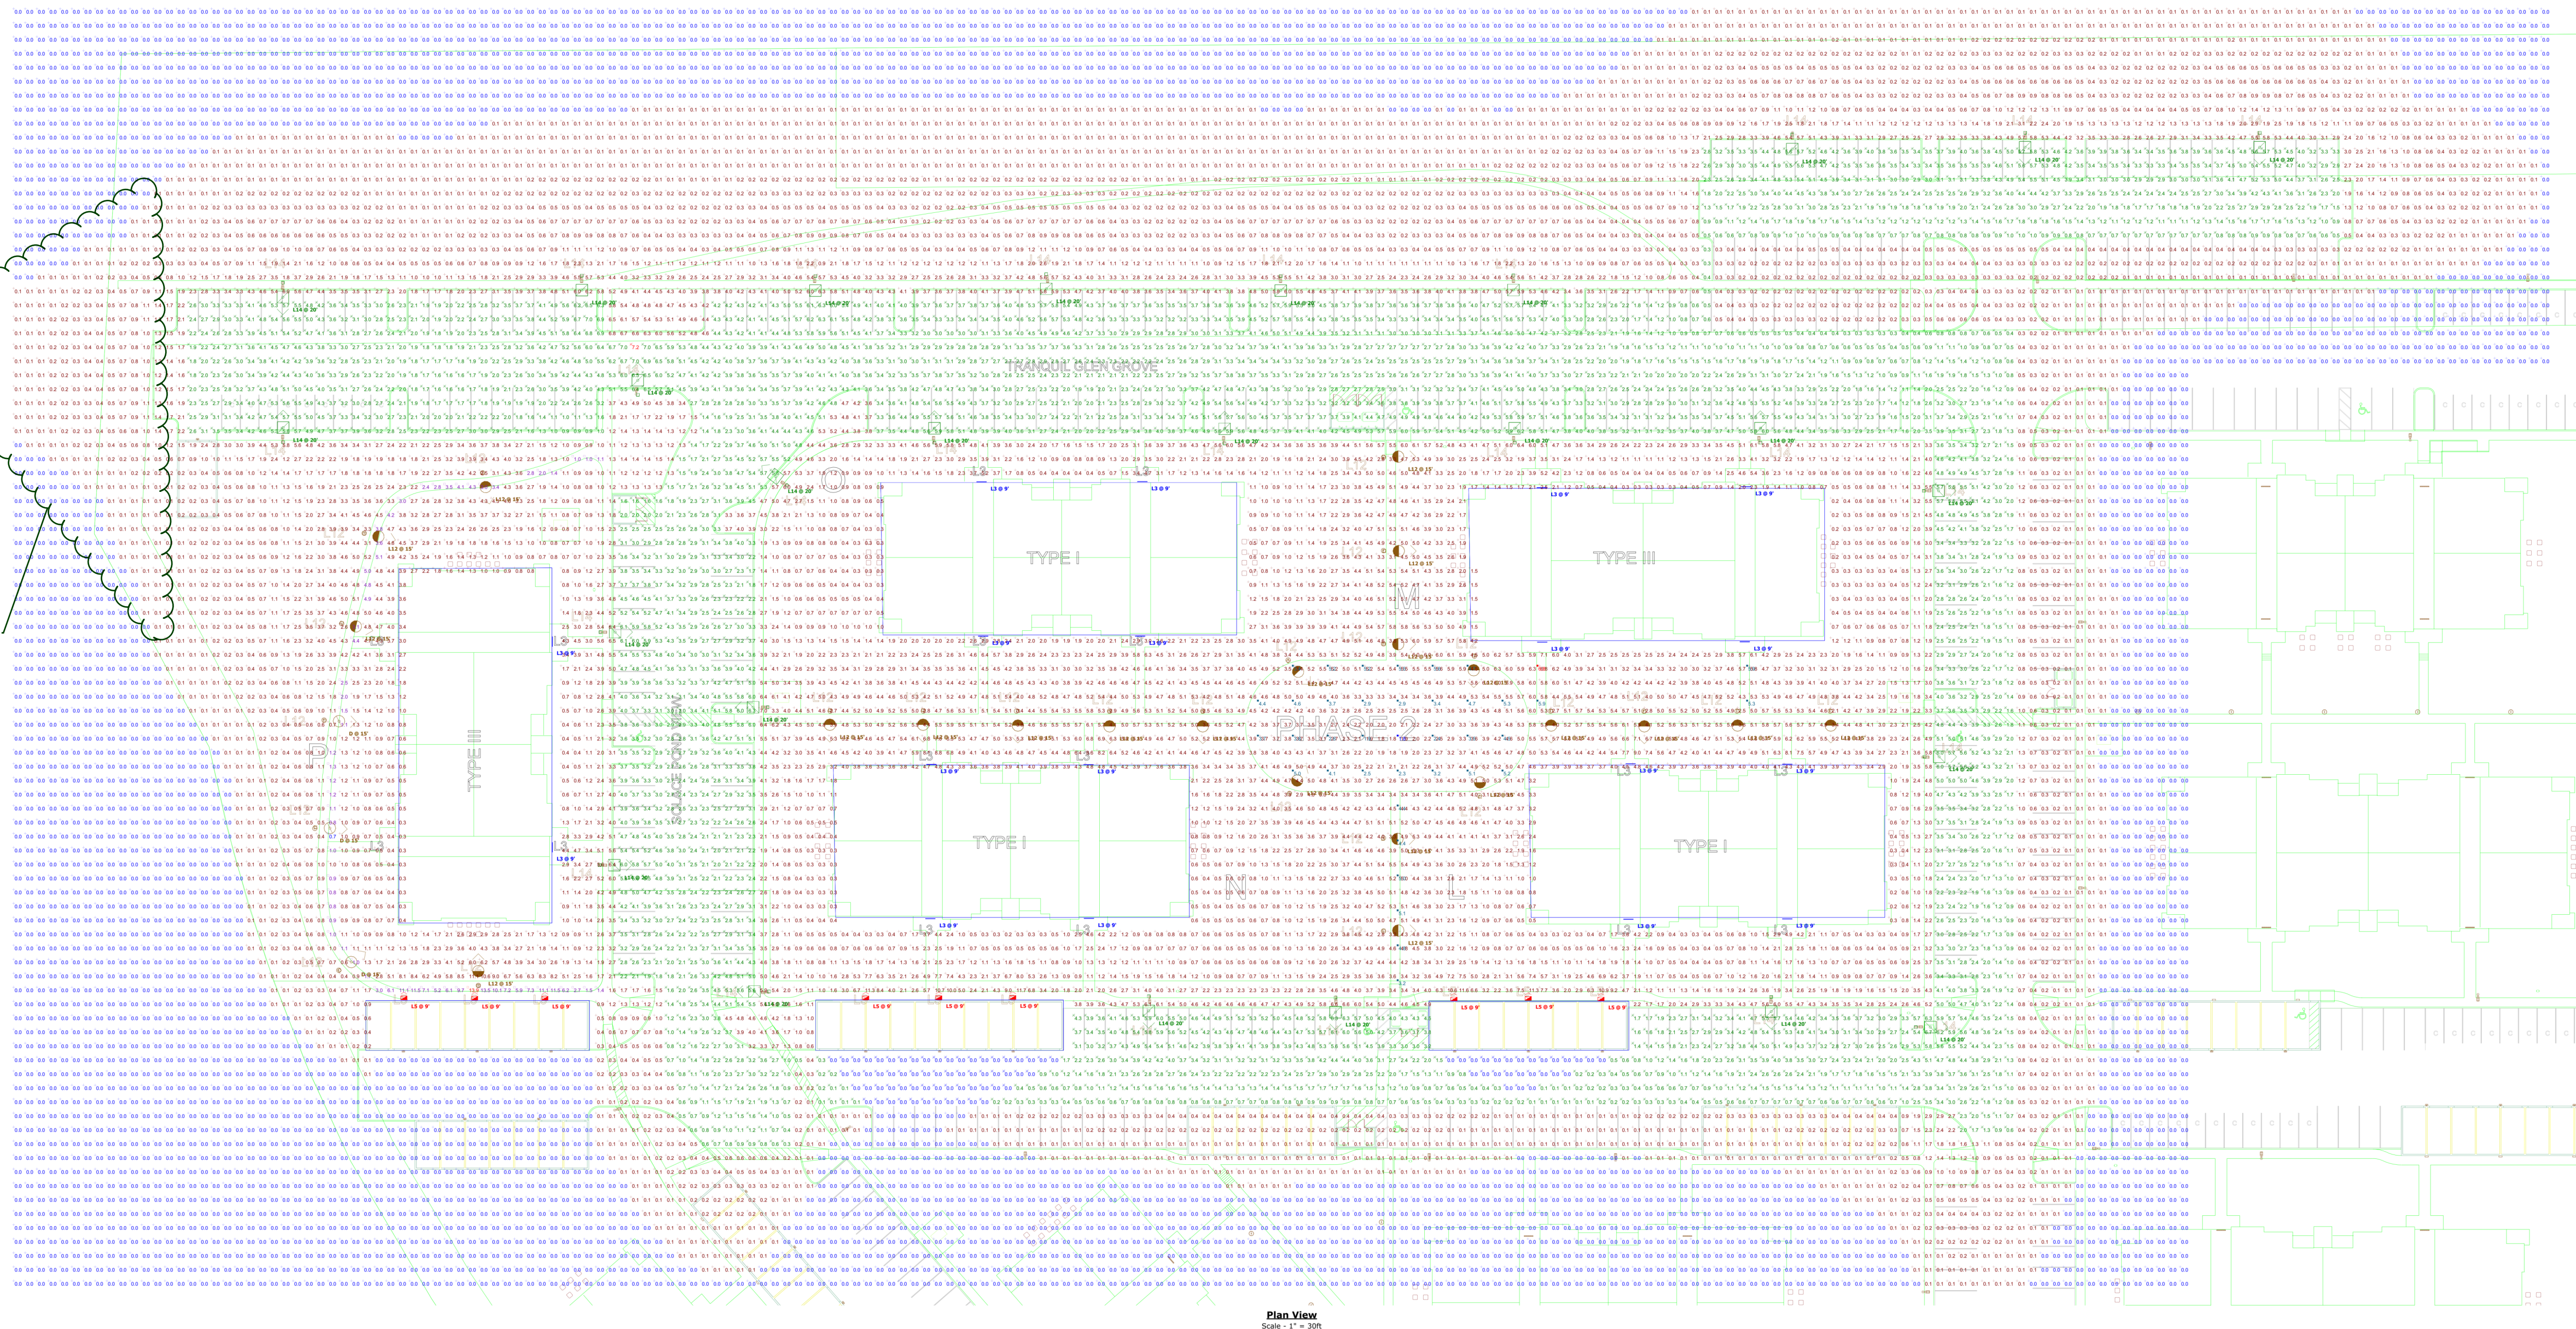

**Note**  
This architectural lighting submittal is provided only for informational purposes and to help the customer or end-user (as applicable) understand how various sections of linear fixtures connect to each other and how they mount to the ceiling. This lighting submittal is strictly based on the information provided to Acuity Brands, and is provided without warranty as to accuracy, completeness, reliability or otherwise. If the information (including but not limited to floorplans, reflected ceiling plans, electrical plans and specifications) provided to Acuity Brands is incorrect, incomplete, or newer versions exist, the accuracy of proposed design may be adversely affected. Once this lighting submittal is received by the customer or end-user (as applicable), it is the obligation of the customer or end-user (as applicable) to consult with a professional engineer to determine whether the proposed design meets the applicable code requirements, code compliance, safety, suitability and effectiveness for use in a particular application. In no event will Acuity Brands be responsible for any loss resulting from any use of any information contained in this lighting submittal.

**Note**  
1. Readings shown are based on a total LLF of as shown at grade. Data references the extrapolated performance projections in a 25c ambient based on 10,000 hrs of LED testing (per IESNA LM-80-08 and projected per IESNA TM-30-15)  
2. Please refer to the "luminaire locations" for mounting heights.  
3. Product information can be obtained at [www.Lithonia.com](http://www.Lithonia.com) or through your local agency.

Description	Symbol	Avg	Max	Min	Max/Min	Avg/Min
Phase 2 Center Walkway	■	4.2 fc	6.8 fc	1.8 fc	3.8:1	2.3:1
Phase 2 Parking Area	■	2.9 fc	7.2 fc	0.0 fc	N/A	N/A
Phase 2 West Walkway	■	4.0 fc	13.9 fc	0.7 fc	19.9:1	5.7:1
Spill Light Summary	+	1.4 fc	13.9 fc	0.0 fc	N/A	N/A

Schedule	Label	Quantity	Manufacturer	Catalog Number	Description	Number	Lumens	Light Loss Factor	Total Lumens	Wattage	Distribution
	D	3	Lithonia Lighting	RADIAN P1 40K PATH H	RADIAN Post Top with P1 4000K Pathway (R100)	1	2380	0.91	2380	25.41A	TYPE IV, SHORT, BUSHING, 8'-10" - 10'
	L3	18	Lithonia Lighting	REM L48 3000K LUMI	REM L48 3000K LUMI (wide profile, narrow lens, wide distribution, 80 CRI, 5000K)	1	2766	0.9	2766	18.05	DIRECT, SCQ=1.31, SC=96-1.84
	L5	9	Lithonia Lighting	W062Z LED P3 40K	W062Z LED WITH P3 PERFORMANCE (40K, 80CRI, VISUAL COMFORT WIDE OPTIC)	1	3213	0.95	3213	22.55	TYPE IV, VERY SHORT, BUSHING, 8'-10" - 10'
	L12	22	Lithonia Lighting	RADIAN P4 40K S/M	RADIAN Post Top with P4 4000K (S/M) (wide profile, narrow lens, wide distribution, 80 CRI, 5000K)	1	11606	0.91	11606	85.67B	TYPE IV, MEDIUM, BUSHING, 8'-10" - 10'
	L14	26	Lithonia Lighting	DSX1 LED P4 40K 12M	DSX1 LED with 40K 12M (wide profile, narrow lens, wide distribution, 80 CRI, 5000K)	1	18997	0.92	18997	163	TYPE IV, MEDIUM, BUSHING, 8'-10" - 10'

**Radean Post Top**

**Specifications**

Length	12.00"
Depth	12.00"
Height	12.00"
Weight	12.00 lbs
Material	Aluminum
Finish	White
Beam Angle	120°
Color Temperature	4000K
CR	80
Input Voltage	120V
Power	25.41W
Efficiency	91 lm/w

**Outgoing Information**

Item	Manufacturer	Part Number	Notes
1	Lithonia	RADIAN P1 40K PATH H	

**Radean Bollard**

**Specifications**

Length	12.00"
Depth	12.00"
Height	12.00"
Weight	12.00 lbs
Material	Aluminum
Finish	White
Beam Angle	120°
Color Temperature	4000K
CR	80
Input Voltage	120V
Power	25.41W
Efficiency	91 lm/w

**Outgoing Information**

Item	Manufacturer	Part Number	Notes
1	Lithonia	RADIAN BOLLARD	

**D-Series Size 1**

**Specifications**

Length	12.00"
Depth	12.00"
Height	12.00"
Weight	12.00 lbs
Material	Aluminum
Finish	White
Beam Angle	120°
Color Temperature	4000K
CR	80
Input Voltage	120V
Power	25.41W
Efficiency	91 lm/w

**Outgoing Information**

Item	Manufacturer	Part Number	Notes
1	Lithonia	D-SERIES SIZE 1	

**D-Series Size 1**

**Specifications**

Length	12.00"
Depth	12.00"
Height	12.00"
Weight	12.00 lbs
Material	Aluminum
Finish	White
Beam Angle	120°
Color Temperature	4000K
CR	80
Input Voltage	120V
Power	25.41W
Efficiency	91 lm/w

**Outgoing Information**

Item	Manufacturer	Part Number	Notes
1	Lithonia	D-SERIES SIZE 1	



819 S. WABASH AVENUE  
CHICAGO, ILLINOIS 60605  
312-913-1717 FAX 913-1727

**OWNER / DEVELOPER:**  
**JACKSON DEARBORN, LLC**  
404 S. WELLS STREET  
SUITE # 400  
CHICAGO, IL 60607  
CONTACT: DAN OLMSTEAD  
TEL: 774.216.2377

**CIVIL ENGINEER:**  
**KIMLEY HORN**  
2N NEVADA AVENUE,  
SUITE # 308  
COLORADO SPRINGS, CO 80903  
TEL: 720.636.8306

**STRUCTURAL ENGINEER:**  
**MARTINO & LUTH, INC**  
999 18TH STREET  
SUITE 855 NORTH  
DENVER, CO 80202  
TEL: 303.260.7118

**MEP ENGINEER:**  
**SALAS O'BRIEN**  
815 SOUTH WABASH AVENUE  
CHICAGO, IL 60605  
TEL: 312.786.4310

**LANDSCAPE ARCHITECT:**  
**KIMLEY HORN**  
2 N NEVADA AVE, SUITE 308,  
COLORADO SPRINGS, CO 80903  
TEL: 720.636.8306

**LANDSCAPE ARCHITECT:**  
**KIMLEY HORN**  
2 N NEVADA AVE, SUITE 308,  
COLORADO SPRINGS, CO 80903  
TEL: 720.636.8306

**LANDSCAPE ARCHITECT:**  
**KIMLEY HORN**  
2 N NEVADA AVE, SUITE 308,  
COLORADO SPRINGS, CO 80903  
TEL: 720.636.8306

**LANDSCAPE ARCHITECT:**  
**KIMLEY HORN**  
2 N NEVADA AVE, SUITE 308,  
COLORADO SPRINGS, CO 80903  
TEL: 720.636.8306

**LANDSCAPE ARCHITECT:**  
**KIMLEY HORN**  
2 N NEVADA AVE, SUITE 308,  
COLORADO SPRINGS, CO 80903  
TEL: 720.636.8306

**LANDSCAPE ARCHITECT:**  
**KIMLEY HORN**  
2 N NEVADA AVE, SUITE 308,  
COLORADO SPRINGS, CO 80903  
TEL: 720.636.8306

**LANDSCAPE ARCHITECT:**  
**KIMLEY HORN**  
2 N NEVADA AVE, SUITE 308,  
COLORADO SPRINGS, CO 80903  
TEL: 720.636.8306

**LANDSCAPE ARCHITECT:**  
**KIMLEY HORN**  
2 N NEVADA AVE, SUITE 308,  
COLORADO SPRINGS, CO 80903  
TEL: 720.636.8306

**LANDSCAPE ARCHITECT:**  
**KIMLEY HORN**  
2 N NEVADA AVE, SUITE 308,  
COLORADO SPRINGS, CO 80903  
TEL: 720.636.8306

**LANDSCAPE ARCHITECT:**  
**KIMLEY HORN**  
2 N NEVADA AVE, SUITE 308,  
COLORADO SPRINGS, CO 80903  
TEL: 720.636.8306

**LANDSCAPE ARCHITECT:**  
**KIMLEY HORN**  
2 N NEVADA AVE, SUITE 308,  
COLORADO SPRINGS, CO 80903  
TEL: 720.636.8306

**LANDSCAPE ARCHITECT:**  
**KIMLEY HORN**  
2 N NEVADA AVE, SUITE 308,  
COLORADO SPRINGS, CO 80903  
TEL: 720.636.8306

**LANDSCAPE ARCHITECT:**  
**KIMLEY HORN**  
2 N NEVADA AVE, SUITE 308,  
COLORADO SPRINGS, CO 80903  
TEL: 720.636.8306

**LANDSCAPE ARCHITECT:**  
**KIMLEY HORN**  
2 N NEVADA AVE, SUITE 308,  
COLORADO SPRINGS, CO 80903  
TEL: 720.636.8306

**LANDSCAPE ARCHITECT:**  
**KIMLEY HORN**  
2 N NEVADA AVE, SUITE 308,  
COLORADO SPRINGS, CO 80903  
TEL: 720.636.8306

**LANDSCAPE ARCHITECT:**  
**KIMLEY HORN**  
2 N NEVADA AVE, SUITE 308,  
COLORADO SPRINGS, CO 80903  
TEL: 720.636.8306

**LANDSCAPE ARCHITECT:**  
**KIMLEY HORN**  
2 N NEVADA AVE, SUITE 308,  
COLORADO SPRINGS, CO 80903  
TEL: 720.636.8306

**LANDSCAPE ARCHITECT:**  
**KIMLEY HORN**  
2 N NEVADA AVE, SUITE 308,  
COLORADO SPRINGS, CO 80903  
TEL: 720.636.8306

**LANDSCAPE ARCHITECT:**  
**KIMLEY HORN**  
2 N NEVADA AVE, SUITE 308,  
COLORADO SPRINGS, CO 80903  
TEL: 720.636.8306

**LANDSCAPE ARCHITECT:**  
**KIMLEY HORN**  
2 N NEVADA AVE, SUITE 308,  
COLORADO SPRINGS, CO 80903  
TEL: 720.636.8306

**LANDSCAPE ARCHITECT:**  
**KIMLEY HORN**  
2 N NEVADA AVE, SUITE 308,  
COLORADO SPRINGS, CO 80903  
TEL: 720.636.8306

**LANDSCAPE ARCHITECT:**  
**KIMLEY HORN**  
2 N NEVADA AVE, SUITE 308,  
COLORADO SPRINGS, CO 80903  
TEL: 720.636.8306

**LANDSCAPE ARCHITECT:**  
**KIMLEY HORN**  
2 N NEVADA AVE, SUITE 308,  
COLORADO SPRINGS, CO 80903  
TEL: 720.636.8306

**LANDSCAPE ARCHITECT:**  
**KIMLEY HORN**  
2 N NEVADA AVE, SUITE 308,  
COLORADO SPRINGS, CO 80903  
TEL: 720.636.8306

**LANDSCAPE ARCHITECT:**  
**KIMLEY HORN**  
2 N NEVADA AVE, SUITE 308,  
COLORADO SPRINGS, CO 80903  
TEL: 720.636.8306