

SOLACE OF COLORADO SPRINGS - EXTERIOR LIGHT FIXTURE SCHEDULE

EXTERIOR			
L1	Exterior wall sconce - Balconies	ABL-Lithonia Lighting	OLLWD LED P1 40K MVOLT DDB
L2-EM	Exterior LED Wall pack - Breezeways	ABL-Lithonia Lighting	WDGE2 LED P2 40K 80CRI VW MVOLT E4WHDBLXD
L3	Exterior Surface mount LED strip @9' AFF	ABL-Lithonia Lighting	FEM L48 3000LM LPAPL WD MVOLT 35K 80CRI
L4	Exterior LED Wall pack - Garages @9' AFF	ABL-Lithonia Lighting	DSXW1 LED 10C 1000 40K T3M MVOLT DBLXD
L5	Exterior LED Wall pack - Garages @9' AFF	ABL-Lithonia Lighting	WDGE2 LED P3 40K 80CRI VW MVOLT DBLXD
L6	Exterior wall sconce - Clubhouse @7' AFF	Bega	66410 K4
(EM) DESIGNATION BEHIND TYPE MARK INDICATES THAT FIXTURE SHALL BE PROVIDED WITH 90-MINUTE BATTERY UNIT FOR EMERGENCY BACKUP. WHERE THE FIXTURE DOES NOT HAVE EMERGENCY BATTERY UNIT OPTION, IT SHALL BE ON AN EMERGENCY CIRCUIT ROUTED THROUGH INVERTER. SEE ELEC.			
SITE			
L10	Bollard Light	ABL-Lithonia Lighting	RADB LED PT5 40K SYM MVOLT BTS BCC H36 DBLXD
L12	15' Post Top - Site	ABL-Lithonia Lighting	RADPT LED P4 40K SYM MVOLT PT4 RSS14 DBLXD
	Straight Round Pole 15'	ABL-Lithonia Lighting	RSS 14 48 PT DBLXD
L13	Parking Light - 20' (T4M)	ABL-Lithonia Lighting	DSX1 LED P6 40K T4M MVOLT SPA HS DBLXD
L14	Parking Light - 20' (T2M)	ABL-Lithonia Lighting	DSX1 LED P6 40K T2M MVOLT SPA HS DBLXD
	Square Straight Steel Pole 20'	ABL-Lithonia Lighting	SSS 25 5G DM19AS VD DBLXD

1 SITE LIGHTING PLAN (PHASE 2)

SCALE: 1/64" = 1'-0"

SUBMITTAL DATE: _____

REVISION DATE: _____


Job Number: 0614.0010



EXPIRES: 10/31/2023

Sheet Title:
SITE LIGHTING PLAN

Sheet Number:
A0.03

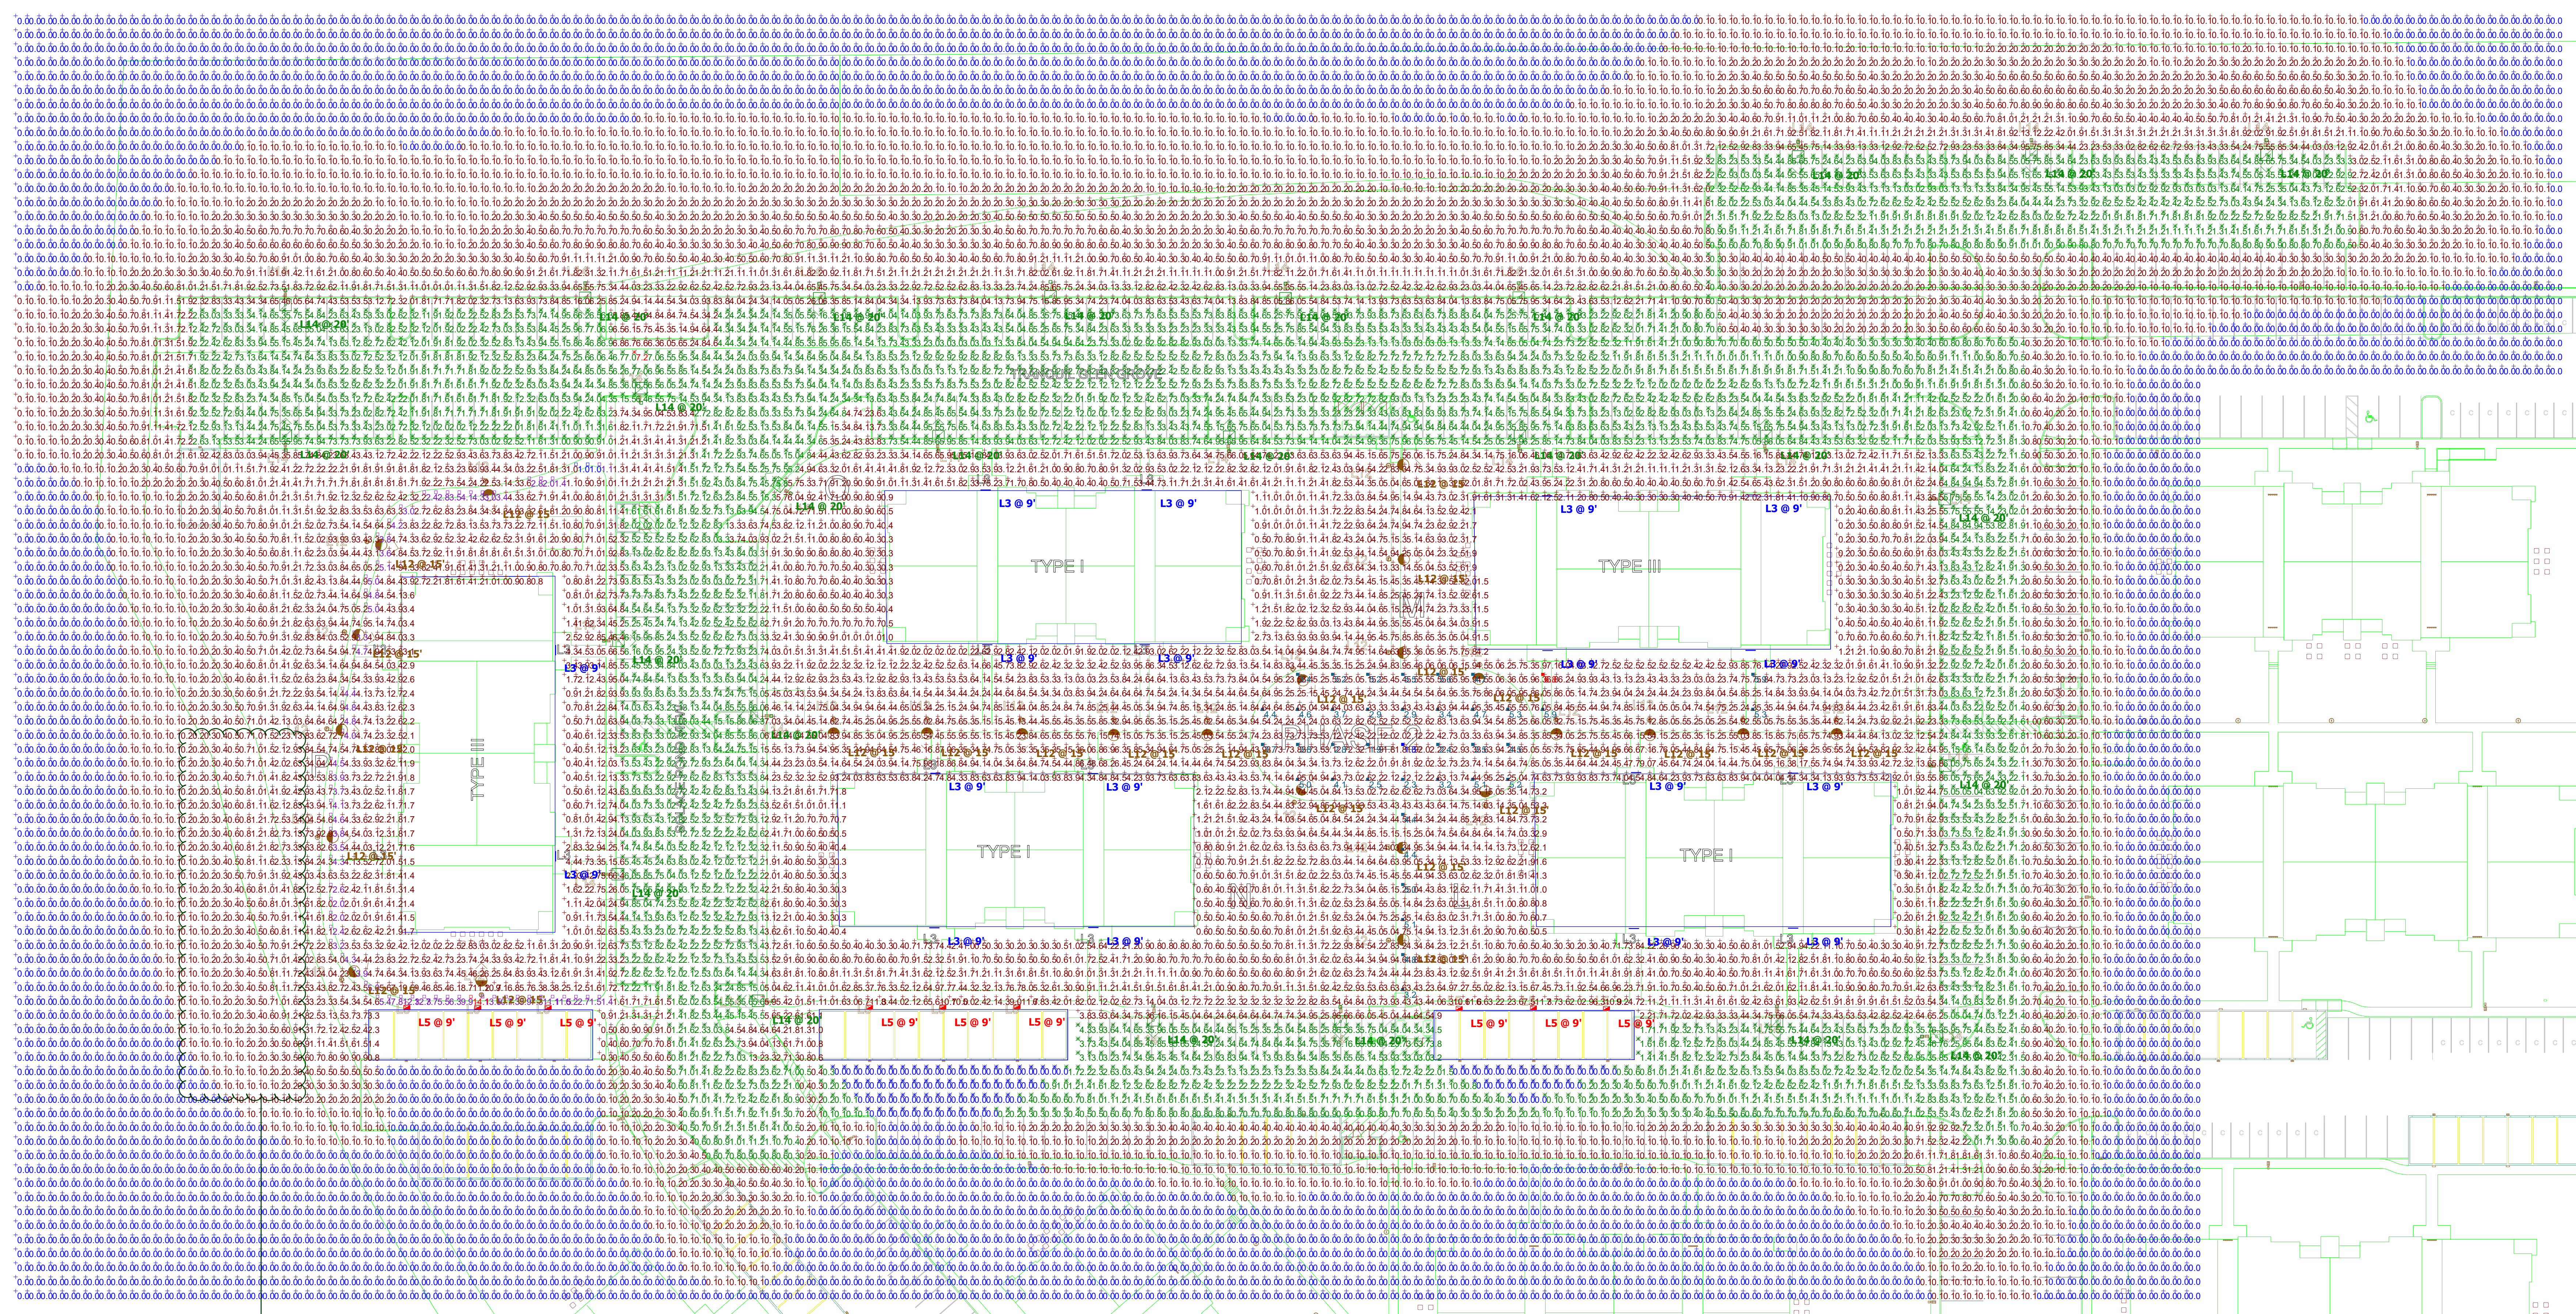

Light levels appear to be great in this area. Greater than 0.1 foot candles at property boundary.

Radean Post Top LED Area Luminaire

Specifications

- Height: 10' (3048mm)
- Width: 18" (457mm)
- Depth: 18" (457mm)
- Weight: 150 lbs (68kg)

Introduction

The architecturally inspired shape of the Radean Post Top area luminaire enhances the grace and strength of the Radean family. It has been expertly cast in aluminum, creating a beautiful architectural sculpture. A support bracket is included to allow the luminaire to be mounted to a variety of ceiling heights. Triangular mounting brackets are included to allow the luminaire to be mounted to a variety of ceiling heights. With sleek lines and simple installation, the Radean Post Top LED luminaire is the perfect choice for modern, urban, and corporate environments.

Ordering Information

Model	Height	Width	Depth	Weight	Material	Finish	Notes
RDPT18	10'	18"	18"	150 lbs	Aluminum	Black	Standard
RDPT18	10'	18"	18"	150 lbs	Aluminum	White	Standard

Radean Bollard LED Line Luminaire

Specifications

- Height: 6' (1829mm)
- Width: 4" (102mm)
- Depth: 4" (102mm)
- Weight: 15 lbs (6.8kg)

Introduction

The Radean Bollard is an award-winning luminaire that is perfect for the modern landscape. The Radean Bollard's elegant construction, standard finish and long-lasting LEDs provide a beautiful and functional lighting solution.

Ordering Information

Model	Height	Width	Depth	Weight	Material	Finish	Notes
RDBL6	6'	4"	4"	15 lbs	Aluminum	Black	Standard
RDBL6	6'	4"	4"	15 lbs	Aluminum	White	Standard

D-Series Size 1 LED Wall Luminaire

Specifications

- Height: 13.5" (343mm)
- Width: 13.5" (343mm)
- Depth: 13.5" (343mm)
- Weight: 13.5 lbs (6.1kg)

Introduction

The D-Series Wall Luminaire is a stylish, fully integrated LED luminaire for residential and commercial applications. It features a sleek, modern design and is available in a variety of finishes. The luminaire is designed to provide a wide range of lighting options, from ambient to task lighting. With an expected service life of over 25 years of nighttime use and up to 75% in energy savings, the D-Series Wall is a reliable, low-maintenance lighting solution that provides the perfect lighting for your space.

Ordering Information

Model	Height	Width	Depth	Weight	Material	Finish	Notes
DSW13	13.5"	13.5"	13.5"	13.5 lbs	Aluminum	Black	Standard
DSW13	13.5"	13.5"	13.5"	13.5 lbs	Aluminum	White	Standard

D-Series Size 1 LED Area Luminaire

Specifications

- Height: 13.5" (343mm)
- Width: 13.5" (343mm)
- Depth: 13.5" (343mm)
- Weight: 13.5 lbs (6.1kg)

Introduction

The D-Series Area Luminaire is a stylish, fully integrated LED luminaire for residential and commercial applications. It features a sleek, modern design and is available in a variety of finishes. The luminaire is designed to provide a wide range of lighting options, from ambient to task lighting. With an expected service life of over 25 years of nighttime use and up to 75% in energy savings, the D-Series Area is a reliable, low-maintenance lighting solution that provides the perfect lighting for your space.

Ordering Information

Model	Height	Width	Depth	Weight	Material	Finish	Notes
DSA13	13.5"	13.5"	13.5"	13.5 lbs	Aluminum	Black	Standard
DSA13	13.5"	13.5"	13.5"	13.5 lbs	Aluminum	White	Standard

Statistics

Description	Symbol	Avg	Max	Min	Max / Min	Avg / Min
Phase 2 Center Walkway	■	4.2 fc	6.8 fc	1.8 fc	3.8:1	2.3:1
Phase 2 Parking Area	✕	2.9 fc	7.2 fc	0.0 fc	N/A	N/A
Phase 2 West Walkway Summary	□	4.9 fc	14.1 fc	1.0 fc	14.1:1	4.9:1
Spill Light Summary	+	1.4 fc	14.1 fc	0.0 fc	N/A	N/A

- Note**
- Readings shown are based on a total LFL of as shown at grade. Data references the extrapolated performance projections in a 25c ambient based on 10,000 hrs of LED testing (per IESNA LM-80-08 and projected per IESNA TM-30).
 - Please refer to the "luminaire locations" for mounting heights.
 - Product information can be obtained at www.Lithonia.com or through your local agency.

Schedule

Symbol	Label	Quantity	Manufacturer	Catalog Number	Description	Number Lamps	Lumens Per Lamp	Light Loss Factor	Total Lamp Lumens	Wattage	Distribution
■	L3	18	Lithonia Lighting	FEM L48 3000LM LPAFL WD BCR31 35K	FEM LED 48", 3,000 lumens, acrylic, low profile frosted lens, wide distribution, 80 CR, 3500 K	1	2766	0.9	2766	18.05	DIRECT, SC-0-L21, SC-90-1-94
■	L5	9	Lithonia Lighting	WGE2 LED P3 40K BCR11 WV	WGE2 LED WITH P3 - PERFORMANCE PACKAGE: 4000K, BCR11, VISUAL COMFORT WIDE OPTIC	1	3213	0.95	3213	22.55	TYPE III, VERY SHORT, BUG RATING: B3 - U2 - G3
■	L12	25	Lithonia Lighting	RDAPT P4 40K 5YM	RADEAN Post-Top with P4 4000K Symmetric distribution	1	11606	0.91	11606	85.6782	TYPE VS, BUG RATING: B3 - U2 - G2
■	L14	26	Lithonia Lighting	DSX1 LED P6 40K T2M MVOLT	DSX1 LED P6 40K T2M MVOLT	1	18997	0.92	18997	163	TYPE III, MEDIUM, BUG RATING: B3 - U0 - G3

Note

This architectural lighting submission is provided only for informational purposes and to help the customer or end-user (as applicable) understand how various sections of linear fixtures connect to each other and how they mount to the ceiling. This lighting submission is strictly based on the information provided to Acuity Brands, and is provided without warranty as to accuracy, completeness, reliability, or otherwise. If the information (including but not limited to floor-plans, reflected ceiling plans, and specifications) provided to Acuity Brands is incomplete or not current (i.e., newer versions exist), the accuracy of proposed design may be adversely affected. Once this lighting submission is received by the customer or end-user (as applicable), it is the obligation of the customer or end-user (as applicable) to consult with a professional engineering advisor to determine whether the proposed design meets the applicable project requirements for lighting system performance, code compliance, safety, suitability and effectiveness for use in a particular application. In no event will Acuity Brands be responsible for any loss resulting from any use of any information contained in this lighting submission.