


NO.	DATE	DESIGN	DWYN	REVISION DESCRIPTION

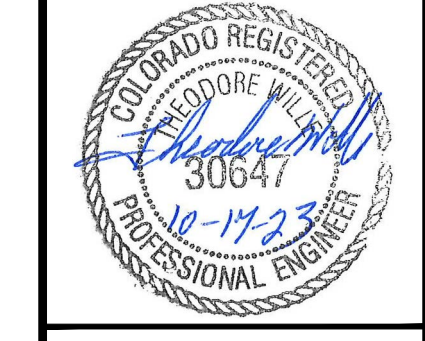

DESIGNED BY: TRW  
 DRAWN BY: TRW  
 CHECKED BY: TFW  
 JOB #: 1164.1e  
 DATE: OCT 2023






© JVA, INC.

ELLICOTT CHLORINATOR UPGRADES  
 CHEROKEE METROPOLITAN DISTRICT  
 EL PASO COUNTY, COLORADO

PHOTOMETRIC STUDY

SHEET NO.  
**E1.5**

LIGHTING FIXTURE SCHEDULE				
SYMBOL	LAMP	MTG HEIGHT	DESCRIPTION	MANUFACTURER
W1	LED, 120V	1 FT. ABOVE DOOR OR 10 FT ABOVE GRADE	DIECAST ALUMINUM FOR RUGGED MOUNTING AND HEAT DISSIPATION, SPECULAR REFLECTOR, VERTICAL LAMP AND REFRACTOR WITH PHOTOELECTRIC CONTROL	LSI: WLS LED 3L UNV DIM 40 BLK PC120

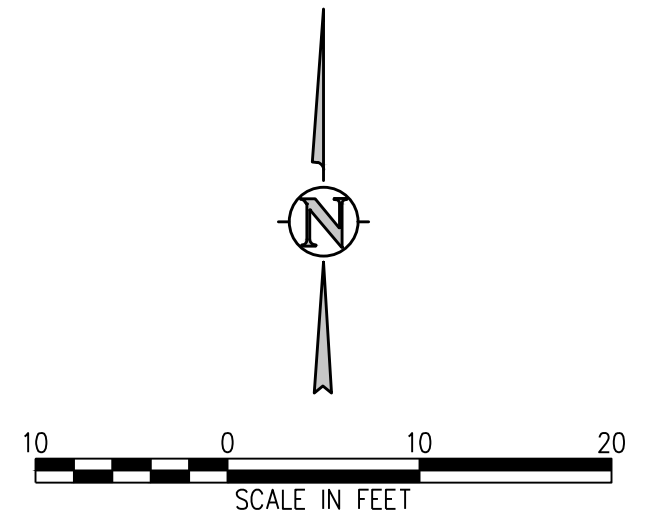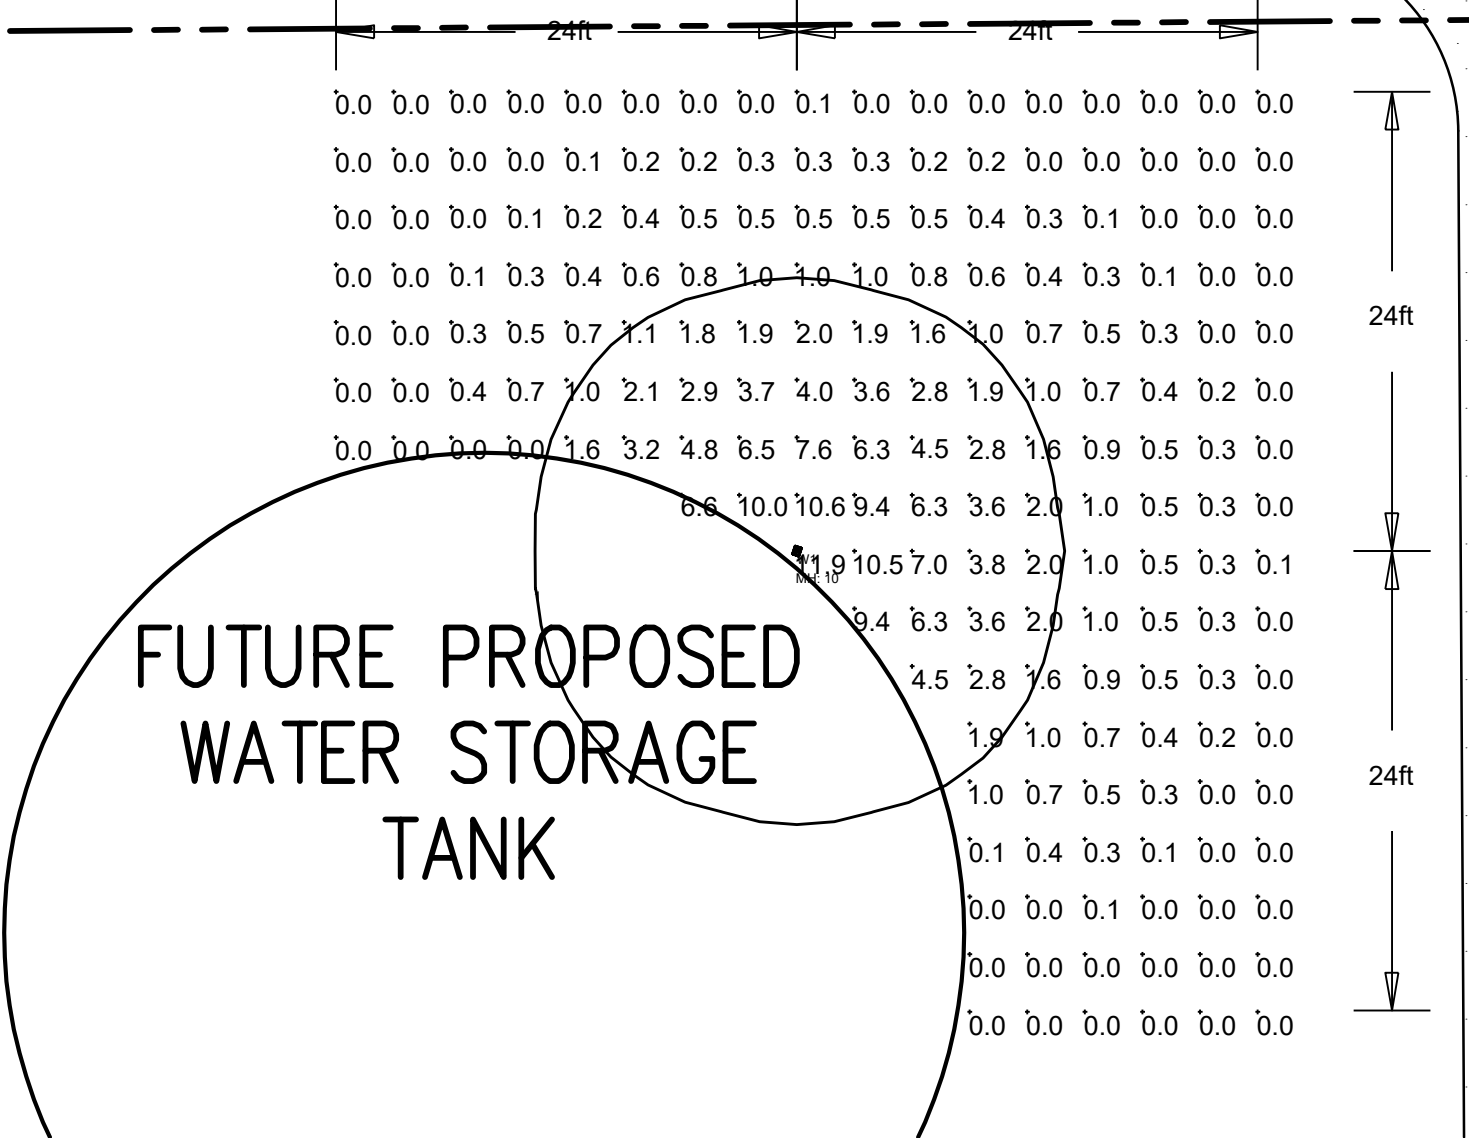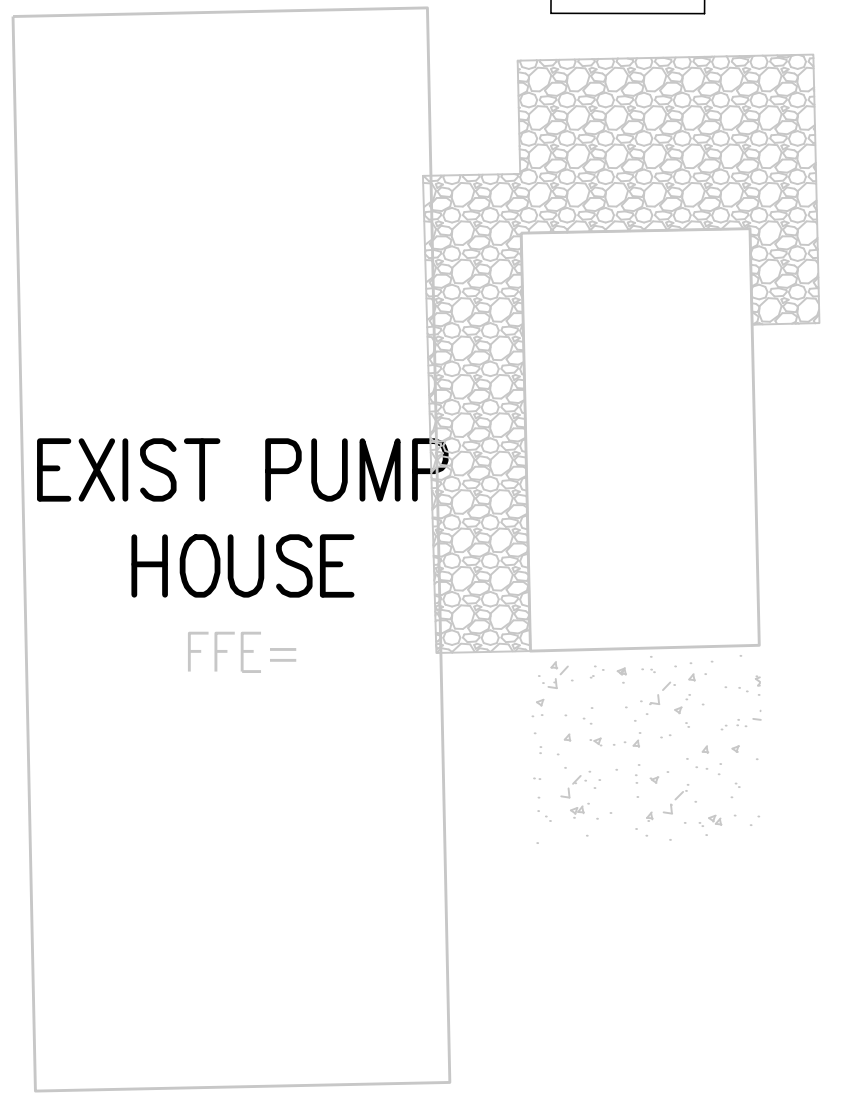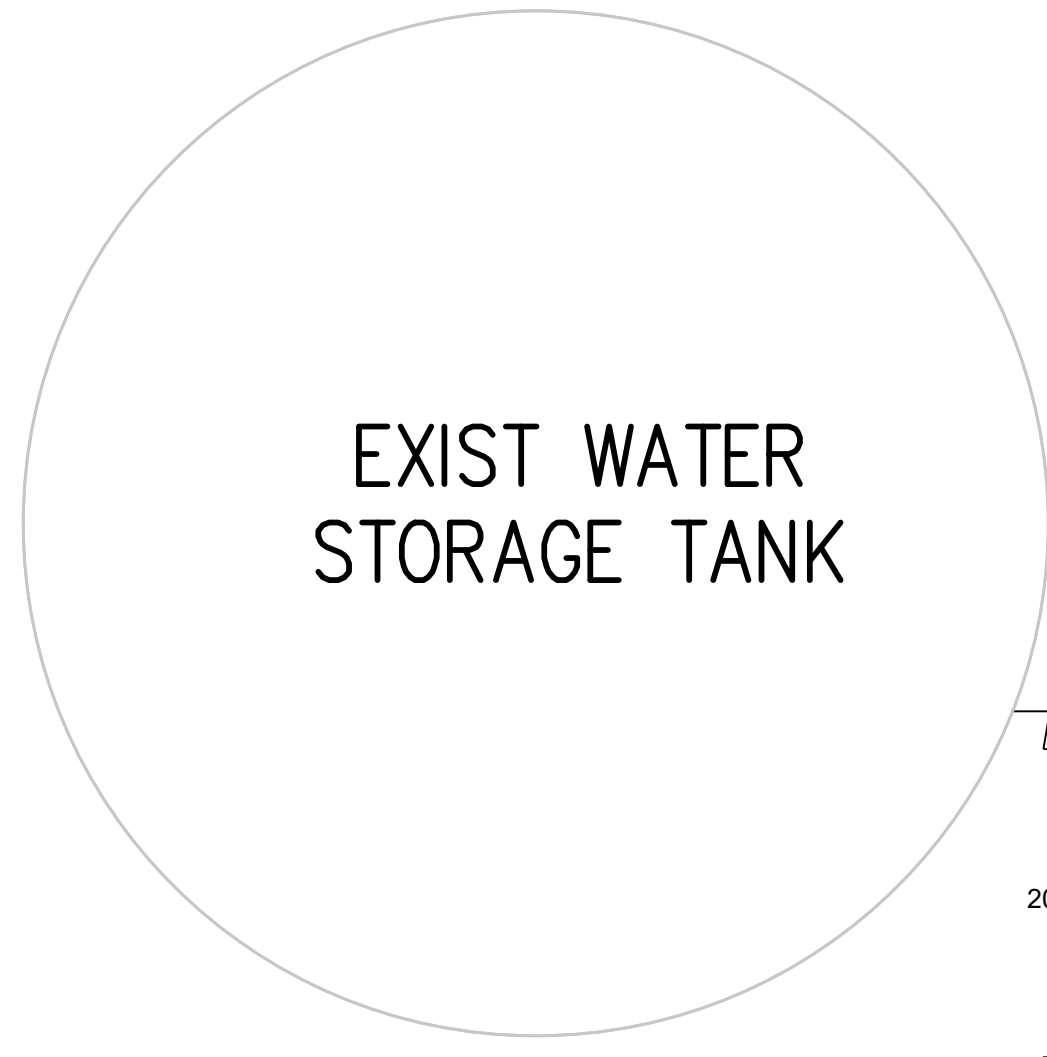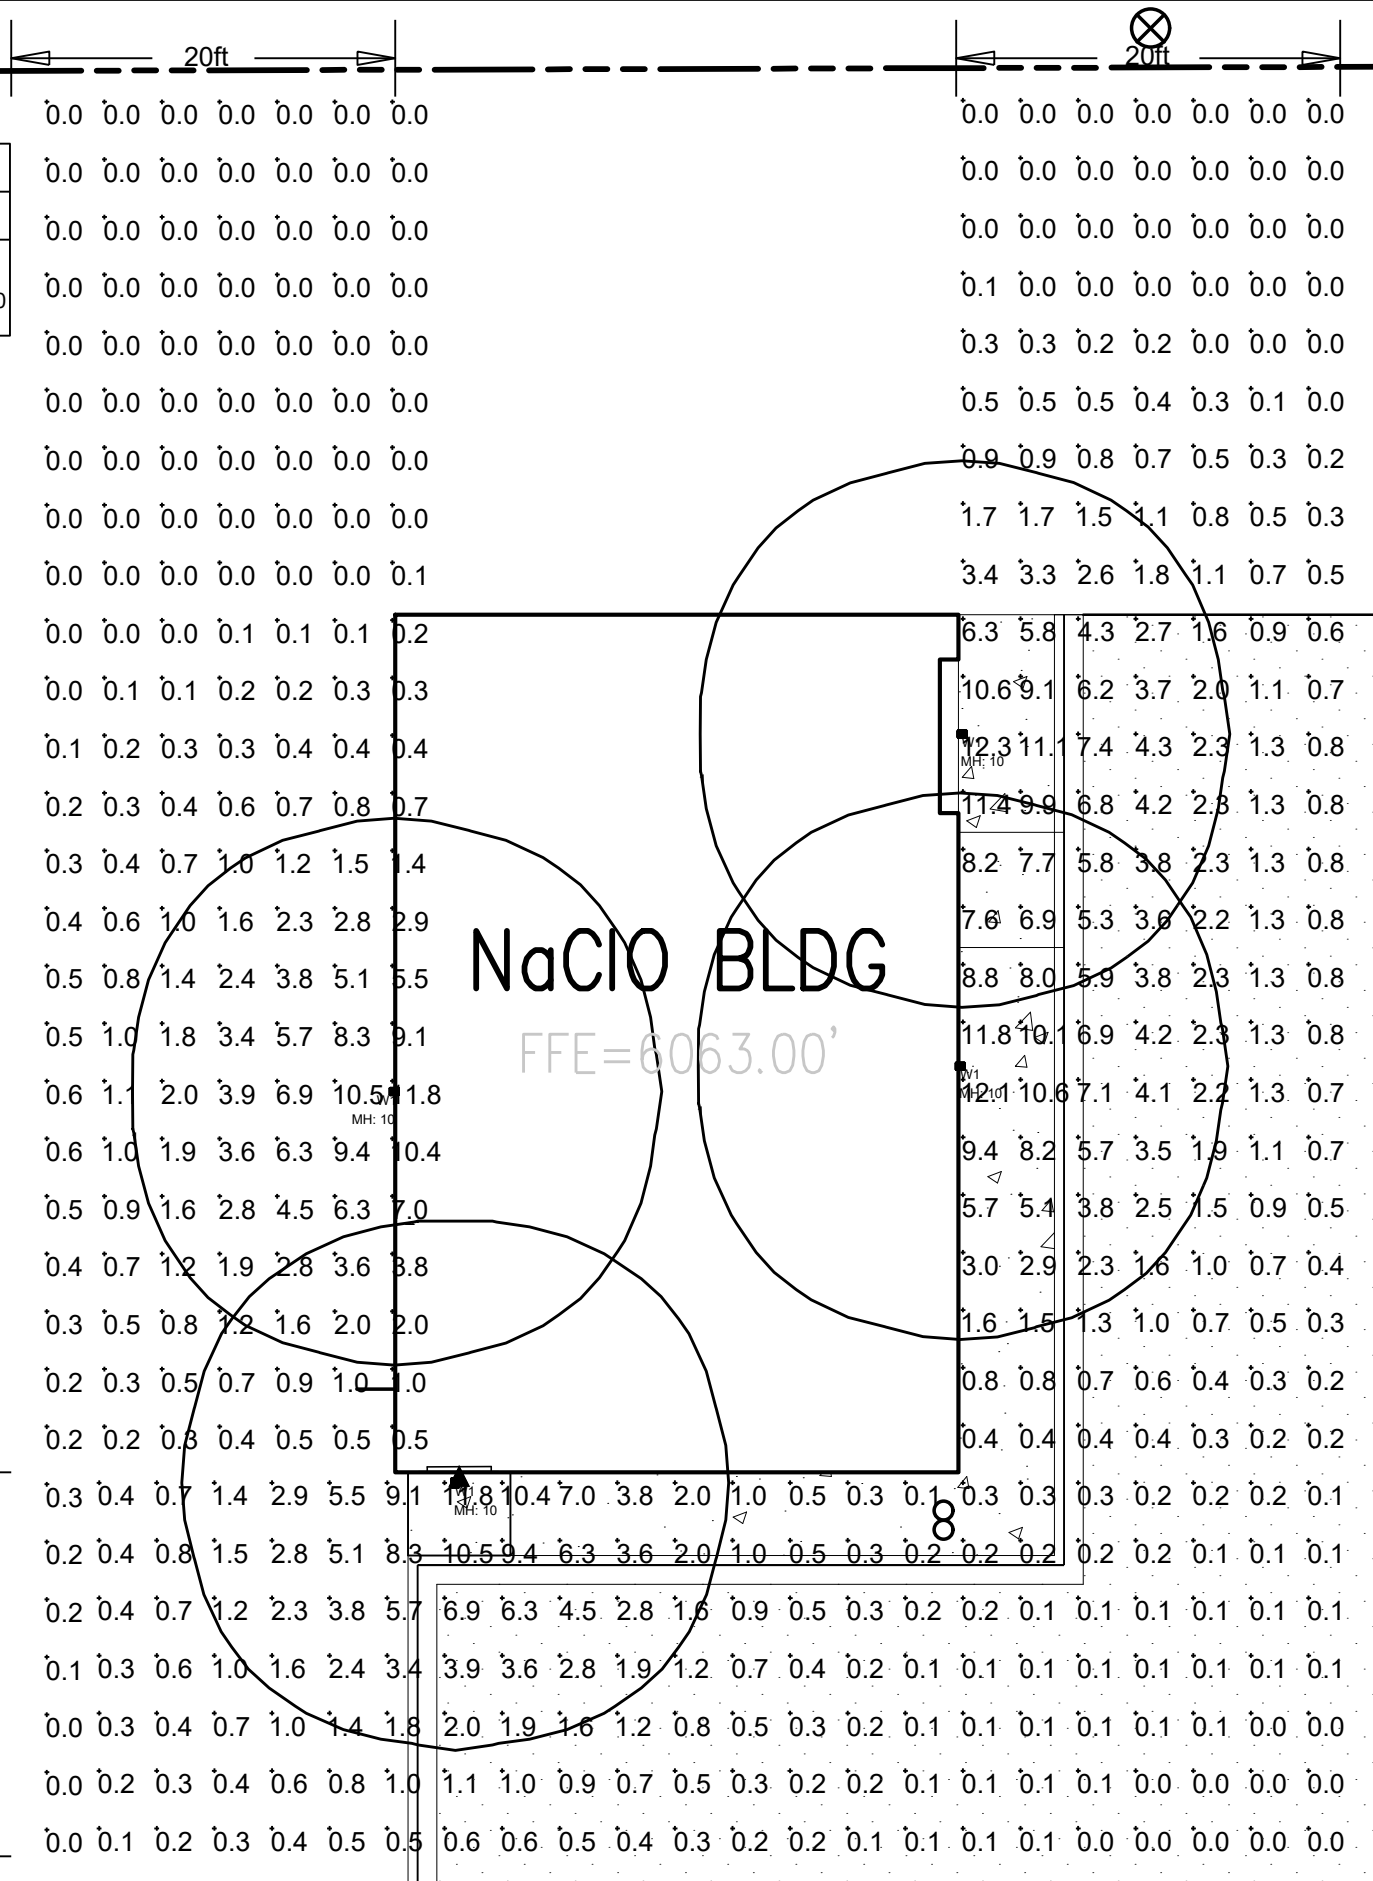

TRACT B