


C:\Users\CareForrest\OneDrive\Documents\Projects\1924 - Northcrest Center\Drawings\MEP\Northcrest Center - Site Photometric.dwg, 8/5/2021 9:57:00 AM, AutoCAD PDF (General Documentation).pc3

LIGHT FIXTURE SCHEDULE							
MARK	MANUF.	MODEL	LAMP		MOUNTING	DESCRIPTION	VOLTAGE
			QTY.	WATT			
P1	LITHONIA	DSX1 LED P1 50K T5S MVOLT	2	54.0	LED	POLE @ 20'-0"	AREA LUMINAIRE
P2	LITHONIA	DSX1 LED P1 50K T5S MVOLT HS	1	54.0	LED	POLE @ 20'-0"	AREA LUMINAIRE
P3	LITHONIA	DSX1 LED P1 50K T4M MVOLT HS	1	54.0	LED	POLE @ 20'-0"	AREA LUMINAIRE
P4	LITHONIA	DSX1 LED P1 50K LCCO MVOLT	1	54.0	LED	POLE @ 20'-0"	AREA LUMINAIRE
WP1	LITHONIA	WDGE1 LED P1 50K 80CRI VF	1	10.0	LED	SURFACE	WALLPACK
WP2	LITHONIA	WDGE1 LED P2 50K 80CRI VF	1	15.0	LED	SURFACE	WALLPACK
WP3	LITHONIA	WDGE1 LED P1 40K 90CRI VW	1	10.0	LED	SURFACE	WALLPACK
							TOTAL WATTS
							108.0

CALCULATION ZONE STATISTICS						
DESCRIPTION	SYMBOL (fc)	AVERAGE (fc)	MAXIMUM (fc)	MINIMUM (fc)	MAX./MIN. (fc)	AVG./MIN. (fc)
PARKING LOT	+	1.8	3.9	0.2	19.5:1	9.0:1
STORAGE YARD	+	2.6	6.3	0.4	15.8:1	6.5:1
TO PROPERTY LINE	+	0.5	4.5	0.0	N/A	N/A

PROPERTY
BOUNDARY

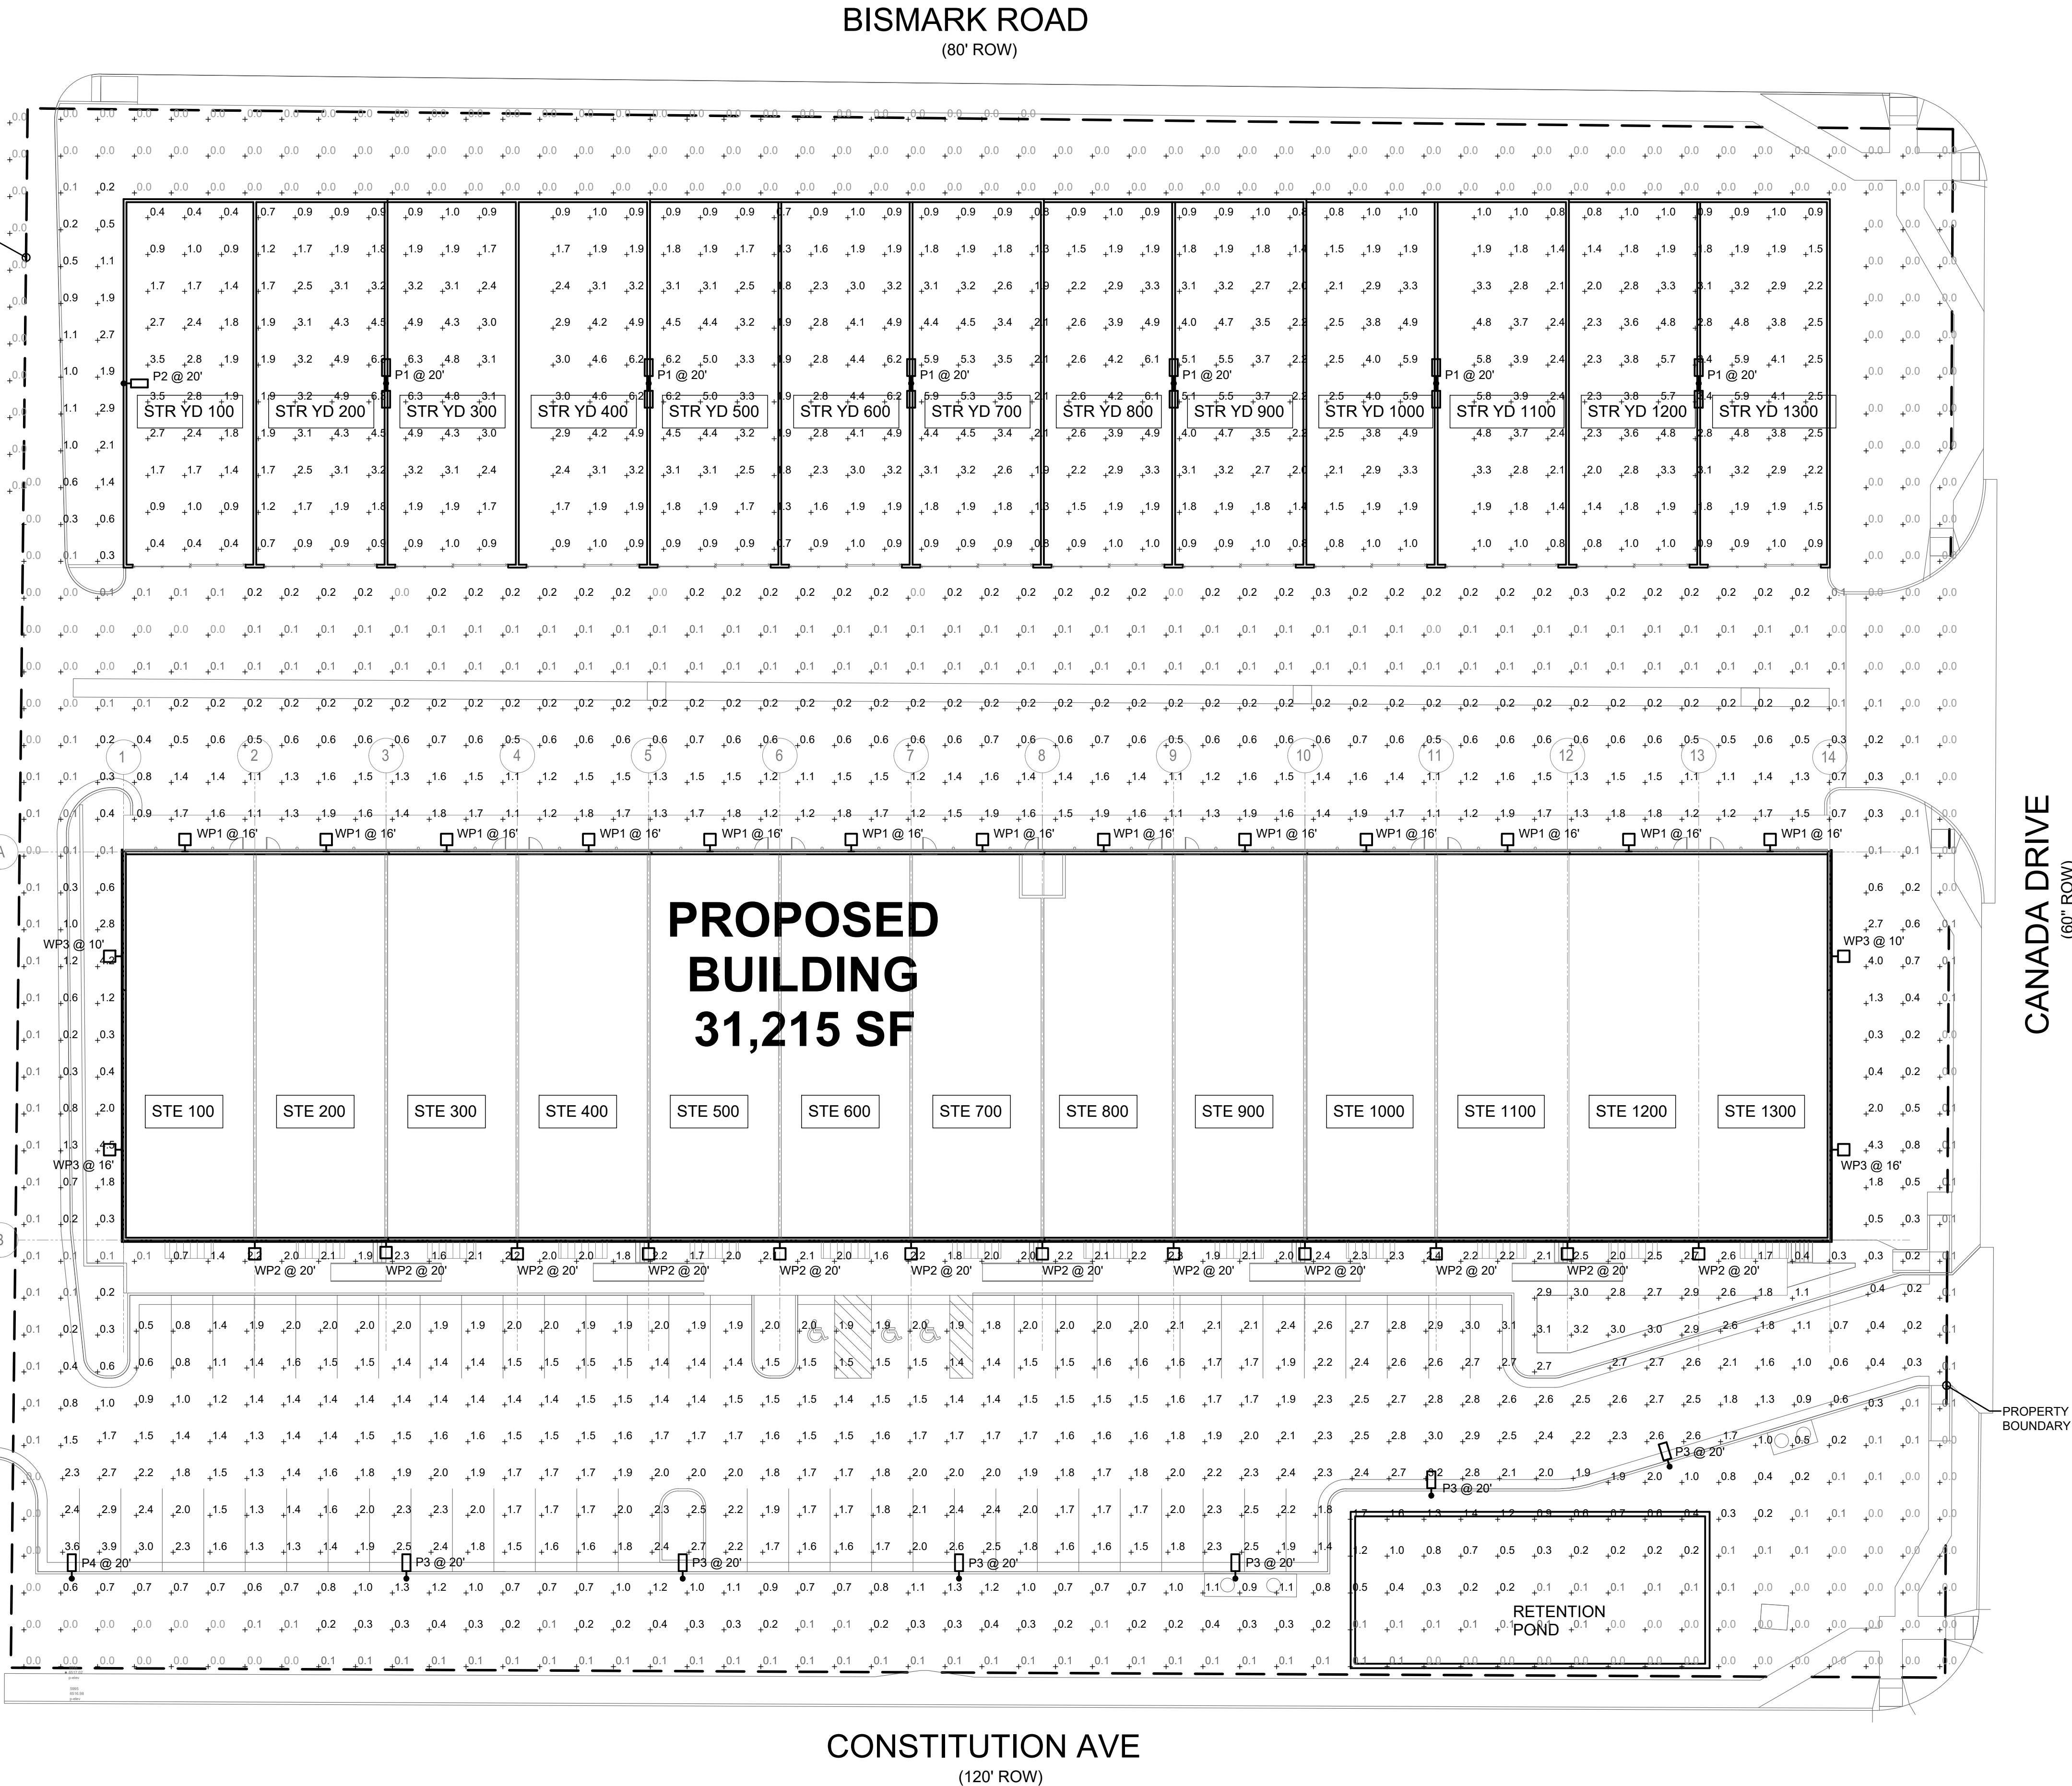


3 WDGE1 WALLPACK (WP1 - WP3)
DP.12 SCALE: NONE



2 DSX1 AREA LUMINAIRE (P1 - P4)
DP.12 SCALE: NONE

1 SITE PHOTOMETRIC PLAN
DP.12 SCALE: 1"=20'-0"

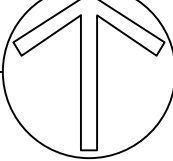

ROCKY MOUNTAIN GROUP

ARCHITECTS
RMG
ENGINEERS

Architectural
Mechanical
Civil/Planning
Forensics

SOUTHERN COLORADO
1975 BEAD 2145 - WWW.RMGENGINEERS.COM
171948B-2145 - 171948B-2145 - 171948B-2145 - 171948B-2145
SOUTHERN COLORADO, DENVER METRO, NORTHERN COLORADO

COLORADO REGISTERED
PROFESSIONAL ENGINEER
08.05.2021

McShea
Consulting, LLC

MECHANICAL + ELECTRICAL + PLUMBING
4445 Northpark Dr., Suite 200
Colorado Springs, CO 80907
mcsheacconsulting.com
Project: 21-11024

NORTHCREST CENTER

CONSTITUTION AVE., COLORADO SPRINGS, CO

LEISURE CONSTRUCTION

SHEET NAME
SITE PHOTOMETRIC PLAN

PROJECT STATUS
DEVELOPMENT PLANS

ARCHING: -
DRAWN: CCF
CHECKED: MRM

DATE
08.05.2021

REVISION
DATE

JOB NO.
180649

SHEET NO.
DP.12

LITHONIA LIGHTING COMMERCIAL OUTDOOR One Lithonia Way • Conyers, Georgia 30012 • Phone: 1-800-705-SERV (7378) • www.lithonia.com W001E1 LED
© 2015-2021 Acuity Brands Lighting, Inc. All rights reserved. Rev 03/17/21

 **LITHONIA
LIGHTING** One Lithonia Way • Conyers, Georgia 30012 • Phone: 1-800-705-SERV (7378) • www.lithonia.com © 2011-2021 Acuity Brands Lighting, Inc. All rights reserved.

works

e plan
best

§

TO	ME
----	----