
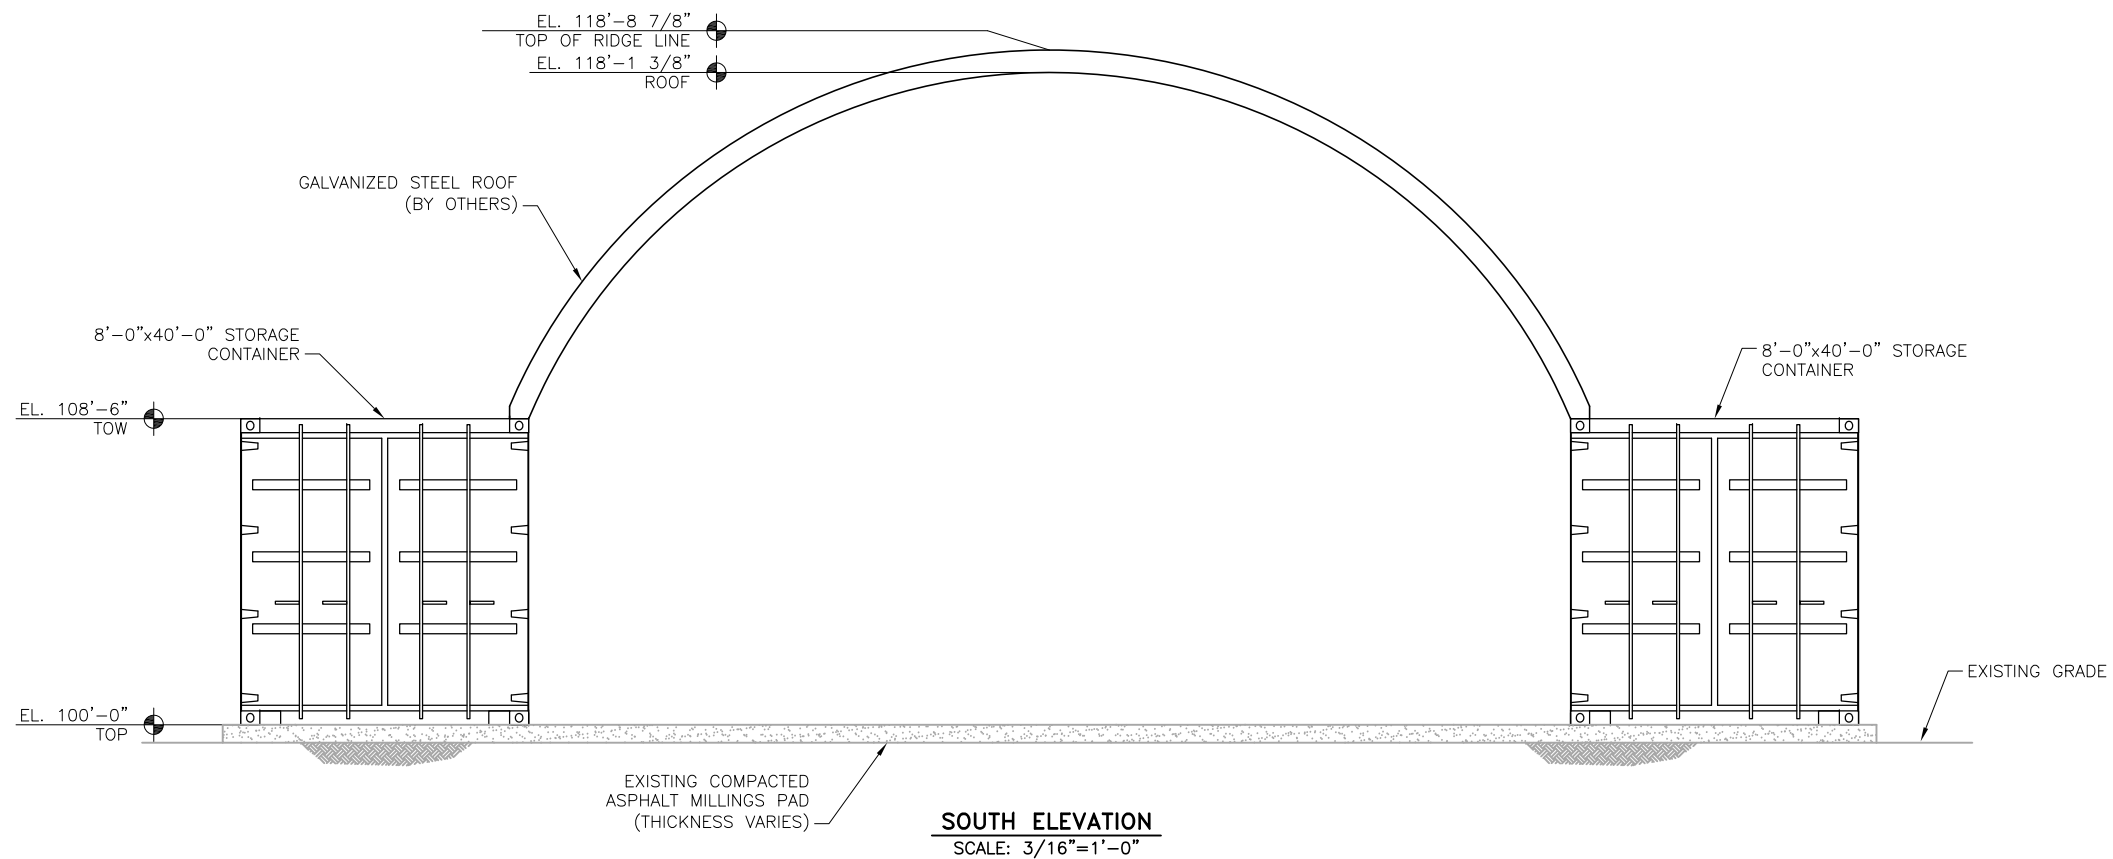


2020/10/23 1:42 PM By: Andrew Hood J:\JDS-Hydro\Project Files\151 Meridian Service Metropolitan District\151.46 Water Ops Facility Permitting\Drawings\Working\EPC\15146_Arch_EPC.dwg

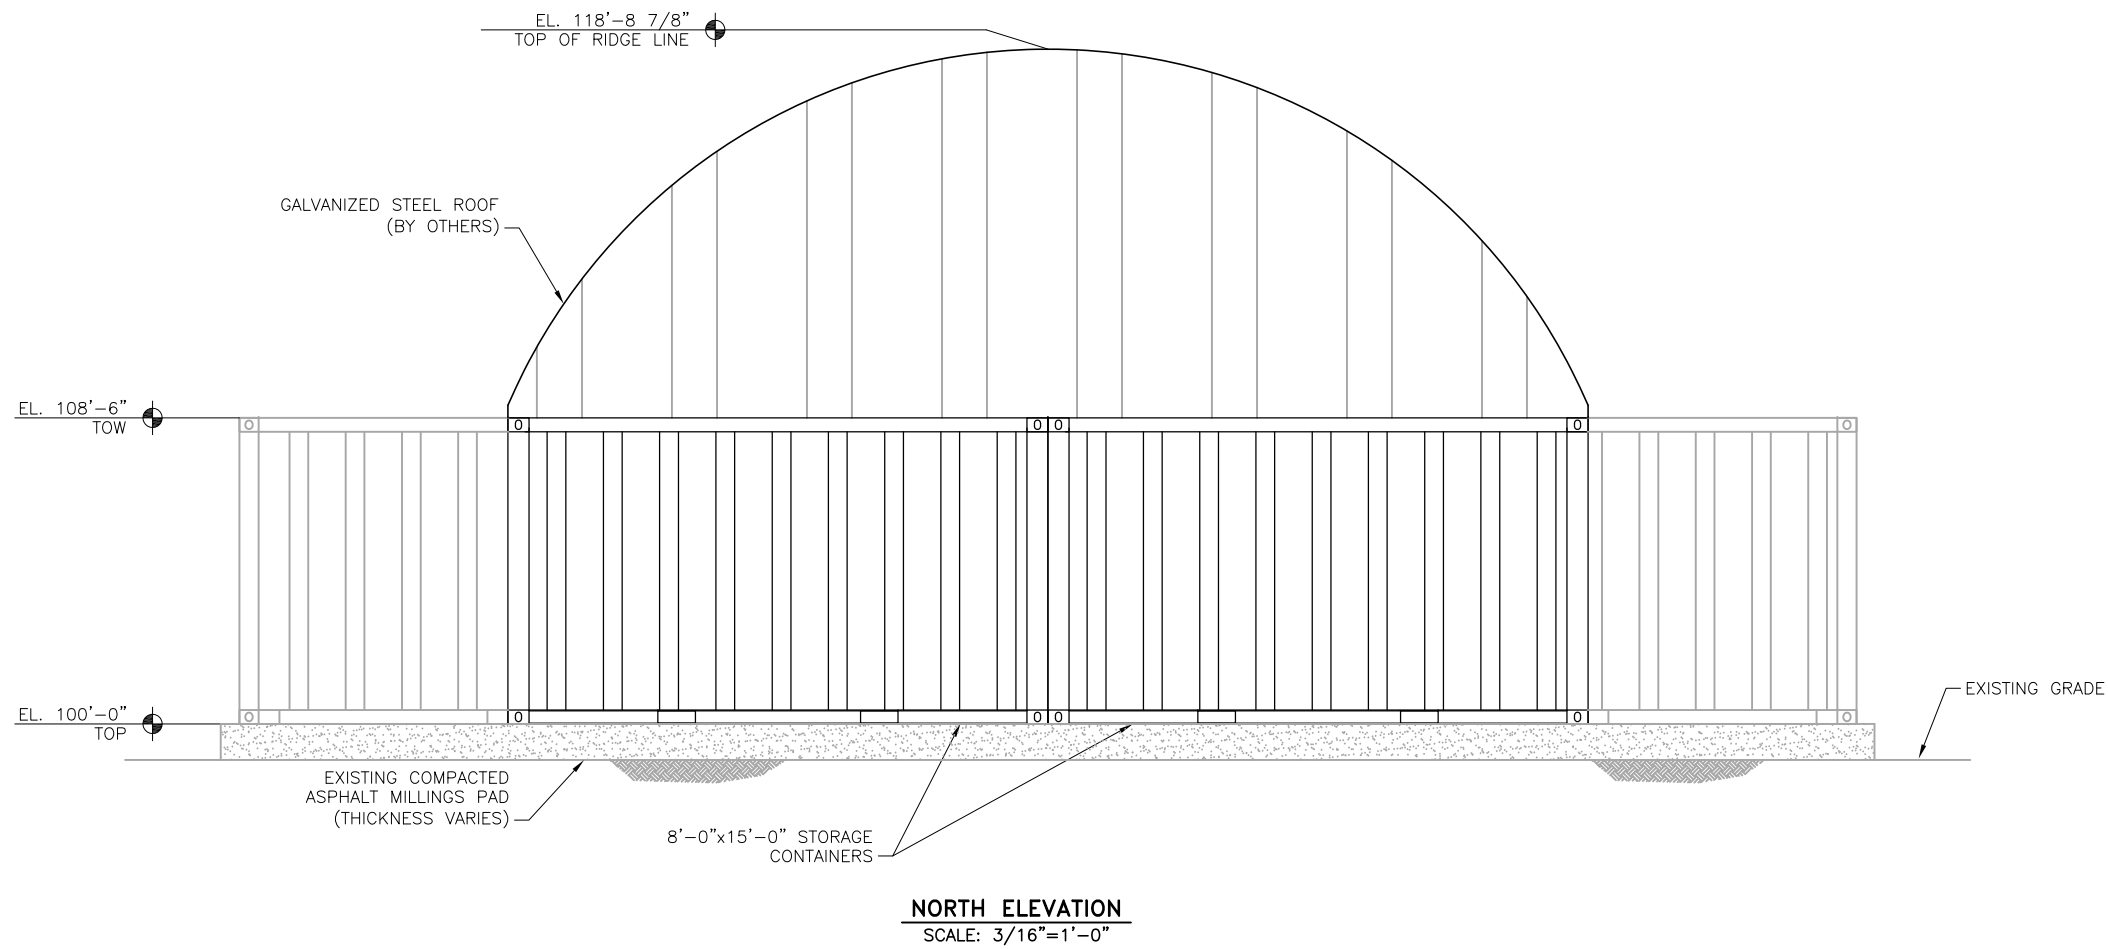

JDS-HYDRO CONSULTANTS, INC.
5540 TECH CENTER DR., SUITE 100
COLORADO SPRINGS, COLORADO 80919
(719) 227-0072

DISCLAIMER: THE CONTRACTOR SHALL VERIFY ALL DIMENSIONS. ANY ERRORS OR OMISSIONS SHALL BE REPORTED TO JDS-HYDRO CONSULTANTS, INC. JDS-HYDRO ASSUMES NO LIABILITY FOR UNAUTHORIZED CHANGES AND/OR REVISIONS MADE TO PLANS.

MERIDIAN SERVICE METROPOLITAN DISTRICT
TANK SITE IMPROVEMENTS – INTERIM STORAGE AREA
ARCHITECTURAL ELEVATIONS
NORTH & SOUTH


| NO. | DESCRIPTION | BY | APP. | DATE |
|-----|-------------|----|------|------|
| 1 | | | | |
| 2 | | | | |
| 3 | | | | |
| 4 | | | | |
| 5 | | | | |
| 6 | | | | |
| 7 | | | | |

FOR REVIEW


Project No.: 151.46
Date: 10/23/20
Design: GGM
Drawn: ACH
Check: DES

A3
SHEET 4 OF 5

2020/10/23 1:42 PM By: Andrew Hood J:\JDS-Hydro\Project Files\151 Meridian Service Metropolitan District\151.46 Water Ops Facility Permitting\Drawings\Working\EPIC\15146_Arch_EPIC.dwg

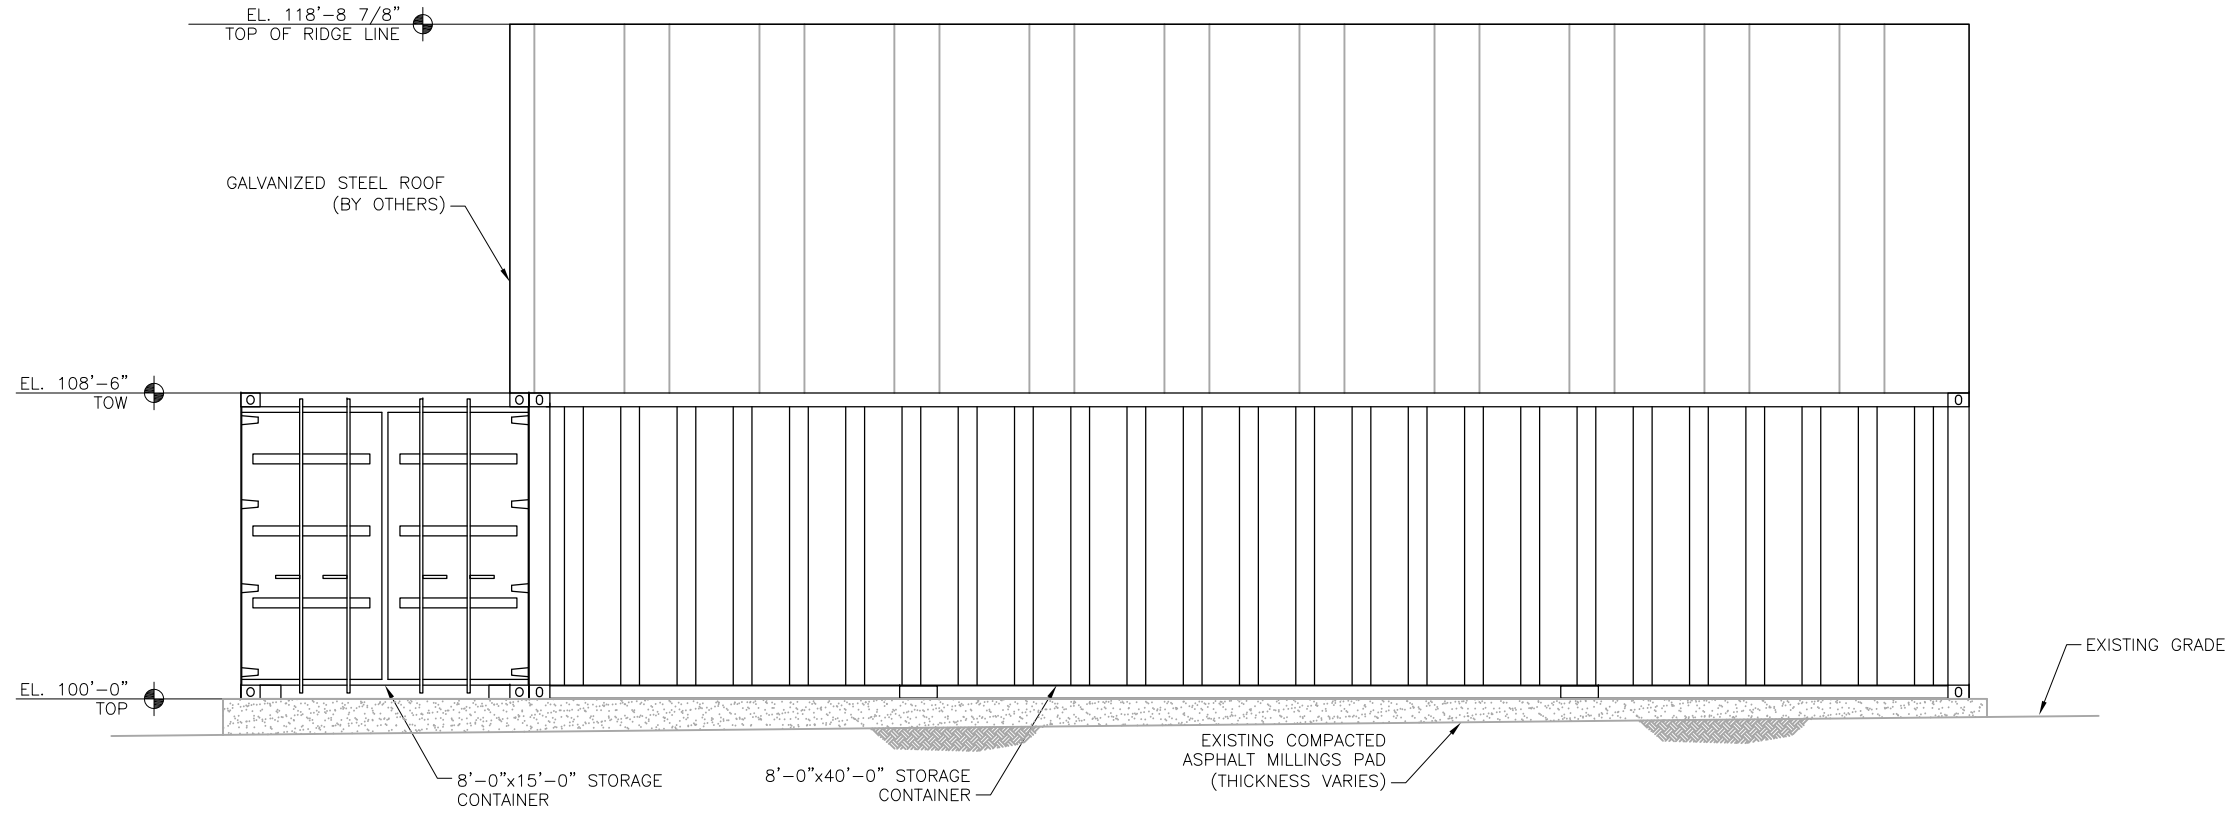

WEST ELEVATION
SCALE: 3/16"=1'-0"

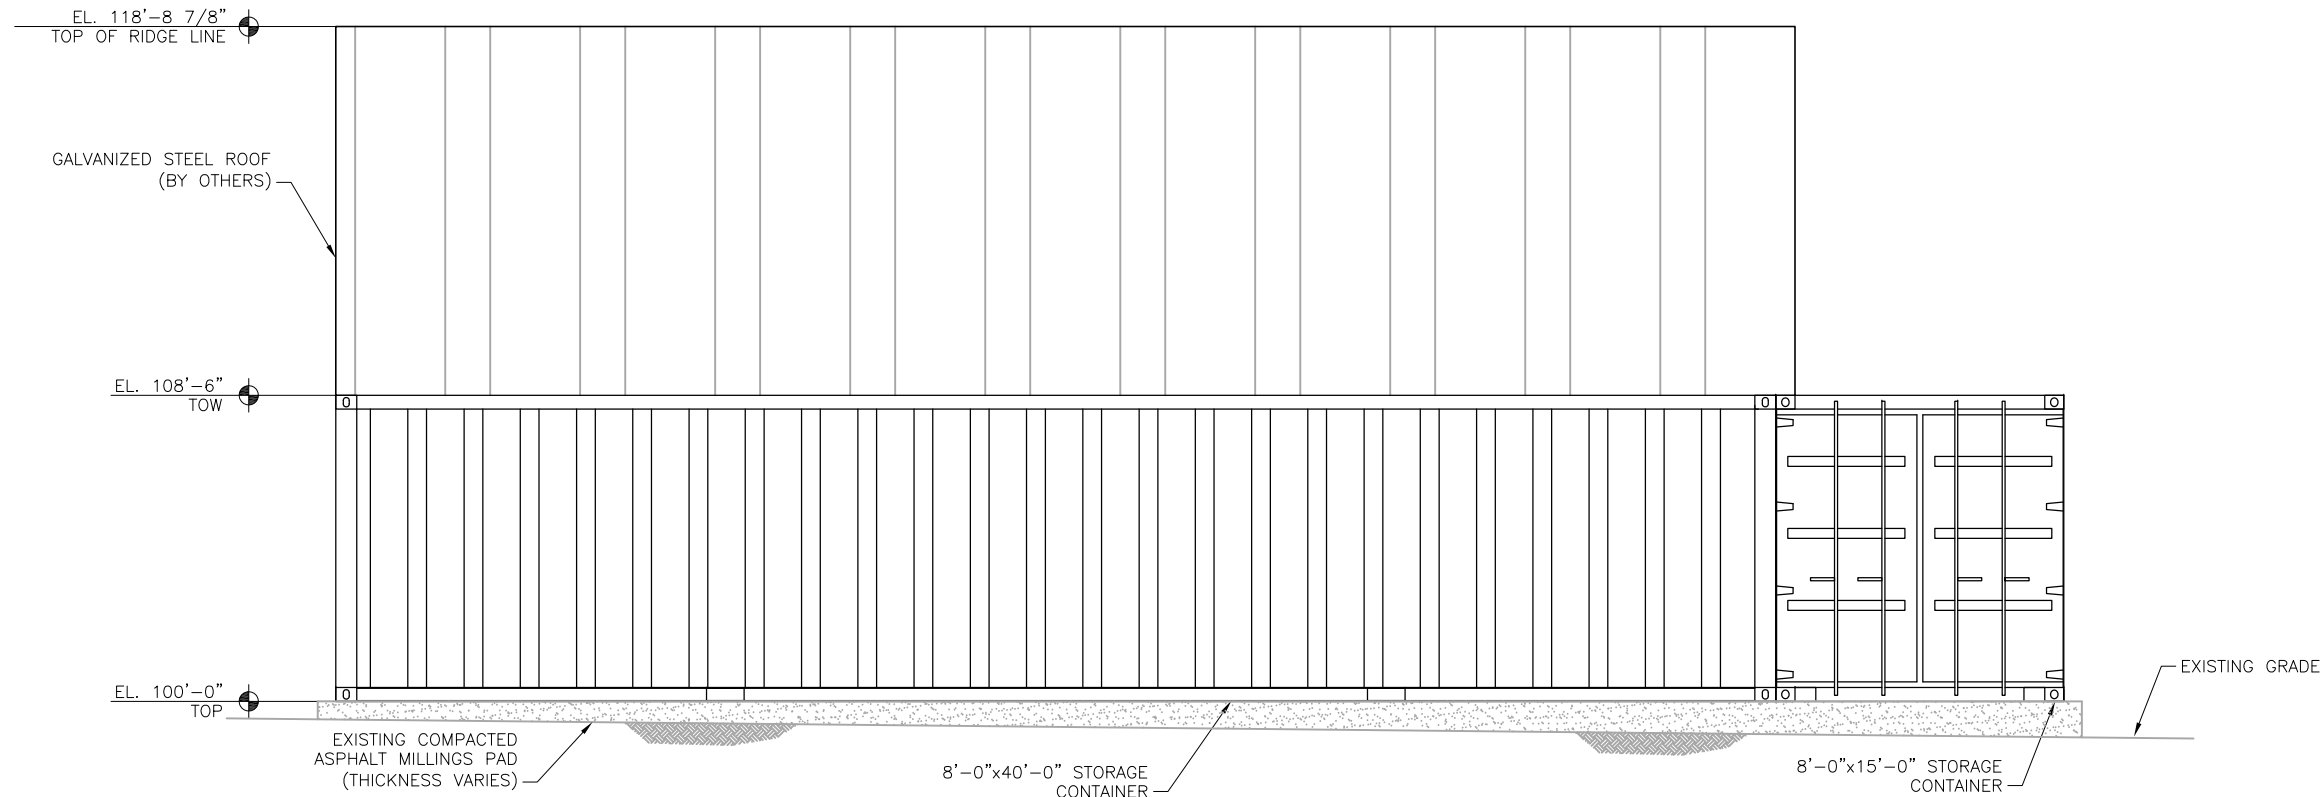

EAST ELEVATION
SCALE: 3/16"=1'-0"

JDS-HYDRO CONSULTANTS, INC.
5540 TECH CENTER DR., SUITE 100
COLORADO SPRINGS, COLORADO 80919
(719) 227-0072
DISCLAIMER: THE CONTRACTOR SHALL VERIFY ALL DIMENSIONS. ANY ERRORS OR OMISSIONS SHALL BE REPORTED TO JDS-HYDRO CONSULTANTS, INC. JDS-HYDRO ASSUMES NO LIABILITY FOR UNAUTHORIZED CHANGES AND/OR REVISIONS MADE TO PLANS.

MERIDIAN SERVICE METROPOLITAN DISTRICT
TANK SITE IMPROVEMENTS - INTERIM STORAGE AREA
ARCHITECTURAL ELEVATIONS
WEST & EAST

| NO. | DESCRIPTION | BY | APP. | DATE |
|-----|-------------|----|------|------|
| 1 | | | | |
| 2 | | | | |
| 3 | | | | |
| 4 | | | | |
| 5 | | | | |
| 6 | | | | |
| 7 | | | | |

FOR REVIEW

Project No.: 151.46
Date: 10/23/20
Design: GGM
Drawn: ACH
Check: DES