


NOTES:

1. WATER, SEWER AND GAS MAINS TO BE "BY OTHERS".
2. THIS CONTRACT TO BE RESPONSIBLE FOR PROVIDING WATER, SEWER AND GAS SERVICES FROM BUILDING AND CONNECT TO UTILITIES STUB-OUTS ON MAINS.
3. ALL CURB ALONG DRIVES AND PARKING AREAS TO BE COLORADO SPRINGS STANDARD MEDIAN CURB- 6" CURB AND 1' GUTTER.
4. ALL WORK IN OLD MERIDIAN ROAD IS CURRENTLY UNDER CONSTRUCTION BY EL PASO COUNTY CONTRACTOR.


CALL BEFORE YOU DIG ...

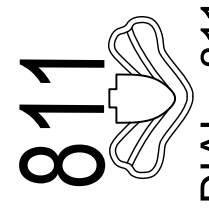

48 HOURS BEFORE YOU DIG, CALL UTILITY LOCATORS FOR LOCATING AIRCRAFT, WATER AND WASTEWATER

REVISIONS	
No.	Description

H Scale:	1" = 30'
V Scale:	N/A
Designed By:	BRH
Drawn By:	DLK
Checked By:	
Date:	12/24/19

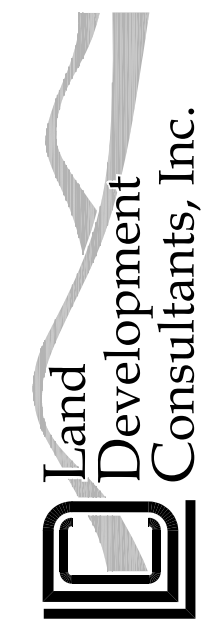

PLANNING · SURVEYING  
www.ldc-inc.com TEL (719) 528-6133 FAX (719) 528-6646  
3888 MAZELAND ROAD · COLORADO SPRINGS, CO 80909

FALCON FIRE  
PROTECTION DISTRICT  
NEW STATION SITE PLAN  
FALCON, COLORADO

Project No.: 20005  
Sheet: 1 of 1