


2023/03/29 10:55 AM By: Shelby Heule N:\Projects\W02242.22002-FAWWA Sterling Ranch WTP\Drawings\Working\4_Architectural\W02242.22002_Arch.dwg IF BAR DOES NOT MEASURE ONE INCH, SCALE OF THIS DRAWING HAS BEEN ALTERED 1"

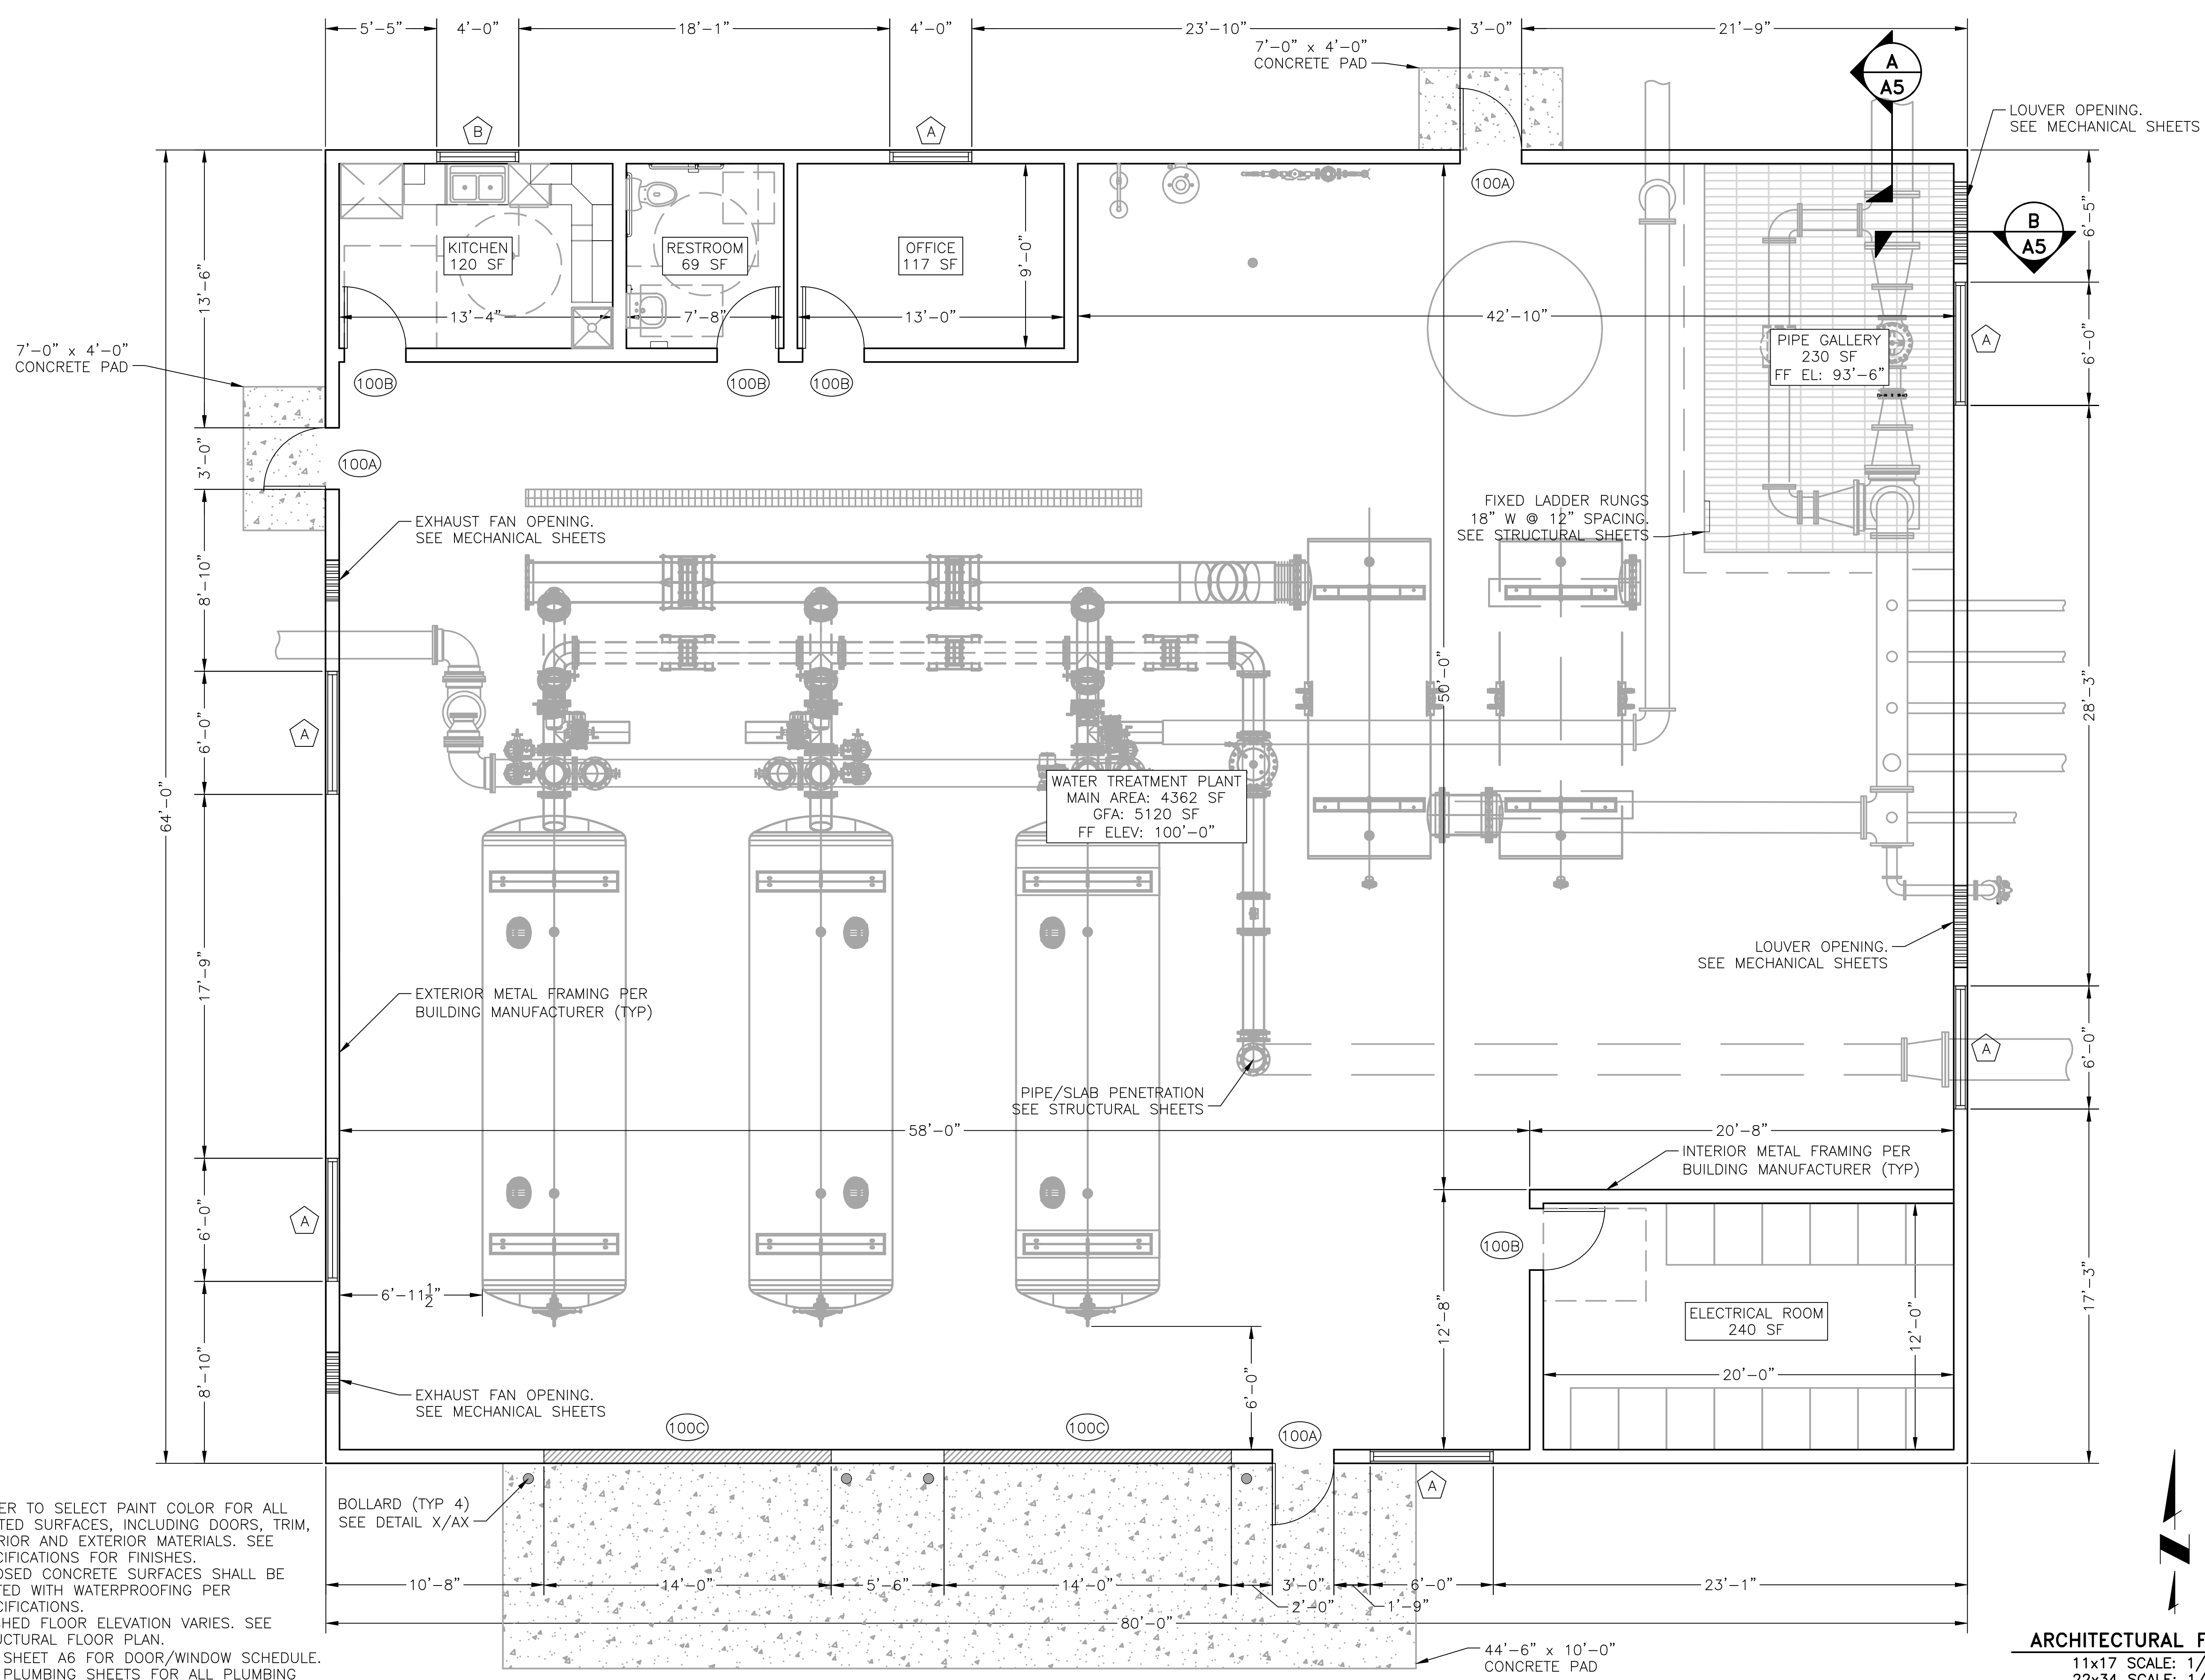

- NOTES:**
- OWNER TO SELECT PAINT COLOR FOR ALL PAINTED SURFACES, INCLUDING DOORS, TRIM, INTERIOR AND EXTERIOR MATERIALS. SEE SPECIFICATIONS FOR FINISHES.
 - EXPOSED CONCRETE SURFACES SHALL BE COATED WITH WATERPROOFING PER SPECIFICATIONS.
 - FINISHED FLOOR ELEVATION VARIES. SEE STRUCTURAL FLOOR PLAN.
 - SEE SHEET A6 FOR DOOR/WINDOW SCHEDULE.
 - SEE PLUMBING SHEETS FOR ALL PLUMBING FIXTURES.

BOLLARD (TYP 4)
SEE DETAIL X/AX

ARCHITECTURAL FLOOR PLAN
 11x17 SCALE: 1/8"=1'-0"
 22x34 SCALE: 1/4"=1'-0"

Colorado Springs, CO
 5540 Tech Center Dr., Suite 100
 Colorado Springs, CO 80919
 Phone: 719.227.0072
 www.respec.com

FALCON AREA WATER & WASTEWATER AUTHORITY
 STERLING RANCH WATER TREATMENT PLANT
 ARCHITECTURAL FLOOR PLAN

NO.	DESCRIPTION	BY	APP.	DATE
1				
2				
3				
4				
5				
6				
7				

FOR REVIEW


Proj.#: W02242.22
 Date: 03/29/23
 Design: GGM
 Drawn: GGM
 Check: JPM

A1

SHEET --- OF ---

2023/03/29 10:55 AM By: Shelby Heule N:\Projects\W02242.22002-FAWMA Sterling Ranch WTP\Drawings\Working\4_Architectural\W02242.22002_Arch.dwg

IF BAR DOES NOT MEASURE ONE INCH, SCALE OF THIS DRAWING HAS BEEN ALTERED

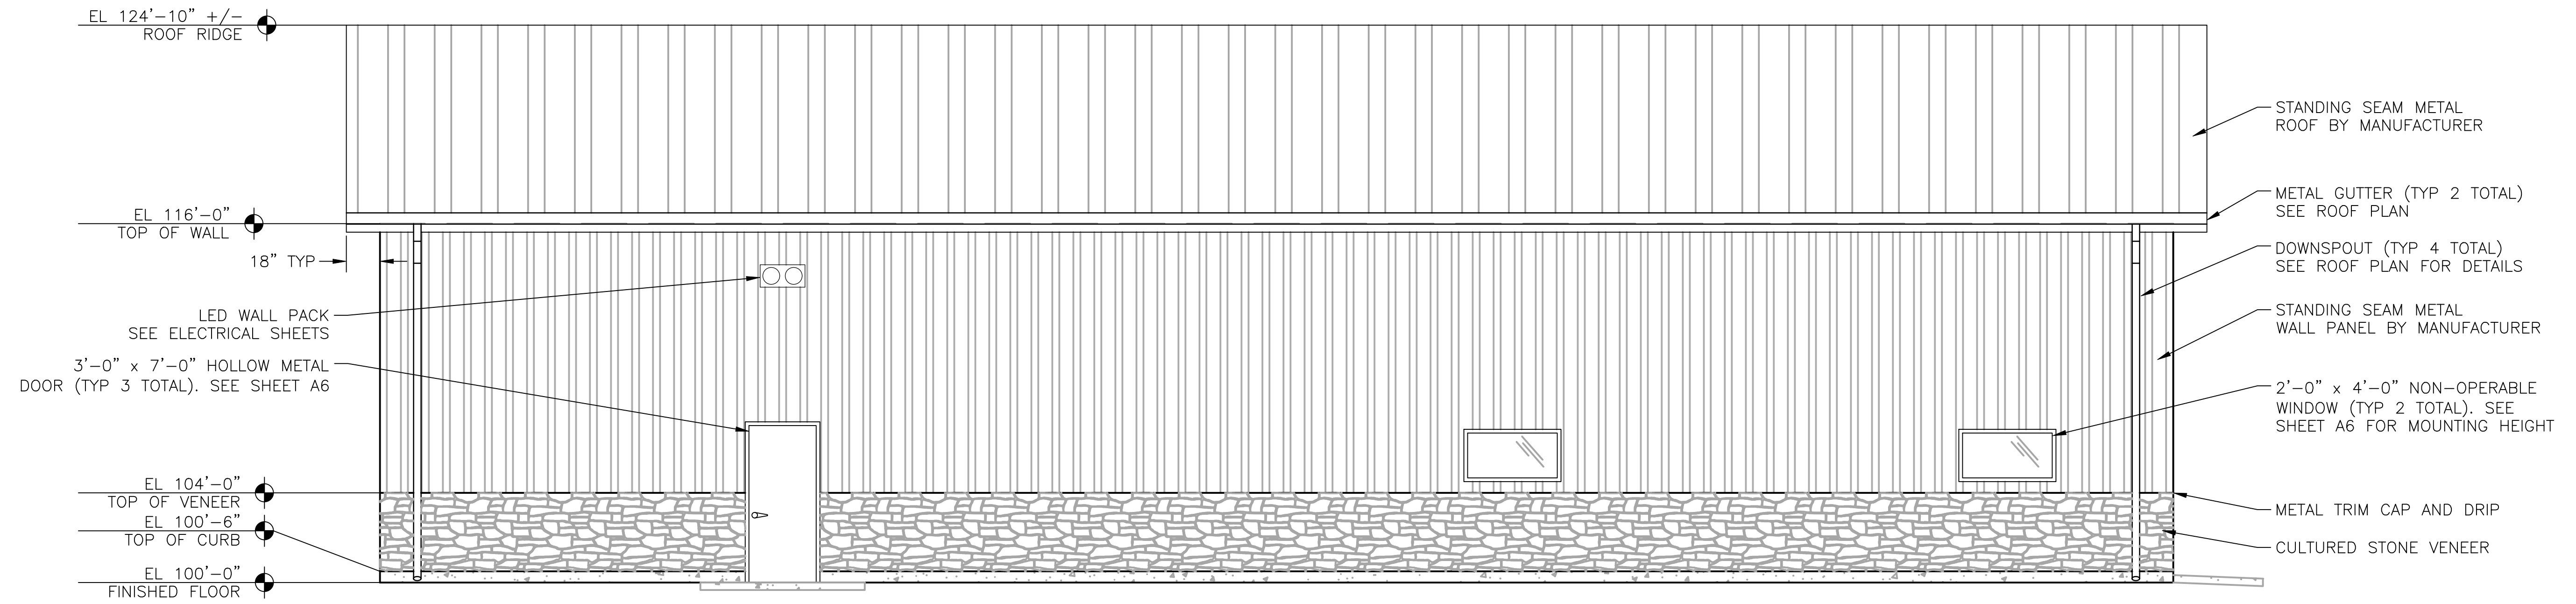

BUILDING ELEVATION: NORTH

11x17 SCALE: 1/8"=1'-0"
22x34 SCALE: 1/4"=1'-0"



BUILDING ELEVATION: SOUTH

11x17 SCALE: 1/8"=1'-0"
22x34 SCALE: 1/4"=1'-0"

Colorado Springs, CO
5540 Tech Center Dr., Suite 100
Colorado Springs, CO 80919
Phone: 719.227.0072
www.respec.com


FALCON AREA WATER & WASTEWATER AUTHORITY
STERLING RANCH WATER TREATMENT PLANT
BUILDING ELEVATION: NORTH & SOUTH

NO.	DESCRIPTION	BY	APP.	DATE
1				
2				
3				
4				
5				
6				
7				

FOR REVIEW




Proj.#: W02242.22
Date: 03/29/23
Design: GGM
Drawn: GGM
Check: JPM

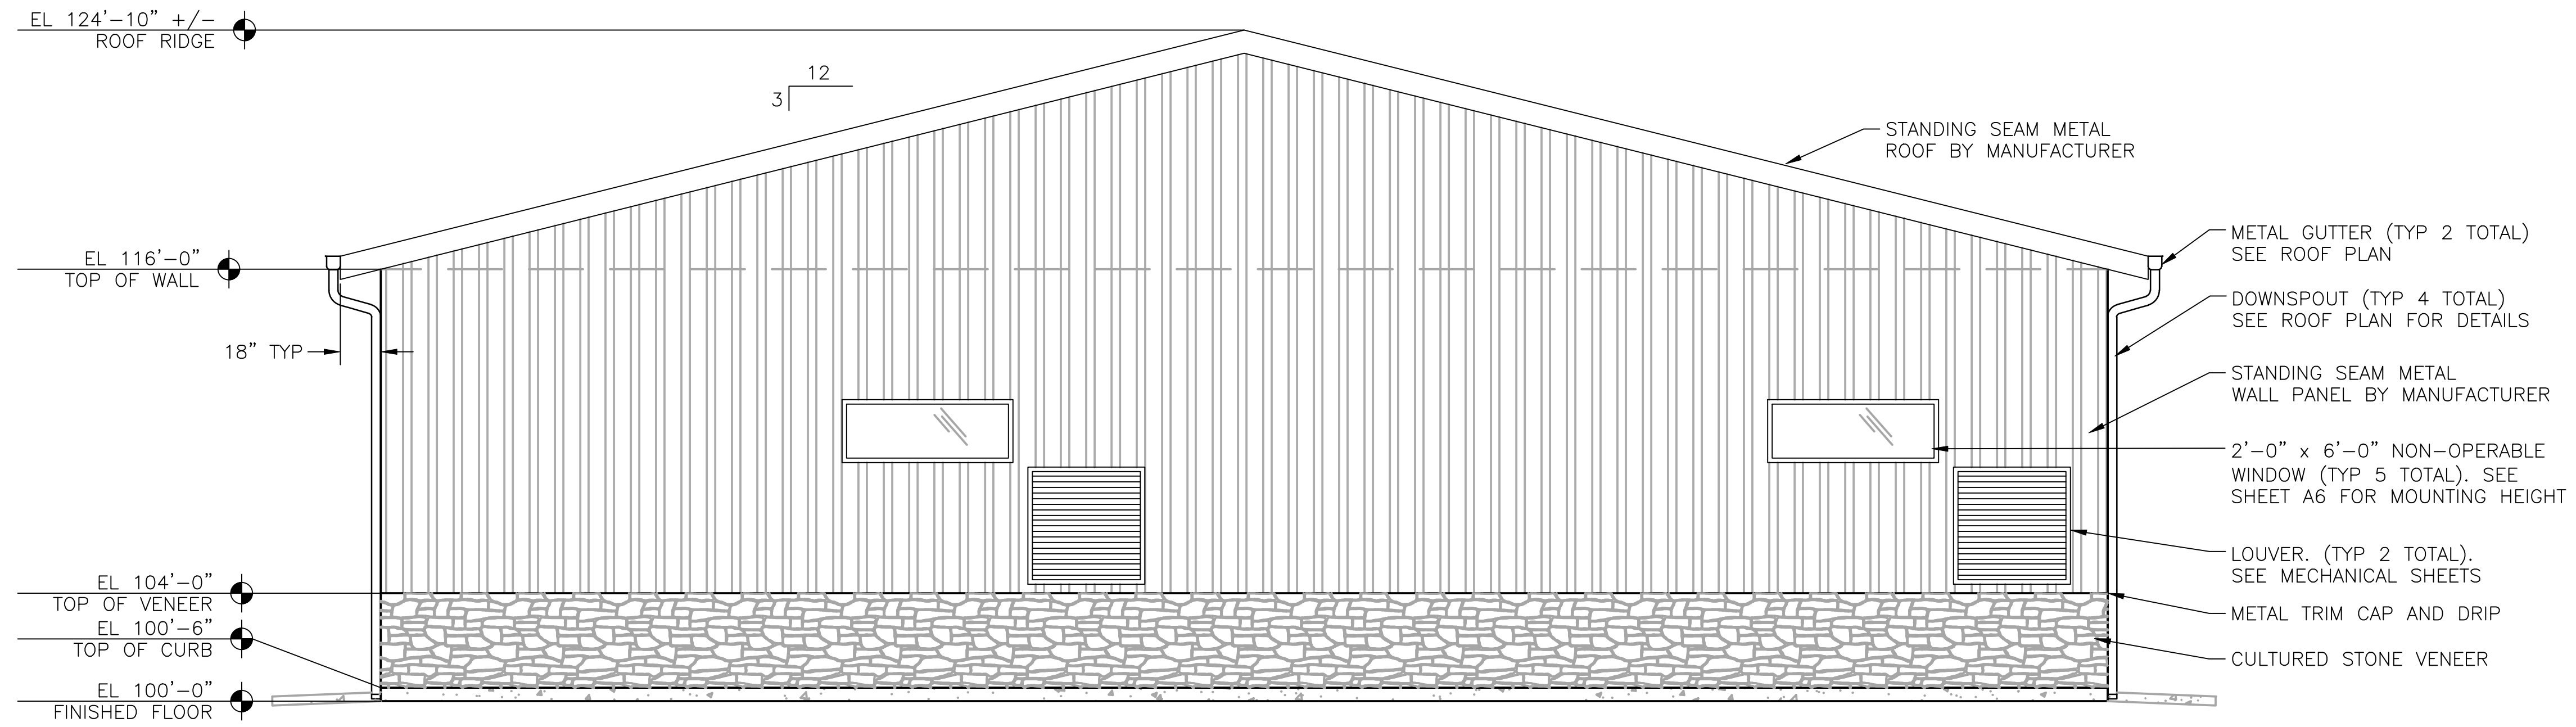

BUILDING ELEVATION: EAST

11x17 SCALE: 1/8"=1'-0"
22x34 SCALE: 1/4"=1'-0"

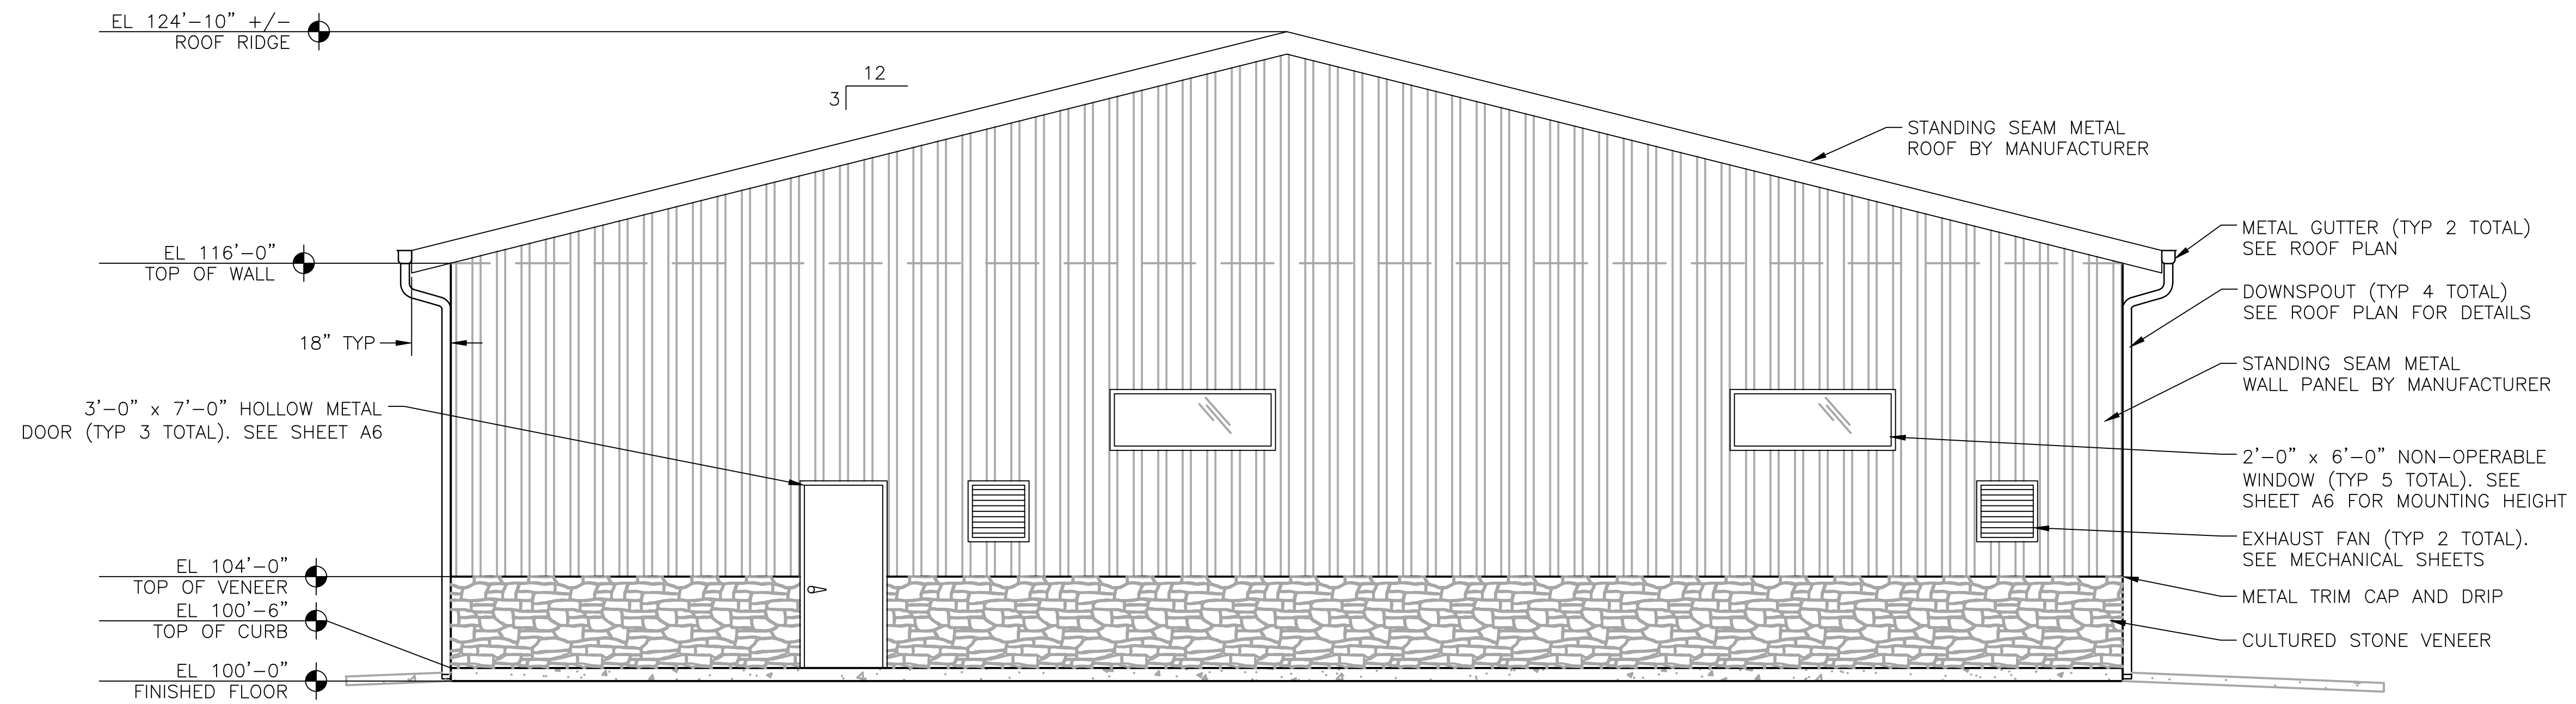

BUILDING ELEVATION: WEST

11x17 SCALE: 1/8"=1'-0"
22x34 SCALE: 1/4"=1'-0"



NO.	DESCRIPTION	BY	APP.	DATE
1				
2				
3				
4				
5				
6				
7				

FOR REVIEW

Proj.#: W02242.22
Date: 03/29/23
Design: GGM
Drawn: GGM
Check: JPM

A4