


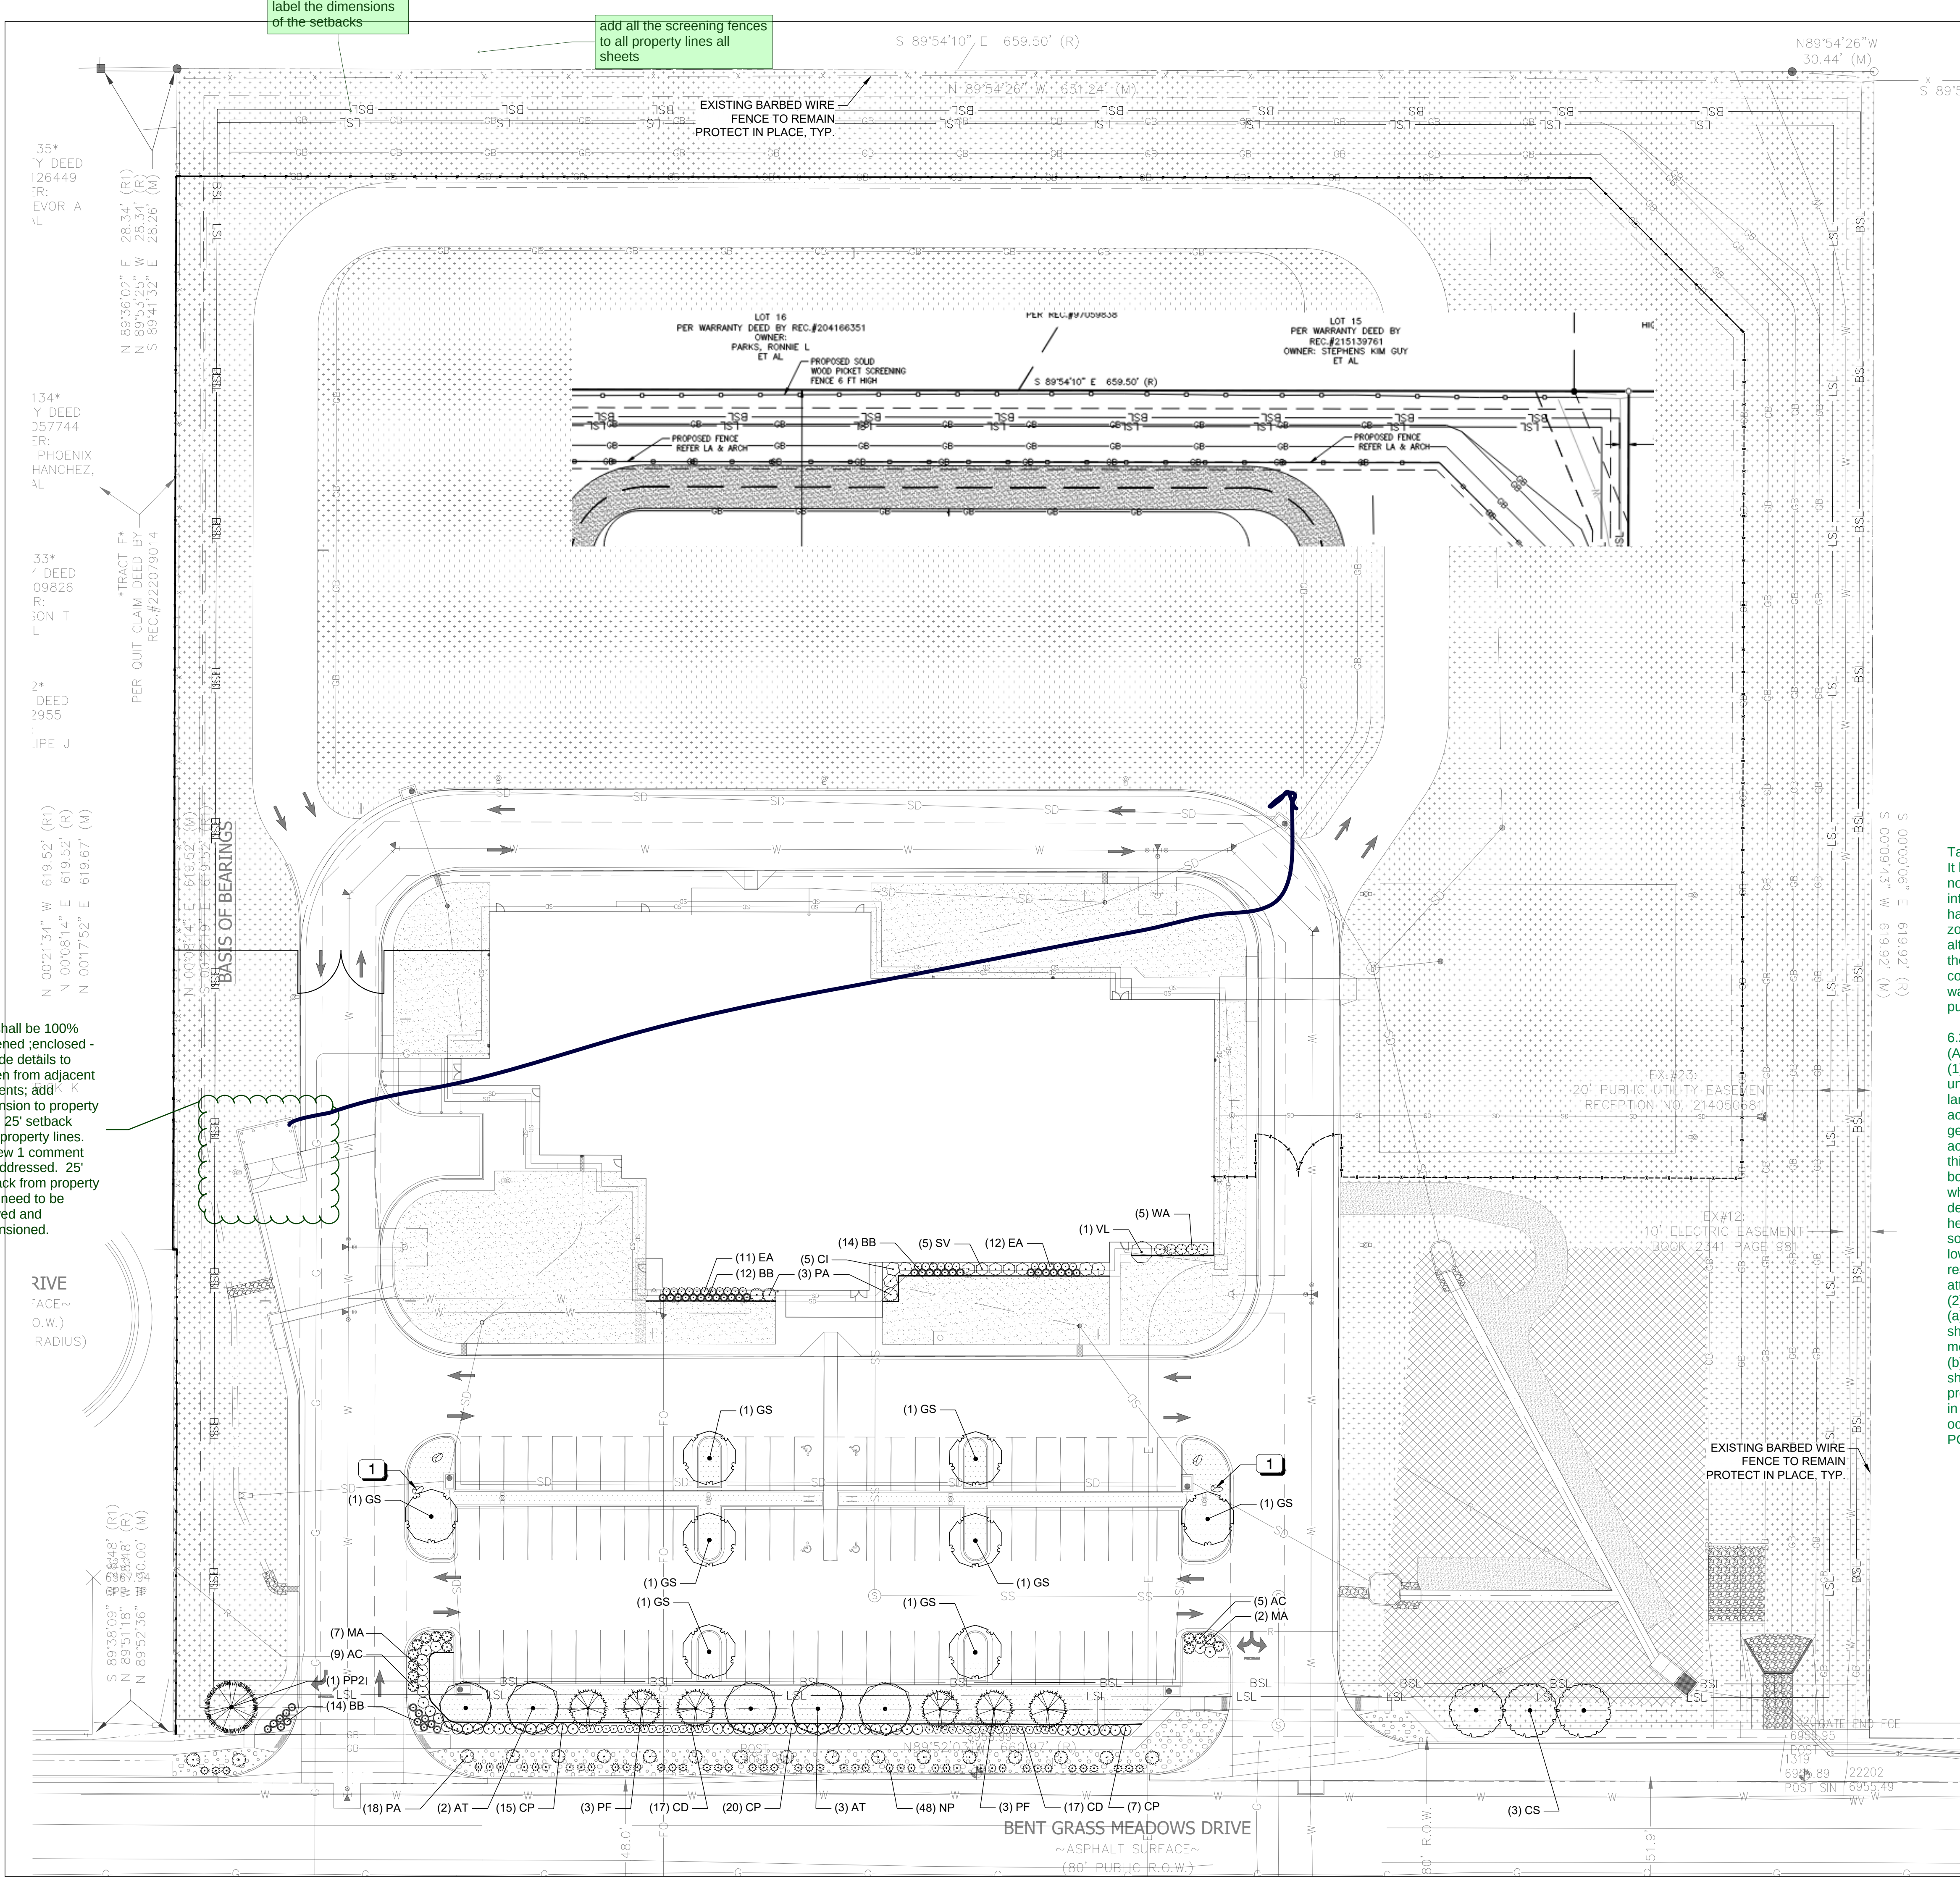

LANDSCAPE CALCULATIONS


SITE INFORMATION: AUTHORITY HAVING JURISDICTION: ZONING: TOTAL SITE AREA:		EL PASO COUNTY, COLORADO BENT GRASS PLANNED UNIT DEVELOPMENT (PUD142) 391,129 SF	
STREETSCAPE LANDSCAPE STREETSCAPE @ BENT GRASS MEADOWS DRIVE: SETBACK REQUIRED: SETBACK PROVIDED: TREES REQUIRED: DECIDUOUS TREES PROVIDED: EVERGREEN TREES: TOTAL TREES:		631 LF 10 LF 10 21 TREES (1 PER 30 LF) 9 TREES 7 TREES (41%) 16 TREE CREDITS*	
PARKING LOT ISLANDS: NUMBER OF PARKING SPACES: TREES REQUIRED: TREES PROVIDED: PARKING LOT SCREENING:		82 6 TREES (1 PER 15 PARKING SPACES) 8 TREES PROVIDED	
INTERNAL LANDSCAPE: LANDSCAPE AREA REQUIRED: LANDSCAPE AREA PROVIDED: TREES REQUIRED: TREES PROVIDED: SHRUBS PROVIDED: LIVE GROUNDCOVER REQUIRED: LIVE GROUNDCOVER PROVIDED: TOTAL TREES:		19,557 SF (5%) 290,626 SF (74.3%) 39 TREES (1 TREE PER 500 SF) 27 TREES 255 SHRUBS (10 SHRUBS EQUALS 1 TREE) 5,887 SF (30%) 244,712 SF (1251.27%) 52 TREE CREDITS	
BUFFER LANDSCAPE: NORTH BUFFER: BUFFER WIDTH REQUIRED: BUFFER WIDTH PROVIDED: TREES REQUIRED: DECIDUOUS TREES PROVIDED: EVERGREEN TREES: TOTAL TREES: - BUFFER PROVIDED WITH A NEW 6-FT HT. OPAQUE WOOD FENCING.		631LF 15 LF 15 LF 25 TREES (1 PER 25 LF) 0 TREES 0 TREES 0 TREE CREDITS*	
EAST BUFFER: BUFFER WIDTH REQUIRED: BUFFER WIDTH PROVIDED: TREES REQUIRED: DECIDUOUS TREES PROVIDED: EVERGREEN TREES: TOTAL TREES:		620 LF 15 LF 15 LF 21 TREES (1 PER 30 LF) 0 TREES 0 TREES 0 TREE CREDIT*	
WEST BUFFER: BUFFER WIDTH REQUIRED: BUFFER WIDTH PROVIDED: TREES REQUIRED: DECIDUOUS TREES PROVIDED: EVERGREEN TREES: TOTAL TREES: - BUFFER PROVIDED WITH EXISTING AND NEW 6-FT HT. OPAQUE WOOD FENCING.		620 LF 15 LF 15 LF 25 TREES (1 PER 25 LF) 0 TREES 0 TREES 0 TREE CREDIT*	
* PROJECT IS ZONING EXEMPT.			

Provide the alternative justification for each area you are omitting landscape from please

Tammy-
It looks like the landscape plan didn't address comments; it does not meet the standards in the Code for buffers, roadway and internal landscape. There is mention of tree credits? We don't have tree credits that I am aware of. A school is not exempt from zoning as indicated on the Plan. Are you proposing an alternative/substitute landscape plan? If so, you will need to state the justification in the table on the Plan. I am sending you my comments on the landscape plan via email so you don't have to wait until the remainder comments on other documents are published, so you can make adjustments.

6.2.2. Landscape Requirements
(A)General.
(1)Purpose. The landscape requirements are intended to provide uniform standards for the development and maintenance of the landscaping of private property and public rights-of-way to achieve a balance between the individual right to develop and the general benefit and welfare of the community. The benefits to be achieved and the overall purposes of the landscaping required by this Section are: (1) to create a positive image and visual appeal both along the road which is highly visible and internal properties which provide a working, shopping and living environment, (2) to decrease the scale of parking lots, provide shade, and reduce heat, glare and noise; (3) to separate circulation systems; to soften and reduce the mass of buildings; to screen and buffer lower intensity uses from higher intensity uses and protect residential privacy; and (4) to create an overall pleasant and attractive surrounding.
(2)Applicability.
(a)Applies to All Land Uses. The requirements of this Section shall apply to all uses. PUD's may have their requirements modified subject to the individual PUD.
(b)New Use Established or Use Changed. Landscaping areas shall conform to this Section for a new building or use of previously vacant land, uses in an enlarged building, and all uses in a building when any use is changed that requires a change of occupancy to be approved by the Building Department or by the PCD.

SEE SHEET LP-4 FOR PLANT SCHEDULE

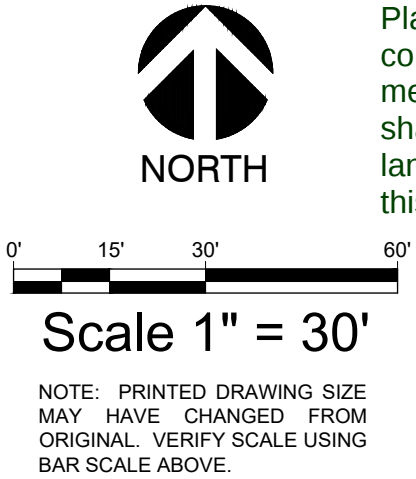

(4)Authority of Director to Approve Substitute Landscape Designs. The PCD Director may approve landscaping that does not meet the specific requirements of this Section provided the proposed landscaping meets the purpose of this Section, promotes the concepts contained in the Landscaping and Planting Manual, and provides an equivalent benefit to the community and environment as would otherwise be achieved by meeting the specific requirements of this Section. This authority shall not allow the PCD Director to eliminate the requirement for landscaping or to diminish the total landscaped area required by this Section.

this shall be 100% screened ,enclosed - provide details to screen from adjacent residents; add dimension to property lines; 25' setback from property lines. Review 1 comment not addressed. 25' setback from property lines need to be showed and dimensioned.

label the dimensions of the setbacks

add all the screening fences to all property lines all sheets

National Presence. Local Expertise.

EVERGREEN DESIGN GROUP
800.680.6630
www.evergreendesigngroup.com
LANDSCAPE ARCHITECTURE
LAND PLANNING • IRRIGATION DESIGN

KENNETH D. BATES
1078
07/25/2014
Professional Seal
STATE OF COLORADO
RESIDED LANDSCAPE ARCHITECT
07/24/2026

HONOR CHARTER
ACADEMY
BENT GRASS MEADOWS DRIVE
PEYTON, CO

SCHEMATIC
LANDSCAPE
PLANTING PLAN

Date	Comment

Project Number

Date 07/24/2026

Drawn By JML

Checked By KB

LP-1

LP-2

PLANTING SPECIFICATIONS

GENERAL		B. SUBMITTALS
A. QUALIFICATIONS OF LANDSCAPE CONTRACTOR	1. ALL LANDSCAPE WORK SHOWN ON THESE PLANS SHALL BE PERFORMED BY A SINGLE FIRM SPECIALIZING IN LANDSCAPE PLANTING.	1. THE CONTRACTOR SHALL PROVIDE SUBMITTALS AND SAMPLES, IF REQUIRED, TO THE LANDSCAPE ARCHITECT, AND RECEIVE APPROVAL IN WRITING FOR SUCH SUBMITTALS BEFORE WORK COMMENCES.
	2. A LIST OF SUCCESSFULLY COMPLETED PROJECTS OF THIS TYPE, SIZE AND NATURE MAY BE REQUESTED BY THE OWNER FOR FURTHER QUALIFICATION MEASURES.	2. SUBMITTALS SHALL INCLUDE PHOTOS OF PLANTS WITH A RULER OR MEASURING STICK FOR SCALE, PHOTOS OR SAMPLES OF ANY REQUIRED MULCHES, AND SOIL TEST RESULTS AND PREPARATION RECOMMENDATIONS FROM THE TESTING LAB (INCLUDING COMPOST AND FERTILIZER RATES AND TYPES, AND OTHER AMENDMENTS FOR TREE/SHRUB, TURF, AND SEED AREAS AS MAY BE APPROPRIATE).
	3. THE LANDSCAPE CONTRACTOR SHALL HOLD A VALID CONTRACTOR'S LICENSE ISSUED BY THE APPROPRIATE LOCAL JURISDICTION.	3. SUBMITTALS SHALL ALSO INCLUDE MANUFACTURER CUT SHEETS FOR PLANTING ACCESSORIES SUCH AS TREE STAKES AND TIES, EXCING, AND LANDSCAPE FABRIC (IF ANY).
B. SCOPE OF WORK	1. WORK COVERED BY THESE SECTIONS INCLUDES THE FURNISHING AND PAYMENT OF ALL MATERIALS, LABOR, SERVICES, EQUIPMENT, LICENSES, TAXES AND ANY OTHER ITEMS THAT ARE NECESSARY FOR THE EXECUTION, INSTALLATION AND COMPLETION OF ALL WORK, SPECIFIED HEREIN AND /OR SHOWN ON THE LANDSCAPE PLANS, NOTES, AND DETAILS.	4. WHERE MULTIPLE ITEMS ARE SHOWN ON A PAGE, THE CONTRACTOR SHALL CLEARLY INDICATE THE ITEM BEING CONSIDERED.
	2. ALL WORK SHALL BE PERFORMED IN ACCORDANCE WITH ALL APPLICABLE LAWS, CODES AND REGULATIONS REQUIRED BY AUTHORITIES HAVING JURISDICTION OVER SUCH WORK, INCLUDING ALL INSPECTIONS AND PERMITS REQUIRED BY FEDERAL, STATE AND LOCAL AUTHORITIES IN SUPPLY, TRANSPORTATION AND INSTALLATION OF MATERIALS.	C. GENERAL PLANTING
	3. THE LANDSCAPE CONTRACTOR SHALL VERIFY THE LOCATION OF ALL UNDERGROUND UTILITY LINES (WATER, SEWER, ELECTRICAL, TELEPHONE, GAS, CABLE, TELEVISION, ETC.) PRIOR TO THE START OF ANY WORK.	1. REMOVE ALL NURSERY TAGS AND STAKES FROM PLANTS.
PRODUCTS	A. ALL MANUFACTURED PRODUCTS SHALL BE NEW.	2. EXCEPT IN AREAS TO BE PLANTED WITH ORNAMENTAL GRASSES, APPLY PRE-EMERGENT HERBICIDES FOR CONTAINER AND BURLAP REMOVAL AND PRECAUTIONS TO AVOID INJURY TO TREE ROOTS, TRUNKS, AND BRANCHES. THE CRZ IS DEFINED AS A CIRCULAR AREA EXTENDING OUTWARD FROM THE TREE TRUNK, WITH A RADIUS EQUAL TO 1" FOR EVERY 1" OF TRUNK DIAMETER-AT-BREAST-HEIGHT (4.5' ABOVE THE AVERAGE GRADE AT THE TRUNK).
	B. CONTAINER AND BALLED-AND-BURLAPPED PLANTS:	a. CONTRACTOR SHALL NOT DISTURB ROOTS 1-1/2" AND LARGER IN DIAMETER WITHIN THE CRITICAL ROOT ZONE (CRZ) OF EXISTING TREES, AND SHALL EXERCISE A POSSIBLE CARE AND PRECAUTIONS TO AVOID INJURY TO TREE ROOTS, TRUNKS, AND BRANCHES. THE CRZ IS DEFINED AS A CIRCULAR AREA EXTENDING OUTWARD FROM THE TREE TRUNK, WITH A RADIUS EQUAL TO 1" FOR EVERY 1" OF TRUNK DIAMETER-AT-BREAST-HEIGHT (4.5' ABOVE THE AVERAGE GRADE AT THE TRUNK).
	1. FURNISH NURSERY-GROWN PLANTS COMPLYING WITH ANSI Z60.1-2014. PROVIDE WELL-SHAPED, FULLY BRANCHED, HEALTHY, VIGOROUS STOCK FREE OF DISEASE, INSECTS, EGGS, LARVAE, AND DEFECTS SUCH AS KNOTS, SUN SCALD, INJURIES, ABRASIONS, AND DISFIGUREMENT. ALL PLANTS WITHIN A SPECIES SHALL HAVE SIMILAR BEING BE OF A FORM TYPICAL FOR THE SPECIES. ALL TREES SHALL BE OBTAINED FROM SOURCES WITHIN 200 MILES OF THE PROJECT SITE, AND WITH SIMILAR CLIMATIC CONDITIONS.	b. ALL EXCAVATION WITHIN THE CRZ SHALL BE PERFORMED USING HAND TOOLS. NO MACHINE EXCAVATION OR TRENCHING OF ANY KIND SHALL BE ALLOWED WITHIN THE CRZ.
METHODS	2. TREES MUST BE PLANTED FROM CONTAINERS OR BALLED-AND-BURLAPPED (B&B), UNLESS SPECIFIED ON THE PLANTING LEGEND. BARE-ROOT TREES ARE NOT ACCEPTABLE.	c. ALTER ALIGNMENT OF PIPE TO AVOID TREE ROOTS 1-1/2" AND LARGER IN DIAMETER. WHERE TREE ROOTS 1-1/2" AND LARGER IN DIAMETER ARE ENCOUNTERED IN THE FIELD, TUNNEL UNDER SUCH ROOTS. WRAP EXPOSURE ROOTS WITH SEVERAL LAYERS OF BURLAP AND KEEP MOIST. CLOSE ALL TRENCHES WITHIN THE CANOPY DRIP LINES WITHIN 24 HOURS.
	3. ANY PLANT DEEMED UNACCEPTABLE BY THE LANDSCAPE ARCHITECT OR OWNER SHALL BE IMMEDIATELY REMOVED FROM THE SITE AND SHALL BE REPLACED WITH AN ACCEPTABLE PLANT OF LIKE TYPE AND SIZE AT THE CONTRACTOR'S OWN EXPENSE. ANY PLANTS APPEARING TO BE UNHEALTHY, EVEN IF DETERMINED TO STILL BE ALIVE, SHALL NOT BE ACCEPTED. THE LANDSCAPE ARCHITECT AND OWNER SHALL BE THE SOLE JUDGES AS TO THE ACCEPTABILITY OF PLANT MATERIAL. ALL TREES SHALL BE STANDARD IN FORM, UNLESS OTHERWISE SPECIFIED. TREES WITH CENTRAL LEADERS WILL NOT BE ACCEPTED IF LEADER IS DAMAGED OR REMOVED. PRUNE ALL DAMAGED TWIGS AFTER PLANTING.	d. ALL SEVERED ROOTS SHALL BE HAND PRUNED WITH SHARP TOOLS AND ALLOWED TO AIR-DRY. DO NOT USE ANY SORT OF SEALER OR WOUND PAINTS UNLESS LOCAL JURISDICTION REQUIRES OR ON TREES LOCATED IN CRZ UNLIT SUSCEPTIBLE AREAS.
	4. CALIPER MEASUREMENTS FOR STANDARD (SINGLE TRUNK) TREES SHALL BE AS FOLLOWS: SIX INCHES ABOVE THE ROOT FLARE FOR TREES UP TO AND INCLUDING FOUR INCHES IN CALIPER, AND TWELVE INCHES ABOVE THE ROOT FLARE FOR TREES EXCEEDING FOUR INCHES IN CALIPER.	D. TREE PLANTING
METHODS	5. MULTI-TRUNK TREES SHALL BE MEASURED BY THEIR OVERALL HEIGHT MEASURED FROM THE TOP OF THE ROOT BALL. WHERE CALIPER MEASUREMENTS ARE USED, THE CALIPER SHALL BE CALCULATED AS ONE-HALF OF THE SUM OF THE CALIPER OF THE THREE LARGEST TRUNKS.	1. TREE PLANTING HOLES SHALL BE EXCAVATED TO MINIMUM WIDTH OF TWO TIMES THE WIDTH OF THE ROOTBALL, AND TO A DEPTH EQUAL TO THE DEPTH OF THE ROOTBALL, LESS TWO TO FOUR INCHES.
	6. SOD: PROVIDE WELL-ROOTED SOD OF THE VARIETY NOTED ON THE PLANS. SOD SHALL BE CUT FROM HEALTHY, MATURE TURF WITH SOIL THICKNESS OF 3/4" TO 1". EACH PALLET OF SOD SHALL BE ACCOMPANIED BY A CERTIFICATE FROM SUPPLIER STATING THE COMPOSITION OF THE SOD.	2. SCARIFY THE SIDES AND BOTTOM OF THE PLANTING HOLE PRIOR TO THE PLACEMENT OF THE TREE. REMOVE ANY GLAZING THAT MAY HAVE BEEN CAUSED DURING THE EXCAVATION OF THE HOLE.
	7. SEED: PROVIDE BLEND OF SPECIES AND VARIETIES AS NOTED ON THE PLANS, WITH MAXIMUM PERCENTAGES OF PURITY, GERMINATION, AND MINIMUM PERCENTAGE OF WEED SEED AS INDICATED ON PLANS. EACH BAG OF SEED SHALL BE ACCOMPANIED BY A TAG FROM THE SUPPLIER INDICATING THE COMPOSITION OF THE SEED.	3. FOR CONTAINER AND BOX TREES, TO REMOVE ANY POTENTIALLY GIRDLING ROOTS AND OTHER ROOT DEFECTS, THE CONTRACTOR SHALL SHAVE A 1" LAYER OFF OF THE SIDES AND BOTTOM OF THE ROOTBALL, OF ALL TREES JUST BEFORE PLACING INTO THE PLANTING PIT. DO NOT "TEASE" ROOTS OUT FROM THE ROOTBALL.
METHODS	8. TOPSOIL: SANDY TO CLAY LOAM TOPSOIL, FREE OF STONES LARGER THAN 1/4" INCH, FOREIGN MATTER, PLANTS, ROOTS, AND SEEDS.	4. INSTALL THE TREE ON UNDISTURBED SUBGRADE SO THAT THE TOP OF THE ROOTBALL IS TWO TO FOUR INCHES ABOVE THE SURROUNDING GRADE.
	9. COMPOST: WELL-COMPOSTED, STABLE, AND WEED-FREE ORGANIC MATTER, pH RANGE OF 5.5 TO 6.5, MOISTURE CONTENT 35 TO 55 PERCENT BY WEIGHT, PASSING THROUGH 3/4-INCH SIEVE; SOLUBLE SALT CONTENT OF 5 TO 10 DECISEMENS/M; NOT EXCEEDING 0.5 PERCENT INERT CONTAMINANTS AND FREE OF SUBSTANCES TOXIC TO PLANTINGS. NO MANURE OR ANIMAL-BASED PRODUCTS SHALL BE USED.	5. BACKFILL THE TREE HOLE UTILIZING THE EXISTING TOPSOIL FROM ON-SITE. ROCKS LARGER THAN 1" DIA. AND ALL OTHER DEBRIS SHALL BE REMOVED FROM THE SOIL PRIOR TO THE BACKFILL. SHOULD ADDITIONAL SOIL BE REQUIRED TO ACCOMPLISH THIS TASK, USE STORED TOPSOIL FROM ON-SITE OR IMPORT ADDITIONAL TOPSOIL FROM OFF-SITE AT NO ADDITIONAL COST TO THE OWNER. IMPORTED TOPSOIL SHALL BE OF SIMILAR TEXTURAL CLASS AND COMPOSITION IN THE ON-SITE SOIL.
	10. FERTILIZER: GRANULAR FERTILIZER CONSISTING OF NITROGEN, PHOSPHORUS, POTASSIUM, AND OTHER NUTRIENTS IN PROPORTIONS, AMOUNTS, AND RELEASE RATES RECOMMENDED IN A SOIL REPORT FROM A QUALIFIED SOIL TESTING AGENCY (SEE BELOW).	6. TREES SHALL NOT BE STAKED UNLESS LOCAL CONDITIONS (SUCH AS HEAVY WINDS OR SLOPES) REQUIRE STAKES TO KEEP TREES UPRIGHT. SHOULD STAKING BE REQUIRED, THE TOTAL NUMBER OF TREE STAKES (BEYOND THE MINIMUMS LISTED BELOW) WILL BE LEFT TO THE LANDSCAPE CONTRACTOR'S DISCRETION. SHOULD ANY TREES FALL OR LEAN, THE LANDSCAPE CONTRACTOR SHALL STRAIGHTEN THE TREE, OR REPLACE IT SHOULD IT BECOME DAMAGED. TREE STAKING SHALL ADHERE TO THE FOLLOWING GUIDELINES:
METHODS	11. MULCH: SIZE AND TYPE AS INDICATED ON PLANS. FREE FROM DELETERIOUS MATERIALS AND SUITABLE AS A TOP DRESSING OF TREES AND SHRUBS.	a. 1-1/2" TREES TWO STAKES PER TREE
	12. TREE STAKING AND GUYING	b. 2-1/2" - 4" TREES THREE STAKES PER TREE
	1. STAKES: 6" LONG GREEN METAL T-POSTS.	c. TREES OVER 4" CALIPER GUY AS NEEDED
METHODS	2. GUY AND TIE WIRE: ASTM A 641, CLASS 1, GALVANIZED-STEEL WIRE, 2-STRAND, TWISTED, 0.106 INCH DIAMETER.	d. MULTI-TRUNK TREES THREE STAKES PER TREE MINIMUM, QUANTITY AND POSITIONS AS NEEDED TO STABILIZE THE TREE
	3. STRAP CHAFING GUARD: REINFORCED NYLON OR CANVAS AT LEAST 1-1/2 INCH WIDE, WITH GROMMETS TO PROTECT TREE TRUNKS FROM DAMAGE.	e. #15 CONT. - 24" BOX TREES TWO STAKES PER TREE
	4. STEEL EDGING: PROFESSIONAL STEEL EDGING, 14 GAUGE THICK X 4 INCHES WIDE, FACTORY PAINTED DARK GREEN, ACCEPTABLE MANUFACTURERS INCLUDE COI-MET OR APPROVED EQUAL.	f. 36"-48" BOX TREES THREE STAKES PER TREE
METHODS	5. PRE-EMERGENT HERBICIDES: ANY GRANULAR, NON-STAINING PRE-EMERGENT HERBICIDE THAT IS LABELED FOR THE SPECIFIC ORNAMENTALS OR TURF ON WHICH IT WILL BE UTILIZED. PRE-EMERGENT HERBICIDES SHALL BE APPLIED PER THE MANUFACTURER'S LABELLED RATES.	g. OVER 48" BOX TREES GUY AS NEEDED
		h. MULTI-TRUNK TREES THREE STAKES PER TREE MINIMUM, QUANTITY AND POSITIONS AS NEEDED TO STABILIZE THE TREE
		7. UPON COMPLETION OF PLANTING, CONSTRUCT AN EARTH WATERING BASIN AROUND THE TREE, COVER THE INTERIOR OF THE TREE RING WITH THE WEED BARRIER CLOTH AND TOPDRESS WITH MULCH (TYPE AND DEPTH PER PLANS).
METHODS		E. SHRUB, PERENNIAL, AND GROUNDCOVER PLANTING
		1. DIG THE PLANTING HOLES TWICE AS WIDE AND 2" LESS DEEP THAN EACH PLANT'S ROOTBALL. INSTALL THE PLANT IN THE HOLE. BACKFILL AROUND THE PLANT WITH SOIL AMENDED PER SOIL TEST RECOMMENDATIONS.
		2. INSTALL THE WEED BARRIER CLOTH, OVERLAPPING IT AT THE ENDS. UTILIZE STEEL STAPLES TO KEEP THE WEED BARRIER CLOTH IN PLACE.
METHODS		3. WHEN PLANTING IS COMPLETE, INSTALL MULCH (TYPE AND DEPTH PER PLANS) OVER ALL PLANTING BEDS, COVERING THE ENTIRE PLANTING AREA.
		F. SODDING
		1. SOD VARIETY TO BE AS SPECIFIED ON THE LANDSCAPE PLAN.
METHODS		2. LAY SOD WITHIN 24 HOURS FROM THE TIME OF STRIPPING. DO NOT LAY IF THE GROUND IS FROZEN.
		3. LAY THE SOD TO FORM A SOLID MASS WITH TIGHTLY FITTED JOINTS. BUTT ENDS AND SIDES OF SOD STRIPS. DO NOT OVERLAP. STAGGER STRIPS TO OFFSET JOINTS IN ADJACENT COURSES.
		4. ROLL THE SOD TO ENSURE GOOD CONTACT OF THE SOD'S ROOT SYSTEM WITH THE SOIL UNDERNEATH.
METHODS		5. WATER THE SOD THOROUGHLY WITH A FINE SPRAY IMMEDIATELY AFTER PLANTING TO OBTAIN AT LEAST SIX INCHES OF PENETRATION INTO THE SOIL BELOW THE SOD.
		G. HYDROMULCHING
		1. TURF HYDROMULCH MIX (PER 1,000 SF) SHALL BE AS FOLLOWS:
METHODS		a. WINTER MIX (OCTOBER 1 - MARCH 31)
		50# CELLULOSE FIBER MULCH
		2# UNHULLED BERMUDA SEED
METHODS		b. ANNUAL RYE SEED
		15# 15-15-15 WATER SOLUBLE FERTILIZER
		c. SUMMER MIX (APRIL 1 - SEPTEMBER 30)
METHODS		50# CELLULOSE FIBER MULCH
		2# HULLED BERMUDA SEED
		15# 15-15-15 WATER SOLUBLE FERTILIZER
METHODS		d. SEED HYDROMULCH MIX (PER 1,000 SF) SHALL BE AS FOLLOWS:
		a. GENERAL
		50# CELLULOSE FIBER MULCH
METHODS		b. 15-15-15 WATER SOLUBLE FERTILIZER
		SEED RATE PER LEGEND
METHODS		H. DRILL SEEDING
		1. ALL SEED SHALL BE DRILL SEEDDED AT THE RATES SHOWN ON THE PLANS, WITH A HYDROMULCH MIX APPLIED AFTER SEEDING.
		2. THE HYDROMULCH MIX (PER 1,000 SF) SHALL BE AS FOLLOWS:
METHODS		a. 50# CELLULOSE FIBER MULCH
		15# 15-15-15 WATER SOLUBLE FERTILIZER
		4# ORGANIC BINDER
METHODS		H. MULCH
		1. INSTALL MULCH TOPDRESSING, TYPE AND DEPTH PER MULCH NOTE, IN ALL PLANTING AREAS AND TREE RINGS.
		2. DO NOT INSTALL MULCH WITHIN 6" OF TREE ROOT FLARE AND WITHIN 24" OF HABITABLE STRUCTURES, EXCEPT AS MAY BE NOTED ON THESE PLANS. MULCH COVER WITHIN 6" OF CONCRETE WALKS AND CURBS SHALL NOT PROTRUDE ABOVE THE FINISH SURFACE OF THE WALKS AND CURBS. MULCH COVER WITHIN 12" OF WALLS SHALL BE AT LEAST 3" LOWER THAN THE TOP OF WALL.
METHODS		I. CLEAN UP
		1. DURING LANDSCAPE PREPARATION AND PLANTING, KEEP ALL PAVEMENT CLEAN AND ALL WORK AREAS IN A NEAT, ORDERLY CONDITION.
		2. LEGALLY DISPOSE ALL EXCAVATED MATERIALS OFF THE PROJECT SITE.
METHODS		J. INSPECTION AND ACCEPTANCE
		1. UPON COMPLETION OF THE WORK, THE LANDSCAPE CONTRACTOR SHALL PROVIDE THE SITE CLEAN, FREE OF DEBRIS AND TRASH, AND SUITABLE FOR USE AS INTENDED. THE LANDSCAPE CONTRACTOR SHALL THEN REQUEST AN INSPECTION BY THE OWNER TO DETERMINE FINAL ACCEPTABILITY.
		2. WHEN THE INSPECTED PLANTING WORK DOES NOT COMPLY WITH THE CONTRACT DOCUMENTS, THE LANDSCAPE CONTRACTOR SHALL REPLACE AND/OR REPAIR THE REJECTED WORK TO THE OWNER'S SATISFACTION WITHIN 24 HOURS.
METHODS		3. THE LANDSCAPE MAINTENANCE PERIOD WILL NOT COMMENCE UNTIL THE LANDSCAPE WORK HAS BEEN RE-INSPECTED BY THE OWNER AND FOUND TO BE ACCEPTABLE. AT THAT TIME, A WRITTEN NOTICE OF FINAL ACCEPTANCE WILL BE ISSUED BY THE OWNER, AND THE MAINTENANCE AND GUARANTEE PERIODS WILL COMMENCE.
		K. LANDSCAPE MAINTENANCE
		1. THE LANDSCAPE CONTRACTOR SHALL BE RESPONSIBLE FOR THE MAINTENANCE OF ALL WORK SHOWN ON THESE PLANS FOR 90 DAYS BEYOND FINAL ACCEPTANCE OF ALL LANDSCAPE WORK BY THE OWNER. LANDSCAPE MAINTENANCE SHALL INCLUDE WEEKLY SITE VISITS FOR THE FOLLOWING ACTIONS (AS APPROPRIATE): PROPER PRUNING, RESTAKING OF TREES, RESETTling OF PLANTS THAT HAVE SETTLED, MOVING AND AERATION OF LAWNS, WEEDING, RESEEDING AREAS WHICH HAVE NOT GERMINATED WELL, TREATING FOR INSECTS AND DISEASES, REPLACEMENT OF MULCH, REMOVAL OF LITTER, REPAIRS TO THE IRRIGATION SYSTEM DUE TO FAULTY PARTS AND/OR WORKMANSHIP, AND THE APPROPRIATE WATERING OF ALL PLANTINGS. THE LANDSCAPE CONTRACTOR SHALL MAINTAIN THE IRRIGATION SYSTEM IN PROPER WORKING ORDER, WITH SCHEDULING ADJUSTMENTS BY SEASON TO MAXIMIZE WATER CONSERVATION.
METHODS		2. SHOULD SEEDS AND/OR SODDED AREAS NOT BE COVERED BY AN AUTOMATIC IRRIGATION SYSTEM, THE LANDSCAPE CONTRACTOR SHALL BE RESPONSIBLE FOR WATERING THESE AREAS AND OBTAINING A FULL, HEALTHY STAND OF PLANTS AT NO ADDITIONAL COST TO THE OWNER.
		3. TO ACHIEVE FINAL ACCEPTANCE AT THE END OF THE MAINTENANCE PERIOD, ALL OF THE FOLLOWING CONDITIONS MUST OCCUR:
METHODS		a. THE LANDSCAPE SHALL SHOW ACTIVE, HEALTHY GROWTH (WITH EXCEPTIONS MADE FOR SEASONAL DORMANCY). ALL PLANTS NOT MEETING THIS CONDITION SHALL BE REJECTED AND REPLACED BY HEALTHY PLANT MATERIAL PRIOR TO FINAL ACCEPTANCE.
		b. ALL HARDSCAPE SHALL BE CLEANED PRIOR TO FINAL ACCEPTANCE.
		c. SODDED AREAS MUST BE ACTIVELY GROWING AND MUST REACH A MINIMUM HEIGHT OF 1 1/2 INCHES BEFORE FIRST MOWING. HYDROMULCHED AREAS SHALL SHOW ACTIVE, HEALTHY GROWTH. BARE AREAS LARGER THAN TWELVE SQUARE INCHES MUST BE RESEEDD OR RESEEDDED (AS APPROPRIATE) PRIOR TO FINAL ACCEPTANCE. ALL SODDED TURF SHALL BE NEATLY MOVED.
METHODS		L. WARRANTY AND REPLACEMENTS
		1. THE LANDSCAPE CONTRACTOR SHALL GUARANTEE ALL TREES, SHRUBS, PERENNIALS, SOD, SEEDS, AND HYDROMULCH AND IRRIGATION SYSTEMS FOR A PERIOD OF ONE YEAR FROM THE DATE OF THE OWNER'S FINAL ACCEPTANCE (90 DAYS FOR ANNUAL PLANTS). THE CONTRACTOR SHALL REPLACE, AT HIS OWN EXPENSE AND TO THE SATISFACTION OF THE OWNER, ANY PLANTS WHICH DIE IN THAT TIME, OR REPAIR ANY PORTION OF THE IRRIGATION SYSTEM WHICH OPERATES IMPROPERLY.
		2. AFTER THE INITIAL MAINTENANCE PERIOD AND DURING THE GUARANTEE PERIOD, THE LANDSCAPE CONTRACTOR SHALL ONLY BE RESPONSIBLE FOR REPLACEMENT OF PLANTS WHEN PLANT DEATH CANNOT BE ATTRIBUTED DIRECTLY TO OVERWATERING OR OTHER DAMAGE BY HUMAN ACTIONS.
METHODS		M. PROVIDE A MINIMUM OF (2) COPIES OF RECORD DRAWINGS TO THE OWNER UPON COMPLETION OF WORK. A RECORD DRAWING IS A RECORD OF ALL CHANGES THAT OCCURRED IN THE FIELD AND THAT ARE DOCUMENTED THROUGH CHANGE ORDERS, ADDENDA, OR CONTRACTOR/CONSULTANT DRAWING MARKUPS.

GENERAL GRADING AND PLANTING NOTES

- BY SUBMITTING A PROPOSAL FOR THE LANDSCAPE PLANTING SCOPE OF WORK, THE CONTRACTOR CONFIRMS THAT HE HAS READ, AND WILL COMPLY WITH, THE ASSOCIATED NOTES, SPECIFICATIONS, AND DETAILS WITH THIS PROJECT.
- THE GENERAL CONTRACTOR IS RESPONSIBLE FOR REMOVING ALL EXISTING VEGETATION (EXCEPT WHERE NOTED TO REMAIN).
- IN THE CONTEXT OF THESE PLANS, NOTES, AND SPECIFICATIONS, "FINISH GRADE" REFERS TO THE FINAL ELEVATION OF THE SOIL SURFACE (NOT TOP OF MULCH) AS INDICATED ON THE GRADING PLANS.
 - BEFORE STARTING WORK, THE LANDSCAPE CONTRACTOR SHALL VERIFY THAT THE ROUGH GRADES OF ALL LANDSCAPE AREAS ARE WITHIN +/-0.1' OF FINISH GRADE. SEE SPECIFICATIONS FOR MORE DETAILED INSTRUCTION ON TURF AREA AND PLANTING BED PREPARATION.
 - CONSTRUCT AND MAINTAIN FINISH GRADES AS SHOWN ON GRADING PLANS, AND CONSTRUCT AND MAINTAIN SLOPES AS RECOMMENDED BY THE GEOTECHNICAL REPORT. ALL LANDSCAPE AREAS SHALL HAVE POSITIVE DRAINAGE AWAY FROM STRUCTURES AT THE MINIMUM SLOPE SPECIFIED IN THE REPORT AND ON THE GRADING PLANS, AND AREAS OF POTENTIAL PONDING SHALL BE REGRADED TO BLEND IN WITH THE SURROUNDING GRADES AND ELIMINATE PONDING POTENTIAL.
 - THE LANDSCAPE CONTRACTOR SHALL DETERMINE WHETHER OR NOT THE EXPORT OF ANY SOIL WILL BE NEEDED, TAKING INTO ACCOUNT THE ROUGH GRADE PROVIDED, THE AMOUNT OF SOIL AMENDMENTS TO BE ADDED (BASED ON A SOIL TEST, PER SPECIFICATIONS), AND THE FINISH GRADES TO BE ESTABLISHED.
 - ENSURE THAT THE FINISH GRADE IN SHRUB AREAS IMMEDIATELY ADJACENT TO WALKS AND OTHER WALKING SURFACES, AFTER INSTALLING SOIL AMENDMENTS, IS 3" BELOW THE ADJACENT FINISH SURFACE, IN ORDER TO ALLOW FOR PROPER MULCH DEPTH. TAPER THE SOIL SURFACE TO MEET FINISH GRADE, AS SPECIFIED ON THE GRADING PLANS, AT APPROXIMATELY 18" AWAY FROM THE WALKS.
 - ENSURE THAT THE FINISH GRADE IN TURF AREAS IMMEDIATELY ADJACENT TO WALKS AND OTHER WALKING SURFACES, AFTER INSTALLING SOIL AMENDMENTS, IS 1" BELOW THE FINISH SURFACE OF THE WALKS. TAPER THE SOIL SURFACE TO MEET FINISH GRADE, AS SPECIFIED ON THE GRADING PLANS, AT APPROXIMATELY 18" AWAY FROM THE WALKS.
 - SHOULD ANY CONFLICTS AND/OR DISCREPANCIES ARISE BETWEEN THE GRADING PLANS, GEOTECHNICAL REPORT, THESE NOTES AND PLANS, AND ACTUAL CONDITIONS, THE CONTRACTOR SHALL IMMEDIATELY BRING SUCH ITEMS TO THE ATTENTION OF THE LANDSCAPE ARCHITECT, GENERAL CONTRACTOR, AND OWNER.
- ALL PLANT LOCATIONS ARE DIAGRAMMATIC. ACTUAL LOCATIONS SHALL BE VERIFIED WITH THE LANDSCAPE ARCHITECT OR DESIGNER PRIOR TO PLANTING. THE LANDSCAPE CONTRACTOR SHALL ENSURE THAT ALL REQUIREMENTS OF THE PERMITTING AUTHORITY ARE MET (I.E. MINIMUM PLANT QUANTITIES, PLANTING METHODS, TREE PROTECTION METHODS, ETC.).
- THE LANDSCAPE CONTRACTOR IS RESPONSIBLE FOR DETERMINING PLANT QUANTITIES, PLANT QUANTITIES SHOWN ON LEGENDS AND CALLOUTS ARE FOR GENERAL INFORMATION ONLY. IN THE EVENT OF A DISCREPANCY BETWEEN THE PLAN AND THE PLANT LEGEND, THE PLANT QUANTITY AS SHOWN ON THE PLAN (FOR INDIVIDUAL SYMBOLS) OR CALLOUT (FOR GROUNDCOVER PATTERNS) SHALL TAKE PRECEDENCE.
- NO SUBSTITUTIONS OF PLANT MATERIALS SHALL BE ALLOWED WITHOUT THE WRITTEN PERMISSION OF THE LANDSCAPE ARCHITECT. IF SOME OF THE PLANTS ARE NOT AVAILABLE, THE LANDSCAPE CONTRACTOR SHALL NOTIFY THE LANDSCAPE ARCHITECT IN WRITING (VIA PROPER CHANNELS).
- THE CONTRACTOR SHALL, AT A MINIMUM, PROVIDE REPRESENTATIVE PHOTOS OF ALL PLANTS PROPOSED FOR THE PROJECT. THE CONTRACTOR SHALL ALLOW THE LANDSCAPE ARCHITECT AND THE OWNER/OWNER'S REPRESENTATIVE TO INSPECT, AND APPROVE OR REJECT, ALL PLANTS DELIVERED TO THE JOBSITE. REFER TO SPECIFICATIONS FOR ADDITIONAL REQUIREMENTS FOR SUBMITTALS.
- CONTRACTOR SHALL PROVIDE AND INSTALL SOLID SOD IN ALL RIGHT-OF-WAYS AND PARKWAYS (UNLESS NOT ALLOWED BY THE LOCAL JURISDICTION) AND SHALL PROVIDE WATERING AND MAINTENANCE UNTIL THE TURF IS ESTABLISHED AND HAS BEEN ACCEPTED BY OWNER.
- THE CONTRACTOR SHALL MAINTAIN THE LANDSCAPE IN A HEALTHY CONDITION FOR 90 DAYS AFTER ACCEPTANCE BY THE OWNER. REFER TO SPECIFICATIONS FOR CONDITIONS OF ACCEPTANCE FOR THE START OF THE MAINTENANCE PERIOD, AND FOR FINAL ACCEPTANCE AT THE END OF THE MAINTENANCE PERIOD.
- SEE SPECIFICATIONS AND DETAILS FOR FURTHER REQUIREMENTS.

IRRIGATION CONCEPT

- AN AUTOMATIC IRRIGATION SYSTEM SHALL BE INSTALLED AND OPERATIONAL BY THE TIME OF FINAL INSPECTION. THE ENTIRE IRRIGATION SYSTEM SHALL BE INSTALLED BY A LICENSED AND QUALIFIED IRRIGATION CONTRACTOR.
- THE IRRIGATION SYSTEM WILL OPERATE ON POTABLE WATER, AND THE SYSTEM WILL HAVE APPROPRIATE BACKFLOW PREVENTION DEVICES INSTALLED TO PREVENT CONTAMINATION OF THE POTABLE SOURCE.
- ALL NON-TURF PLANTED AREAS SHALL BE DRIP IRRIGATED. SODDED AND SEEDDED AREAS SHALL BE IRRIGATED WITH SPRAY OR ROTOR HEADS AT 100% HEAD-TO-HEAD COVERAGE.
- ALL PLANTS SHARING SIMILAR HYDROZONE CHARACTERISTICS SHALL BE PLACED ON A VALVE DEDICATED TO PROVIDE THE NECESSARY WATER REQUIREMENTS SPECIFIC TO THAT HYDROZONE.
- THE IRRIGATION SYSTEM SHALL BE DESIGNED AND INSTALLED, TO THE MAXIMUM EXTENT POSSIBLE, TO CONSERVE WATER BY USING THE FOLLOWING DEVICES AND SYSTEMS: MATCHED PRECIPITATION RATE TECHNOLOGY ON ROTOR AND SPRAY HEADS (WHEREVER POSSIBLE), RAIN SENSORS, AND MULTI-PROGRAM COMPUTERIZED IRRIGATION CONTROLLERS FEATURING SENSORY INPUT CAPABILITIES.

ROOT BARRIERS


THE CONTRACTOR SHALL INSTALL ROOT BARRIERS NEAR ALL NEWLY PLANTED TREES THAT ARE LOCATED WITHIN FIVE (5) FEET OF PAVING, CURBS, WATER, STORM, OR SANITARY SEWER UTILITIES. ROOT BARRIERS SHALL BE "CENTURY" OR "DEEP-ROOT" 24" DEEP PANELS (OR EQUAL). BARRIERS SHALL BE LOCATED IMMEDIATELY ADJACENT TO HARDSCAPE. INSTALL PANELS PER MANUFACTURER'S RECOMMENDATIONS. UNDER NO CIRCUMSTANCES SHALL THE CONTRACTOR USE ROOT BARRIERS OF A TYPE THAT COMPLETELY ENCLOSE THE ROOTBALL.

MULCHES

AFTER ALL PLANTING IS COMPLETE, CONTRACTOR SHALL INSTALL 2" THICK LAYER OF 1-1/2" SHREDDED WOOD MULCH, NATURAL (UNDYED), OVER LANDSCAPE FABRIC IN ALL PLANTING AREAS (EXCEPT FOR TURF AND SEEDDED AREAS). CONTRACTOR SHALL SUBMIT PHOTOS OF ALL MULCHES TO LANDSCAPE ARCHITECT AND OWNER FOR APPROVAL PRIOR TO CONSTRUCTION. ABSOLUTELY NO EXPOSED GROUND SHALL BE LEFT SHOWING ANYWHERE ON THE PROJECT AFTER MULCH HAS BEEN INSTALLED (SUBJECT TO THE CONDITIONS AND REQUIREMENTS OF THE "GENERAL GRADING AND PLANTING NOTES" AND SPECIFICATIONS).

PLANTING & IRRIGATION GUARANTEE

THE LANDSCAPE CONTRACTOR SHALL GUARANTEE THAT ALL NEWLY INSTALLED AND EXISTING PLANTS SHALL SURVIVE FOR ONE YEAR AFTER FINAL OWNER ACCEPTANCE OF THE INSTALLATION WORK. THE CONTRACTOR SHALL ALSO BE RESPONSIBLE FOR APPROPRIATE WATERING OF THE LANDSCAPE THROUGH INSTALLATION OF A PROPERLY DESIGNED IRRIGATION SYSTEM. THE OWNER SHALL APPROVE THE SYSTEM DESIGN BEFORE INSTALLATION OF PLANTS OR IRRIGATION.


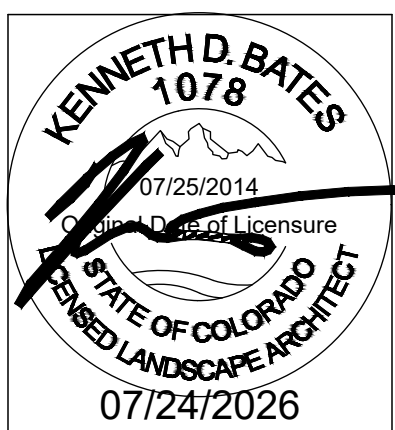


HONOR CHARTER
ACADEMY
BENT GRASS MEADOWS DRIVE
PEYTON, CO

LANDSCAPE NOTES & SPECIFICATIONS

Date	Comment
Project Number	
Date	07/24/2026
Drawn By	JML
Checked By	KB

 LP-3

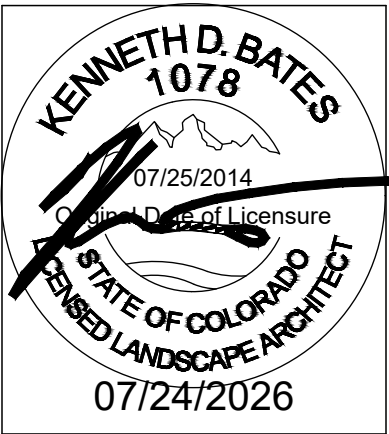

HONOR CHARTER
ACADEMY
BENT GRASS MEADOWS DRIVE
PEYTON, CO
















LANDSCAPE
SCHEDULE

Date	Comment

Project Number
Date07/24/2026
Drawn ByJML
Checked ByKB


LP-4

  PLANT SCHEDULE

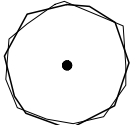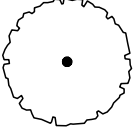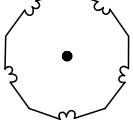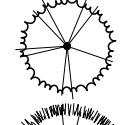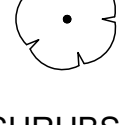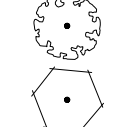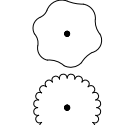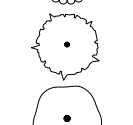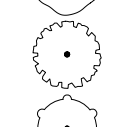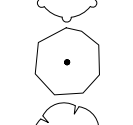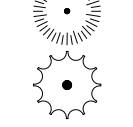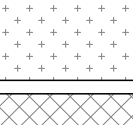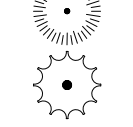
SYMBOL	CODE	BOTANICAL / COMMON NAME	SIZE	CONTAINER	QTY	MATURE HEIGHT	MATURE WIDTH
DECIDUOUS TREES							
	AT	Acer tataricum / Tatarian Maple	1.5" Cal.	Cont. or B&B	5	15 - 25ft. ht.	15 - 25ft. w.
	CS	Catalpa speciosa / Northern Catalpa	1.5" Cal.	Cont. or B&B	3	40 - 65ft. ht.	25 - 40ft. w.
	GS	Gleditsia triacanthos inermis 'Shademaster' / Shademaster Honey Locust	1.5" Cal.	Cont. or B&B	9	40 - 65ft. ht.	25 - 40ft. w.
EVERGREEN TREES							
	PF	Pinus flexilis 'Vanderwolf's Pyramid' / Vanderwolf's Pyramid Limber Pine	6' Ht.	Cont. or B&B	6	25 - 40ft. ht.	10 - 15ft. w.
	PP2	Pinus ponderosa / Ponderosa Pine	6' Ht.	Cont. or B&B	1	> 65ft. ht.	25 - 40ft. w.
ORNAMENTAL TREES							
	CC	Crataegus laevigata 'Crimson Cloud' / Crimson Cloud Hawthorn	1" Cal.	Cont. or B&B	2	15 - 25ft. ht.	15 - 25ft. w.
SHRUBS							
	AC	Arctostaphylos x coloradensis 'Chieftain' / Chieftain Mock Bearberry Manzanita	5 gal.	Cont.	14	3 - 6ft. ht.	3 - 6ft. w.
	CD	Caryopteris x clandonensis 'Dark Knight' / Dark Knight Bluebeard	5 gal.	Cont.	34	18 - 36in. ht.	1 - 3ft. w.
	CI	Cercocarpus intricatus / Littleleaf Mountain Mahogany	5 gal.	Cont.	5	3 - 6ft. ht.	3 - 6ft. w.
	CP	Cytisus purgans / Broom	5 gal.	Cont.	42	3 - 6ft. ht.	3 - 6ft. w.
	EA	Ericameria nauseosa nauseosa / Baby Blue Rabbitbrush	5 gal.	Cont.	23	18 - 36in. ht.	1 - 3ft. w.
	MA	Mahonia aquifolium / Oregon Grape	5 gal.	Cont.	9	3 - 6ft. ht.	3 - 6ft. w.
	PA	Perovskia atriplicifolia / Russian Sage	5 gal.	Cont.	21	3 - 6ft. ht.	3 - 6ft. w.
	SV	Spiraea x vanhouttei / Vanhoutte Spirea	5 gal.	Cont.	5	3 - 1ft. ht.	3 - 1ft. w.
	VL	Viburnum lantana 'Mohican' / Mohican Wayfaring Tree	15 gal.	Cont.	1	6 - 10ft. ht.	6 - 10ft. w.
	WA	Weigela florida 'Alexandra' / Wine & Roses® Weigela	5 gal.	Cont.	5	3 - 6ft. ht.	3 - 6ft. w.
GRASSES							
	BB	Bouteloua gracilis 'Blonde Ambition' / Blonde Ambition Blue Grama	5 gal.		40	18 - 36in. ht.	1 - 3ft. w.
	NP	Nassella tenuissima 'Pony Tails' / Pony Tails Mexican Feather Grass	5 gal.		48	18 - 36in. ht.	1 - 3ft. w.
GROUND COVERS							
	BL	Buchloe dactyloides 'Legacy' / Legacy Buffalo Grass	Seed or Sod		17,700 sf	< - 1ft. ht.	
	BG2	Native Grass / El Paso Native Shotgun Grass Seed Mix application rate of 10lbs / acre for broadcast application or 5lbs / acre for drilled application.	seed		209,976 sf	18 - 36in. ht.	1 - 3ft. w.
	GR	Riparian Seed Mix	seed		15,030 sf		
ROCK/STONE							
	CS2	2"-4" Local Cobblestone			3,481 sf		
	CF	Crushed Granite			7,605 sf		

SITE AMENITY SCHEDULE

SYMBOL	CODE	DESCRIPTION	QTY
	1	3'-4' Granite Boulder	4

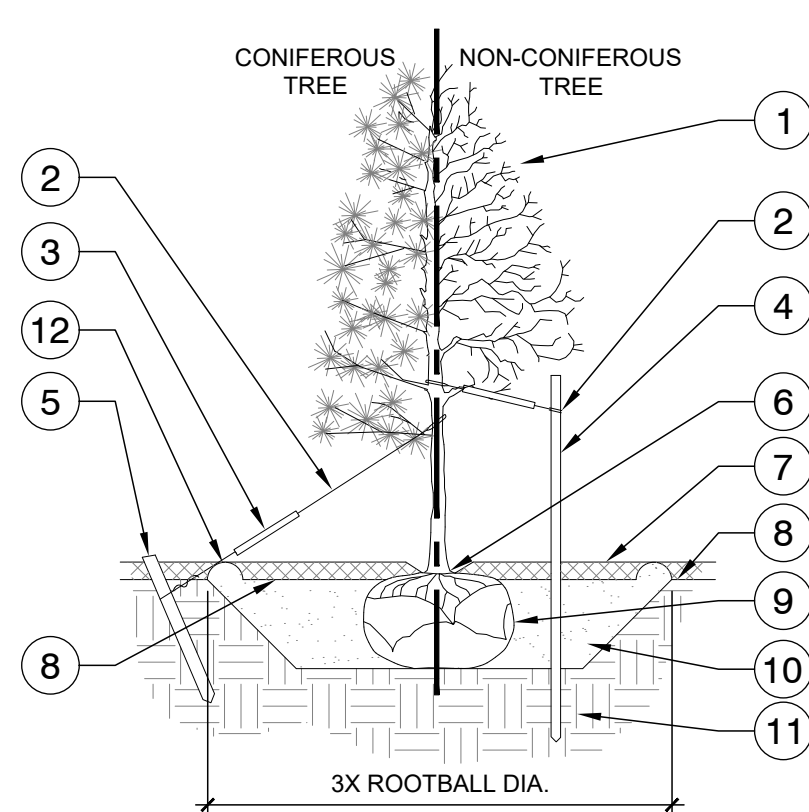

STAKING EXAMPLES (PLAN VIEW)

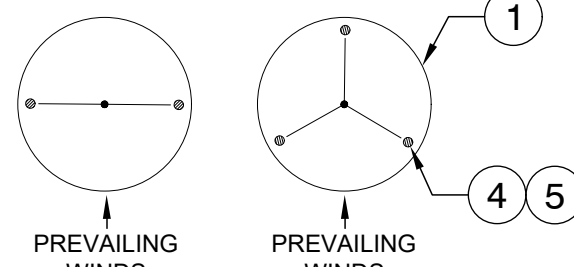


NOTES:

1. SCARIFY SIDES OF PLANTING PIT PRIOR TO SETTING TREE.
2. REMOVE EXCESS SOIL APPLIED ON TOP OF THE ROOTBALL THAT COVERS THE ROOT FLARE. THE PLANTING HOLE DEPTH SHALL BE SUCH THAT THE ROOTBALL RESTS ON UNDISTURBED SOIL, AND THE ROOT FLARE IS 2"-4" ABOVE FINISH GRADE.
3. FOR B&B TREES, CUT OFF BOTTOM 1/3 OF WIRE BASKET BEFORE PLACING TREE IN HOLE. CUT OFF AND REMOVE REMAINDER OF BASKET AFTER TREE IS SET IN HOLE. REMOVE ALL NYLON TIES, TWINE, ROPE, AND OTHER PACKING MATERIAL. REMOVE AS MUCH BURLAP FROM AROUND ROOTBALL AS IS PRACTICAL.
4. REMOVE ALL NURSERY STAKES AFTER PLANTING.
5. TREES SHALL NOT BE STAKED UNLESS LOCAL CONDITIONS REQUIRE STAKES TO KEEP TREES UPRIGHT. STAKING SHALL BE TIGHT ENOUGH TO PREVENT TRUNK FROM BENDING, BUT LOOSE ENOUGH TO ALLOW SOME TRUNK MOVEMENT IN WIND.
6. FOR TREES 36" BOX/2.5" CAL. AND LARGER, USE THREE STAKES OR DEADMEN (AS APPROPRIATE), SPACED EVENLY AROUND TREE.

A TREE PLANTING

NTS

000-PL-06

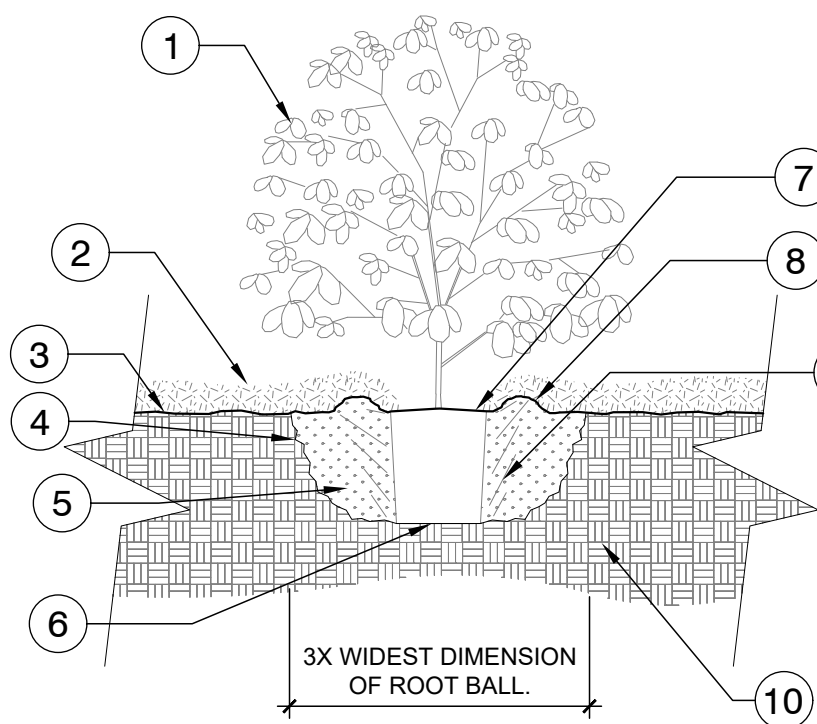

SECTION VIEW


NOTES:

1. SHRUBS SHALL BE OF QUALITY PRESCRIBED IN THE ROOT OBSERVATIONS DETAIL AND SPECIFICATIONS.
2. SEE SPECIFICATIONS FOR FURTHER REQUIREMENTS RELATED TO THIS DETAIL.

B SHRUB PLANTING

NTS

000-PL-02

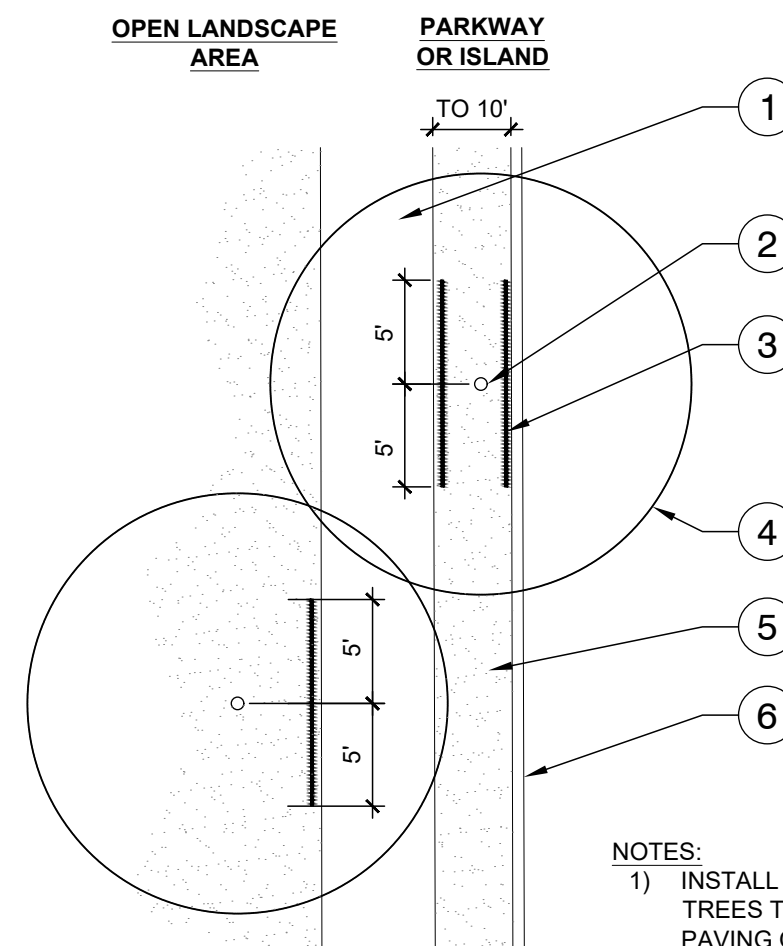


NOTES:

1. INSTALL ROOT BARRIERS NEAR ALL NEWLY-PLANTED TREES THAT ARE LOCATED WITHIN FIVE (5) FEET OF PAVING OR CURBS.
2. BARRIERS SHALL BE LOCATED IMMEDIATELY ADJACENT TO HARDSCAPE. UNDER NO CIRCUMSTANCES SHALL THE CONTRACTOR USE ROOT BARRIERS OF A TYPE THAT COMPLETELY ENCIRCLE THE ROOTBALL.

C ROOT BARRIER - PLAN VIEW

NTS

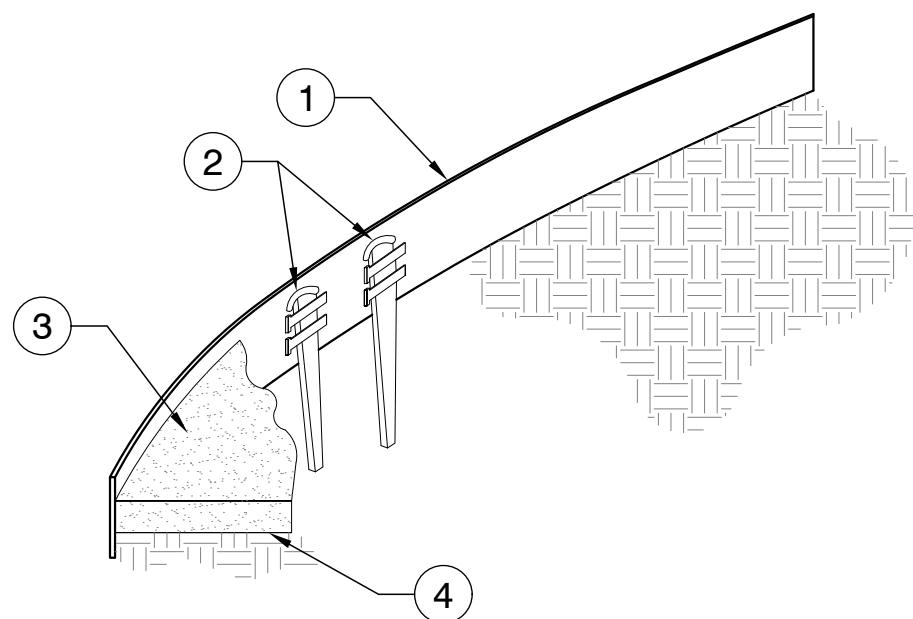


NOTES:

1. INSTALL EDGING SO THAT STAKES WILL BE ON INSIDE OF PLANTING BED.
2. BOTTOM OF EDGING SHALL BE BURIED A MINIMUM OF 1" BELOW FINISH GRADE.
3. TOP OF MULCH SHALL BE 1" LOWER THAN TOP OF EDGING.
4. STEEL EDGING SHOULD BE SMOOTH & CONSISTENT AT CURVES & SHOULD JOIN AT 90 DEGREE ANGLES UNLESS OTHERWISE NOTED.

D STEEL EDGING

NTS

000-ED-12

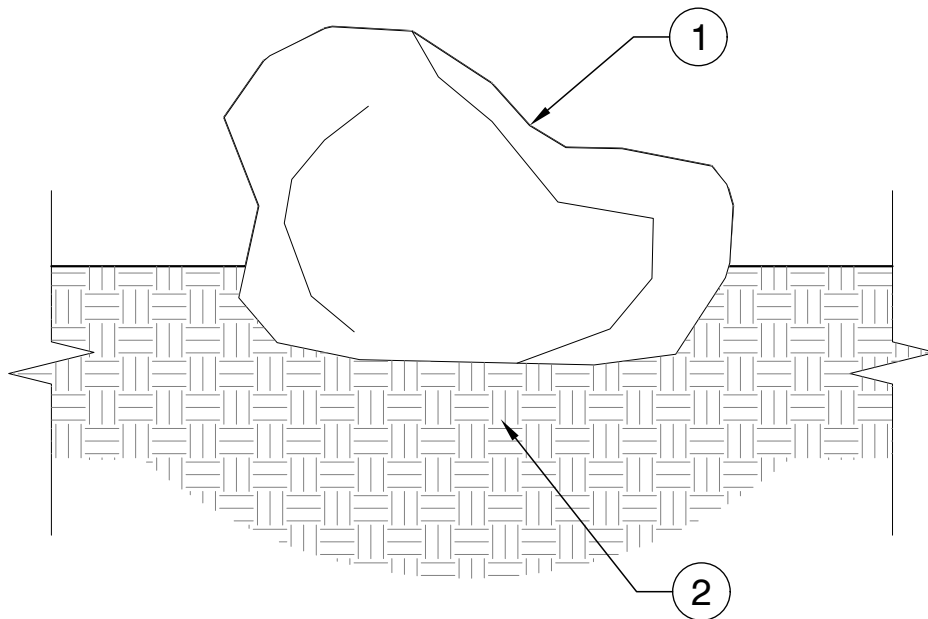

NOTES:

1. BOULDER SIZES SHALL BE AS NOTED ON THE PLANS. SUBMIT PHOTOS (MIN. OF 4) OF TYPICAL BOULDERS (CLOSE UP & AT DISTANCE) PRIOR TO DELIVERY FOR APPROVAL.

E LANDSCAPE BOULDER

NTS

000-HA-13

National Presence. Local Expertise.



EVERGREEN DESIGN GROUP
800.680.6630
www.evergreendesigngroup.com
LANDSCAPE ARCHITECTURE
LAND PLANNING • IRRIGATION DESIGN




HONOR CHARTER
ACADEMY
BENT GRASS MEADOWS DRIVE
PEYTON, CO

LANDSCAPE
DETAILS

Date	Comment

Project Number	
Date	07/24/2026
Drawn By	JML
Checked By	KB

LP-5

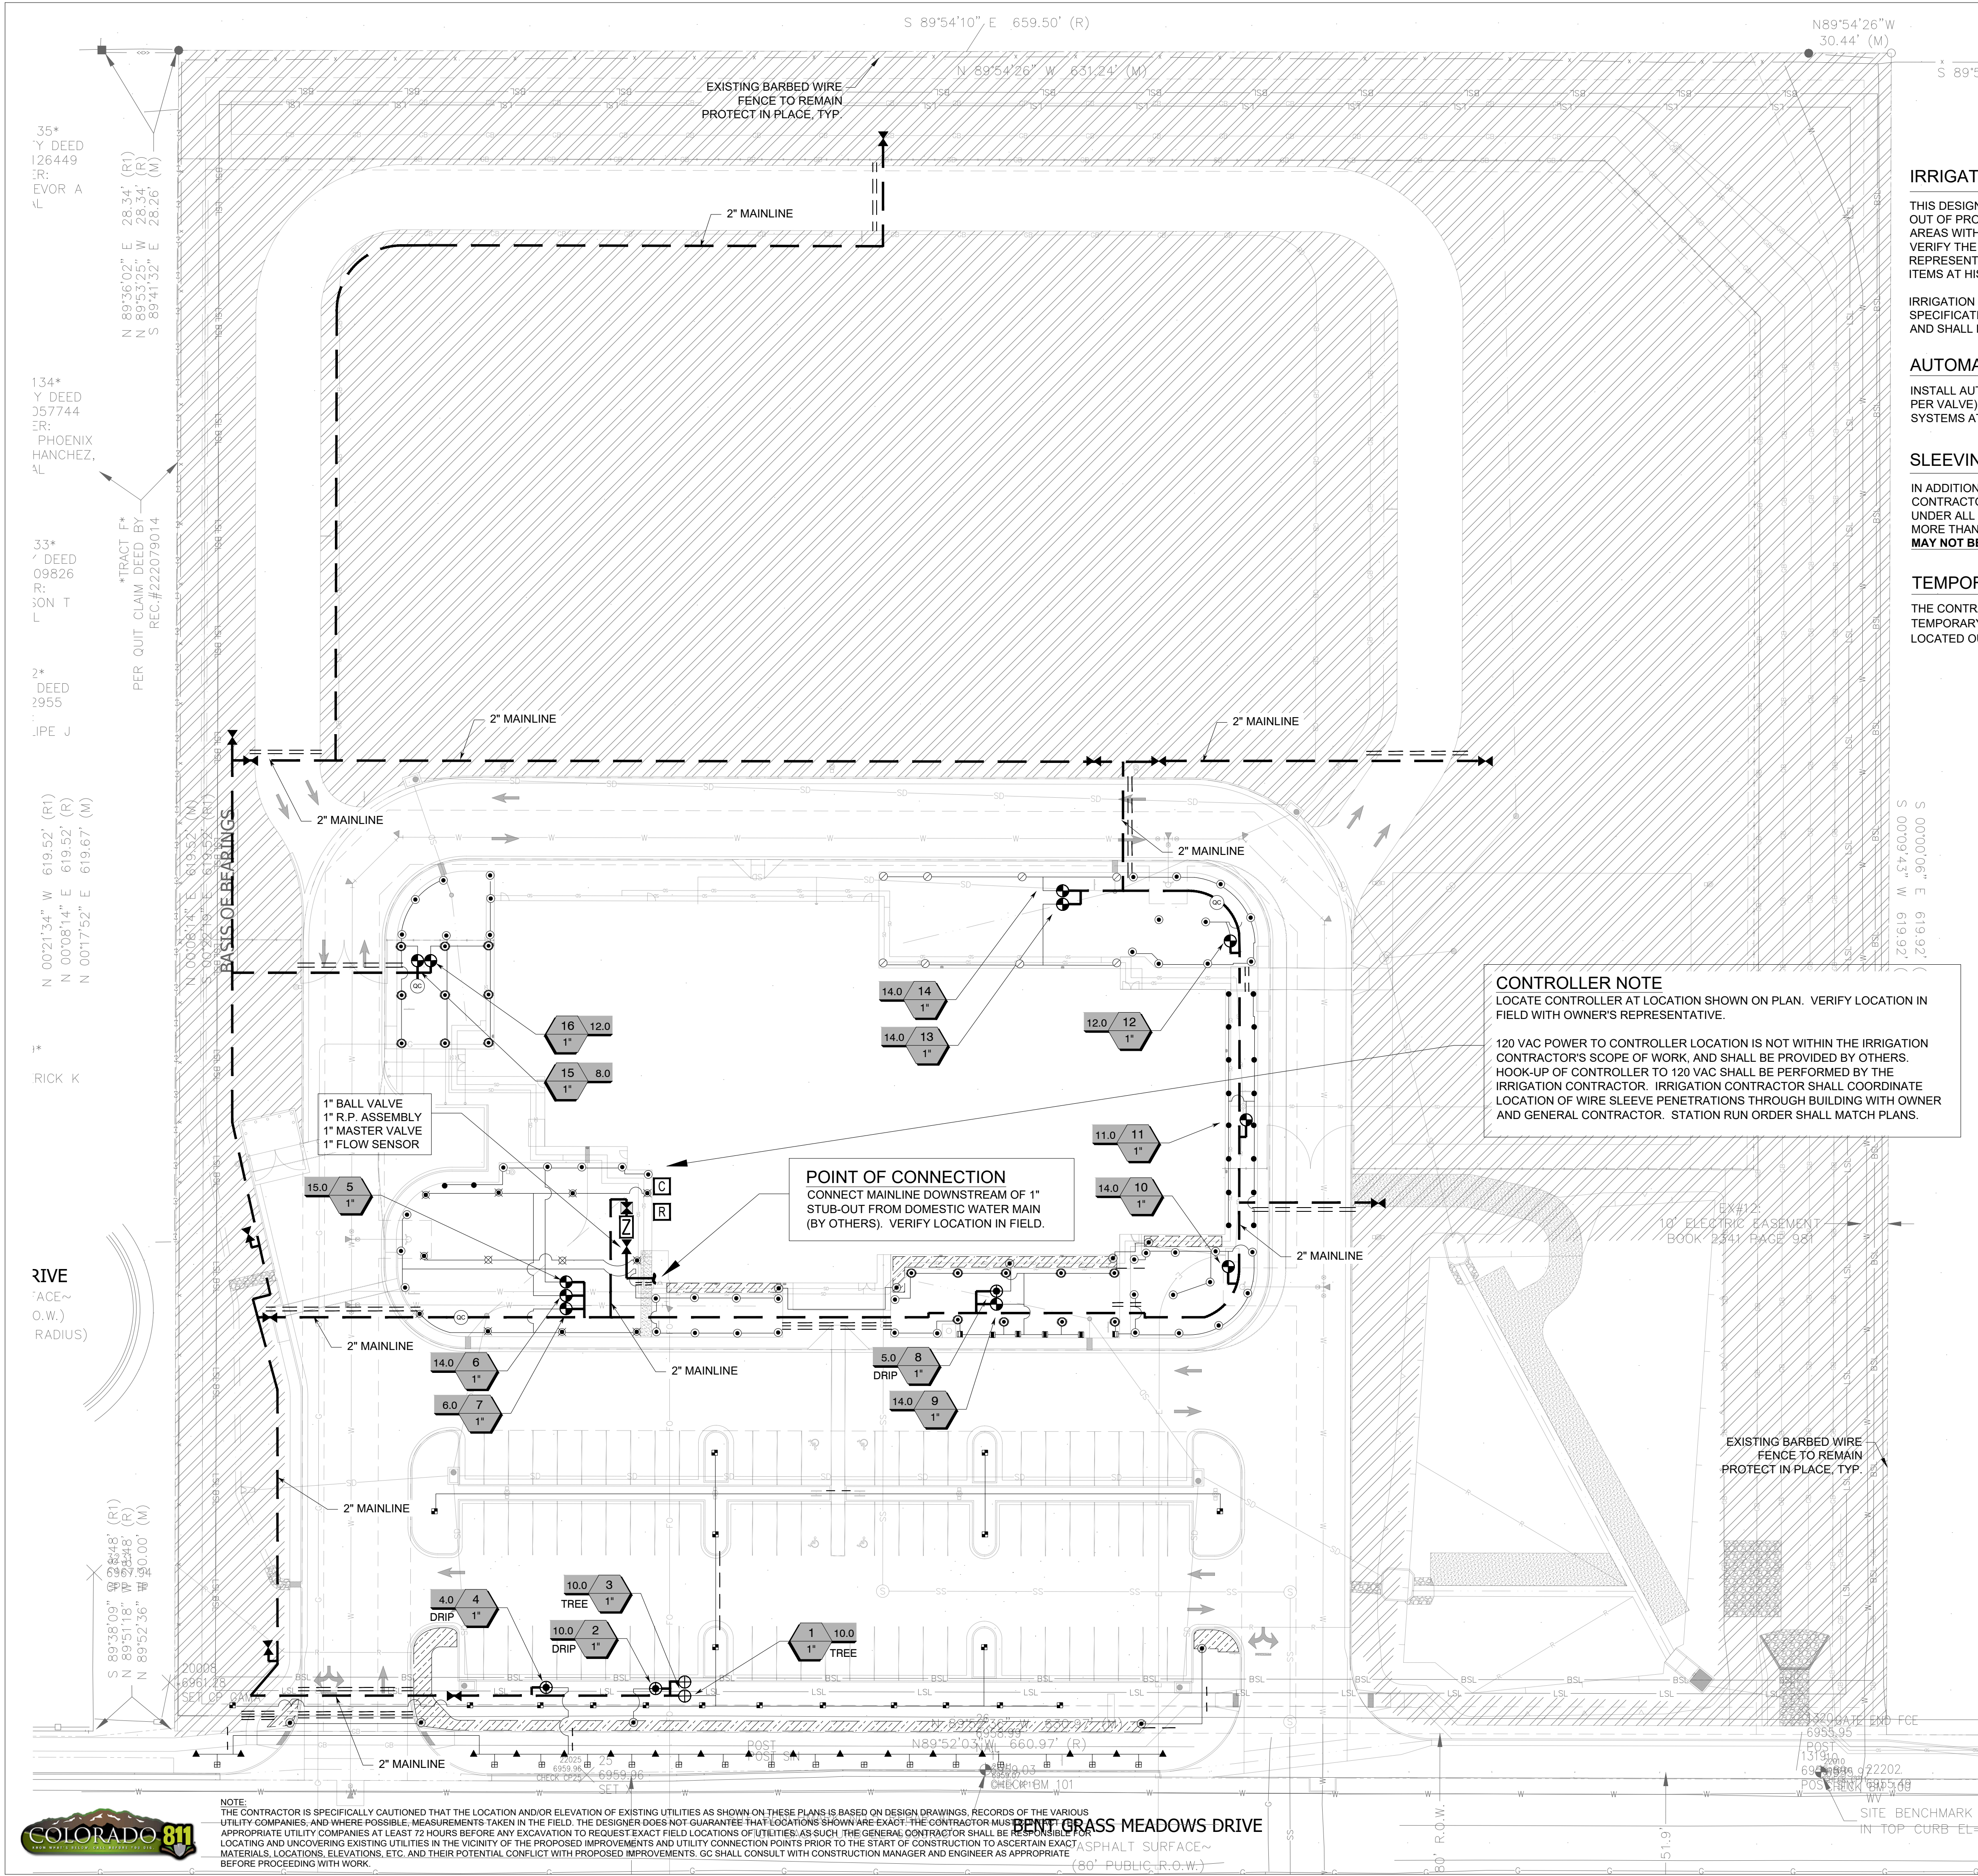

IRRIGATION DISCLAIMER

THIS DESIGN IS DIAGRAMMATIC. ALL PIPING, VALVES, AND OTHER EQUIPMENT SHOWN WITHIN PAVED AREAS OR OUT OF PROPERTY BOUNDARIES ARE FOR DESIGN CLARIFICATION ONLY, AND SHALL BE INSTALLED IN PLANTING AREAS WITHIN THE PROPERTY LINES OR LIMITS INDICATED ON PLAN. THE IRRIGATION CONTRACTOR SHALL VERIFY THE LOCATIONS OF ALL ABOVE-GRADE IRRIGATION EQUIPMENT WITH THE OWNER'S AUTHORIZED REPRESENTATIVE PRIOR TO INSTALLATION, OR IRRIGATION CONTRACTOR MAY BE REQUIRED TO MOVE SUCH ITEMS AT HIS OWN COST.

IRRIGATION CONTRACTOR IS RESPONSIBLE FOR VERIFYING ALL FINAL QUANTITIES PER DRAWINGS AND SPECIFICATIONS. ANY QUANTITIES PROVIDED ARE PROVIDED AS A CONVENIENCE TO THE CONTRACTOR ONLY AND SHALL NOT BE CONSIDERED ABSOLUTE.

AUTOMATIC DRAIN VALVES AND AIR RELIEF VALVES

INSTALL AUTOMATIC DRAIN VALVES AT THE LOW POINTS OF EACH LATERAL LINE (MIN. 2 PER VALVE) AS PER DETAIL ON SHEET LI-2. INSTALL AIR RELIEF VALVES ON DRIP SYSTEMS AT THE LOCATIONS SHOWN ON THE PLANS, AS PER DETAILS.

SLEEVING / WIRING NOTES:

IN ADDITION TO PROVIDING SLEEVES FOR ALL PIPING UNDER ROADWAYS AND WALKWAYS, THE IRRIGATION CONTRACTOR SHALL PROVIDE AND INSTALL SCH. 40 PVC SLEEVES FOR ALL CONTROLLER WIRES OCCURRING UNDER ALL ROADWAYS AND WALKWAYS. SLEEVES FOR CONTROLLER WIRES SHALL BE 2" DIA. AND CONTAIN NO MORE THAN 25 WIRES. **FOR PLAN CLARITY, ONLY SOME REPRESENTATIVE SLEEVES ARE SHOWN; SOME SLEEVES MAY NOT BE SHOWN.**

TEMPORARY IRRIGATION

THE CONTRACTOR SHALL COORDINATE WITH THE PLANTING PLAN AND PROVIDE TEMPORARY IRRIGATION FOR THE ESTABLISHMENT OF ALL PROPOSED PLANT MATERIALS LOCATED OUTSIDE THE LIMITS OF COVERAGE PROVIDED BY THE PERMANENT SYSTEM.

CONTROLLER NOTE
LOCATE CONTROLLER AT LOCATION SHOWN ON PLAN. VERIFY LOCATION IN FIELD WITH OWNER'S REPRESENTATIVE.

120 VAC POWER TO CONTROLLER LOCATION IS NOT WITHIN THE IRRIGATION CONTRACTOR'S SCOPE OF WORK, AND SHALL BE PROVIDED BY OTHERS. HOOK-UP OF CONTROLLER TO 120 VAC SHALL BE PERFORMED BY THE IRRIGATION CONTRACTOR. IRRIGATION CONTRACTOR SHALL COORDINATE LOCATION OF WIRE SLEEVE PENETRATIONS THROUGH BUILDING WITH OWNER AND GENERAL CONTRACTOR. STATION RUN ORDER SHALL MATCH PLANS.

POINT OF CONNECTION
CONNECT MAINLINE DOWNSTREAM OF 1" STUB-OUT FROM DOMESTIC WATER MAIN (BY OTHERS). VERIFY LOCATION IN FIELD.

1" BALL VALVE
1" R.P. ASSEMBLY
1" MASTER VALVE
1" FLOW SENSOR

EXISTING BARBED WIRE FENCE TO REMAIN PROTECT IN PLACE, TYP.

Scale 1" = 30'
NOTE: PRINTED DRAWING SIZE MAY HAVE CHANGED FROM ORIGINAL. VERIFY SCALE USING BAR SCALE ABOVE.

NOTE:
THE CONTRACTOR IS SPECIFICALLY CAUTIONED THAT THE LOCATION AND/OR ELEVATION OF EXISTING UTILITIES AS SHOWN ON THESE PLANS IS BASED ON DESIGN DRAWINGS, RECORDS OF THE VARIOUS UTILITY COMPANIES, AND WHERE POSSIBLE, MEASUREMENTS TAKEN IN THE FIELD. THE DESIGNER DOES NOT GUARANTEE THAT LOCATIONS SHOWN ARE EXACT. THE CONTRACTOR MUST CONSULT WITH THE APPROPRIATE UTILITY COMPANIES AT LEAST 72 HOURS BEFORE ANY EXCAVATION TO REQUEST EXACT FIELD LOCATIONS OF UTILITIES. AS SUCH, THE GENERAL CONTRACTOR SHALL BE RESPONSIBLE FOR LOCATING AND UNCOVERING EXISTING UTILITIES IN THE VICINITY OF THE PROPOSED IMPROVEMENTS AND UTILITY CONNECTION POINTS PRIOR TO THE START OF CONSTRUCTION TO ASCERTAIN EXACT MATERIALS, LOCATIONS, ELEVATIONS, ETC. AND THEIR POTENTIAL CONFLICT WITH PROPOSED IMPROVEMENTS. GC SHALL CONSULT WITH CONSTRUCTION MANAGER AND ENGINEER AS APPROPRIATE BEFORE PROCEEDING WITH WORK.

National Presence. Local Expertise.

EVERGREEN DESIGN GROUP
800.680.6630
www.evergreendesigngroup.com
LANDSCAPE ARCHITECTURE
LAND PLANNING • IRRIGATION DESIGN

KENNETH D. BATES
1078
07/25/2014
Professional Seal
STATE OF COLORADO
RESIDED LANDSCAPE ARCHITECT
07/24/2026


HONOR CHARTER ACADEMY
BENT GRASS MEADOWS DRIVE
PEYTON, CO

SCHEMATIC IRRIGATION PLAN

Date	Comment


Project Number
Date 06/26/2026
Drawn By JML
Checked By KB

LI-1

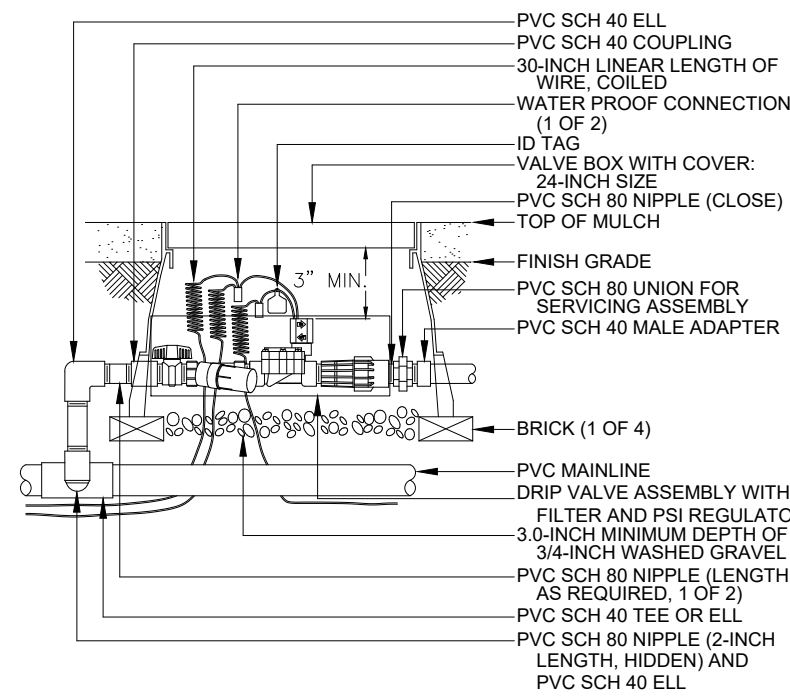


CONTROL ZONE KIT

N.T.S.

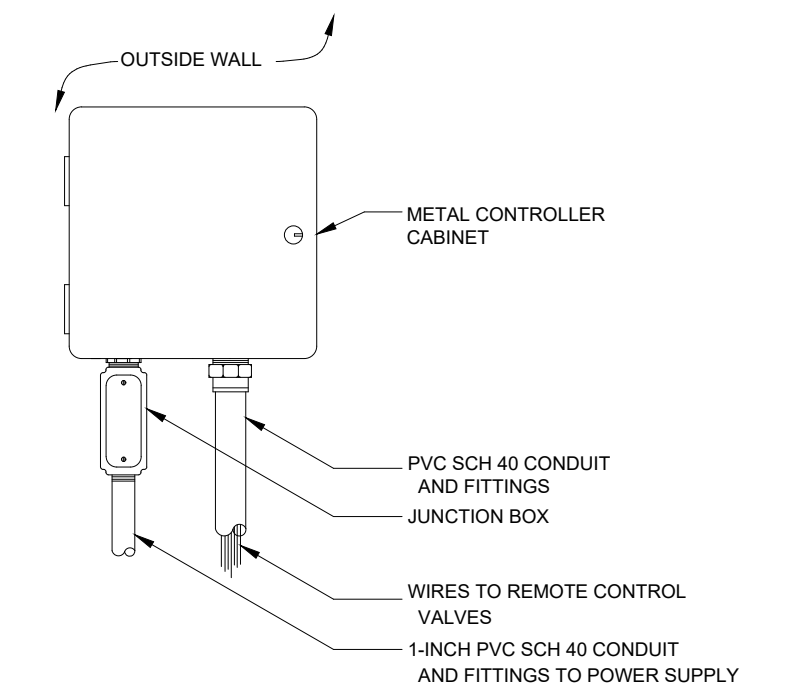


WALL MOUNT CONTROLLER

N.T.S.

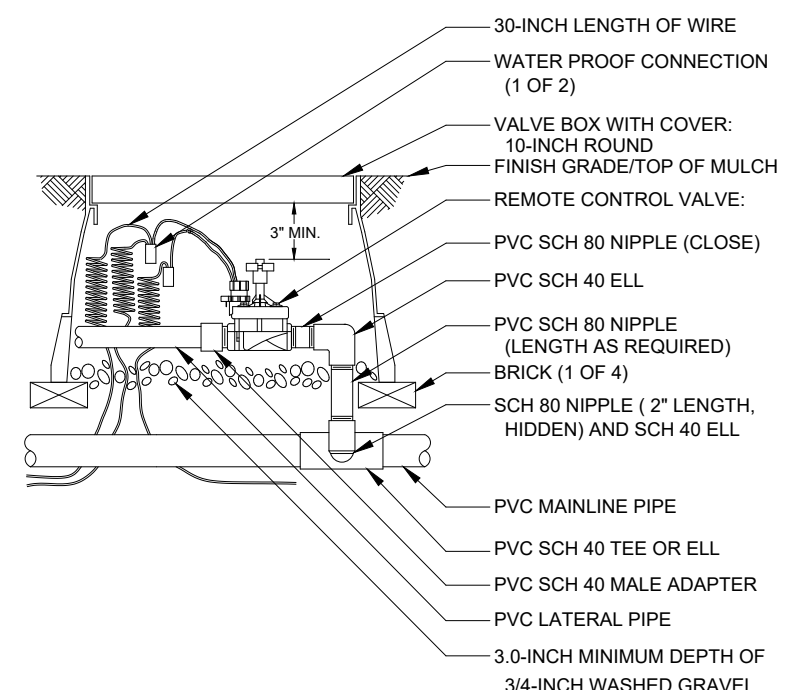


REMOTE CONTROL VALVE

N.T.S.

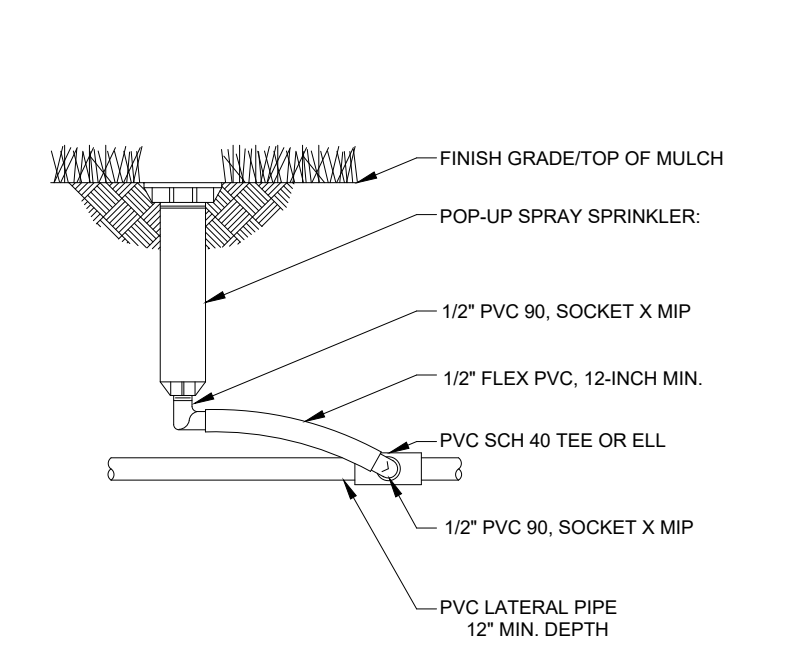


POP-UP SPRAY HEAD

N.T.S.

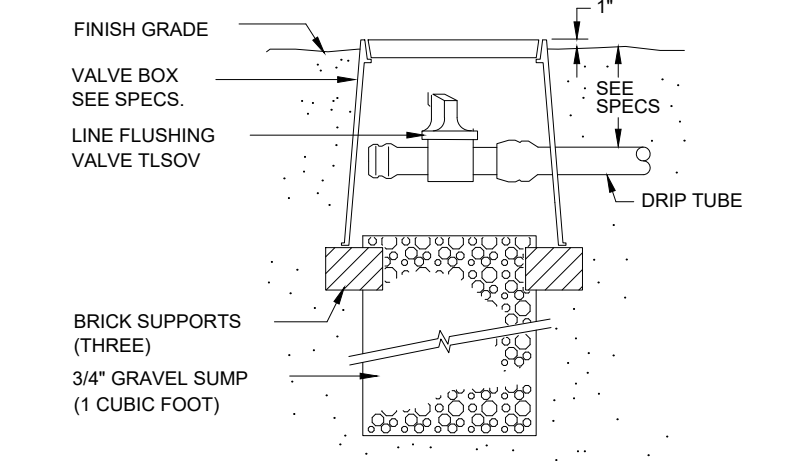


MANUAL LINE FLUSH VALVE

N.T.S.

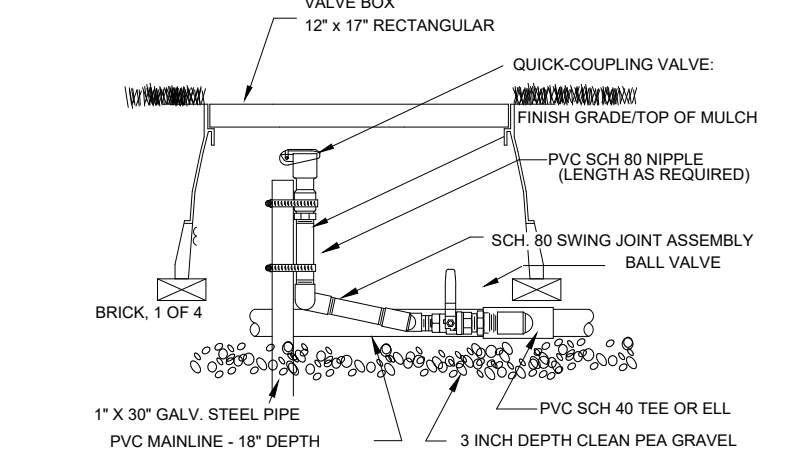


QUICK COUPLER VALVE WITH PVC BALL VALVE

N.T.S.

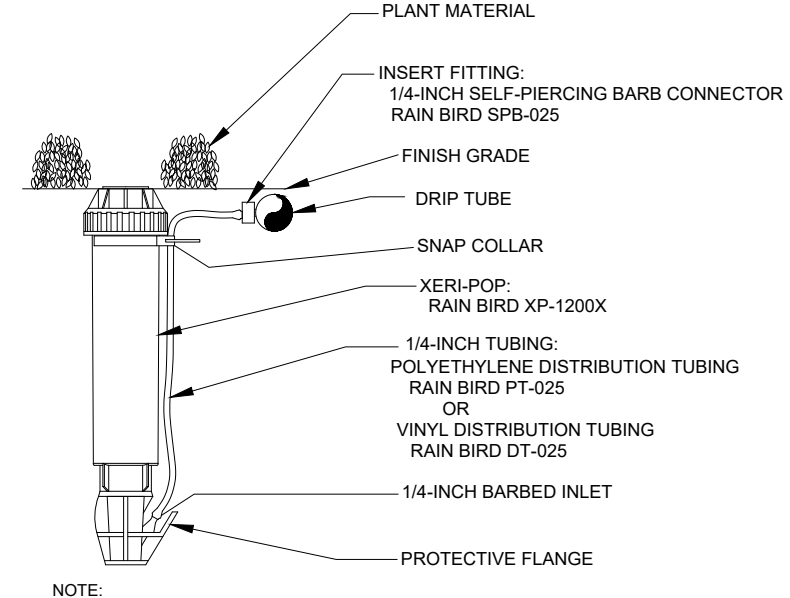


NOTE:
USE XERIMAN TOOL XM-T001 TO INSERT BARB CONNECTOR DIRECTLY INTO 1/2-INCH POLYETHYLENE TUBING.
LOCATE AT FURTHEST DISTANCE FROM DRIP VALVE ASSEMBLY, ADJACENT TO EDGING OR WITHIN LOW PLANTINGS FOR OPTIMUM VIEWING, WITH CLOSED SPRAY NOZZLE.

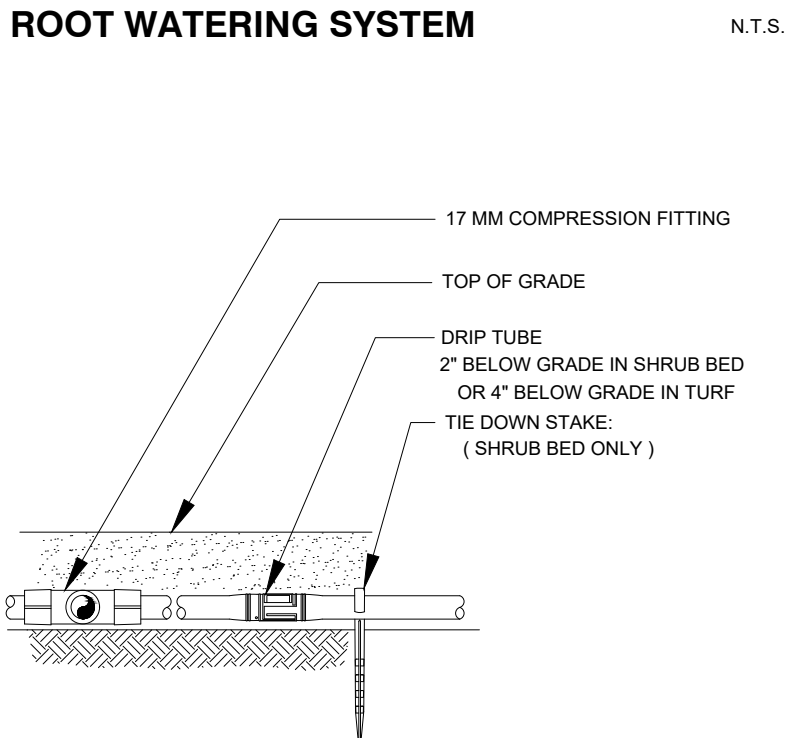

ROOT WATERING SYSTEM


N.T.S.

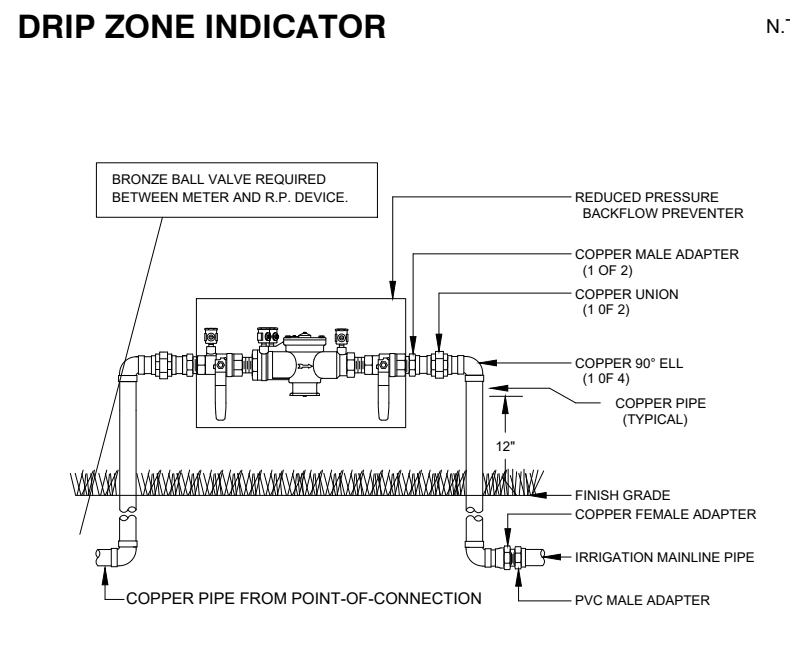

DRIP ZONE INDICATOR

N.T.S.

NOTE:
1. INSTALL BACKFLOW PREVENTER AS REQUIRED BY LOCAL CODES AND HEALTH DEPARTMENT. VERIFY LOCAL REQUIREMENTS PRIOR TO INSTALLATION.

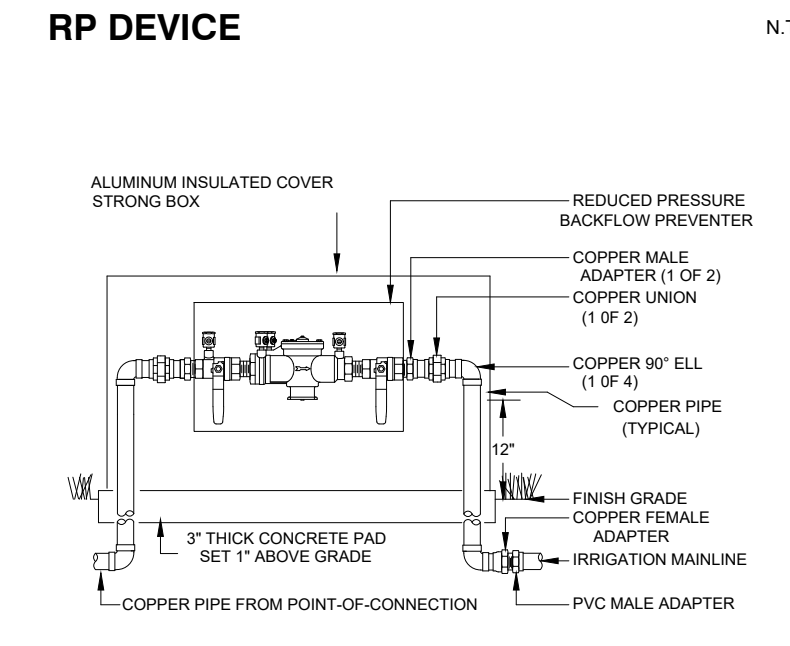


RP DEVICE

N.T.S.

NOTE:
1. INSTALL BACKFLOW PREVENTER AS REQUIRED BY LOCAL CODES. VERIFY LOCAL REQUIREMENTS PRIOR TO INSTALLATION.

RP DEVICE WITH INSULATED COVER


N.T.S.

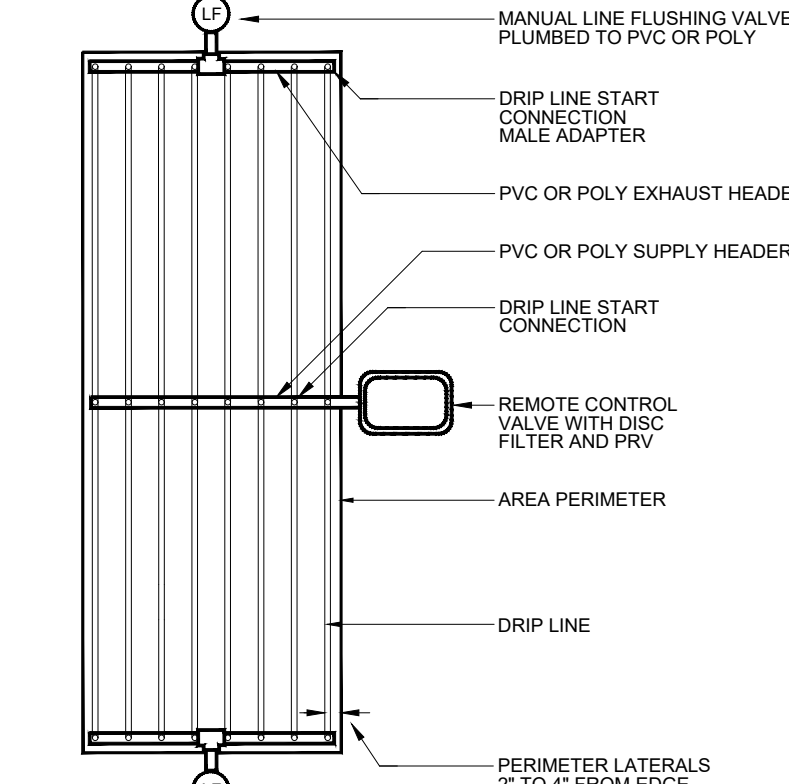

SUPPLY AND EXHAUST HEADERS SHALL BE CLASS 200 PVC PIPE, OF THE SAME DIAMETER AS THE ZONE VALVE SIZE.
USE DRIP TUBE FOR SUPPLY AND EXHAUST HEADERS ON GRIDS WITH FLOW SMALLER THAN 5 GPM ONLY.

DRIP CENTER FEED LAYOUT


N.T.S.

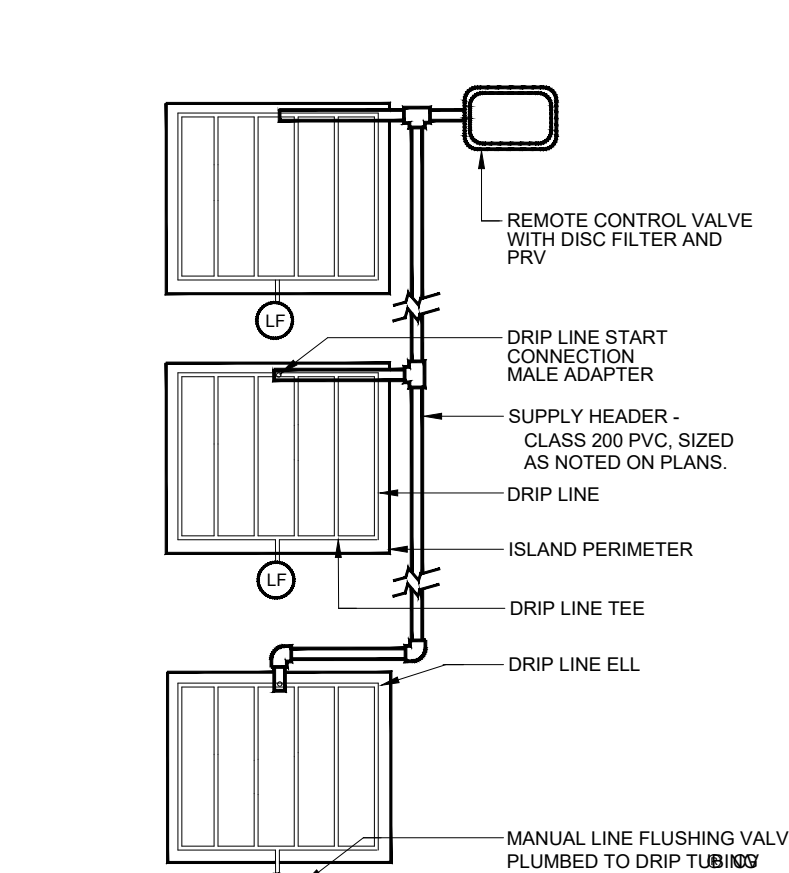

USE DRIP TUBE FOR SUPPLY AND EXHAUST HEADERS ON GRIDS WITH FLOW SMALLER THAN 5 GPM ONLY.

DRIP ISLAND LAYOUT

N.T.S.

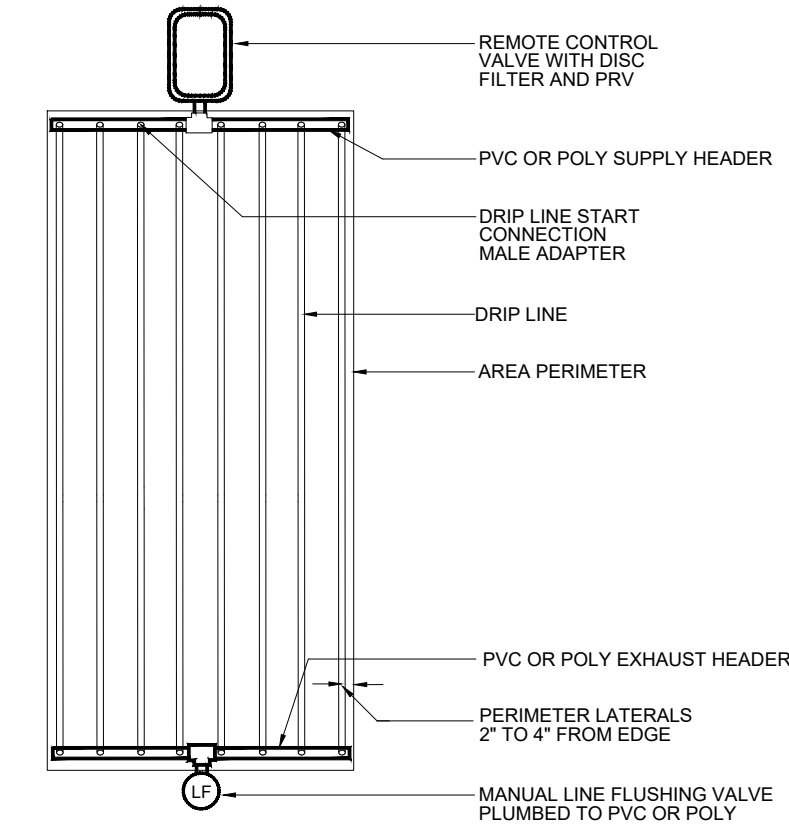


SUPPLY AND EXHAUST HEADERS SHALL BE CLASS 200 PVC PIPE, OF THE SAME DIAMETER AS THE ZONE VALVE SIZE.


USE DRIP TUBE FOR SUPPLY AND EXHAUST HEADERS ON GRIDS WITH FLOW SMALLER THAN 5 GPM ONLY.

DRIP END FEED LAYOUT

N.T.S.

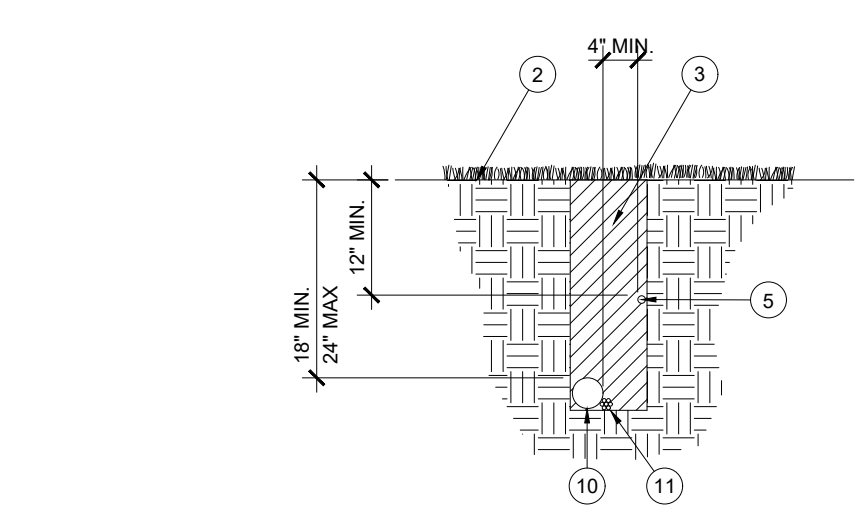


TRENCHING

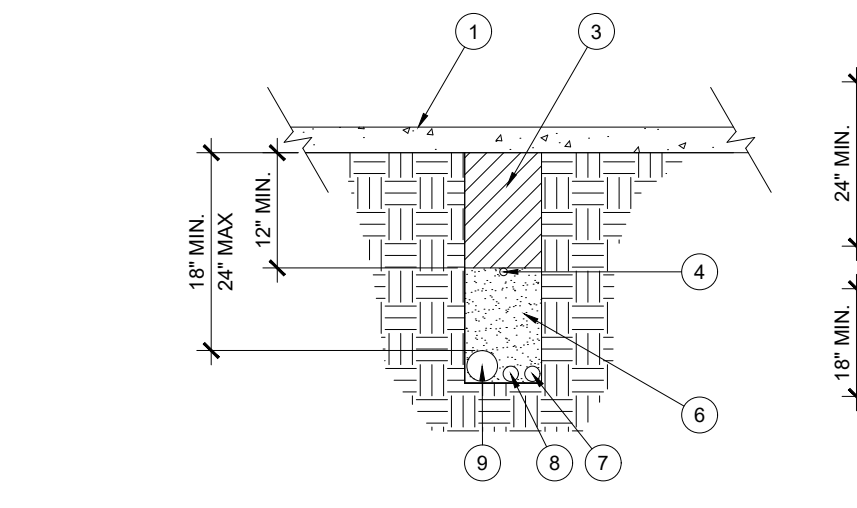

SLEEVEING

PIPE AND SLEEVE INSTALLATION



N.T.S.

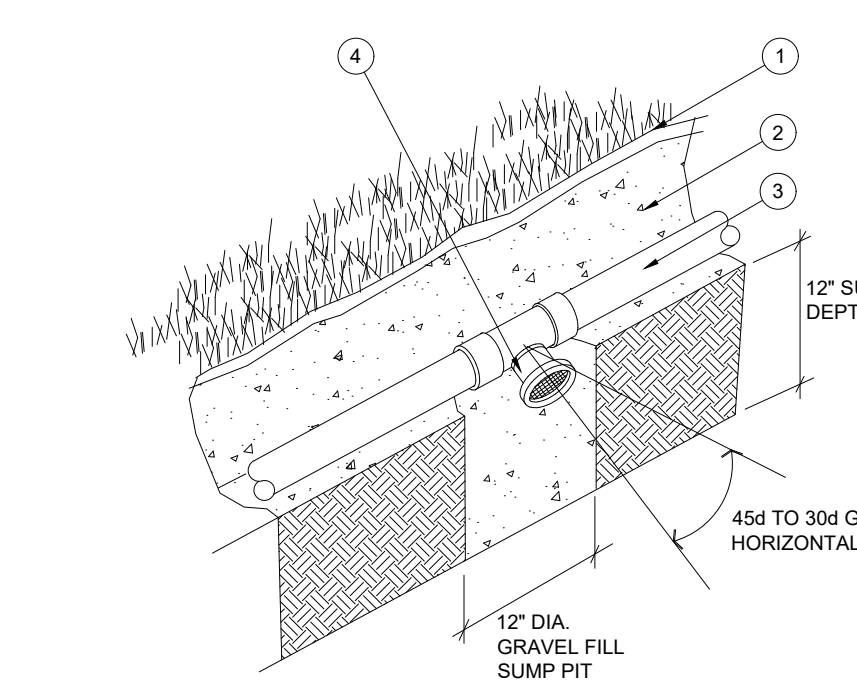

NOTE:
AUTOMATIC VALVES ARE TO BE LOCATED AT LOW POINTS OF LATERAL LINES.
LOCATE END DRAIN VALVE 12\"/>

AUTOMATIC DRAIN VALVE


N.T.S.

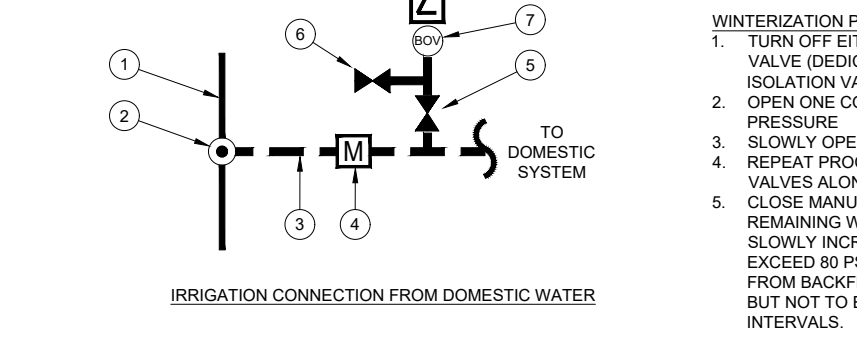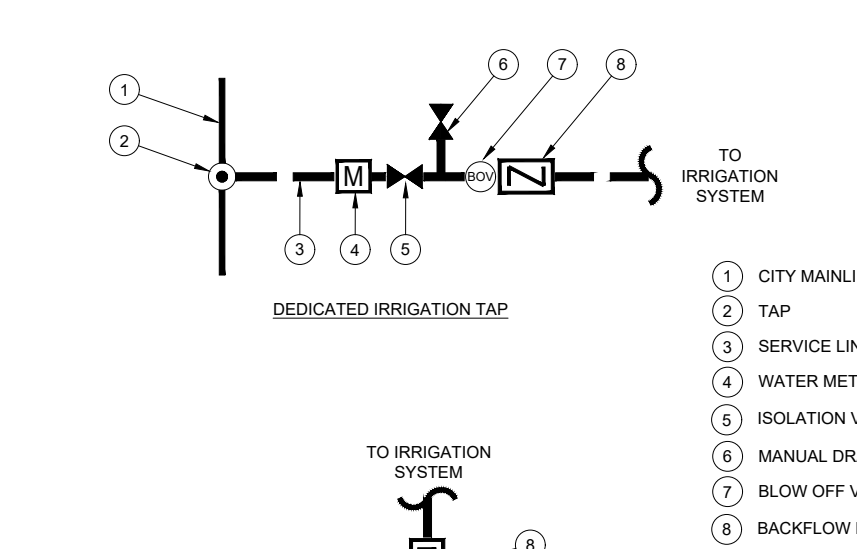

WATER TAP DIAGRAM


N.T.S.

1. PAVEMENT SURFACE
2. FINISH GRADE
3. TRENCH BACKFILL
4. LOCATOR WIRE W/ BURIED CAUTION TAPE
5. PVC IRRIGATION LATERAL
6. SAND BACKFILL
7. SCH. 40 PVC LATERAL SLEEVE - SEE PLANS FOR SIZE
8. SCH. 40 PVC WIRE SLEEVE FOR CONTROL WIRES, MIN. 2" DIA.
9. SCH. 40 PVC MAINLINE SLEEVE - SEE PLANS FOR SIZE
10. PVC IRRIGATION MAINLINE
11. CONTROL WIRES - TAPE TO MAINLINE AT 10' INTERVALS
12. PVC CAP, SOLVENT WELDED

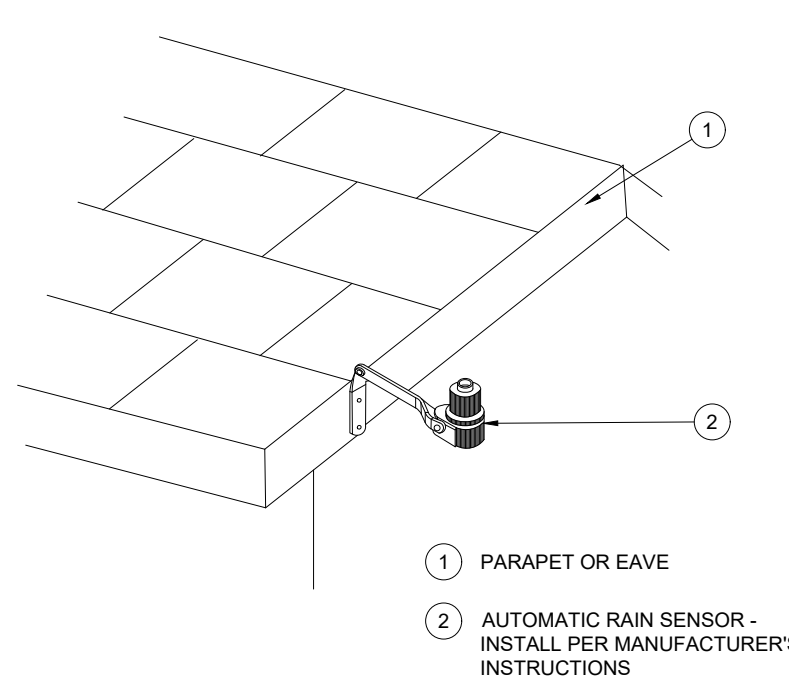


RAIN SENSOR, ROOF MOUNT

N.T.S.

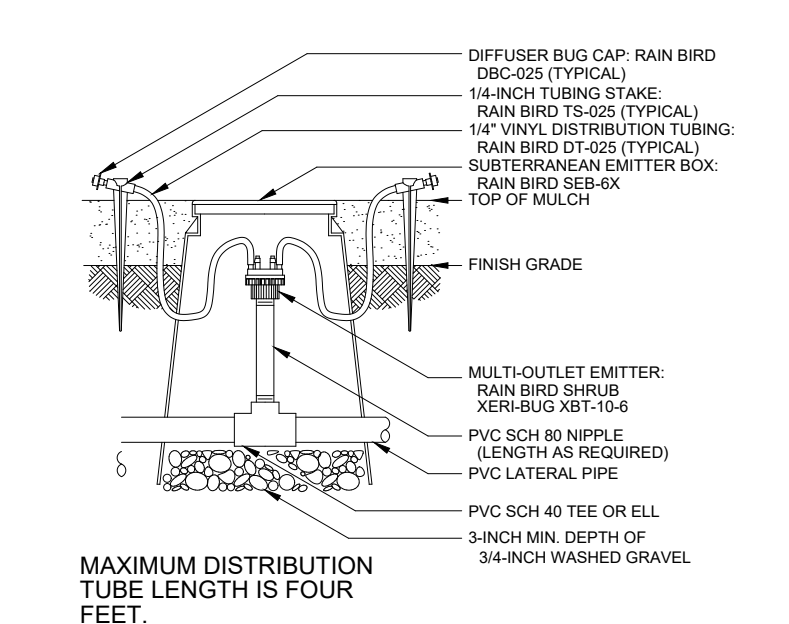

XBT MULTI-OUTLET EMITTER / BOX

N.T.S.

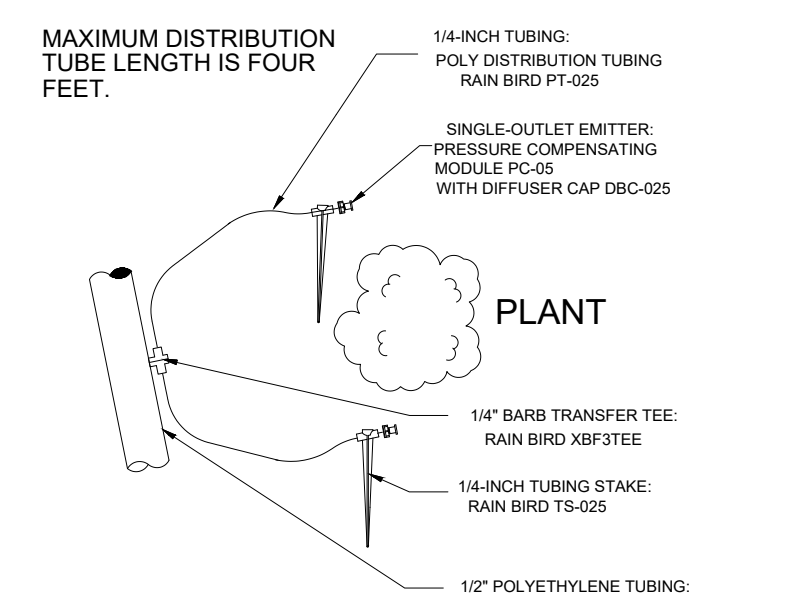

XERI-BUG EMITTER

N.T.S.

IRRIGATION
DETAILS

Date	Comment

Project Number	
Date	06/26/2026
Drawn By	JML
Checked By	KB



IRRIGATION SPECIFICATIONS

GENERAL

- A. QUALIFICATIONS OF IRRIGATION CONTRACTOR
- ALL WORK SHOWN ON THESE PLANS SHALL BE PERFORMED BY A SINGLE IRRIGATION CONTRACTING FIRM SPECIALIZING IN IRRIGATION SYSTEMS. SEE THE IRRIGATION PLAN FOR SPECIFIC EQUIPMENT AND SYSTEM LAYOUT.
 - THE IRRIGATION CONTRACTOR MUST HAVE ON ITS STAFF A LICENSED IRRIGATION INSTALLER, AS REGULATED BY THE APPROPRIATE LOCAL JURISDICTION. A LICENSED IRRIGATION INSTALLER SHALL BE PRESENT AT THE PROJECT SITE AT ALL TIMES AS WORK IS IN PROGRESS. THE OWNER MAY DEMAND THAT WORK STOP UNTIL THE CONTRACTOR PROVIDES FOR A LICENSED IRRIGATION INSTALLER TO BE PRESENT AT THE PROJECT SITE AND SUPERVISING ALL IRRIGATION WORK.
 - A LIST OF SUCCESSFULLY COMPLETED PROJECTS OF THIS TYPE, SIZE AND NATURE MAY BE REQUESTED BY THE OWNER FOR FURTHER QUALIFICATION MEASURES.
- B. SCOPE OF WORK
- WORK COVERED BY THESE SECTIONS INCLUDES THE FURNISHING AND PAYMENT OF ALL MATERIALS, LABOR, SERVICES, EQUIPMENT, LICENSES, TAXES, FEES, AND ANY OTHER ITEMS THAT ARE NECESSARY FOR THE EXECUTION, INSTALLATION AND COMPLETION OF ALL WORK SPECIFIED HEREIN AND/OR SHOWN ON THE IRRIGATION PLANS, NOTES, AND DETAILS.
 - ALL WORK SHALL BE PERFORMED IN ACCORDANCE WITH ALL APPLICABLE LAWS, CODES AND REGULATIONS REQUIRED BY AUTHORITIES HAVING JURISDICTION OVER SUCH WORK, INCLUDING ALL INSPECTIONS AND PERMITS REQUIRED BY FEDERAL, STATE AND LOCAL AUTHORITIES IN SUPPLY, TRANSPORTATION AND INSTALLATION OF MATERIALS. IN CASE OF CONFLICT BETWEEN THESE PLANS AND LOCAL AND/OR STATE CODES, CODES SHALL PREVAIL.
 - THE INTENT OF THE IRRIGATION SYSTEM IS TO PROVIDE 100% COVERAGE OF ALL LANDSCAPE AREAS. THE IRRIGATION PLAN IS GENERALLY DIAGRAMMATIC. COORDINATE IRRIGATION INSTALLATION WITH UTILITY INSTALLATIONS. ACTUAL LOCATION OF CONTROLLER, BACKFLOW DEVICE, PIPING, VALVES, SPRAY HEADS, DRIP IRRIGATION, AND RELATED EQUIPMENT MAY NEED TO BE ADJUSTED BASED ON ACTUAL SITE CONDITIONS.
 - FOR CLARITY PURPOSES, SOME IRRIGATION LINES AND EQUIPMENT ARE SHOWN IN HARDCAPE AREAS WITHOUT ACCESS SLEEVES; THESE LINES SHALL BE INSTALLED IN A COMMON TRENCH OR AT THE BACK OF CURB IN LANDSCAPE AREAS. MINOR FIELD ADJUSTMENTS SHALL BE MADE AT NO ADDITIONAL COST TO THE OWNER.

 
 
PRODUCTS

- A. ALL MATERIALS SHALL BE NEW AND WITHOUT FLAWS OR DEFECTS OF ANY TYPE AND SHALL BE THE BEST OF THEIR CLASS AND KIND. ALL MATERIALS SHALL HAVE A MINIMUM GUARANTEE OF ONE YEAR AGAINST MATERIAL DEFECTS OR DEFECTIVE WORKMANSHIP. ALL MATERIALS SHALL BE OF THE BRANDS AND TYPES NOTED ON THE DRAWINGS OR AS SPECIFIED HEREIN, OR APPROVED EQUAL. THE CONTRACTOR MUST FIRST OBTAIN APPROVAL FROM THE IRRIGATION DESIGNER FOR AN APPROVED EQUAL BEFORE INSTALLING SUCH MATERIALS IN THE FIELD, OR THE CONTRACTOR MAY BE REQUIRED TO REPLACE SUCH MATERIALS AT HIS OWN COST.
- B. BACKFLOW PREVENTION DEVICES SHALL BE OF THE SIZE AND TYPE INDICATED ON THE DRAWINGS. INSTALL BACKFLOW PREVENTION UNITS IN ACCORDANCE WITH IRRIGATION CONSTRUCTION DETAILS AND ALL APPLICABLE STATE AND LOCAL CODES AND ORDINANCES.
- C. PIPING
- PRESSURE SUPPLY LINES, DOWNSTREAM OF THE POINT-OF-CONNECTION:
 - SCHEDULE 40 PVC FOR ALL PIPE 1-1/2" OR LESS
 - CLASS 315 PVC FOR ALL PIPE 2" TO 2-1/2"
 - CLASS 200 PVC, CASKED, FOR ALL PIPE 3" AND LARGER
 - SLEEVING AND NON-PRESSURE LATERAL LINES (DOWNSTREAM FROM VALVES): CLASS 200 PVC
 - FITTINGS: SCH. 40 PVC, EXCEPT AS NOTED OTHERWISE.
- D. VALVES AND DRIP VALVE ASSEMBLIES: TYPE AND SIZE AS NOTED ON PLANS. EACH VALVE SHALL BEAR A PRE-MANUFACTURED, NUMBERED WATERPROOF TAG BEARING A NUMBER CORRESPONDING TO ITS VALVE SEQUENCE OF OPERATION ON THE CONTROLLER. THE OPERATION SEQUENCE SHALL MATCH THAT AS SHOWN ON THE PLANS.
- E. QUICK COUPLERS, BALL VALVES, AND GATE VALVES: TYPE AND SIZE PER PLANS.
- F. VALVE BOXES: TYPE AND SIZE AS NOTED ON DETAILS. ALL VALVES BOXES SHALL BE LOCKING BOLT-DOWN TYPE, FURNISHED WITH LIDS AND BOLTS. BOXES SHALL BE OF A SIZE TO CONTAIN THE ENTIRE VALVE AND/OR VALVE ASSEMBLY. THE VALVE BOX LID SHALL HAVE THE VALVE STATION NUMBER HEAT-BRANDED INTO THE LID WITH 2" HIGH LETTERS.
- G. FIXED SPRAY HEADS AND ROTORS: PLASTIC BODY POP-UP, WITH A REMOVABLE PLASTIC SPRAY NOZZLE. EXACT TYPE, MODEL, AND NOZZLE SHALL BE AS INDICATED ON PLANS.
- H. INTEGRAL EMITTER DRIP TUBING: TUBING MODEL AND FLOW RATE AS NOTED ON PLANS, WITH INTEGRAL EMITTERS WELDED TO THE INSIDE WALL OF THE TUBING AS AN INTEGRAL PART OF THE TUBING ASSEMBLY.
- I. AUTOMATIC CONTROLLER: TYPE AND MODEL PER PLANS. PROVIDE VANDAL-PROOF ENCLOSURE FOR ALL EXTERIOR INSTALLATIONS. PROVIDE LINE-VOLTAGE DISCONNECT SWITCH WITH GROUND FAULT PROTECTION.
- J. 24 VOLT VALVE WIRE SHALL BE A MINIMUM OF #14 GAUGE, U.F. APPROVED FOR DIRECT BURIAL. SINGLE CONDUCTOR IRRIGATION WIRE. EACH CONTROLLER SHALL HAVE A DIFFERENT COLOR STATION AND COMMON WIRE.
- STATION WIRE - ANY COLOR EXCEPT WHITE OR BLUE
 - COMMON WIRE - WHITE
- K. EXTRA COMMON WIRES - BLUE
- L. WIRE SPLICES SHALL BE ENCASED IN A WATERPROOF COMPOUND OR GEL. ALL FIELD SPLICES SHALL BE LOCATED IN A 6 INCH ROUND VALVE BOX.
- L. RAIN SENSOR: TYPE AND MODEL PER PLANS.

METHODS

- A. THIS DESIGN IS DIAGRAMMATIC. ALL PIPING, VALVES, AND OTHER EQUIPMENT SHOWN WITHIN PAVED AREAS OR OUT OF PROPERTY BOUNDARIES ARE FOR DESIGN CLARIFICATION ONLY, AND SHALL BE INSTALLED IN PLANTING AREAS WITHIN THE PLANTING LINES OR LIMITS INDICATED ON PLAN. THE IRRIGATION CONTRACTOR SHALL VERIFY THE LOCATIONS OF ALL ABOVE-GRADE IRRIGATION EQUIPMENT WITH THE OWNER'S AUTHORIZED REPRESENTATIVE PRIOR TO INSTALLATION, OR IRRIGATION CONTRACTOR MAY BE REQUIRED TO MOVE SUCH ITEMS AT HIS OWN COST. ENSURE FIELD COORDINATION IS MADE EARLY ON IN THE CONSTRUCTION PHASE SO PLACEMENT LOCATION IS CORRECT.
- B. THE IRRIGATION CONTRACTOR SHALL MEET WITH THE OWNER'S REPRESENTATIVE PRIOR TO COMMENCEMENT OF WORK, AND SHALL OBTAIN ALL ENGINEERING, LANDSCAPE, AND OTHER APPLICABLE PLANS & DOCUMENTS. THE CONTRACTOR SHALL THOROUGHLY REVIEW THE PLANS AND REPORT ANY CONFLICTS OR DISCREPANCIES TO THE LANDSCAPE ARCHITECT AND OWNERS REPRESENTATIVE IMMEDIATELY.
- C. THE IRRIGATION CONTRACTOR SHALL NOT WILLFULLY INSTALL THE IRRIGATION SYSTEM AS SHOWN ON THE DRAWINGS WHEN IT IS OBVIOUS IN THE FIELD THAT UNKNOWN OBSTRUCTIONS, GRADES OR DIMENSIONS EXIST THAT MIGHT NOT HAVE BEEN CONSIDERED IN THE ENGINEERING. SUCH OBSTRUCTIONS OR DIFFERENCES SHALL BE BROUGHT TO THE ATTENTION OF THE IRRIGATION DESIGNER. IN THE EVENT THAT THIS NOTIFICATION IS NOT PERFORMED, THE IRRIGATION CONTRACTOR SHALL ASSUME FULL RESPONSIBILITY FOR ANY REVISIONS AND NECESSARY COSTS.
- D. THE IRRIGATION CONTRACTOR SHALL PAY ANY AND ALL FEES AND PERMITS ASSOCIATED WITH THE INSTALLATION OF THE IRRIGATION SYSTEM.
- E. AT LEAST SEVEN DAYS BEFORE BEGINNING WORK, CONFIRM THE STATIC WATER PRESSURE IS AT LEAST 65 PSI. IF STATIC WATER PRESSURE IS OUTSIDE OF THE STATED RANGE, DO NOT PROCEED WITHOUT FIRST NOTIFYING THE IRRIGATION DESIGNER AND OWNER IN WRITING, AND OBTAINING SUBSEQUENT DIRECTION FOR CORRECTIIONAL MEASURES. SHOULD THE IRRIGATION CONTRACTOR CHOOSE TO BEGIN THE INSTALLATION WITHOUT SUCH NOTIFICATION, THE IRRIGATION CONTRACTOR WILL ASSUME THE RESPONSIBILITY FOR ALL COSTS INCURRED TO ENSURE THE SYSTEM IS WORKING PROPERLY. NO CHANGE ORDERS WILL BE AUTHORIZED IN SUCH CIRCUMSTANCES.
- F. THE IRRIGATION CONTRACTOR SHALL VERIFY THE LOCATION OF ALL UNDERGROUND UTILITY LINES (WATER, SEWER, ELECTRICAL, TELEPHONE, GAS, CABLE, TELEVISION, ETC.) PRIOR TO THE START OF ANY WORK. THE CONTRACTOR SHALL BE FAMILIAR WITH ALL GRADE DIFFERENCES, LOCATIONS OF WALLS, STRUCTURES AND UTILITIES.
- G. COORDINATE WITH THE OWNER THE PROPOSED LOCATIONS OF THE AUTOMATIC CONTROLLER AND ANY REQUIRED SLEEVES THROUGH THE BUILDING FOR CONTROL WIRES.
- H. TRENCING NEAR EXISTING TREES:
- CONTRACTOR SHALL NOT DISTURB ROOTS 1-1/2" AND LARGER IN DIAMETER WITHIN THE CRITICAL ROOT ZONE (CRZ) OF EXISTING TREES, AND SHALL EXERCISE ALL POSSIBLE CARE AND PRECAUTIONS TO AVOID INJURY TO TREE ROOTS, TRUNKS, AND BRANCHES. THE CRZ IS DEFINED AS A CIRCULAR AREA EXTENDING OUTWARD FROM THE TREE TRUNK, WITH A RADIUS EQUAL TO 1" FOR EVERY 1" OF TRUNK DIAMETER-AT-BREAST-HEIGHT (4.5' ABOVE THE AVERAGE GRADE AT THE TRUNK).
 - ALL EXCAVATION WITHIN THE CRZ SHALL BE PERFORMED USING HAND TOOLS. NO MACHINE EXCAVATION OR TRENCING OF ANY KIND SHALL BE ALLOWED WITHIN THE CRZ.
 - ALTER ALIGNMENT OF PIPE TO AVOID TREE ROOTS 1-1/2" AND LARGER IN DIAMETER. WHERE TREE ROOTS 1-1/2" AND LARGER IN DIAMETER ARE ENCOUNTERED IN THE FIELD, TUNNEL UNDER SUCH ROOTS. WRAP EXPOSED ROOTS WITH SEVERAL LAYERS OF BURLAP AND KEEP MOIST. CLOSE ALL TRENCHES WITHIN THE CANOPY DRIP LINES WITHIN 24 HOURS.
 - ALL SEVERED ROOTS SHALL BE HAND PRUNED WITH SHARP TOOLS AND ALLOWED TO AIR-DRY. DO NOT USE ANY SORT OF SEALERS OR WOUND PAINTS.
- V. REFER TO THE PLANTING SPECIFICATIONS FOR ADDITIONAL CONDITIONS OF FINAL ACCEPTANCE AND START OF THE MAINTENANCE PERIOD.
- W. WARRANTY
- THE IRRIGATION SYSTEM SUPPLIED AND INSTALLED SHALL BE WARRANTED (LABOR AND MATERIALS) TO REMAIN OPERATIONAL FOR A PERIOD OF 12 MONTHS AFTER THE DATE OF FINAL ACCEPTANCE. DURING THIS PERIOD, THE CONTRACTOR SHALL ALSO REPAIR ANY SETTLEMENT OF THE IRRIGATION TRENCHES.
 - BY THE END OF THE WARRANTY PERIOD, ANY IRRIGATION PART THAT IS EITHER NON-OPERATIONAL OR THAT IS OPERATING BELOW STANDARDS AS DETERMINED BY THE OWNER, SHALL BE REMOVED FROM THE SITE AND SHALL BE REPLACED. REPLACEMENTS SHALL BE OF THE SAME KIND AS SPECIFIED IN THE IRRIGATION LEGEND, AND SHALL BE INSTALLED AS ORIGINALLY SPECIFIED.
 - IRRIGATION PARTS DAMAGED OR IMPAIRED DUE TO ACTS OF GOD, VANDALISM, AND/OR THE OWNER'S IMPROPER MAINTENANCE SHALL NOT BE COVERED BY THIS WARRANTY.
- X. SHOULD THE PERMITTING JURISDICTION REQUIRE AN IRRIGATION AUDIT, THE IRRIGATION CONTRACTOR SHALL RETAIN THE SERVICES OF A THIRD-PARTY CERTIFIED LANDSCAPE IRRIGATION AUDITOR, AT NO ADDITIONAL COST TO THE OWNER.

IRRIGATION LEGEND

SYMBOL	MANUFACTURER/MODEL
●	RAIN BIRD R-VAN14 1806-SAM-P45, TURF ROTARY, 8'-14" 45°-270° AND 360° HAND ADJUSTABLE MULTI-STREAM ROTARY W/1800 TURF SPRAY BODY ON 6.0" POP-UP, WITH CHECK VALVE AND 45 PSI IN-STEM PRESSURE REGULATOR. 1/2" NPT FEMALE THREADED INLET.
⦿	RAIN BIRD R-VAN18 1806-SAM-P45, TURF ROTARY, 13'-18" 45°-270° AND 360° HAND ADJUSTABLE MULTI-STREAM ROTARY W/1800 TURF SPRAY BODY ON 6.0" POP-UP, WITH CHECK VALVE AND 45 PSI IN-STEM PRESSURE REGULATOR. 1/2" NPT FEMALE THREADED INLET.
⦿	RAIN BIRD R-VAN24 1806-SAM-P45, TURF ROTARY, 17'-24" 45°-270° AND 360° HAND ADJUSTABLE MULTI-STREAM ROTARY W/1800 TURF SPRAY BODY ON 6.0" POP-UP, WITH CHECK VALVE AND 45 PSI IN-STEM PRESSURE REGULATOR. 1/2" NPT FEMALE THREADED INLET.
⌘	RAINBIRD RWS ROOT WATERING SYSTEM MODEL RWS-M-B-C-1402 WITH RWS-SOCK. (TWO PER TREE) SEE INSTALLATION NOTE #N-5 REGARDING TREE BUBBLER LATERAL PIPE
⌘	RAINBIRD XERI-BUG MULTI OUTLET (XBT-10-6) POINT SOURCE DRIP EMITTERS. RAIN BIRD XBT-6 SIX MULTI-OUTLET DRIP EMITTER/BUBBLER SIX-OUTLET, PRESSURE COMPENSATING, DRIP EMITTER. REFERENCE LANDSCAPE PLAN FOR DRIP EMITTER QUANTITIES
▲	RAINBIRD XERI-BUG SINGLE POINT SOURCE DRIP EMITTERS (XBT-10PC) REFERENCE LANDSCAPE PLAN FOR DRIP EMITTER QUANTITIES
⊗	RAINBIRD 5004PCSAMR, ADJUSTABLE ARC 4" POP UP ROTARY HEAD, PART CIRCLE, #1.5 LA NOZZLE UNLESS NOTED OTHERWISE
⊗	RAINBIRD 5004PCSAMR, ADJUSTABLE ARC 4" POP UP ROTARY HEAD, FULL CIRCLE, #3.0 LA NOZZLE UNLESS NOTED OTHERWISE
⊗	RAINBIRD 5004PCSAMR, ADJUSTABLE ARC 4" POP UP ROTARY HEAD, PART CIRCLE, #4.0 NOZZLE UNLESS NOTED OTHERWISE
⦿	RAINBIRD XCZ-100-PRB-COM / 150-PRB-COM SERIES AUTOMATIC DRIP VALVE ASSEMBLY WITH 40 PSI PRESSURE REGULATOR XCZ-100-PRB-COM - 1" BALL VALVE WITH 1" PESB VALVE AND 1" PRESSURE REGULATING 40PSI QUICK-CHECK BASKET FILTER. 0.3GPM TO 20GPM.
⊕	RAINBIRD PEB SERIES ELECTRIC REMOTE CONTROL, "TREE BUBBLER ZONE" VALVE SEE INSTALLATION NOTE #N-5 REGARDING TREE BUBBLER LATERAL PIPE
⦿	RAINBIRD PEB SERIES 1", 1-1/2", 2" PLASTIC INDUSTRIAL VALVES. LOW FLOW OPERATING CAPABILITY, GLOBE CONFIGURATION.
	AREA TO RECEIVE DRIPLINE RAINBIRD XFS-CV-06-12 SERIES DRIP TUBE IN SHRUB BED INSTALLED AT 2" DEPTH
	TEMPORARY IRRIGATION
	PIPE TRANSITION POINT ABOVE GRADE PIPE TRANSITION POINT FROM PVC LATERAL TO DRIP TUBING WITH RISER TO ABOVE GRADE INSTALLATION.
	ZURN / WILKINS 375XLB SERIES REDUCED PRESSURE TYPE BACKFLOW PREVENTOR INSTALLED PER CITY CODE WITH HEATED / INSULATED ALUMINUM ENCLOSURE AND SAME SIZE BRONZE BALL VALVE INSTALLED ON THE UP-STREAM SIDE. G.C. TO COORDINATE POWER TO BACKFLOW ENCLOSURE LOCATION PRIOR TO CONSTRUCTION BLOW OFF VALVE TO BE INSTALLED BETWEEN THE METER AND BACKFLOW DEVICE FOR SYSTEM WINTERIZATION
⌘	LASCO "V" SERIES SCH. 80 PVC TRUE UNION BALL VALVE, MAINLINE SIZE
⊗	RAINBIRD 33DLRC QUICK COUPLER, 3/4"
⊗	RAINBIRD ESP12LXMEF2P SERIES AUTOMATIC WALL MOUNT CONTROLLER WITH TWO ESPLXMSM12 STATION MODULES
⊗	RAINBIRD WR2-RFC RAIN / FREEZE SENSOR - CONFIRM SENSOR LOCATION WITH OWNERS REPRESENTATIVE
⌘	1" MASTER VALVE MODEL # 100-EFB-CP WITH RAINBIRD FLOW SENSOR MODEL #FS100P SERIES

- IRRIGATION LATERAL LINE: CLASS 200 PVC
- IRRIGATION MAINLINE: SCHEDULE 40 PVC
- == == == == IRRIGATION SLEEVES, SCH. 40 PVC, MIN. TWICE SIZE OF PIPE TO BE INSERTED

IRRIGATION NOTES:

- L.I.C. SHALL SELECT R-VAN SPRAY NOZZLES FOR "HEAD-TO-HEAD" COVERAGE, ADJUSTED FOR NO OVERSPRAY ONTO WALLS AND WALKS. NO OVERSPRAY INTO STREETS IS PERMITTED.
- ALL PIPE TO BE SIZED SUCH THAT FLOWS WILL NOT EXCEED VELOCITY OF 5 FPS
- IRRIGATION CONTRACTOR SHALL PROVIDE 3/4" OF WATER FOR THE REAR PRACTICE FIELD TO LIMIT THE OVERALL WATERING RUN TIME.

WATER CONSERVATION

IRRIGATION WATER CONSERVATION SHALL BE ACCOMPLISHED THROUGH THE FOLLOWING EFFORTS:


- SEPARATE TURF / SHRUB ZONES FOR SCHEDULING ADJUSTMENT
- NO OVERSPRAY ONTO PAVEMENT PERMITTED
- USE OF RAIN SENSOR SHUT OFF OVER-RIDE DEVICE

LATERAL PIPE SIZE CHART

LATERAL PIPE SHALL BE SIZED TO ALLOW A MAXIMUM FLOW VELOCITY OF FIVE FEET PER SECOND ACCORDING TO THE FOLLOWING CHART:

FLOW IN GPM	LATERAL PIPE SIZE
UP TO 5 GPM	3/4" CLASS 200
6 - 10 GPM	3/4" CLASS 200
11 - 15 GPM	1" CLASS 200
16 - 28 GPM	1 1/4" CLASS 200
29 - 35 GPM	1 1/2" CLASS 200
36 - 54 GPM	2" CLASS 200
55 - 81 GPM	2 1/2" CLASS 200
82 - 120 GPM	3" CLASS 200

VALVE KEY

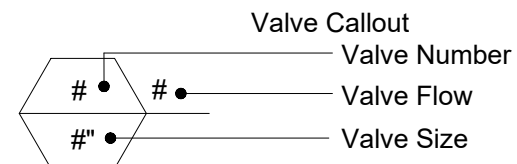

CRITICAL ANALYSIS

P.O.C. NUMBER: 01
Water Source Information: Irrigation Meter, By Others

FLOW AVAILABLE
Domestic Water Meter Size: 3/4"
Flow Available: 18 gpm

PRESSURE AVAILABLE
Static Pressure at POC (est.): 68.00 psi
Elevation Change: NA
Service Line Size: NA
Length of Service Line: NA
Pressure Available: 65.00 psi

DESIGN ANALYSIS
Maximum Station Flow: 14.0 gpm
Flow Available at POC: 18.0 gpm
Residual Flow Available: 4.0 gpm

Critical Station: 9
Head Pressure Required: 35.0 psi
Lateral Loss: 3.5 psi
Loss through Valve: 4.8 psi
Pressure Req. at Critical Station: 40.3 psi
Loss for Main Line: 1.6 psi
Loss for Fittings 20% (Main Line): 0.32 psi
Loss for Master Valve: 1.7 psi
Loss for Backflow: 11.0 psi
Loss for Water Meter: 3.1 psi
Critical Station Pressure at POC: 57.92 psi
Pressure Available: 65.00 psi
Residual Pressure Available: 7.08 psi

HONOR CHARTER
ACADEMY
BENT GRASS MEADOWS DRIVE
PEYTON, CO

IRRIGATION SPECIFICATIONS

Date	Comment

Project Number
Date: 06/26/2026
Drawn By: JML
Checked By: KB

LI-3

V3_Landscape Plan drawings.pdf Markup Summary

dsdparsons (12)



Subject: Text Box
Page Label: 1
Author: dsdparsons
Date: 9/15/2026 12:18:21 PM
Status:
Color: ■
Layer:
Space:

Tammy-

It looks like the landscape plan didn't address comments; it does not meet the standards in the Code for buffers, roadway and internal landscape.

There is mention of tree credits? We don't have tree credits that I am aware of. A school is not exempt from zoning as indicated on the Plan. Are you proposing an alternative/substitute landscape plan? If so, you will need to state the justification in the table on the Plan. I am sending you my comments on the landscape plan via email so you don't have to wait until the remainder comments on other documents are published, so you can make adjustments.

6.2.2. Landscape Requirements

(A)General.

(1)Purpose. The landscape requirements are intended to provide uniform standards for the development and maintenance of the landscaping of private property and public rights-of-way to achieve a balance between the individual right to develop and the general benefit and welfare of the community. The benefits to be achieved and the overall purposes of the landscaping required by this Section are: (1) to create a positive image and visual appeal both along the road which is highly visible and internal properties which provide a working, shopping and living environment; (2) to decrease the scale of parking lots, provide shade, and reduce heat, glare and noise; (3) to separate circulation systems; to soften and reduce the mass of buildings; to screen and buffer lower intensity uses from higher intensity uses and protect residential privacy; and (4) to create an overall pleasant and attractive surrounding.

(2)Applicability.

(a)Applies to All Land Uses. The requirements of this Section shall apply to all uses. PUD's may have their requirements modified subject to the individual PUD.

(b)New Use Established or Use Changed.

Landscaping areas shall conform to this Section for a new building or use of previously vacant land, uses in an enlarged building, and all uses in a building when any use is changed that requires a change of occupancy to be approved by the Building Department or by the PCD.


USE AREAS LAYOUT FOR
PLANT SCHEDULE

(4)Authority of Director to Approve Substitute Landscape Designs. The PCD Director may approve landscaping that does not meet the specific requirements of this Section provided the proposed landscaping meets the purpose of this Section, promotes the concepts contained in the Landscaping and Planting Manual, and provides an equivalent benefit to the community and environment as would otherwise be achieved by meeting the specific requirements of this Section. This authority shall not allow the PCD Director to eliminate the requirement for landscaping or to decrease the total landscaped area required by this Section.

307


Subject: Text Box
Page Label: 1
Author: dsdparsons
Date: 9/15/2026 12:19:00 PM
Status:
Color: ■
Layer:
Space:

(4)Authority of Director to Approve Substitute Landscape Designs. The PCD Director may approve landscaping that does not meet the specific requirements of this Section provided the proposed landscaping meets the purpose of this Section, promotes the concepts contained in the Landscaping and Planting Manual, and provides an equivalent benefit to the community and environment as would otherwise be achieved by meeting the specific requirements of this Section. This authority shall not allow the PCD Director to eliminate the requirement for landscaping or to diminish the total landscaped area required by this Section.

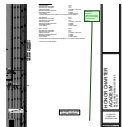


Subject: Planner
Page Label: 1
Author: dsdparsons
Date: 9/15/2026 12:19:32 PM
Status:
Color: ■
Layer:
Space:

 Provide the alternative justification for each area you are omitting landscape from please




Subject: Planner
Page Label: 1
Author: dsdparsons
Date: 9/15/2026 12:20:06 PM
Status:
Color: ■
Layer:
Space:

 add all the screening fences to all property lines all sheets




Subject: Planner
Page Label: 1
Author: dsdparsons
Date: 9/15/2026 12:20:22 PM
Status:
Color: ■
Layer:
Space:

label the dimensions of the setbacks

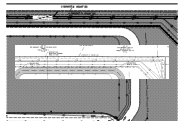


Subject: Image
Page Label: 1
Author: dsdparsons
Date: 9/15/2026 12:22:52 PM
Status:
Color: ■
Layer:
Space:

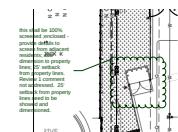

Subject: Planner
Page Label: 1
Author: dsdparsons
Date: 9/15/2026 12:33:11 PM
Status:
Color: ■
Layer:
Space:

this shall be 100% screened ;enclosed - provide details to screen from adjacent residents; add dimension to property lines; 25' setback from property lines.
Review 1 comment not addressed. 25' setback from property lines need to be showed and dimensioned.

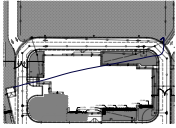


Subject: Pen
Page Label: 1
Author: dsdparsons
Date: 9/15/2026 12:33:40 PM
Status:
Color: ■
Layer:
Space:




Subject: Callout
Page Label: 2
Author: dsdparsons
Date: 9/15/2026 12:20:55 PM
Status:
Color: ■
Layer:
Space:

Add screening fence detail

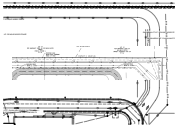


Subject: Image
Page Label: 2
Author: dsdparsons
Date: 9/15/2026 12:22:59 PM
Status:
Color: ■
Layer:
Space:

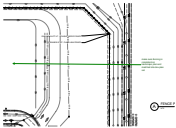

Subject: Callout
Page Label: 2
Author: dsdparsons
Date: 9/15/2026 12:23:33 PM
Status:
Color: ■
Layer:
Space:

 make sure fencing is consistent on landscape plan
and matched site dev plan set



Subject: Planner
Page Label: 2
Author: dsdparsons
Date: 9/15/2026 12:23:57 PM
Status:
Color: ■
Layer:
Space:

fencing