


EAST ELEVATION
SCALE: 3/16" = 1'-0"

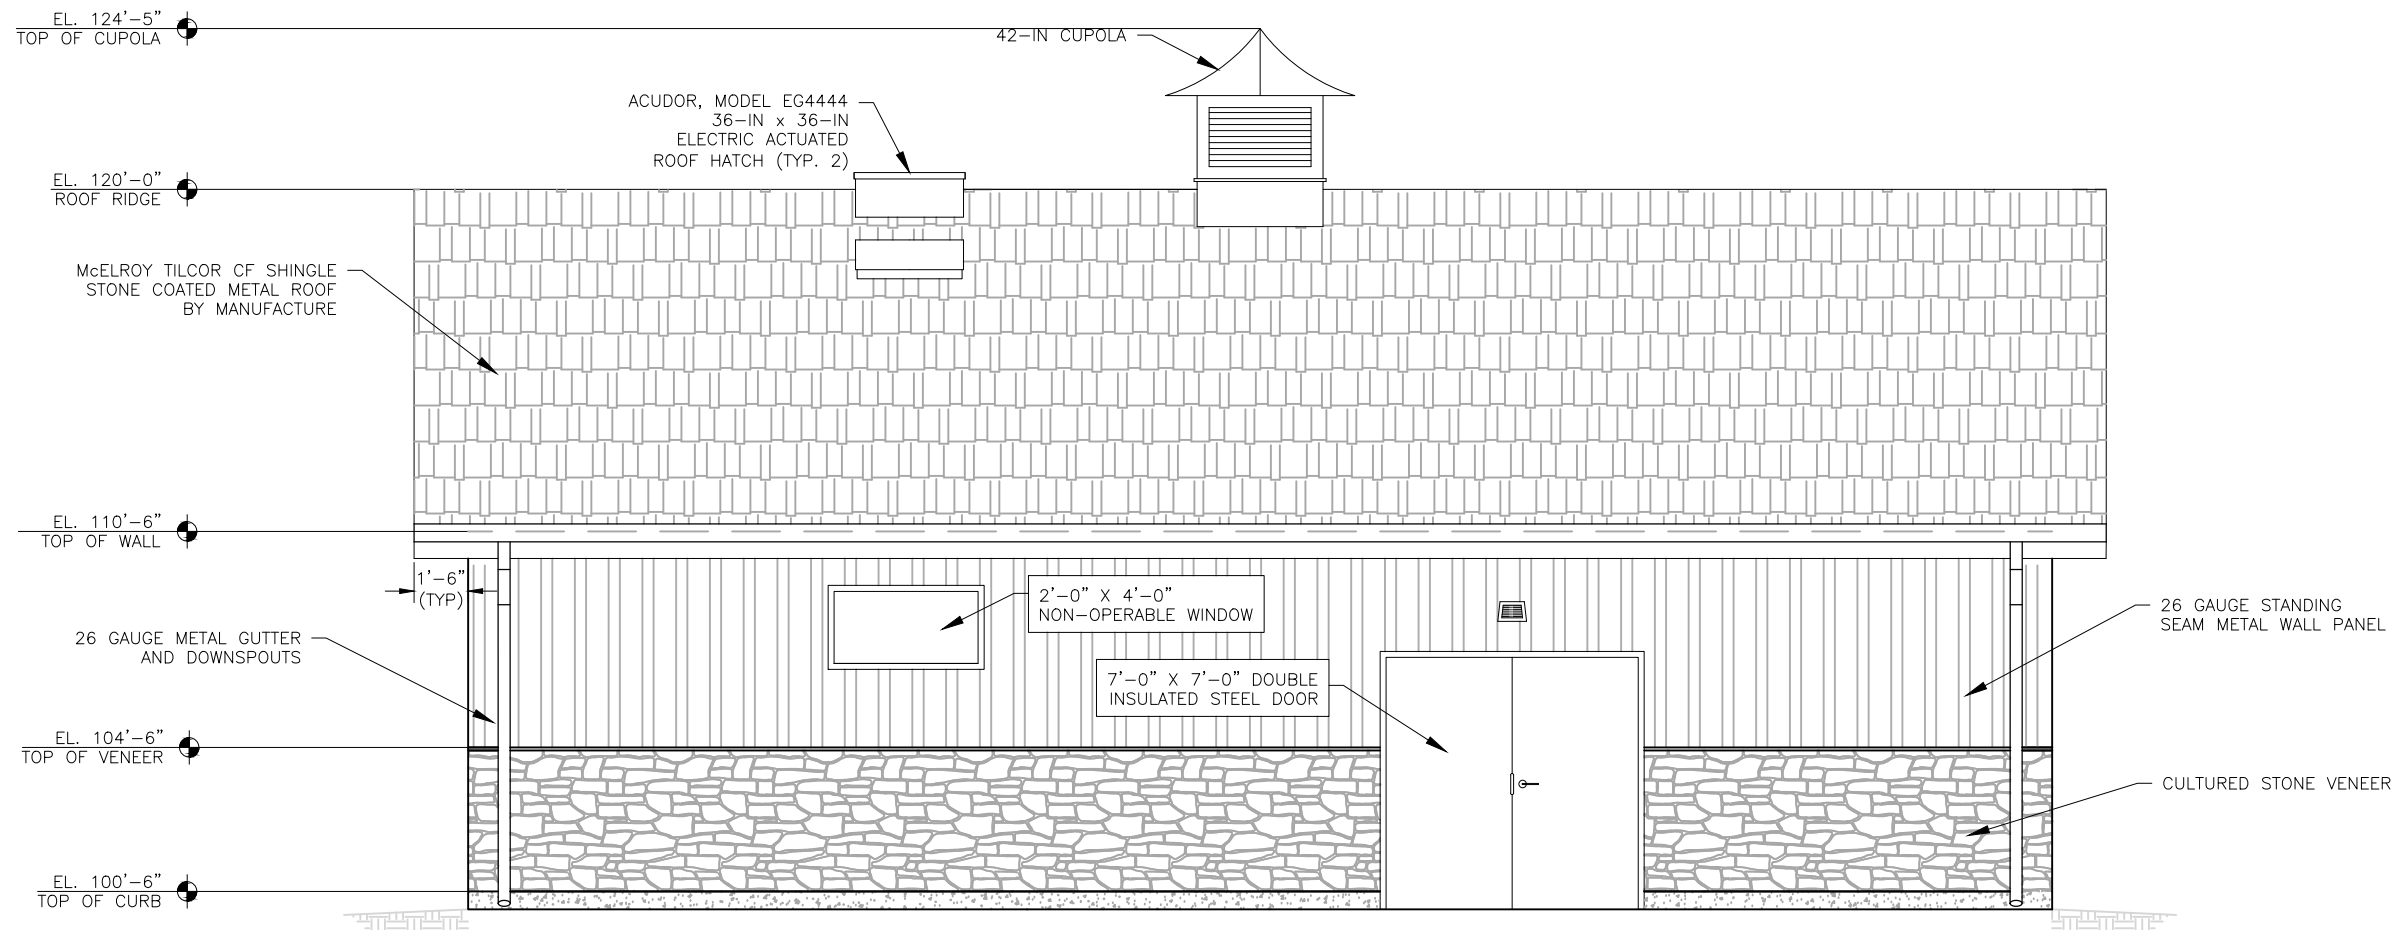

WEST ELEVATION
SCALE: 3/16" = 1'-0"

JDS-HYDRO a Division of **RESPEC**
5540 TECH CENTER DR., SUITE 100
COLORADO SPRINGS, COLORADO 80919
(719) 227-0072
THE CONTRACTOR SHALL VERIFY ALL DIMENSIONS. ANY ERRORS OR OMISSIONS ARE THE CONTRACTOR'S RESPONSIBILITY. RESPEC ASSUMES NO LIABILITY FOR UNAUTHORIZED CHANGES AND/OR REVISIONS MADE TO PLANS.

TRIVIEW METROPOLITAN DISTRICT
NORTHERN DELIVERY SYSTEM - BOOSTER PUMP STATION
EAST & WEST BUILDING ELEVATIONS

NO.	DESCRIPTION	BY		DATE	
		APP.	MLD	MLD	MLD
1	UPDATE	1	CGM	10/31/22	
2	UPDATE	2	SNH	02/03/23	
3	REV	3	MLD	3/31/23	
4					
5					
6					
7					

100% DESIGN


Project No.: W224.21029
Date: 01/09/23
Design: MLD
Drawn: AMY
Check: MLD

A3
SHEET 31 OF 54


PCD File No. PPR-22-62

2023/04/14 11:10 AM By: Shelby Heule N:\Projects\224 Triview Metro District\224.29 Northern Regional Water Delivery Project - Phase 2\Drawings\Working\Segment A - Pump Station\06_Architectural\224029_Arch.dwg

2023/04/14 11:10 AM By: Shelby Heule N:\Projects\224 Triview Metro District\224.29 Northern Regional Water Delivery Project - Phase 2\Drawings\Working\Segment A - Pump Station\06_Architectural\224029_Arch.dwg

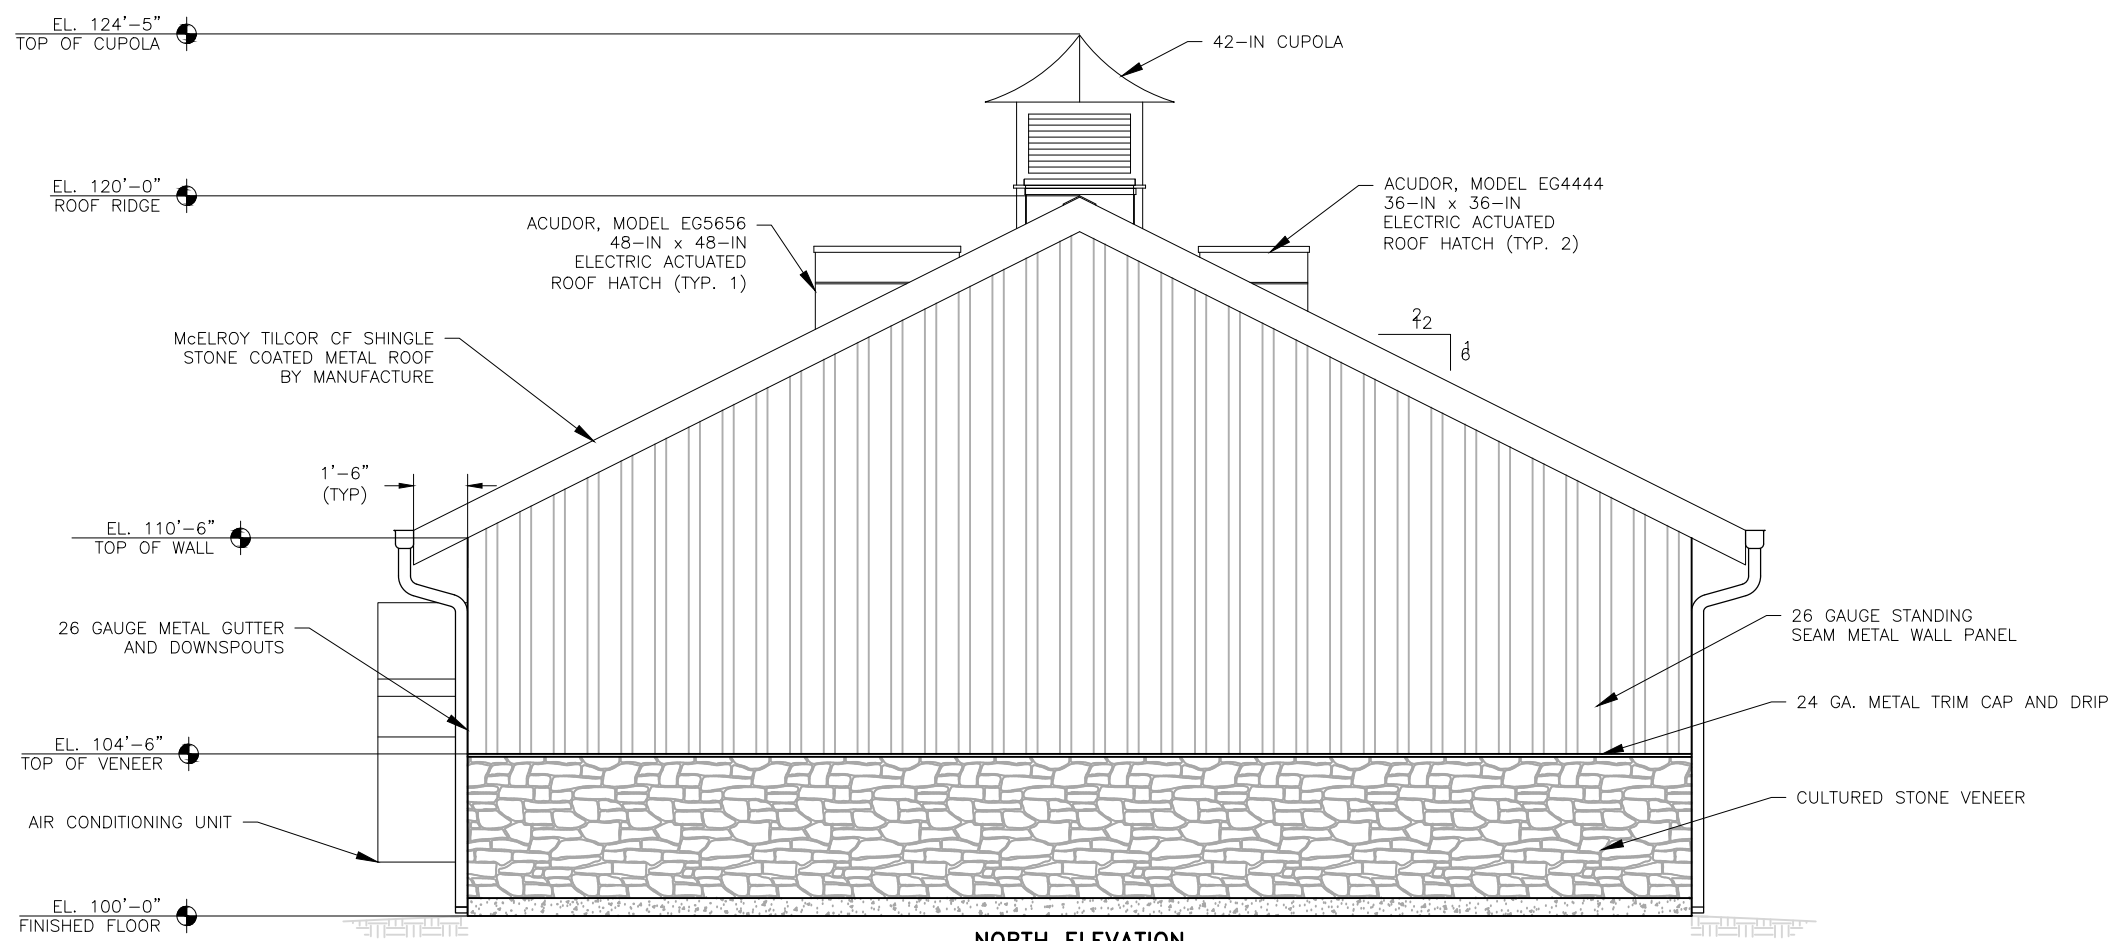

NORTH ELEVATION
SCALE: 3/16" = 1'0"

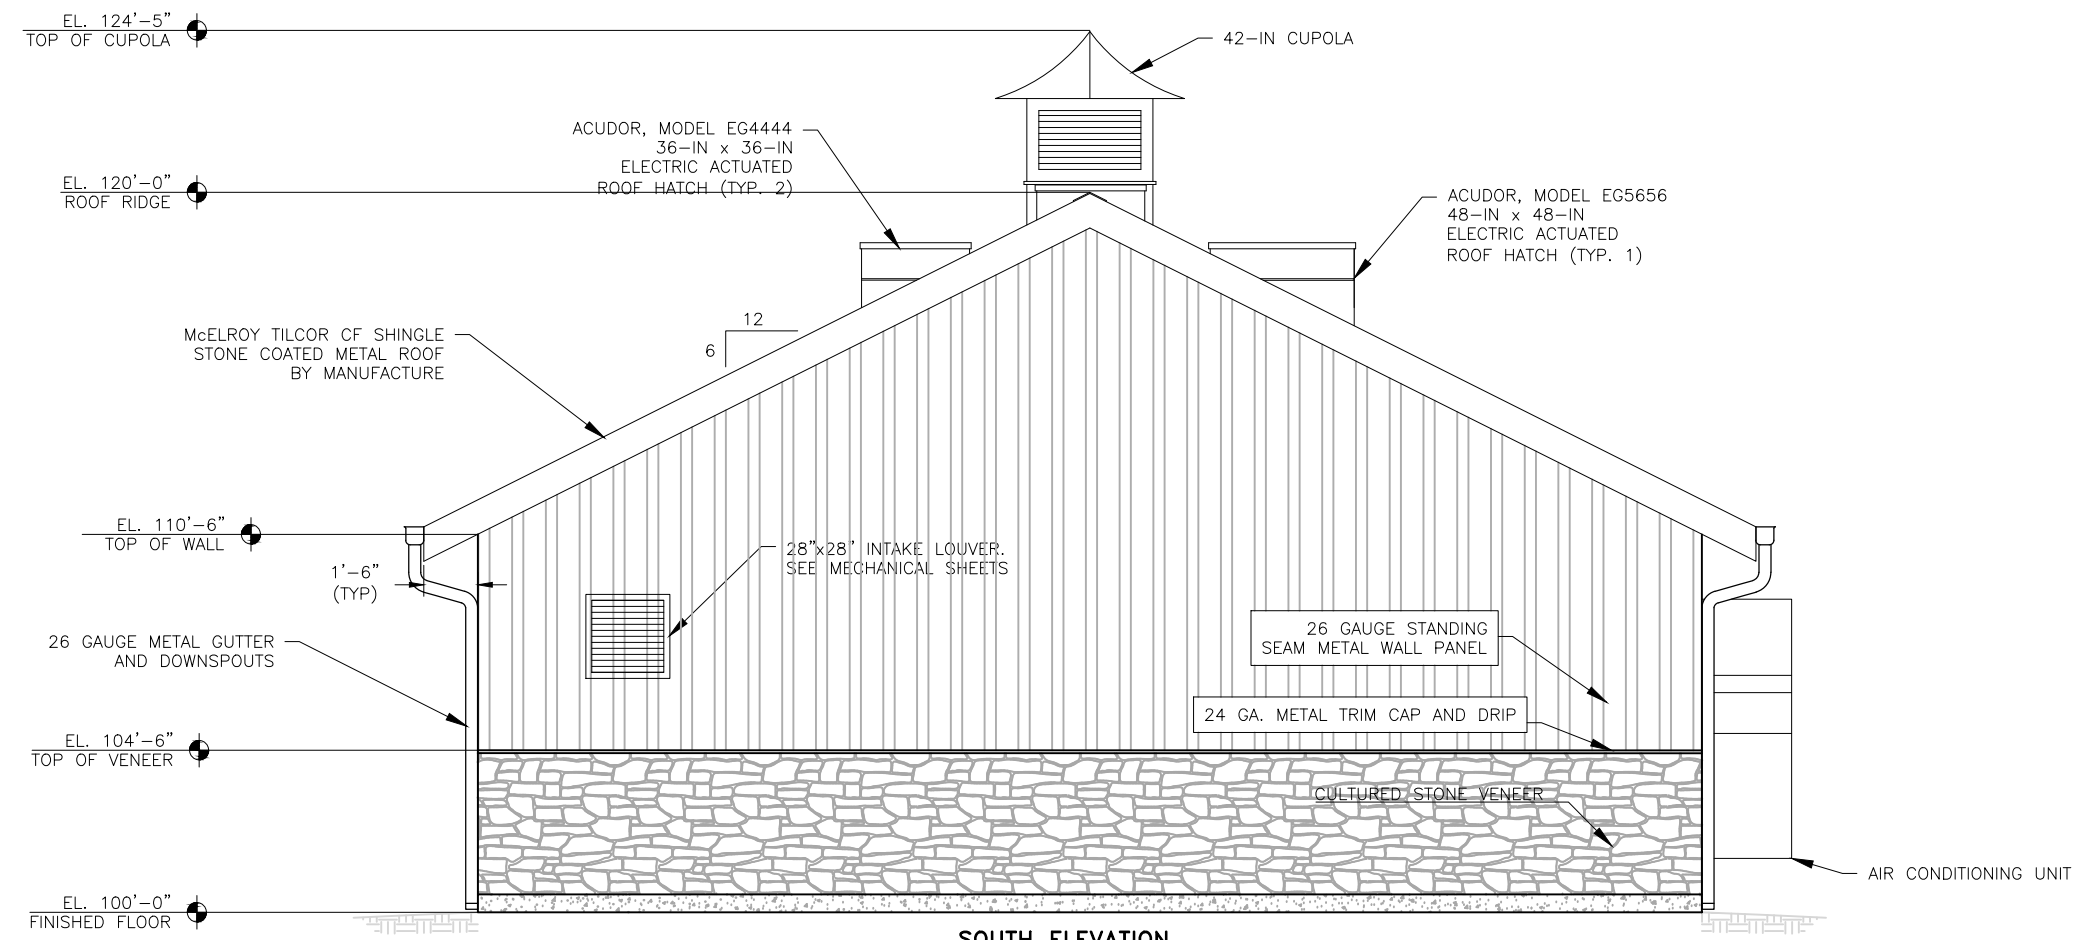

SOUTH ELEVATION
SCALE: 3/16" = 1'0"

JDS-HYDRO a Division of **RESPEC**
5540 TECH CENTER DR., SUITE 100
COLORADO SPRINGS, COLORADO 80919
(719) 227-0072
THE CONTRACTOR SHALL VERIFY ALL DIMENSIONS. ANY ERRORS OR OMISSIONS ARE THE RESPONSIBILITY OF THE CONTRACTOR. RESPEC ASSUMES NO LIABILITY FOR UNAUTHORIZED CHANGES AND/OR REVISIONS MADE TO PLANS.

TRIVIEW METROPOLITAN DISTRICT
NORTHERN DELIVERY SYSTEM - BOOSTER PUMP STATION
NORTH & SOUTH BUILDING ELEVATIONS

REVISIONS		BY	APP.	DATE
NO.	DESCRIPTION			
1	UPDATE	CGM	MLD	10/31/22
2	REV 2	MLD	MLD	3/31/23
3				
4				
5				
6				
7				

100% DESIGN

Project No.: W224.21029
Date: 01/09/23
Design: MLD
Drawn: AMY
Check: MLD

PCD File No. PPR-22-62