


Per 6.2.3 B 1 d - Light levels shall not exceed 10 foot candles.

Calculation Summary						
Label	CalcType	Avg	Max	Min	Avg/Min	Max/Min
SITE Planar	Illuminance	0.2	16.8	0.0	N.A.	N.A.

Luminaire Schedule					
Symbol	Qty	Label	LLF	Description	Tag
☐	2	WPLED18/FC	0.810	WPLED18/FC	EA

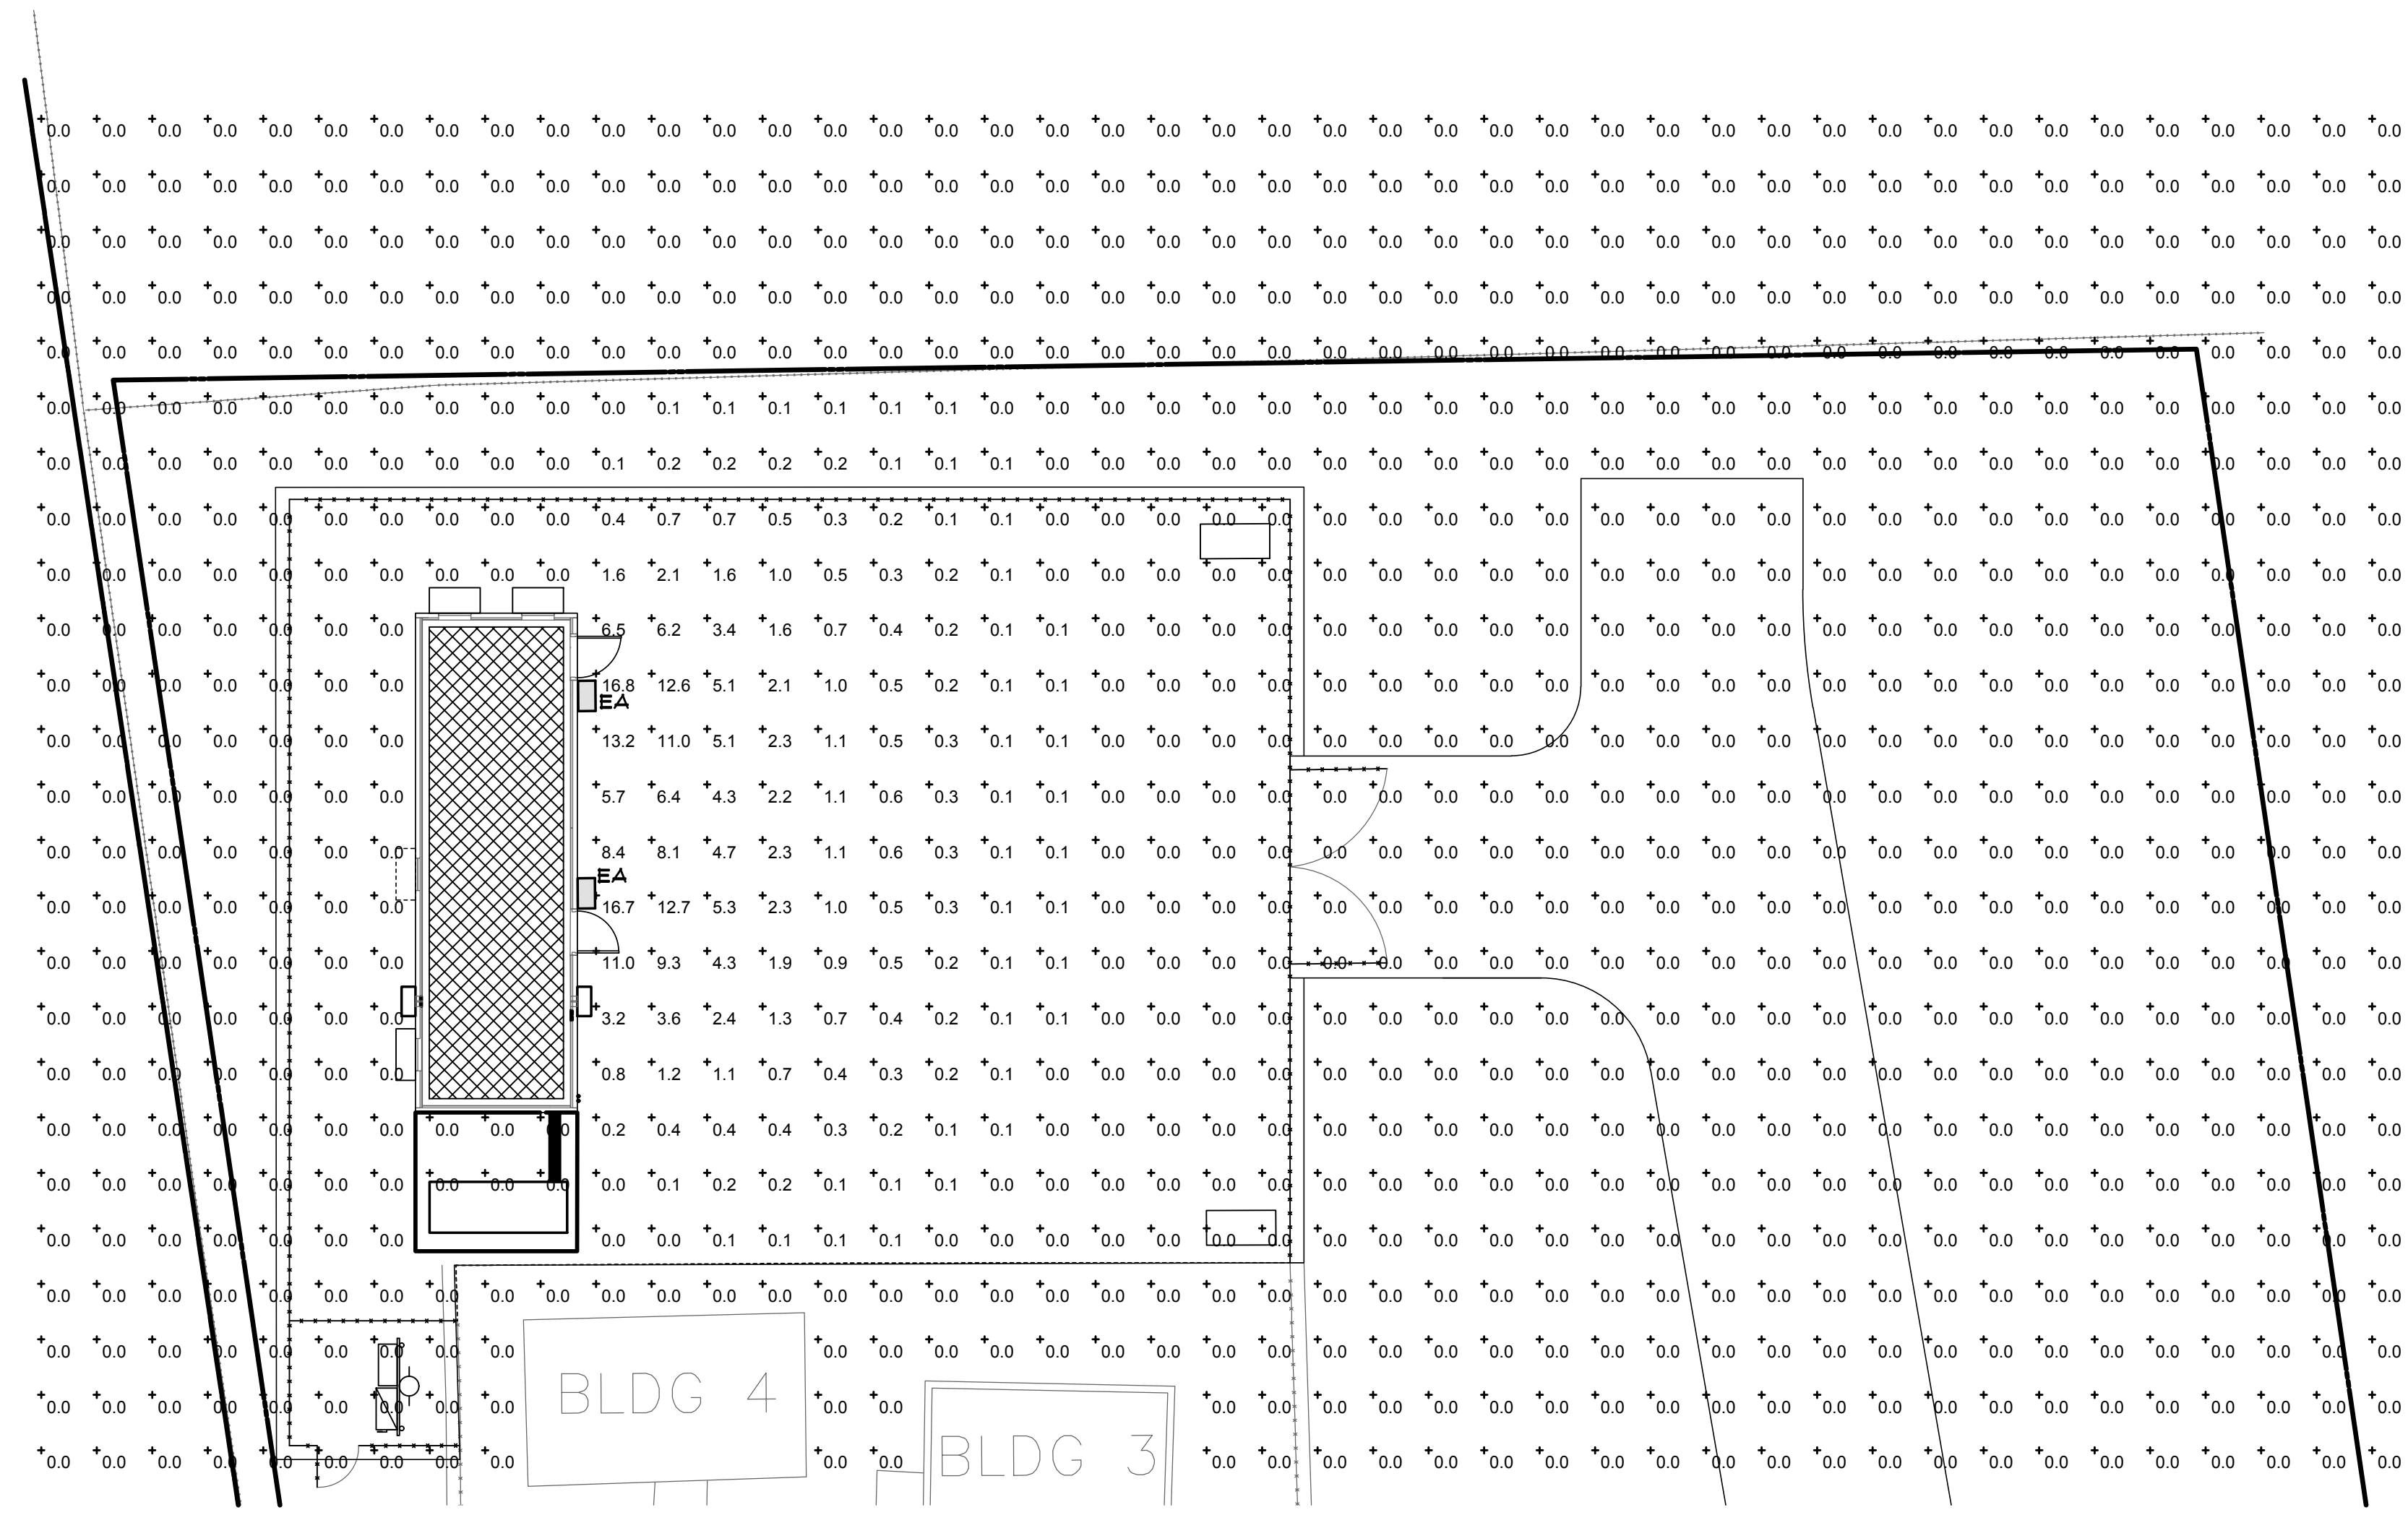


SITE PLAN - PHOTOMETRIC

SCALE: 1" = 10'-0"

PRELIMINARY
 Plotted: October 24, 2019
NOT FOR CONSTRUCTION



15925 HARGRAY DRIVE
 NOBLESVILLE, INDIANA 46062
 P: 833-348-3934
 www.five9dg.com

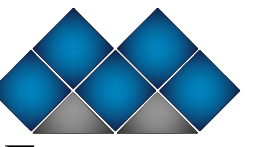

MILLIES ENGINEERING GROUP
 MILLIES • JANNEY • HROMADA
 9711 Volporsko Drive Chicago, Illinois 60601
 221 N. LaSalle Street Murfreesboro, Indiana 46321
 (219) 924-8400
 www.milliesengineeringgroup.com
 Copyright © 2019 Millies Engineering Group

THIS IS AN ORIGINAL DESIGN, CREATED BY FIVE NINE DESIGN GROUP. THE CONCEPTS, IDEAS, PLANS AND DETAILS ARE THE SOLE PROPERTY OF FIVE NINE DESIGN GROUP. NONE OF THE CONCEPTS, IDEAS, PLANS OR DETAILS SHALL BE COPIED, USED BY, OR DISCLOSED TO ANY PERSON, FIRM OR CORPORATION FOR ANY PURPOSE WITHOUT THE PRIOR WRITTEN PERMISSION OF FIVE NINE DESIGN GROUP. WRITTEN PERMISSION ON DRAWINGS SHALL HAVE PRECEDENCE OVER SCALE DIMENSIONS. CONTRACTORS SHALL VERIFY AND BE RESPONSIBLE FOR ALL DIMENSIONS AND CONDITIONS ON THE JOB AND FIVE NINE DESIGN GROUP MUST BE NOTIFIED OF ANY VARIATION FROM THE DIMENSIONS AND CONDITIONS SHOWN ON THESE DRAWINGS.

NAVALO GROUP
 18370 HIGHWAY 94
 COLORADO SPRINGS, CO 80930

NUMBER	DATE	ISSUED FOR REVIEW SET	DESCRIPTION

CERTIFICATION:

SHEET TITLE:
SITE PLAN - PHOTOMETRIC
 PROJECT NUMBER: 18061
 CAD FILE: E1-1.DWG
 DRAWN BY: LT
 CHECKED BY: SM

SHEET NUMBER:
E101