


# SITE PLAN

SCALE: 1" = 30'-0"

# AERIAL VIEW

SCALE: NTS

TOTAL # OF PANELS  
31

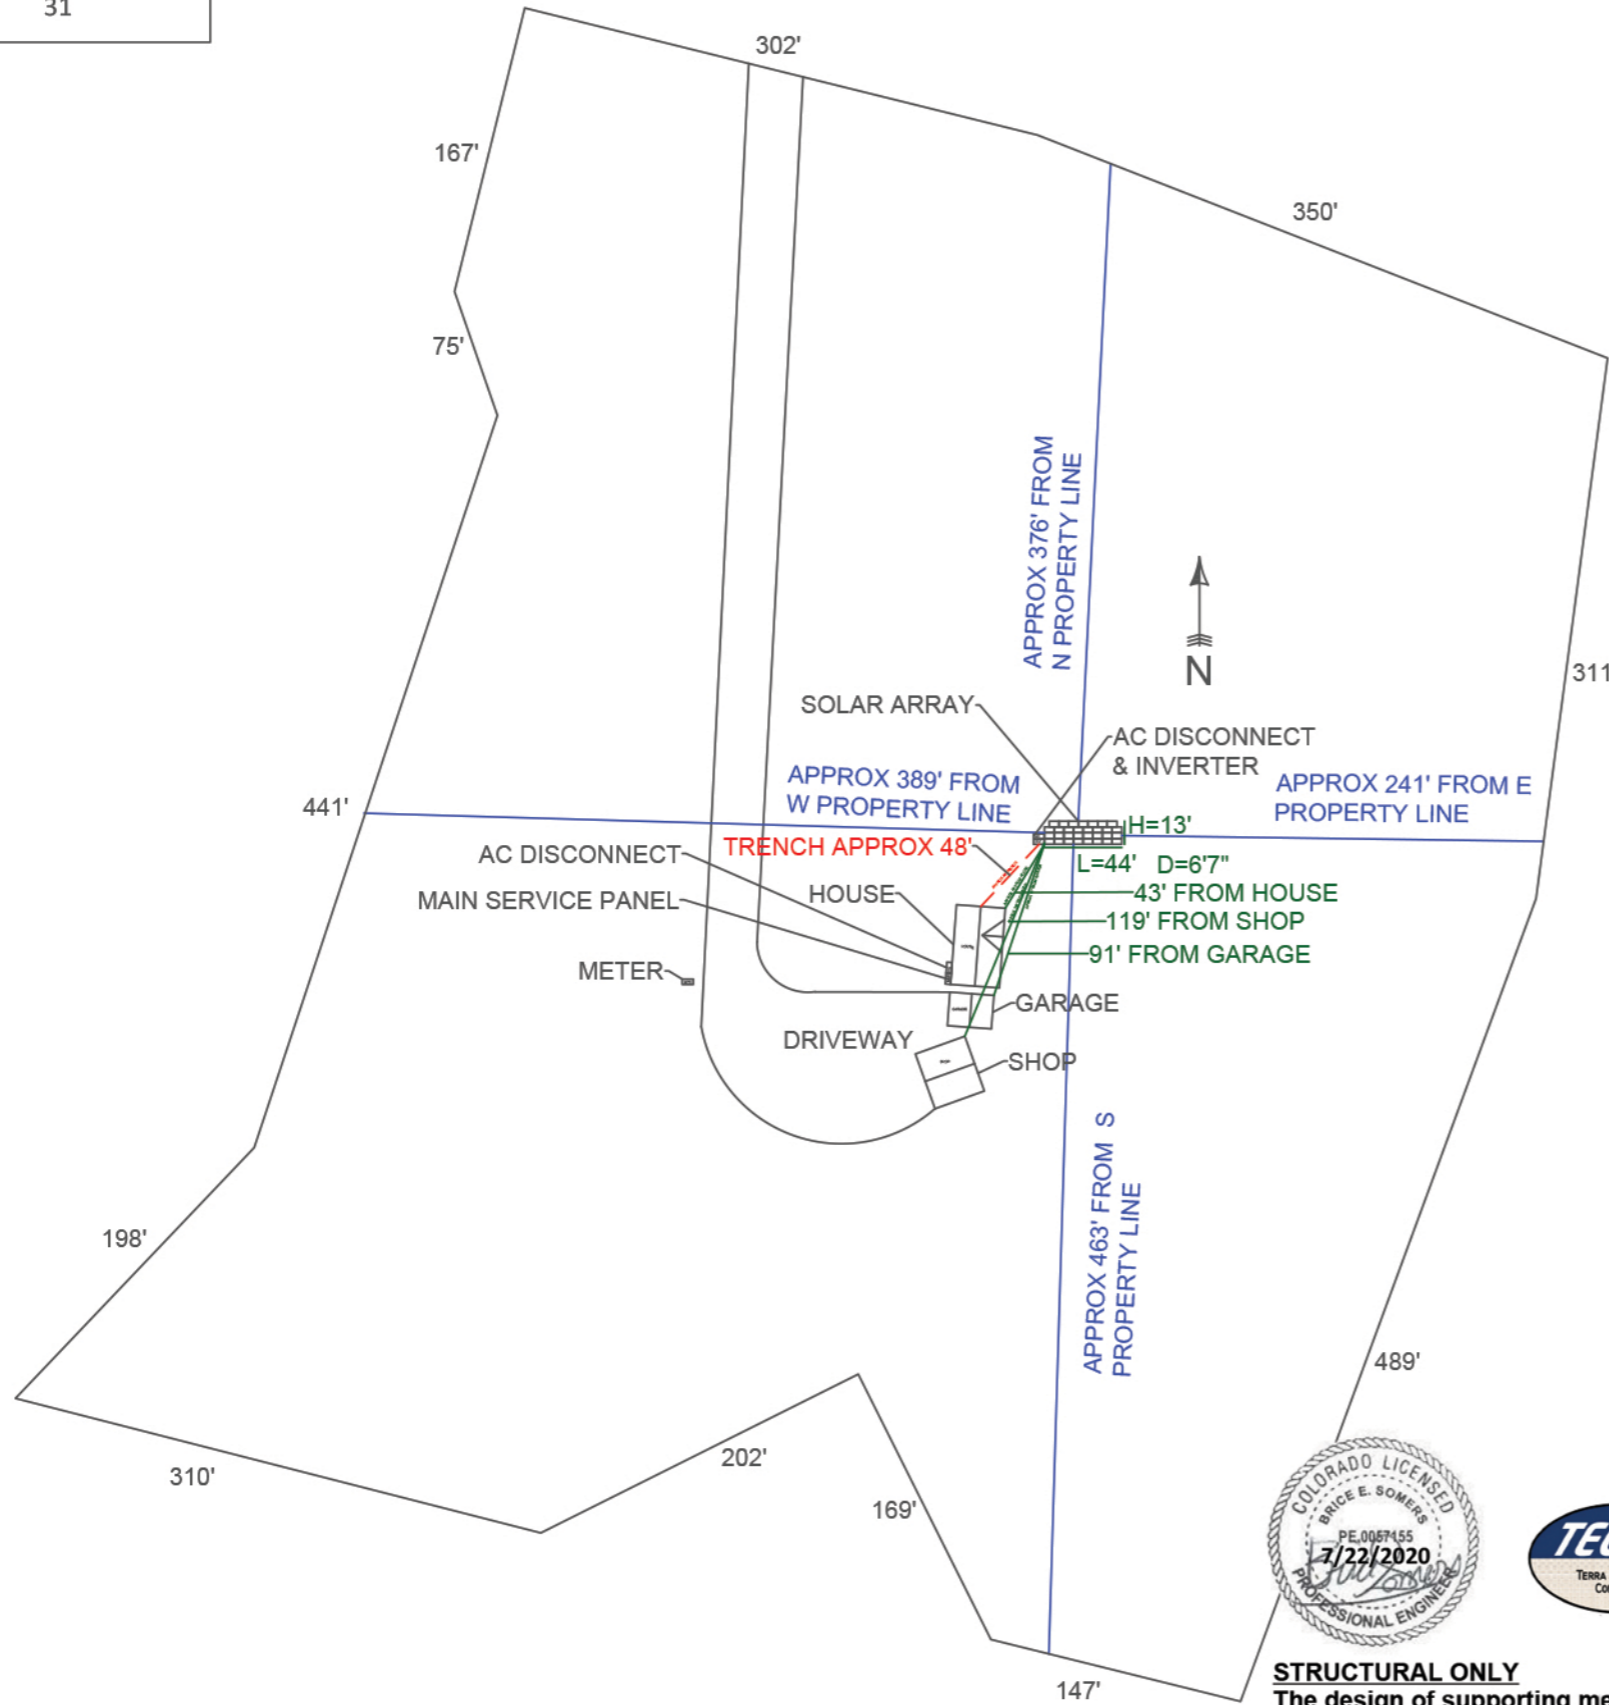


**STRUCTURAL ONLY**  
 The design of supporting members and connections are provided by manufacturer, SnapNrack. Electrical engineering is out of scope of this review.




## ABBREVIATIONS

INV	INVERTER	MSP	MAIN SERVICE PANEL
AC	AC DISCONNECT	MTR	METER

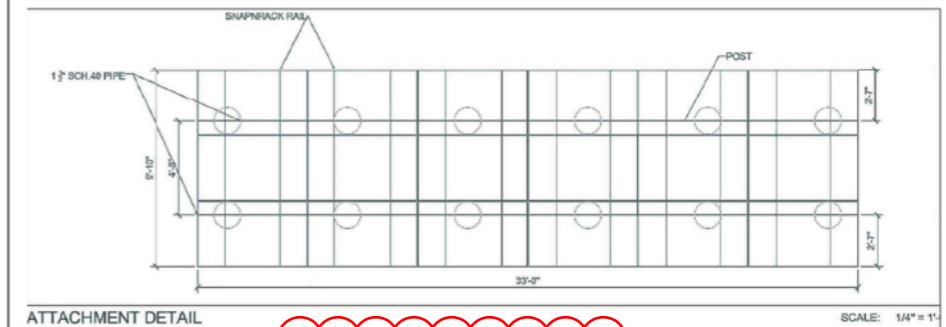

ILLEGIBLE

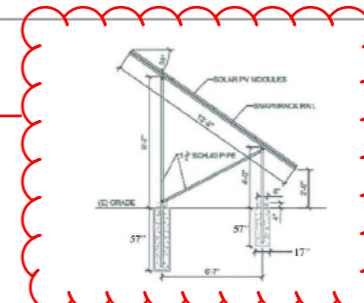

DISAPPROVED  
 08/24/2020 6:27:24 AM  
 danm  
 CONSTRUCTION

CONTRACTOR INFORMATION  
 Big Dog Renewable Electric Energy  
 Contractor Lic # EC.0100531  
 620 Pheasant Ridge Dr  
 Chubbuck, ID 83202  
 208-242-3352 T  
 208-232-5935 F X



DESIGNED BY  
**ALAN JOHNSON**  
 9911 AVENIDA HERMOSA VIEW  
 FOUNTAIN, CO 80817  
 512-567-3644

ISSUED FOR: PERMIT	DATE
SITE PLAN, AERIAL VIEW	7/16/2020