
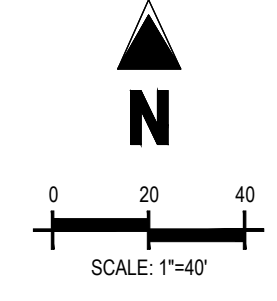


Table with 4 columns: #, Date, Issue / Description, Init.

Project No: MRS01  
Drawn By: ASA, BLB  
Checked By: BAS  
Date: 04/26/2024

PHOTOMETRIC PLAN AND  
DETAILS

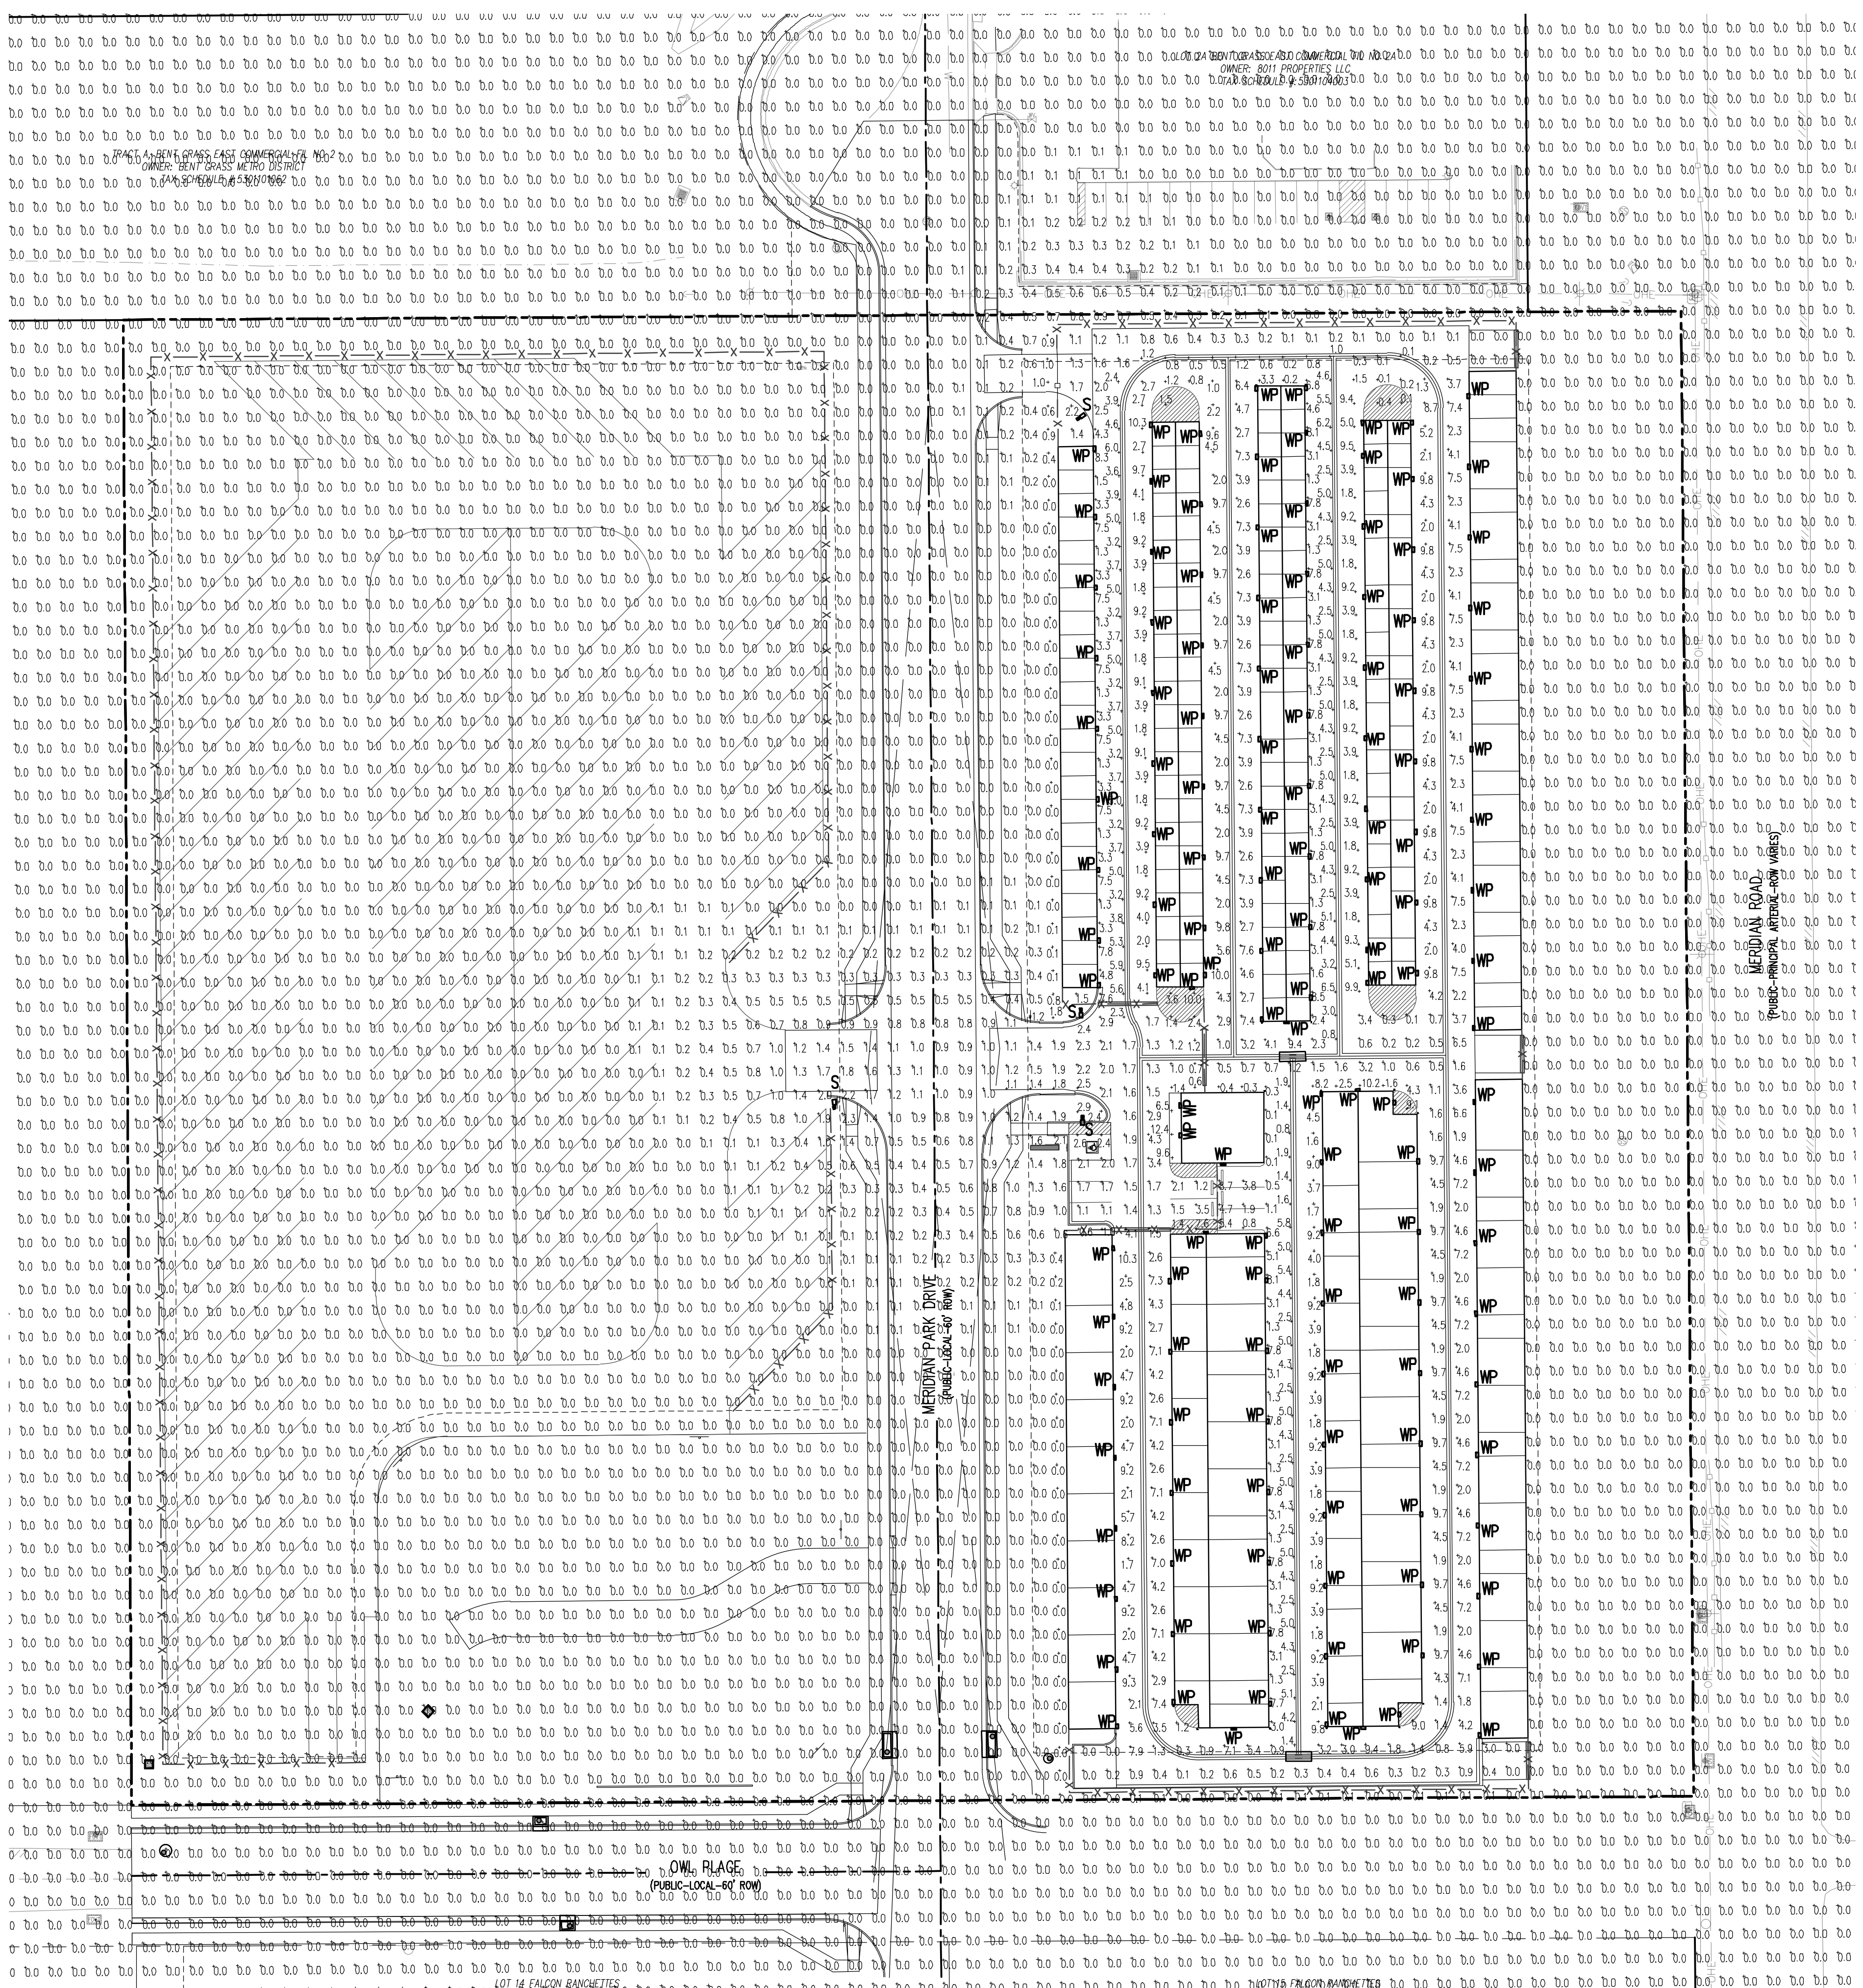

D-Series Size 0 LED Area Luminaire  
Specifications: Depth 0.5", Length 26.1", Width 14.5", Height 1.7", Weight 2.3 lbs.  
Introduction: The modern styling of the D-Series features a highly refined aesthetic that blends seamlessly with any architecture.


WEDGE1 LED Architectural Wall Sconce  
Specifications: Depth 0.5", Height 8", Weight 1.2 lbs.  
Introduction: The WEDGE1 family is designed to meet specifier's every wall-mounted lighting need in a widely accepted shape that blends with any architecture.

Ordering Information table with columns: Part No., Description, Qty., Unit, Price, Total Price.

Ordering Information table for WEDGE1 LED Family, including columns for Part No., Description, Qty., Unit, Price, Total Price.

LUMINAIRE SCHEDULE table with columns: MARK, QTY, LABEL, MOUNTING, ARRANGEMENT, LLF, CATALOG NUMBER, DESCRIPTION, LUMENS, WATTS.

Calculation Summary table with columns: LABEL, UNITS, AVG, MAX, UNIFORMITY.

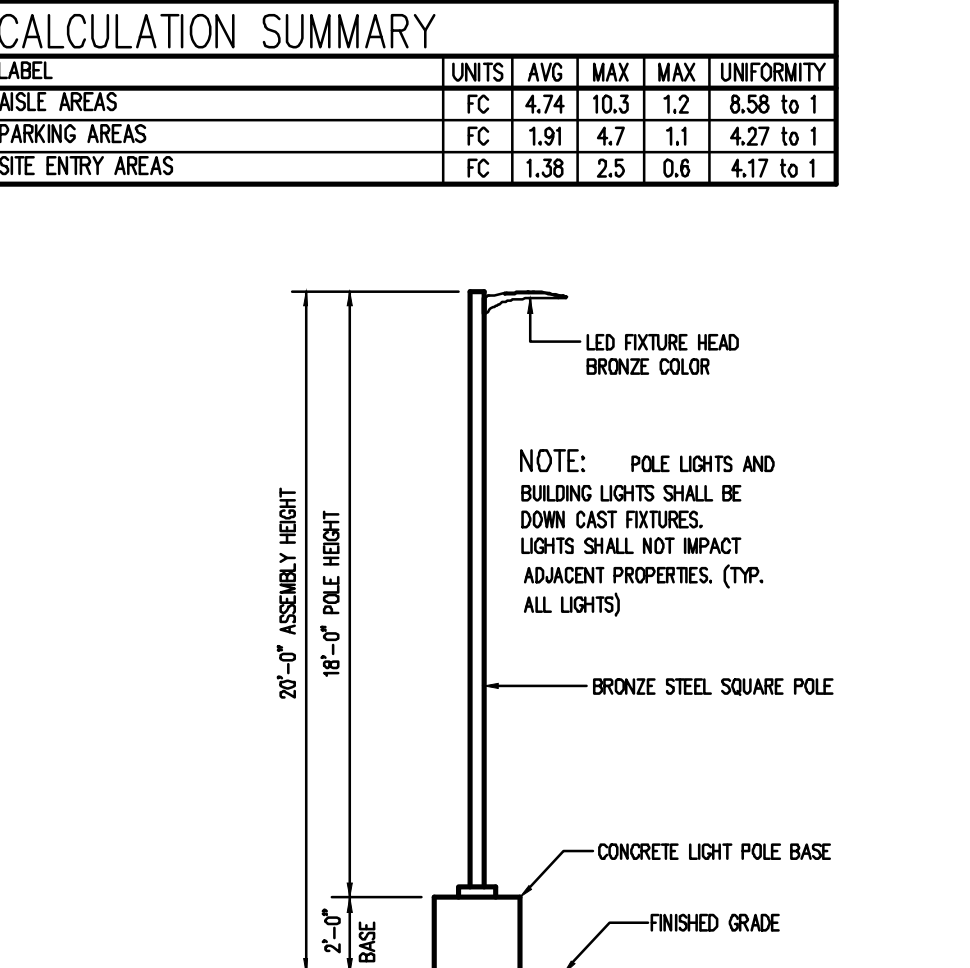

2 AREA LIGHT DETAIL  
SCALE: NOT TO SCALE