

COPYRIGHT
THESE PLANS ARE AN INSTRUMENT OF SERVICE
AND ARE THE PROPERTY OF GALLOWAY, AND MAY
NOT BE DUPLICATED, DISCLOSED, OR REPRODUCED
WITHOUT THE WRITTEN CONSENT OF GALLOWAY.
COPYRIGHTS AND INFRINGEMENTS WILL BE
ENFORCED AND PROSECUTED.





SITE DEVELOPMENT PLAN
MERIDIAN STORAGE
MERIDIAN STORAGE, LLC
PPR2336
STATE OF COLORADO, MERIDIAN ROAD & OWL PLACE
EL PASO COUNTY, FALCON, CO 80931

Table with 4 columns: #, Date, Issue / Description, Init.

Project No: MRS01
Drawn By: ASA, BLB
Checked By: BAS
Date: 04/26/2024

PHOTOMETRIC PLAN AND DETAILS

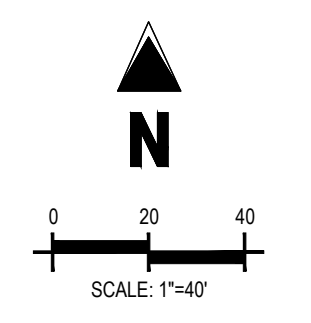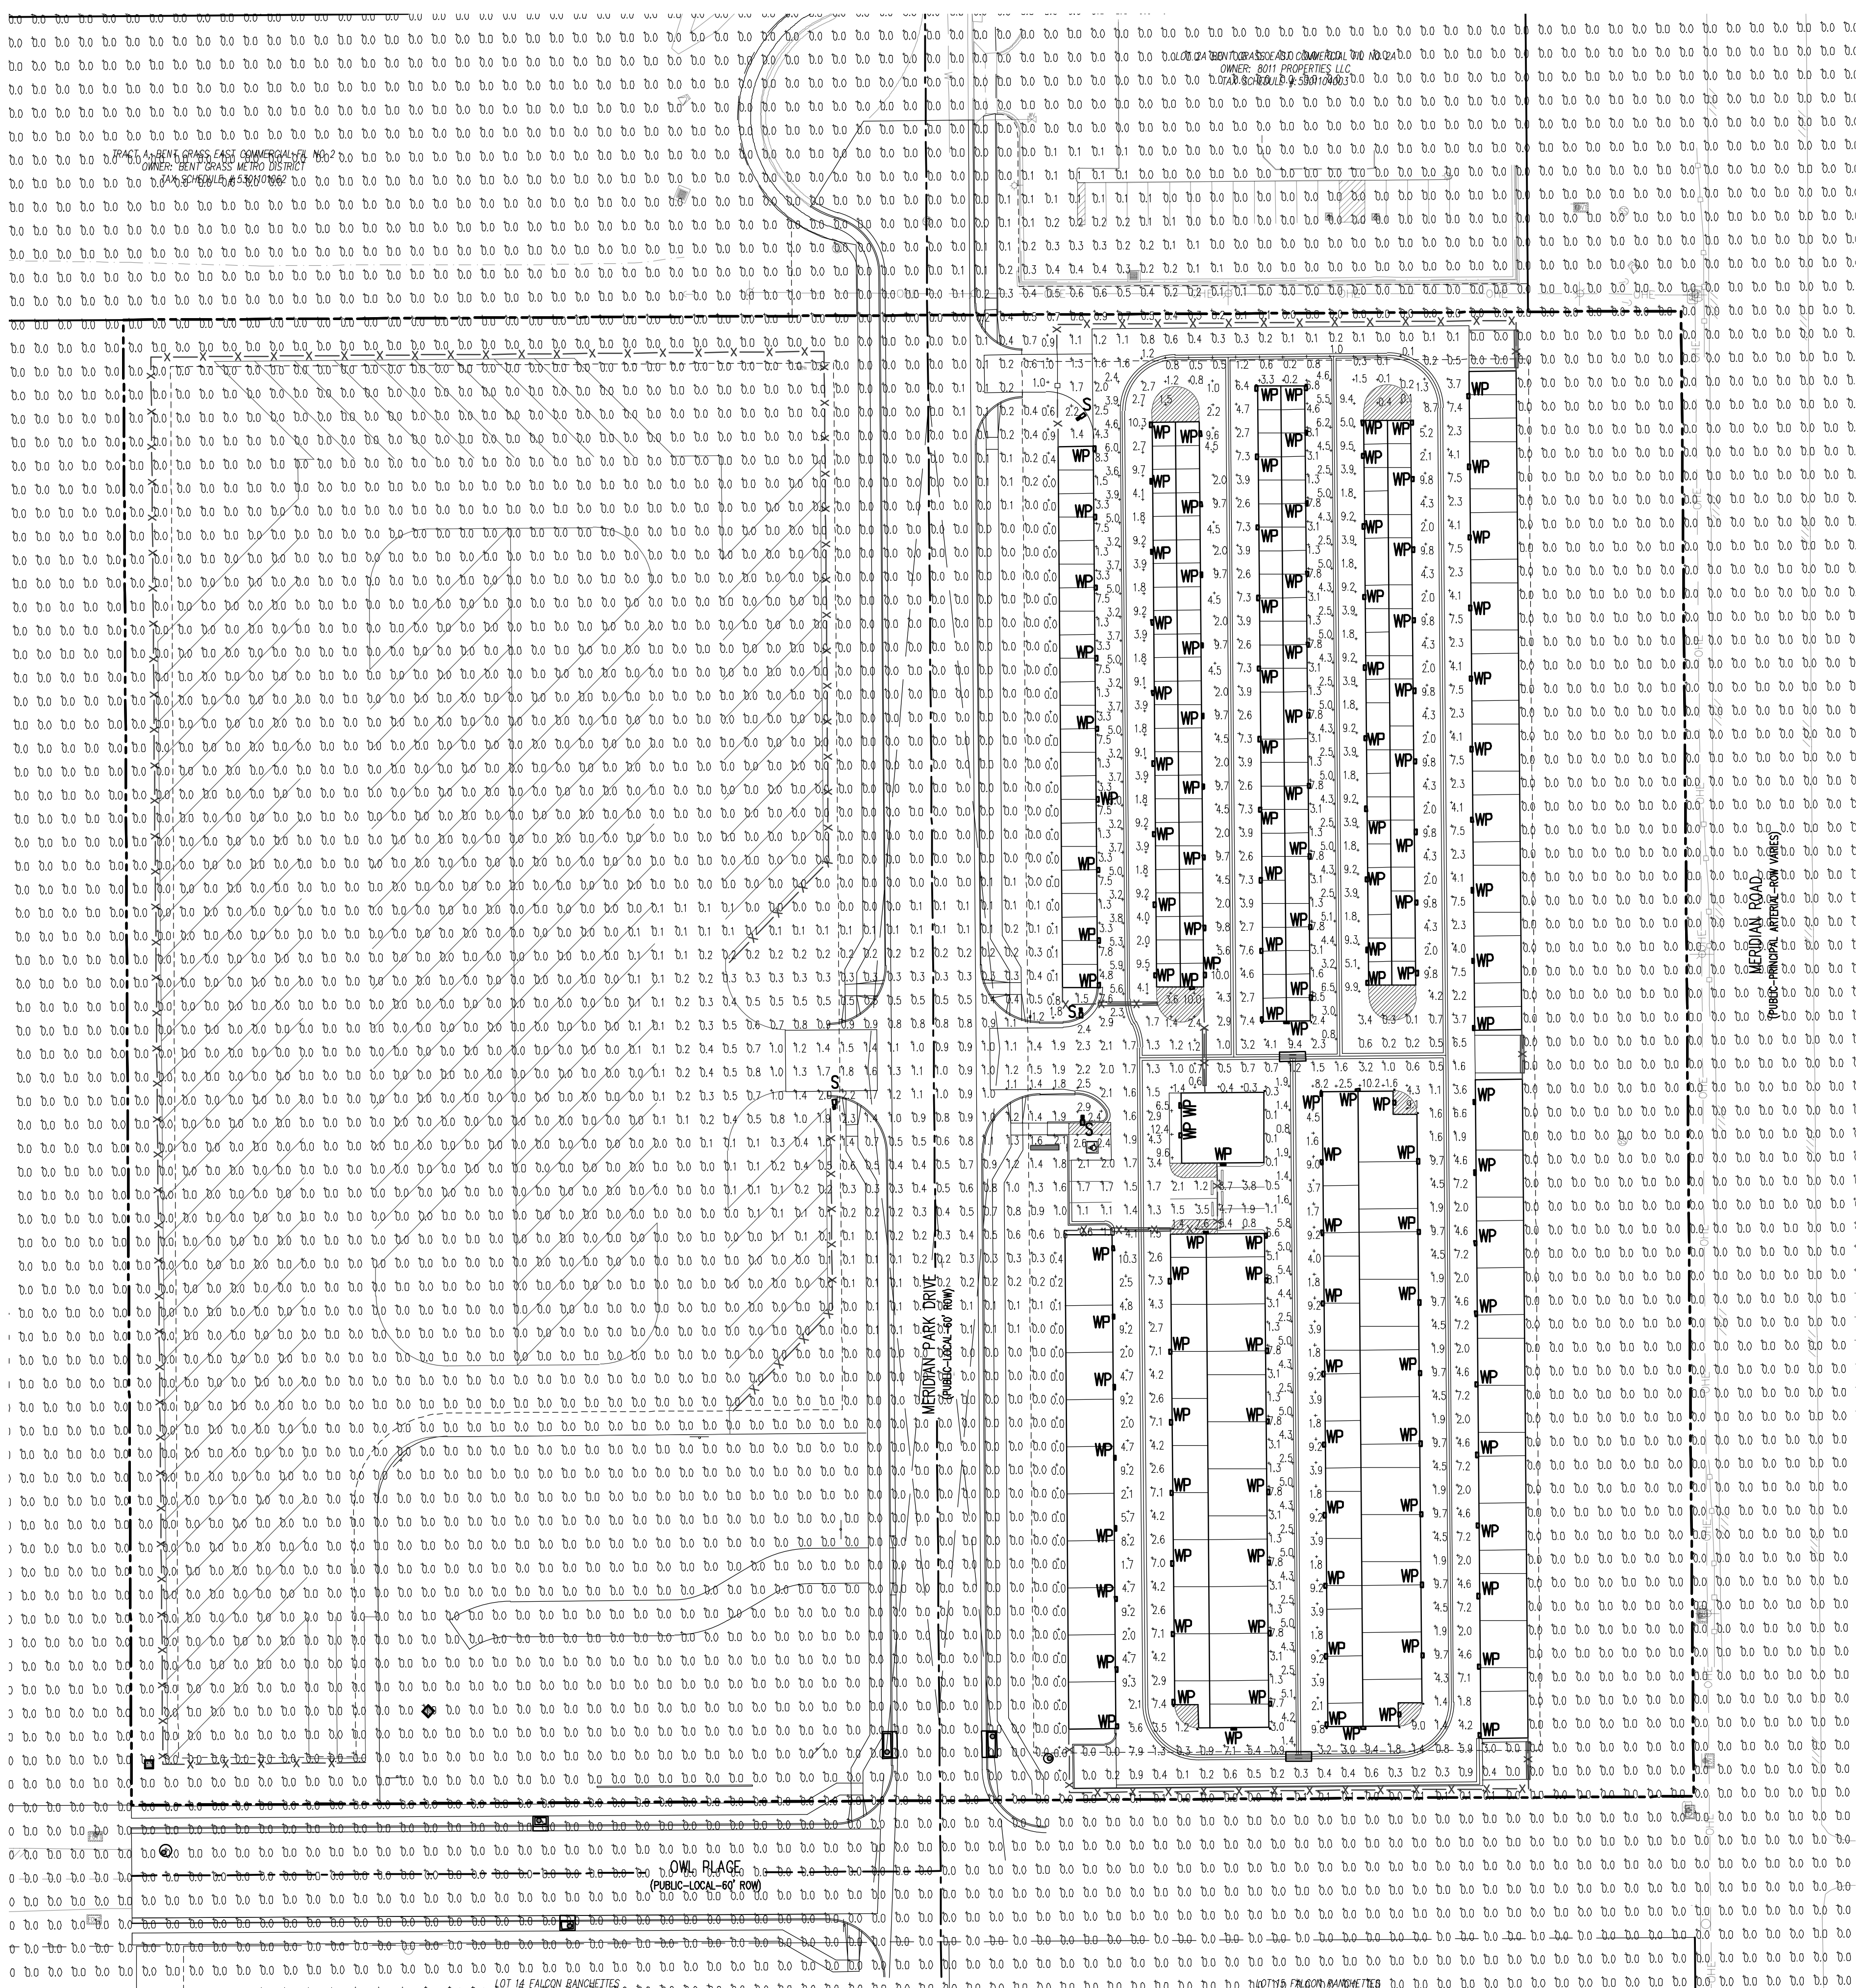

D-Series Size 0 LED Area Luminaire
Specifications: 60W, 5.0 ft, 26.1" length, 14.5" width, 2.3" height, 2.3" depth, 7.6" weight.
Introduction: The modern styling of the D-Series features a highly refined aesthetic that blends seamlessly into any environment.


WEDGE1 LED Architectural Wall Sconce
Specifications: Depth 0.75", Height 8", Weight 1.5 lb.
Introduction: The WEDGE1 family is designed to meet specifier's every wall-mounted lighting need in a widely accepted shape that blends with any architecture.

Ordering Information table for D-Series and WEDGE1 fixtures, including columns for item, description, quantity, and notes.

Ordering Information table for WEDGE1 LED Family, including columns for item, description, quantity, and notes.

LUMINAIRE SCHEDULE table with columns: MARK, QTY, LABEL, MOUNTING, ARRANGEMENT, LLF, CATALOG NUMBER, DESCRIPTION, LUMENS, WATTS.

CALCULATION SUMMARY table with columns: LABEL, UNITS, AVG, MAX, UNIFORMITY.

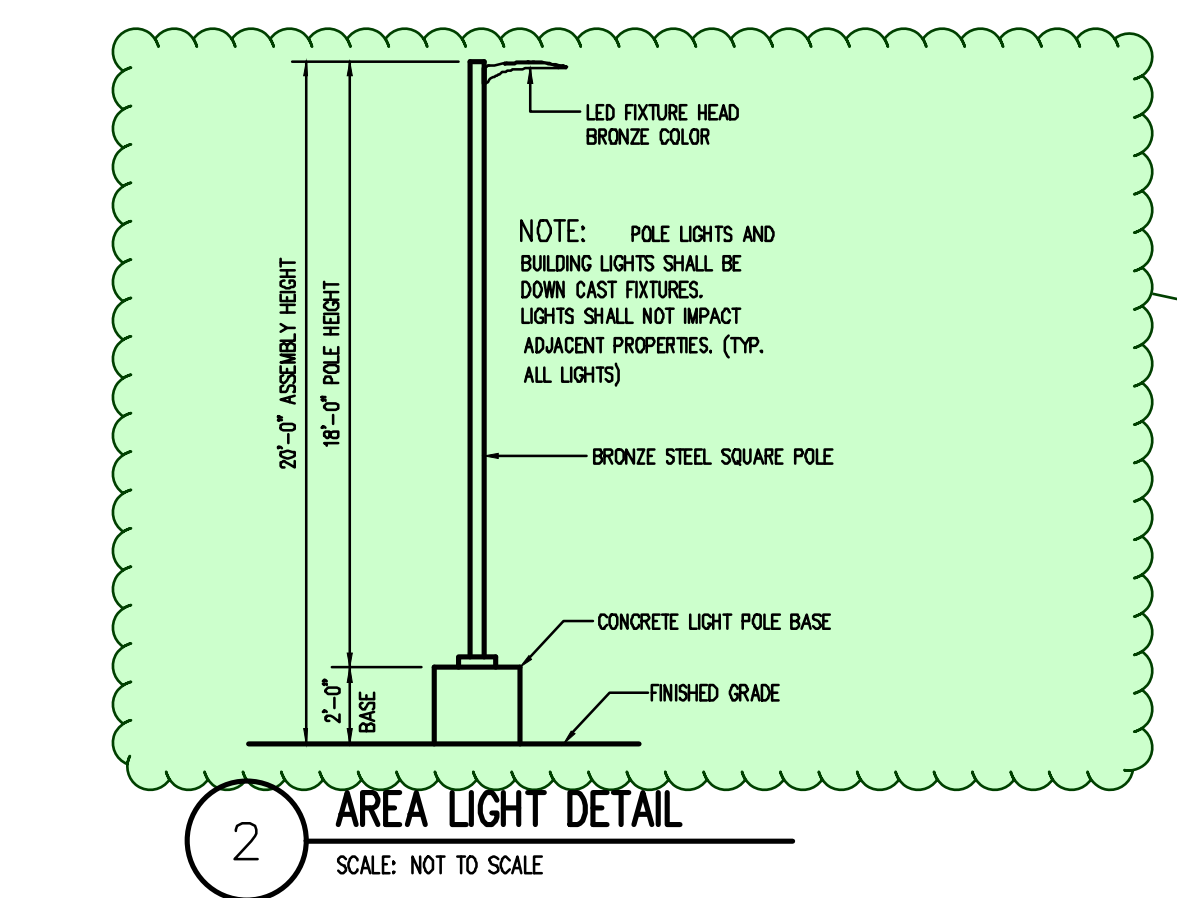

2 AREA LIGHT DETAIL
SCALE: NOT TO SCALE