
 
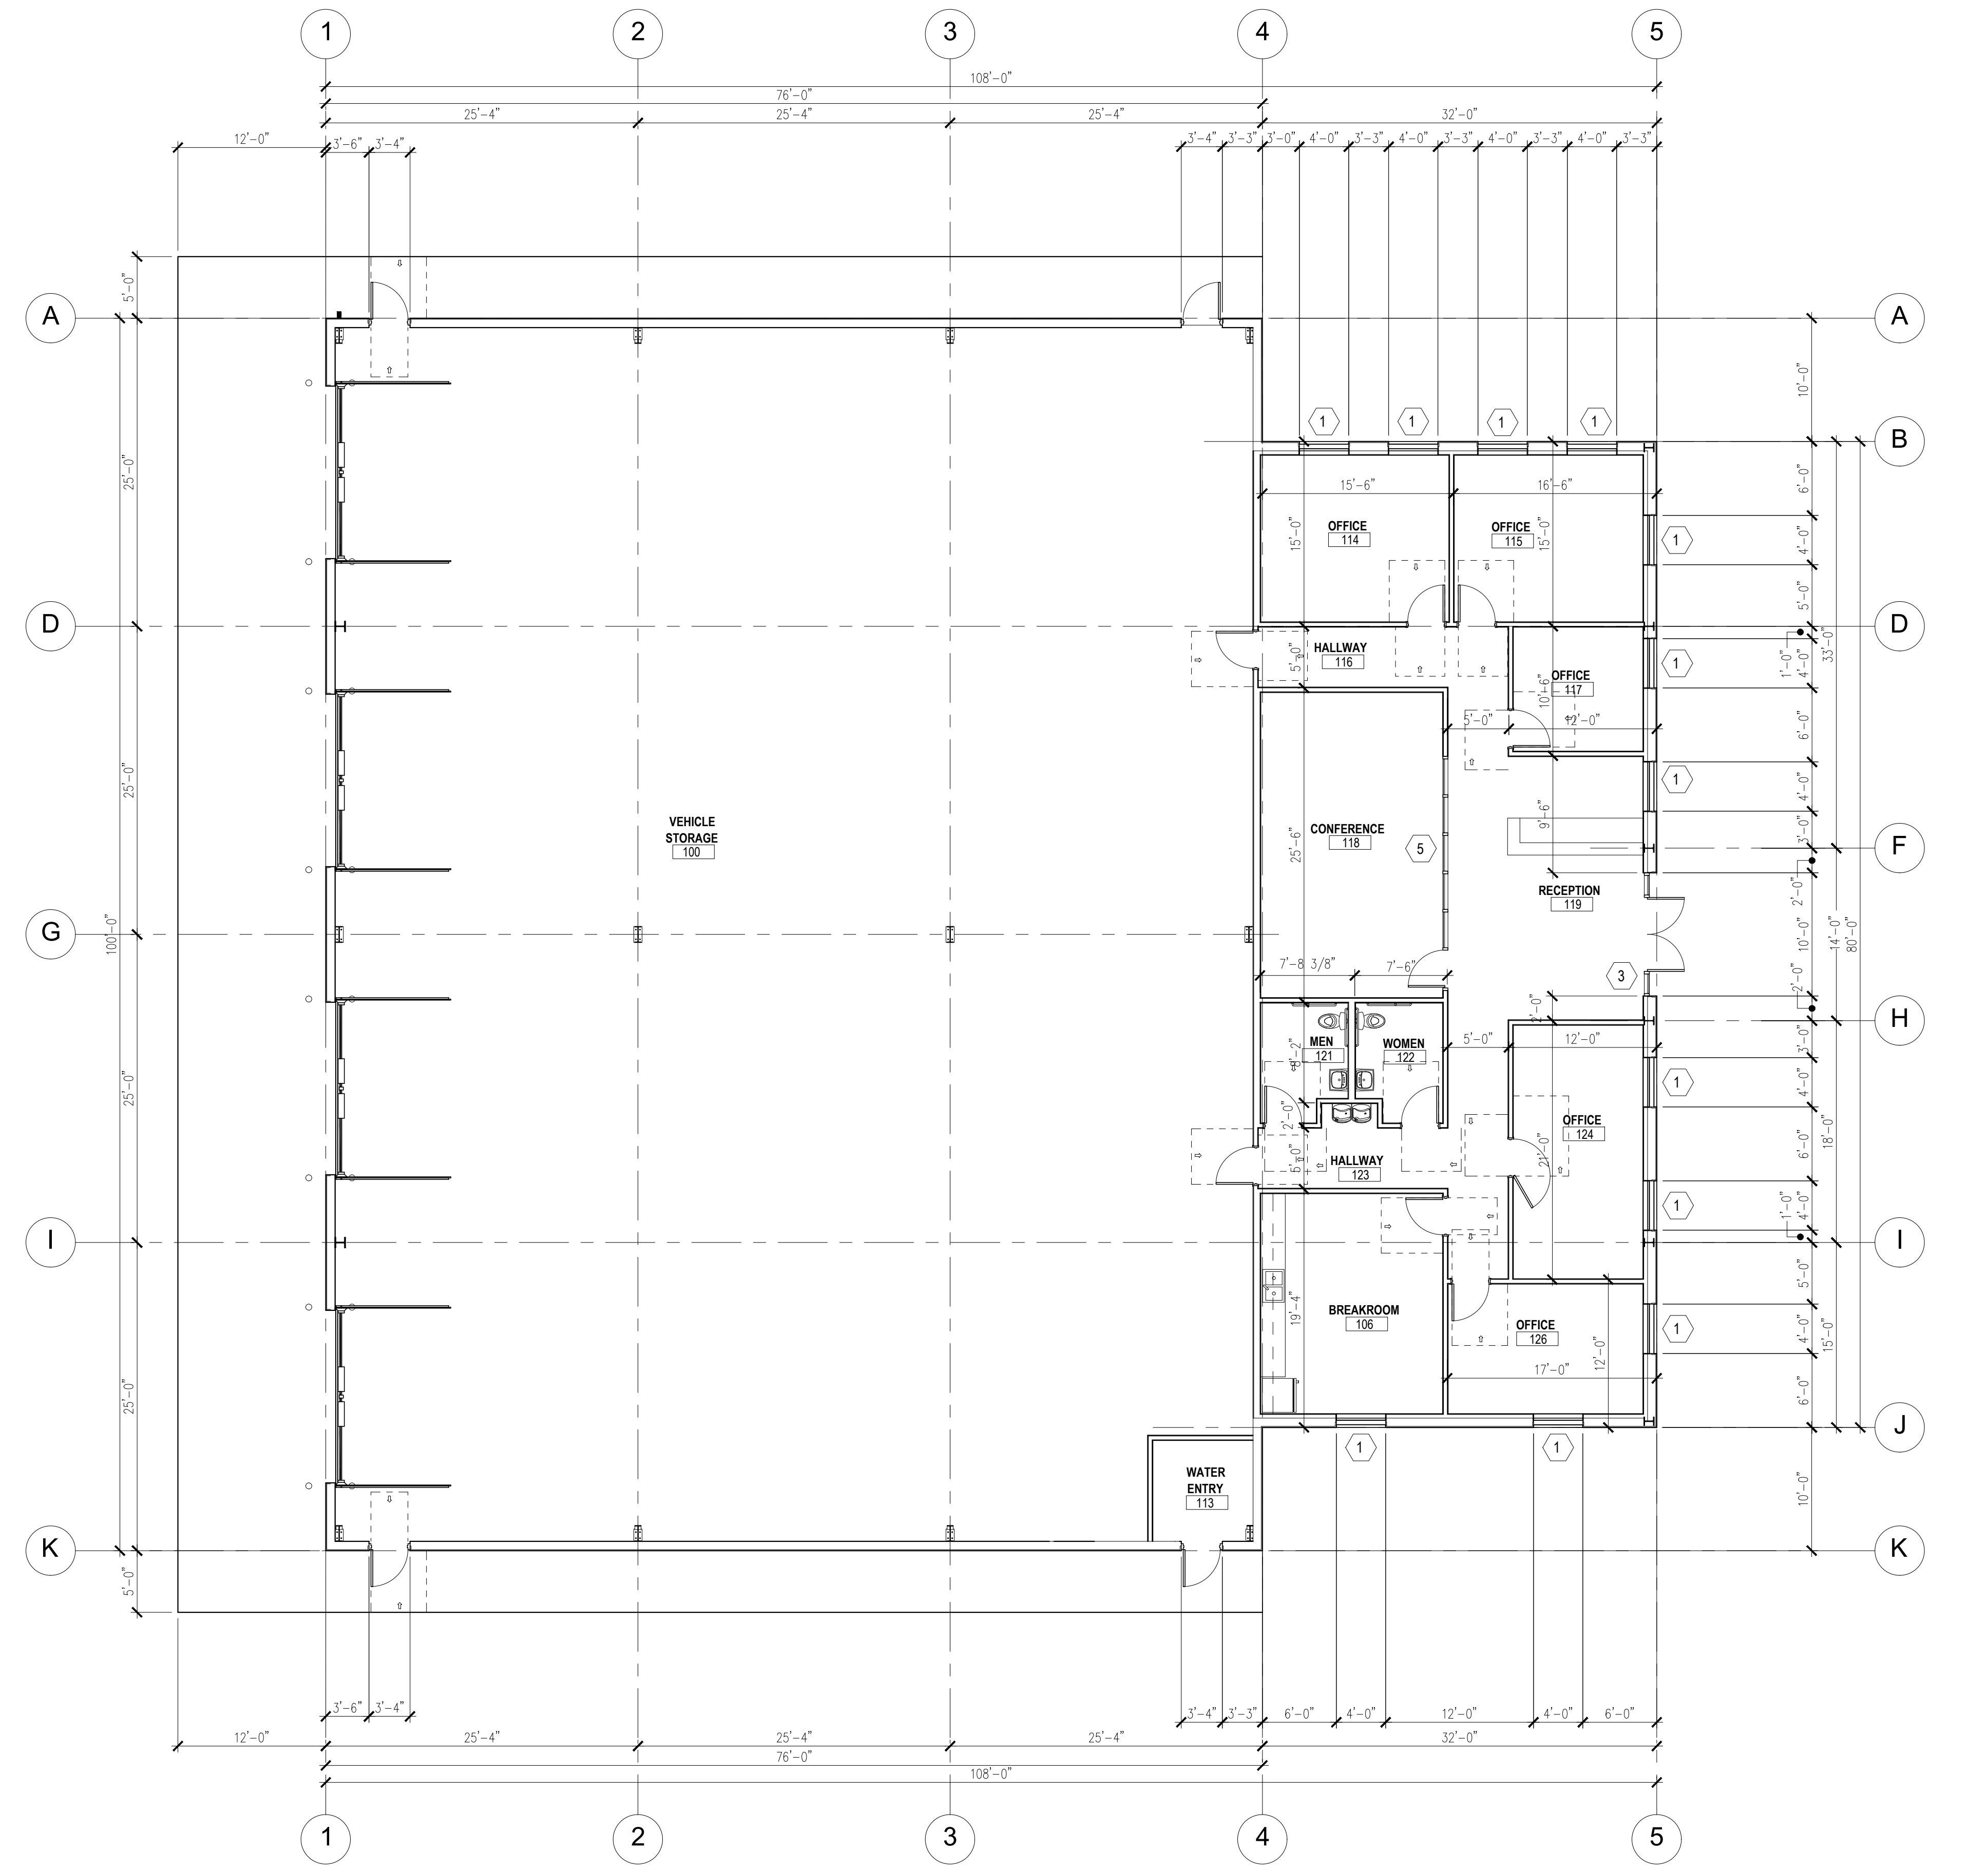


J:\01_PROJECTS\2021 Projects\02-1115 Black Diamond Cable\04 AUTOCAD\A-110\Fir Plan_5/27/2022 10:44:55 AM




1 FIRST FLOOR
 A-110 1/8" = 1'-0"

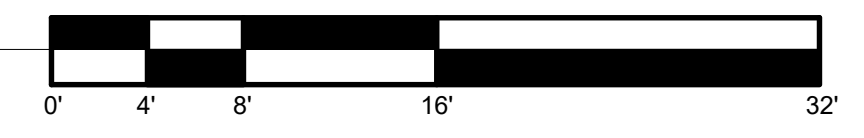

Design Development
 Consultants @
 1310 FORD STREET
 COLORADO SPRINGS, CO 80915 (719) 570-1456
 (C) ALL RIGHTS RESERVED

Revisions	
#	DATE

BLACK DIAMOND CABLE

7315 COLE VIEW
COLORADO SPRINGS, CO 80915

D2-1115

CDS

DATE 05-18-2022

CHECKED -

DRAWN BY -

FLOOR PLAN

A-110