

# LILLYWOOD SHOW STABLES RIDING ACADEMY

A PORTION OF THE SOUTHWEST QUARTER OF SECTION 15, TOWNSHIP 11 SOUTH,  
RANGE 65 WEST OF THE 6TH P.M., EL PASO COUNTY, COLORADO  
EL PASO COUNTY, COLORADO



Wall Mounted Lighting, Night Exhibit



Wall Mounted Lighting, Night Exhibit




Wall Mounted Lighting




Wall Mounted Lighting



Wall Mounted Lighting

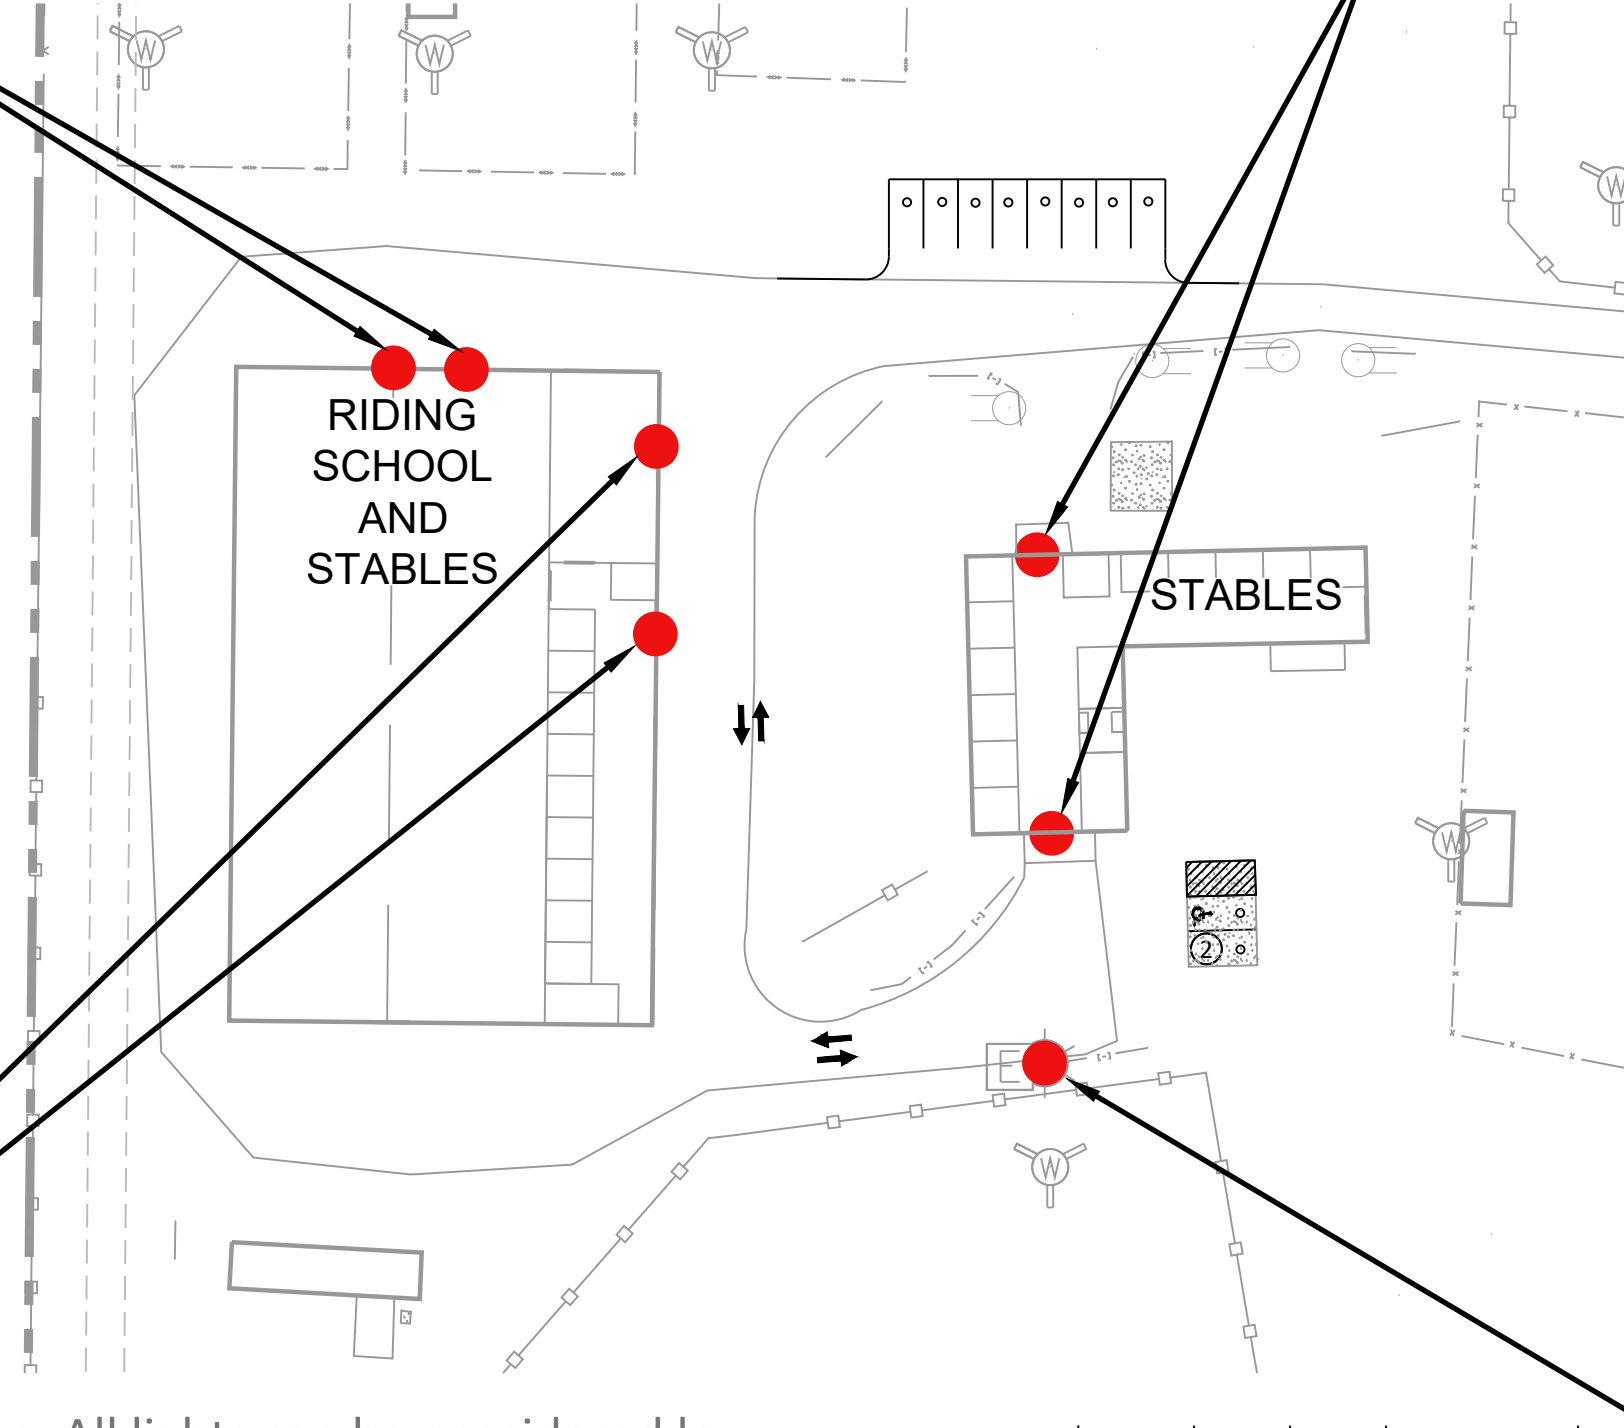

Note: All lights can be considered low impact and downward facing. No light emanates beyond the property boundary.

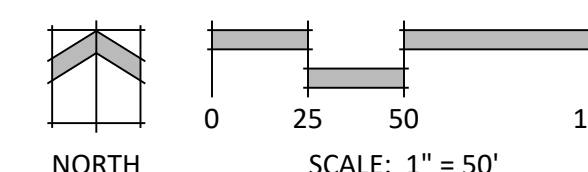

Light Pole



N.E.S. Inc.  
619 N. Cascade Avenue, Suite 200  
Colorado Springs, CO 80903

Tel. 719.471.0073  
Fax 719.471.0267

www.nescolorado.com

© 2012. All Rights Reserved.

PLANNER / LANDSCAPE ARCHITECT

BY ASSOCIATION WITH

STAMP

ISSUE INFO

ISSUE / REVISION

SHEET TITLE

SHEET NUMBER

PLAN FILE #

## LILLYWOOD SHOW STABLES RIDING ACADEMY

SITE DEVELOPMENT PLAN

9210 MORGAN RD  
COLORADO SPRINGS  
CO, 80908

DATE: 3/14/24  
PROJECT MGR: E. TROLLER  
PREPARED BY: A. ROMAN

DATE:	BY:	DESCRIPTION:

### LIGHTING PLAN