



**4** WDGE2 Wallpack (WP2, WP3)  
Scale: None




**3** WDGE1 Wallpack (WP1)  
Scale: None



**2** DSX1 Area Luminaire (AL1, AL2)  
Scale: None

Calculation Zone Statistics						
Description	Symbol	Average (FC)	Maximum (FC)	Minimum (FC)	Max./ Min. (FC)	Avg./ Min. (FC)
Parking Lot	+	1.4	2.8	0.4	7.0:1	3.5:1
Drive Way	+	1.2	2.4	0.2	12.0:1	6.0:1

Light Fixture Schedule							
Mark	Manufacturer	Model	Description	Bulb Type	Mounting	Watts Per Fixture (W)	Voltage (V)
AL1	Lithonia	(2) DSX1 LED P3 40K 80CRI T5W	Area Luminaire, Twin Head	LED	Pole @ 20', Base @ 3'	204.3	120-277
AL2	Lithonia	DSX1 LED P3 40K 80CRI T2M	Area Luminaire	LED	Pole @ 20', Base @ 3'	102.2	120-277
WP1	Lithonia	WDGE1 LED P2 40K 80CRI VW	Wallpack	LED	Wall Surface	15.0	120-277
WP2	Lithonia	WDGE2 LED P4 40K 80CRI T2M	Wallpack	LED	Wall Surface	46.7	120-277
WP3	Lithonia	WDGE2 LED P4 40K 80CRI TFTM	Wallpack	LED	Wall Surface	46.7	120-277

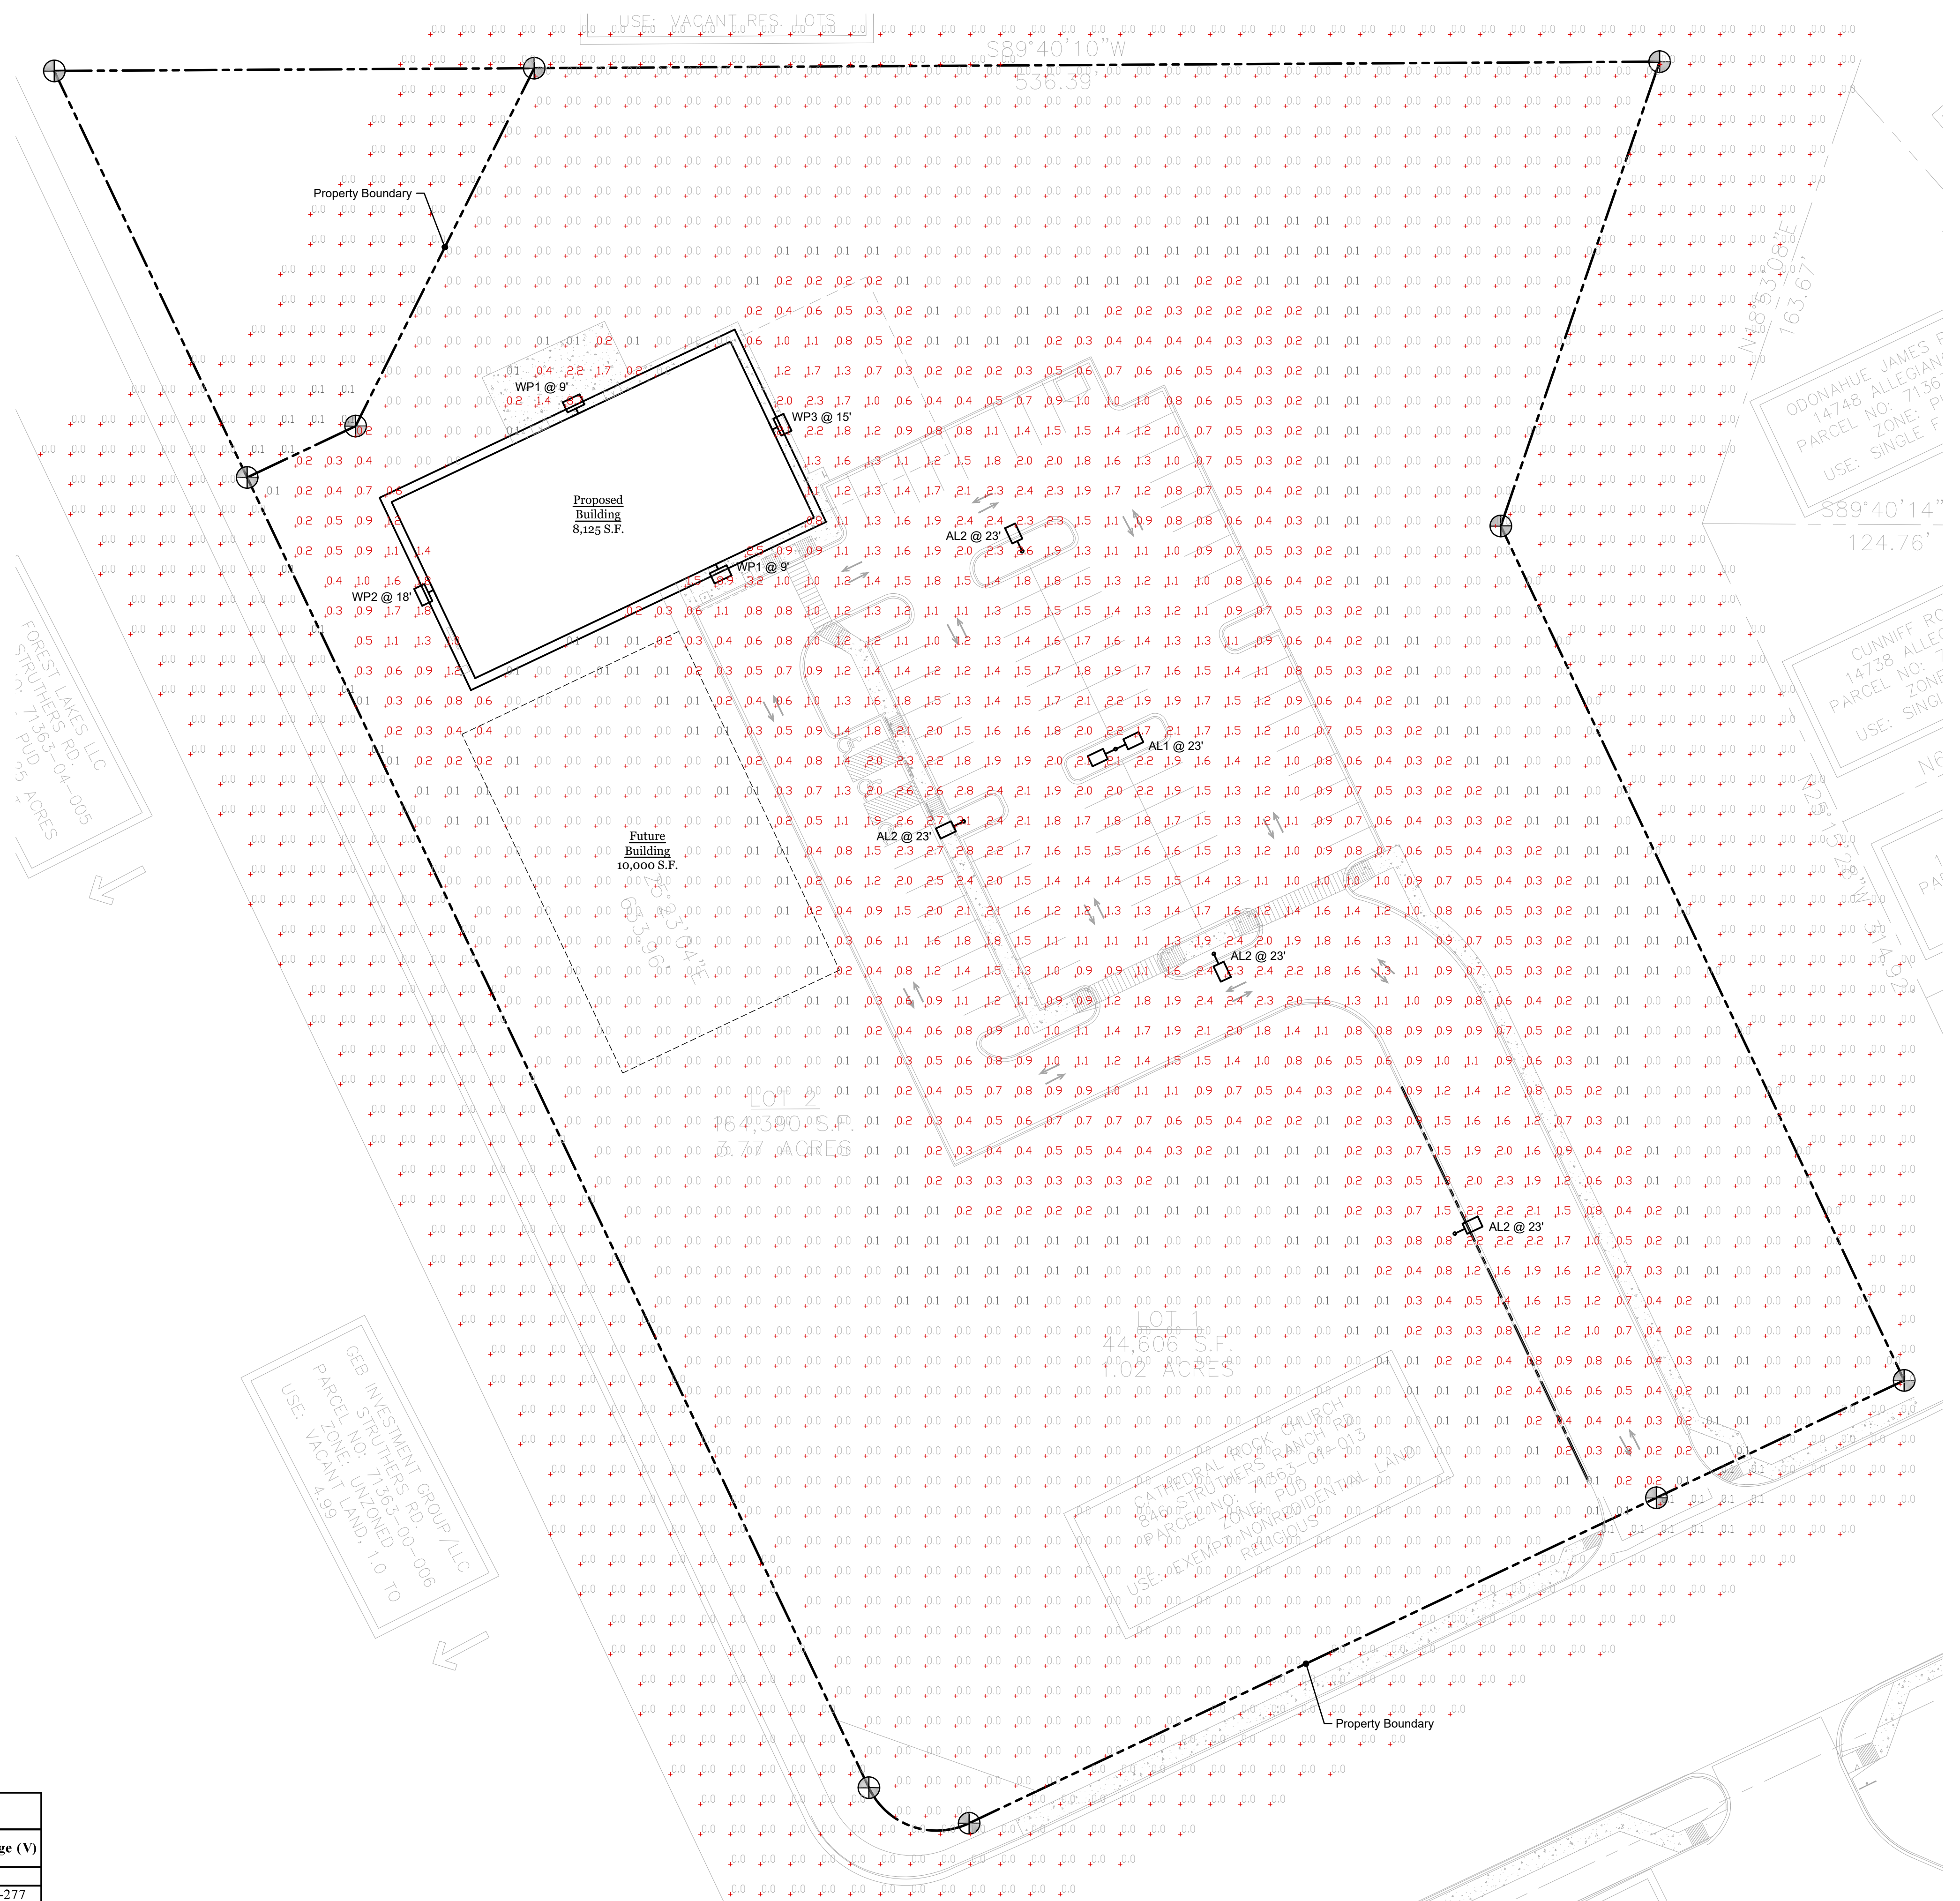

**1** Site Photometric Plan  
Scale: 1"=30'-0"

**CATHEDRAL ROCK Church**  
846 Struthers Ranch Rd.  
Colorado Springs, CO 80921  
El Paso County, Colorado

**HAMMERS CONSTRUCTION INC.**  
COMMERCIAL GENERAL CONTRACTORS SPECIALIZING IN DESIGN/BUILD  
PRESIDENT: STEVE R. HAMMERS  
VICE PRES: DAVID J. HAMMERS  
COLORADO SPRINGS, CO 80915  
(719) 570-1599 FAX (719) 570-3008  
www.hammersconstruction.com

**COLORADO LICENSED PROFESSIONAL ENGINEER**  
CORRE C. FORRESTER  
60643  
08.16.2024

**PETRICHOR SOLUTIONS LLC**  
Petrichor Solutions, LLC  
101 N. Cascade Ave. Suite 400  
Colorado Springs, CO 80903

#	Revision	Date

Date: 08.16.2024  
Project No.: 0236  
Drawn: CCF  
Checked: CCF

Sheet Number  
**SP0.1**



