


**CRAWFORD APARTMENTS**

1170 CRAWFORD AVE.  
 COLORADO SPRINGS, COLORADO 80911

**EXTERIOR LIGHTING PLAN**

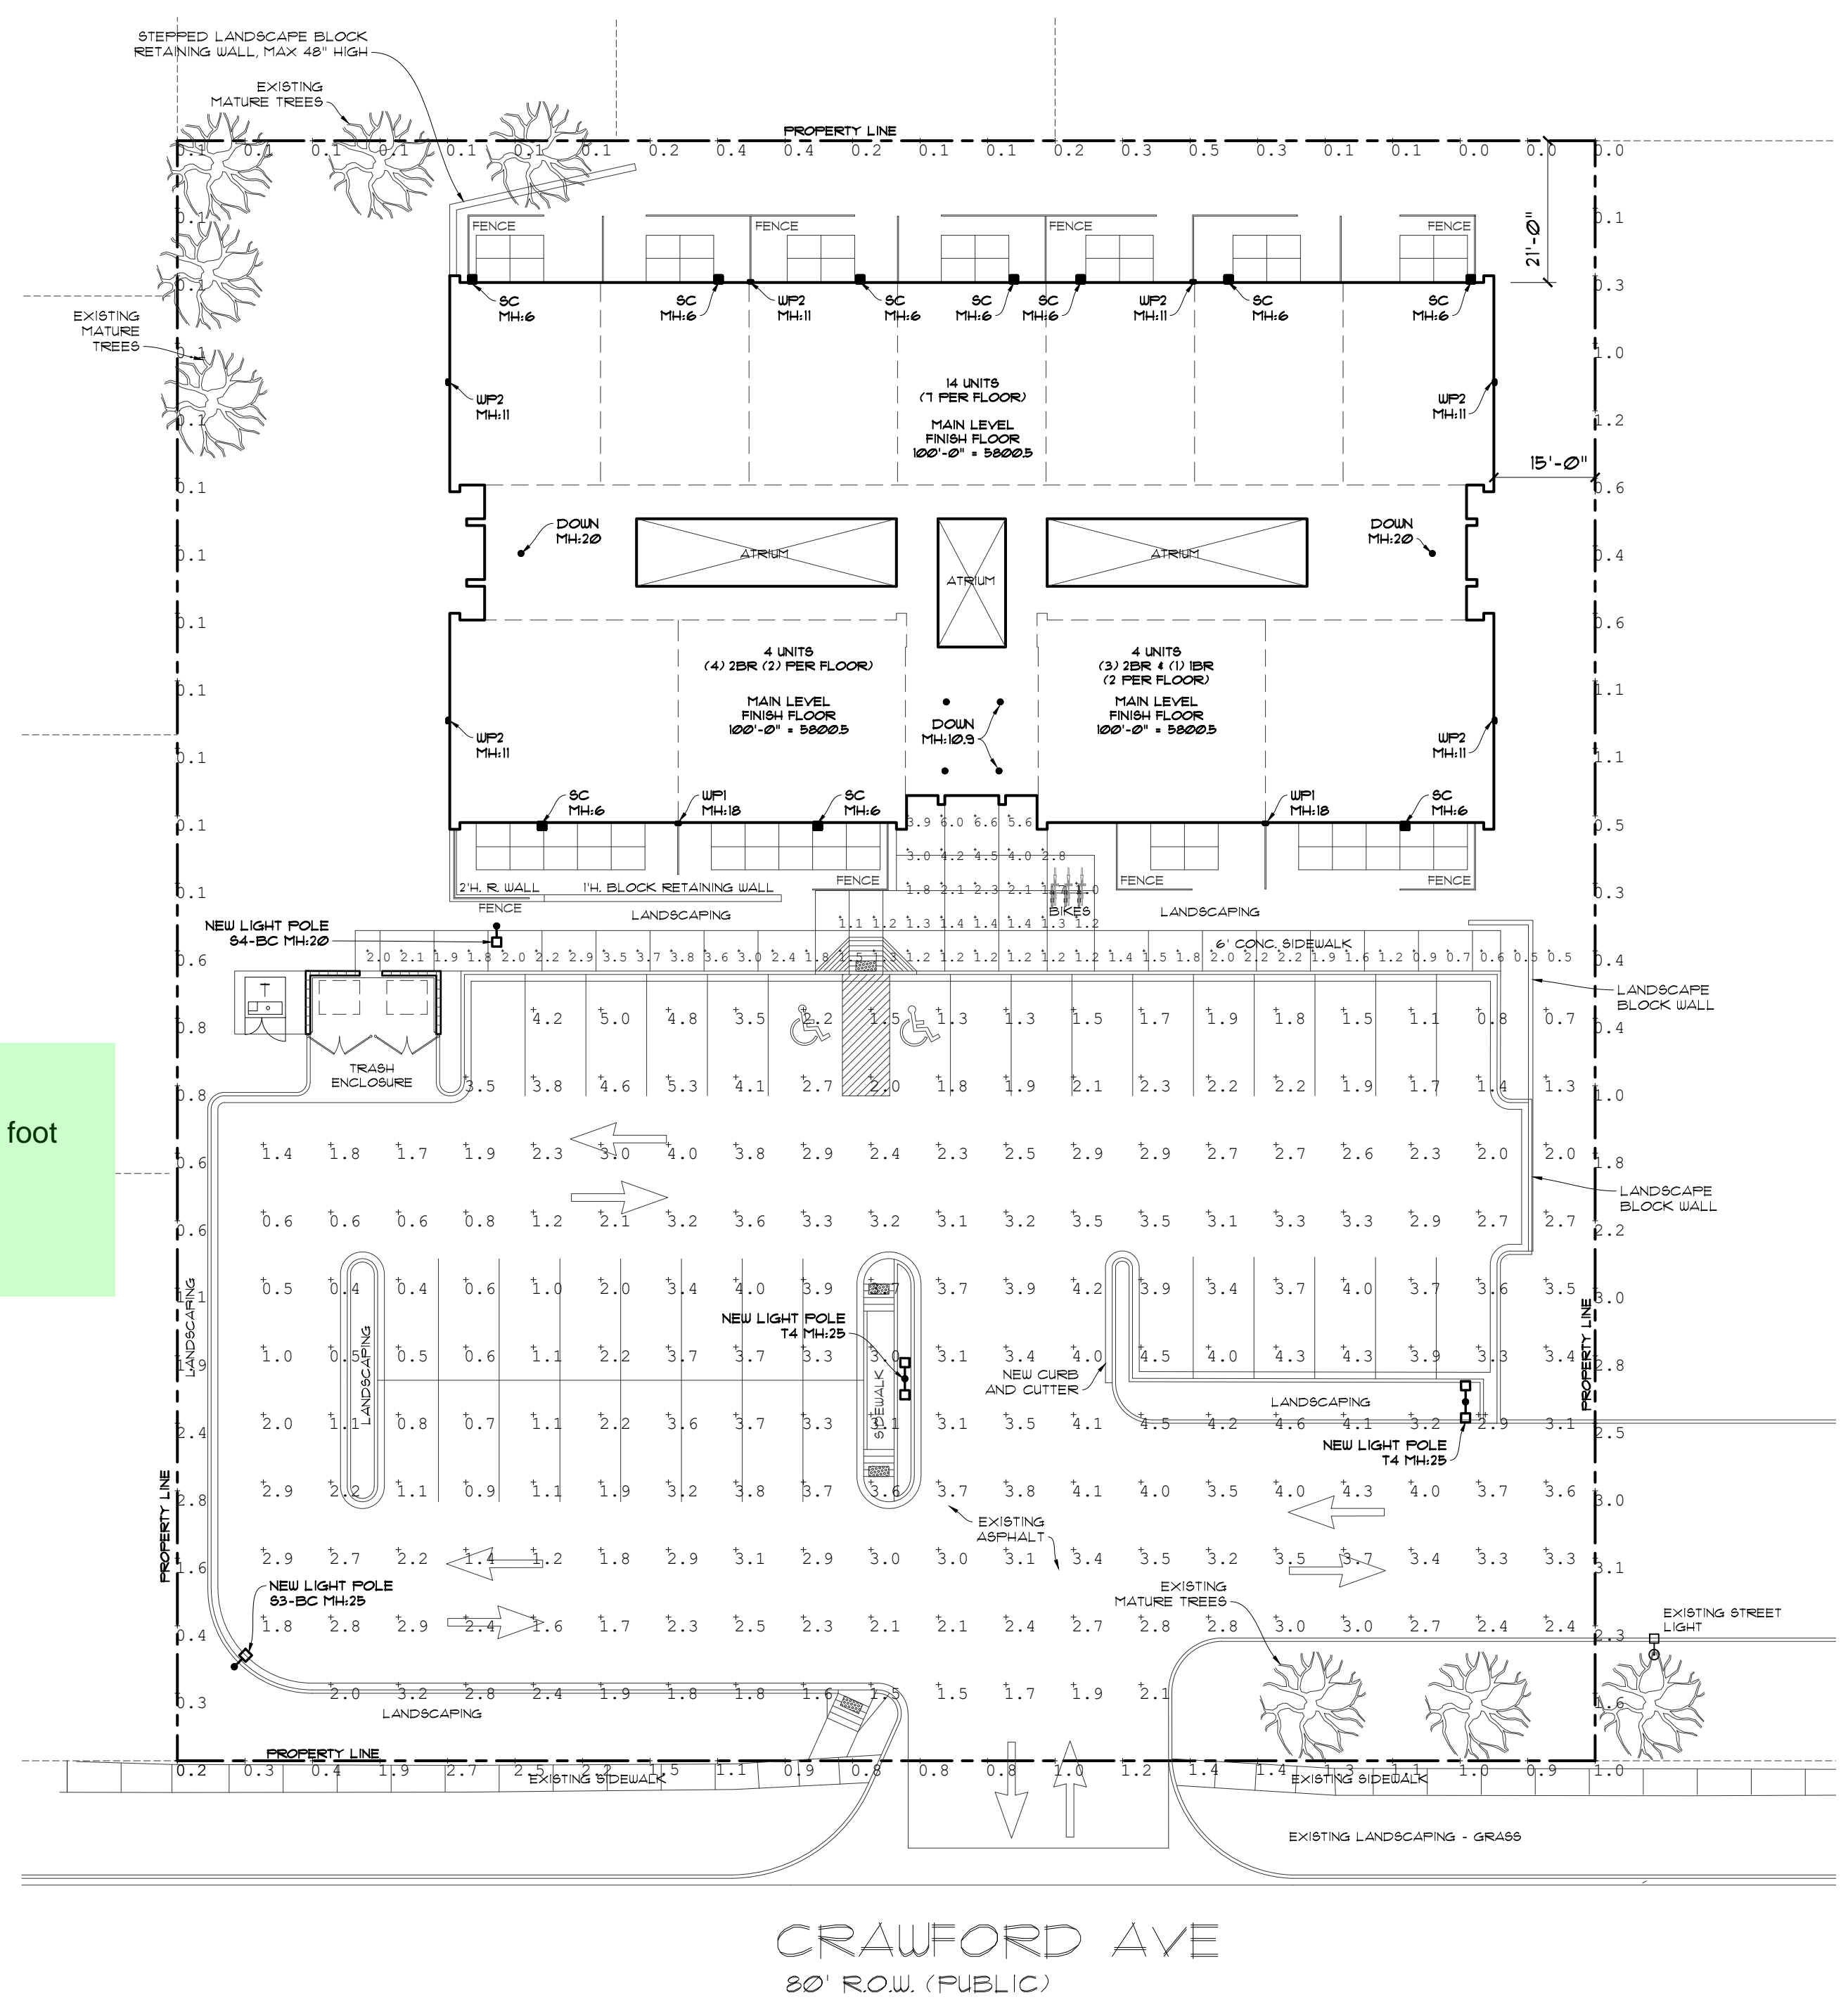

**UNRESOLVED V1 COMMENT:**  
 Lighting levels near a ROW or residential neighboring property must not exceed 0.1 foot candle levels, please adjust.  
 Section 6.2.3.B.1.e

Luminaire Schedule					
Qty	Label	Arrangement	LLF	Description	Tag
10	DOWN	SINGLE	0.855	LBRST-6RD-M-LSSLWCWS9-WH	PRESCOLITE
10	SC	SINGLE	0.599	CTO-L10.8-LT350-VOLT-DL-30K-S	TERON
2	WP1	SINGLE	0.855	SG1-40-3K7-FT	CURRENT EXO
6	WP2	SINGLE	0.855	SG1-20-3K7-FT	CURRENT EXO
1	S3-BC	SINGLE	0.855	ASL2-320L-145-3K7-3-BC	CURRENT EXO
1	S4-BC	SINGLE	0.855	ASL2-320L-145-3K7-4-BC	CURRENT EXO
2	T4	BACK-BACK	0.855	ASL2-320L-145-3K7-4W-U	CURRENT EXO

Calculation Summary							
Label	CalcType	Units	Avg	Max	Min	Avg/Min	Max/Min
FRONT WALK	Illuminance	Fc	2.16	6.6	0.5	4.32	13.20
PARKING	Illuminance	Fc	2.64	5.3	0.4	6.60	13.25
PLAYGROUND	Illuminance	Fc	5.60	9.4	0.9	6.22	10.44
PROPERTY LINE	Illuminance	Fc	0.95	3.7	0.0	N.A.	N.A.

PLAN - EXTERIOR LIGHTING  
 SCALE: 1"=20'

COUNTY FILE NUMBER: PPR2257

PROJECT NO.  
 DRN. BY:  
 L. ROES  
 REVISIONS:

REVIEW SET  
 NOT FOR  
 CONSTRUCTION  
 8-15-2023

ISSUE  
 DATE:  
 SHEET:  
**DP-5**