
 


NOTES	
1.	CONTRACTOR SHALL FIELD VERIFY ALL DIMENSIONS.
2.	ANTENNA SPECIFICATIONS REFER TO ANTENNA SCHEDULE AND TO FINAL CONSTRUCTION RFDS FOR ALL RF DETAILS.


- | NOTES | |
|-------|-----------------------------------------------------------------------------------------------------|
| 1. | CONTRACTOR SHALL FIELD VERIFY ALL DIMENSIONS. |
| 2. | ANTENNA SPECIFICATIONS REFER TO ANTENNA SCHEDULE AND TO FINAL CONSTRUCTION RFDS FOR ALL RF DETAILS. |

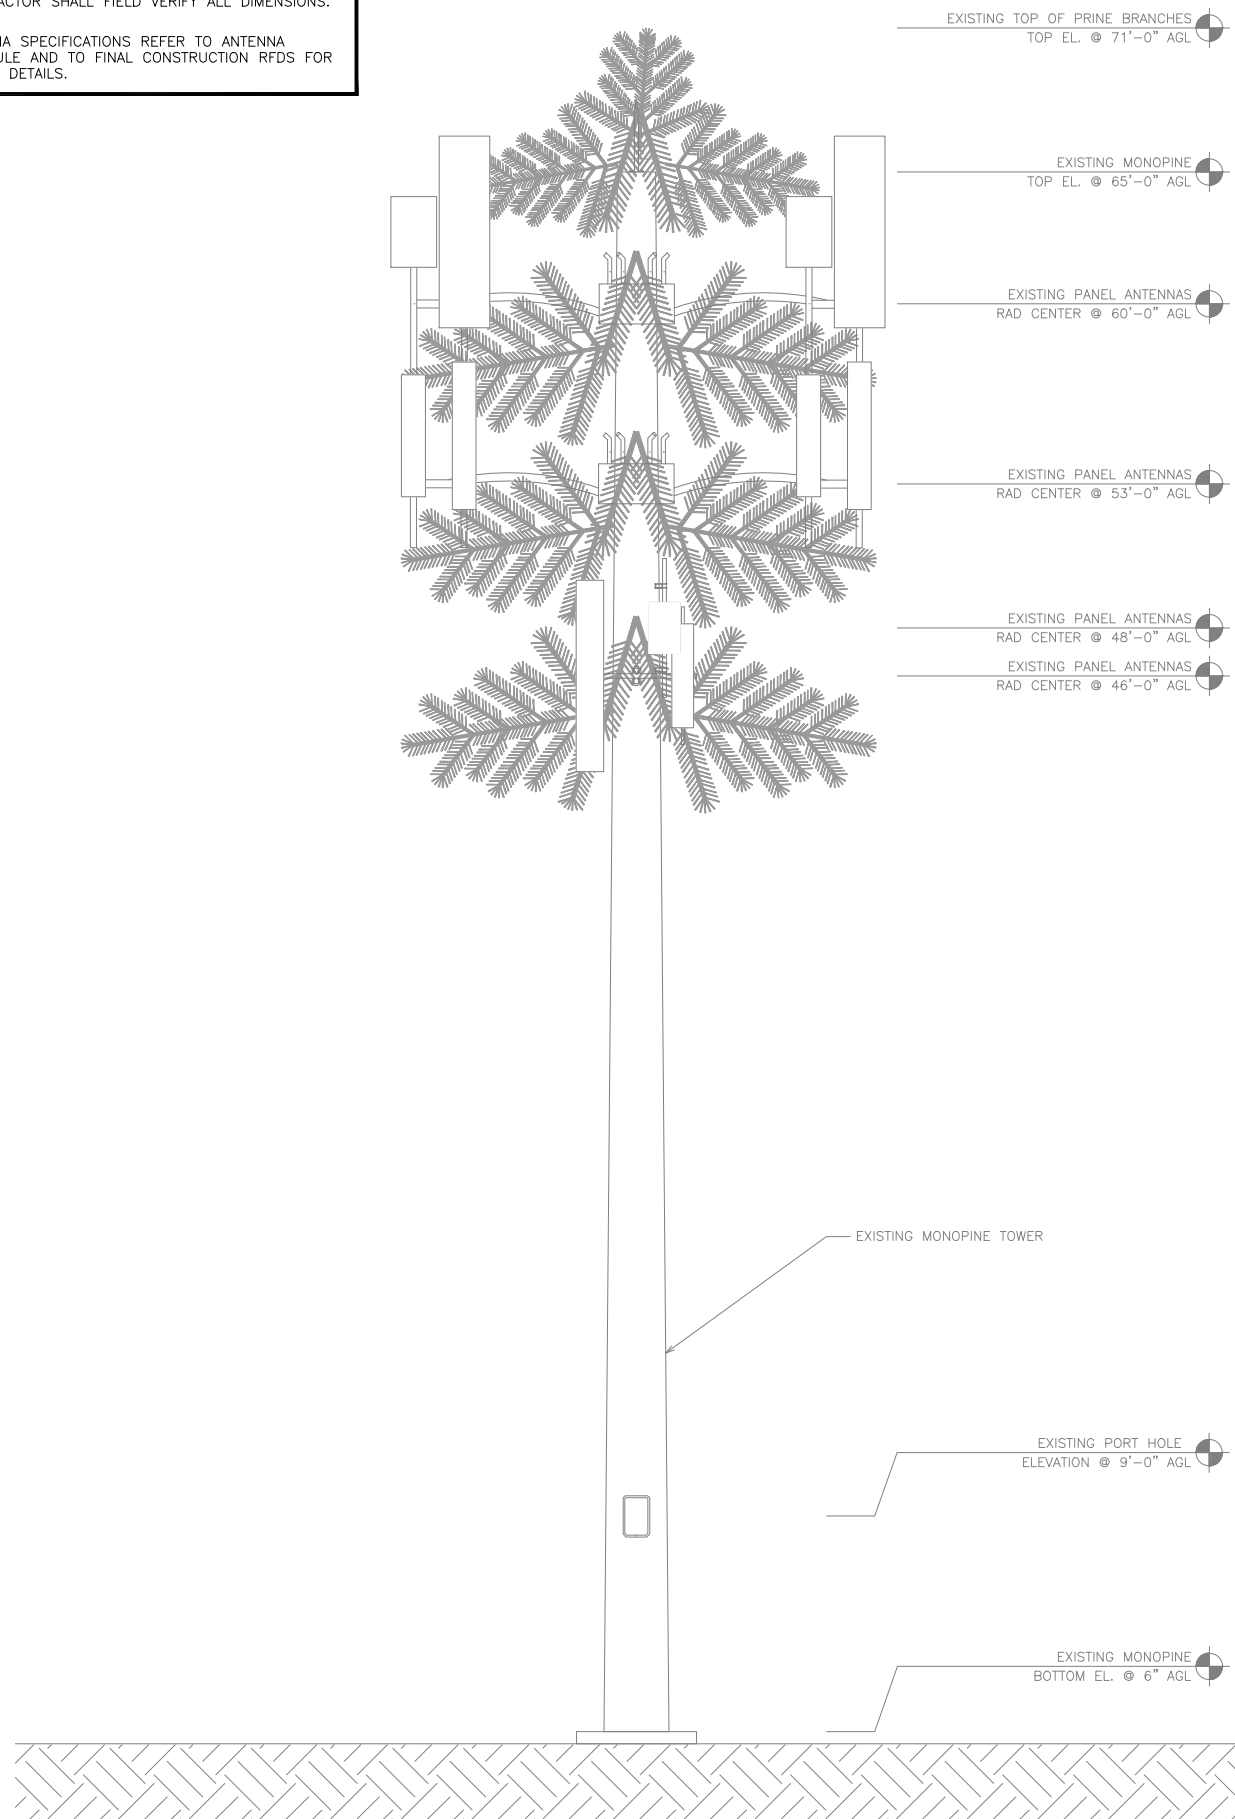


EXISTING WEST ELEVATION



1

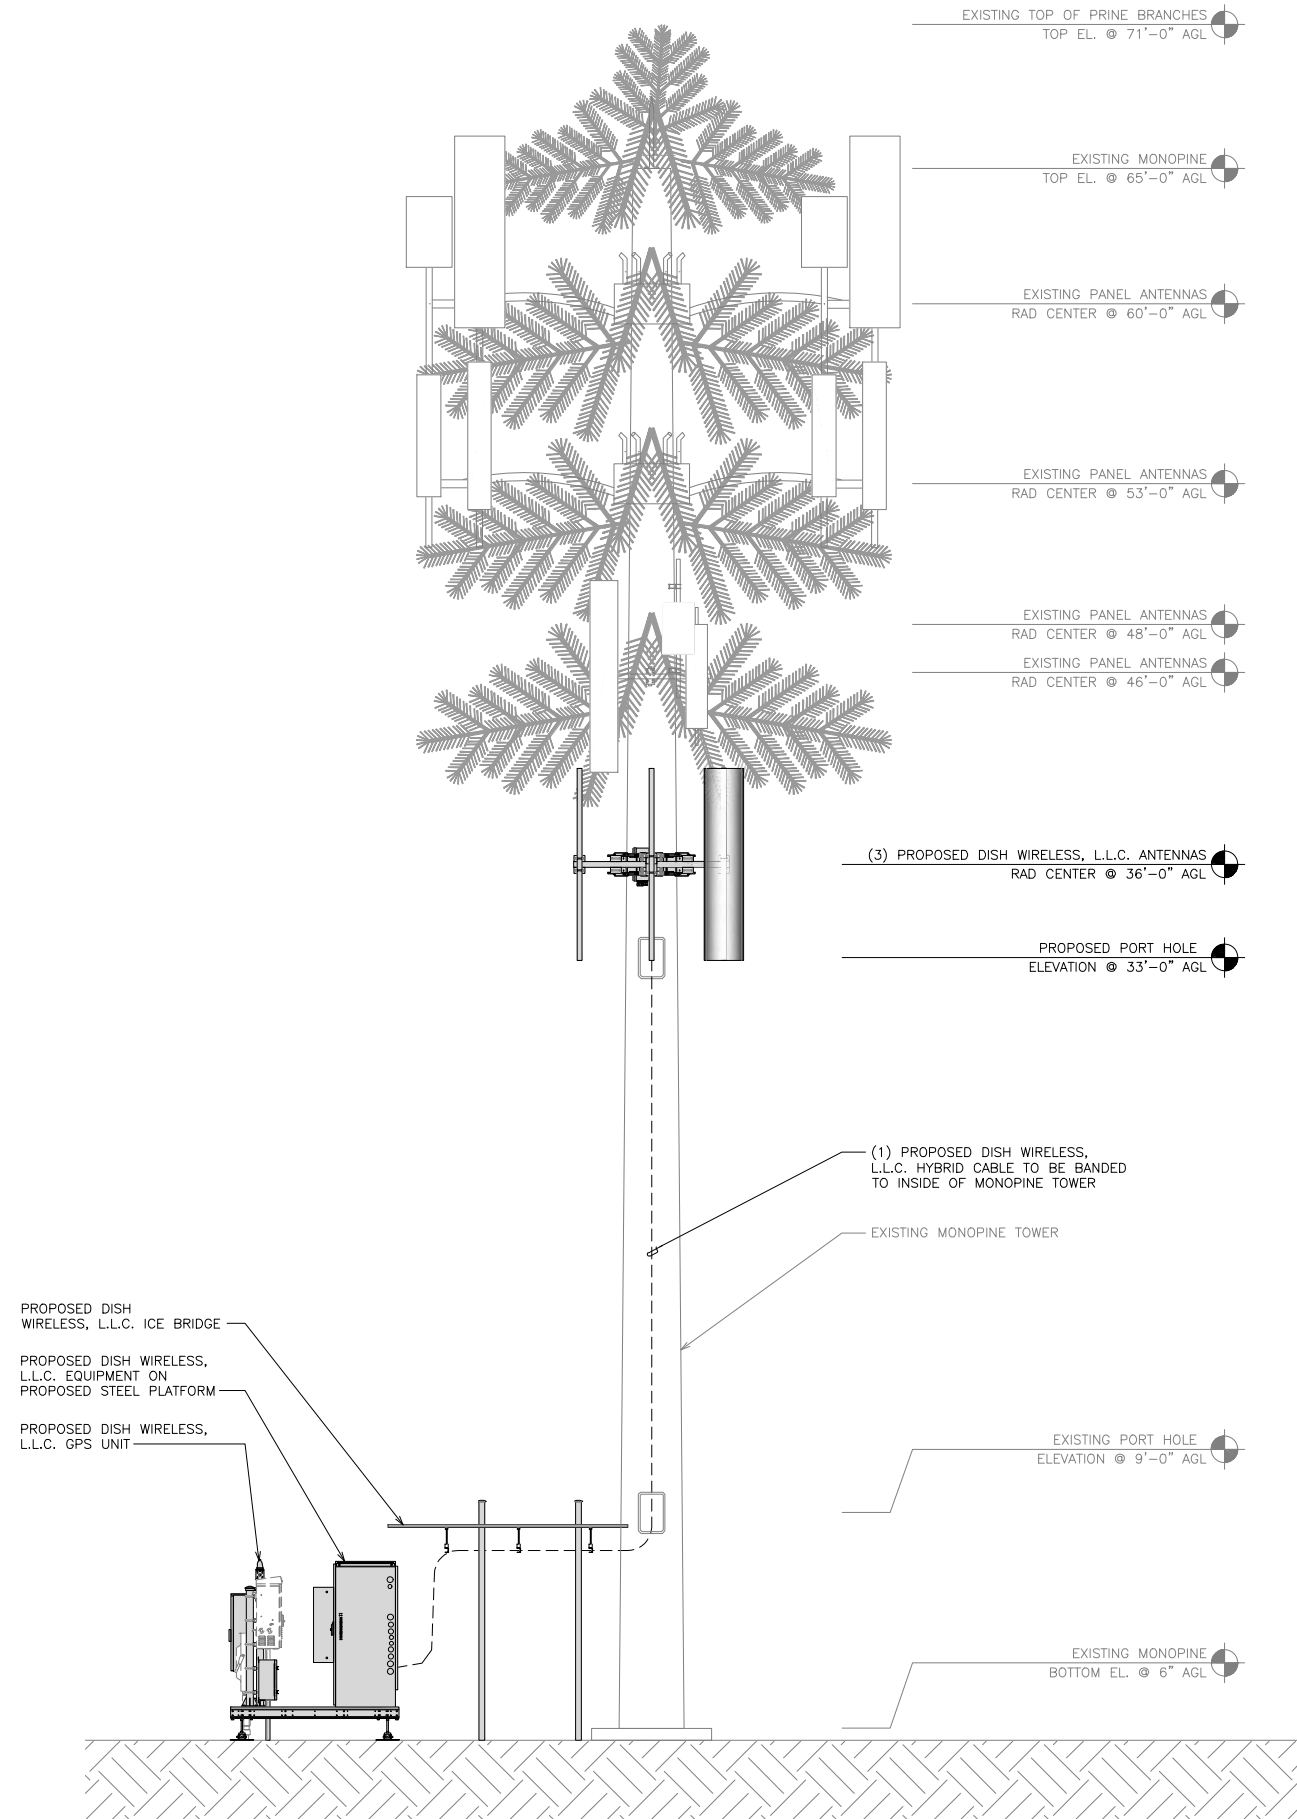


PROPOSED WEST ELEVATION

 


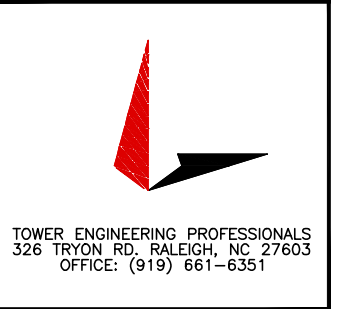
2

dish
wireless.


5701 SOUTH SANTA FE DRIVE
LITTLETON, CO 80120



TOWER ENGINEERING PROFESSIONALS
326 TRYON RD. RALEIGH, NC 27603
OFFICE: (919) 661-6351



TOWER ENGINEERING PROFESSIONALS
326 TRYON RD. RALEIGH, NC 27603
OFFICE: (919) 661-6351

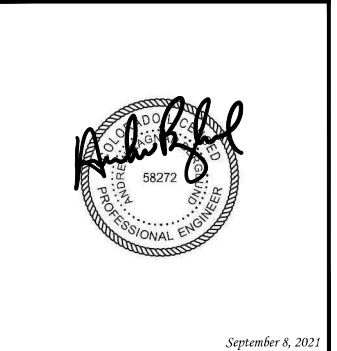

A circular professional engineer seal for the State of Ohio. The outer ring contains the text "STATE OF OHIO" at the top and "PROFESSIONAL ENGINEER" at the bottom, separated by dots. Inside the ring, the name "Richard J. L." is written in a large, stylized cursive script. Below the name, the number "58272" is printed. The seal is positioned in the center of the page.

IT IS A VIOLATION OF LAW FOR ANY PERSON,
UNLESS THEY ARE ACTING UNDER THE DIRECTION
OF A LICENSED PROFESSIONAL ENGINEER,
TO ALTER THIS DOCUMENT.

DRAWN BY:	CHECKED BY:	APPROVED BY:
SVJ	GVM	JFJ

DRAWN BY:	CHECKED BY:	APPROVED BY:
SVJ	GVM	JFJ

RFDS REV #:	TBD
CONSTRUCTION	

CONSTRUCTION
DOCUMENTS

SUBMITTALS

SUBMITTALS		
REV	DATE	DESCRIPTION
A	08-31-21	PRELIMINARY
0	09-08-21	CONSTRUCTION

A&E PROJECT NUMBER
93936.281632

A&E PROJECT NUMBER
93936.281632

DISH WIRELESS, L.L.C.
PROJECT INFORMATION
DNDEN00187A
CO-CCI-T-824664
20017 BEACON LITE RD
MONUMENT, CO 80321

SHEET TITLE
TOWER
ELEVATIONS

<p>SHEET TITLE</p> <p>TOWER</p> <p>ELEVATIONS</p>

<p>SHEET TITLE</p> <p>TOWER</p> <p>ELEVATIONS</p>

SHEET NUMBER

A-2.1

SHEET NUMBER

A-2.1