



Show height of the buildings, 45' max

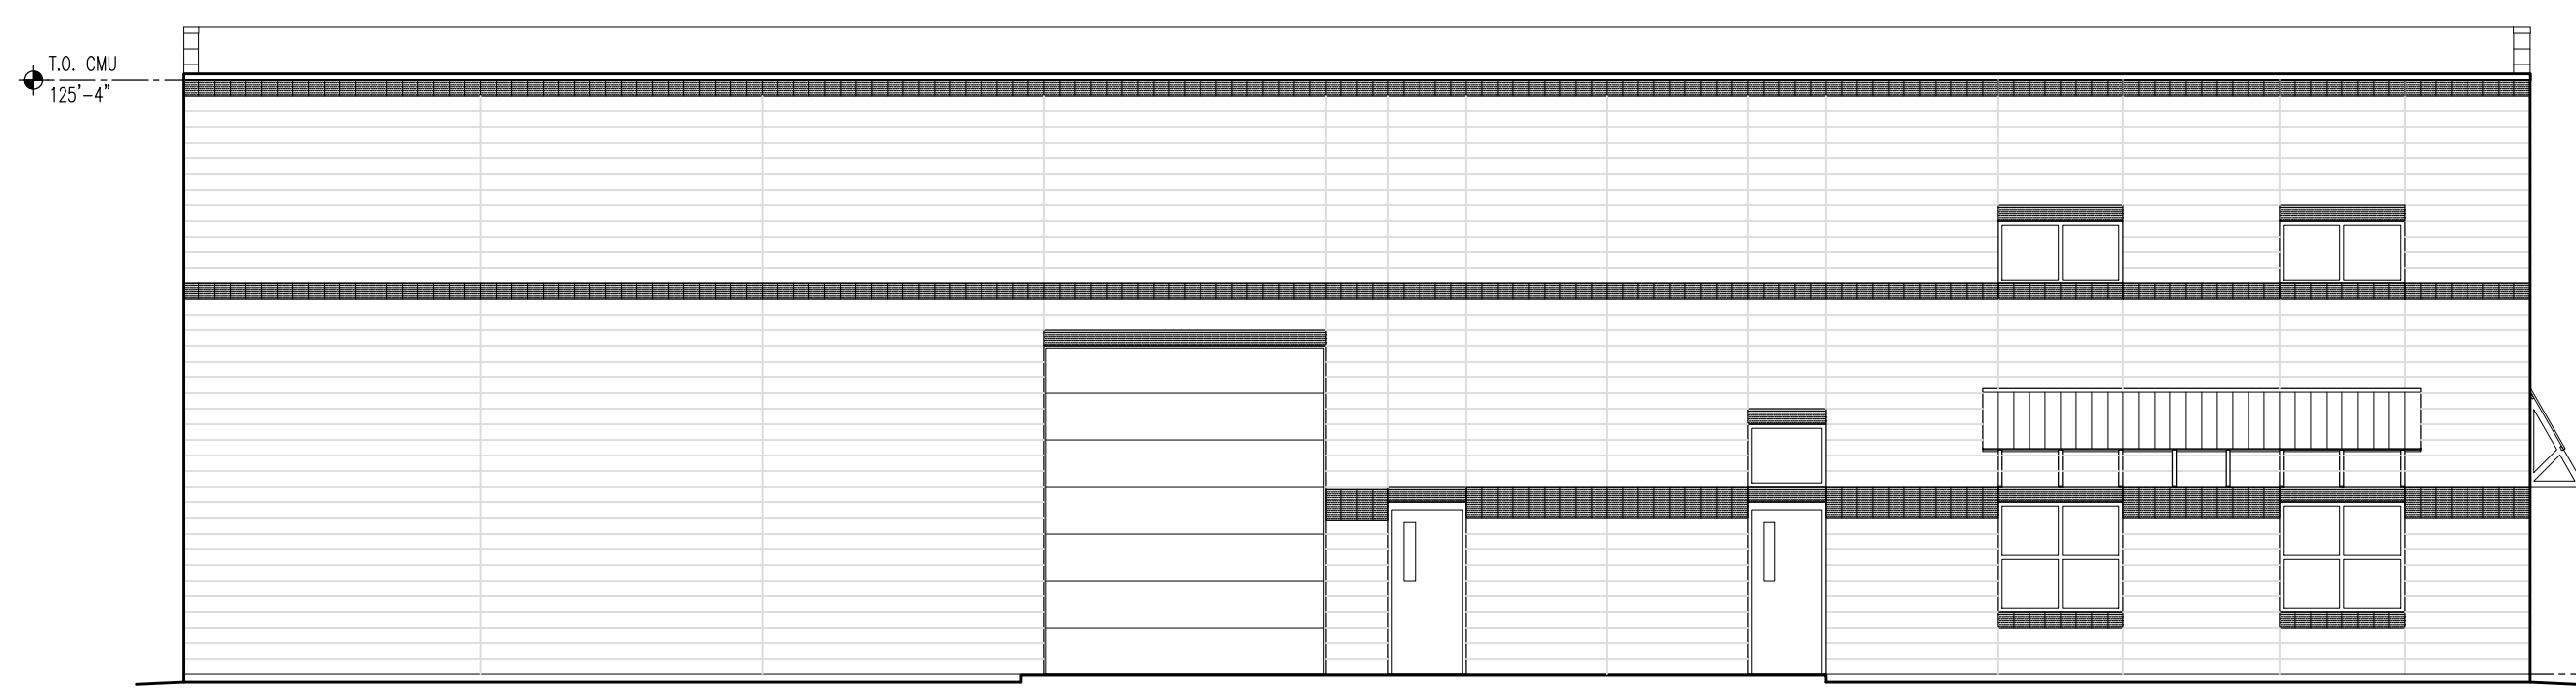


WEST ELEVATION



SOUTH ELEVATION

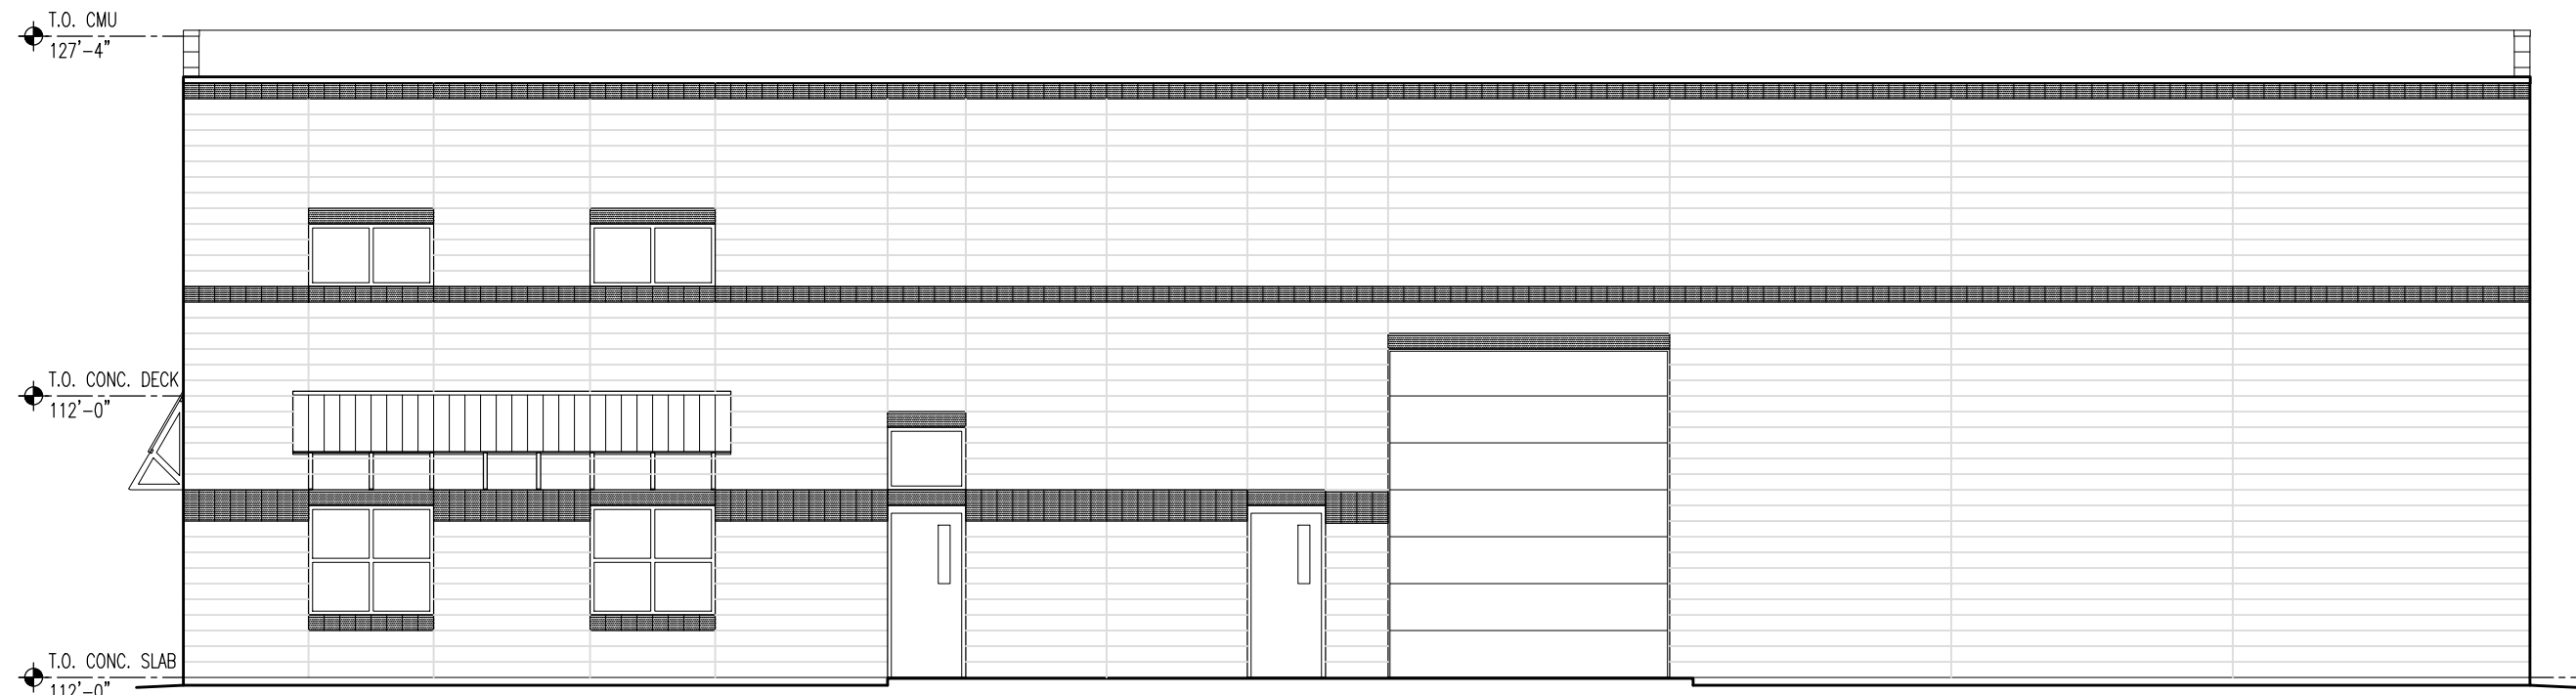

EAST ELEVATION

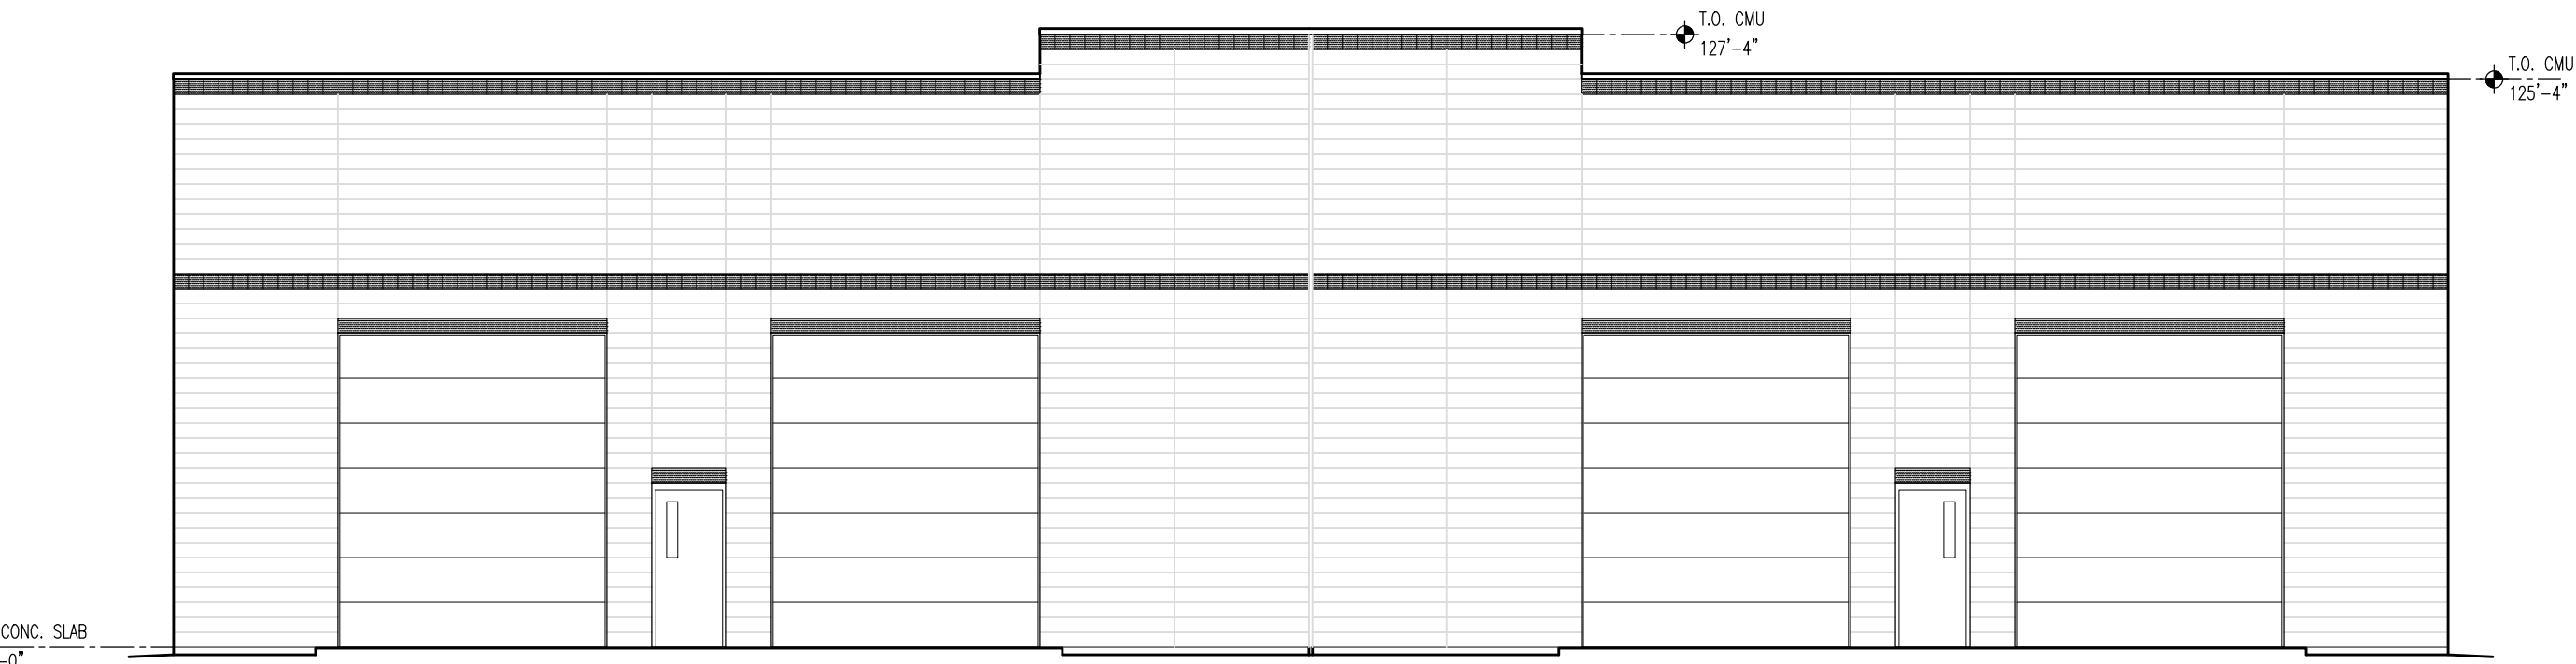

NORTH ELEVATION

EXTERIOR ELEVATIONS

SCALE: 1/8" = 1'-0"


EXTERIOR ELEVATION NOTES

1/ SEE GENERAL NOTES ON SHEET T5-1.
2/ SEE ASSEMBLY NOTES ON SHEET A-1.
3/ SEE MECHANICAL, PLUMBING & ELECTRICAL PLANS.

Contractor :

COPYRIGHT 2017 LGA STUDIOS. THIS DOCUMENT AND ITS CONTENTS ARE THE PROPERTY OF AND MAY NOT BE REPRODUCED WITHOUT THE WRITTEN PERMISSION OF LGA STUDIOS. ALL RIGHTS RESERVED.

Michael W. Heitschell, P.A., CSI
MWH & ASSOCIATES
Consulting Architectural Services
Larry Gilland, LEED AP, CSI, CPBD
201 East Las Animas Street Suite 113
Colorado Springs, CO 80903
Office: (719) 535-0880
Fax: (719) 535-0880
LGA Studios
www.lgastudios.com

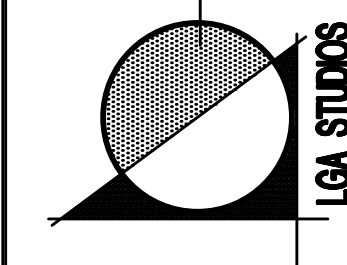


**JACKSON OFFICE
WAREHOUSE BUILDINGS A&B**
8140 SANDY COURT
COLORADO SPRINGS, COLORADO 80915

Project No. LGA17-1523
MWH17-919-08
File No. A4 EL-A&B
Drawn: MWH
Checked: MWH, LG
Issued: 08/23/17
Revisions:


**EXTERIOR
ELEVATIONS**
SCALE: AS NOTED
Sheet Number:
A4
OF 1 SHEETS

PRELIMINARY REVIEW ONLY
NOT FOR CONSTRUCTION

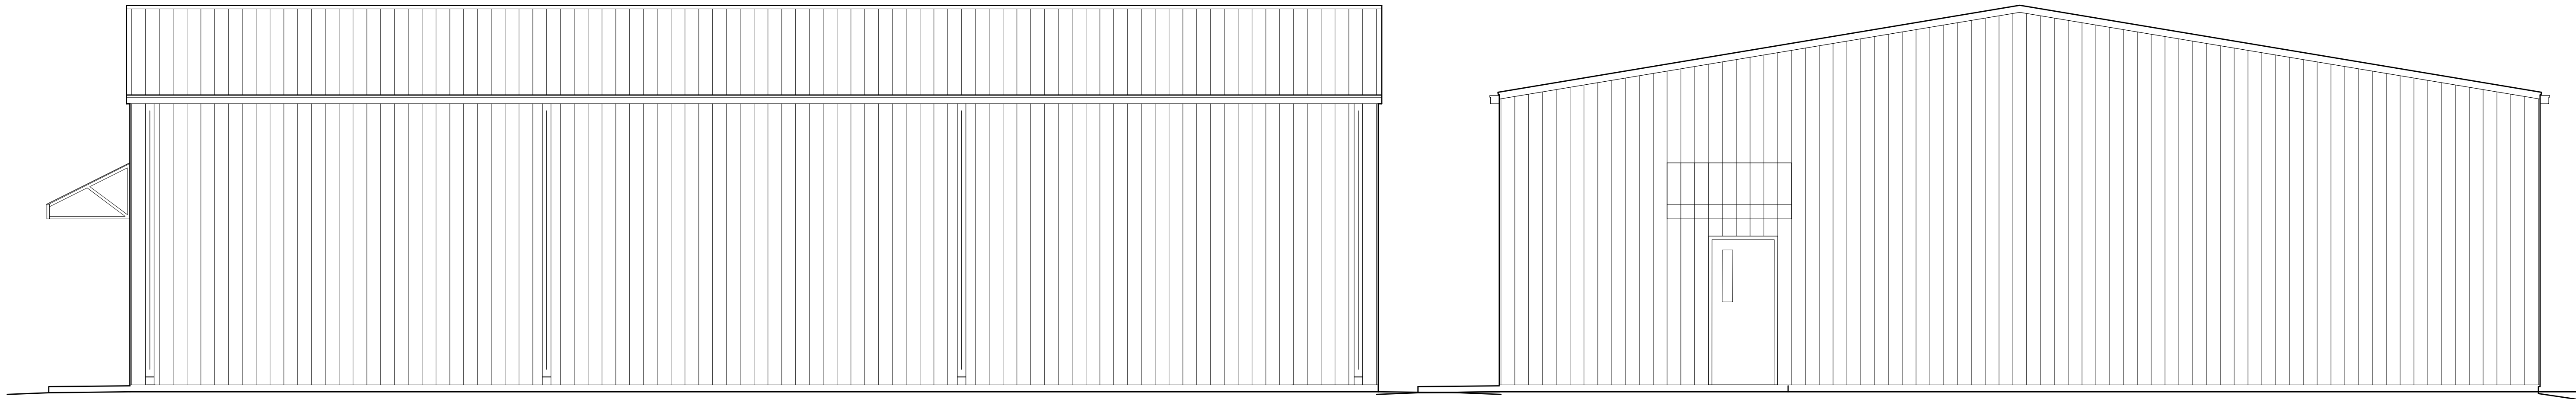

NORTH ELEVATION

EAST ELEVATION

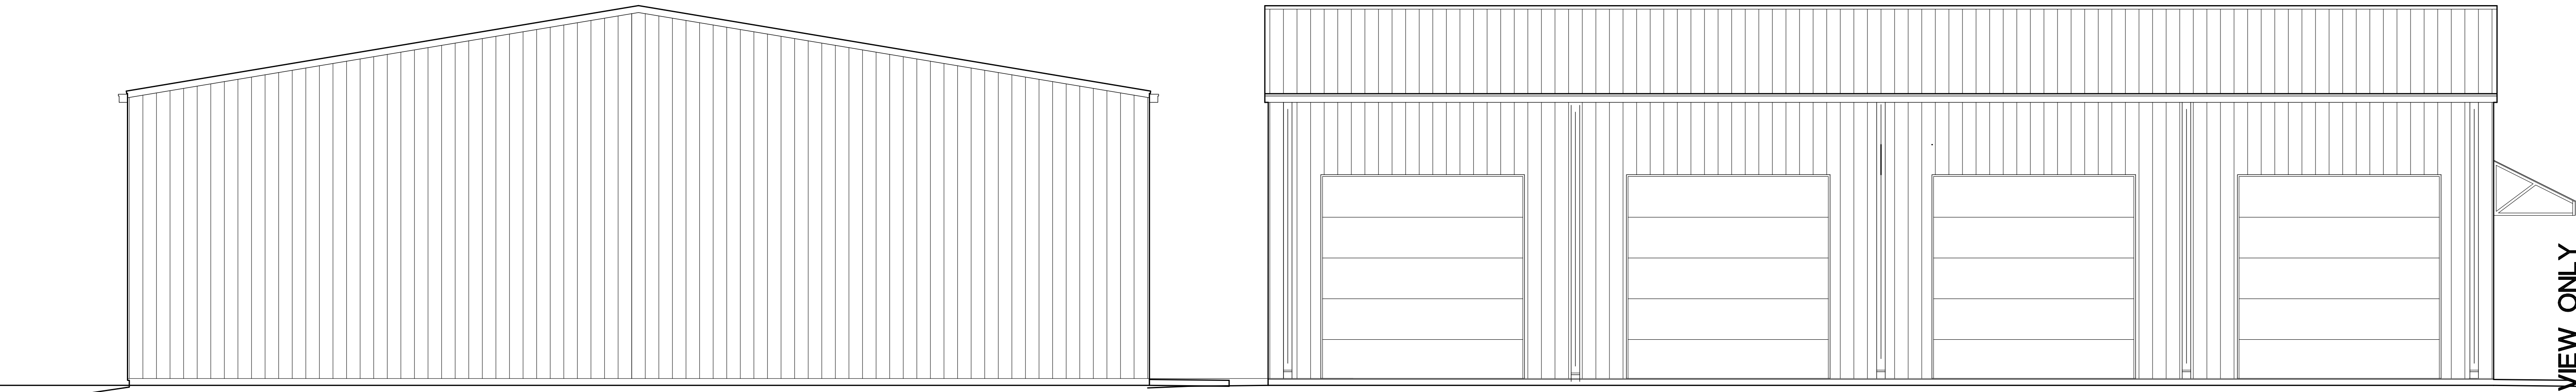

WEST ELEVATION

SOUTH ELEVATION

EXTERIOR ELEVATIONS

SCALE: 1/4" = 1'-0"


EXTERIOR ELEVATION NOTES

- 1/ SEE GENERAL NOTES ON SHEET TS-1.
2/SEE ASSEMBLY NOTES ON SHEET A-1.
3/SEE MECHANICAL, PLUMBING & ELECTRICAL PLANS.

Contractor :

COPYRIGHT 2017 LGA STUDIOS. THIS DOCUMENT AND ITS CONTENTS ARE THE PROPERTY OF AND MAY NOT BE REPRODUCED WITHOUT THE WRITTEN PERMISSION OF LGA STUDIOS. ALL RIGHTS RESERVED.

Michael W. Heitschel, RA, CSI
MWH & ASSOCIATES
Consulting Architectural Services
Larry Gilland, LEED AP, CSI, CPBD
201 East Las Animas Street Suite 113
Colorado Springs, CO 80903
Office: (719) 535-0880
Cell: (719) 684-7000
LGA Studios@gmail.com
www.lgastudios.com

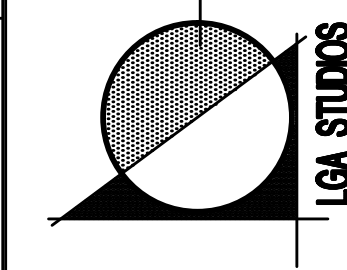

**JACKSON VEHICLE
STORAGE BUILDING 'C'**
8140 SANDY COURT
COLORADO SPRINGS, COLORADO 80915

 
Project No. LGS17-1523
(MWH-TT-010-02)
File No. A4.1EL-C
Drawn: MWH
Checked: MWH, LG
Issued: 08/22/17
Revisions:

**EXTERIOR
ELEVATIONS**
SCALE: AS NOTED
Sheet Number:
A4.1
OF 2 SHEETS

PRELIMINARY REVIEW ONLY
NOT FOR CONSTRUCTION

Markup Summary

1 (1)



Subject: Dimension

Page Label: 1

Lock: Locked

Status:

Checkmark: Unchecked

Author: dsdkendall

Date: 12/29/2017 8:57:35 AM

Color:

Layer:

Space:

Show height of the buildings, 45' max