


WEST ELEVATION

SOUTH ELEVATION

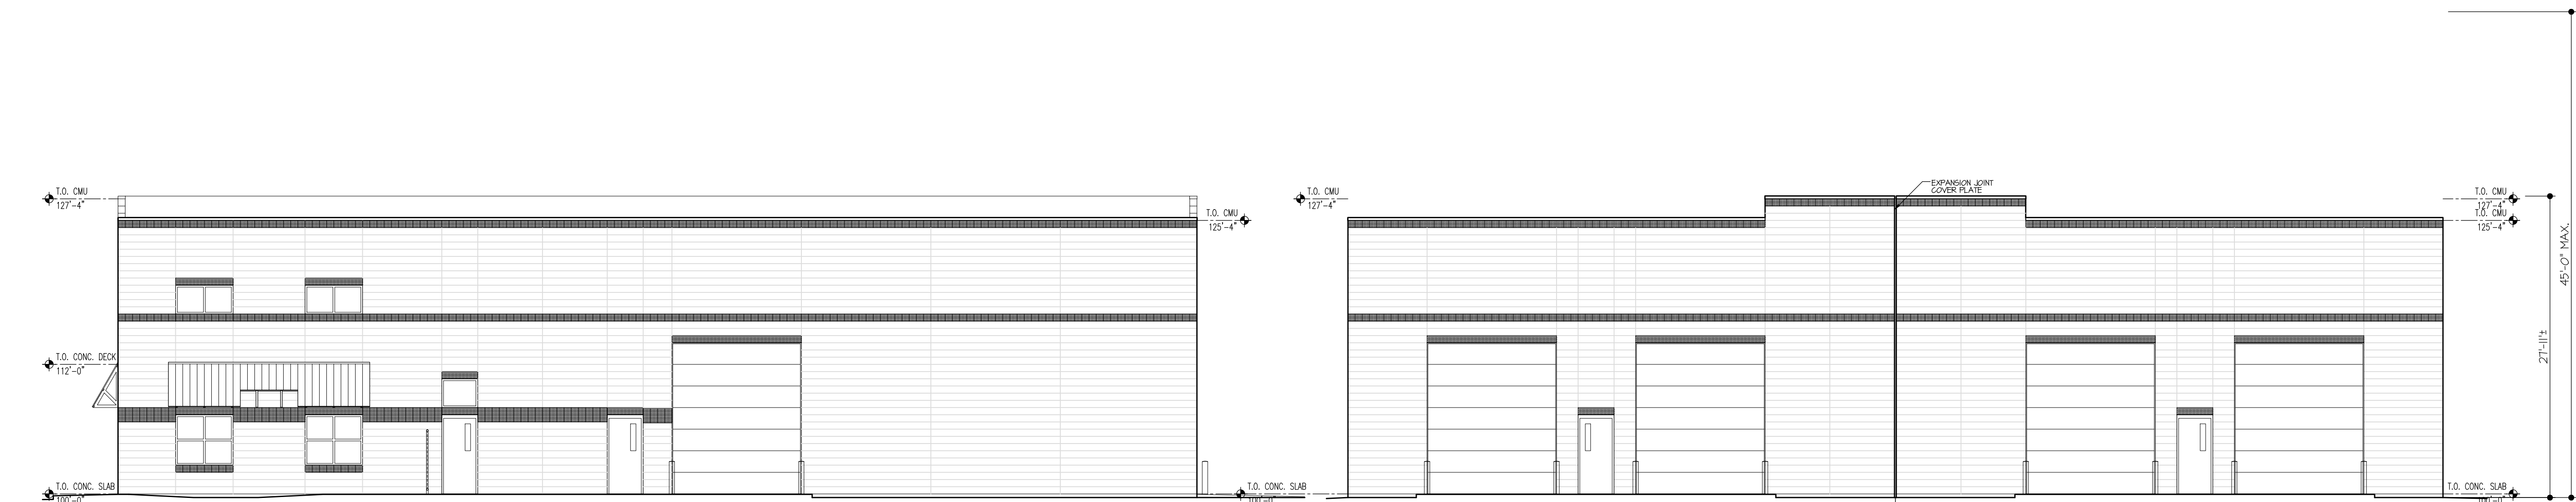

EAST ELEVATION

NORTH ELEVATION

EXTERIOR ELEVATIONS

SCALE: 1/8" = 1'-0"


EXTERIOR ELEVATION NOTES

- 1) SEE GENERAL NOTES ON SHEET T5-1.
- 2) SEE ASSEMBLY NOTES ON SHEET A-1.
- 3) SEE MECHANICAL, PLUMBING & ELECTRICAL PLANS.

Contractor :

COPYRIGHT 2017 LGA STUDIOS. THIS DOCUMENT AND ITS CONTENTS ARE THE PROPERTY OF AND MAY NOT BE REPRODUCED WITHOUT THE WRITTEN PERMISSION OF LGA STUDIOS. ALL RIGHTS RESERVED.

Michael W. Heintschel, RA, CSI
MWH & ASSOCIATES
Consulting Architectural Services
Larry Gilland, LEED AP, CSI, CPBD
201 East Las Animas Street Suite 113
Colorado Springs, CO 80903
Office: (719) 635-0880
Cell: (719) 684-2008
LGA
www.lgastudios.com

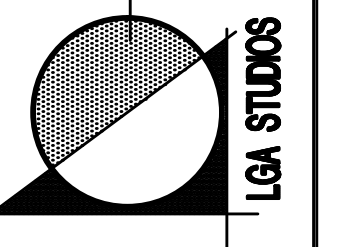

**JACKSON OFFICE
WAREHOUSE BUILDINGS A&B**
8140 & 8170 SANDY COURT
COLORADO SPRINGS, COLORADO 80915

Project No. LGA17-1523
MWH17-919-08
File No. A4 EL-A&B
Drawn: MWH
Checked: MWH, LG
Issued: 08/23/17
Revisions: 02/07/18

EXTERIOR
ELEVATIONS
SCALE: AS NOTED

Sheet Number:

A4
OF 1 SHEETS

PRELIMINARY REVIEW ONLY
NOT FOR CONSTRUCTION