


MAIN LEVEL FLOOR PLAN AREA 'A'

SCALE: 1/4" = 1'-0"

FLOOR PLAN NOTES

- 1) SEE GENERAL NOTES ON SHEET TS-1.
- 2) SEE ASSEMBLY NOTES ON SHEET A-1.
- 3) SEE MECHANICAL, PLUMBING & ELECTRICAL PLANS.

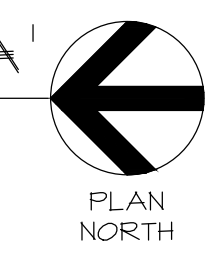

Contractor:

COPYRIGHT 2017 LGA STUDIOS. THIS DOCUMENT AND ITS CONTENTS ARE THE PROPERTY OF AND MAY NOT BE REPRODUCED WITHOUT THE WRITTEN PERMISSION OF LGA STUDIOS. ALL RIGHTS RESERVED.

Michael W. Heintzel, RA, CSI
 MWH & ASSOCIATES
 Consulting Architectural Services


Larry Gilland, LEED AP, CSI, CPBD
 201 East Las Animas Street Suite 113
 Colorado Springs, CO. 80903
 Office: (719) 635-0880
 Cell: (719) 684-7008
 LGA
 www.lgastudios.com

**JACKSON OFFICE
 WAREHOUSE BUILDINGS
 8140 SANDY COURT
 COLORADO SPRINGS, COLORADO 80915**

Project No. LGS17-1523
 (MWH-TT-019-02)
 File No. A1.1MFP-A
 Drawn: MWH
 Checked: MWH, LG
 Issued: 10/06/17
 Revisions:

**MAIN LEVEL FLOOR PLAN
 NOTES**
 SCALE: AS NOTED
 Sheet Number:
A11
 OF 11 SHEETS

**PRELIMINARY REVIEW ONLY
 NOT FOR CONSTRUCTION**

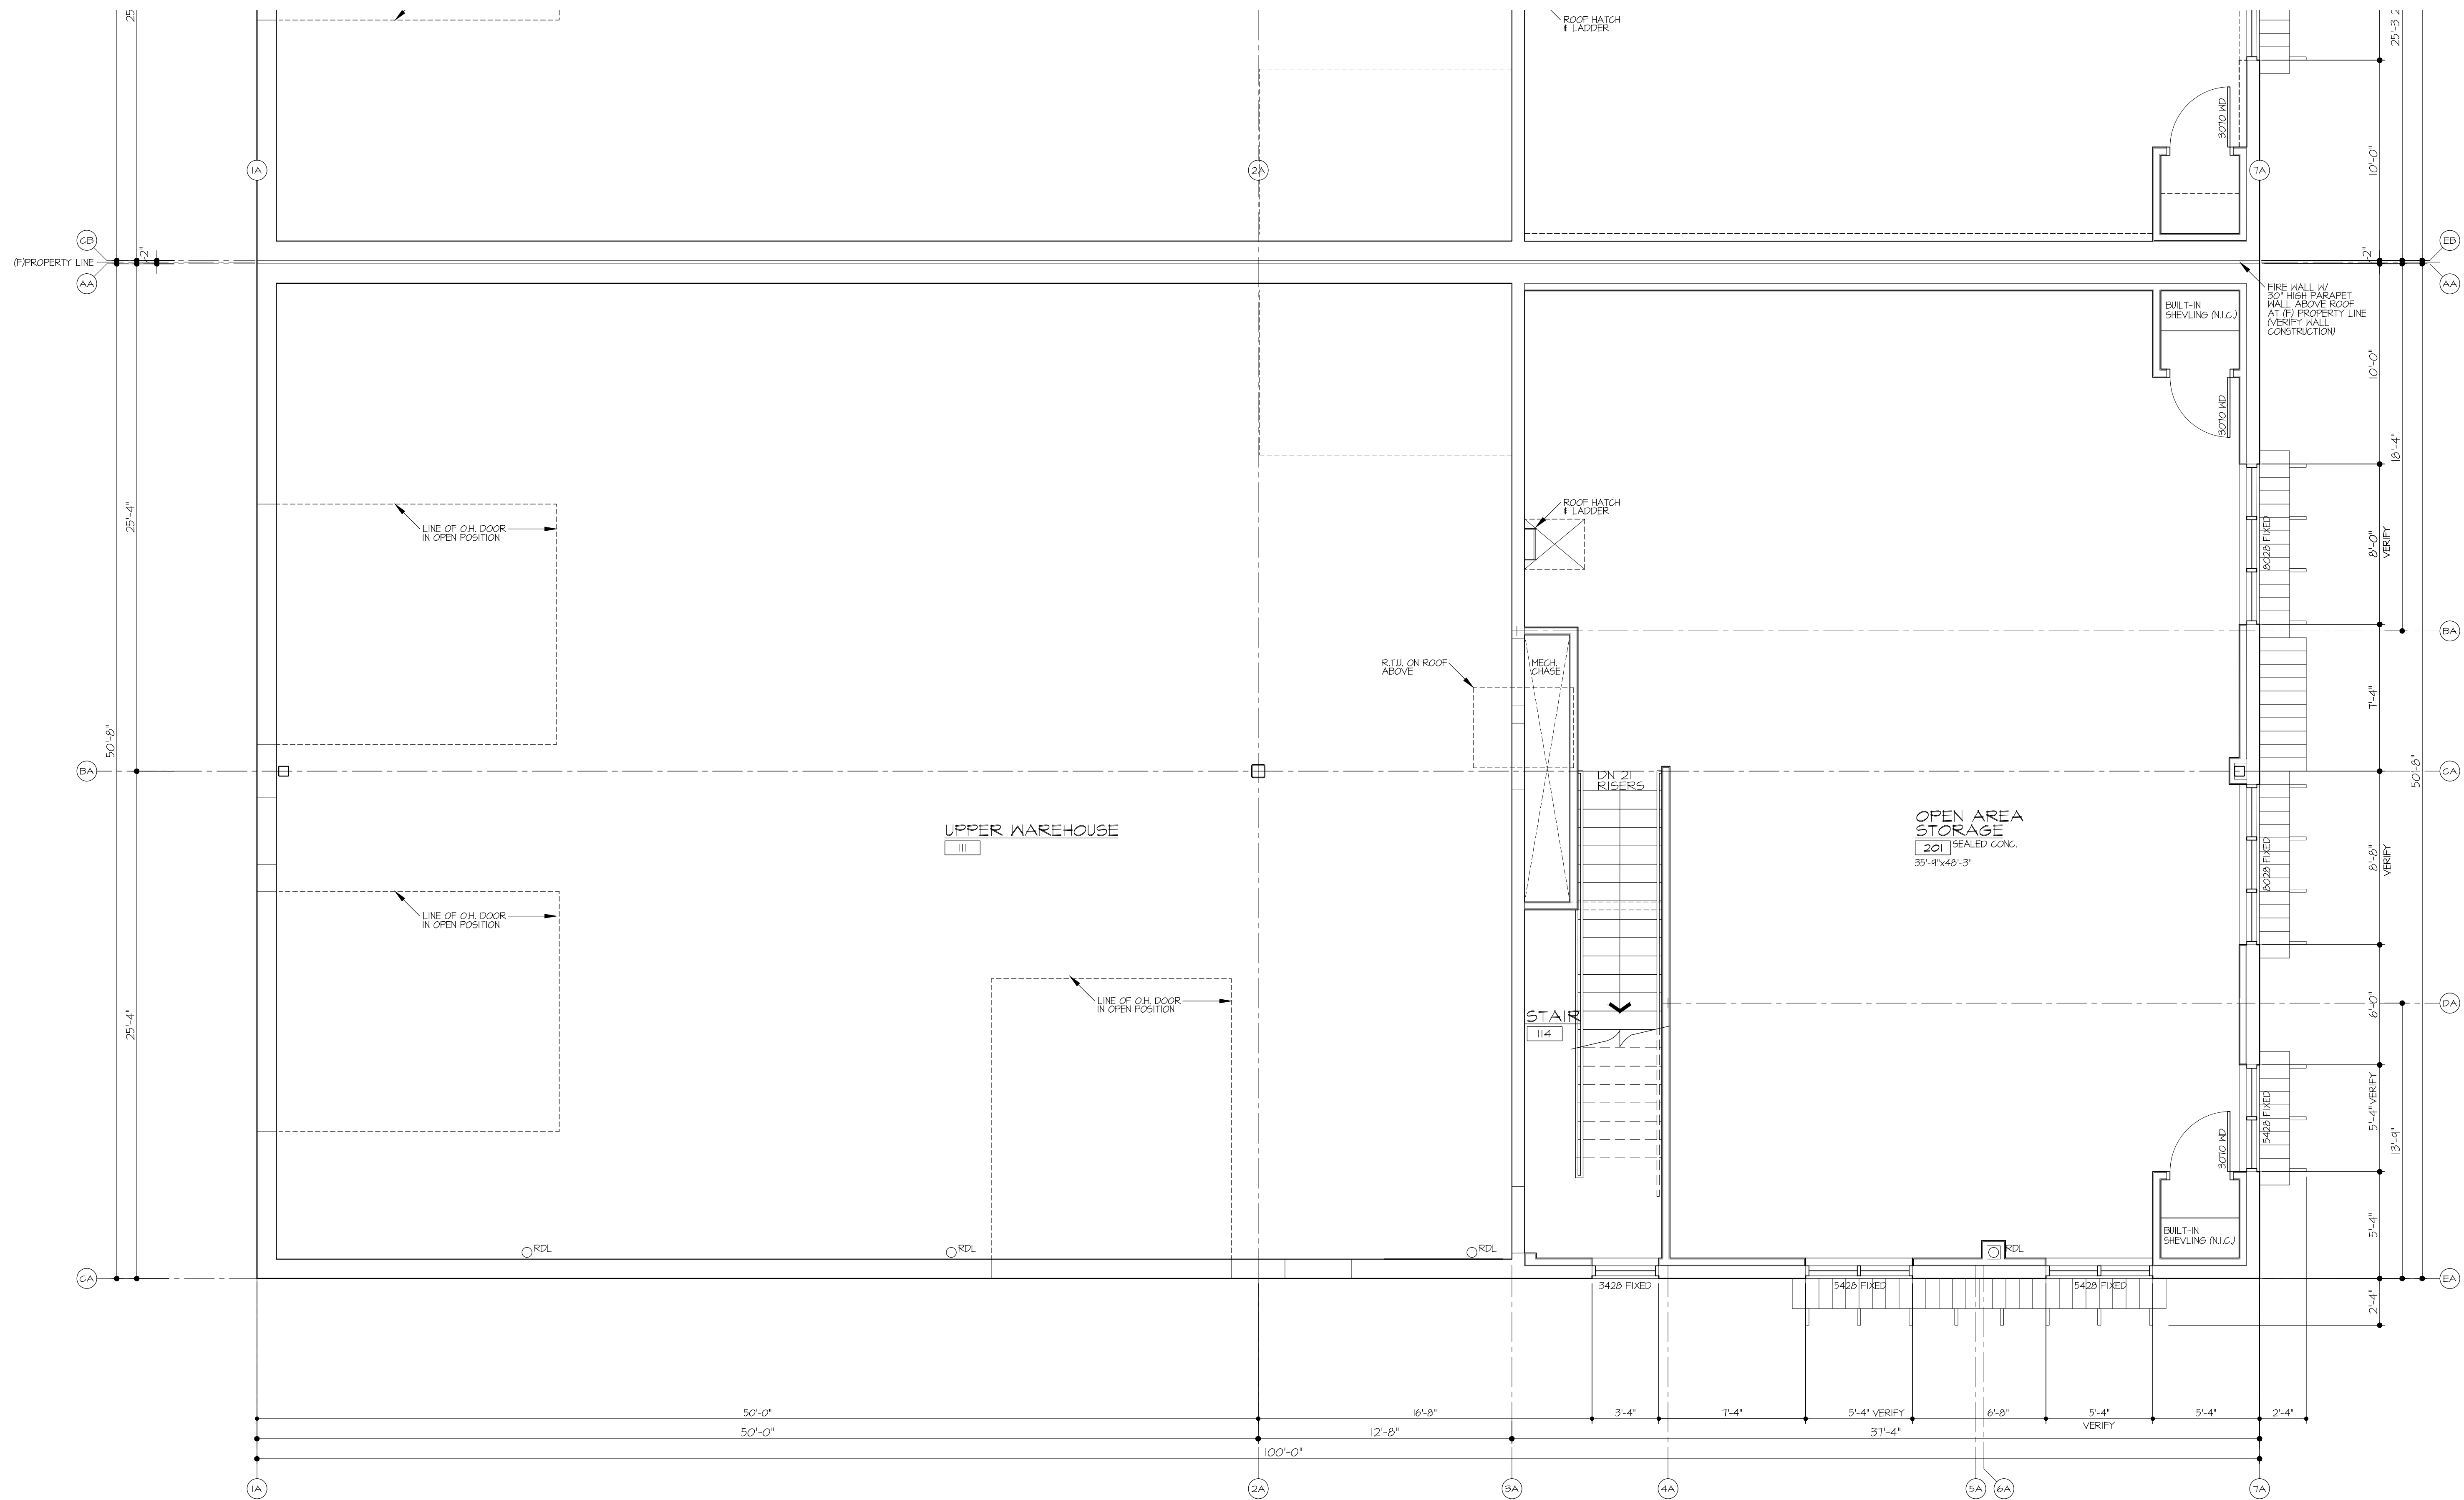


UPPER LEVEL FLOOR PLAN AREA 'A'

SCALE: 1/4" = 1'-0"

FLOOR PLAN NOTES

- 1) SEE GENERAL NOTES ON SHEET TS-1.
- 2) SEE ASSEMBLY NOTES ON SHEET A-1.
- 3) SEE MECHANICAL, PLUMBING & ELECTRICAL PLANS.

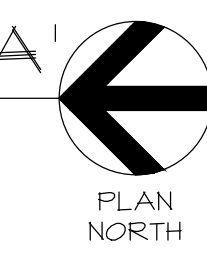


PRELIMINARY REVIEW ONLY
NOT FOR CONSTRUCTION

Project No.	LGS17-1523 (MWH-TT-019-02)
File No.	A1.2UFP-A
Drawn:	MWH
Checked:	MWH, LG
Issued:	10/06/17
Revisions:	

UPPER LEVEL FLOOR PLAN
NOTES
SCALE: AS NOTED
Sheet Number:
A12
OF 11 SHEETS


**JACKSON OFFICE
WAREHOUSE BUILDINGS**
8140 SANDY COURT
COLORADO SPRINGS, COLORADO 80915

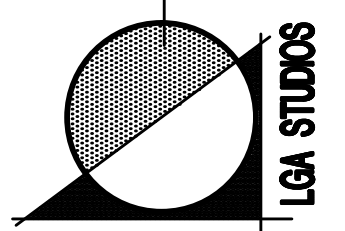

Michael W. Heintschel, RA, CSI
MWH & ASSOCIATES
Consulting Architectural Services
Larry Gilland, LEED AP, CSI, CPBD
201 East Las Animas Street Suite 113
Colorado Springs, CO 80903
Office: (719) 635-0880
Cell: (719) 684-7008
LGA Studios
www.lgastudios.com

COPYRIGHT 2017 LGA STUDIOS. THIS DOCUMENT AND ITS CONTENTS ARE THE PROPERTY OF AND MAY NOT BE REPRODUCED WITHOUT THE WRITTEN PERMISSION OF LGA STUDIOS. ALL RIGHTS RESERVED.

Contractor:

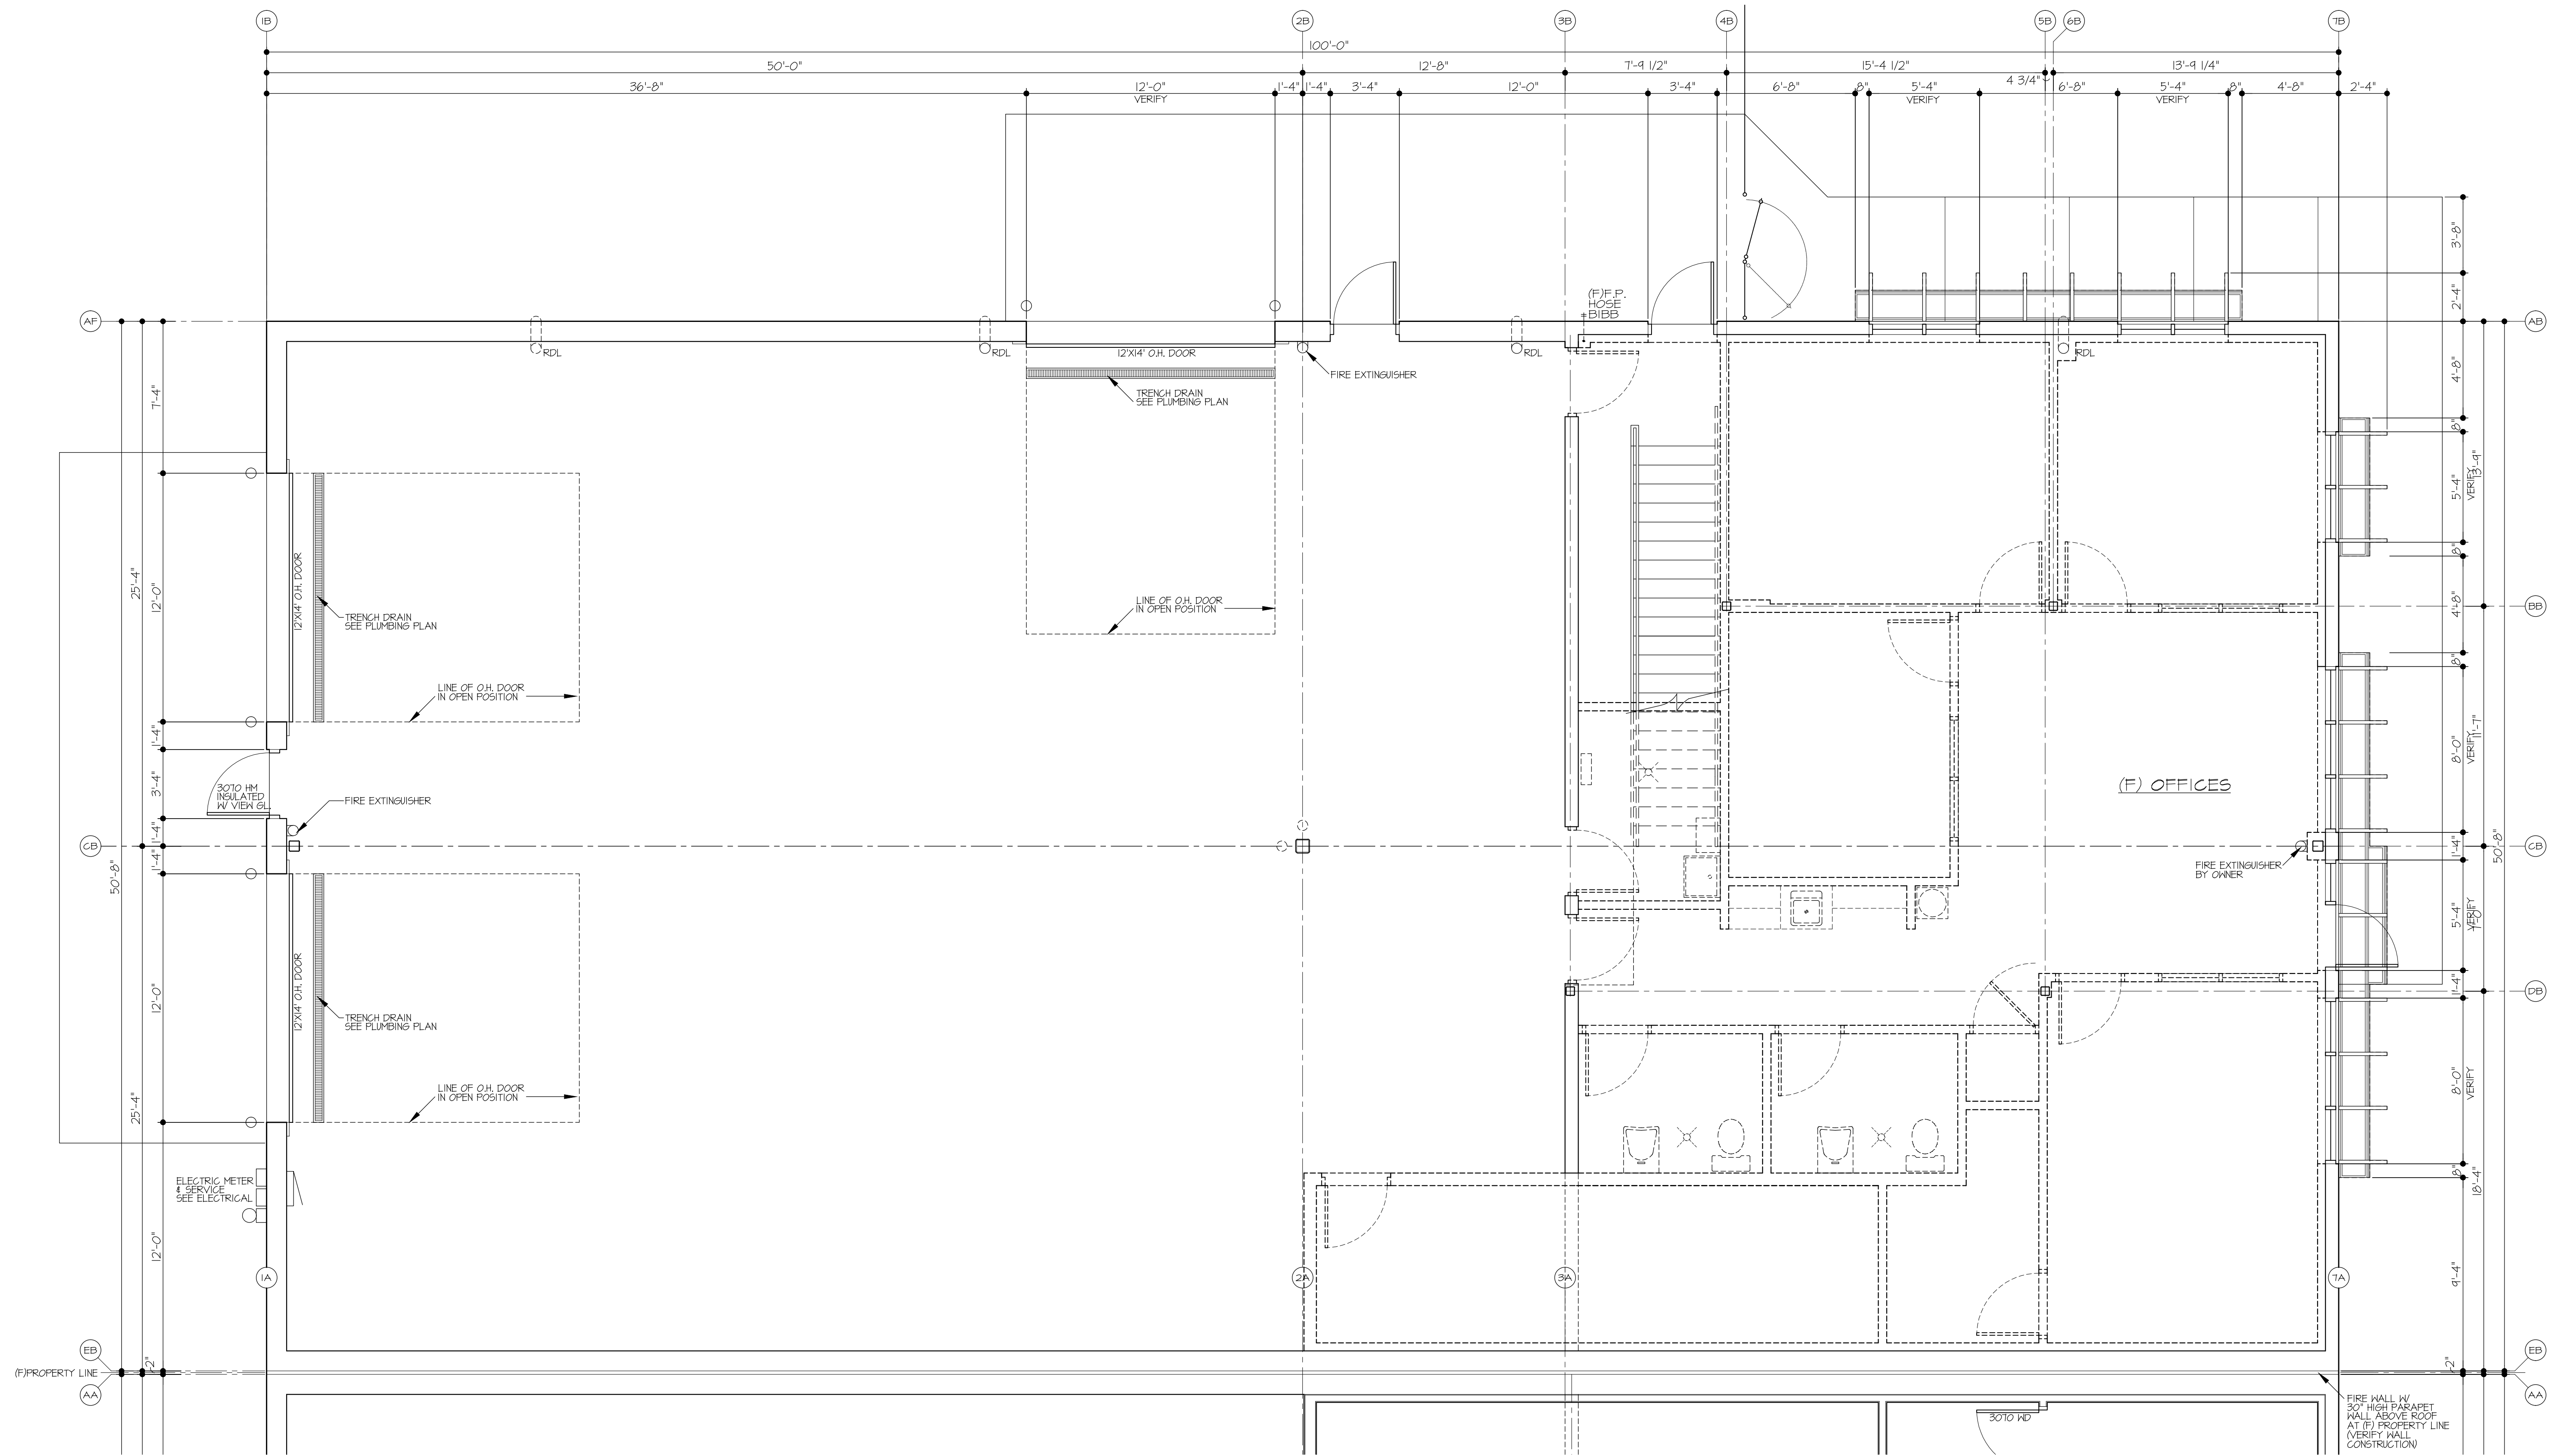

MAIN LEVEL FLOOR PLAN AREA 'B'

SCALE: 1/4" = 1'-0"

FLOOR PLAN NOTES


- 1) SEE GENERAL NOTES ON SHEET TS-1.
- 2) SEE ASSEMBLY NOTES ON SHEET A-1.
- 3) SEE MECHANICAL, PLUMBING & ELECTRICAL PLANS.



Contractor :

COPYRIGHT 2017 LGA STUDIOS. THIS DOCUMENT AND ITS CONTENTS ARE THE PROPERTY OF AND MAY NOT BE REPRODUCED WITHOUT THE WRITTEN PERMISSION OF LGA STUDIOS. ALL RIGHTS RESERVED.

Michael W. Heitschell, RA, CSI
MWH & ASSOCIATES
Consulting Architectural Services
Larry Gilliland, LEED AP, CSI, CPBD
201 East Las Animas Street Suite 113
Colorado Springs, CO 80903
Office: (719) 635-0880
Cell: (719) 684-7008
LGA - lga@lga.com
www.lgastudios.com

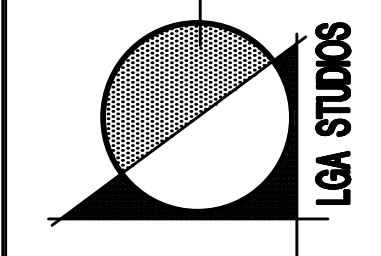


**JACKSON OFFICE
WAREHOUSE BUILDINGS**
8140 SANDY COURT
COLORADO SPRINGS, COLORADO 80915

PRELIMINARY REVIEW ONLY
NOT FOR CONSTRUCTION


Project No. LGS17-1523
(MWH-17-019-02)
File No. A1.4UFP-B
Drawn: MWH
Checked: MWH, LG
Issued: 10/06/17
Revisions:

MAIN LEVEL FLOOR PLAN
NOTES
SCALE: AS NOTED
Sheet Number:
A13
OF 11 SHEETS

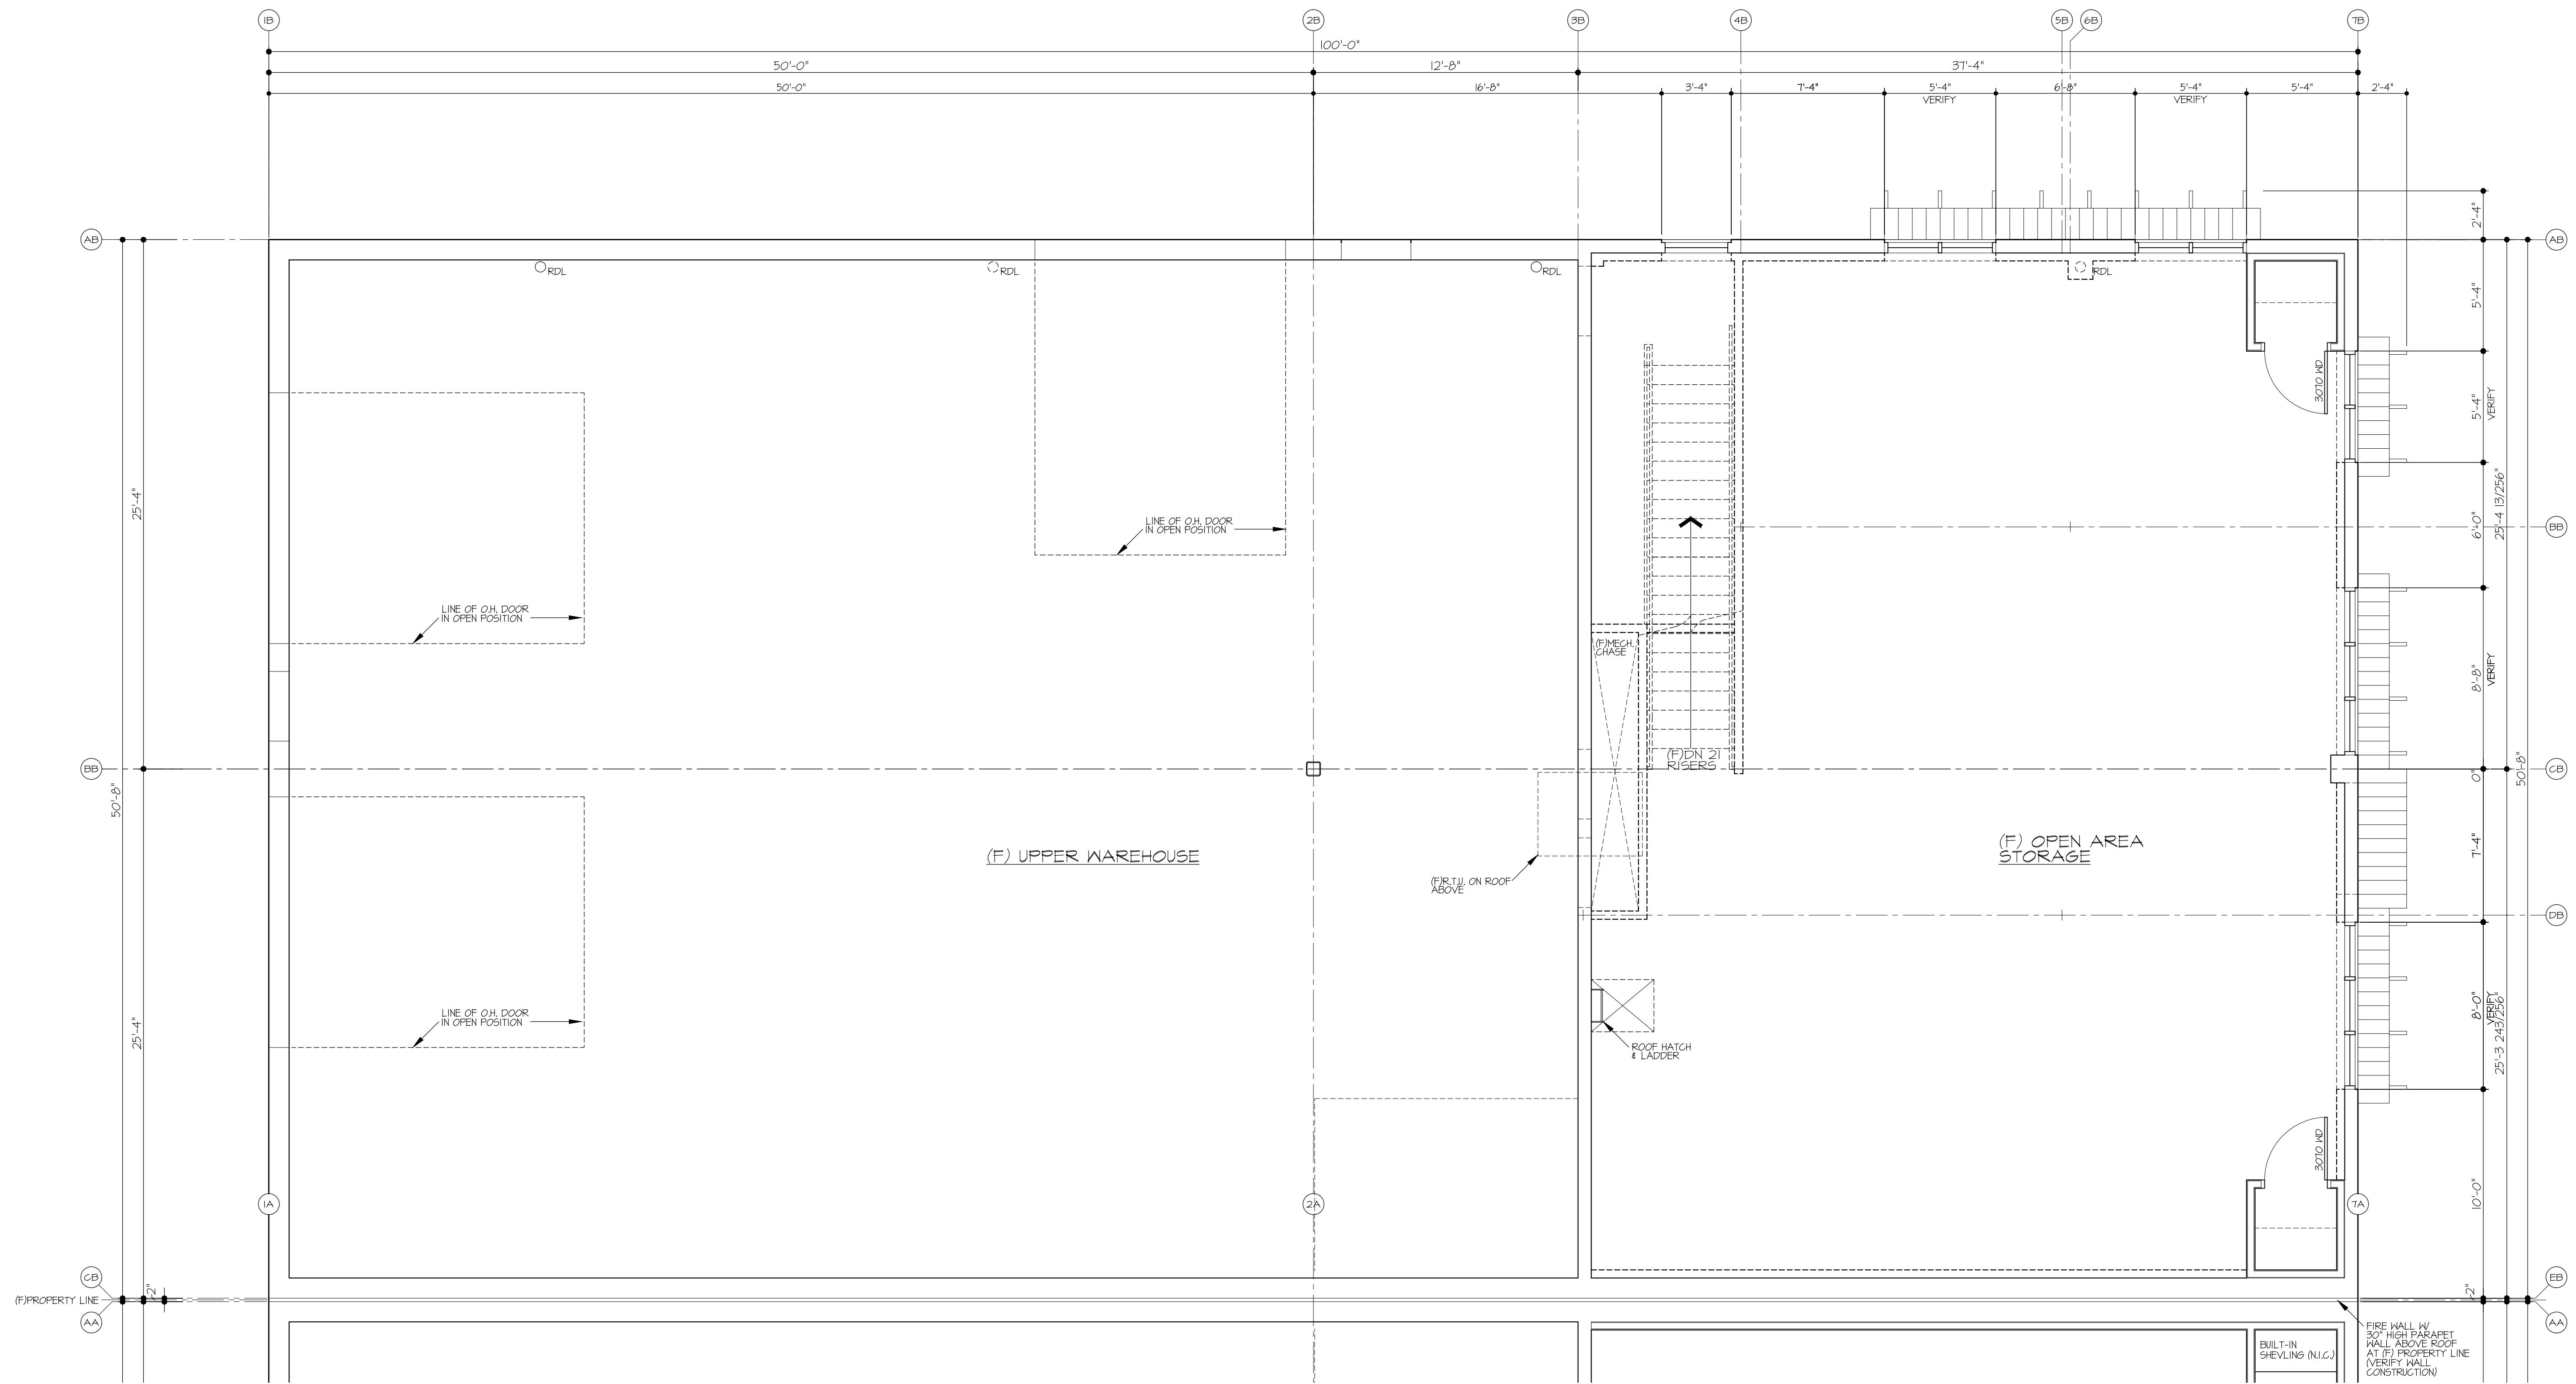

UPPER LEVEL FLOOR PLAN AREA 'B'


SCALE: 1/4" = 1'-0"
 FLOOR PLAN NOTES
 1) SEE GENERAL NOTES ON SHEET TS-1.
 2) SEE ASSEMBLY NOTES ON SHEET A-1.
 3) SEE MECHANICAL, PLUMBING & ELECTRICAL PLANS.

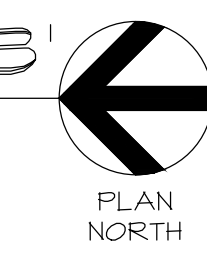

Contractor :

COPYRIGHT 2017 LGA STUDIOS. THIS DOCUMENT AND ITS CONTENTS ARE THE PROPERTY OF AND MAY NOT BE REPRODUCED WITHOUT THE WRITTEN PERMISSION OF LGA STUDIOS. ALL RIGHTS RESERVED.

Michael W. Heitschell, RA, CSI
 MWH & ASSOCIATES
 Consulting Architectural Services
 Larry Gilliland, LEED AP, CSI, CPBD
 201 East Las Animas Street Suite 113
 Colorado Springs, CO. 80903
 Office: (719) 635-0880
 Cell: (719) 684-7000
 LGA
 www.lgastudios.com

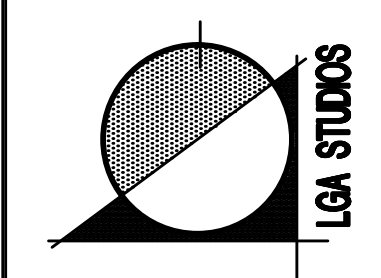


**JACKSON OFFICE
 WAREHOUSE BUILDINGS**
 8140 SANDY COURT
 COLORADO SPRINGS, COLORADO 80915

PRELIMINARY REVIEW ONLY
 NOT FOR CONSTRUCTION

Project No. LGS17-1523
 (MWH-TT-919-02)
 File No. A1.3MFP-B
 Drawn: MWH
 Checked: MWH, LG
 Issued: 10/06/17
 Revisions:

UPPER LEVEL FLOOR PLAN
 NOTES
 SCALE: AS NOTED
 Sheet Number:
A1.4
 OF 11 SHEETS

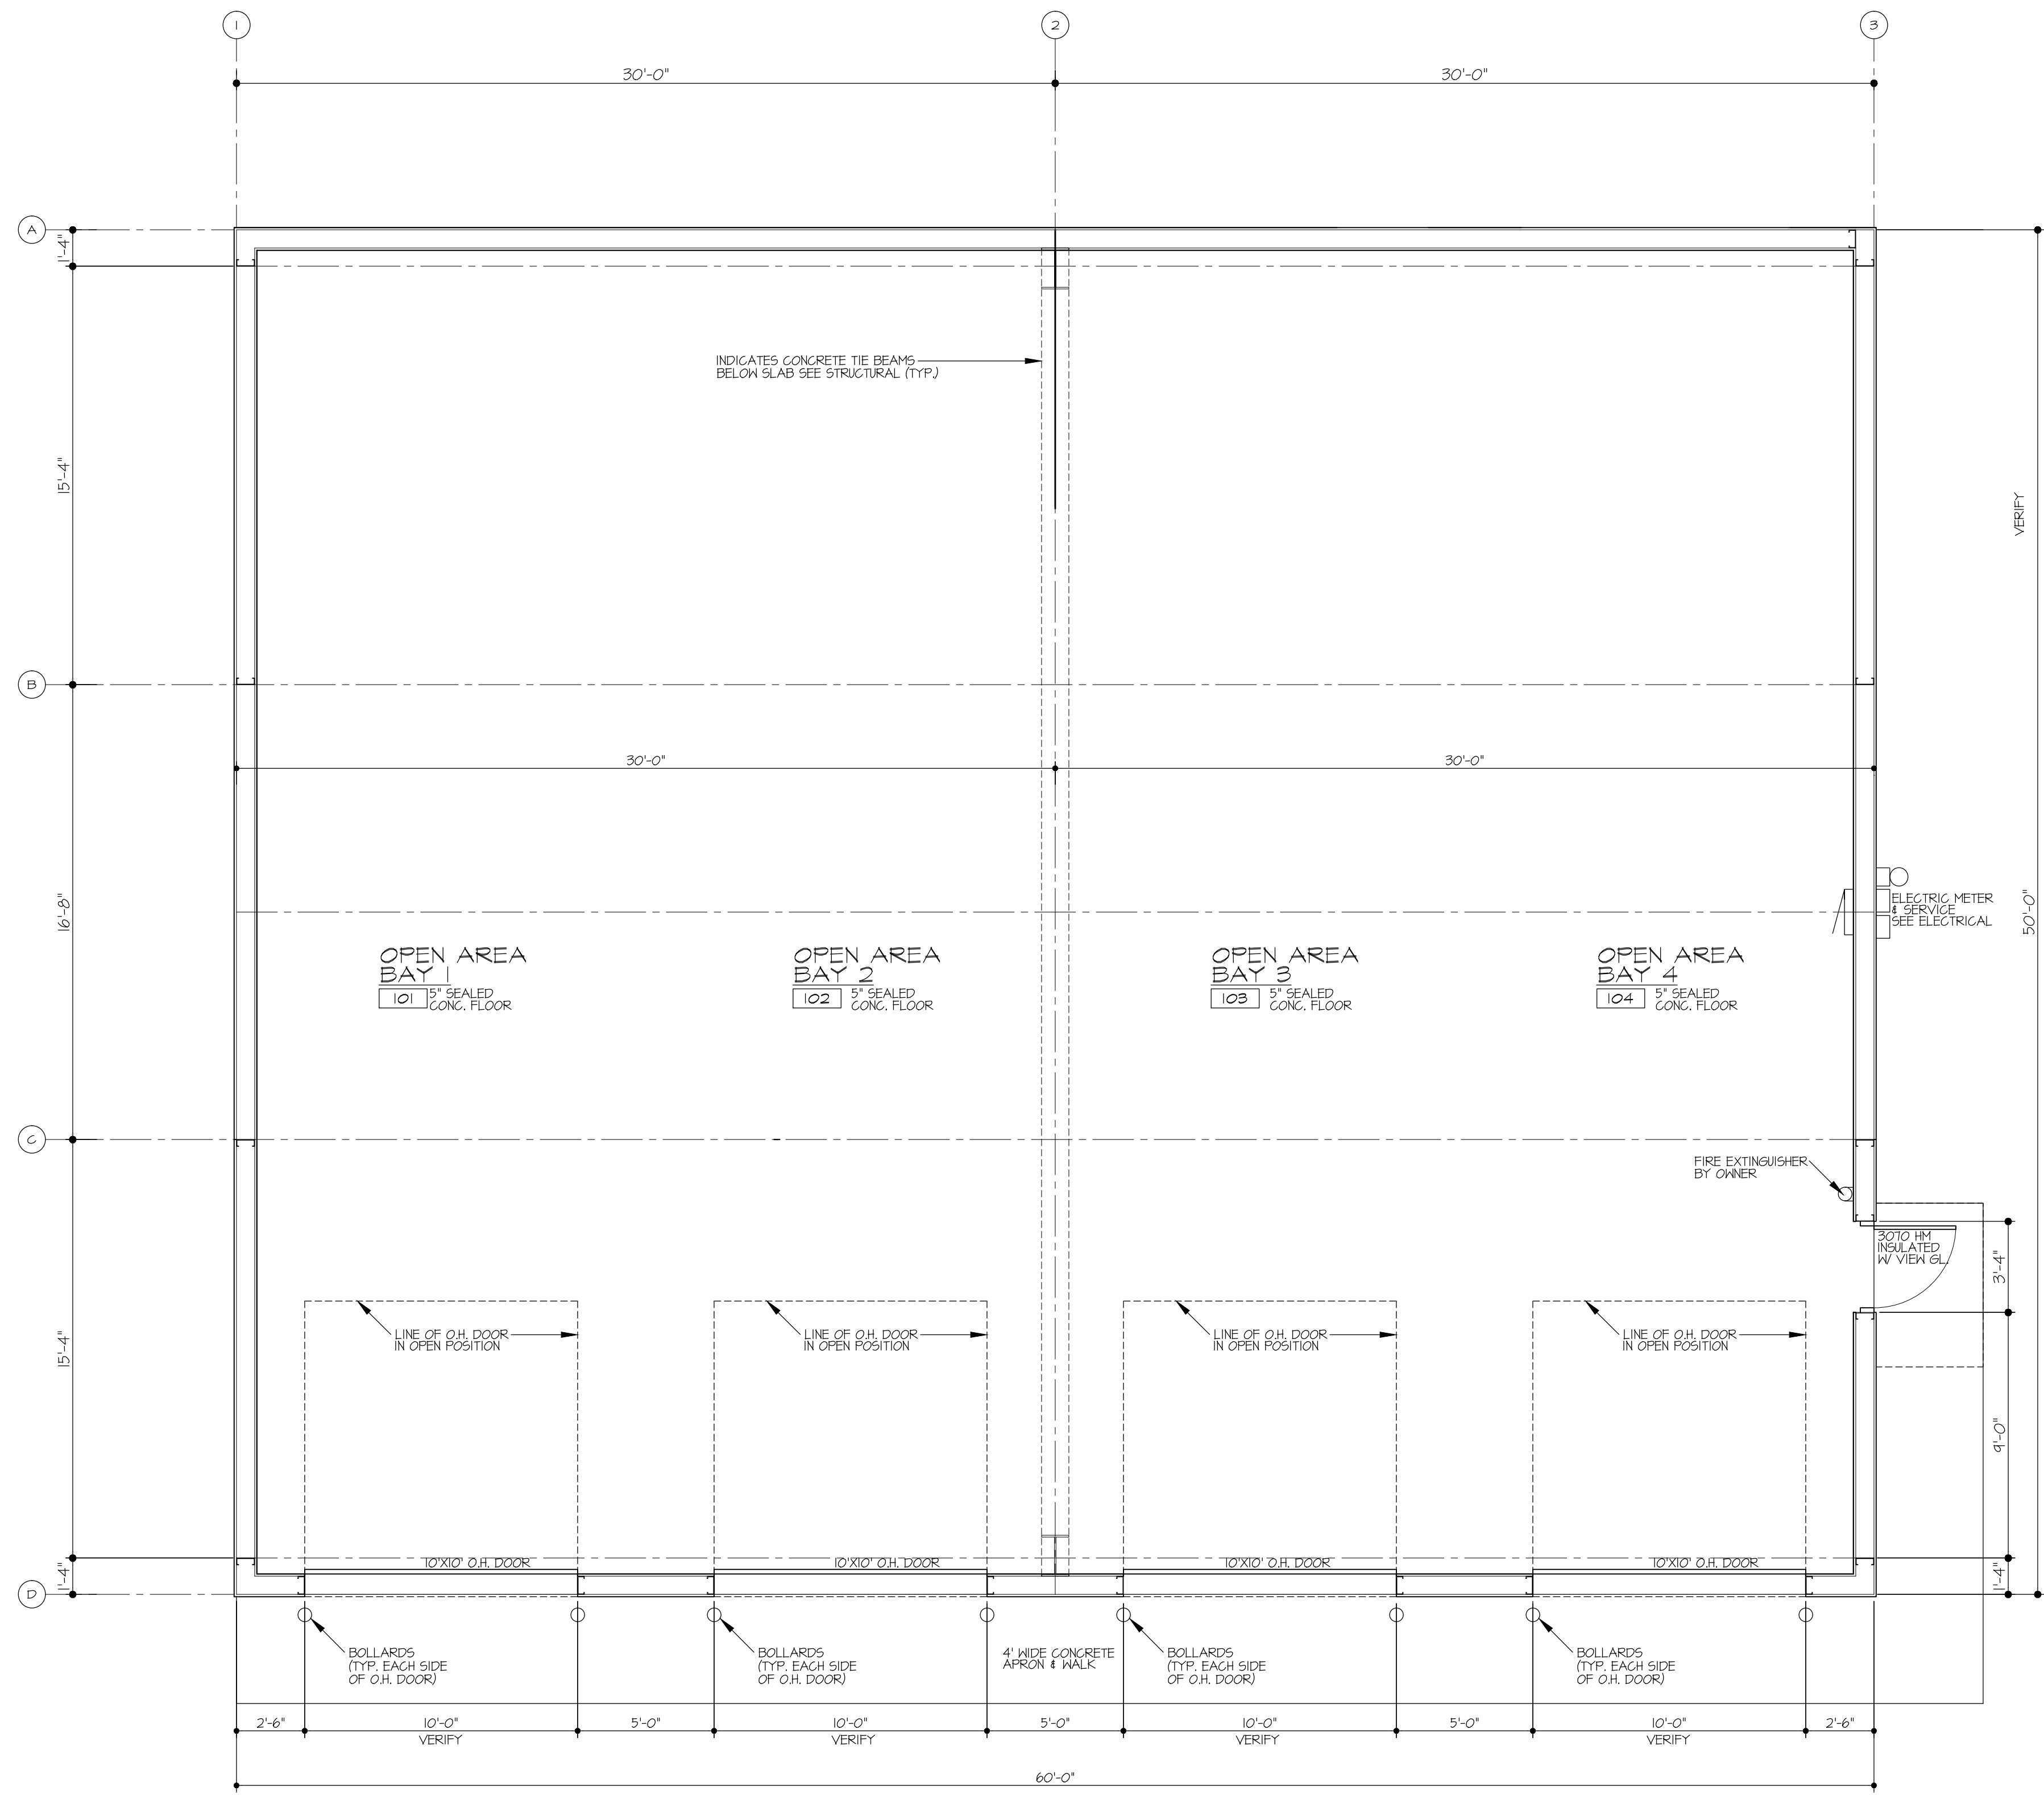


FLOOR PLAN BUILDING 'C'

SCALE: 1/4" = 1'-0"

FLOOR PLAN BUILDING 'C' NOTES

- 1) SEE GENERAL NOTES ON SHEET TS-1.
- 2) SEE ASSEMBLY NOTES ON SHEET A-1.
- 3) SEE MECHANICAL, PLUMBING & ELECTRICAL PLANS.

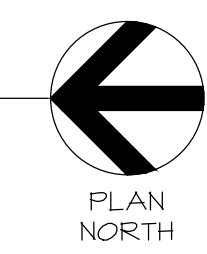


Contractor :

COPYRIGHT 2017 LGA STUDIOS. THIS DOCUMENT AND ITS CONTENTS ARE THE PROPERTY OF AND MAY NOT BE REPRODUCED WITHOUT THE WRITTEN PERMISSION OF LGA STUDIOS. ALL RIGHTS RESERVED.

Michael W. Heintschel, RA, CSI
MWH & ASSOCIATES
Consulting Architectural Services

Larry Gilland, LEED AP, CSI, CPBD
201 East Las Animas Street Suite 113
Colorado Springs, CO. 80903
Office: (719) 635-0880
Cell: (719) 684-7008
LGA Studios@gmail.com
www.lgastudios.com

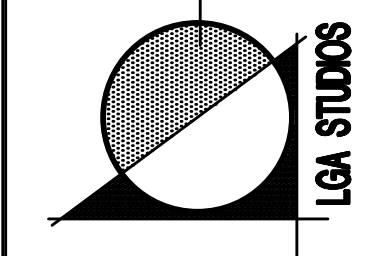

JACKSON VEHICLE STORAGE BUILDING 'C'
8140 SANDY COURT
COLORADO SPRINGS, COLORADO 80915

PRELIMINARY REVIEW ONLY
NOT FOR CONSTRUCTION

Project No. LGS17-1523
(MWH-17-019-02)

File No. A1.1FP-C

Drawn: MWH, JAP

Checked: MWH, LG

Issued: 08/22/17

Revisions:

BLDG-C FLOOR PLAN NOTES
SCALE: AS NOTED

Sheet Number:
A11
OF 1 SHEETS