


THE SHOP'S AT MERIDIAN RANCH

FILING NO. 1, LOT 4

PHOTOMETRIC PLAN

EL PASO COUNTY, COLORADO.

FALCON, COLORADO

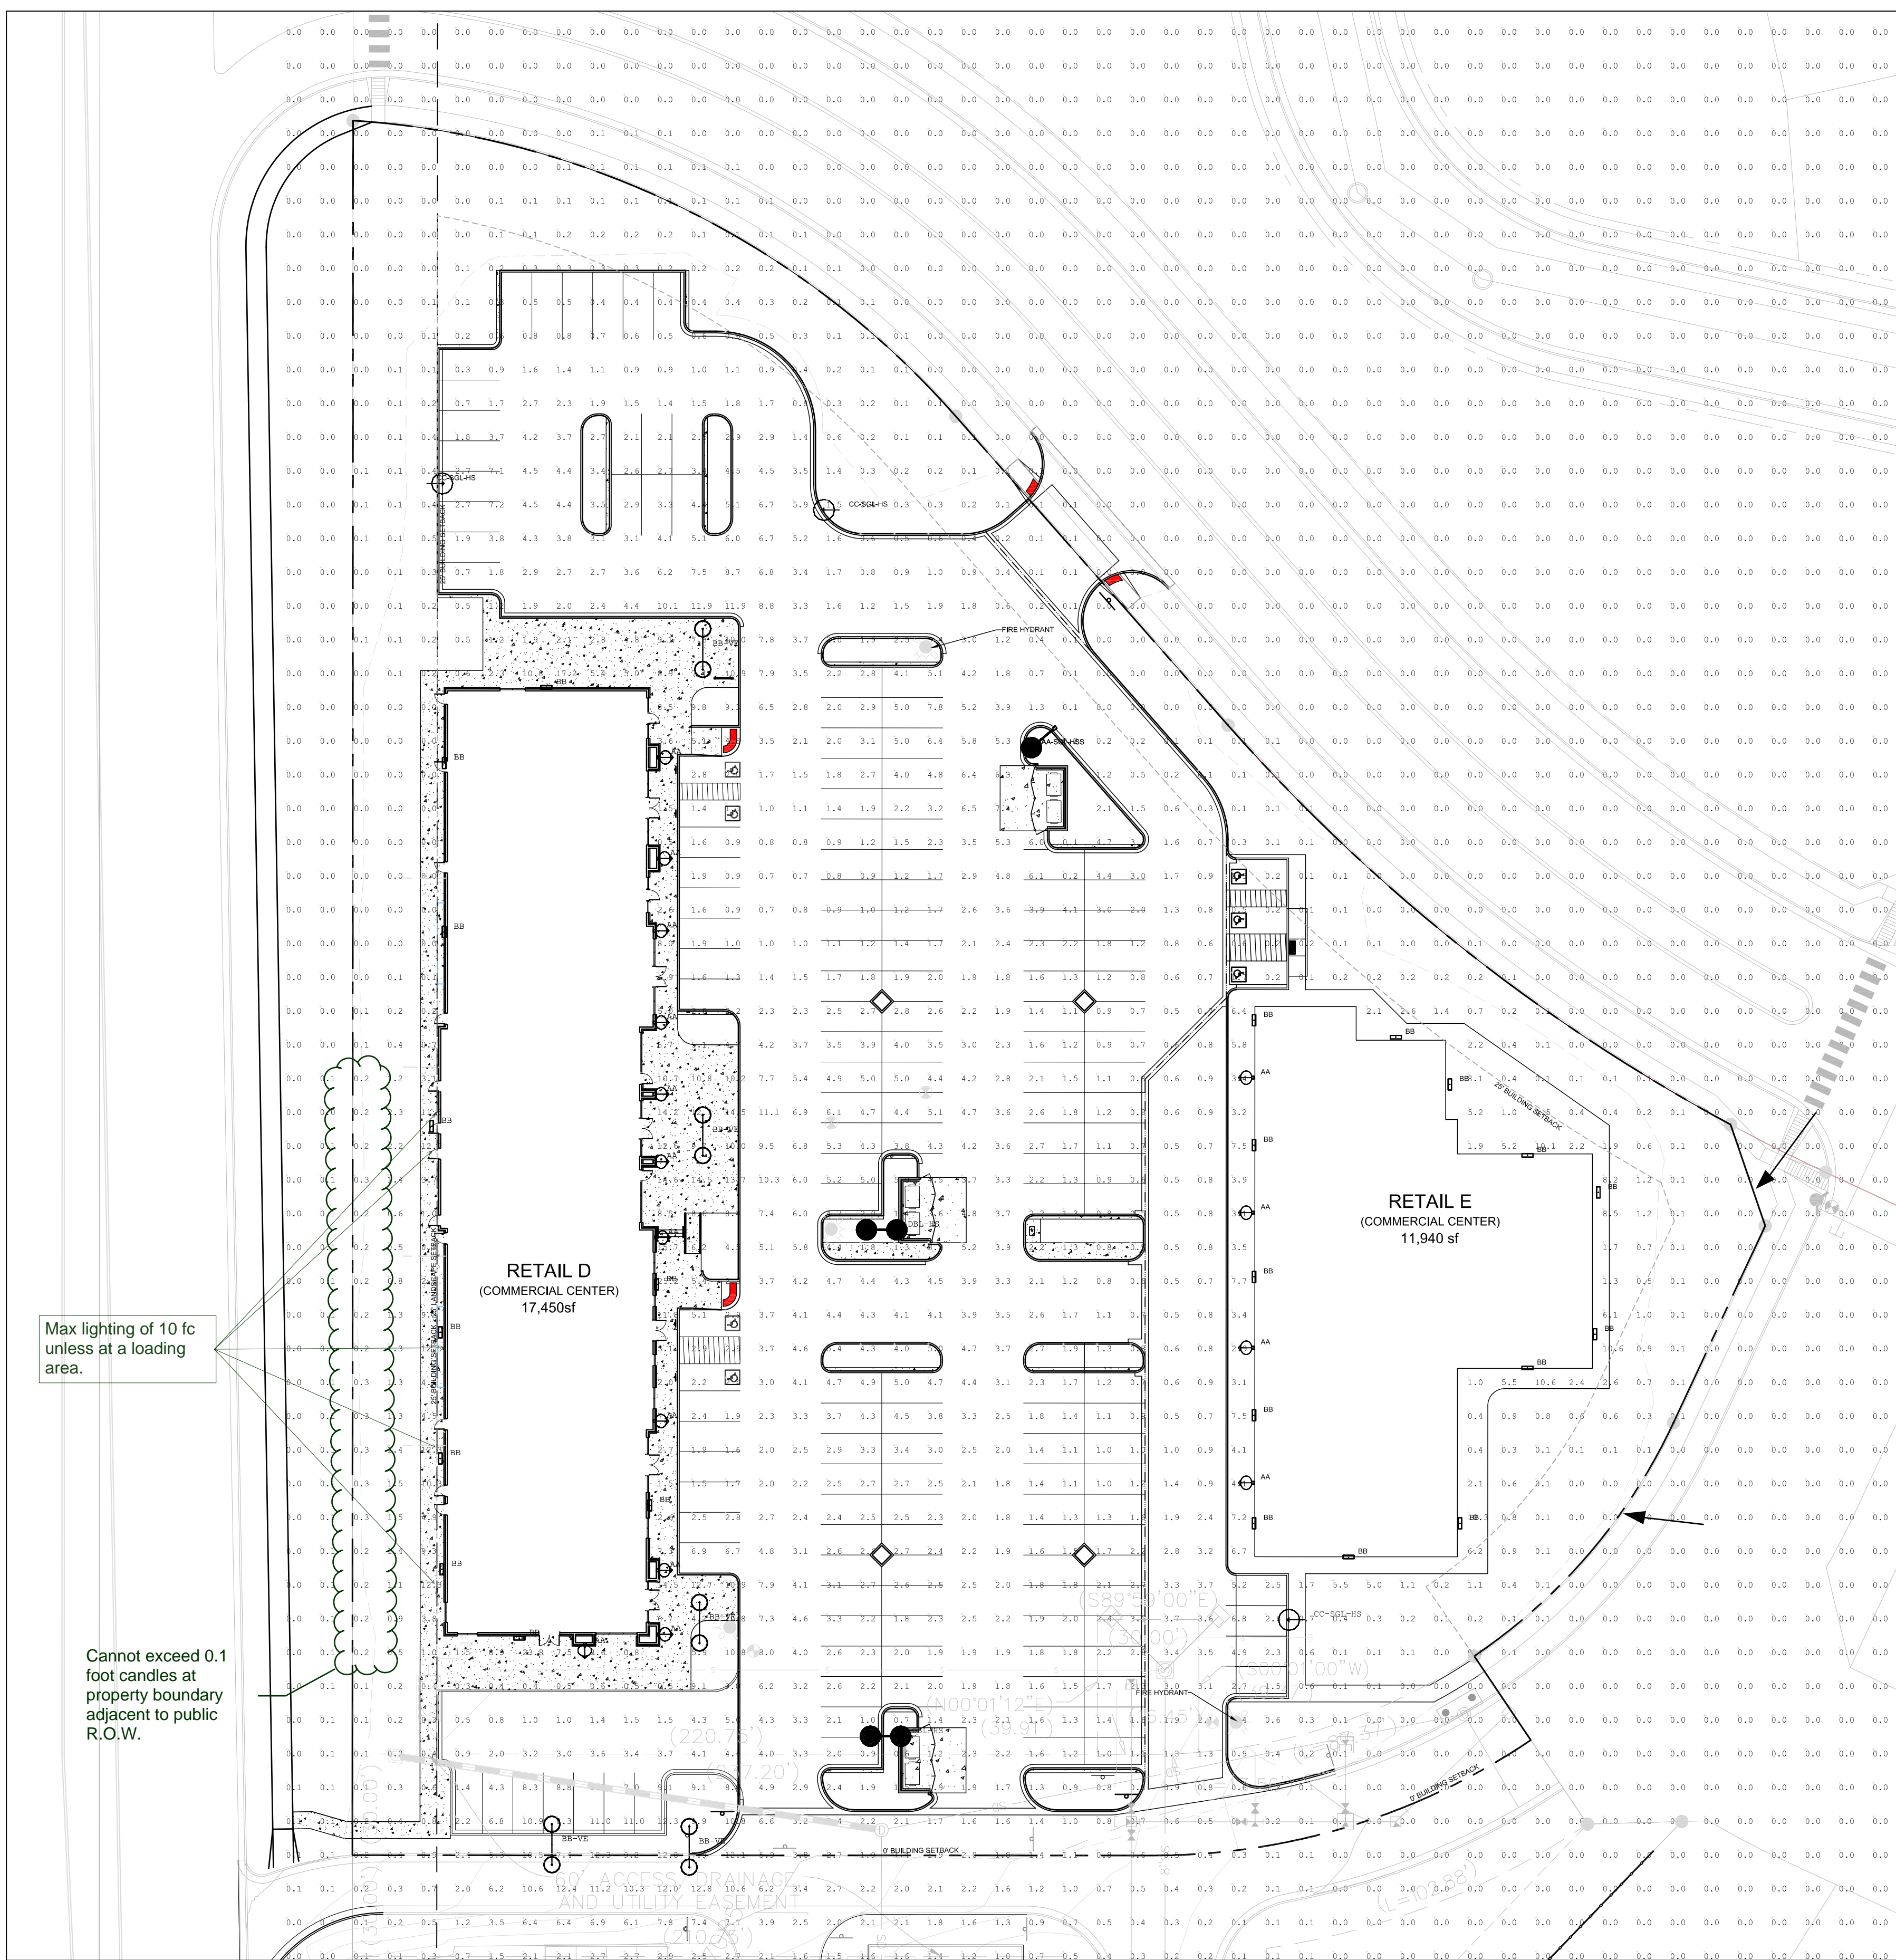

HM LIGHTING 25" Arm

Job Name: Meridian Ranch
Type: AA-COL-416
KIM FACCSA-DP70-96L4K-12B-010
VARIANT CODE: HANDED BY: HAN-FCUP-AS-MB

PR4 - Aluminum Pole

ORDERING CODE

Code	Description	Quantity	Notes
AA-COL-416	25" Arm	1	
PR4	Aluminum Pole	1	

HM LIGHTING 25" Arm

Job Name: Meridian Ranch
Type: AA-COL-416
KIM FACCSA-DP70-96L4K-12B-010
VARIANT CODE: HANDED BY: HAN-FCUP-AS-MB

UCS - Universal Small Housing Scale

ORDERING CODE

Code	Description	Quantity	Notes
AA-COL-416	25" Arm	1	
UCS	Universal Small Housing Scale	1	

valmont STRUCTURES

Job Name: Meridian Ranch
Type: AA-DBL
CROSS-SECTION: DS340
VARIANT CODE: HANDED BY: HAN-FCUP-AS-MB

ROUND NON-TAPERED STEEL DS340

ANCHORAGE DATA

Anchor	Length	Embedment	Notes
A	1.0	3.5	10.6
B	0.4	0.9	0.8
C	0.4	0.3	0.1
D	2.1	0.6	0.1
E	0.6	0.1	0.0
F	0.6	0.1	0.0

BB-VE

Job Name: Meridian Ranch
Type: AA-COL-416
KIM FACCSA-DP70-96L4K-12B-010
VARIANT CODE: HANDED BY: HAN-FCUP-AS-MB

PR4 - Aluminum Pole

ORDERING CODE

Code	Description	Quantity	Notes
AA-COL-416	25" Arm	1	
PR4	Aluminum Pole	1	

AA

Job Name: Meridian Ranch
Type: AA-COL-416
KIM FACCSA-DP70-96L4K-12B-010
VARIANT CODE: HANDED BY: HAN-FCUP-AS-MB

UCS - Universal Small Housing Scale

ORDERING CODE

Code	Description	Quantity	Notes
AA-COL-416	25" Arm	1	
UCS	Universal Small Housing Scale	1	


VWP ARCHITECTURAL WALL PACK

Job Name: Meridian Ranch
Type: AA-DBL
CROSS-SECTION: DS340
VARIANT CODE: HANDED BY: HAN-FCUP-AS-MB

LED

ORDERING CODE

Code	Description	Quantity	Notes
AA-DBL	Round Non-Tapered Steel DS340	1	
VWP	Voltaire Architectural Wall Pack	1	

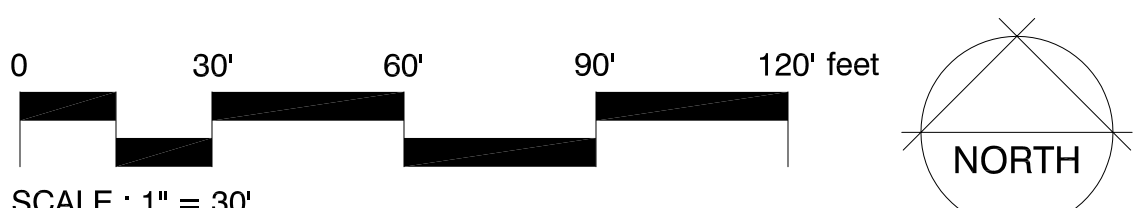

Luminaire Schedule

Symbol	Qty	Label	Arrangement	Total Lamp Lumens	LLF	Description	Lum. Watts	Total Watts
AA	15	AA	SINGLE	0.900	N.A.	UCS-STR-12LED-NW	26.9	26.9
BB	23	BB	SINGLE	0.900	N.A.	VWPH4-30-730-T3-SDGL-OPT-EDD-UNV	35.7	357
AA-DBL	2	AA-DBL	BACK-BACK	0.900	N.A.	2B/CC253P70-96L4K	216.9	1735.2
AA-SGL	1	AA-SGL	SINGLE	0.900	N.A.	1A/CC253P70-96L4K	216.9	650.7
BB-VE	7	BB-VE	BACK-BACK	0.900	N.A.	2-U/CC-ANG-T3-32LED-4K-700-AWT	71.3	998.2001

OWNER INFO

company name: SHOPS AT MERIDIAN RANCH LLC
address/city/state: P.O. BOX 80036, SAN DIEGO CA 91238
phone no:

YOW ARCHITECTS PC
ARCHITECTURE & PLANNING
115 S. Weber Colorado Springs, Colorado 475-8133

Structural:
Electrical:
Mechanical:
Plumbing:

Shop's @ Meridian Ranch
Site Development Plan
Meridian Road
Falcon, CO


Job No: 15-115
Directory: Planning
File: Site development plan 11-14-18
Drawn By: DIB
Date: 6/22/2018
Revised: 10/4/2018
11/28/2018

DRAWING NO. **4**
PHOTOMETRIC PLAN

FILE NUMBER: PPR18033


Markup Summary

dskendall (2)

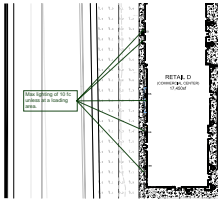

Subject: Callout
Page Label: 1
Lock: Locked
Author: dskendall
Date: 12/26/2018 12:17:03 PM
Color: ■

Max lighting of 10 fc unless at a loading area.

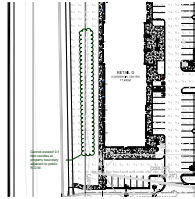

Subject: Cloud+
Page Label: 1
Lock: Locked
Author: dskendall
Date: 12/26/2018 12:17:04 PM
Color: ■

Cannot exceed 0.1 foot candles at property boundary adjacent to public R.O.W.